

CS

REFER TO **ENTRADA DESIGN GUIDELINES** FOR FUTHER DETAILED INFORMATION REGARDING THESE PLANS

SYMBOLS LEGEND	
SECTION HATCHES & SYMBOLS	
	SAND OR GROUT
	EARTH OR NATURAL GROUND
	POROUS FILL (GRAVEL)
	STONE
	CONCRETE
	BRICK (PLAN & SECTION)
	MASONRY
	STEEL
	NON-FERROUS ALUMINUM
	PLYWOOD
	WOOD (FINISH)
	CONTINUOUS NOMINAL LUMBER
	DISCONTINUOUS NOMINAL LUMBER & WOOD BLOCKING (INTERRUPTED MEMBER)
	INSULATION (LOOSE OR BATT)
	RIGID INSULATION
	GLAZING (LARGE SCALE)
	GYPSUM WALL BOARD
	PLASTER WITH LATH
	ACOUSTICAL TILE
	CARPET
ELEVATION HATCHES & SYMBOLS	
	STONE
	STONE VENEER
	WOOD (FINISHED)
	GLASS
	BRICK
	STONE
	STUCCO
	CLAY TILE ROOF
CONSTRUCTION SYMBOLS	
	COLUMN GRID
	PARTITION TAG
	ELEVATION DATUM POINT
	ROOM TAG
	UNIT TAG
	DOOR TAG
	ALIGN WITH ESTABLISHED SURFACES
	SHEET KEYNOTE
	WINDOW MARK
	REVISION REFERENCE
	SECTION IDENTIFIER
	PLAN DETAIL IDENTIFIER
	FIRE EXTINGUISHER WITHOUT CABINET
	FIRE EXTINGUISHER CABINET ON WALL
	CENTERLINE
	EXTERIOR ELEVATION
	INTERIOR ELEVATION
	GLAZING ELEVATION
	FINISH TAG
	KEYNOTE TAG
	KEYNOTE TAG
	ELEVATION LEVEL
	DETAIL REFERENCE
	WALL TAG
	WINDOW TAG
	SECTION DETAIL IDENTIFIER

A CONDITION(ING) ACCESS ACCESSORY ACOUS ACOUSTICAL(AC) AFF ABOVE FINISHED FLOOR AL ALUMINUM ALT ALTERNATE ANNUNC ANNUNCIATOR ANOD ANODIZED APPL APPLIANCE ARCH ARCHITECT(URAL) AUTO AUTOMATIC AVG AVERAGE & AND B BLDG BUILDING BOLL BOLLARD BD BOARD BLKG BLOCKING BRDLM BROADLOOM BU BUILT UP C CAB CABINET CPT CARPET CEM CEMENT(ITIOUS) CER CERAMIC CLG CEILING COATG COATING COILG COILING CONC CONCRETE CONST CONSTRUCTION CONT CONTINUOUS(ATION) CONTR CONTRACT(OR) COV COVER CMU CONCRETE MASONRY UNIT D DBL DOUBLE DEPT DEPARTMENT DES DESIGN(ED) DET DETAIL	DF DRINKING FOUNTAIN DIA DIAMETER DIFF DIFFUSER DIM DIMENSION DISP DISPENSER DIV DIVISION DN DOWN \$ DOLLAR (US CURRENCY) DR DOOR DSCON DISCONNECT DWR DRAWER E EJ EXPANSION JOINT ELAST ELASTOMERIC ELEC ELECTRICAL EMBED EMBEDD(ED)(ING) ENGR ENGINEER(ED) ENTR ENTRANCE EQ EQUAL EQUIP EQUIPMENT EXIST EXISTING EXP JT EXPANSION JOINT EXPS EXPOSE(D) EXT EXTERIOR F FAB FABRICATION FD FLOOR DRAIN FE FIRE EXTINGUISHER FEC FIRE EXTINGUISHER CABINET FHC FIRE HOSE CABINET FIN FINISH FLDG FOLDING FLPC FLAMEPLACE FR FIRE RATING(ED) FRG FRAMING FXD FIXED FXTR FIXTURE FLR FLOOR(ING) FURN FURNITURE FWC FABRIC WALL COVERING	G GA GAUGE GD GRADE(E)(ING) GFRG GLASS FIBER REINF. CONCRETE GFRG GLASS FIBER REINF. GYPSUM GFRP GLASS FIBER REINF. PLASTER GL GLASS GR GRAD(E)(ING) GYP GYPSUM H HD HEAD HDWD HARDWOOD HDWR HARDWARE HM HOLLOW METAL HORIZ HORIZONTAL HVAC HEATING, VENTILATION, & AIR CONDITIONING I INFO INFORMATION INSTRUM INSTRUMENT(ATION) INSUL INSULATION INTLK INTERLOCK(ING) INT INTERIOR INFILTR INFILTRATION J JAN JANITOR JT JOINT K KIT KITCHEN L LAV LAVATORY LB POUND £ BRITISH POUND (CURRENCY) LT LIGHT LVLG LEVELING LVR LOUVER M MAX MAXIMUM MFD MANUFACTURED MFR MANUFACTURER	MECH MECHANICAL MTL METAL MEM MEMBRANE MEZ MEZZANINE MIN MINIMUM MISC MISCELLANEOUS MLWK MILLWORK MOIST MOISTURE MOT MOTOR(IZED) MD MOUNTED N NIC NOT IN CONTRACT NO (#) NUMBER NTS NOT TO SCALE O OH OPPOSITE HAND ORNA ORNAMENTAL OVFL OVERFLOW OVHD OVERHEAD OPNG OPENING(S) OPR OPERABLE P PTN PARTITION PED PEDESTRIAN PBD PARTICLE BOARD PNL PANEL POLYST POLYSTYRENE PORT PORTABLE PREFIN PREFINISHED PREFAB PREFABRICATED PLAM PLASTIC LAMINATE PLAS PLASTER PLSTC PLASTIC PLYWD PLYWOOD PRTECN PROTECTION R RDR READER RECES RECESSED RECPT RECEPTACLE REF REFERENCE	REFL REFLECTED REFR REFRIGERATOR REQ REQUIRED RESIS RESIST(ANT)(IVE) REINF REINFORCE(D)(ING)(MENT) RESIL RESILIENT RFG ROOFING RM ROOM RO ROUGH OPENING S SCR SCRIBE SECUR SECURITY SF SQUARE FEET SGL SINGLE SHORG SHORING SIM SIMILAR SS STAINLESS STEEL STD STANDARD STL STEEL STFRF STOREFRONT STRUCT STRUCTURAL SURF SURFACE SUSP SUSPENDED SYS SYSTEM(S) T THK THICK TLT RESTROOM TRAF TRAFFIC TRANS TRANSPARENT TRTD TREATED T&G TONGUE & GROOVE TYP TYPICAL U UNDRLAY UNDERLAYMENT UTIL UTILITY UNO UNLESS NOTED OTHERWISE UON UNLESS OTHERWISE NOTED V VEH VEHICLE VERT VERTICAL	VIF VERIFY IN FIELD W W/ WITH WC WATER CLOSET WD WOOD WDW WINDOW W/O WITHOUT WT WEIGHT WTRPRF WATERPROOFING
--	---	---	--	--	--

	COLUMN GRID
	PARTITION TAG
	ELEVATION DATUM POINT
	ROOM TAG
	UNIT TAG
	DOOR TAG
	ALIGN WITH ESTABLISHED SURFACES
	SHEET KEYNOTE
	WINDOW MARK
	REVISION REFERENCE
	SECTION IDENTIFIER
	PLAN DETAIL IDENTIFIER
	FIRE EXTINGUISHER WITHOUT CABINET
	FIRE EXTINGUISHER CABINET ON WALL
	CENTERLINE
	EXTERIOR ELEVATION
	INTERIOR ELEVATION
	GLAZING ELEVATION
	FINISH TAG
	KEYNOTE TAG
	KEYNOTE TAG
	ELEVATION LEVEL
	DETAIL REFERENCE
	WALL TAG
	WINDOW TAG
	SECTION DETAIL IDENTIFIER

	STONE		ELEVATION LEVEL
	STONE VENEER		# / SHEET
	WOOD (FINISHED)		DETAIL REFERENCE
	GLASS		WALL TAG
	BRICK		WINDOW TAG
	STONE		SECTION DETAIL IDENTIFIER
	STUCCO		
	CLAY TILE ROOF		

MECHANICAL SYMBOLS	
—+ W	COLD WATER TAP FOR REFRIGERATOR OR ICE MAKER
—+ GAS	GAS SUPPLY
—+φ	GAS KEY
—+φ—GAS	SWITCHED GAS KEY
—+ HB	FROST FREE HOSE BIB
CONSTRUCTION NOTES	
1. CONSTRUCTION: COMPLY WITH APPLICABLE CODES AND RELATED AMENDMENTS. 2. ALL STRUCTURES IN THIS ZONING DISTRICT MUST COMPLY WITH ALL CITY OF WESTLAKE ORDINANCES (OTC). 3. ALL CONSTRUCTION TO COMPLY WITH ENTRADA DESIGN GUIDELINES. 4. THE CONTRACTOR SHALL PAY ALL FINES, GIVE ALL NOTICES, FILE ALL NECESSARY DRAWINGS, AND PAY AND OBTAIN ALL PERMITS AND AND INSPECTIONS REQUIRED IN CONNECTION WITH ALL WORK UNDER THE CONTRACT DOCUMENTS. 5. THESE DRAWINGS DO NOT CONTAIN COMPLETE SPECIFICATIONS, DETAILS, OR FULL INFORMATION NECESSARY FOR THE COMPLETE CONSTRUCTION OF THE PROJECT. 6. ELECTRICAL, MECHANICAL AND PLUMBING ITEMS SHOWN ON THE ARCHITECTURAL DRAWINGS ARE DIAGRAMMATIC AND PROVIDED TO SHOW DESIGN INTENT. THE GENERAL CONTRACTORS SUB CONSULTANTS FOR THOSE TRADES ARE RESPONSIBLE FOR THE ACTUAL DESIGN TO OF THOSE SYSTEMS TO MEET NATIONAL, STATE OR CITY CODE REQUIREMENTS THAT HAVE JURISDICTION. FIRE SPRINKLERS SYSTEMS: LICENSED FIRE PROTECTION SUB CONTRACTOR TO SUBMIT TO REED FIRE PROTECTION (214) 638-7599 7. THE CONTRACTOR IS TO COORDINATE TELECOMMUNICATIONS, DATA AND SECURITY SYSTEM INSTALLATIONS. 8. REFER TO CIVIL AND LANDSCAPE DRAWINGS FOR GRADING AND DRAINAGE REQUIREMENTS. CONTRACTOR TO CONSULT WITH A STRUCTURAL ENGINEER FOR STRUCTURAL DESIGN, SPECIFICATIONS, AND DETAILS; INCLUDING REQUIRED RETAINING WALLS, WATERPROOFING, AND FRENCH DRAIN SYSTEMS. COORDINATE SOIL COMPACTION REQUIREMENTS BEHIND RETAINING WALLS WITH STRUCTURAL ENGINEER. 9. CONTRACTOR TO REVIEW DOCUMENTS, VERIFY DIMENSIONS AND FIELD CONDITIONS AND CONFIRM THE WORK IS BUILDABLE AS SHOWN. NOTIFY ARCHITECT AND OWNER OF ERRORS, OMISSIONS, AND DISCREPANCIES IN CONTRACT DOCUMENTS, OR BETWEEN CONTRACT DOCUMENTS AND ACTUAL SITE CONSTRUCTION CONDITIONS. ERRORS, OMISSIONS, AND DISCREPANCIES MUST BE RESOLVED AND DOCUMENTED BEFORE CONTINUING CONSTRUCTION WITH THE WORK IN QUESTION. FAILURE TO NOTIFY THE OWNER AND ARCHITECT IN SUCH AN EVENT SHALL CONSTITUTE ACCEPTANCE OF ANY RESULTING OBLIGATIONS OR RESPONSIBILITIES WITH REGARDS TO DELAYS, COSTS, CODE COMPLIANCE, AND LEGAL REMEDIES RESULTING FROM THIS OR RELATED WORK. 10. SUBMIT REQUESTS FOR SUBSTITUTIONS, REVISIONS, OR CHANGES TO ARCHITECT FOR REVIEW PRIOR TO PURCHASE, FABRICATION OR INSTALLATION.THE CONTRACTOR SHALL VERIFY ALL MEASUREMENTS AT THE SITE AND BE RESPONSIBLE FOR THE ACCURACY AND CORRECTNESS OF SAME. 11. SUBMIT SHOP DRAWINGS AND SELECTIONS FOR ARCHITECTS/OWNERS REVIEW BEFORE ORDERING AND INSTALLING ANDY EQUIPMENT, MASONRY, CAST STONE, WINDOWS, STEEL ETC. DO NOT SCALE DRAWINGS, WRITTEN DIMENSIONS GOVERN. IN CASE OF CONFLICT, CONSULT THE ARCHITECT. 12. MAINTAIN WORK AREAS CLEAN, SECURE AND LOCKABLE DURING CONSTRUCTION. 13. PROTECT AREA OF WORK AND ADJACENT PROPERTIES FROM DAMAGE. 14. VERIFY TYPE AND LOCATION OF UTILITIES SERVING SITE. 15. FIREPLACES: 15.1 VERIFY SIZES, INCLUDING HEARTH EXTENSIONS REQUIRED BY CODE. 15.2 PROVIDE OUTSIDE MAKE-UP AIR INLET AND SCREENED LOUVER AND DAMPER. 16. FLOOR ELEVATIONS AT SECOND FLOOR ARE GIVEN TO TOP OF FLOOR DECK. 17. INSTALL STUDS AT CLOSET SIDE WALL ROD LOCATIONS, MEASURED 10" FROM BACK WALL. 18. EXTERIOR MATERIALS AND FINISHES ARE TO BE INSTALLED IN ACCORDANCE WITH MANUFACTURERS WRITTEN INSTRUCTIONS AND DETAILS. 19. STONE WALL CORNERS SHALL BE LAID SO THAT THE COURSES INTERLOCK (TOOTHING). SHOWING THE FULL DIMENSION OF THE STONE. 20. PARTITIONS ARE DIMENSIONED FROM FACE OF STUD TO FACE OF STUD, UNLESS OTHERWISE NOTED, MAINTAIN DIMENSIONS MARKED "CLEAR". ALLOW FOR THICKNESS OR FINISHES. 21. COORDINATE AND PROVIDE BLOCKING/BACKING FOR MILLWORK AND OTHER ITEMS ATTACHED OR MOUNTED TO WALLS OR CEILINGS. 22. STUCCO CONTROL JOINTS ARE TO BE LOCATED AT 12'-0" O.C. EACH WAY MAXIMUM. STUCCO CONTROL JOINTS ARE TO BE CONCEALED. 23. STONE CONTROL JOINTS ARE TO BE LOCATED 25'-0" O.C. MAXIMUM. STONE CONTROL JOINTS SHOULD BE CONCEALED. 24. UNDERCUT INTERIOR DOORS TO CLEAR TOP OF FLOOR FINISH BY 1/4 INCH, UNLESS OTHERWISE NOTED. 25. ALL GUTTERS ARE TO BE PREFINISHED GALVANIZED ALUMINUM DARK BRONZE 6" HALF ROUND PROFILE. ALL HORIZONTAL JOINTS ARE REQUIRED TO BE SOLDERED OR MECHANICALLY FASTENED WITH CONCEALED FASTENERS. 26. ALL DOWNSPOUTS ARE TO BE PREFINISHED ALUMINUM DARK BRONZE 4" MINIMUM PLAIN ROUND. VERTICAL DOWNSPOUT SECTIONS, ELBOWS AND BENDS MAY BE SLIP JOINTED AND/OR RIVETED IF RIVETS ARE CONCEALED.	
FOR DIMENSION PURPOSES:	
1. DO NOT SCALE DRAWINGS.	
2. VERIFY DIMENSIONS: NOTIFY ARCHITECT OF ANY DISCREPANCIES.	
3. WOOD STUD WALLS: VERIFY AND REFER TO STRUCTURAL ENGINEER FOR SIZES AND STUD SPACING.	
4. WALL PLATE HEIGHTS: CROSS REFERENCE EXTERIOR ELEVATIONS, WALL SECTIONS, AND FASCIA DETAILS TO DETERMINE.	
5. WINDOWS AND DOORS: 5.1. VERIFY ROUGH OPENINGS WITH SELECTED MANUFACTURER. 5.2. REFER TO EXTERIOR ELEVATIONS AND FLOOR PLANS OR SCHEDULE FOR HEAD HEIGHTS.	

[illegible]

1. CONSTRUCTION: COMPLY WITH APPLICABLE CODES AND RELATED AMENDMENTS.
2. ALL STRUCTURES IN THIS ZONING DISTRICT MUST COMPLY WITH ALL CITY OF WESTLAKE ORDINANCES (OTC).
3. ALL CONSTRUCTION TO COMPLY WITH ENTRADA DESIGN GUIDELINES.
4. THE CONTRACTOR SHALL PAY ALL FINES, GIVE ALL NOTICES, FILE ALL NECESSARY DRAWINGS, AND PAY AND OBTAIN ALL PERMITS AND AND INSPECTIONS REQUIRED IN CONNECTION WITH ALL WORK UNDER THE CONTRACT DOCUMENTS.
5. THESE DRAWINGS DO NOT CONTAIN COMPLETE SPECIFICATIONS, DETAILS, OR FULL INFORMATION NECESSARY FOR THE COMPLETE CONSTRUCTION OF THE PROJECT.
6. ELECTRICAL, MECHANICAL AND PLUMBING ITEMS SHOWN ON THE ARCHITECTURAL DRAWINGS ARE DIAGRAMMATIC AND PROVIDED TO SHOW DESIGN INTENT. THE GENERAL CONTRACTORS SUB CONSULTANTS FOR THOSE TRADES ARE RESPONSIBLE FOR THE ACTUAL DESIGN TO OF THOSE SYSTEMS TO MEET NATIONAL, STATE OR CITY CODE REQUIREMENTS THAT HAVE JURISDICTION. FIRE SPRINKLERS SYSTEMS: LICENSED FIRE PROTECTION SUB CONTRACTOR TO SUBMIT TO REED FIRE PROTECTION (214) 638-7599
7. THE CONTRACTOR IS TO COORDINATE TELECOMMUNICATIONS, DATA AND SECURITY SYSTEM INSTALLATIONS.
8. REFER TO CIVIL AND LANDSCAPE DRAWINGS FOR GRADING AND DRAINAGE REQUIREMENTS. CONTRACTOR TO CONSULT WITH A STRUCTURAL ENGINEER FOR STRUCTURAL DESIGN, SPECIFICATIONS, AND DETAILS; INCLUDING REQUIRED RETAINING WALLS, WATERPROOFING, AND FRENCH DRAIN SYSTEMS. COORDINATE SOIL COMPACTION REQUIREMENTS BEHIND RETAINING WALLS WITH STRUCTURAL ENGINEER.
9. CONTRACTOR TO REVIEW DOCUMENTS, VERIFY DIMENSIONS AND FIELD CONDITIONS AND CONFIRM THE WORK IS BUILDABLE AS SHOWN. NOTIFY ARCHITECT AND OWNER OF ERRORS, OMISSIONS, AND DISCREPANCIES IN CONTRACT DOCUMENTS, OR BETWEEN CONTRACT DOCUMENTS AND ACTUAL SITE CONSTRUCTION CONDITIONS. ERRORS, OMISSIONS, AND DISCREPANCIES MUST BE RESOLVED AND DOCUMENTED BEFORE CONTINUING CONSTRUCTION WITH THE WORK IN QUESTION. FAILURE TO NOTIFY THE OWNER AND ARCHITECT IN SUCH AN EVENT SHALL CONSTITUTE ACCEPTANCE OF ANY RESULTING OBLIGATIONS OR RESPONSIBILITIES WITH REGARDS TO DELAYS, COSTS, CODE COMPLIANCE, AND LEGAL REMEDIES RESULTING FROM THIS OR RELATED WORK.
10. SUBMIT REQUESTS FOR SUBSTITUTIONS, REVISIONS, OR CHANGES TO ARCHITECT FOR REVIEW PRIOR TO PURCHASE, FABRICATION OR INSTALLATION. THE CONTRACTOR SHALL VERIFY ALL MEASUREMENTS AT THE SITE AND BE RESPONSIBLE FOR THE ACCURACY AND CORRECTNESS OF SAME.
11. SUBMIT SHOP DRAWINGS AND SELECTIONS FOR ARCHITECTS/OWNERS REVIEW BEFORE ORDERING AND INSTALLING ANY EQUIPMENT, MASONRY, CAST STONE, WINDOWS, STEEL ETC. DO NOT SCALE DRAWINGS, WRITTEN DIMENSIONS GOVERN. IN CASE OF CONFLICT, CONSULT THE ARCHITECT.
12. MAINTAIN WORK AREAS CLEAN, SECURE AND LOCKABLE DURING CONSTRUCTION.
13. PROTECT AREA OF WORK AND ADJACENT PROPERTIES FROM DAMAGE.
14. VERIFY TYPE AND LOCATION OF UTILITIES SERVING SITE.
15. FIREPLACES:
 - 15.1 VERIFY SIZES, INCLUDING HEARTH EXTENSIONS REQUIRED BY CODE.
 - 15.2 PROVIDE OUTSIDE MAKE-UP AIR INLET AND SCREENED LOUVER AND DAMPER.
16. FLOOR ELEVATIONS AT SECOND FLOOR ARE GIVEN TO TOP OF FLOOR DECK.
17. INSTALL STUDS AT CLOSET SIDE WALL ROD LOCATIONS, MEASURED 10" FROM BACK WALL.
18. EXTERIOR MATERIALS AND FINISHES ARE TO BE INSTALLED IN ACCORDANCE WITH MANUFACTURERS WRITTEN INSTRUCTIONS AND DETAILS.
19. STONE WALL CORNERS SHALL BE LAID SO THAT THE COURSES INTERLOCK (TOOTHING). SHOWING THE FULL DIMENSION OF THE STONE.
20. PARTITIONS ARE DIMENSIONED FROM FACE OF STUD TO FACE OF STUD, UNLESS OTHERWISE NOTED, MAINTAIN DIMENSIONS MARKED "CLEAR". ALLOW FOR THICKNESS OR FINISHES.
21. COORDINATE AND PROVIDE BLOCKING/BACKING FOR MILLWORK AND OTHER ITEMS ATTACHED OR MOUNTED TO WALLS OR CEILINGS.
22. STUCCO CONTROL JOINTS ARE TO BE LOCATED AT 12'-0" O.C. EACH WAY MAXIMUM. STUCCO CONTROL JOINTS ARE TO BE CONCEALED.
23. STONE CONTROL JOINTS ARE TO BE LOCATED 25'-0" O.C. MAXIMUM. STONE CONTROL JOINTS SHOULD BE CONCEALED.
24. UNDERCUT INTERIOR DOORS TO CLEAR TOP OF FLOOR FINISH BY 1/4 INCH, UNLESS OTHERWISE NOTED.
25. ALL GUTTERS ARE TO BE PREFINISHED GALVANIZED ALUMINUM DARK BRONZE 6" HALF ROUND PROFILE. ALL HORIZONTAL JOINTS ARE REQUIRED TO BE SOLDERED OR MECHANICALLY FASTENED WITH CONCEALED FASTENERS.
26. ALL DOWNSPOUTS ARE TO BE PREFINISHED ALUMINUM DARK BRONZE 4" MINIMUM PLAIN ROUND. VERTICAL DOWNSPOUT SECTIONS, ELBOWS AND BENDS MAY BE SLIP JOINTED AND/OR RIVETED IF RIVETS ARE CONCEALED.

FOR DIMENSION PURPOSES:

1. DO NOT SCALE DRAWINGS.
2. VERIFY DIMENSIONS: NOTIFY ARCHITECT OF ANY DISCREPANCIES.
3. WOOD STUD WALLS: VERIFY AND REFER TO STRUCTURAL ENGINEER FOR SIZES AND STUD SPACING.
4. WALL PLATE HEIGHTS: CROSS REFERENCE EXTERIOR ELEVATIONS, WALL SECTIONS, AND FASCIA DETAILS TO DETERMINE.
5. WINDOWS AND DOORS:
 - 5.1. VERIFY ROUGH OPENINGS WITH SELECTED MANUFACTURER.
 - 5.2. REFER TO EXTERIOR ELEVATIONS AND FLOOR PLANS OR SCHEDULE FOR HEAD HEIGHTS.

1. DO NOT SCALE DRAWINGS.
2. VERIFY DIMENSIONS: NOTIFY ARCHITECT OF ANY DISCREPANCIES.
3. WOOD STUD WALLS: VERIFY AND REFER TO STRUCTURAL ENGINEER FOR SIZES AND STUD SPACING.
4. WALL PLATE HEIGHTS: CROSS REFERENCE EXTERIOR ELEVATIONS, WALL SECTIONS, AND FASCIA DETAILS TO DETERMINE.
5. WINDOWS AND DOORS:
 - 5.1. VERIFY ROUGH OPENINGS WITH SELECTED MANUFACTURER.
 - 5.2. REFER TO EXTERIOR ELEVATIONS AND FLOOR PLANS OR SCHEDULE FOR HEAD HEIGHTS.

1800 VALLEY VIEW LANE, STE. 400
FARMERS BRANCH, TX 75234
PHONE: 469-857-3151
©BUSH ARCHITECTS, LLC - 2021

1800 VALLEY VIEW LANE, STE. 400
FARMERS BRANCH, TX 75234
PHONE: 469-857-3151
© BUSH ARCHITECTS, LLC - 2021


LOT 1, 2, & 3 - BLOCK H

TOWN OF WESTLAKE TARRANT COUNTY, TEXAS

[illegible]

GENERAL NOTES

A001

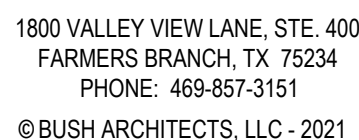


LOT 1, 2, & 3 - BLOCK H

TOWN OF WESTLAKE TARRANT COUNTY, TEXAS

[illegible]

PROJECT NO:	20-129
ISSUED FOR:	OTP
DRAWN BY:	WLL
DATE:	11/29/2

A100

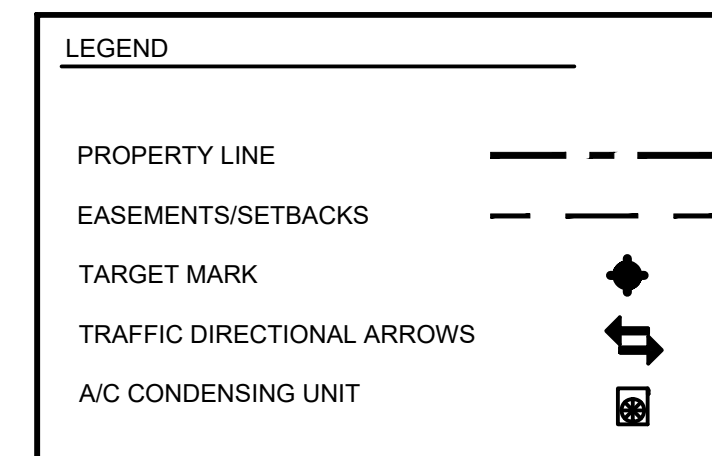

SITE NOTES


1. CONTRACTOR TO INSTALL ALL EXTERIOR LIGHTING TO MEET ENTRADA GUIDELINES AND ZONING REQUIREMENTS.
2. SEE CIVIL ENGINEERING AND LANDSCAPE PLANS FOR UTILITIES, DIMENSIONS CONTROL, GRADING, DRAINAGE, PAVEMENT, HC RAMPS AND ALL SIDEWALKS.
3. CONTRACTOR TO INSTALL ALL SIGNAGE TO MEET ENTRADA GUIDELINE REQUIREMENTS



01 SITE PLAN
A100 SCALE: 1:100

NOTE: REFER TO CIVIL PLANS FOR SITE DIMENSION CONTROL

REFER TO **ENTRADA DESIGN GUIDELINES** FOR FUTHER DETAILED INFORMATION REGARDING THESE PLANS

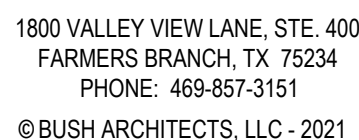

LOT 1, 2, & 3 - BLOCK H


TOWN OF WESTLAKE TARRANT COUNTY, TEXAS

[illegible]

PROJECT NO:	20-129
ISSUED FOR:	OTP
DRAWN BY:	WLL
DATE:	11/29/2

FIRST FLOOR PLAN

A101

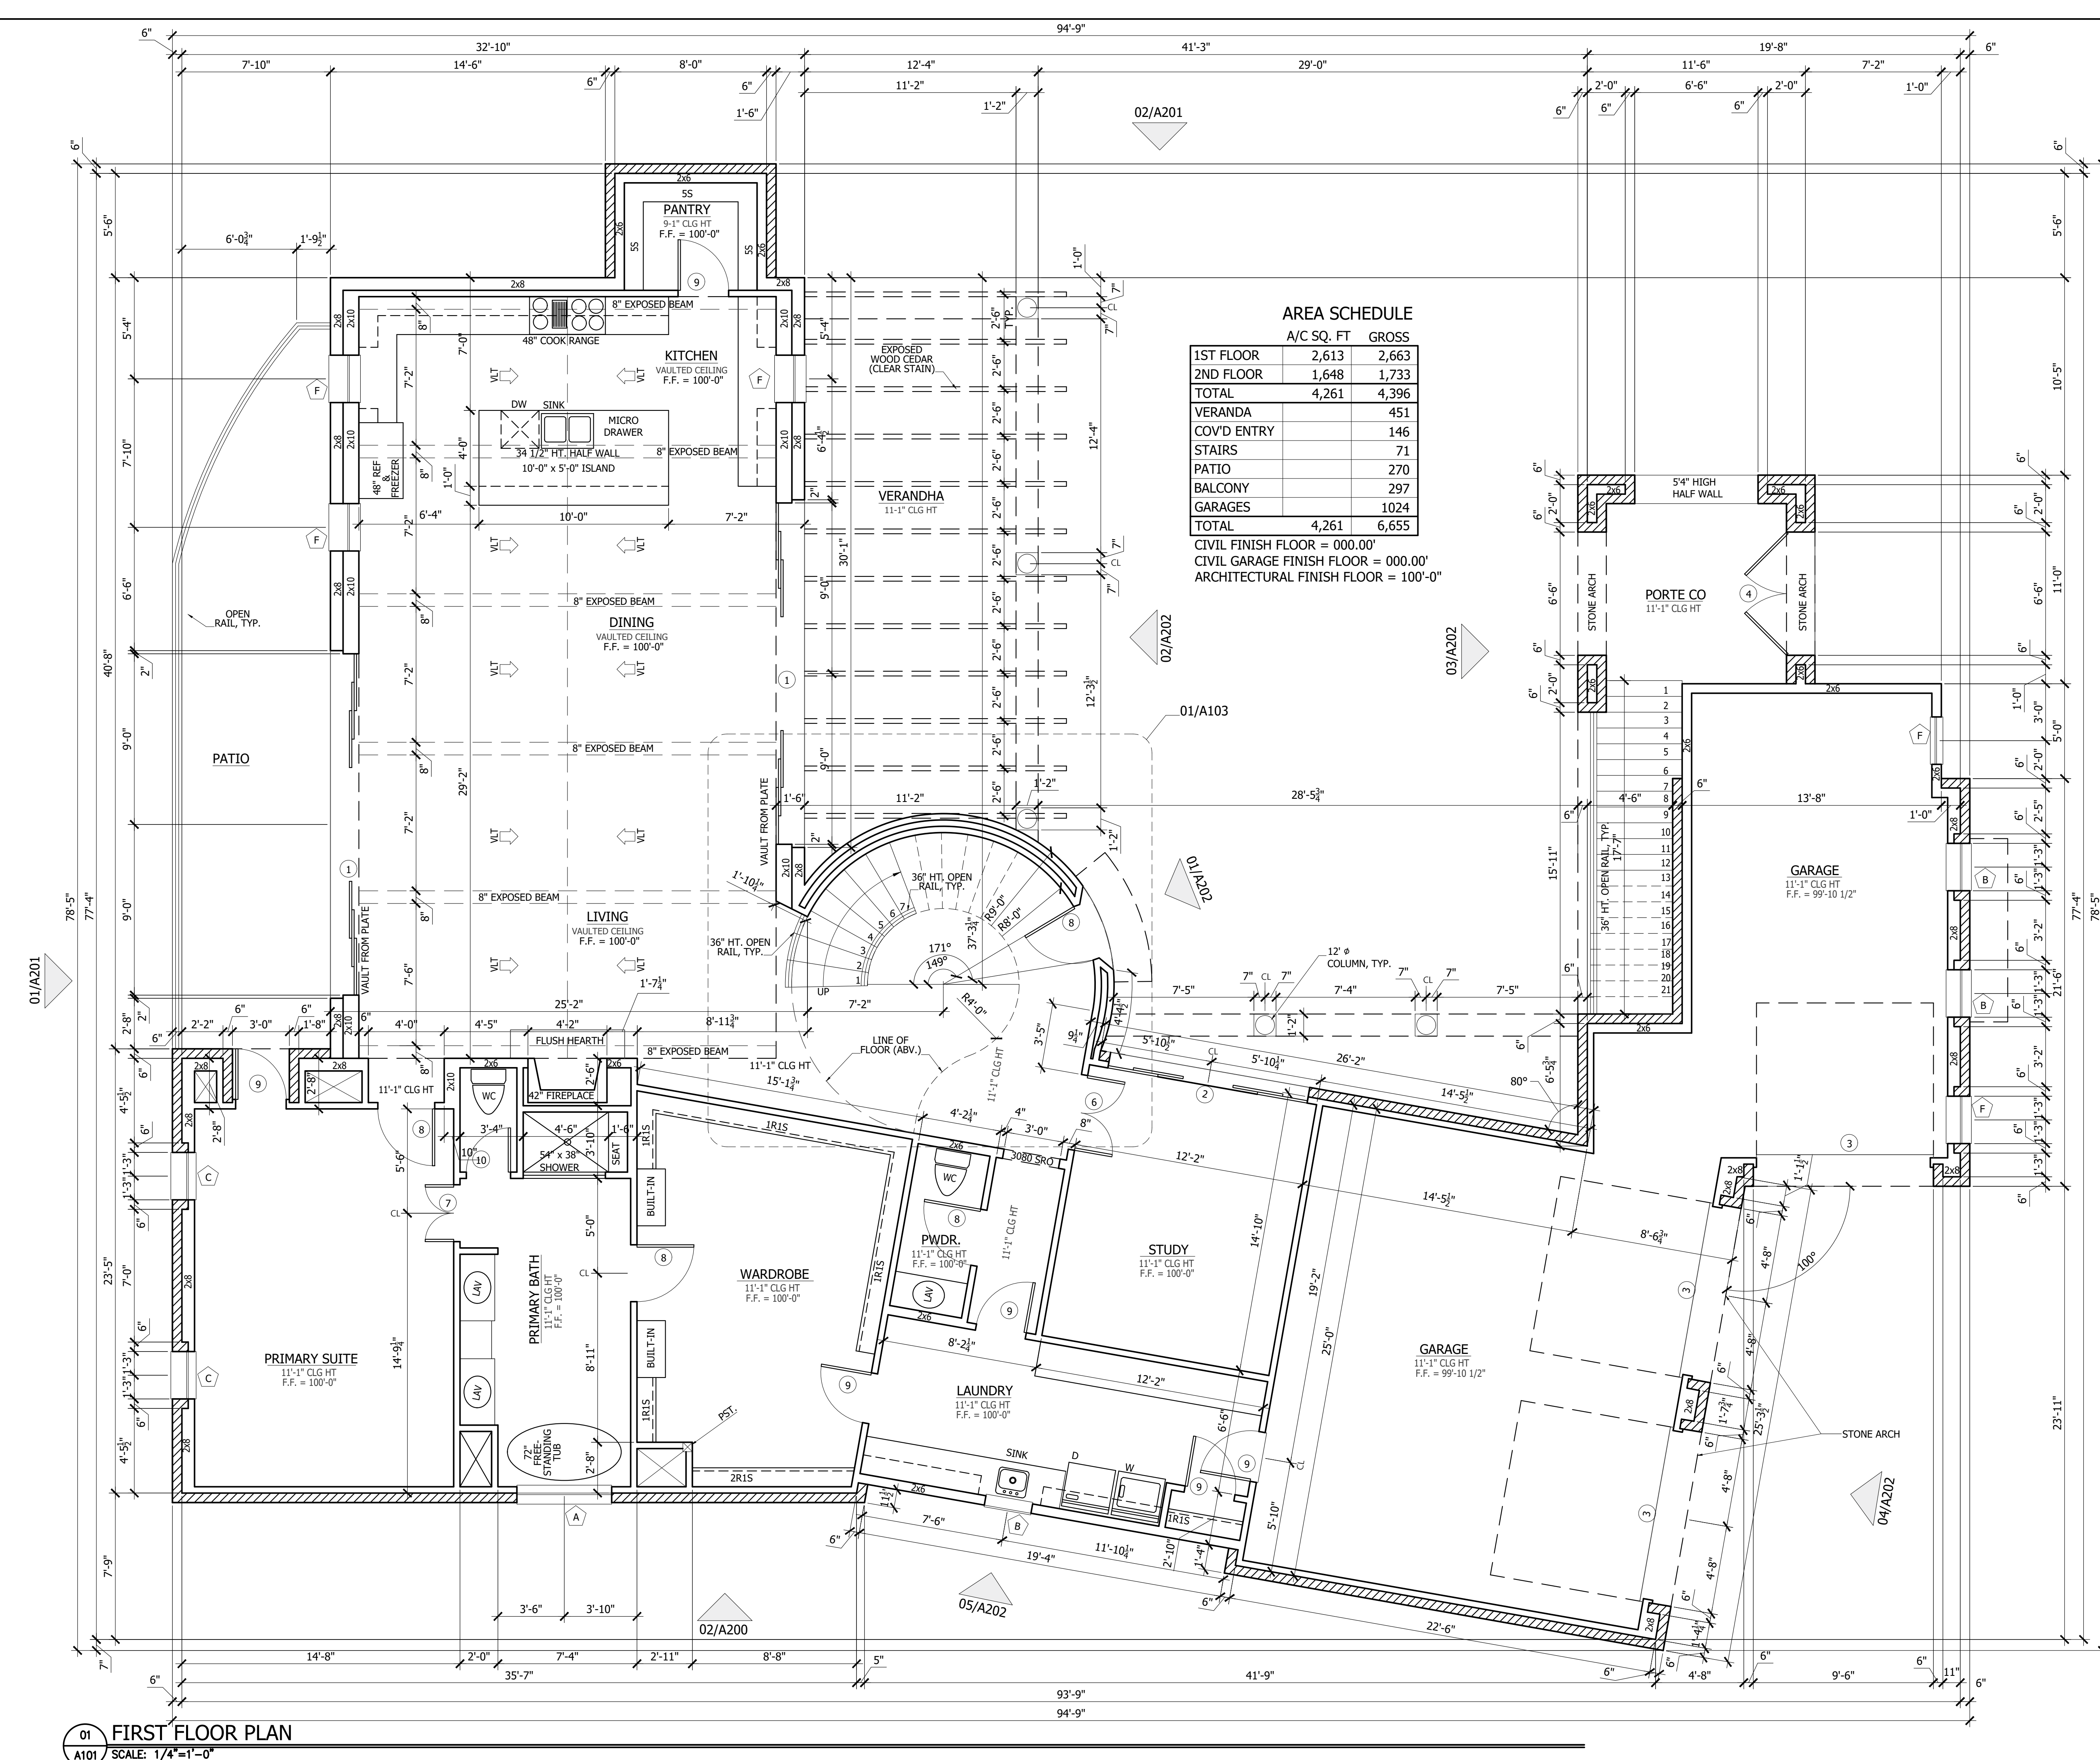

ENTRADA
LOT 1, 2, & 3 - BLOCK H
TOWN OF WESTLAKE TARRANT COUNTY, TEXAS


ISSUE LOG

NO.	DESCRIPTION	DATE

PROJECT NO: 20-129
ISSUED FOR: OTP
DRAWN BY: WILL
DATE: 11/29/21

**SECOND
FLOOR PLAN**

A102

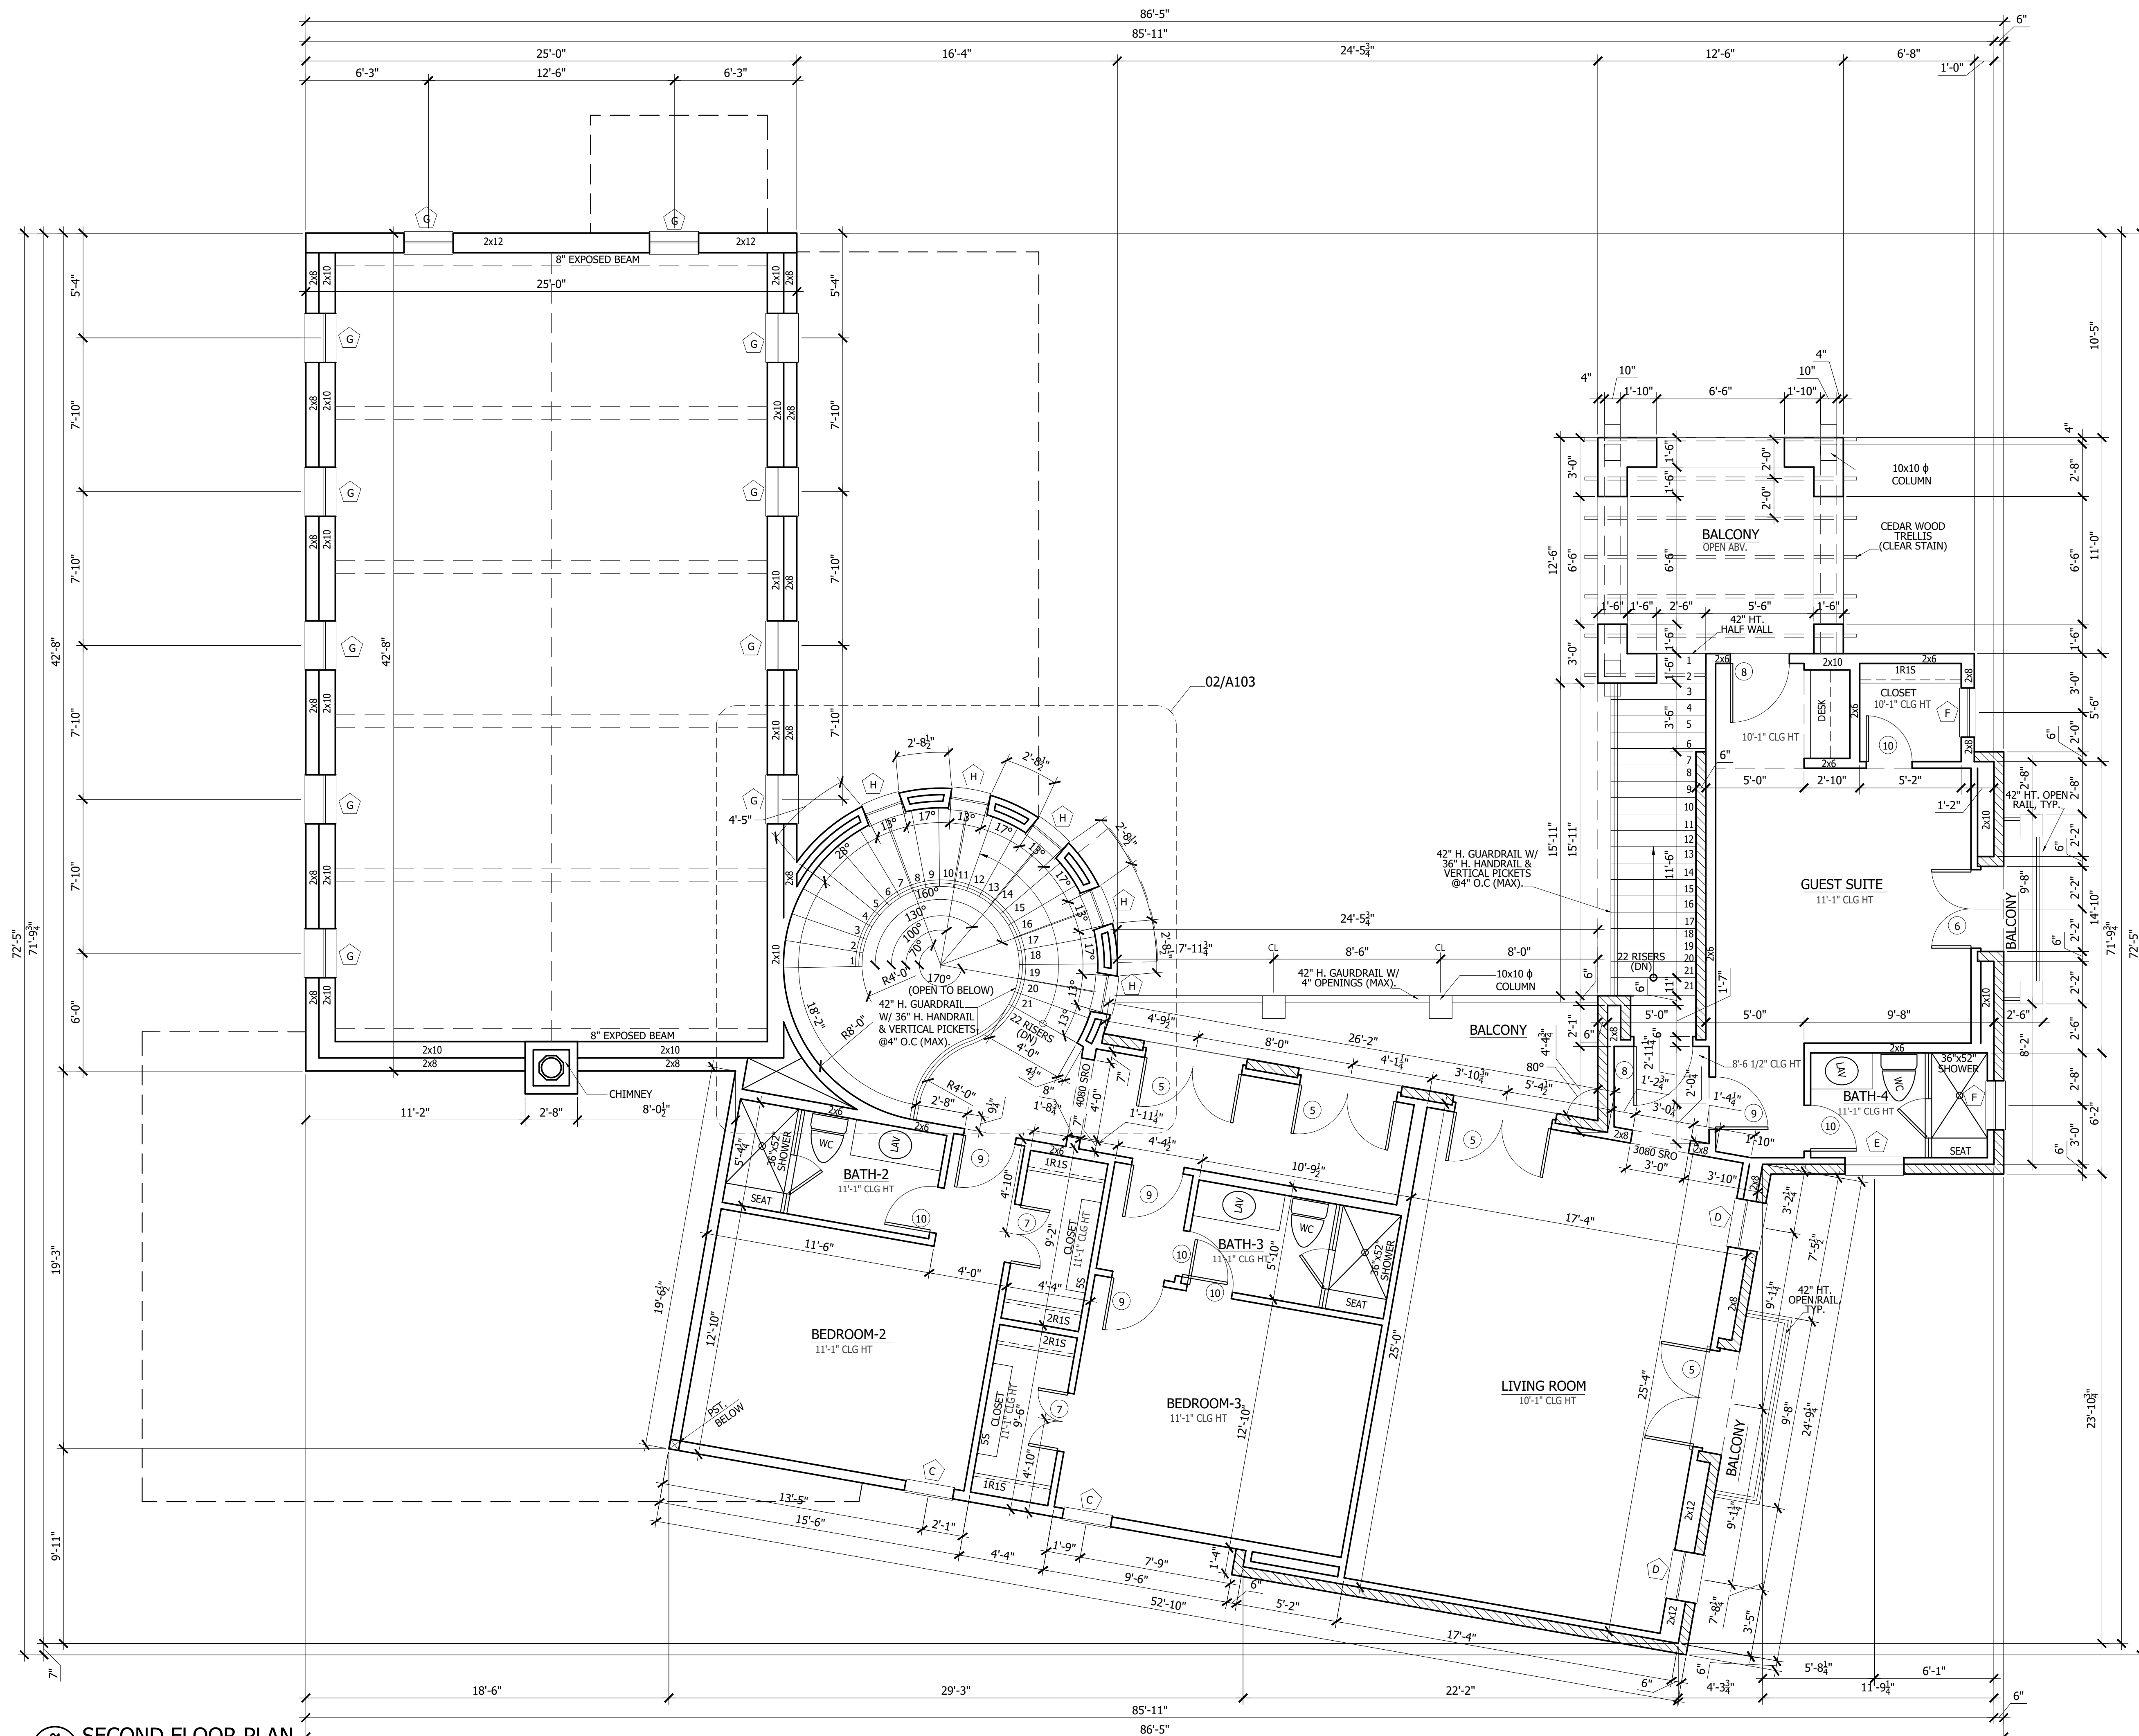

01 SECOND FLOOR PLAN
A102 SCALE: 1/4"=1'-0"

REFER TO **ENTRADA DESIGN GUIDELINES** FOR FUTHER DETAILED INFORMATION REGARDING THESE PLANS



ENTRADA


LOT 1, 2, & 3 - BLOCK H

TOWN OF WESTLAKE TARRANT COUNTY, TEXAS


[illegible]

DETAIL FLOOR PLAN

A103

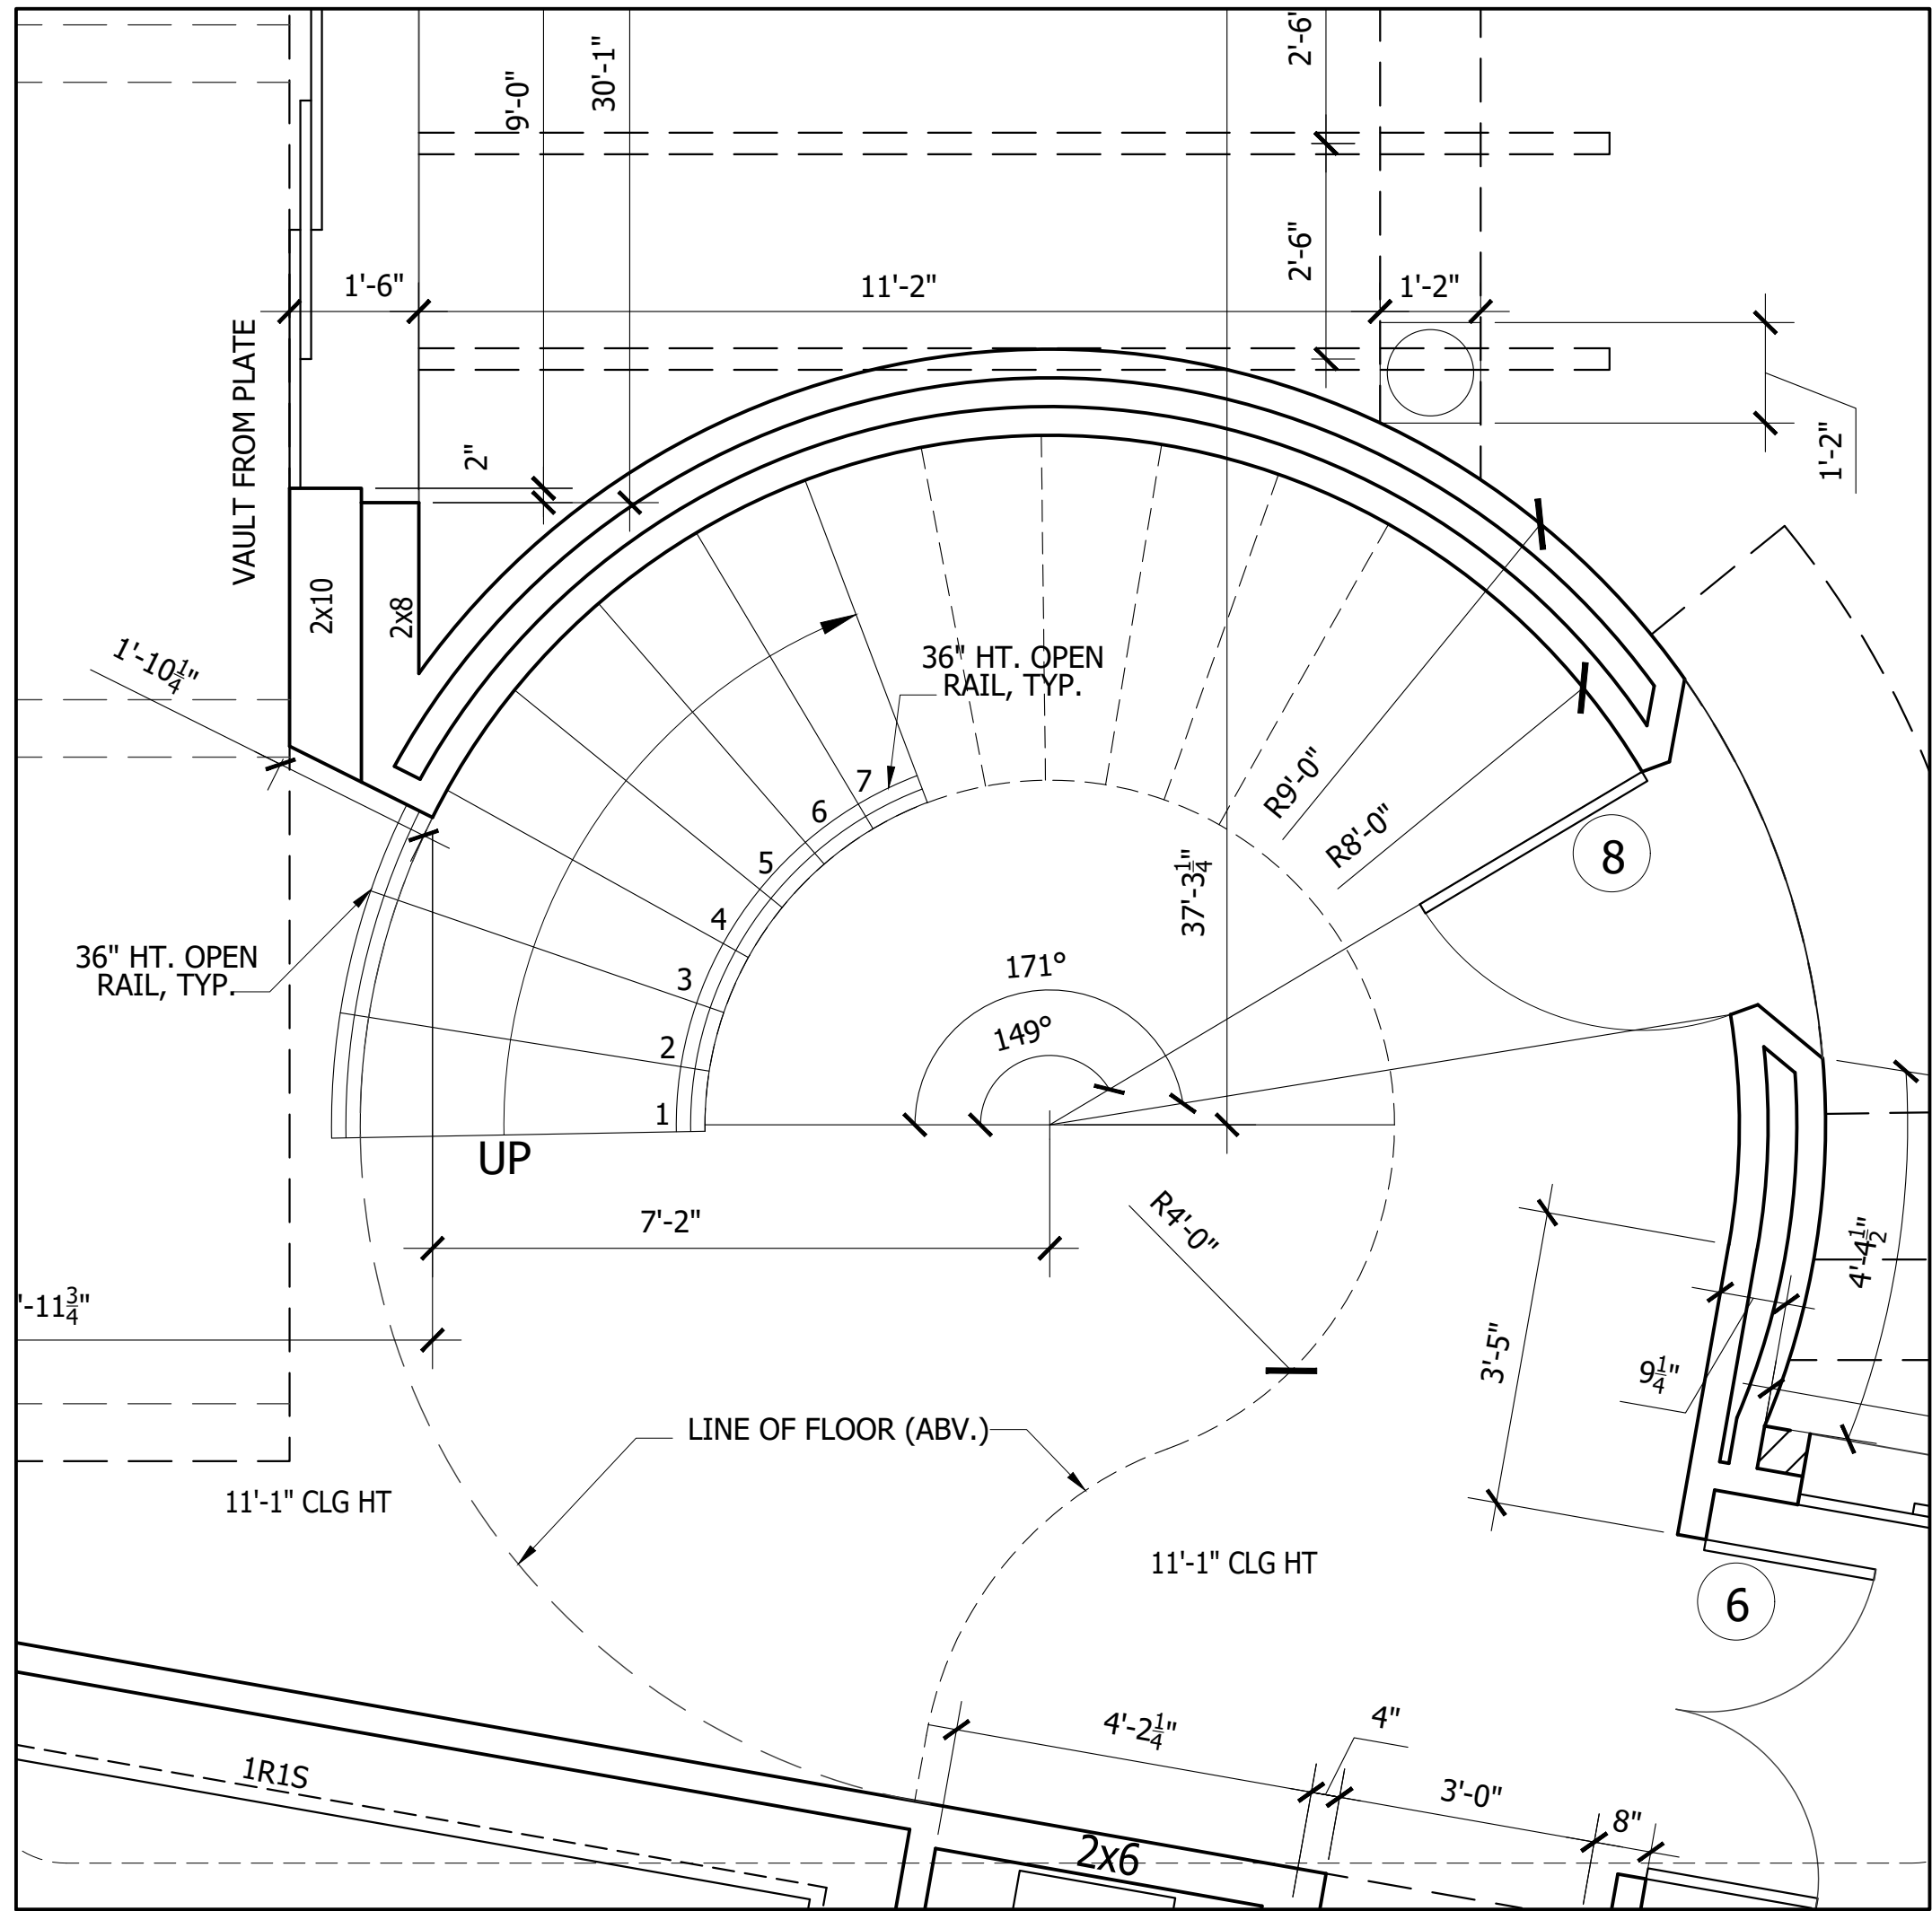

01 TURRET DETAIL @ FIRST FLOOR
A103 SCALE: 1/2"=1'-0"

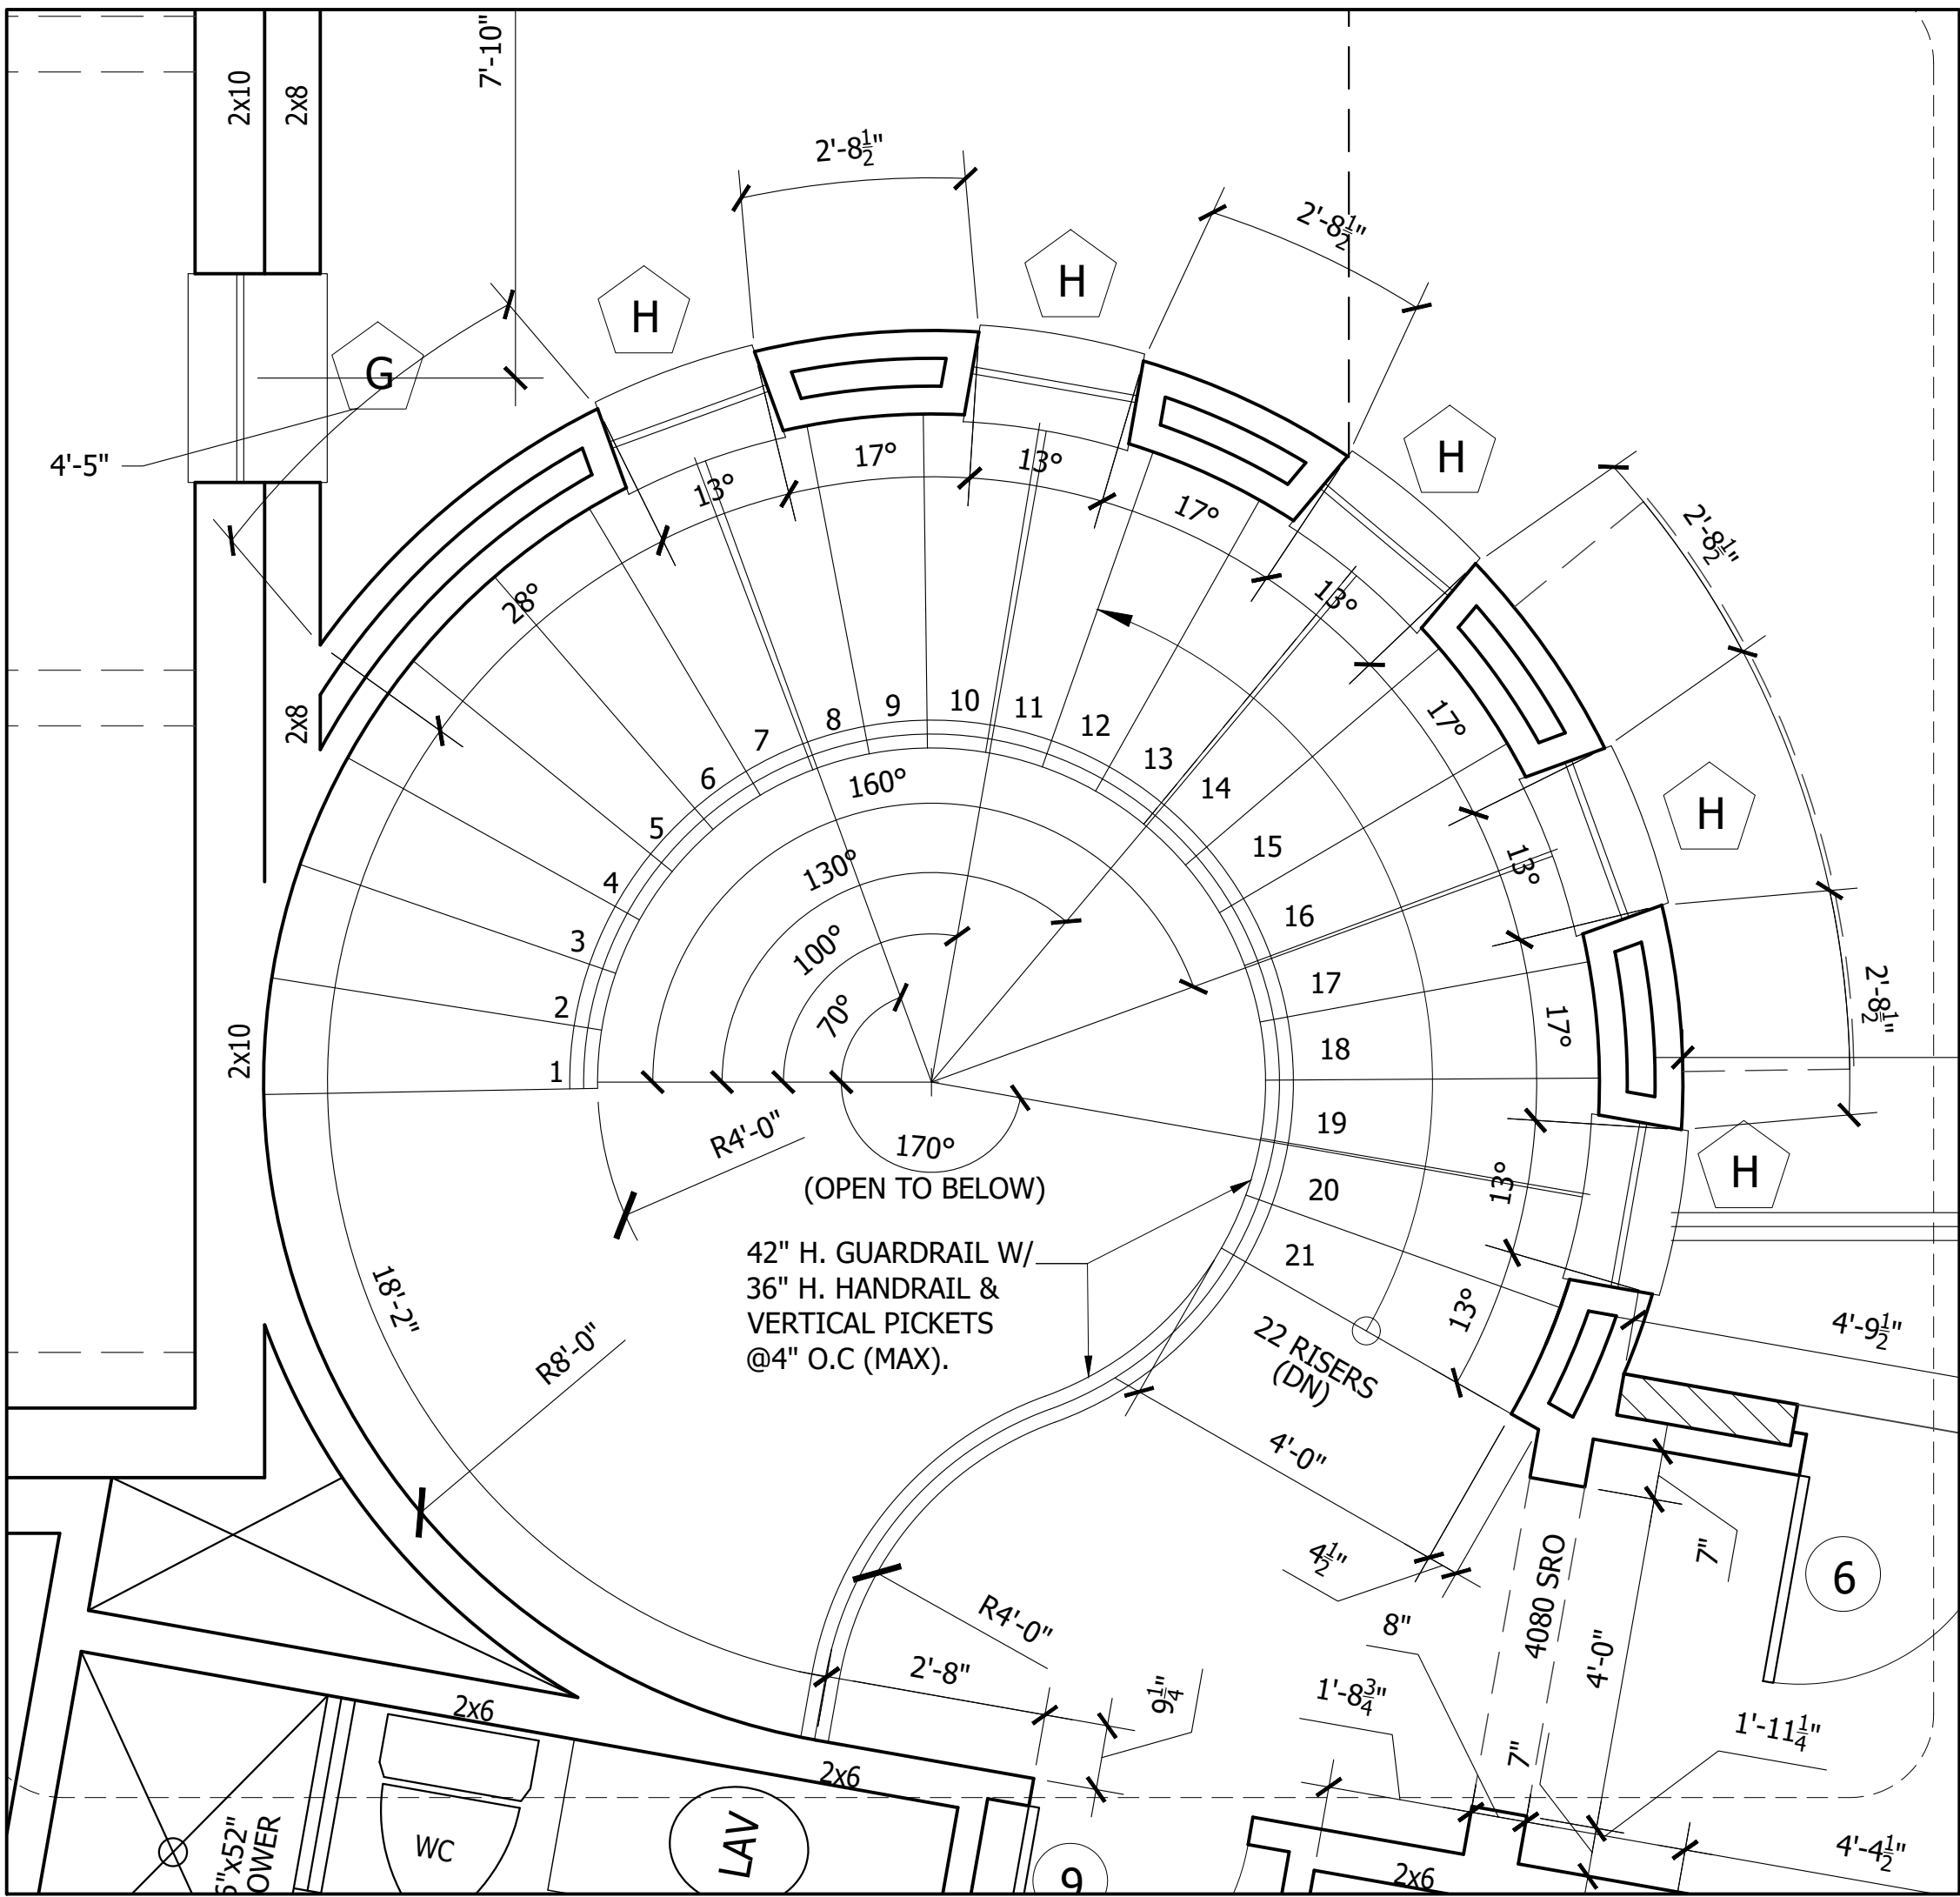

02 TURRET DETAIL @ SECOND FLOOR
A103 SCALE: 1/2"=1'-0"

REFER TO **ENTRADA DESIGN GUIDELINES** FOR FUTHER DETAILED INFORMATION REGARDING THESE PLANS

ENTRADA

LOT 1, 2, & 3 - BLOCK H

TOWN OF WESTLAKE TARRANT COUNTY, TEXAS

ISSUE LOG

NO.	DESCRIPTION	DATE

PROJECT NO:	20-129
ISSUED FOR:	OTP
DRAWN BY:	WILL
DATE:	11/29/21

DOOR &
WINDOW SCHEDULE

A104

DOOR SCHEDULE							
TAG	DOOR	WIDTH	HEIGHT	TYPE	MATERIAL	STYLE	NOTES
1	18080	18'-0"	8'-0"	EXTERIOR	WOOD		SLIDER
1	18080	18'-0"	8'-0"	EXTERIOR	WOOD		SLIDER
2	10880	10'-8"	8'-0"	EXTERIOR	WOOD		SLIDER
3	9080	9'-0"	8'-0"	EXTERIOR	WOOD		ARCH / O' HEAD
3	9080	9'-0"	8'-0"	EXTERIOR	WOOD		ARCH / O' HEAD
3	9080	9'-0"	8'-0"	EXTERIOR	WOOD		ARCH / O' HEAD
4	PR3090	6'-0"	9'-0"	EXTERIOR	WOOD	PAIR	ARCH / WOODEN GATE
5	PR2680	5'0"	8'-0"	EXTERIOR	WOOD	PAIR	
5	PR2680	5'0"	8'-0"	EXTERIOR	WOOD	PAIR	
5	PR2680	5'0"	8'-0"	EXTERIOR	WOOD	PAIR	
5	PR2680	5'0"	8'-0"	EXTERIOR	WOOD	PAIR	
6	PR2080	4'-0"	8'-0"	EXTERIOR	WOOD	PAIR	
6	PR2080	4'-0"	8'-0"	INTERIOR	WOOD	PAIR	
7	PR1680	3'-0"	8'-0"	INTERIOR	WOOD	PAIR	
7	PR1680	3'-0"	8'-0"	INTERIOR	WOOD	PAIR	
7	PR1680	3'-0"	8'-0"	INTERIOR	WOOD	PAIR	
8	3080	3'-0"	8'-0"	EXTERIOR	WOOD		ARCH
8	3080	3'-0"	8'-0"	EXTERIOR	WOOD		
8	3080	3'-0"	8'-0"	EXTERIOR	WOOD		
8	3080	3'-0"	8'-0"	EXTERIOR	WOOD		
8	3080	3'-0"	8'-0"	INTERIOR	WOOD		
8	3080	3'-0"	8'-0"	INTERIOR	WOOD		
9	2880	2'-8"	8'-0"	EXTERIOR	WOOD		
9	2880	2'-8"	8'-0"	EXTERIOR	WOOD		
9	2880	2'-8"	8'-0"	INTERIOR	WOOD		
9	2880	2'-8"	8'-0"	INTERIOR	WOOD		
9	2880	2'-8"	8'-0"	INTERIOR	WOOD		
9	2880	2'-8"	8'-0"	INTERIOR	WOOD		
9	2880	2'-8"	8'-0"	INTERIOR	WOOD		
9	2880	2'-8"	8'-0"	INTERIOR	WOOD		
9	2880	2'-8"	8'-0"	INTERIOR	WOOD		
10	2480	2'-4"	8'-0"	INTERIOR	WOOD		
10	2480	2'-4"	8'-0"	INTERIOR	WOOD		
10	2480	2'-4"	8'-0"	INTERIOR	WOOD		
10	2480	2'-4"	8'-0"	INTERIOR	WOOD		
10	2480	2'-4"	8'-0"	INTERIOR	WOOD		

01

DOOR SCHEDULE

A104

SCALE: 1/4"=1'-0"

WINDOW SCHEDULE								
TAG	WINDOW	WIDTH	HEIGHT	HDR	HT	LITE WIDTH HEIGHT	TYPE	NOTES
A	5050	5'-0"	5'-0"	8'-0"	3	3	FXD DL	OBSCURED/TEMPERED
B	2650	2'-6"	5'-0"	8'-0"	2	3	FXD DL	
B	2650	2'-6"	5'-0"	8'-0"	2	3	FXD DL	
B	2650	2'-6"	5'-0"	8'-0"	2	3	FXD DL	
B	2650	2'-6"	5'-0"	8'-0"	2	3	FXD DL	
C	2650	2'-6"	5'-0"	8'-0"	2	3	CSMT DL	
C	2650	2'-6"	5'-0"	8'-0"	2	3	CSMT DL	
C	2650	2'-6"	5'-0"	8'-0"	2	3	CSMT DL	
C	2650	2'-6"	5'-0"	8'-0"	2	3	CSMT DL	
D	2650	2'-6"	5'-0"	8'-0"	2	3	DH DL	
D	2650	2'-6"	5'-0"	8'-0"	2	3	DH DL	
E	2636	2'-6"	3'-6"	8'-0"	2	2	FXD DL	TEMP
F	2630	2'-6"	3'-0"	8'-0"	2	2	FXD DL	TEMP
F	2630	2'-6"	3'-0"	8'-0"	2	2	FXD DL	
F	2630	2'-6"	3'-0"	8'-0"	2	3	FXD DL	
F	2630	2'-6"	3'-0"	8'-0"	2	3	FXD DL	
F	2630	2'-6"	3'-0"	8'-0"	2	3	FXD DL	
F	2630	2'-6"	3'-0"	8'-0"	2	3	FXD DL	
G	2626	2'-0"	2'-0"	17'-4"	2	2	FXD DL	
G	2626	2'-0"	2'-0"	17'-4"	2	2	FXD DL	
H	2020	2'-0"	2'-0"	22'-8"	2	2	FXD DL	
H	2020	2'-0"	2'-0"	22'-8"	2	2	FXD DL	
H	2020	2'-0"	2'-0"	22'-8"	2	2	FXD DL	
H	2020	2'-0"	2'-0"	22'-8"	2	2	FXD DL	
H	2020	2'-0"	2'-0"	22'-8"	2	2	FXD DL	

02

WINDOW SCHEDULE

A104

SCALE: 1/4"=1'-0"

REFER TO **ENTRADA DESIGN GUIDELINES** FOR FUTHER DETAILED INFORMATION REGARDING THESE PLANS

ELECTRICAL NOTES

ECTRICAL INSTALLATION SHALL MEET REQUIREMENTS
F APPROVED CODES AND REGULATIONS.
ERIFY UTILITIES AND LOCATIONS WITH CONTRACTOR.
WITCHED CONVENIENCE OUTLETS TO BE SWITCHED AT
DP OUTLET ONLY.
WITCHES: 4'-6" ABV. FINISHED FLOOR TO CENTERLINE
F SWITCH, UNLESS NOTED OTHERWISE.
TERIOR WALL MOUNTED BRACKET FIXTURES: 6'-6" ABV.
NISHED WALKING SURFACE TO CENTERLINE OF
ACKET, U.N.O.
TERIOR WALL MOUNTED BRACKET FIXTURES: 7'-0" ABV.
NISHED WALKING SURFACE TO CENTERLINE OF
ACKET, U.N.O.
MOKE/CARBON MONOXIDE DETECTORS : COORDINATE
/ ALARM SYSTEM. DETECTORS TO COMPLY WITH
OVERRING CODES AND REGULATIONS.
ROVIDE 220V JUNCTION BOX AND OTHER REQUIRED
IRING FOR HVAC UNITS. VERIFY LOCATION WITH
ONTRACTOR.
ERIFY ALL EQUIPMENT POWER REQUIREMENTS WITH THE
ANUFACTURER AND/OR SUPPLIER.
LL EXTERIOR CONVENIENCE OUTLETS TO BE WATER
ROOF AND ON A GROUND FAULT CIRCUIT
LL OUTLETS SHALL BE COMBINATION TYPE AFCI AND
HALL BE TAMPER PROOF/RESISTENT.

ELECTRICAL SYMBOLS

LIGHT FIXTURES

CEILING MOUNTED

WITH PULL CHAIN

WALL BRACKET - INTERIOR AND EXTERIOR

RECESSED IN CEILING OR SOFFIT

RECESSED "WALL WASHER" IN CEILING OR SOFFIT

FLUORESCENT FIXTURE

UNDER CABINET LIGHT

RECESSED "PIN HOLE" IN CEILING OR SOFFIT

WALL MOUNTED FLOODLIGHT

CEILING SPEAKER

LANDSCAPE LIGHT

LOW VOLTAGE

CONVENIENCE OUTLETS

110V, DUPLEX OUTLET;
12" ABOVE FLOOR-TYP.

110V, FOURPLEX OUTLET;
12" ABOVE FLOOR-TYP.

DISTANCE ABOVE FLOOR;
OTHER THAN 12"

WATERPROOF
GROUNDFAULT
OUTLET

GARAGE DOOR
OPENER

GROUNDFAULT
OUTLET

ARC
FAULT

SWITCHED OUTLET

FLOOR OUTLET

220V. OUTLET

SWITCHES

SINGLE POLE SWITCH

THREE WAY SWITCH

FOUR WAY SWITCH

DIMMER SWITCH

GENERAL

110V JUNCTION BOX

220V JUNCTION BOX

GARABGE DISPOSAL

EXHAUST FAN

EXHAUST FAN W/ LIGHT

WALL EXHAUST FAN

ELECTRICAL PANEL

TELEVISION OUTLET

TELEPHONE/DATA OUTLET

FAUCET

SMOKE DETECTOR/
CARBON MONOXIDE
DETECTOR

S.D./C.O.


PUSH BUTTON

LANTERN

CHANDELLIER

CEILING FAN

CEILING FAN W/
LIGHT

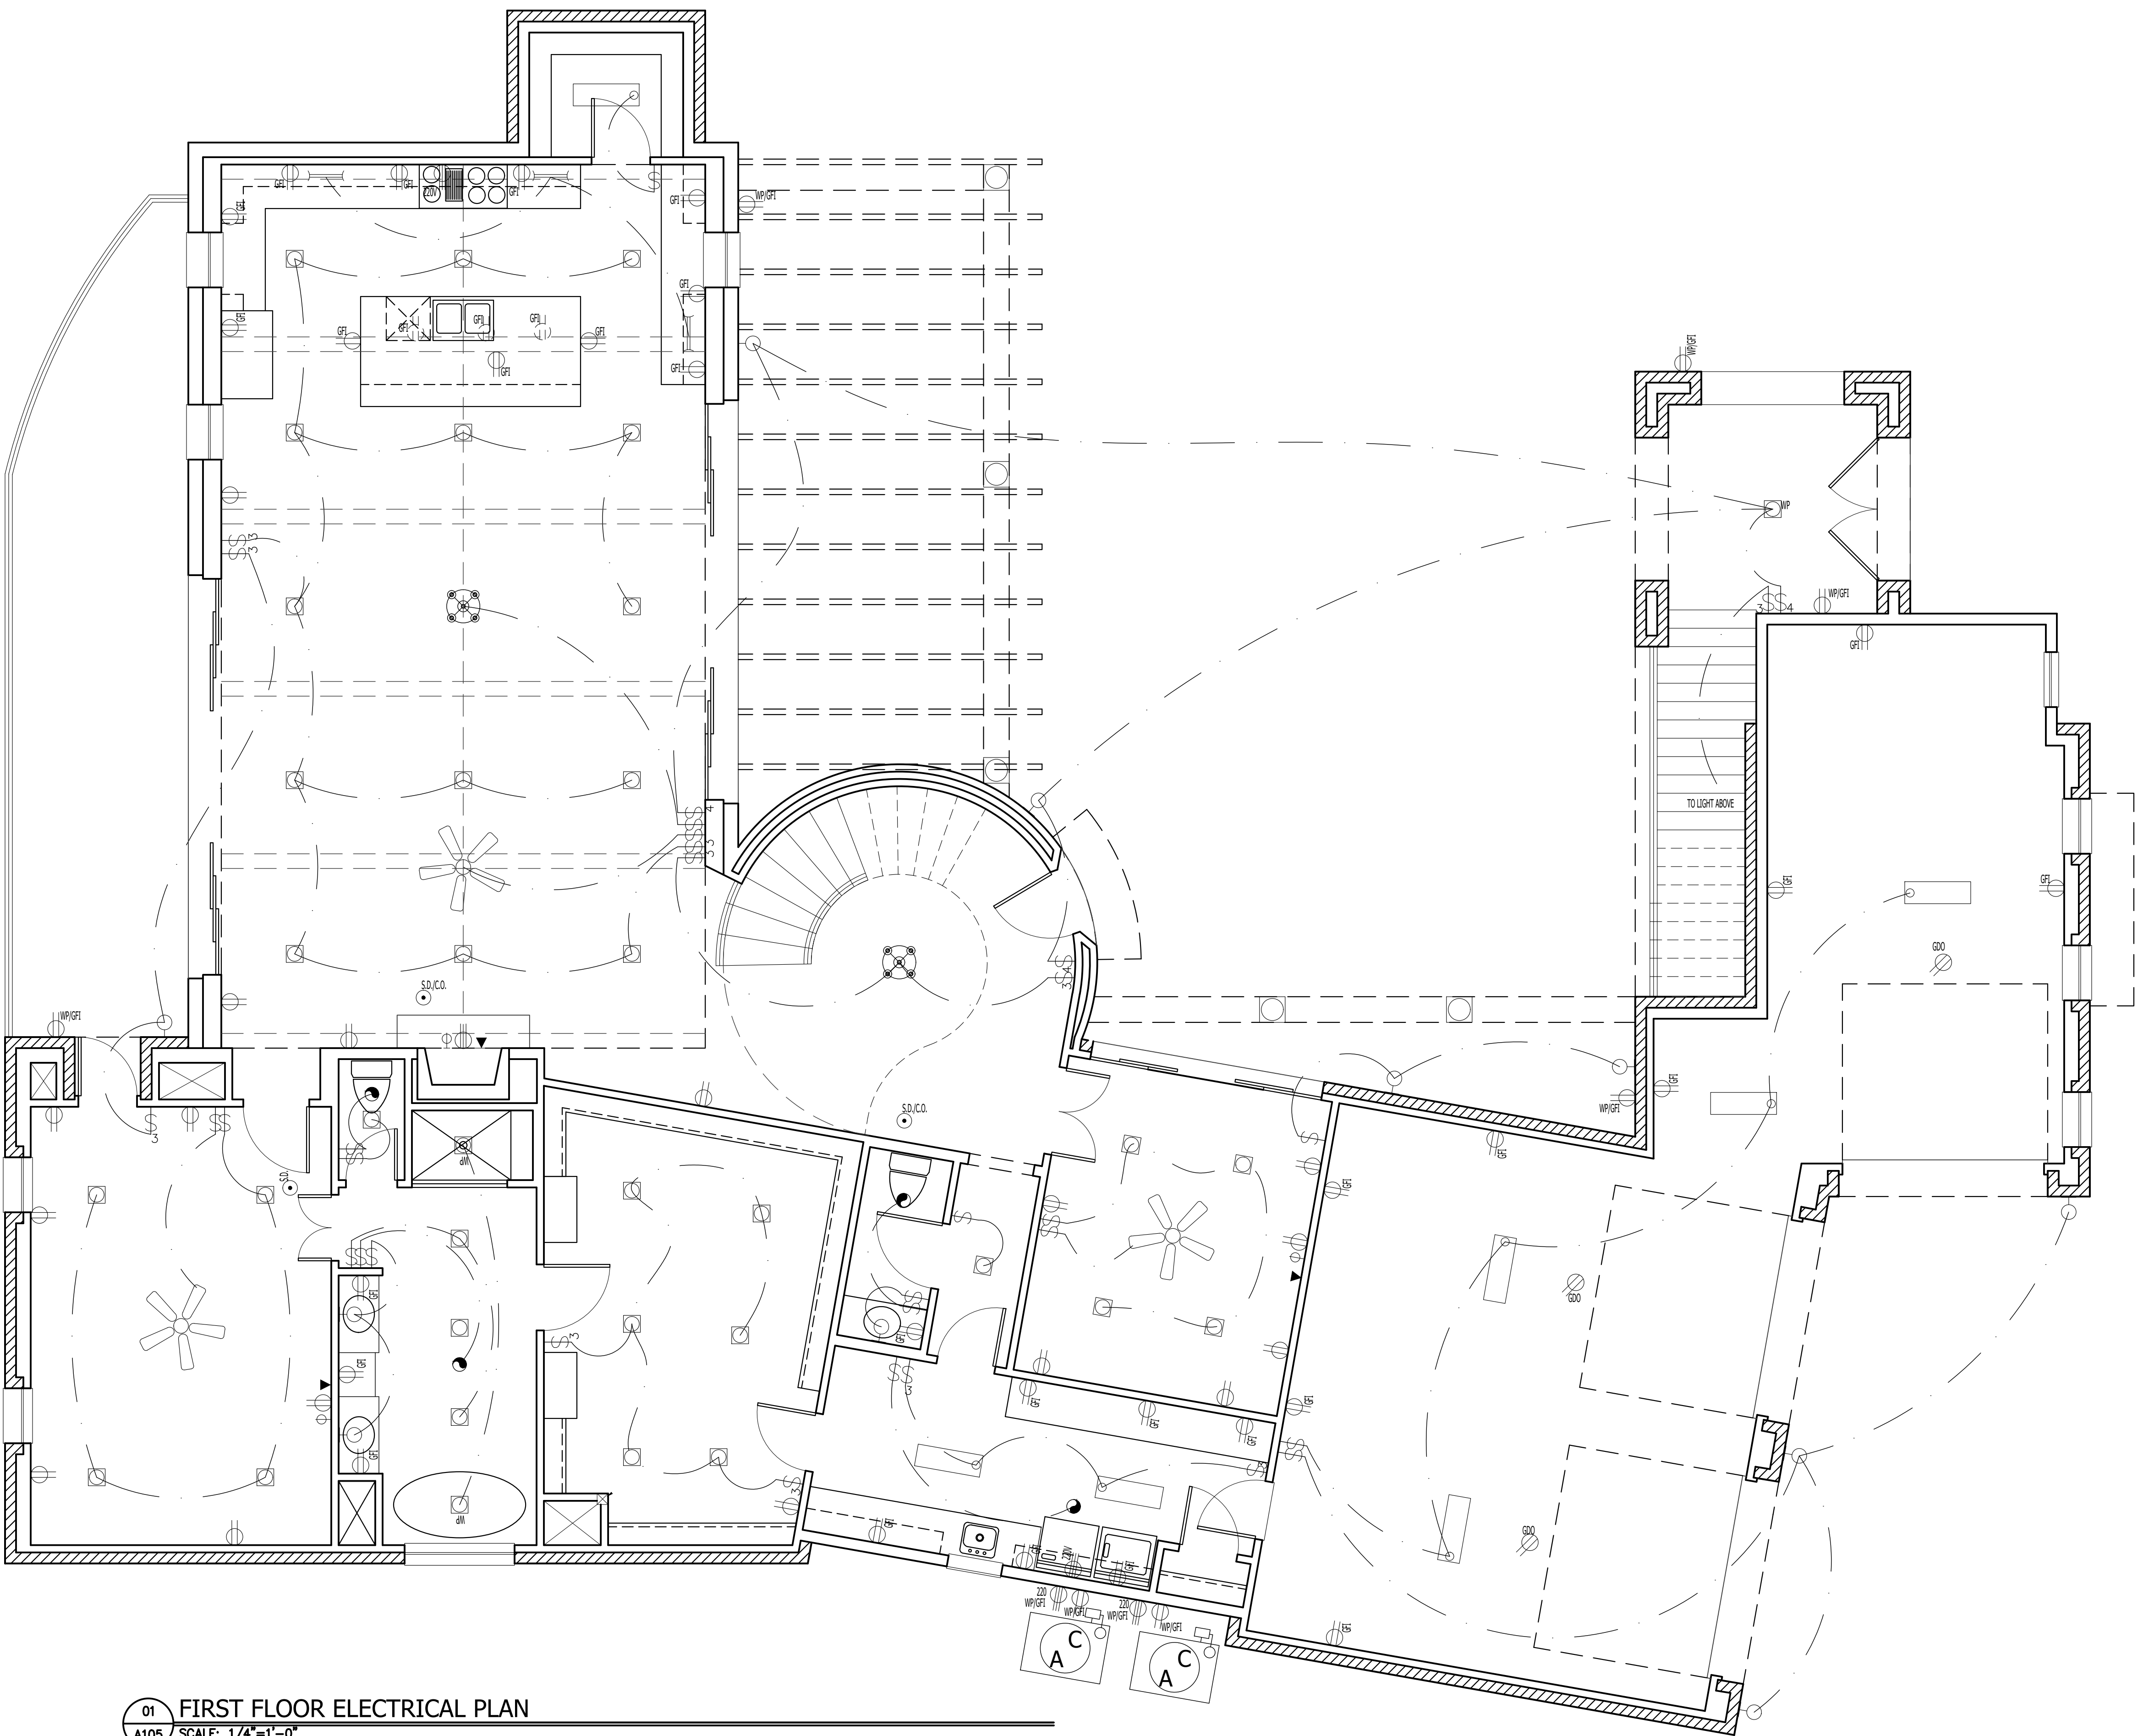

01 FIRST FLOOR ELECTRICAL PLAN
A105 SCALE: 1/4"=1'-0"

ENTRADA

LOT 1, 2, & 3 - BLOCK H

TOWN OF WESTLAKE TARRANT COUNTY, TEXAS

ISSUE LOG

NO.	DESCRIPTION	DATE

PROJECT NO:	20-129
ISSUED FOR:	OTP
DRAWN BY:	WLL
DATE:	11/29/21

FIRST FLOOR
ELECTRICAL PLAN

A105

ELECTRICAL NOTES

LECTRICAL INSTALLATION SHALL MEET REQUIREMENTS
F APPROVED CODES AND REGULATIONS.
ERIFY UTILITIES AND LOCATIONS WITH CONTRACTOR.
WITCHED CONVENIENCE OUTLETS TO BE SWITCHED AT
DP OUTLET ONLY.
WITCHES: 4'-6" ABV. FINISHED FLOOR TO CENTERLINE
F SWITCH, UNLESS NOTED OTHERWISE.
TERIOR WALL MOUNTED BRACKET FIXTURES: 6'-6" ABV.
NISHED WALKING SURFACE TO CENTERLINE OF
ACKET, U.N.O.
TERIOR WALL MOUNTED BRACKET FIXTURES: 7'-0" ABV.
NISHED WALKING SURFACE TO CENTERLINE OF
ACKET, U.N.O.
MOKE/CARBON MONOXIDE DETECTORS : COORDINATE
/ ALARM SYSTEM. DETECTORS TO COMPLY WITH
OVERRING CODES AND REGULATIONS.
ROVIDE 220V JUNCTION BOX AND OTHER REQUIRED
IRING FOR HVAC UNITS. VERIFY LOCATION WITH
ONTRACTOR.
ERIFY ALL EQUIPMENT POWER REQUIREMENTS WITH THE
ANUFACTURER AND/OR SUPPLIER.
LL EXTERIOR CONVENIENCE OUTLETS TO BE WATER
ROOF AND ON A GROUND FAULT CIRCUIT
LL OUTLETS SHALL BE COMBINATION TYPE AFCI AND
HALL BE TAMPER PROOF/RESISTENT.

ELECTRICAL SYMBOLS

LIGHT FIXTURES

CEILING MOUNTED

WITH PULL CHAIN

WALL BRACKET - INTERIOR AND EXTERIOR

RECESSED IN CEILING OR SOFFIT

RECESSED "WALL WASHER" IN CEILING OR SOFFIT

FLUORESCENT FIXTURE

UNDER CABINET LIGHT

RECESSED "PIN HOLE" IN CEILING OR SOFFIT

WALL MOUNTED FLOODLIGHT

CEILING SPEAKER

LANDSCAPE LIGHT

LOW VOLTAGE

CONVENIENCE OUTLETS

110V, DUPLEX OUTLET;
12" ABOVE FLOOR-TYP.

110V, FOURPLEX OUTLET;
12" ABOVE FLOOR-TYP.

DISTANCE ABOVE FLOOR;
OTHER THAN 12"

WATERPROOF
GROUNDFAULT
OUTLET

GARAGE DOOR
OPENER

GFI GROUNDFAULT
OUTLET

ARC ARC FAULT

SWITCHED OUTLET

FLOOR OUTLET

220V OUTLET

SWITCHES

SINGLE POLE SWITCH

THREE WAY SWITCH

FOUR WAY SWITCH

DIMMER SWITCH

GENERAL

110V JUNCTION BOX

220V JUNCTION BOX

GARBAGE DISPOSAL

EXHAUST FAN

EXHAUST FAN W/ LIGHT

WALL EXHAUST FAN

ELECTRICAL PANEL

TELEVISION OUTLET

TELEPHONE/DATA OUTLET

FAUCET

SMOKE DETECTOR/
CARBON MONOXIDE
DETECTOR

S.D./C.O.


PUSH BUTTON

LANTERN

CHANDELLIER

CEILING FAN

CEILING FAN W/ LIGHT

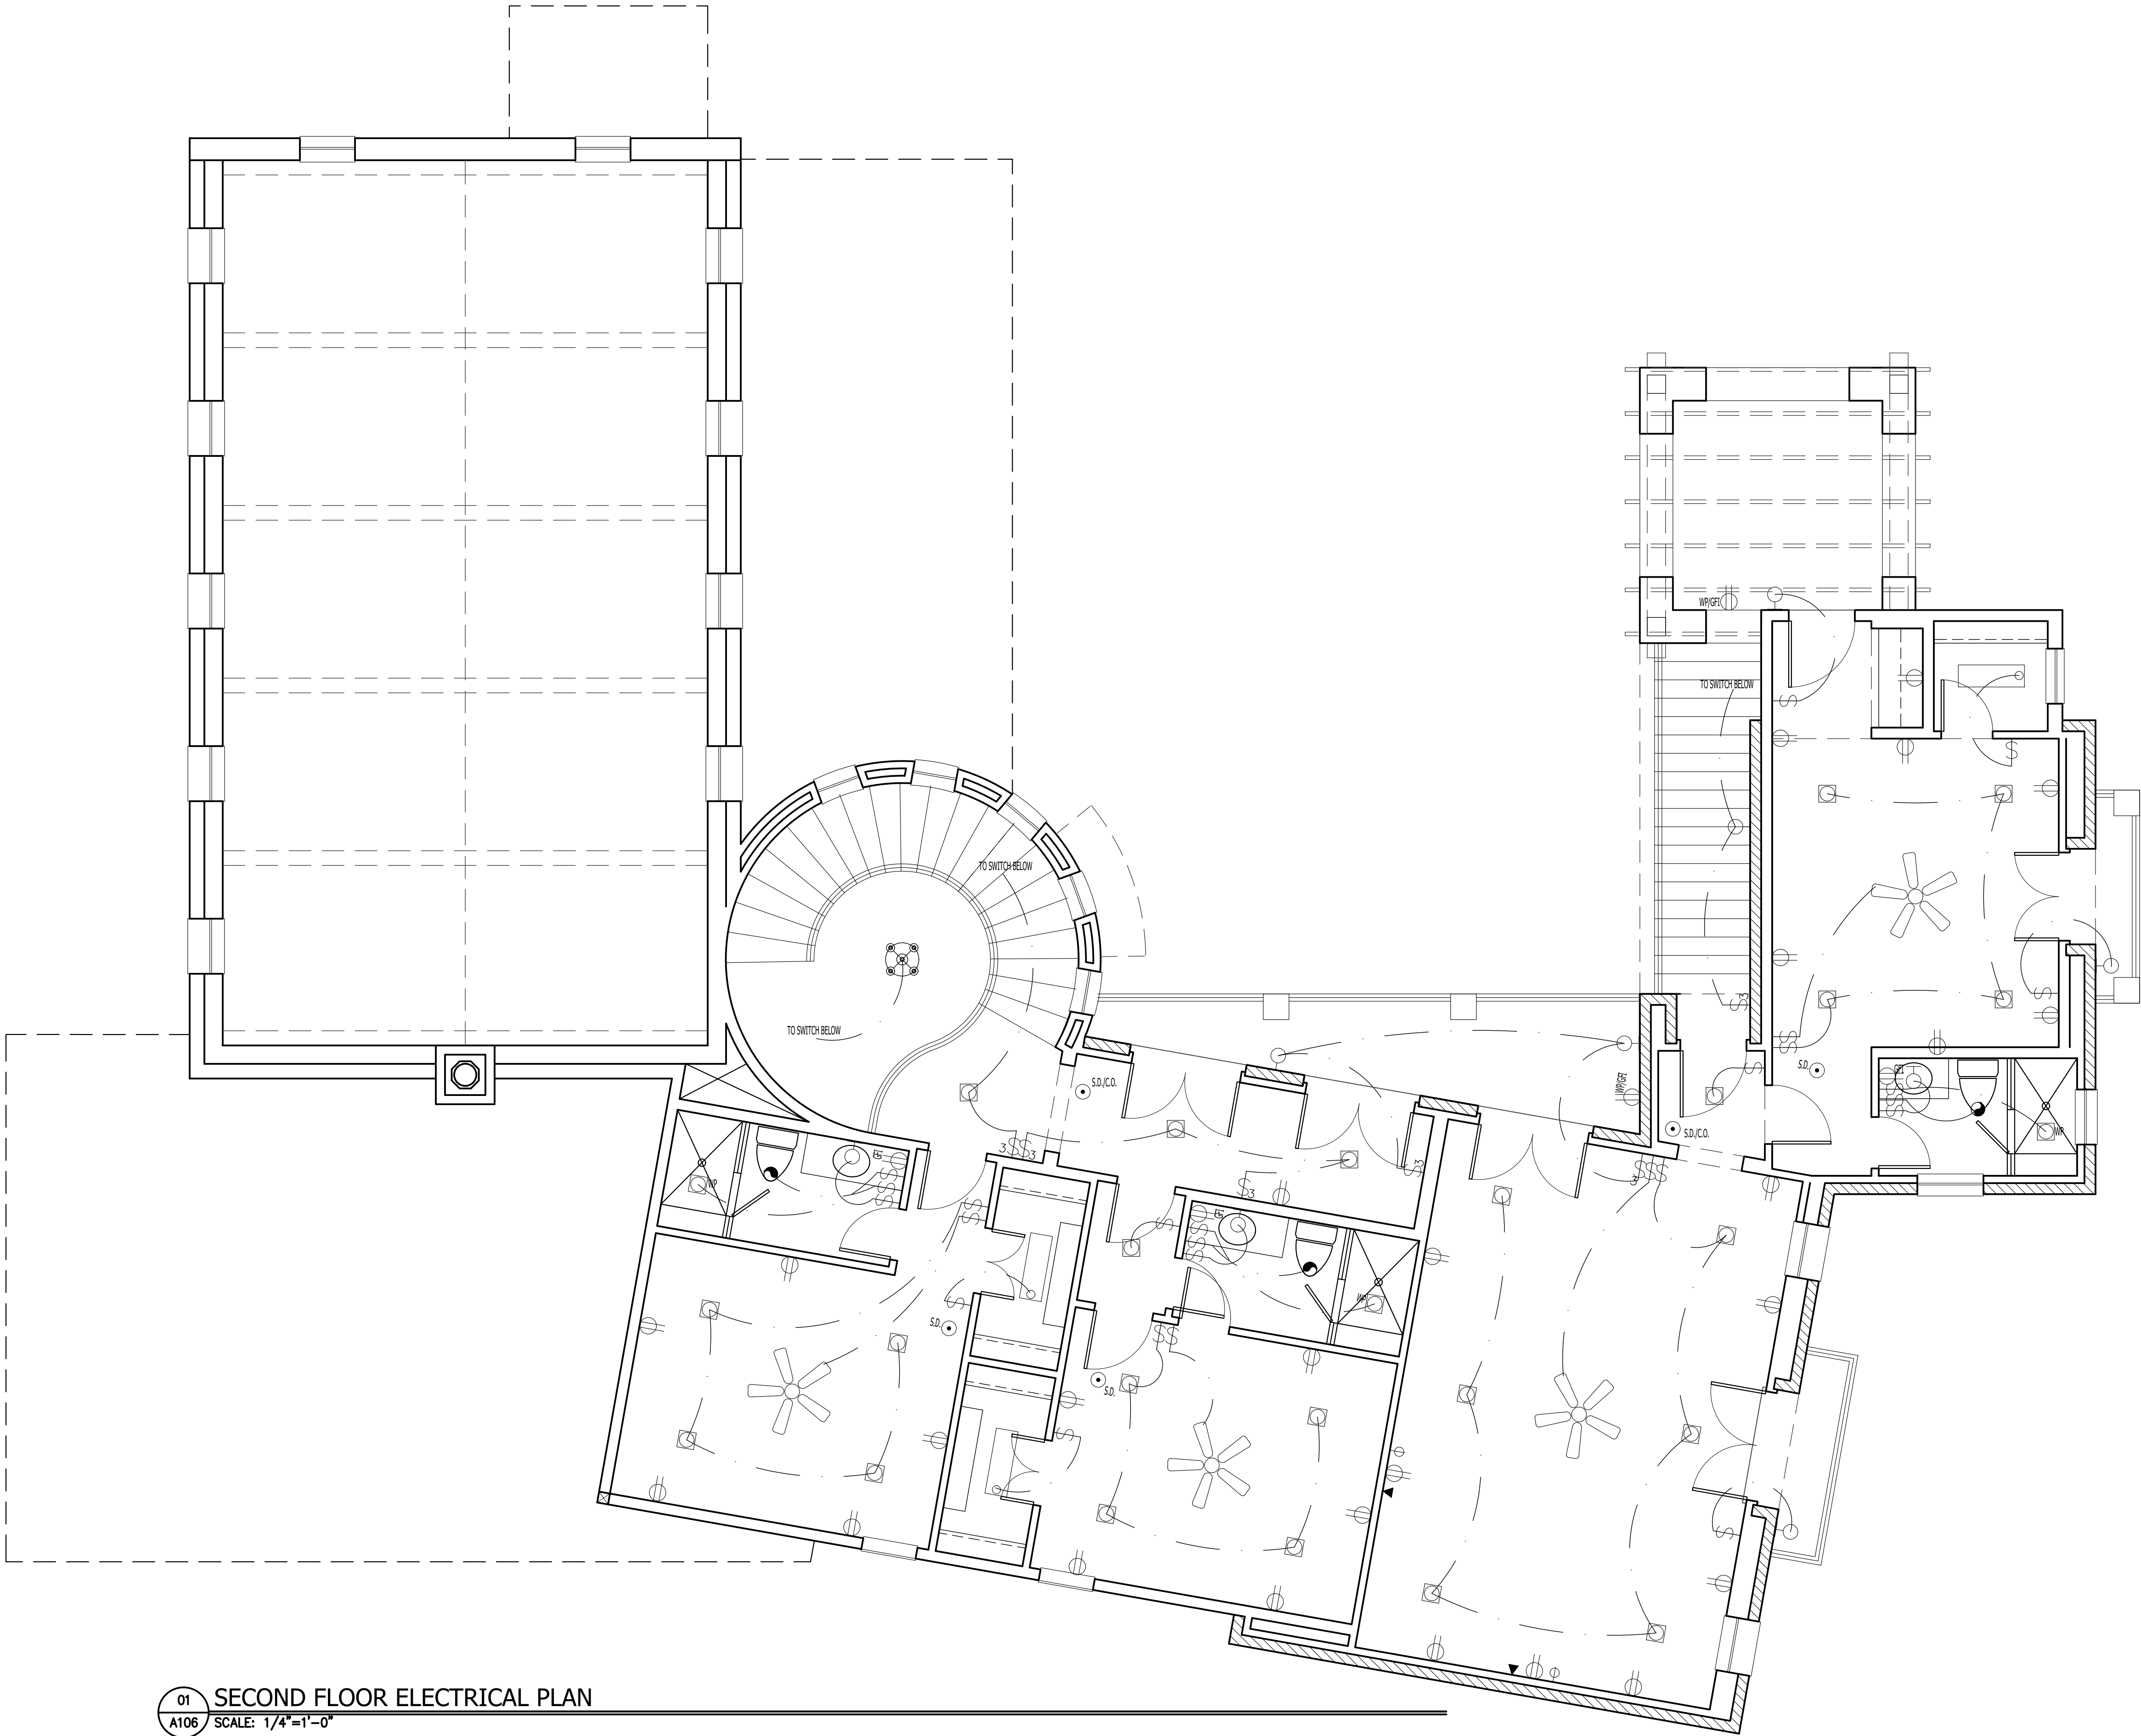

01 SECOND FLOOR ELECTRICAL PLAN
A106 SCALE: 1/4"=1'-0"

ENTRADA

LOT 1, 2, & 3 - BLOCK H

TOWN OF WESTLAKE TARRANT COUNTY, TEXAS

ISSUE LOG

NO.	DESCRIPTION	DATE

PROJECT NO:	20-129
ISSUED FOR:	OTP
DRAWN BY:	WLL
DATE:	11/29/21

**SECOND FLOOR
ELECTRICAL PLAN**

A106



ENTRADA

LOT 1, 2, & 3 - BLOCK H

TOWN OF WESTLAKE TARRANT COUNTY, TEXAS


ISSUE LOG

[illegible]

PROJECT NO:	20-129
ISSUED FOR:	OTP
DRAWN BY:	WLL
DATE:	11/29/21

ROOF PLAN

A107

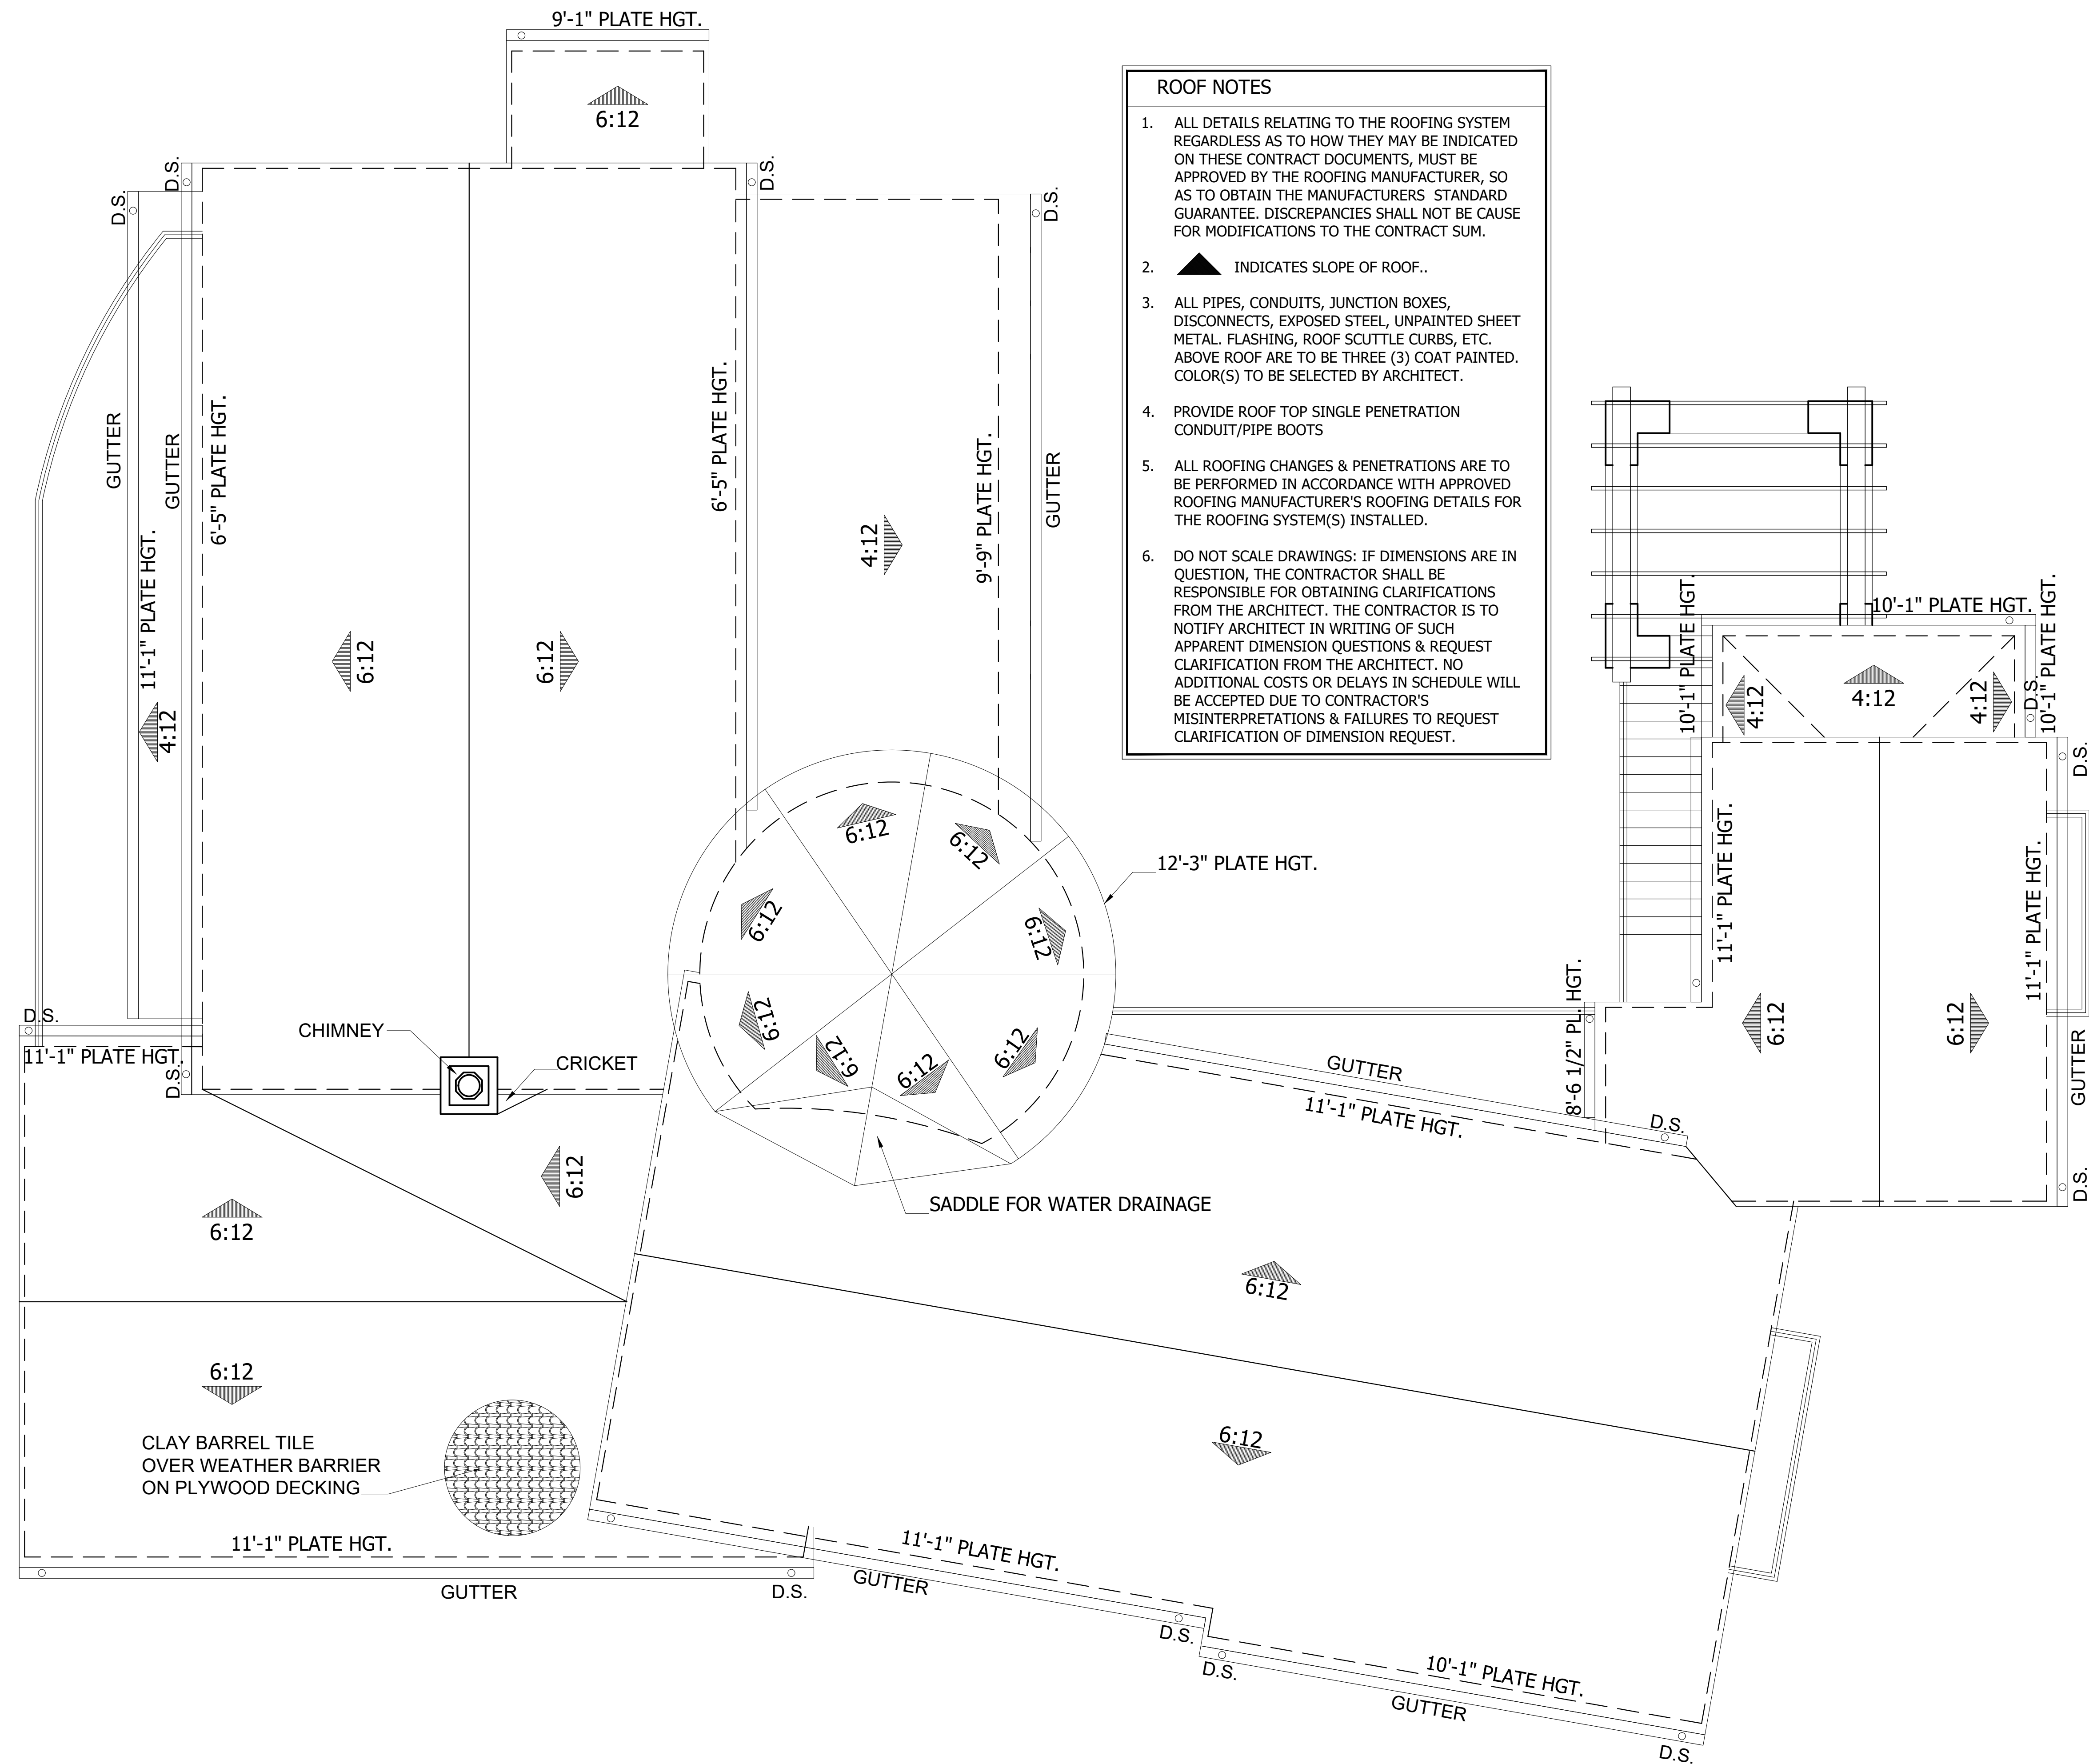

01 ROOF PLAN
A107 SCALE: 3/16"=1'-0"

REFER TO **ENTRADA DESIGN GUIDELINES** FOR FUTHER DETAILED INFORMATION REGARDING THESE PLANS



REFER TO **ENTRADA DESIGN GUIDELINES** FOR FUTHER DETAILED INFORMATION REGARDING THESE PLANS




ENTRADA

LOT 1, 2, & 3 - BLOCK H


[illegible]

REAR & RIGHT ELEVATIONS

A201

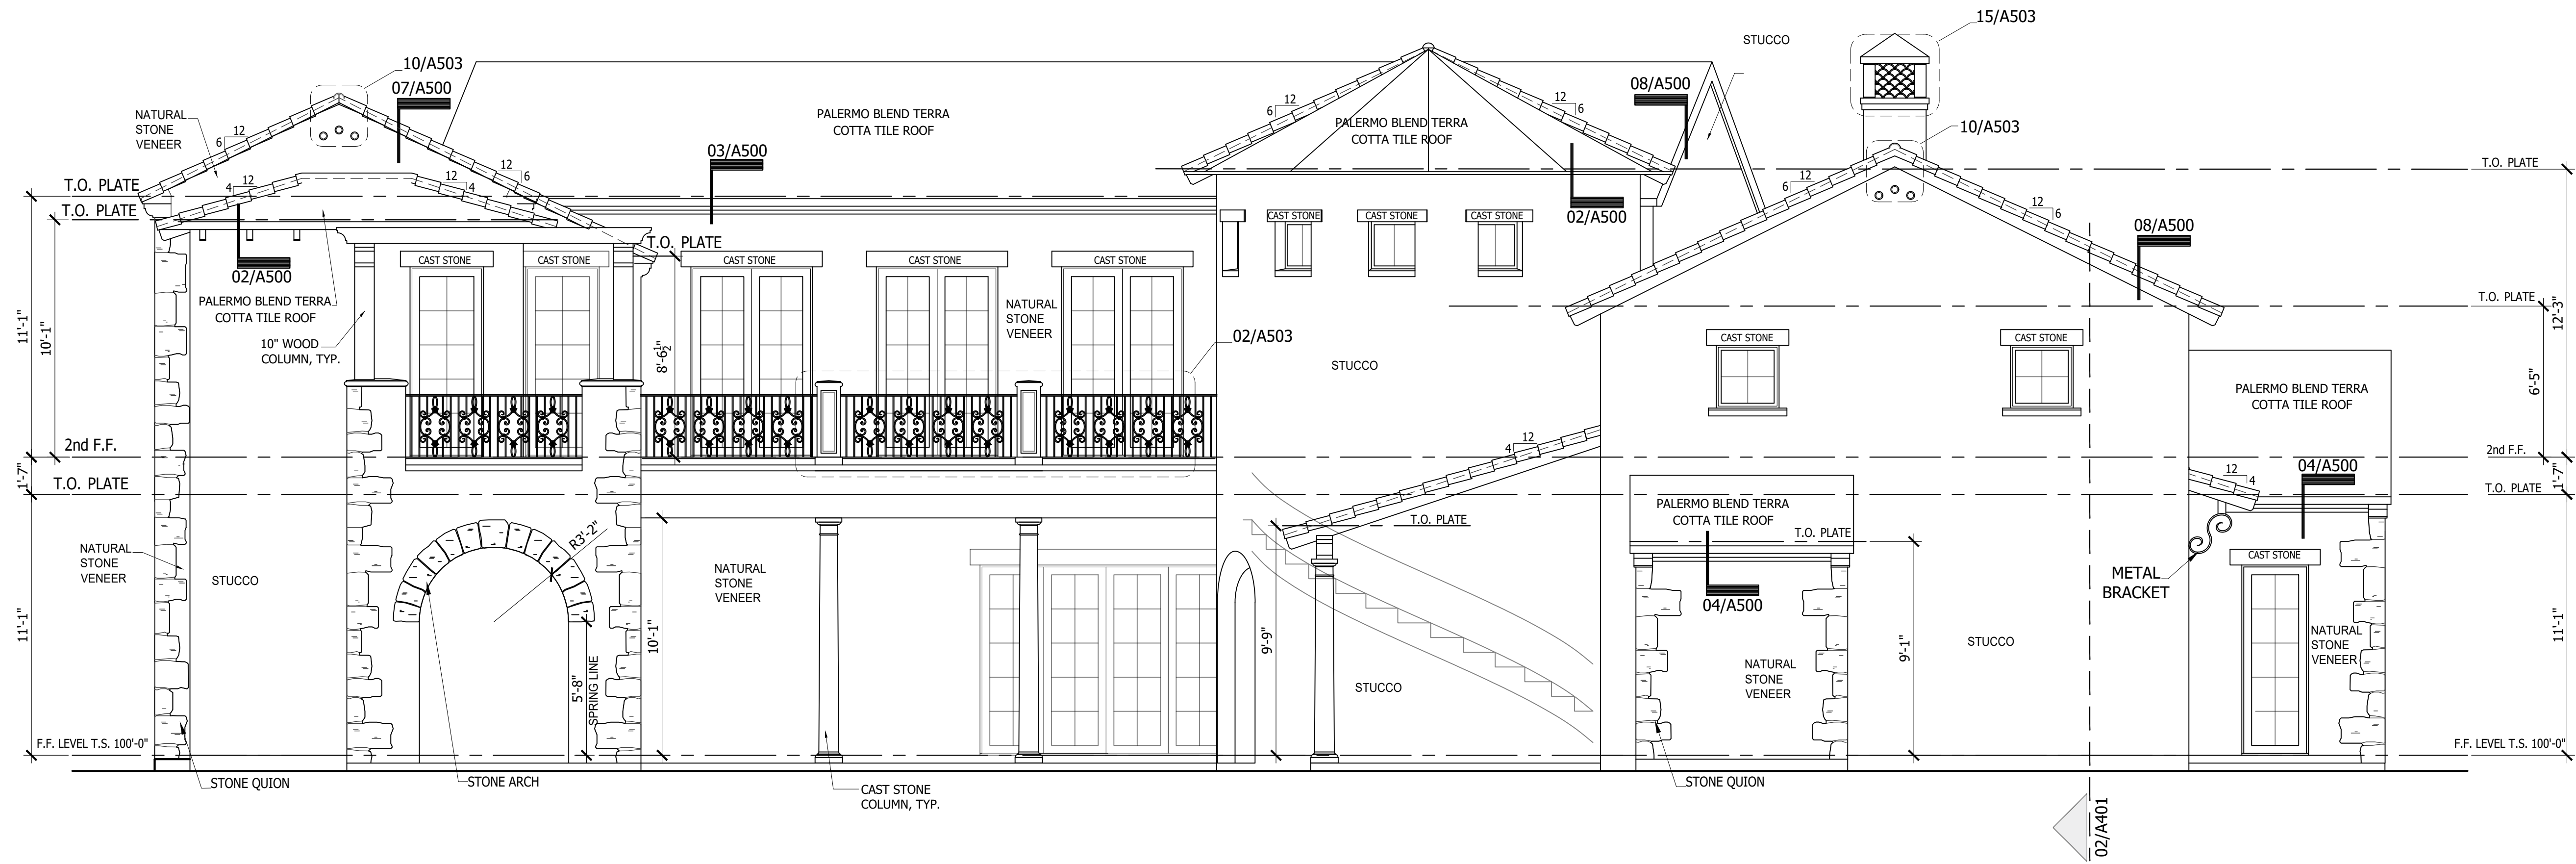

02 RIGHT ELEVATION
A201 SCALE: 1/4"=1'-0"

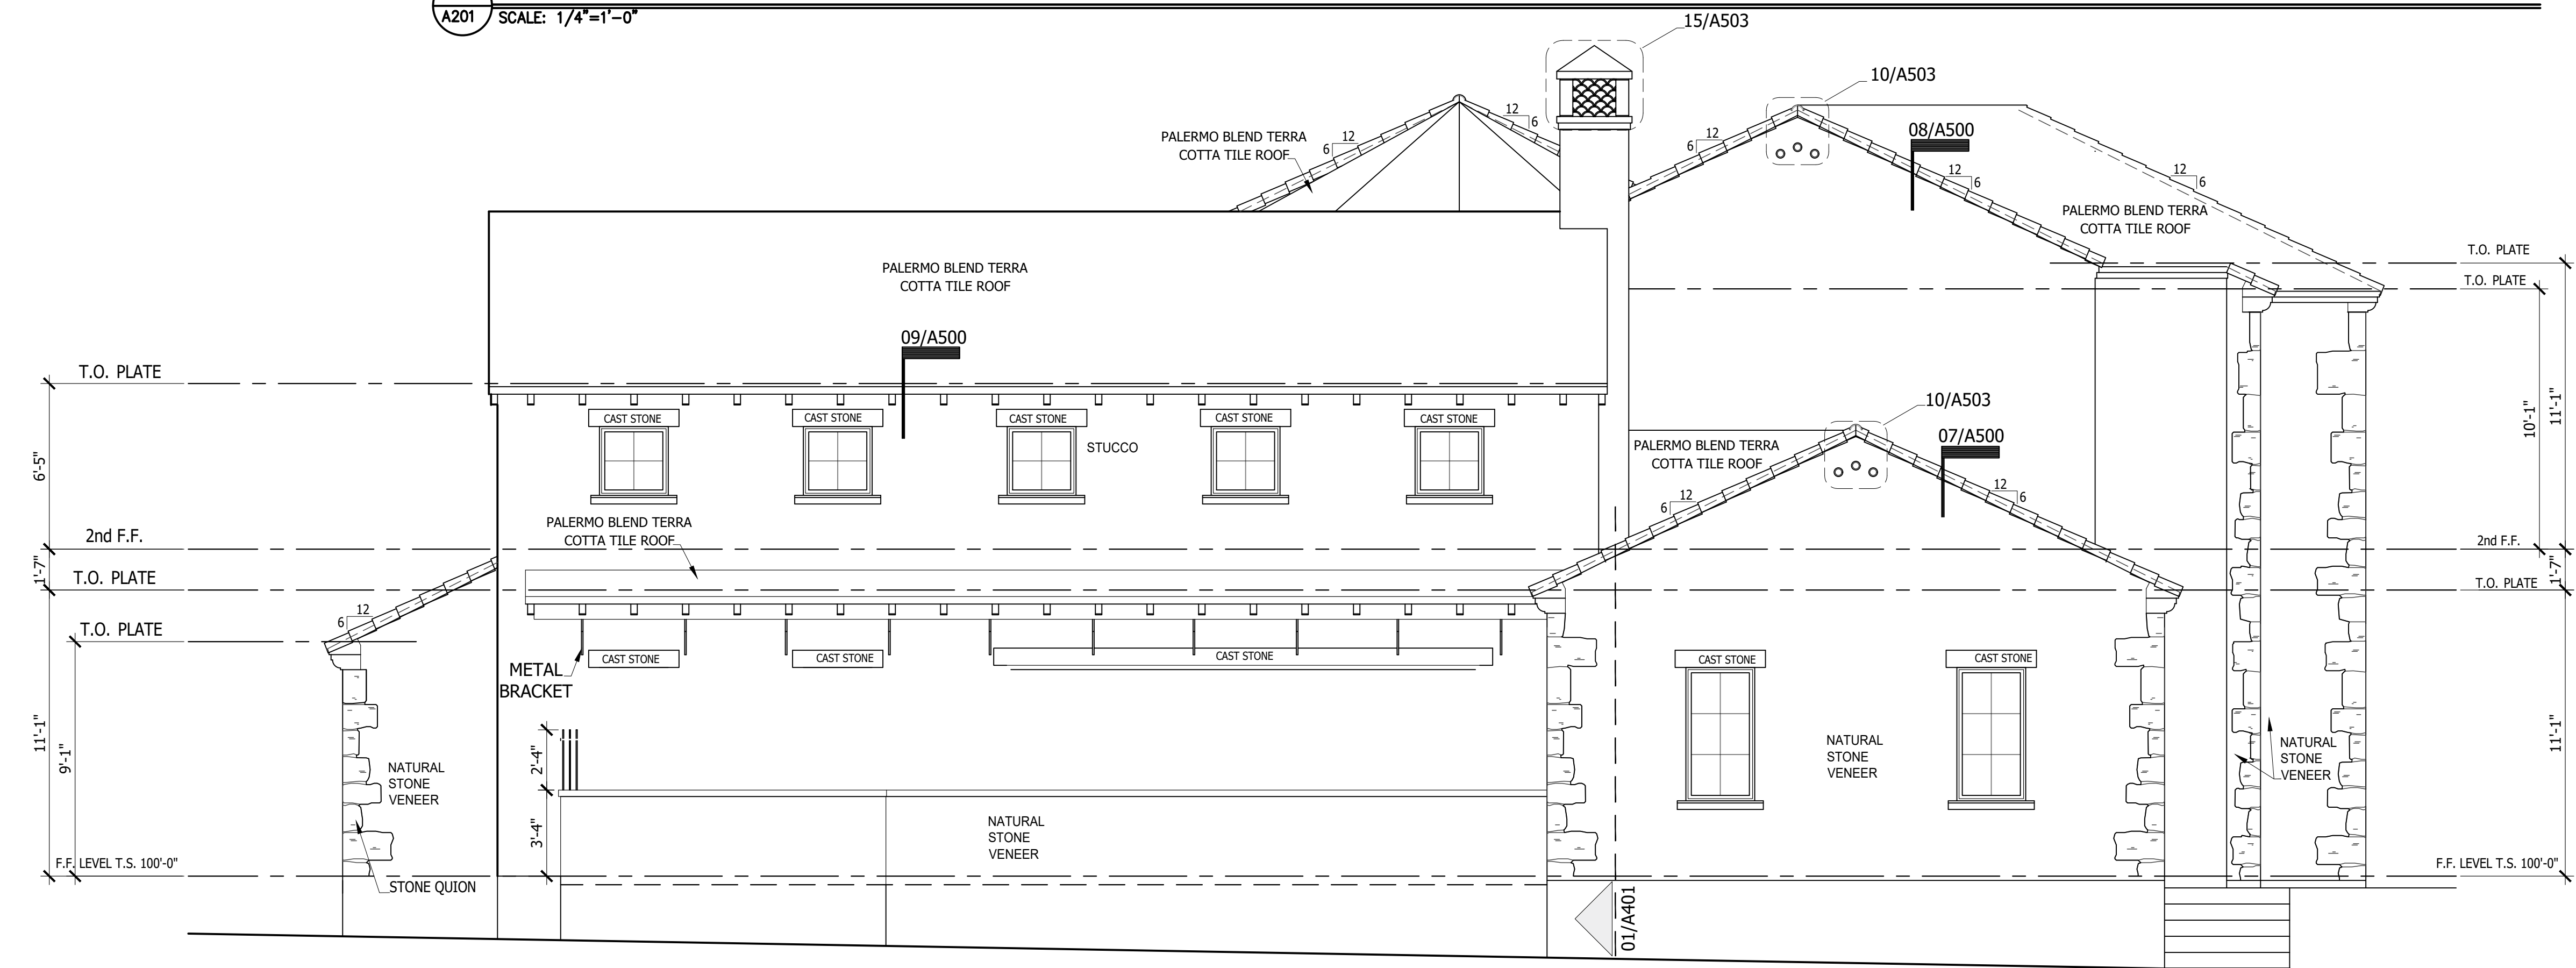

01 REAR ELEVATION
A201 SCALE: 1/4"=1'-0"

REFER TO **ENTRADA DESIGN GUIDELINES** FOR FUTHER DETAILED INFORMATION REGARDING THESE PLANS

ENTRADA
LOT 1, 2, & 3 - BLOCK H
TOWN OF WESTLAKE TARRANT COUNTY, TEXAS






ISSUE LOG

NO.	DESCRIPTION	DATE

PROJECT NO: 20-129
ISSUED FOR: OTP
DRAWN BY: WILL
DATE: 11/29/21

**COUTYARD
ELEVATIONS**

A202

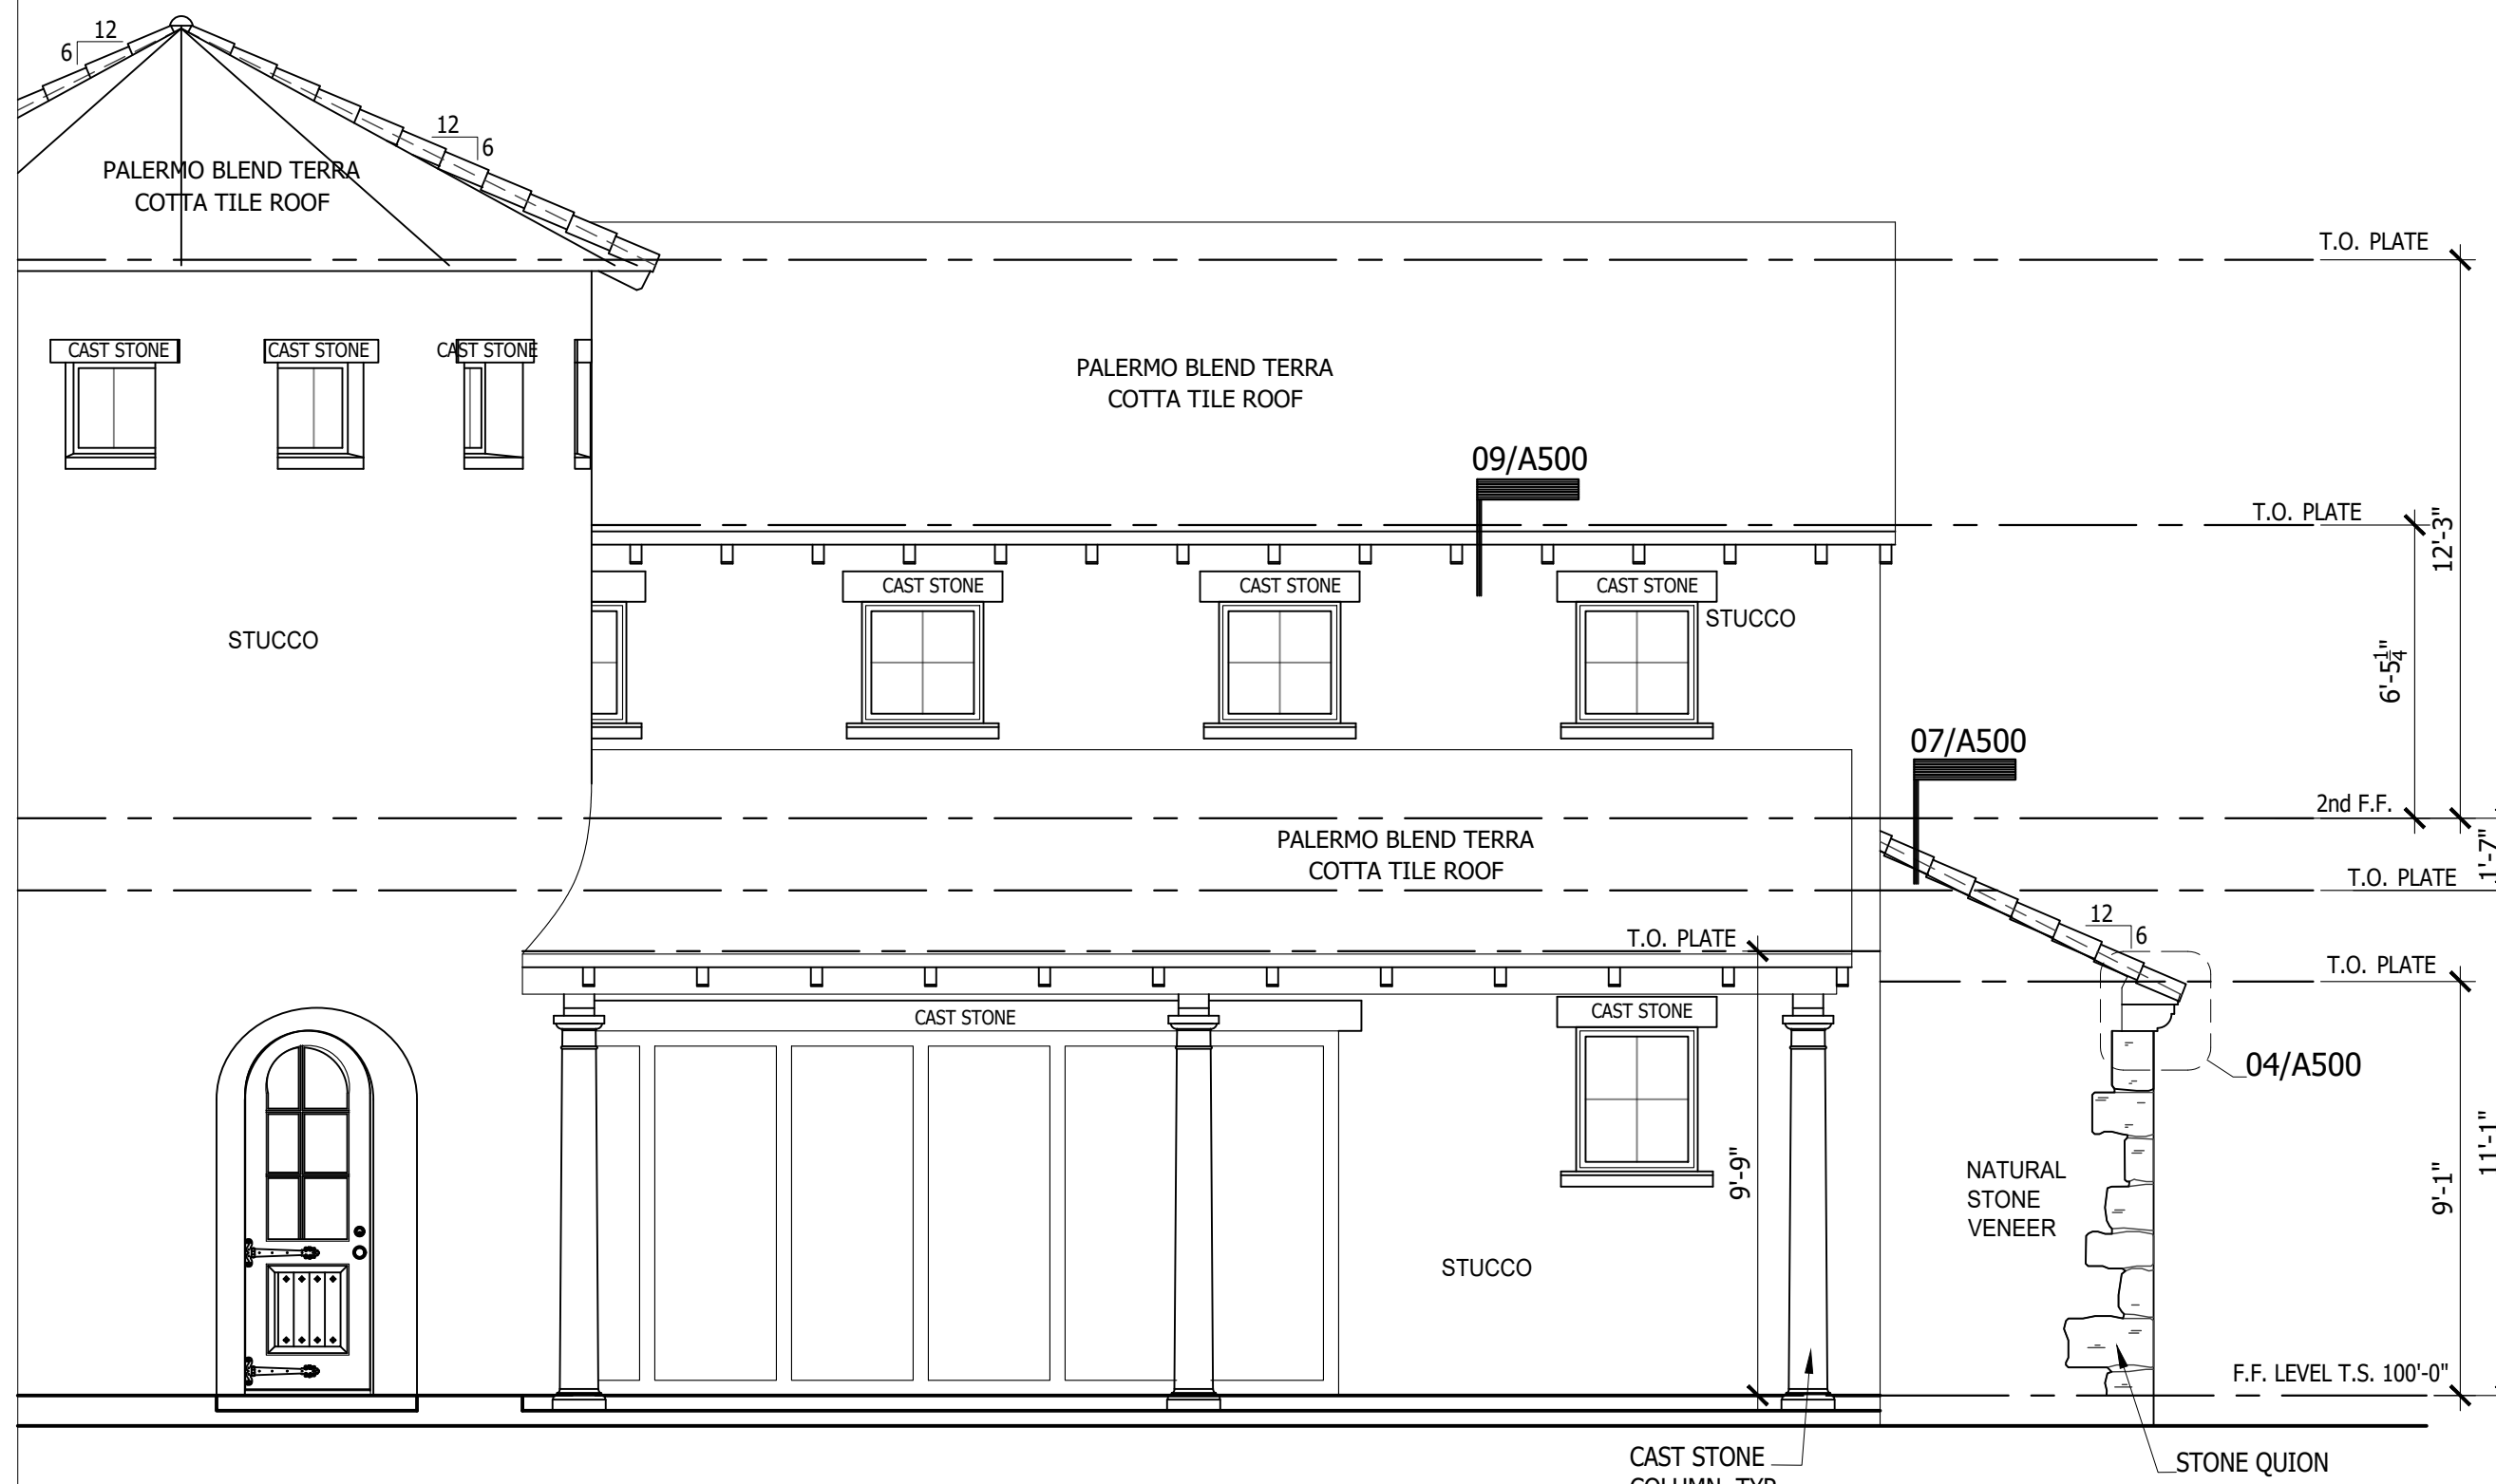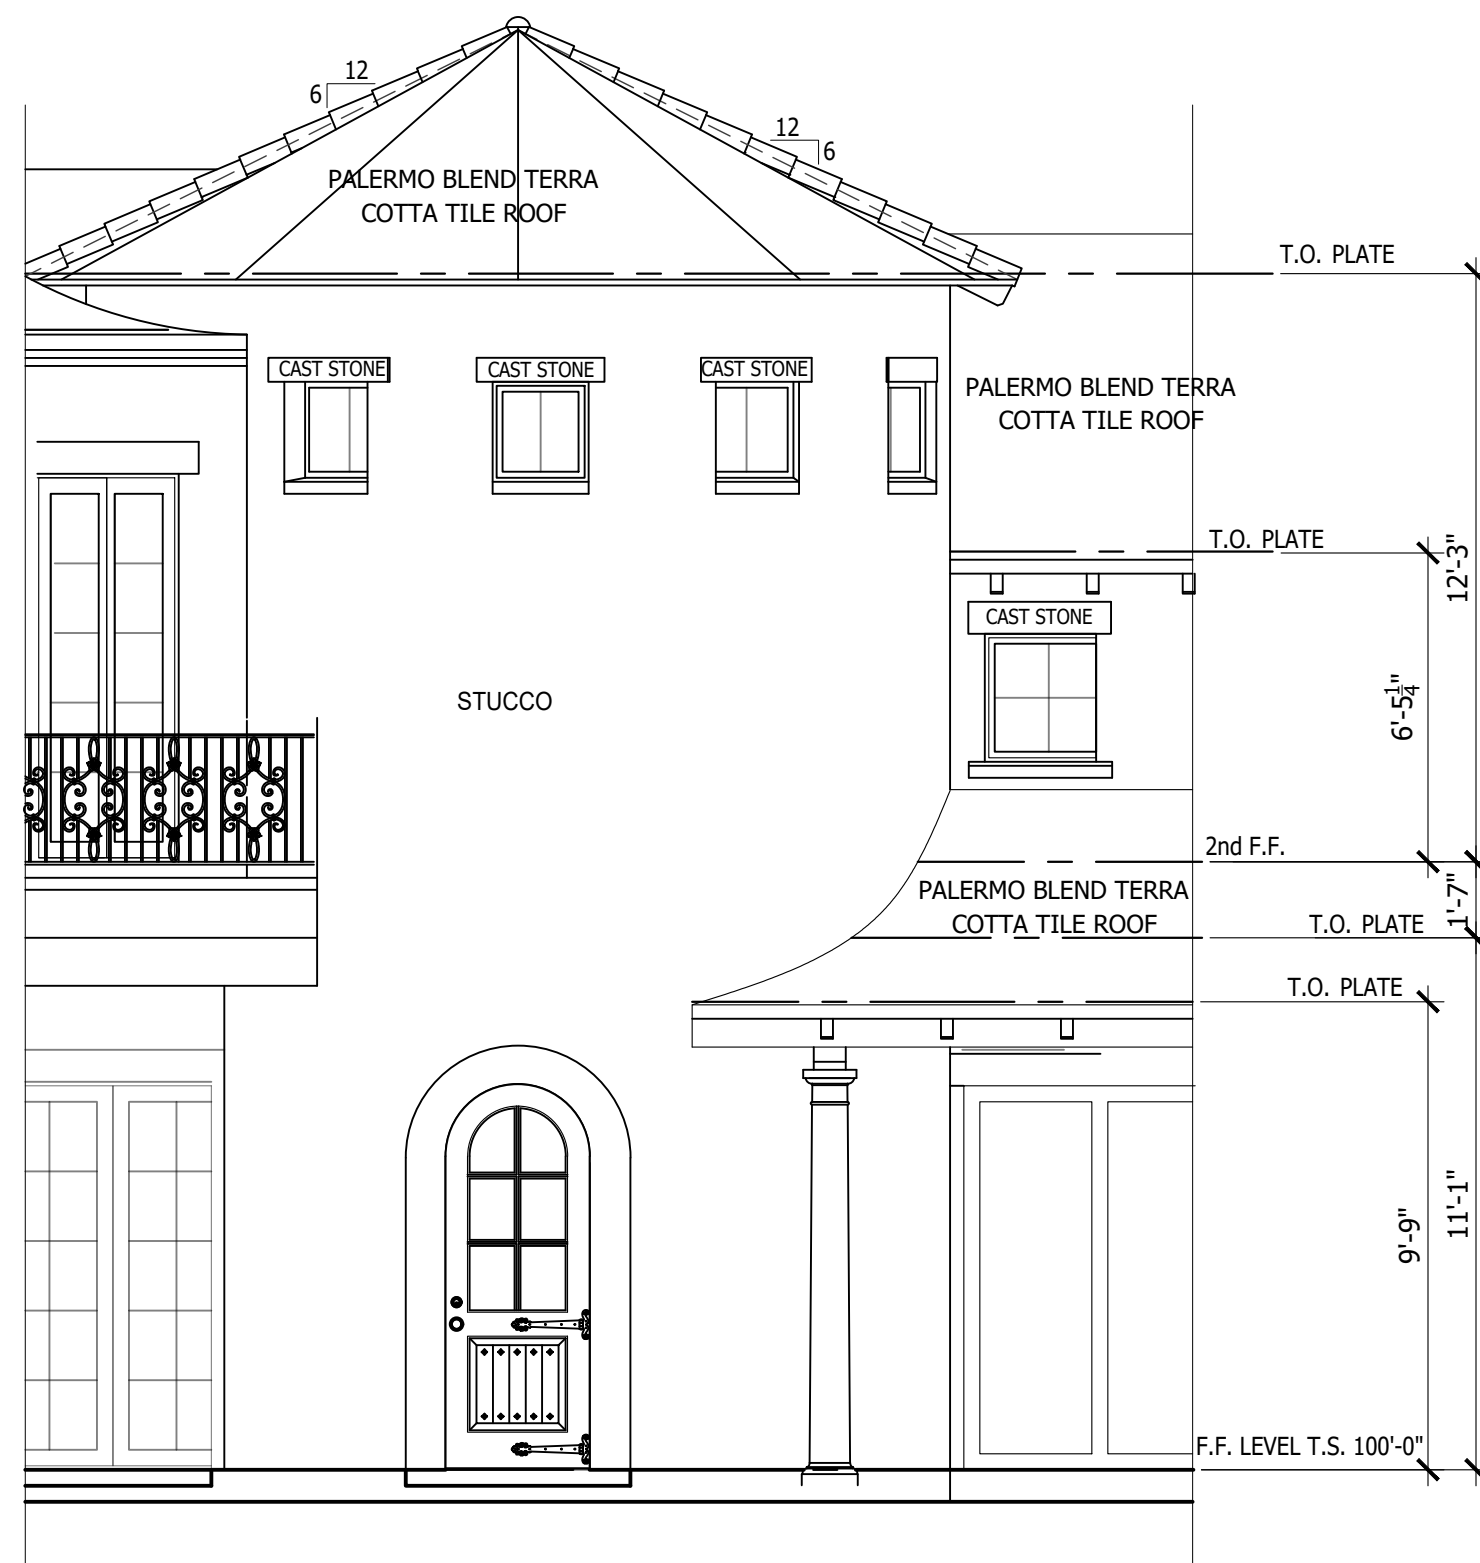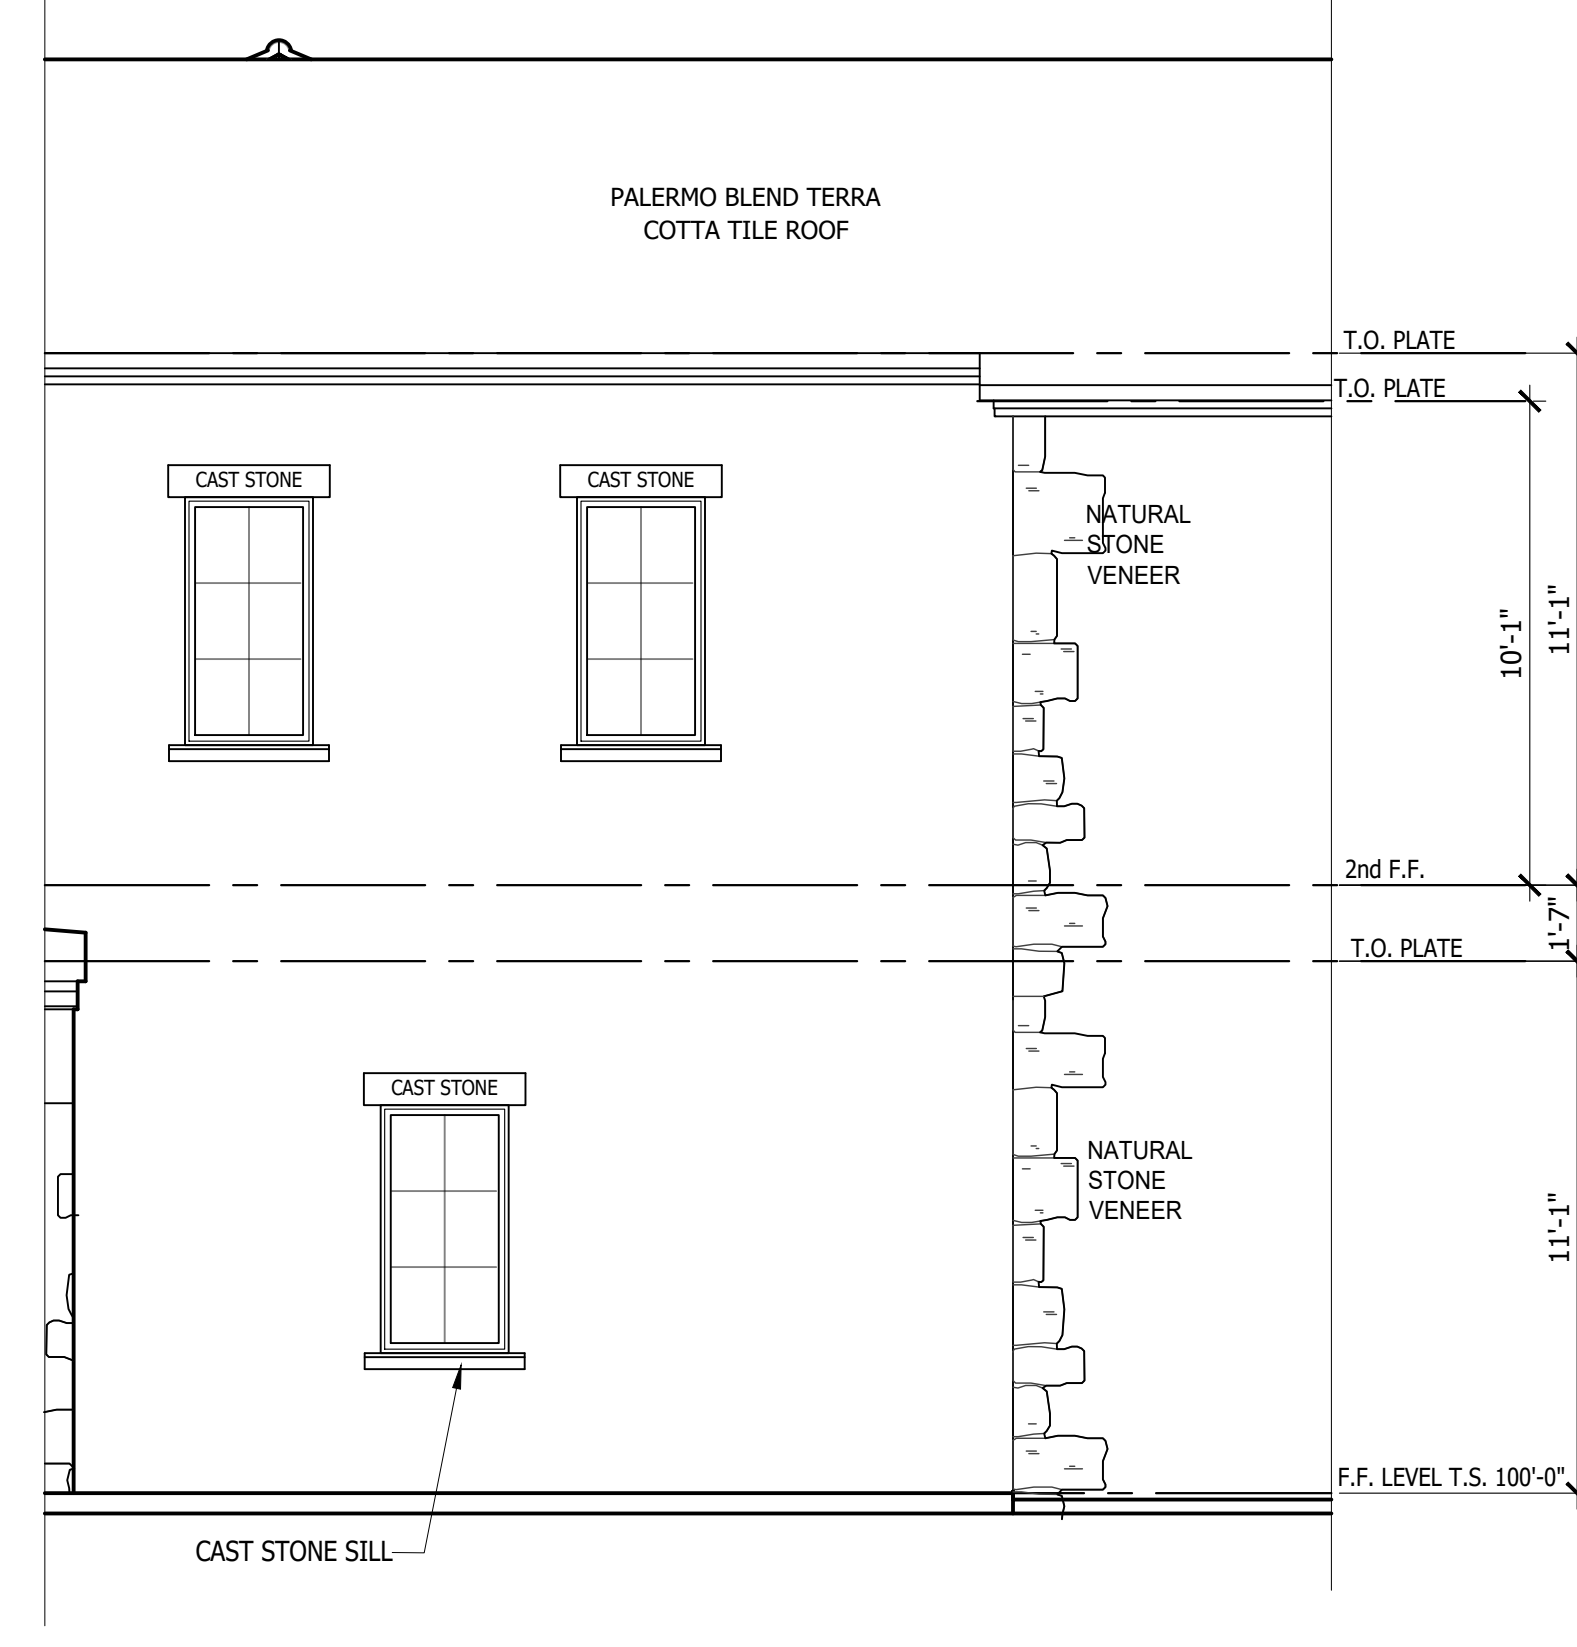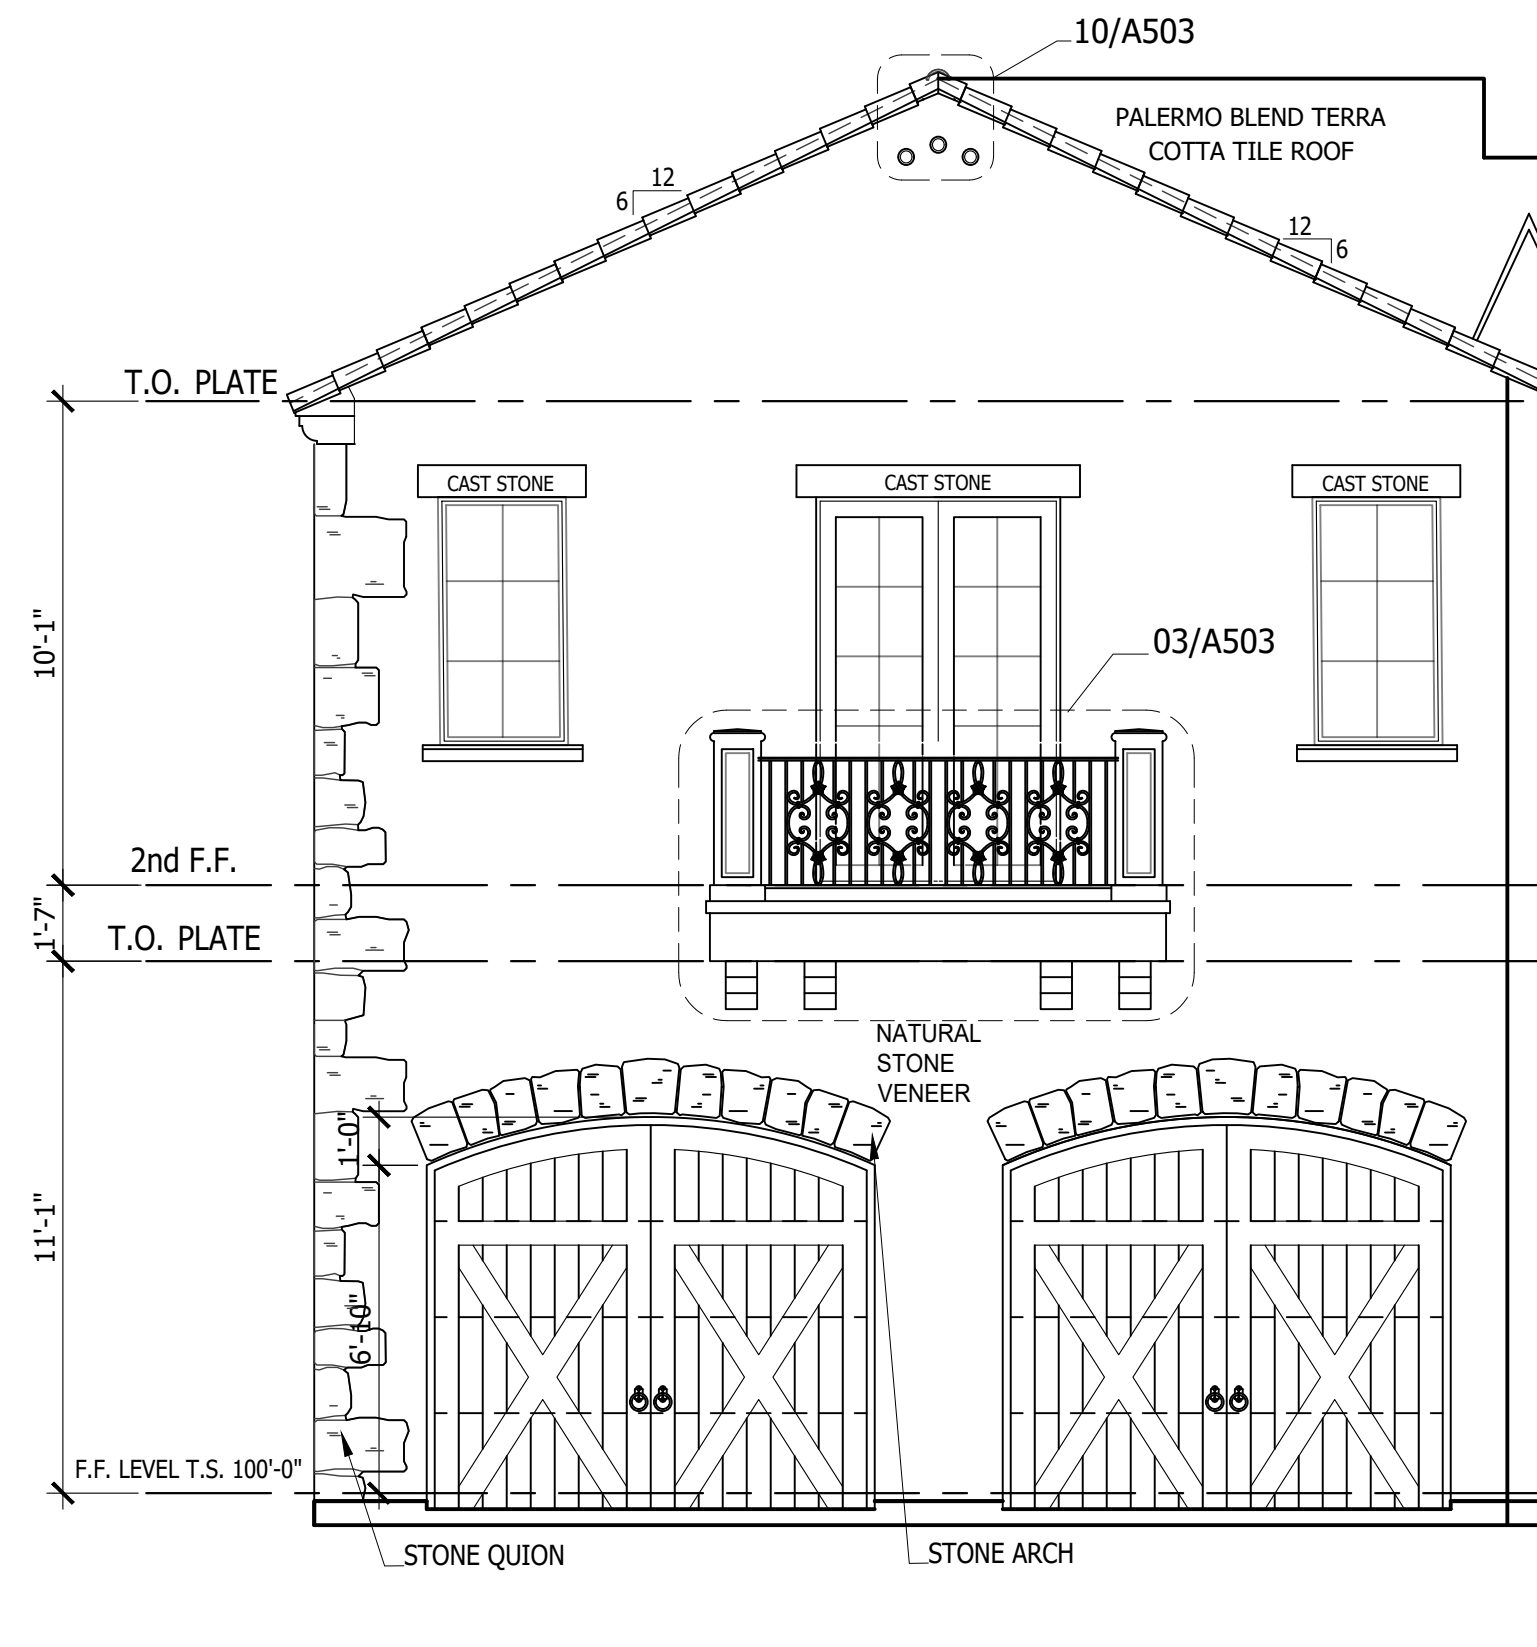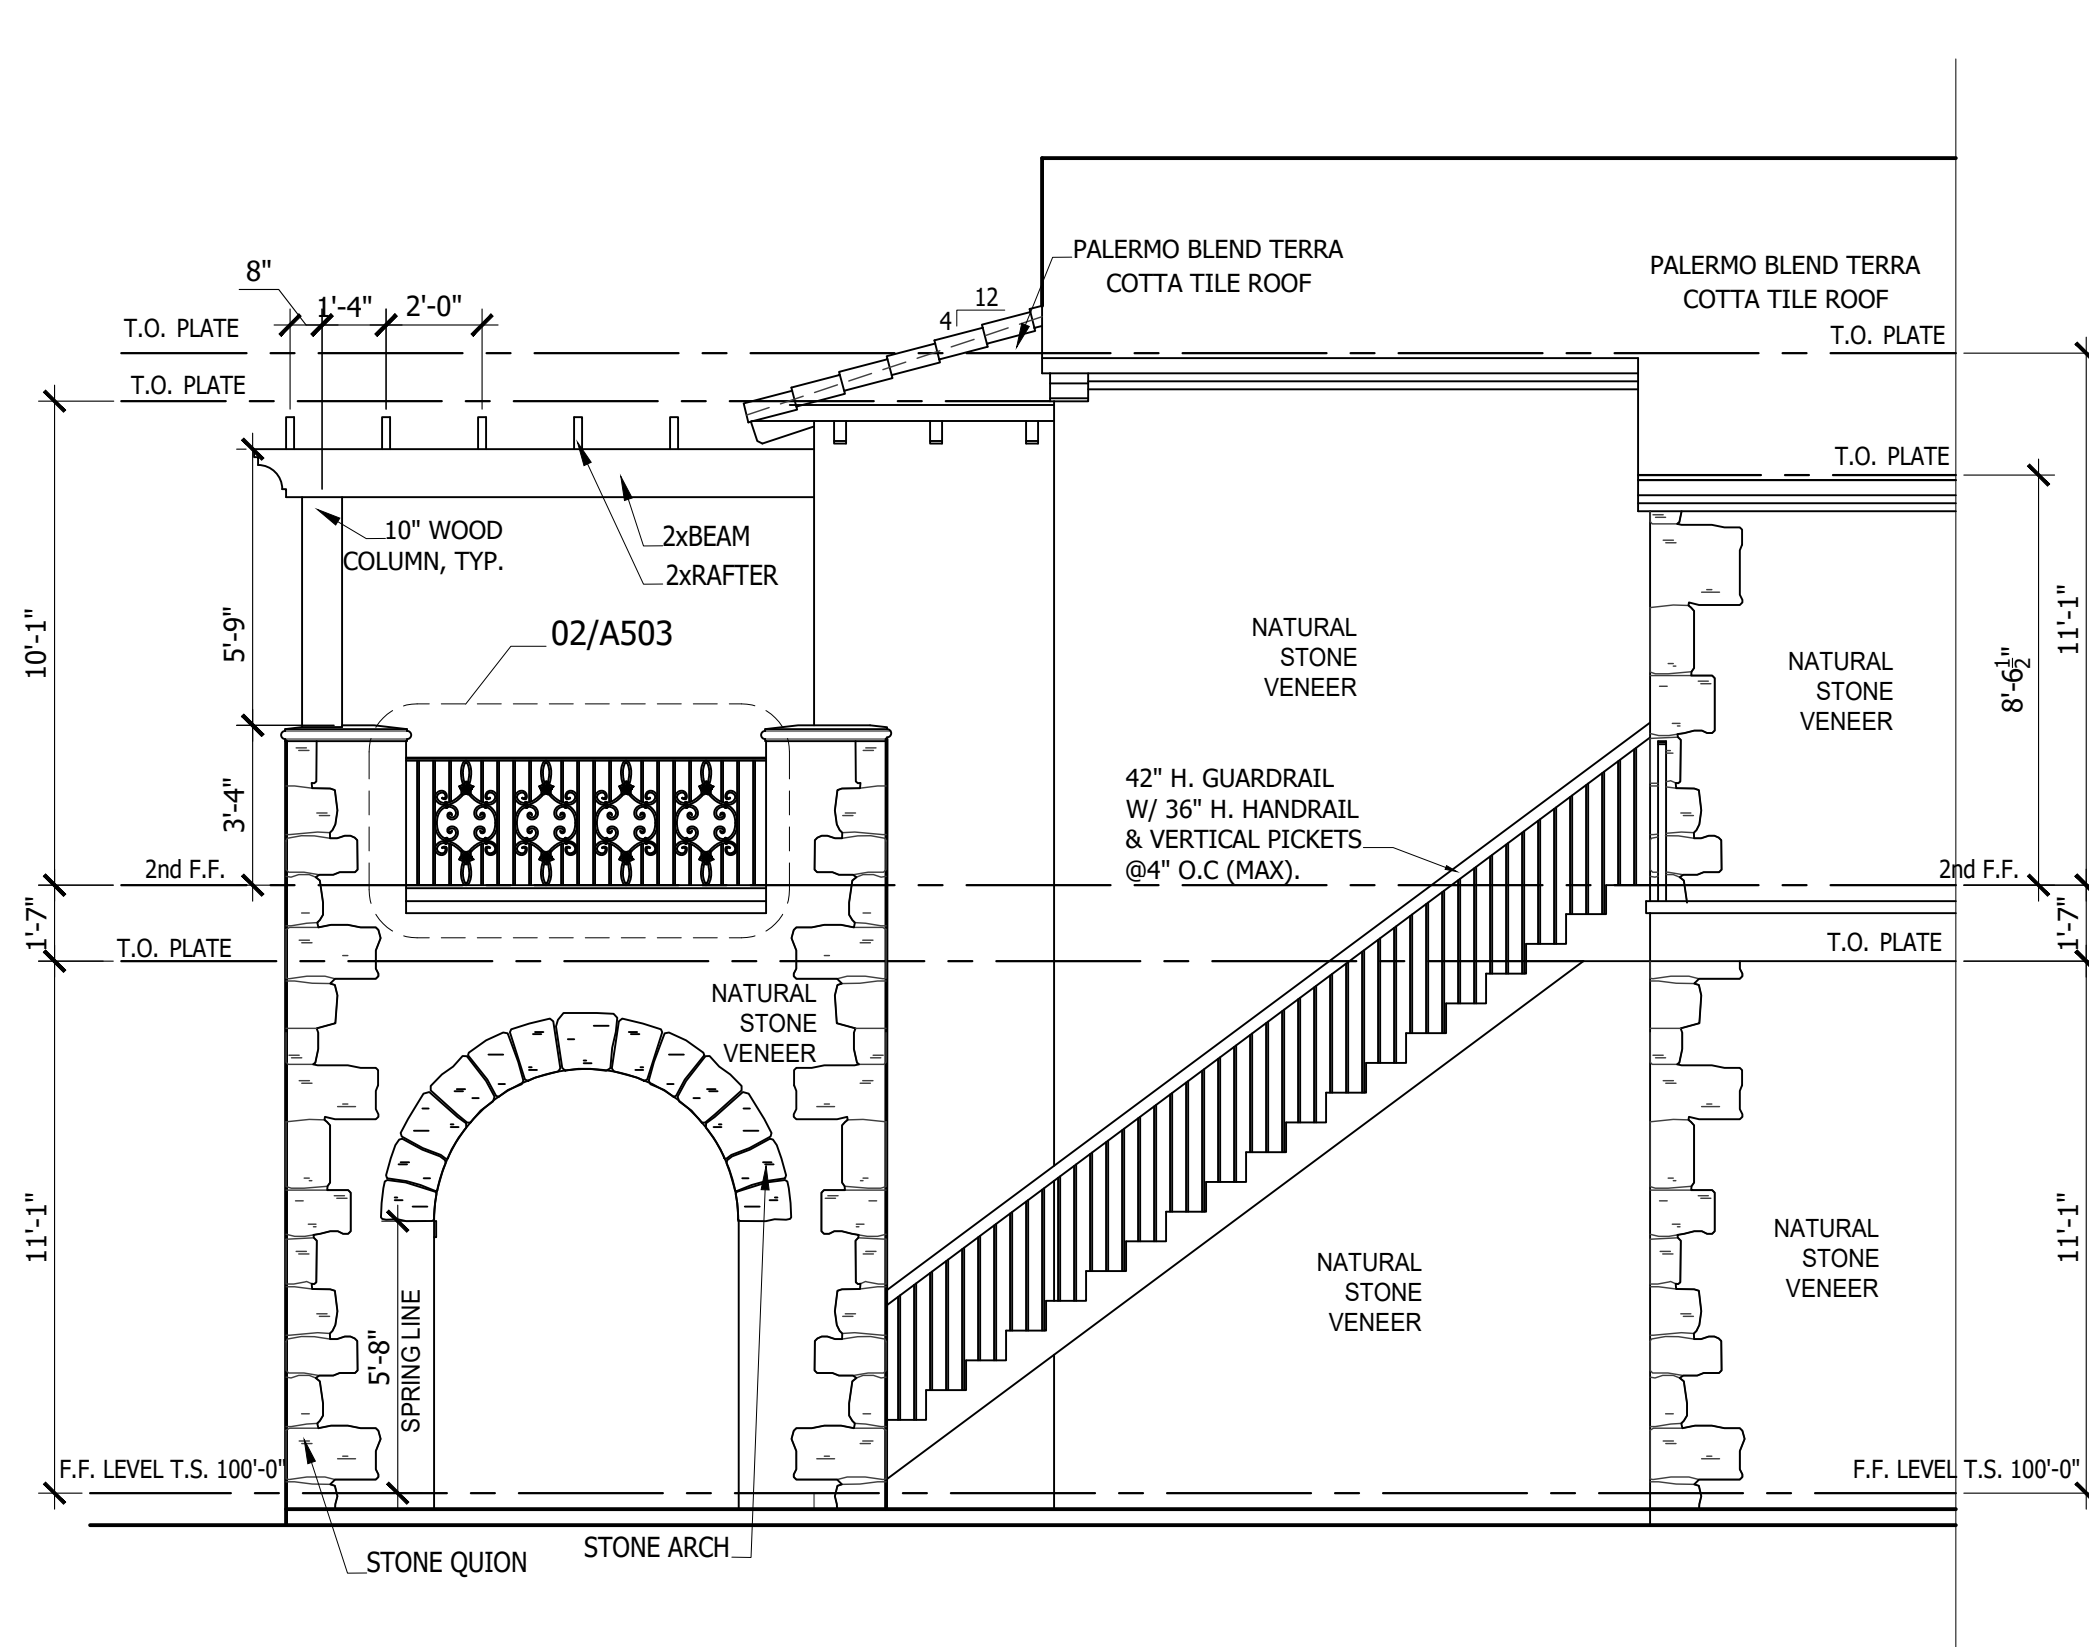

REFER TO **ENTRADA DESIGN GUIDELINES** FOR FUTHER DETAILED INFORMATION REGARDING THESE PLANS

ENTRADA

LOT 1, 2, & 3 - BLOCK H

TOWN OF WESTLAKE TARRANT COUNTY, TEXAS


ISSUE LOG

NO.	DESCRIPTION	DATE

PROJECT NO:	20-129
ISSUED FOR:	OTP
DRAWN BY:	WLL
DATE:	11/29/21

SHEPHERD'S WALL
ELEVATIONS

A203

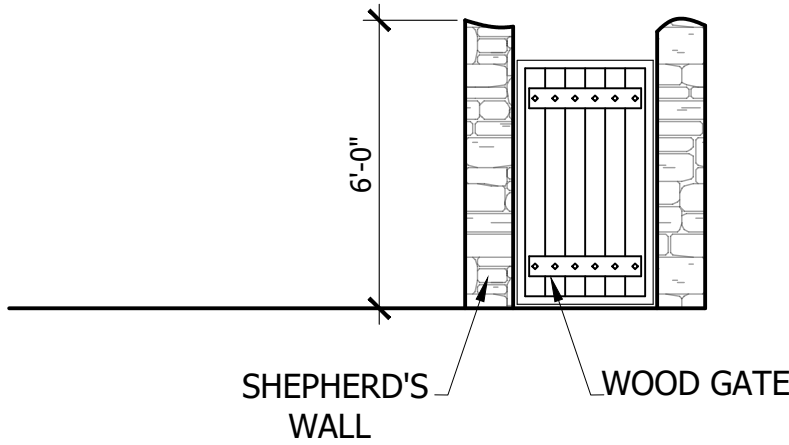


03

A203

SHEPHERD'S WALL REAR ELEVATION

SCALE: 1/4"=1'-0"

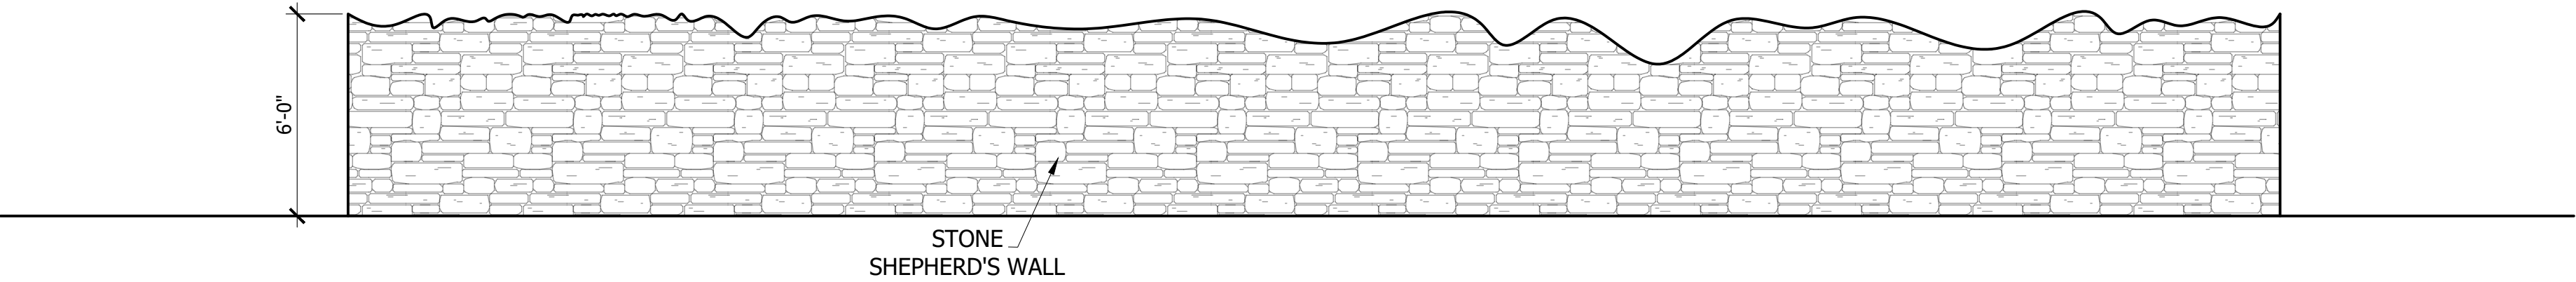


02

A203

SHEPHERD'S WALL SIDE ELEVATION

SCALE: 1/4"=1'-0"

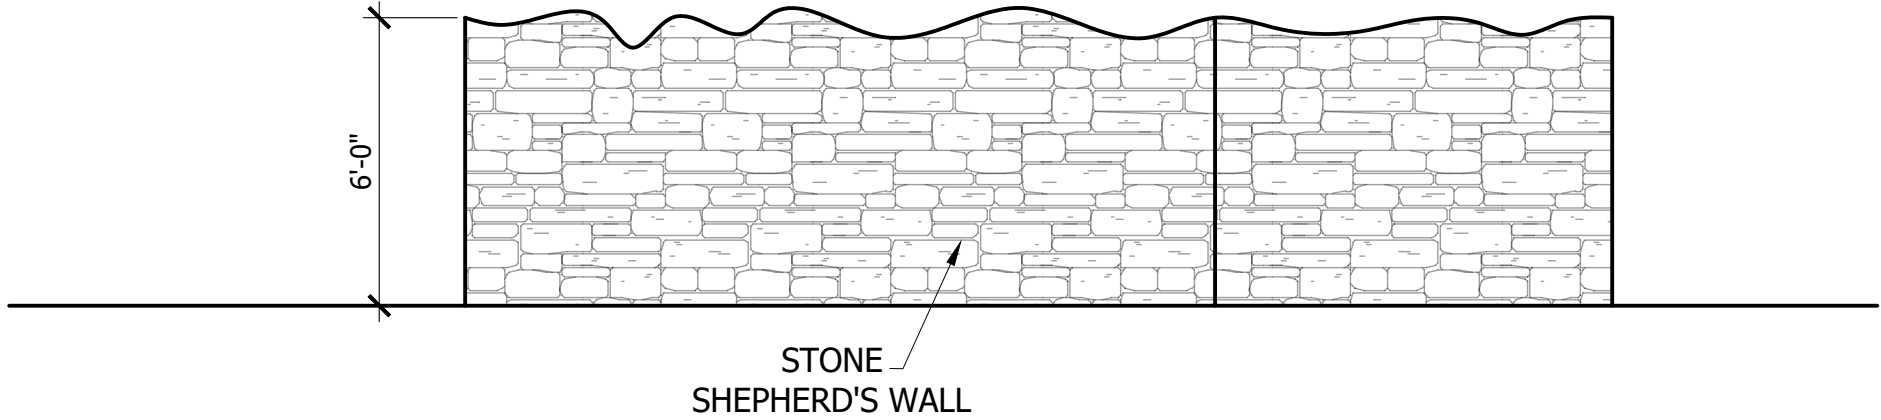

01

A203

SHEPHERD'S WALL FRONT ELEVATION

SCALE: 1/4"=1'-0"


ISSUE LOG

NO.	DESCRIPTION	DATE

PROJECT NO:	20-129
ISSUED FOR:	OTP
DRAWN BY:	WLL
DATE:	11/29/21


WALL SECTIONS

A401

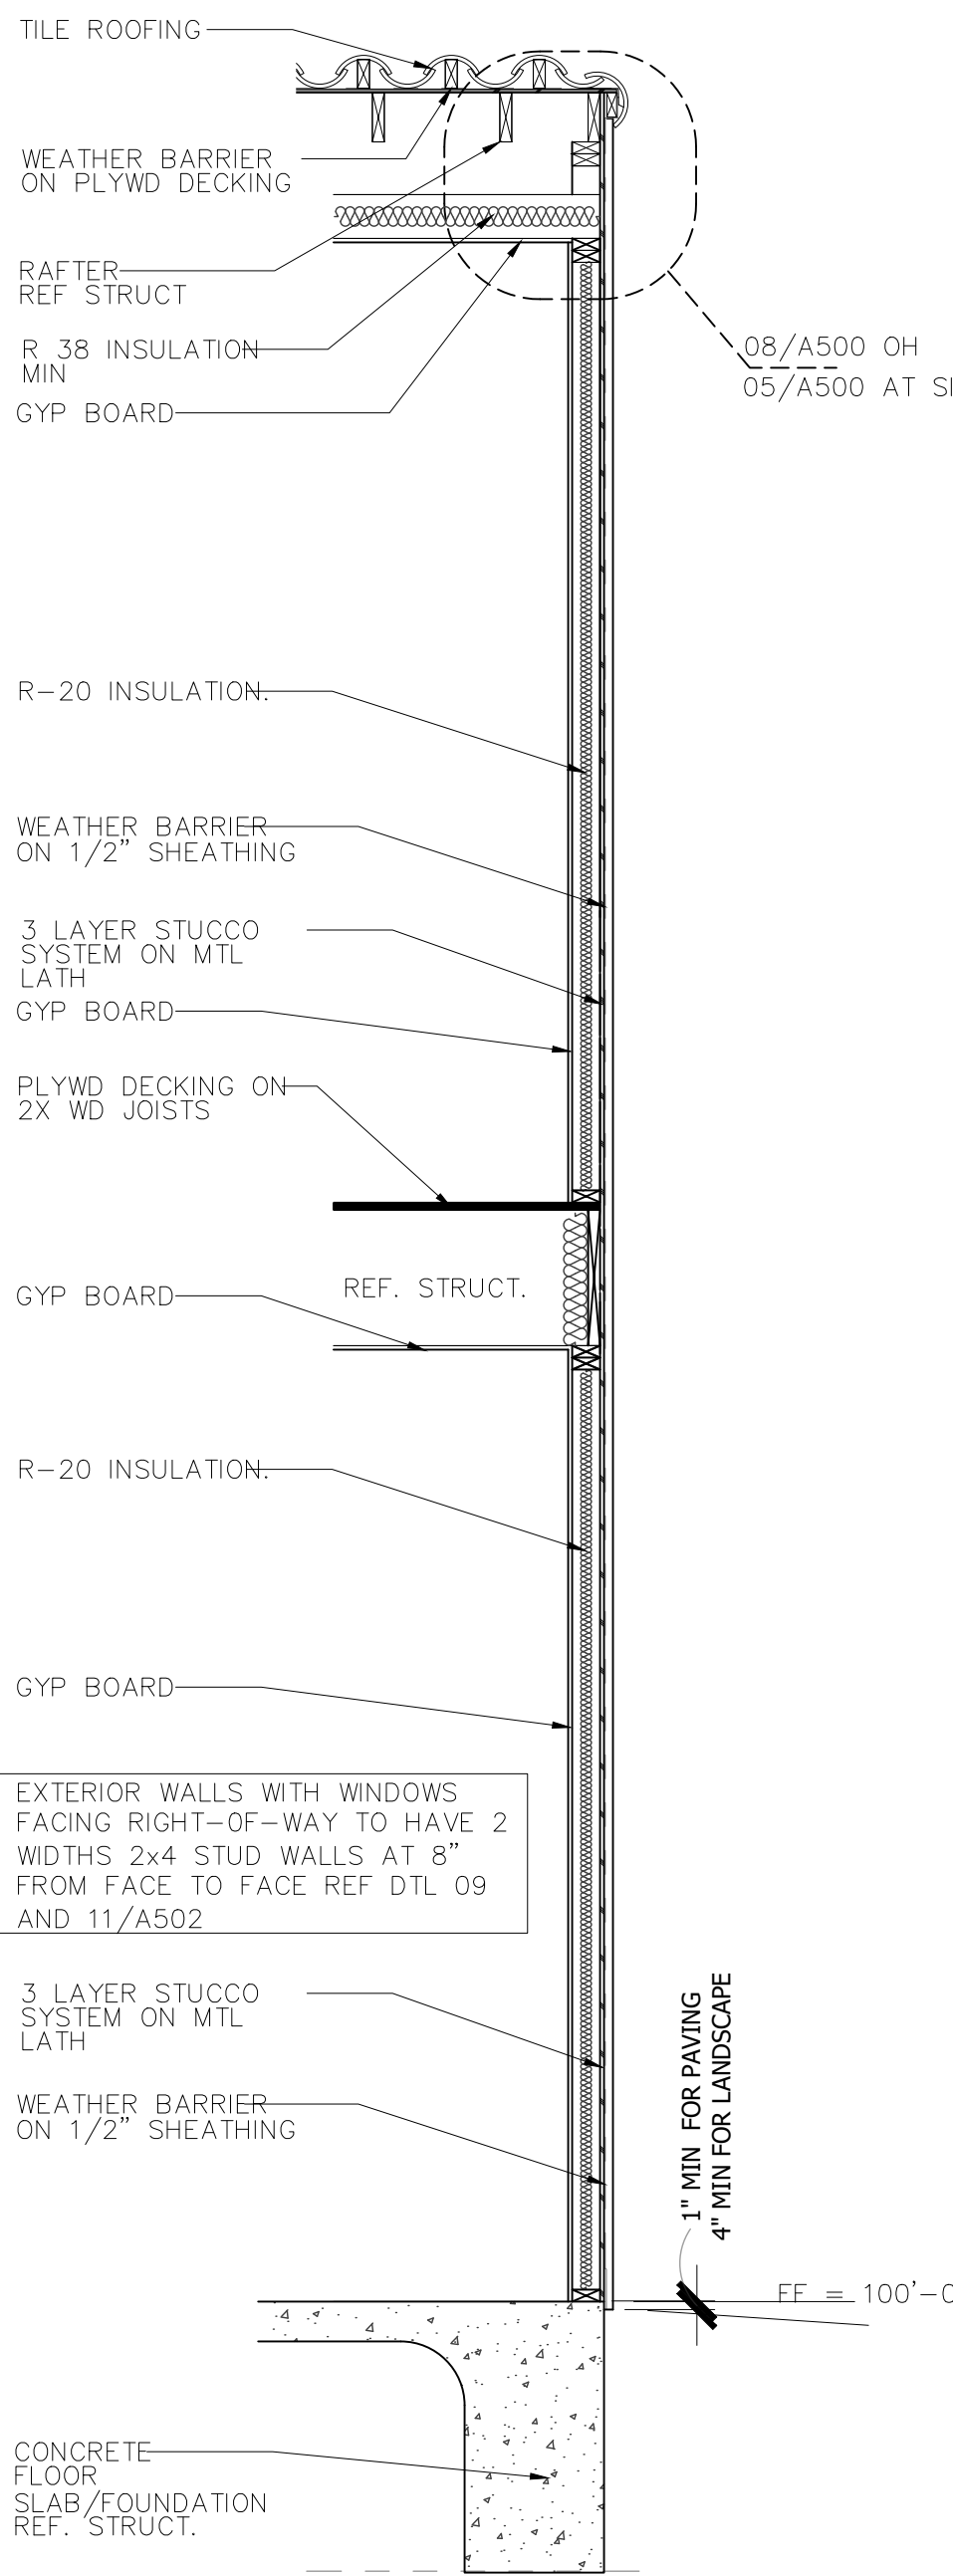


02 WALL SECTION

SCALE: 1/2" = 1'-0"

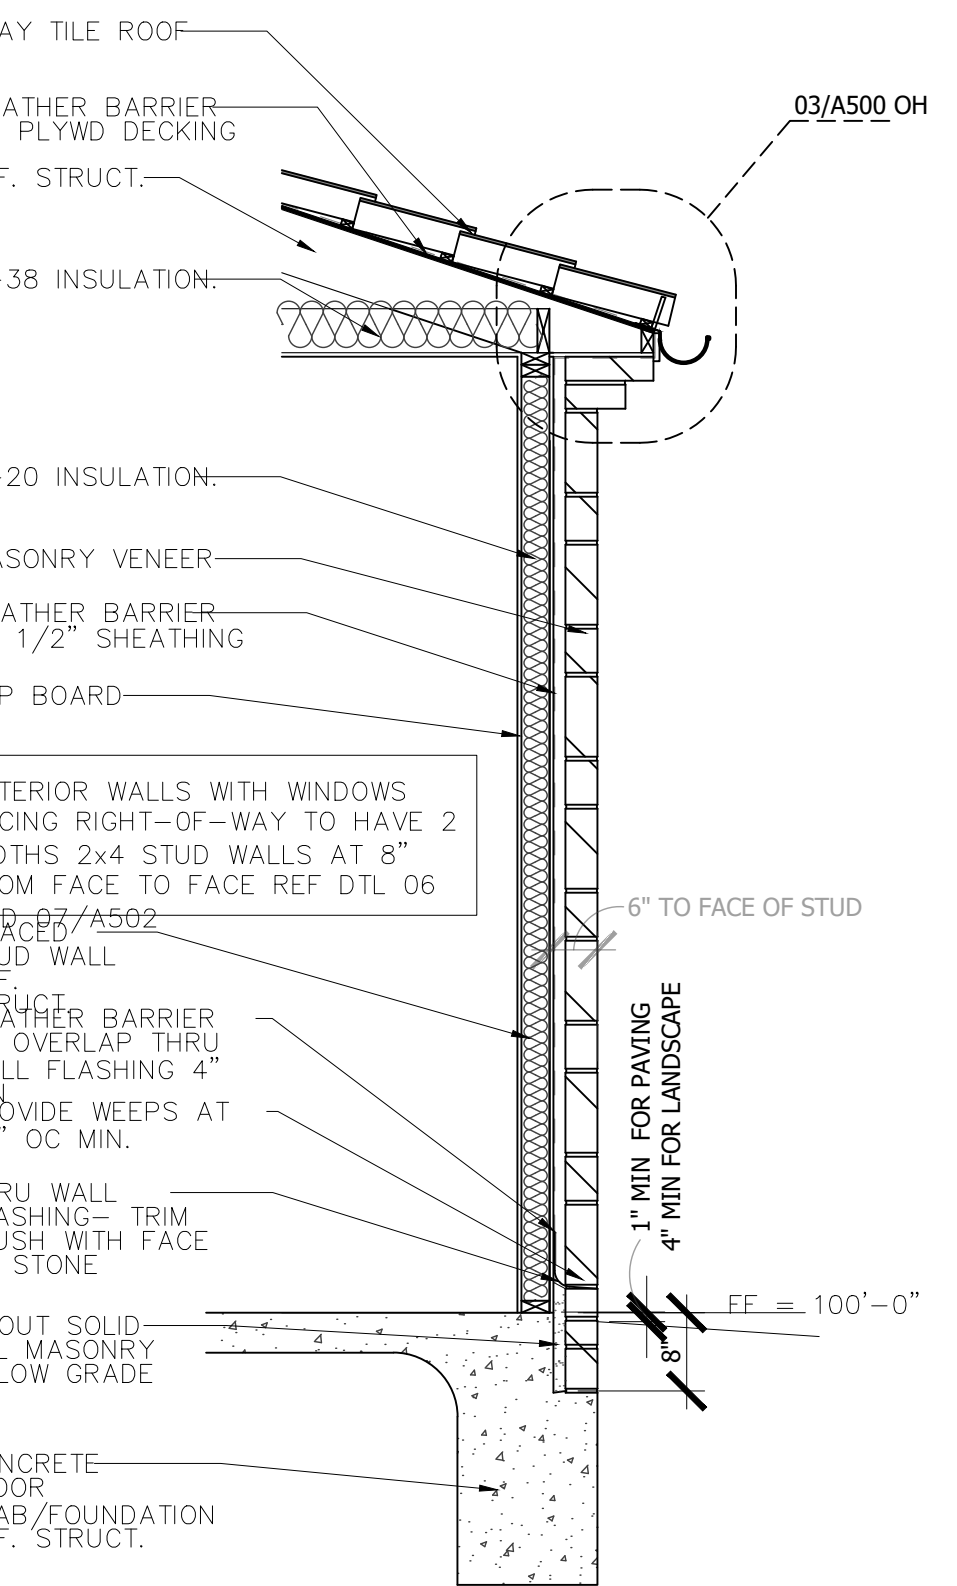


01 WALL SECTION

SCALE: 1/2" = 1'-0"

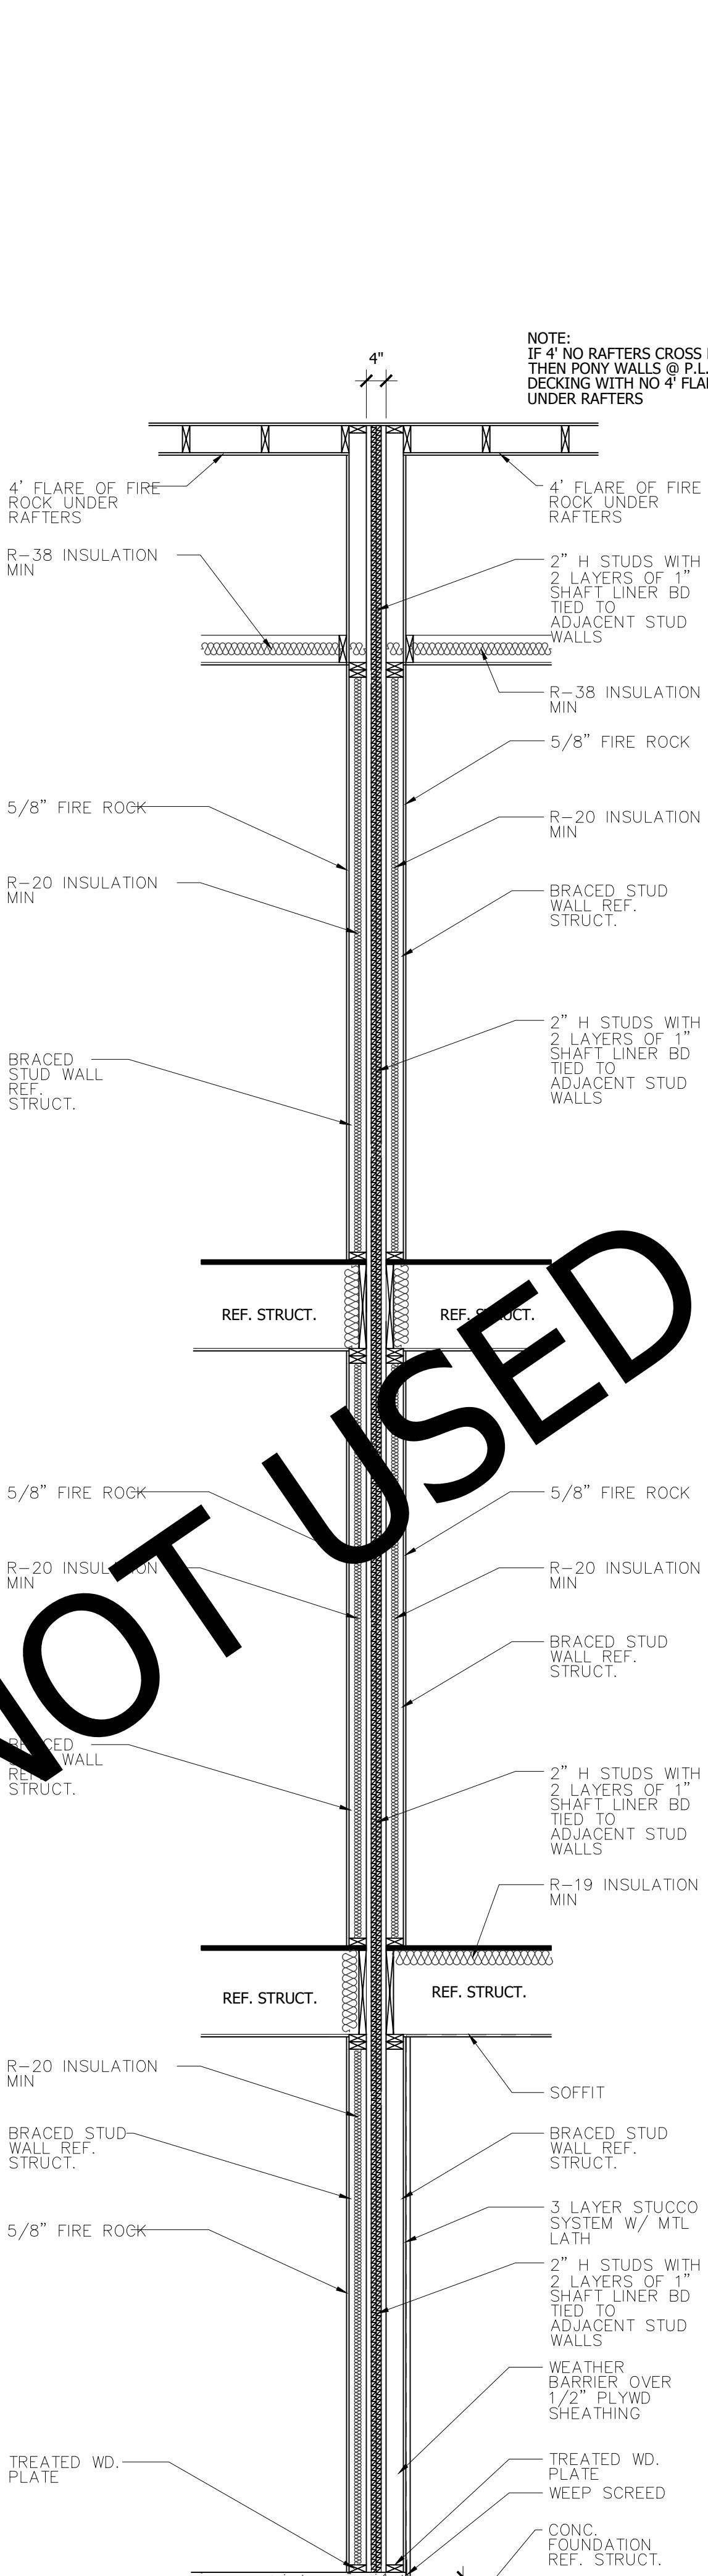


03 WALL SECTION

SCALE: 1/2" = 1'-0"

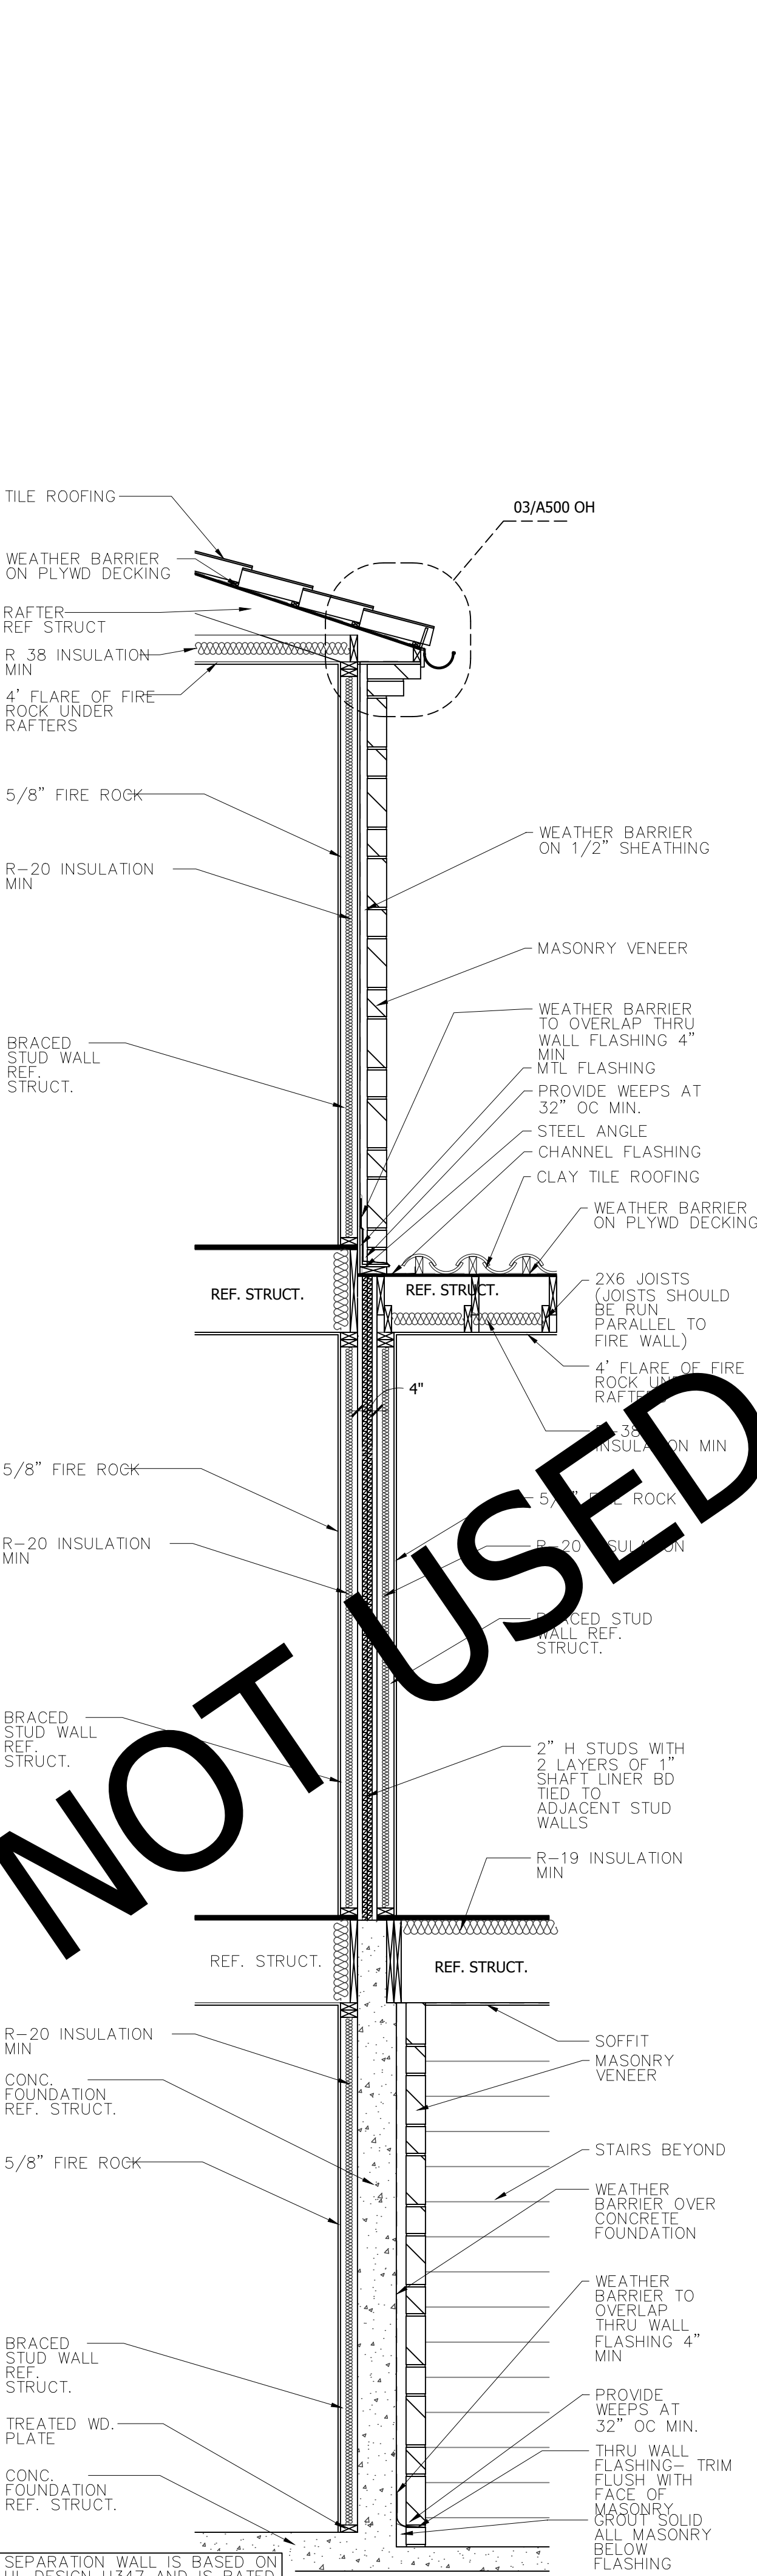


04 WALL SECTION

SCALE: 1/2" = 1'-0"

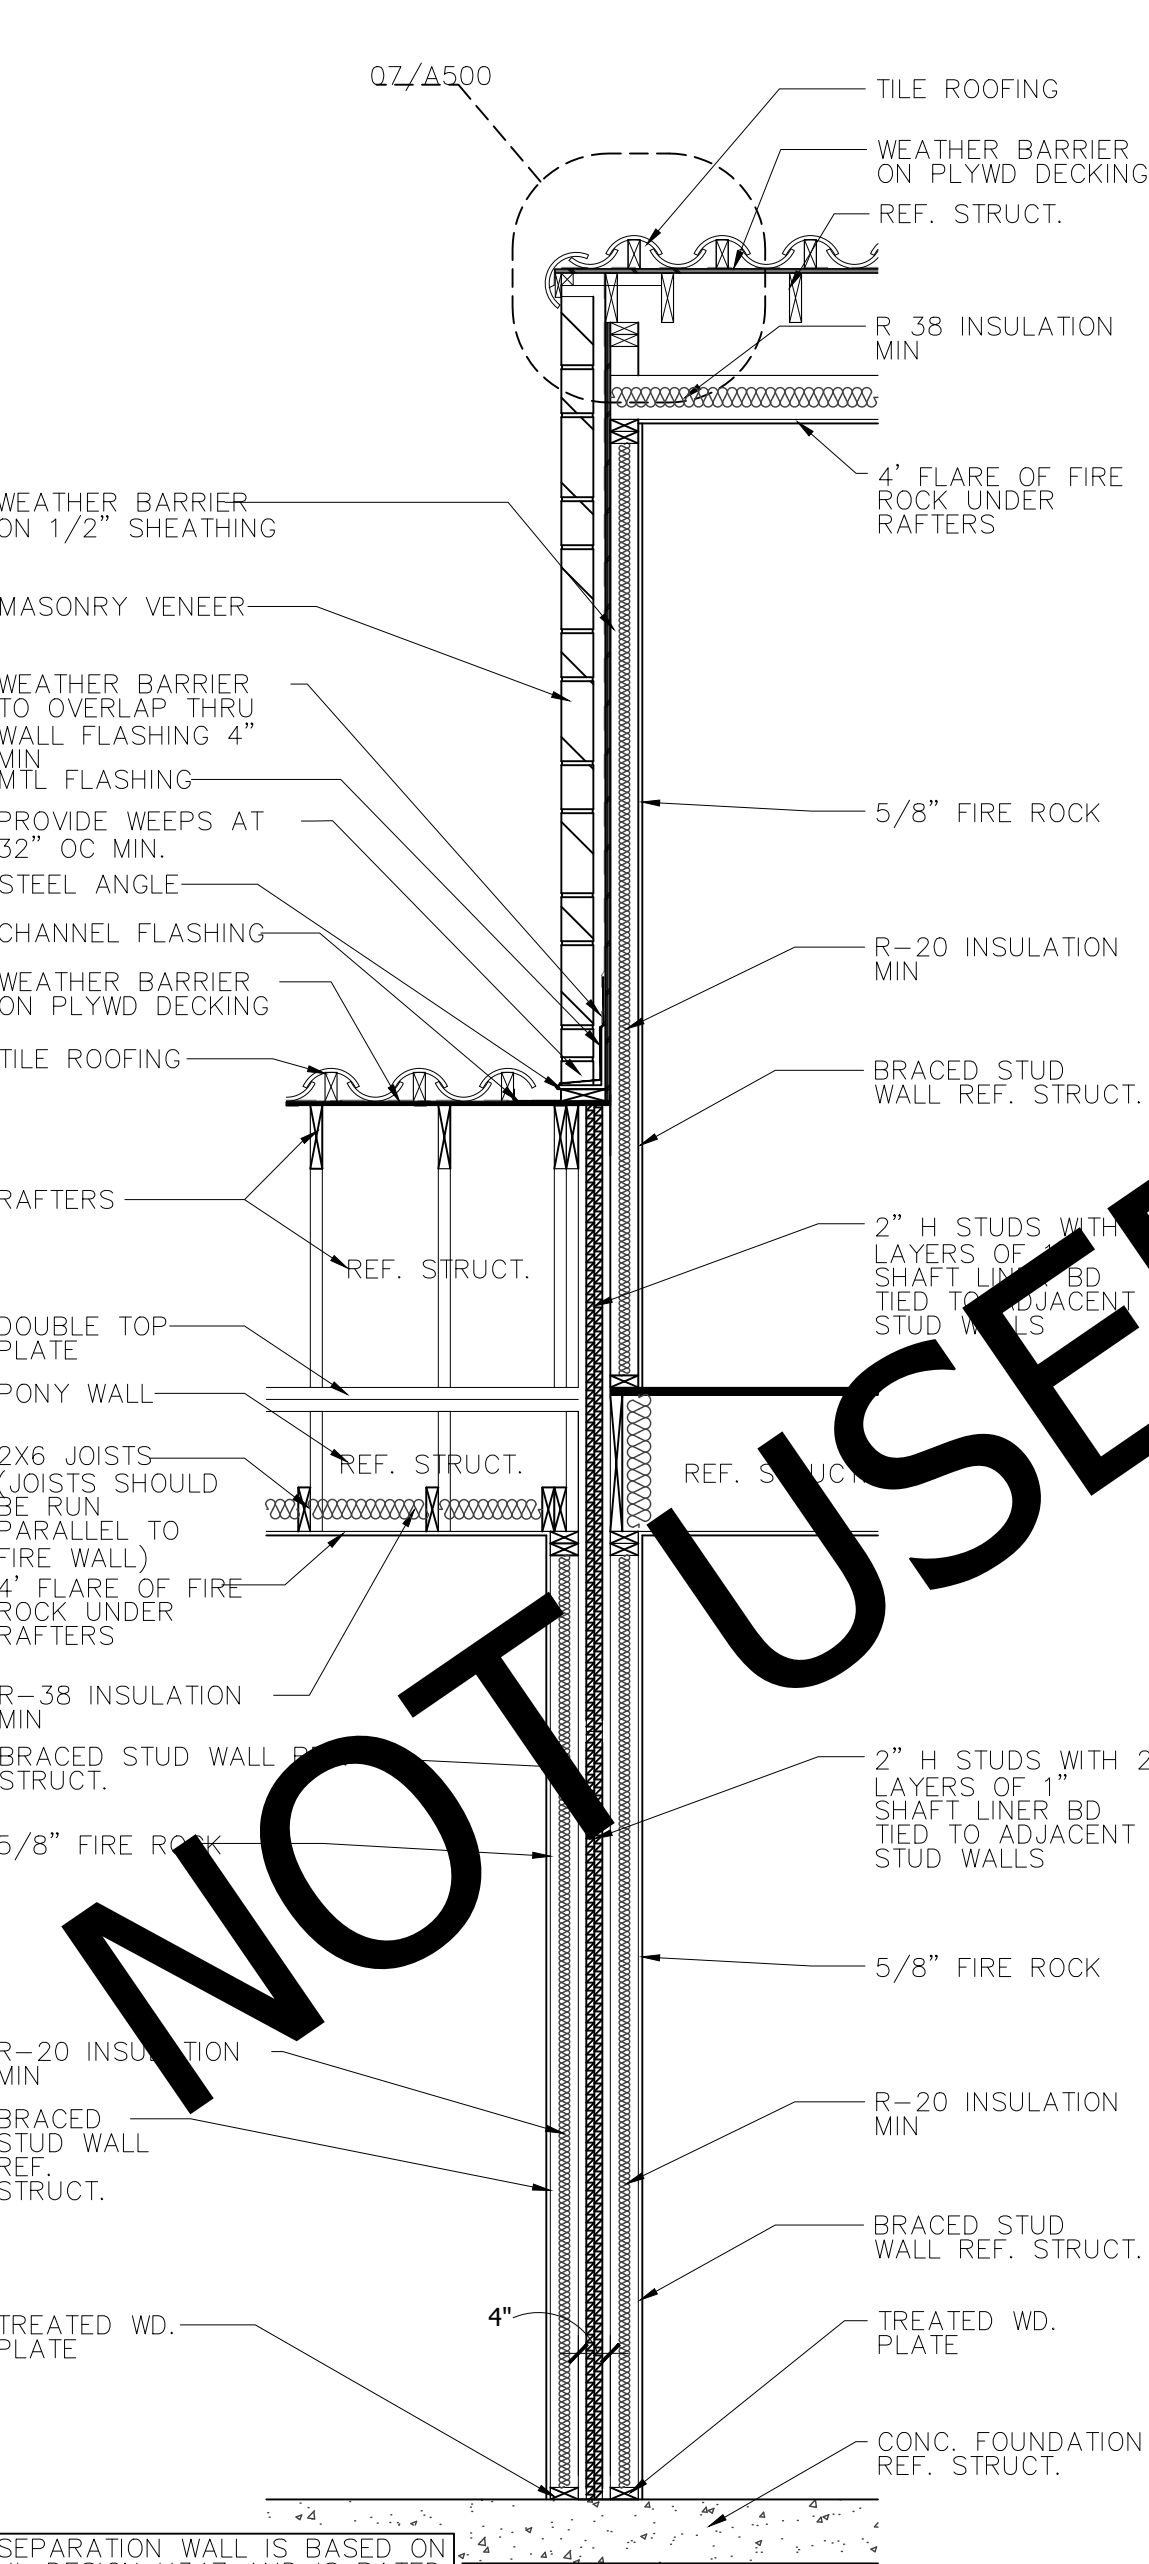

06 WALL SECTION

SCALE: 1/2" = 1'-0"

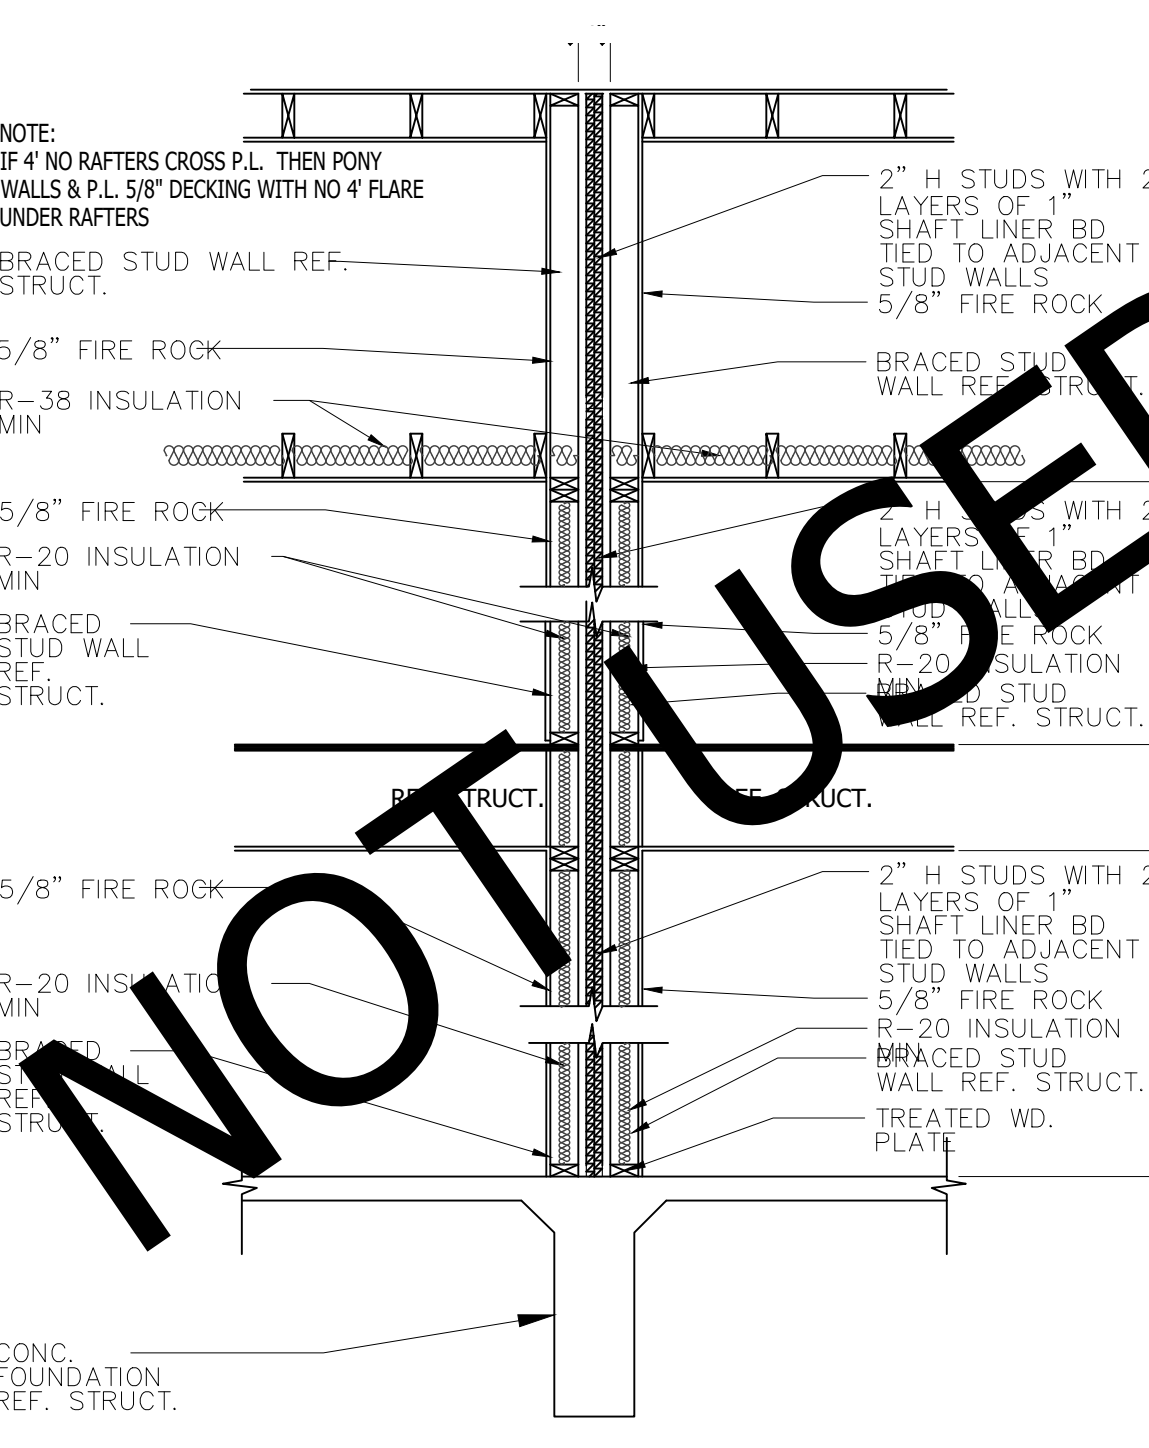

05 FIRE WALL DETAIL

SCALE: 1/2" = 1'-0"

REFER TO **ENTRADA DESIGN GUIDELINES** FOR FUTHER DETAILED INFORMATION REGARDING THESE PLANS
















ISSUE LOG

NO.	DESCRIPTION	DATE

PROJECT NO:	20-129
ISSUED FOR:	OTP
DRAWN BY:	WLL
DATE:	11/29/21

ROOF DETAILS

  A500

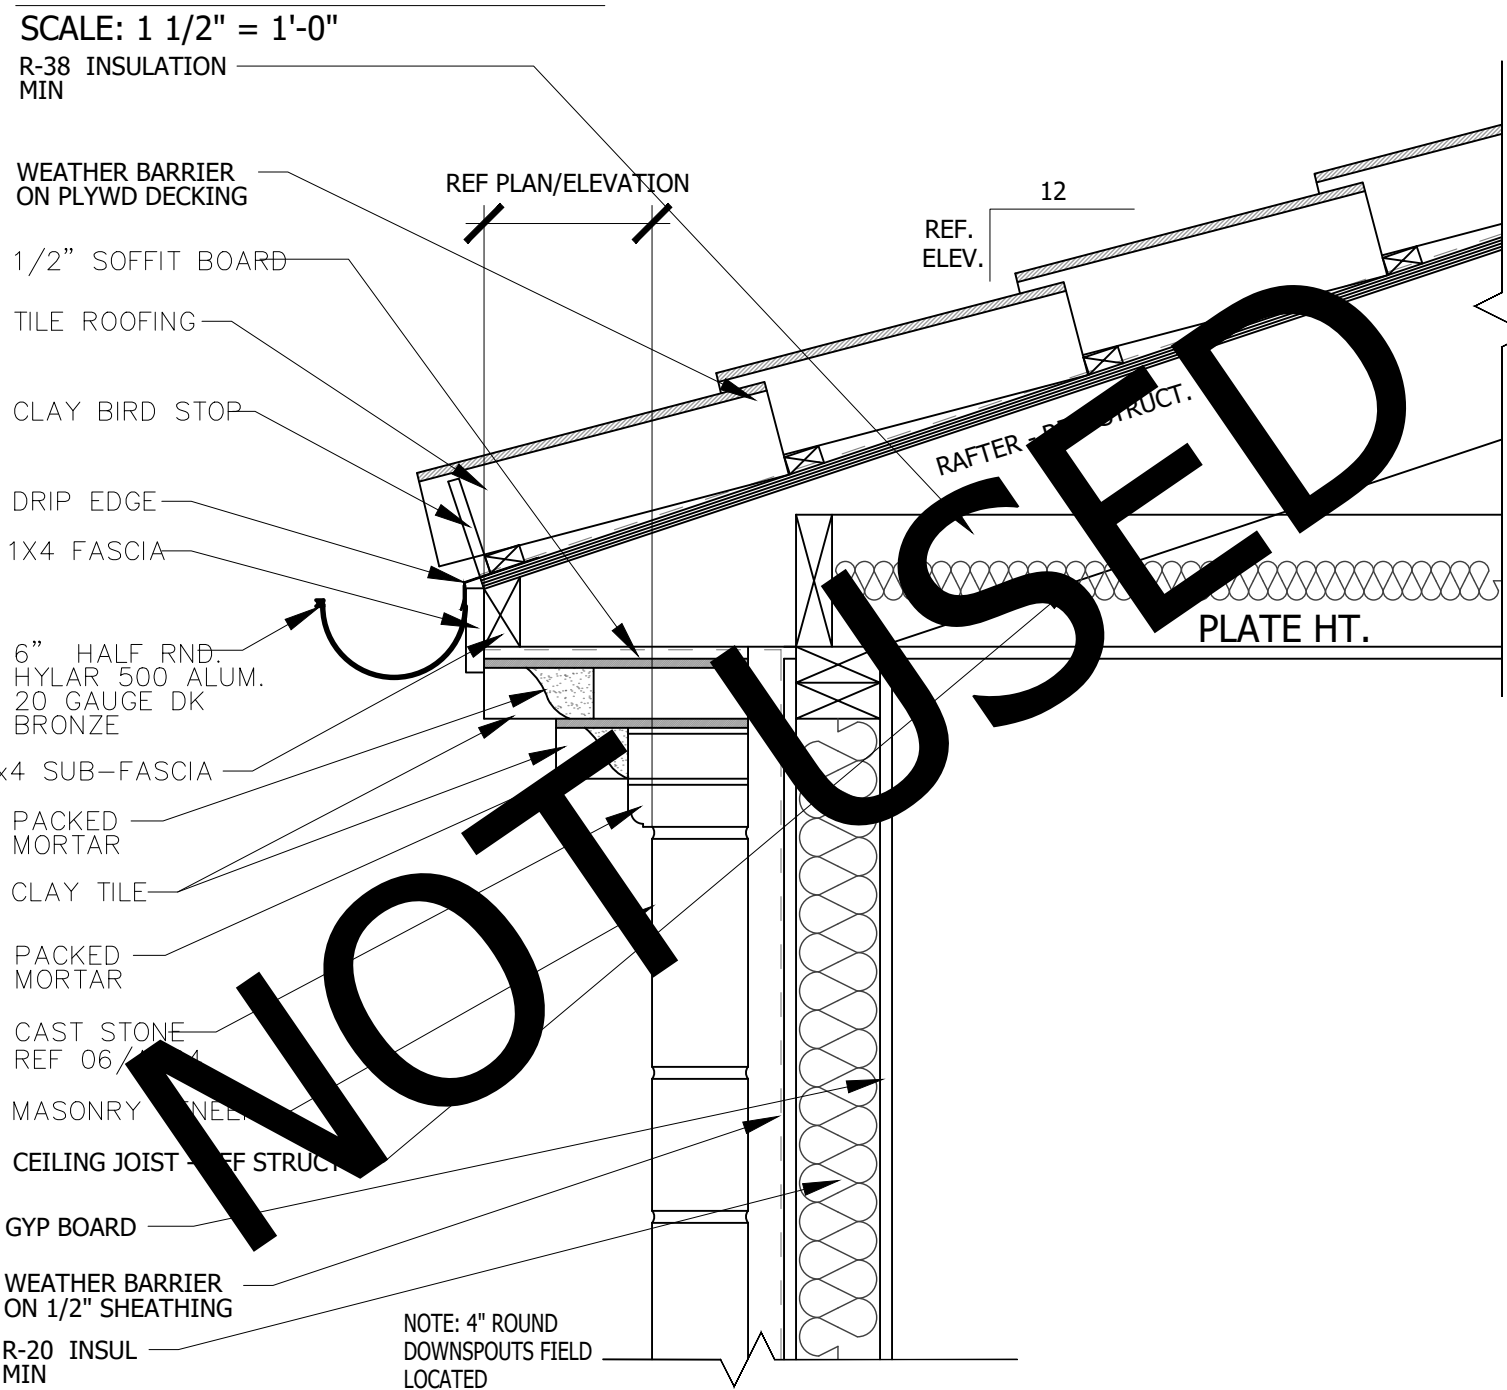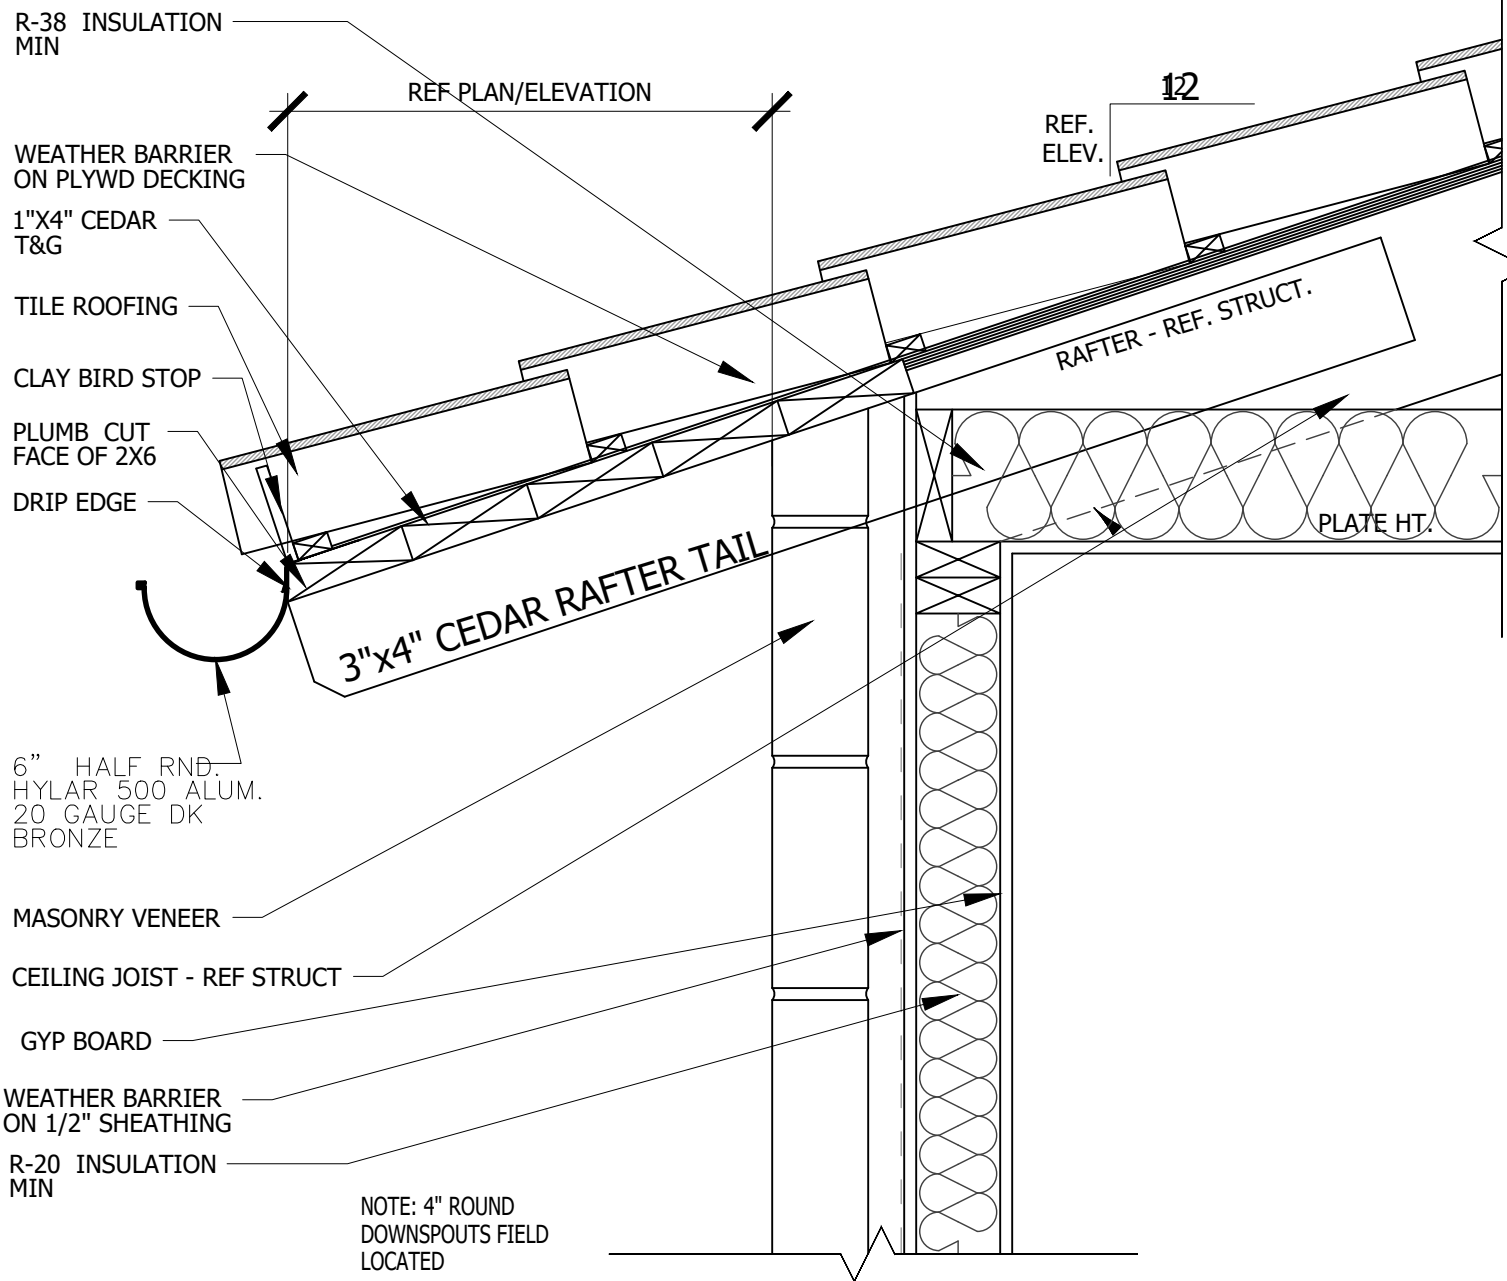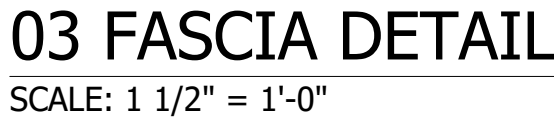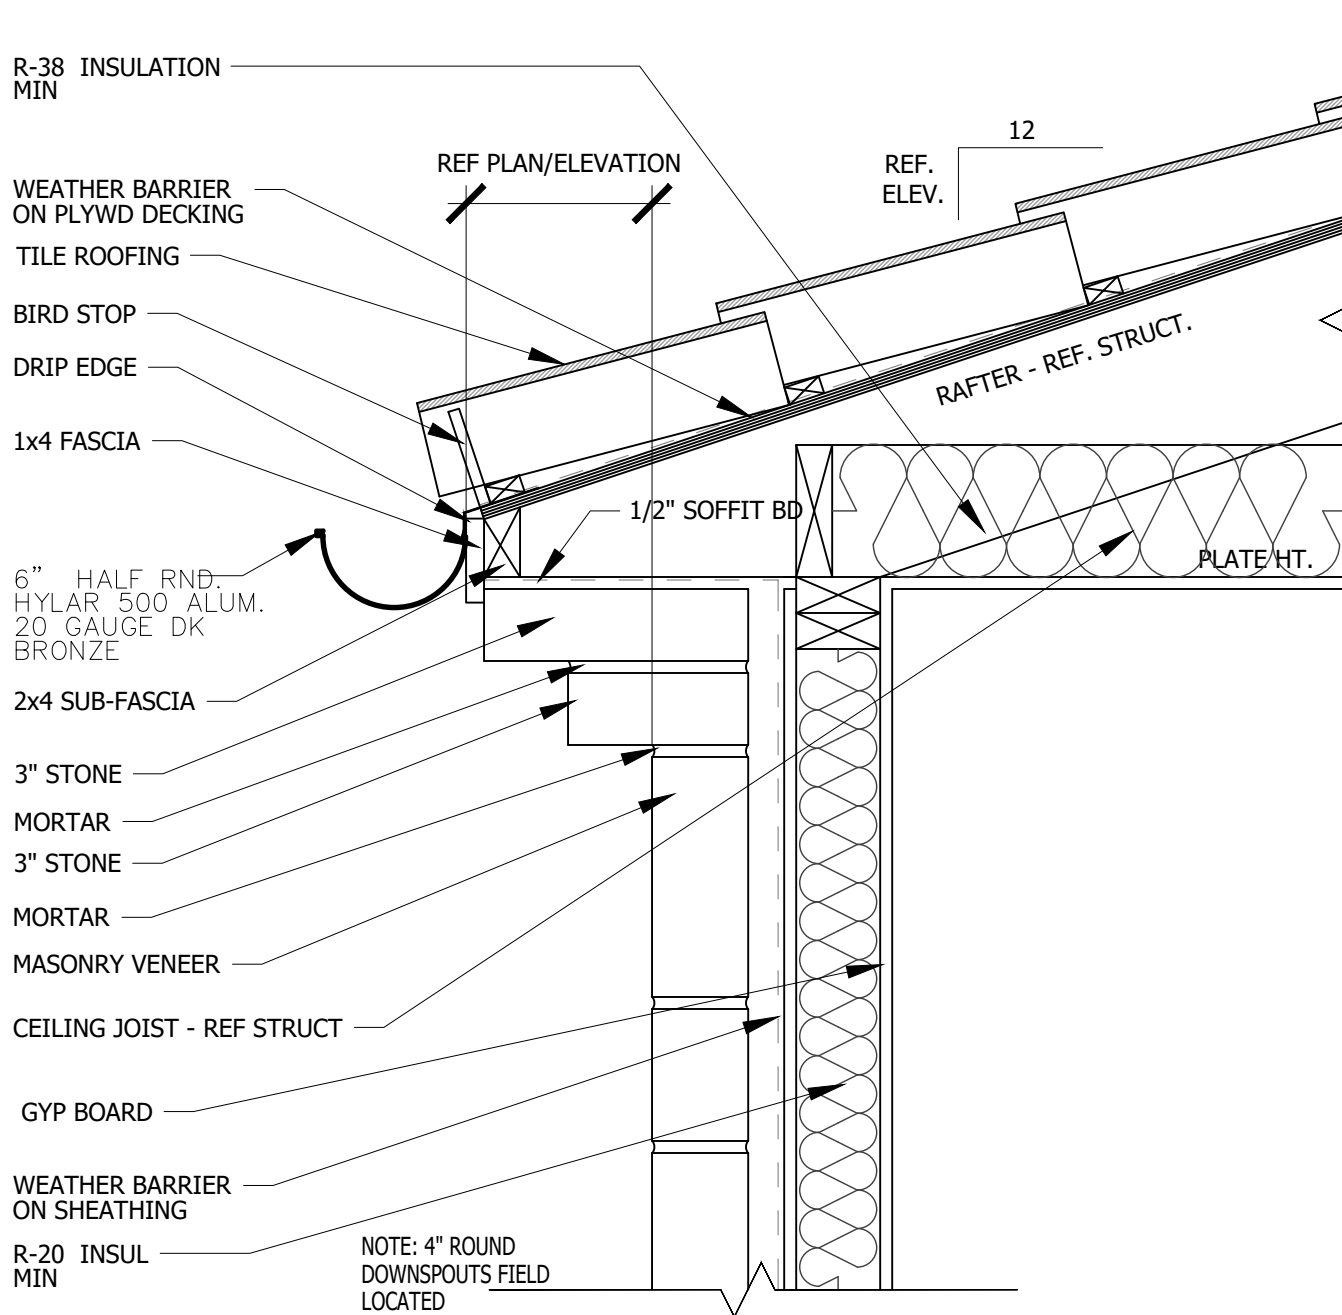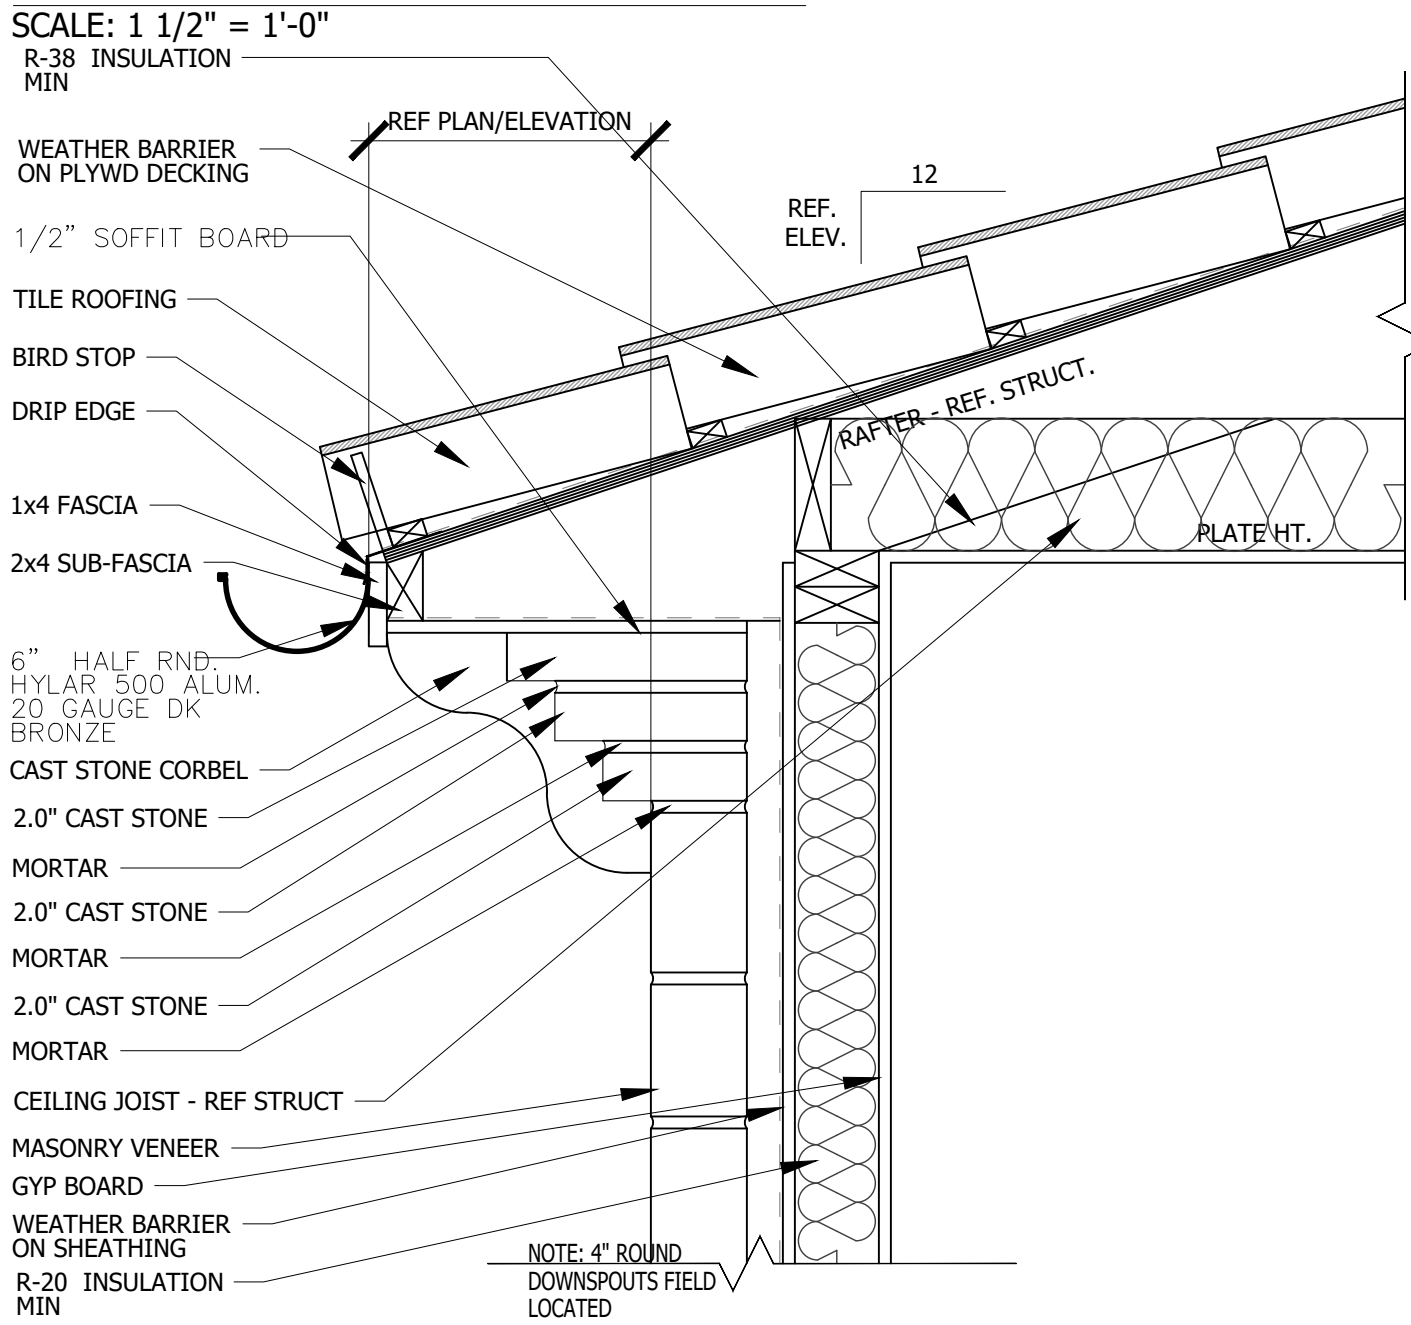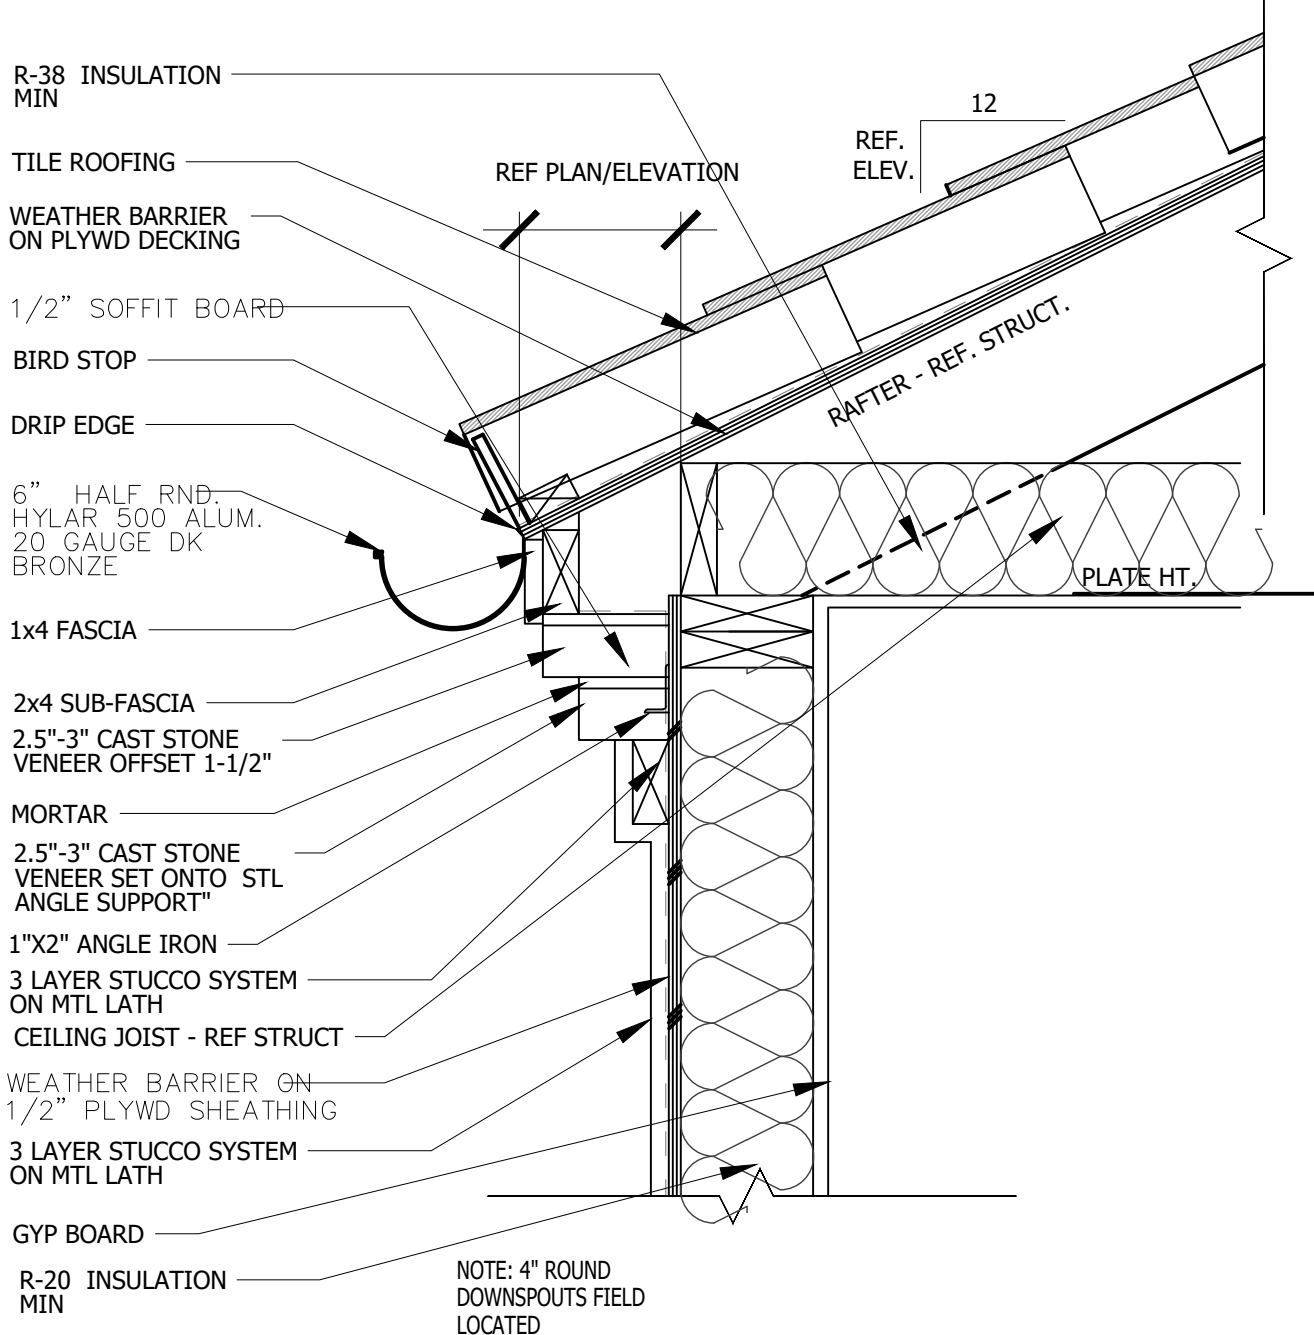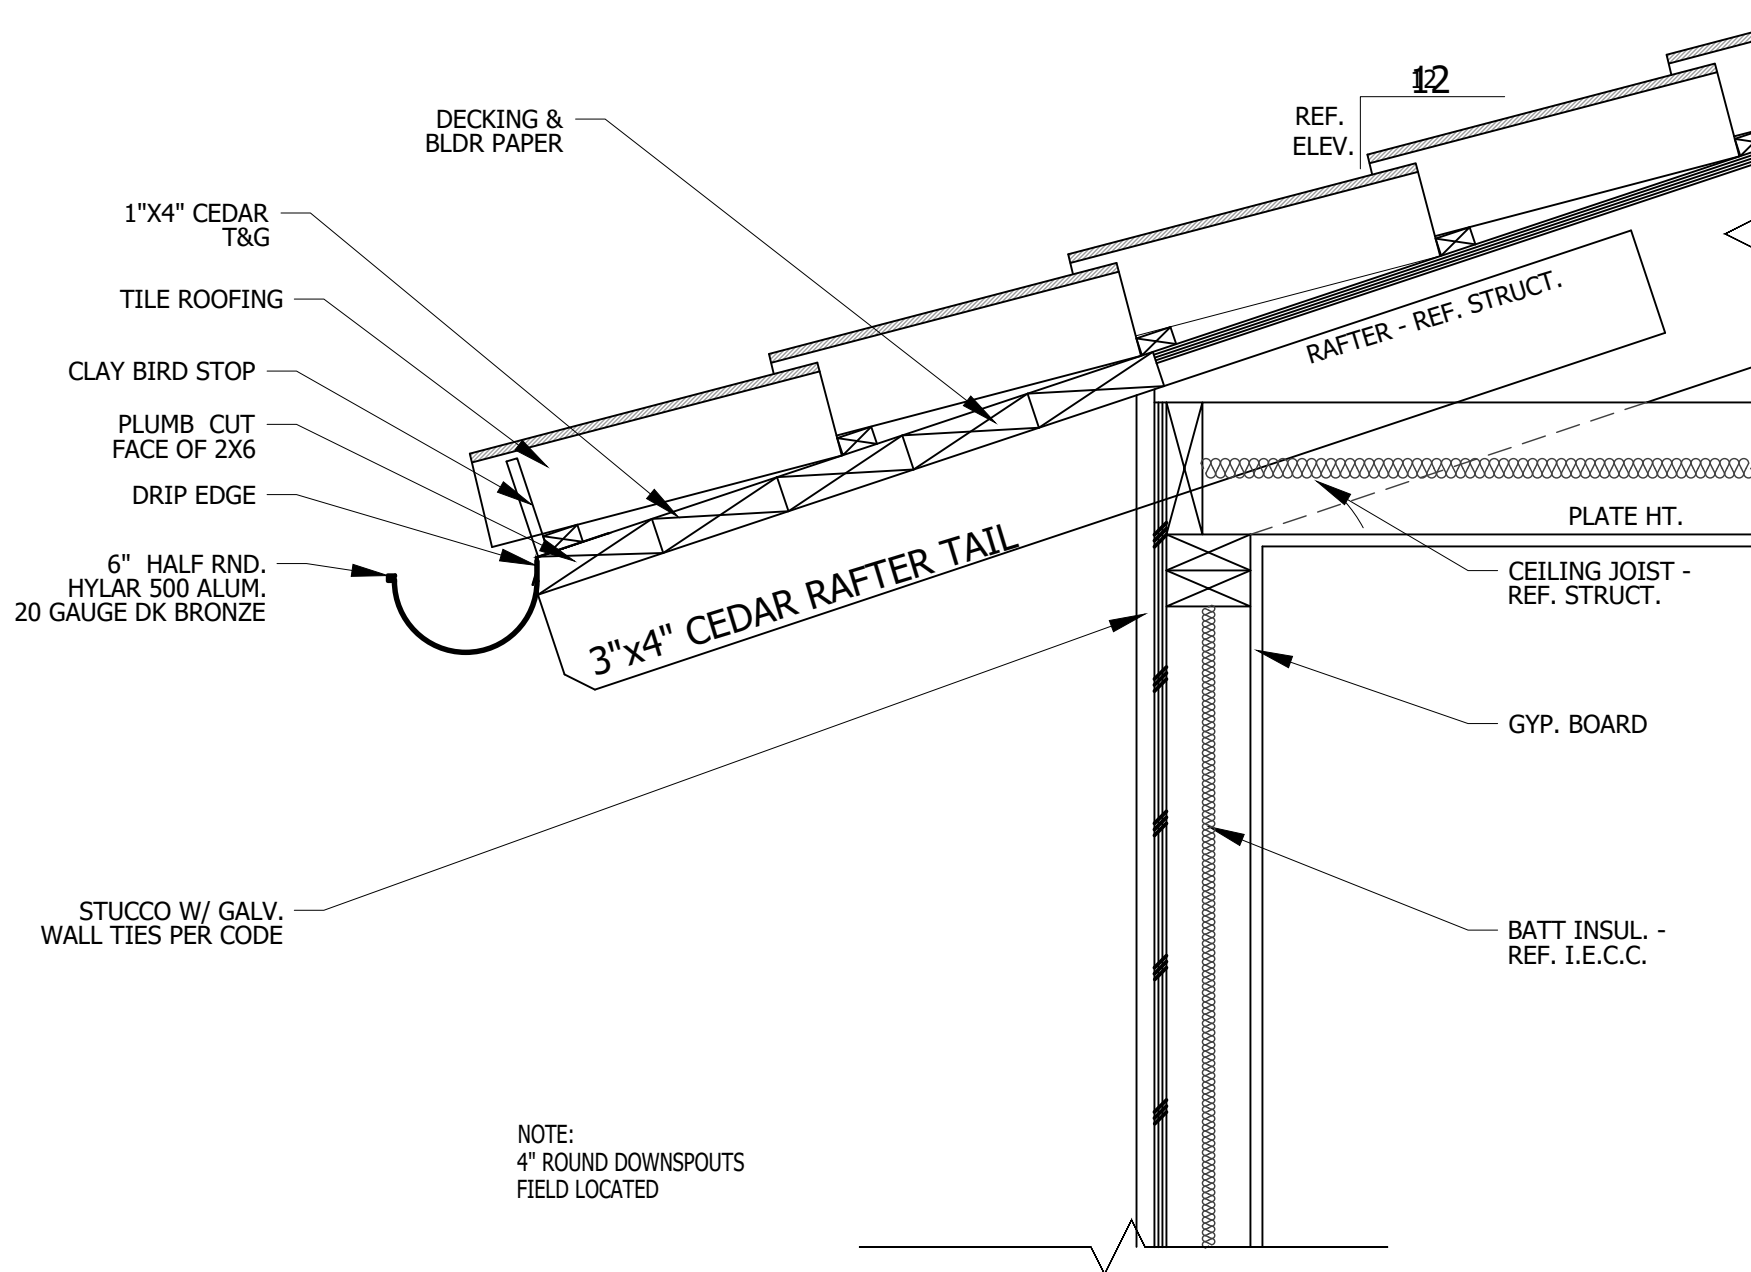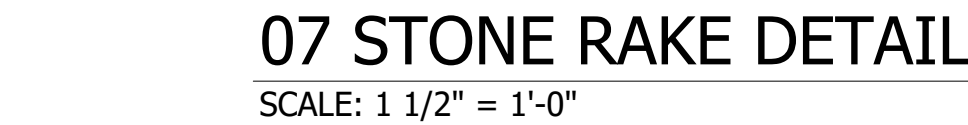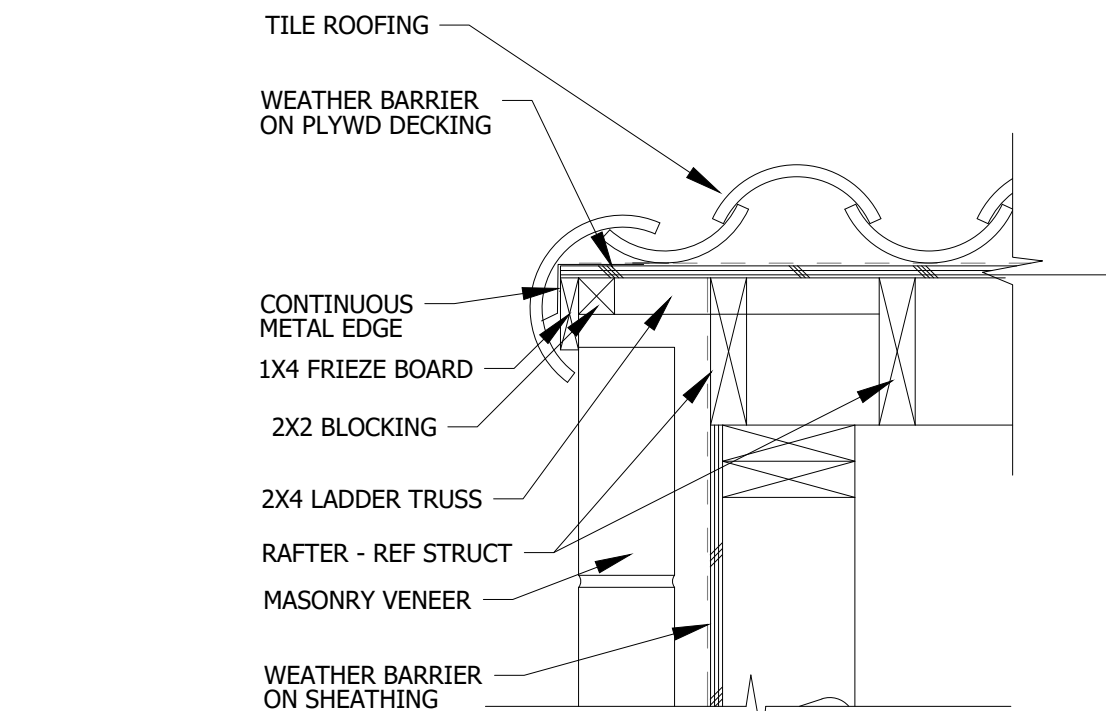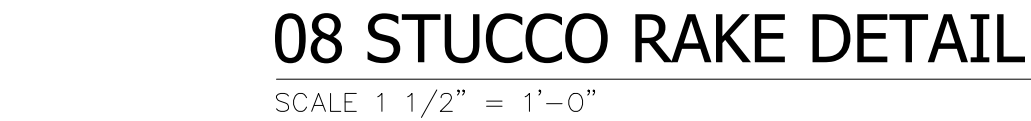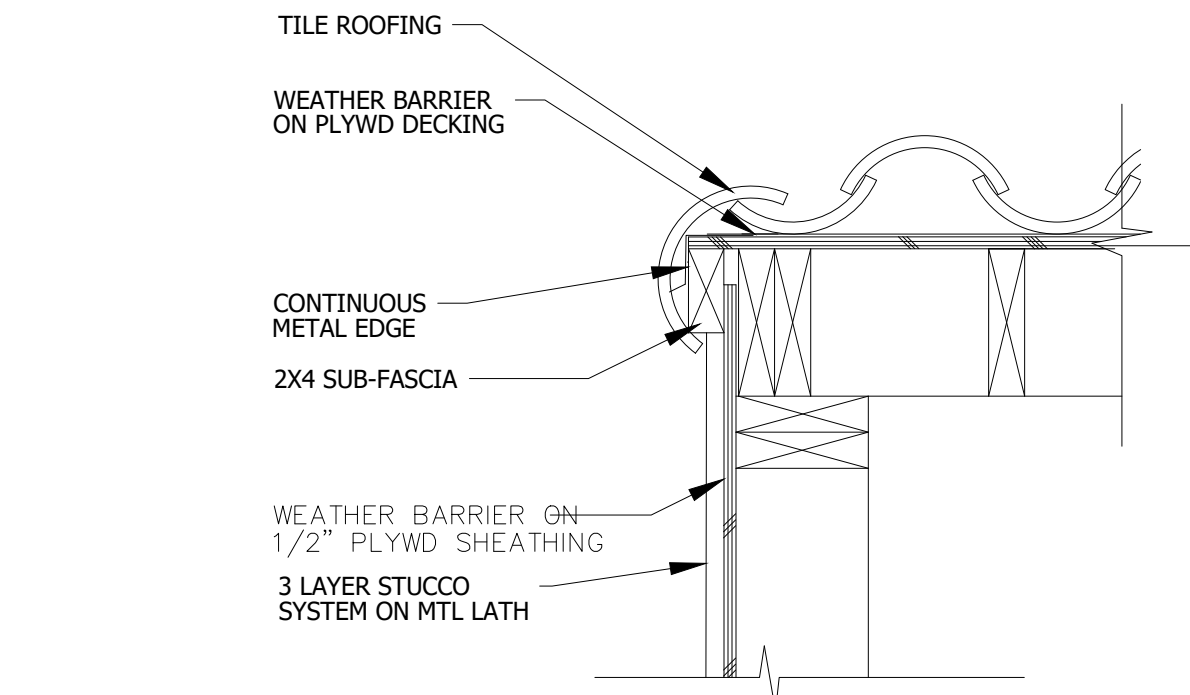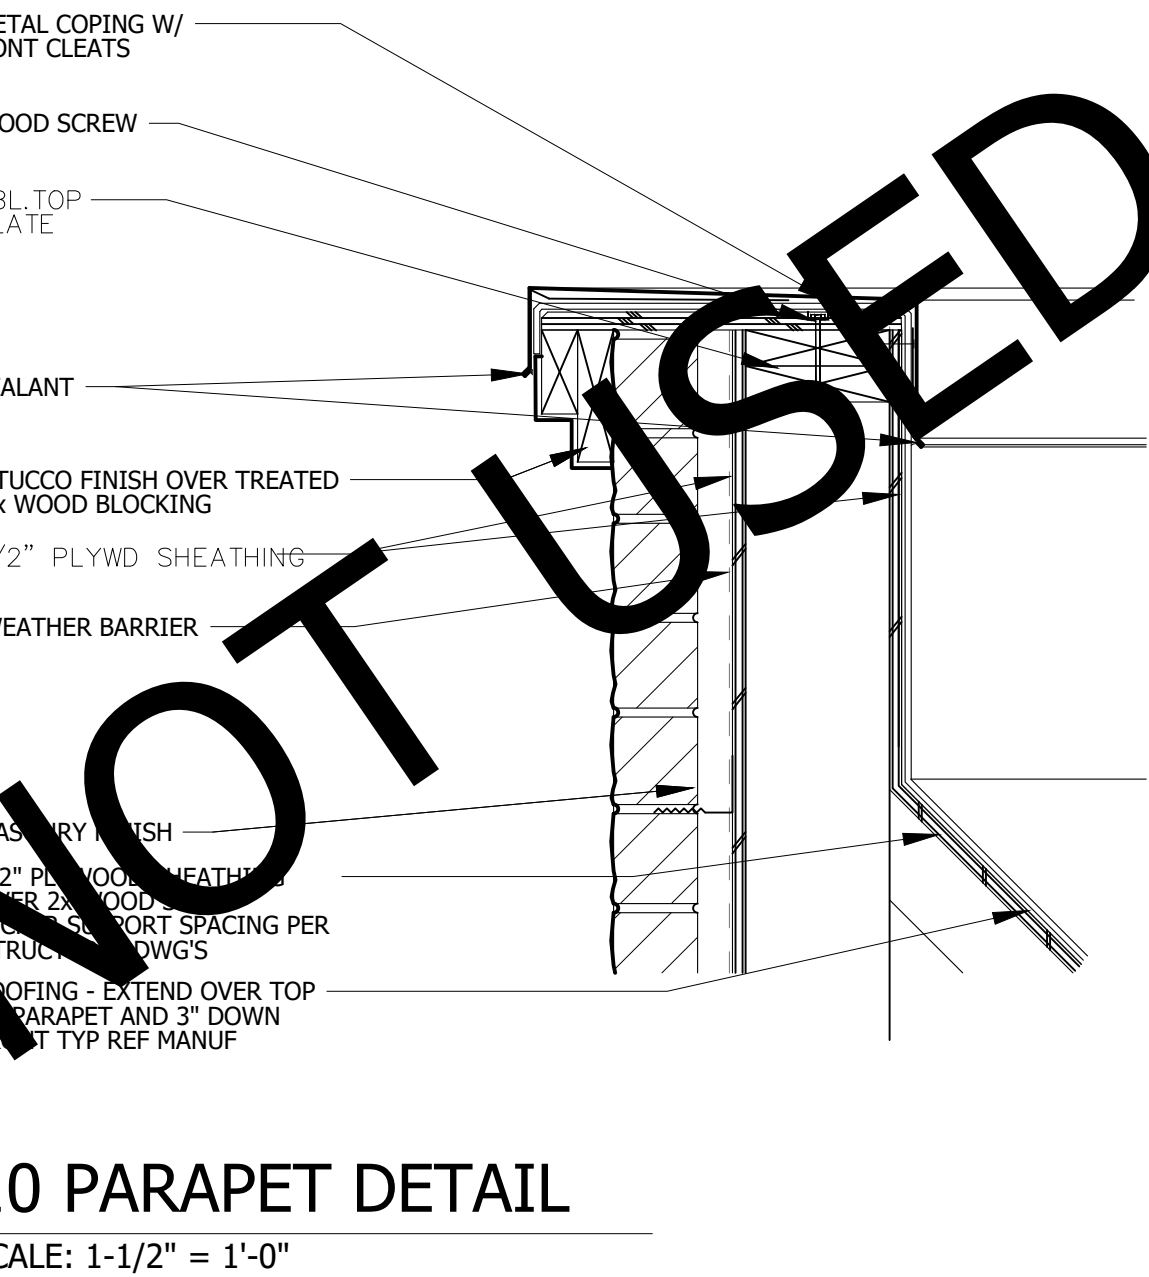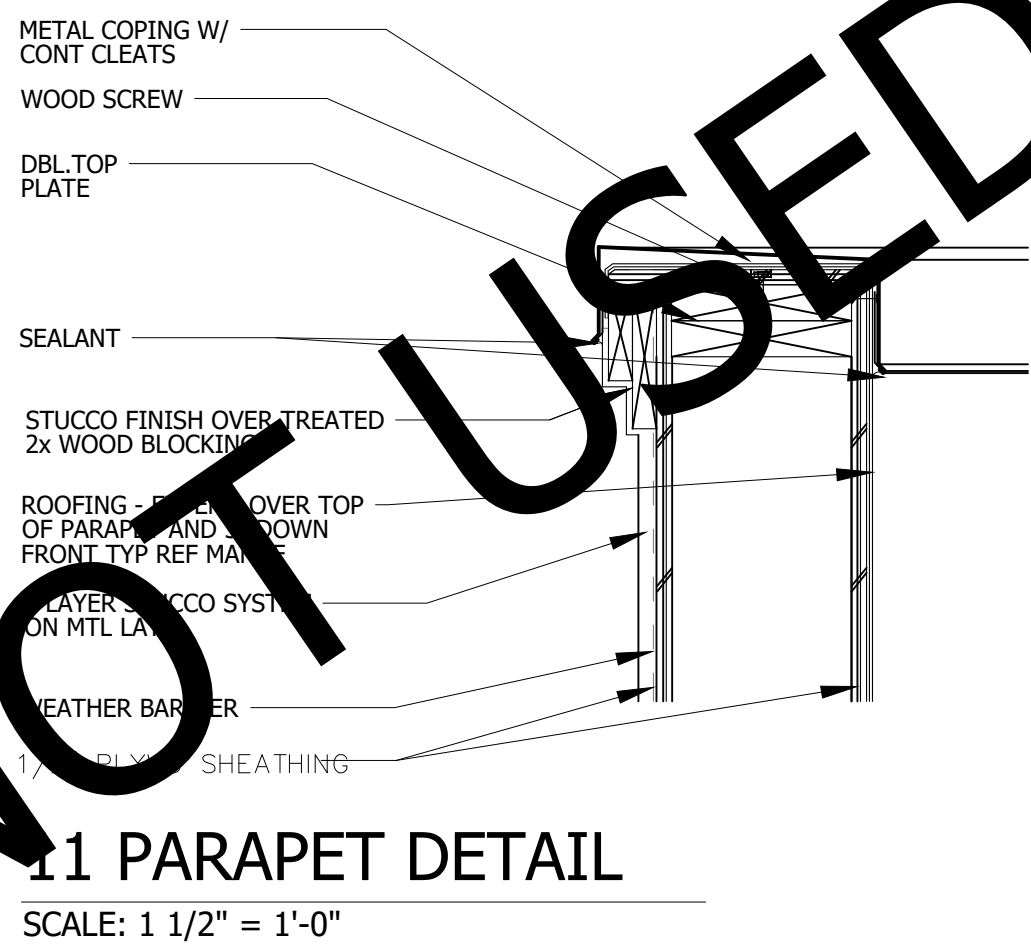


ISSUE LOG

NO.	DESCRIPTION	DATE

PROJECT NO:	20-129
ISSUED FOR:	OTP
DRAWN BY:	WLL
DATE:	11/29/21


STANDARD DETAILS

A501

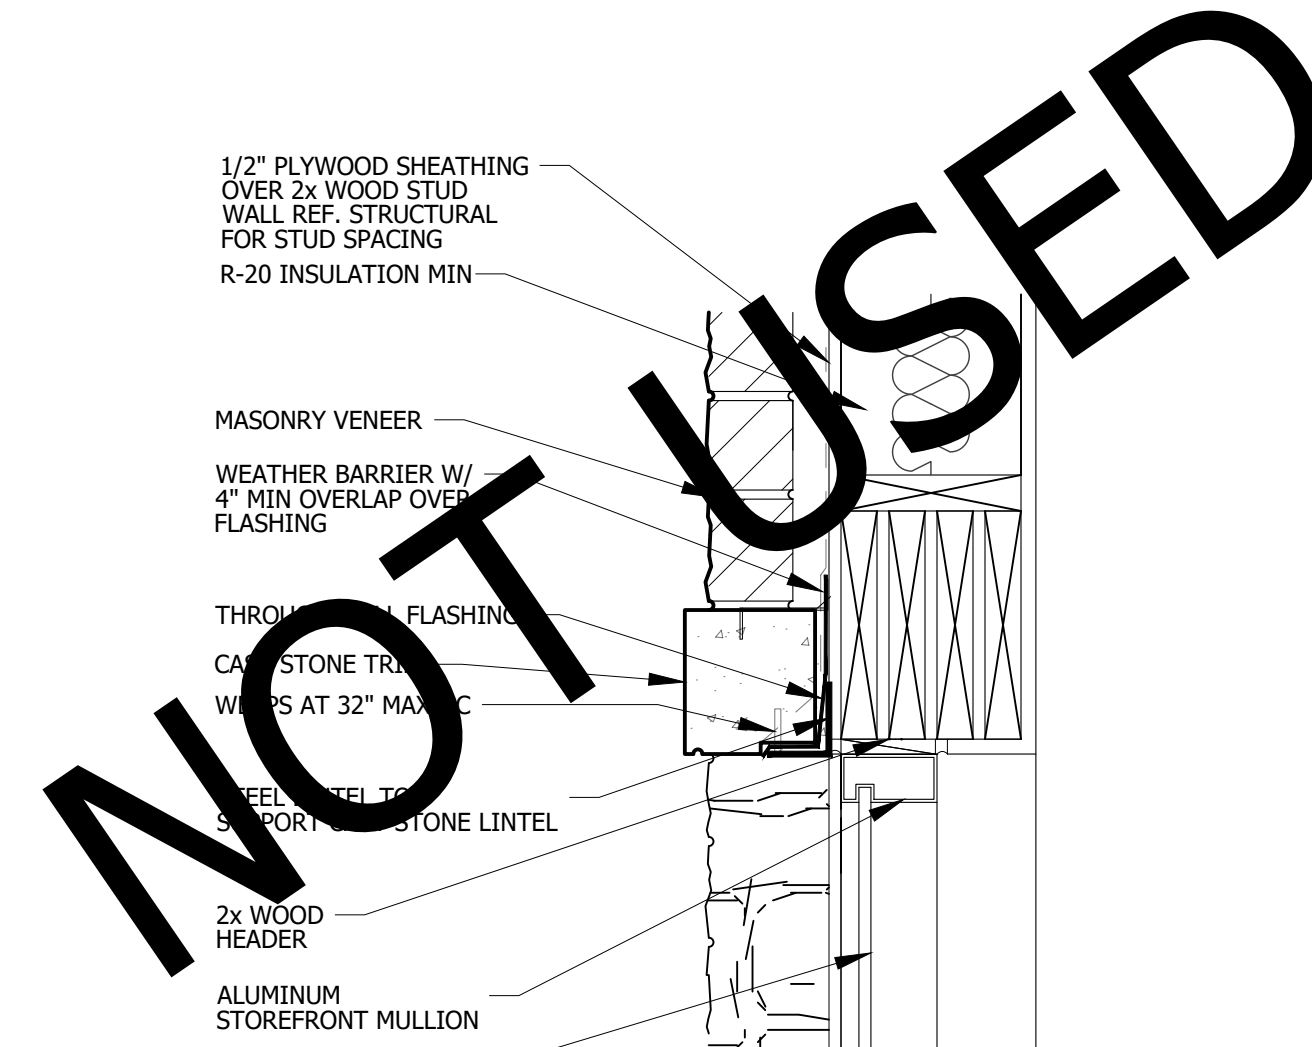


08 STOREFRONT HEADER

SCALE: 1 1/2" = 1'-0"

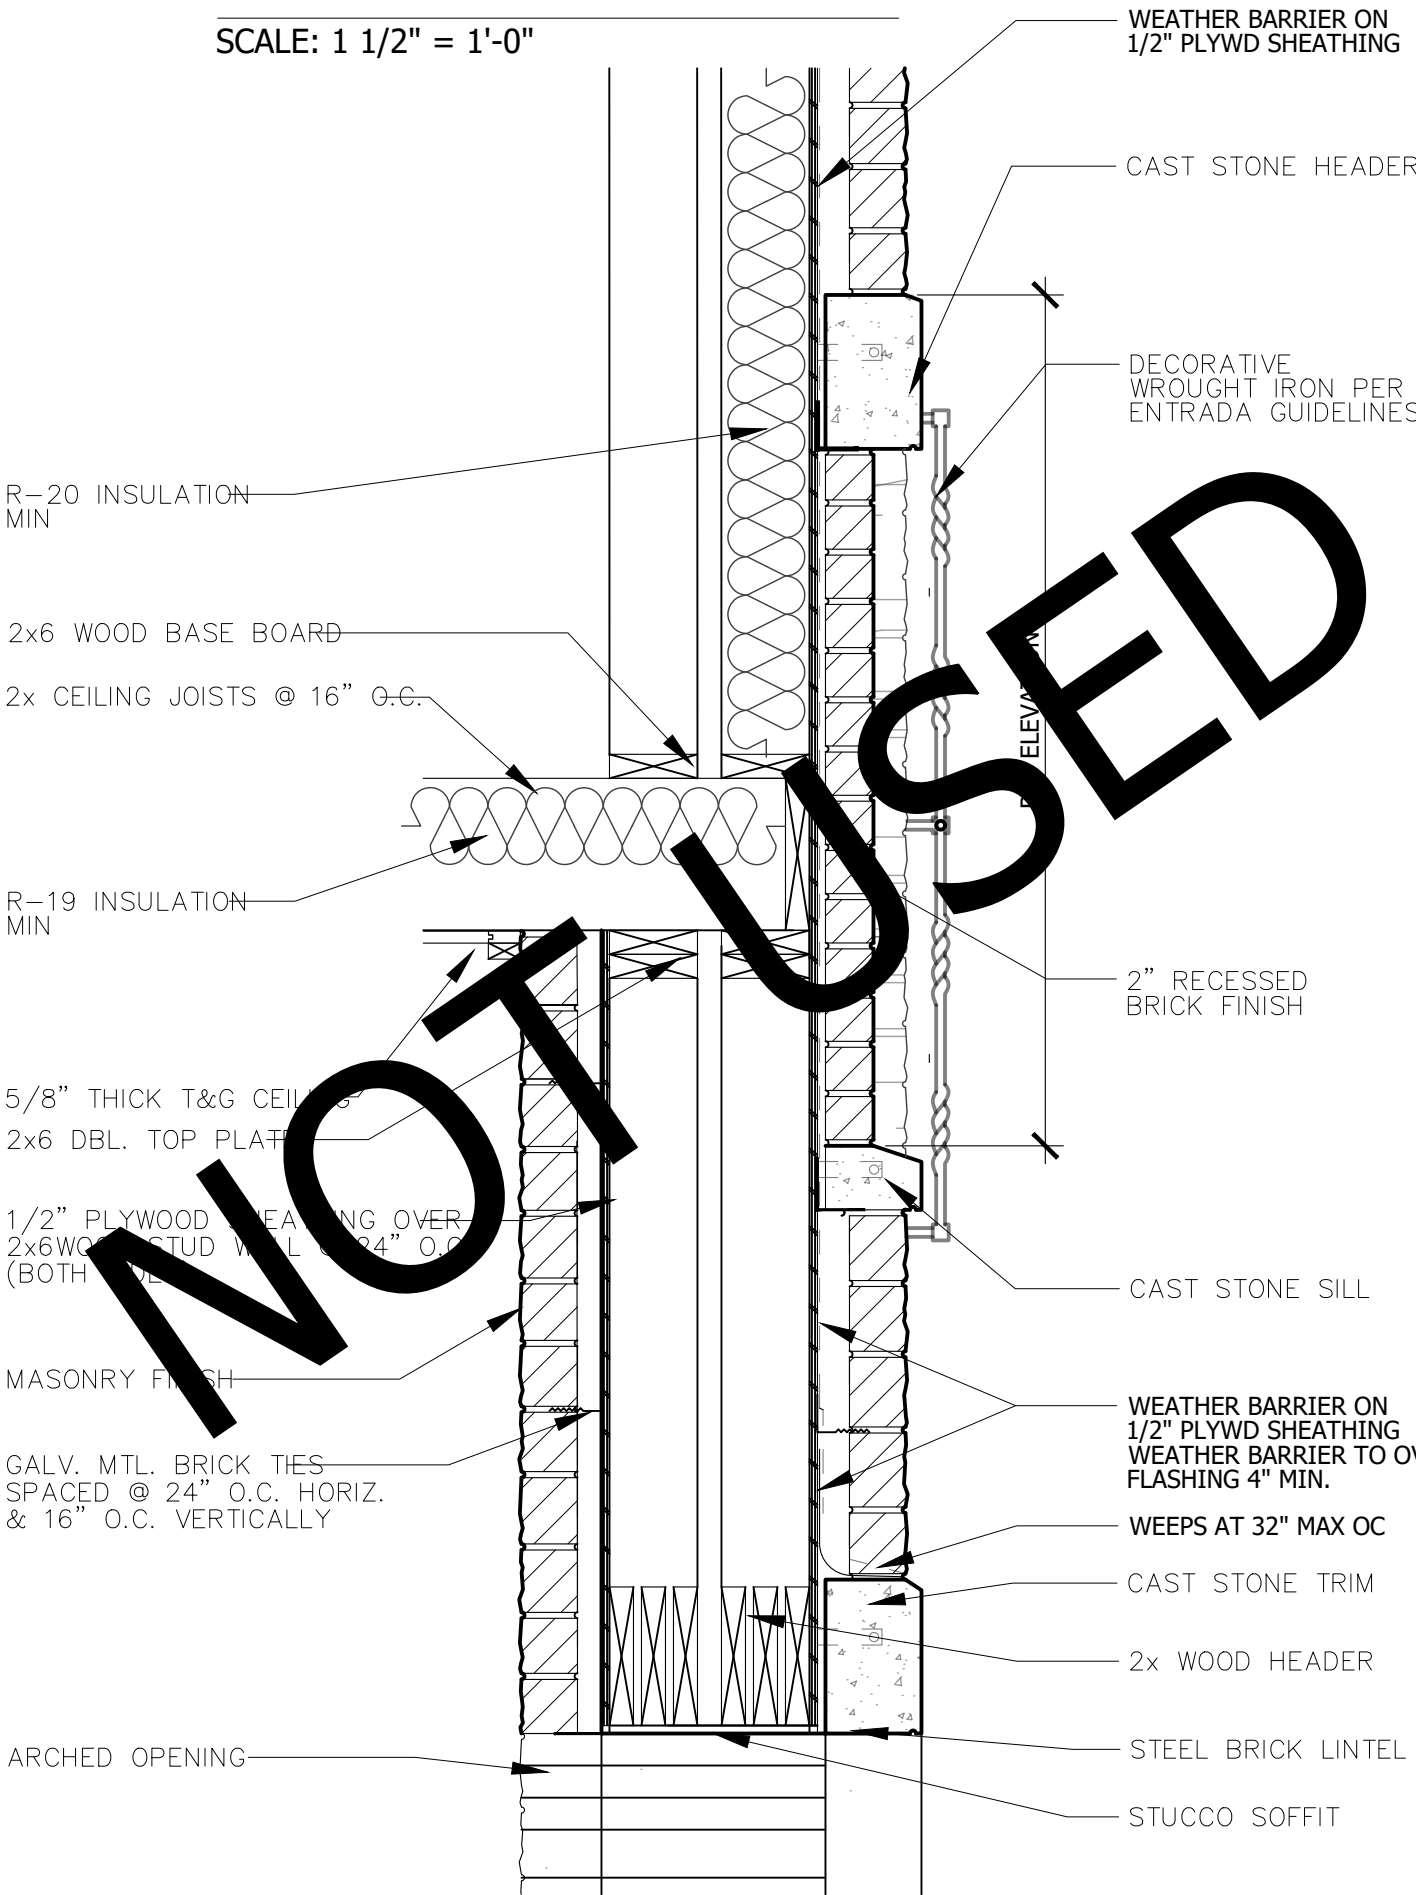


07 INSET BRICK DETAIL
W/ DECORATIVE WROUGHT IRON

SCALE: 1" = 1'-0"

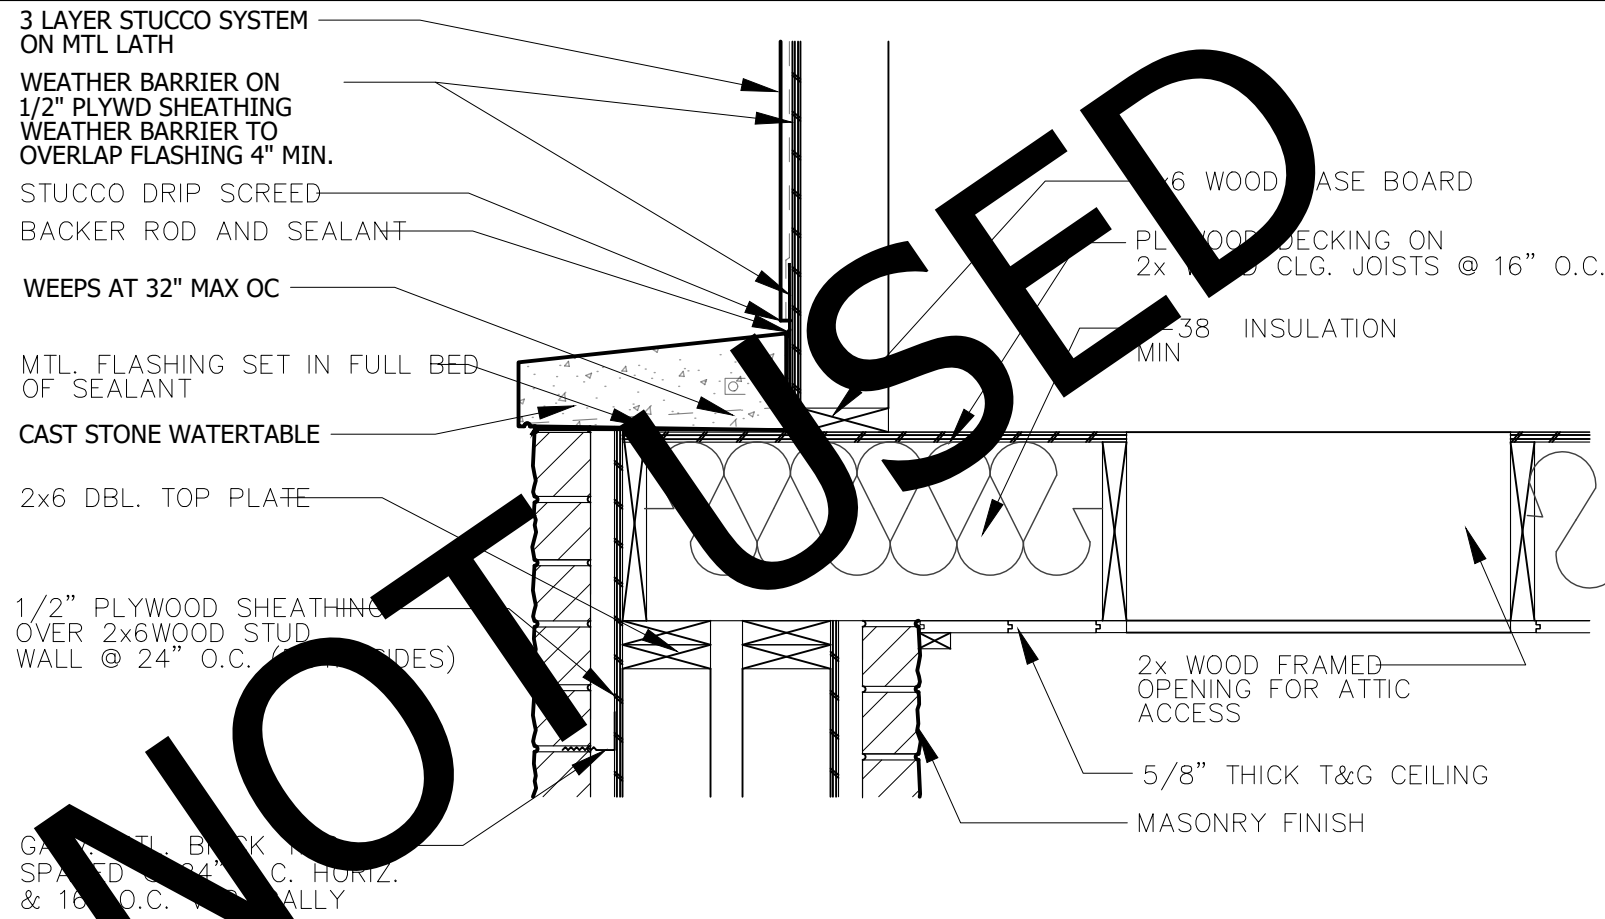


06 ATTIC ACCESS DETAIL

SCALE: 1" = 1'-0"

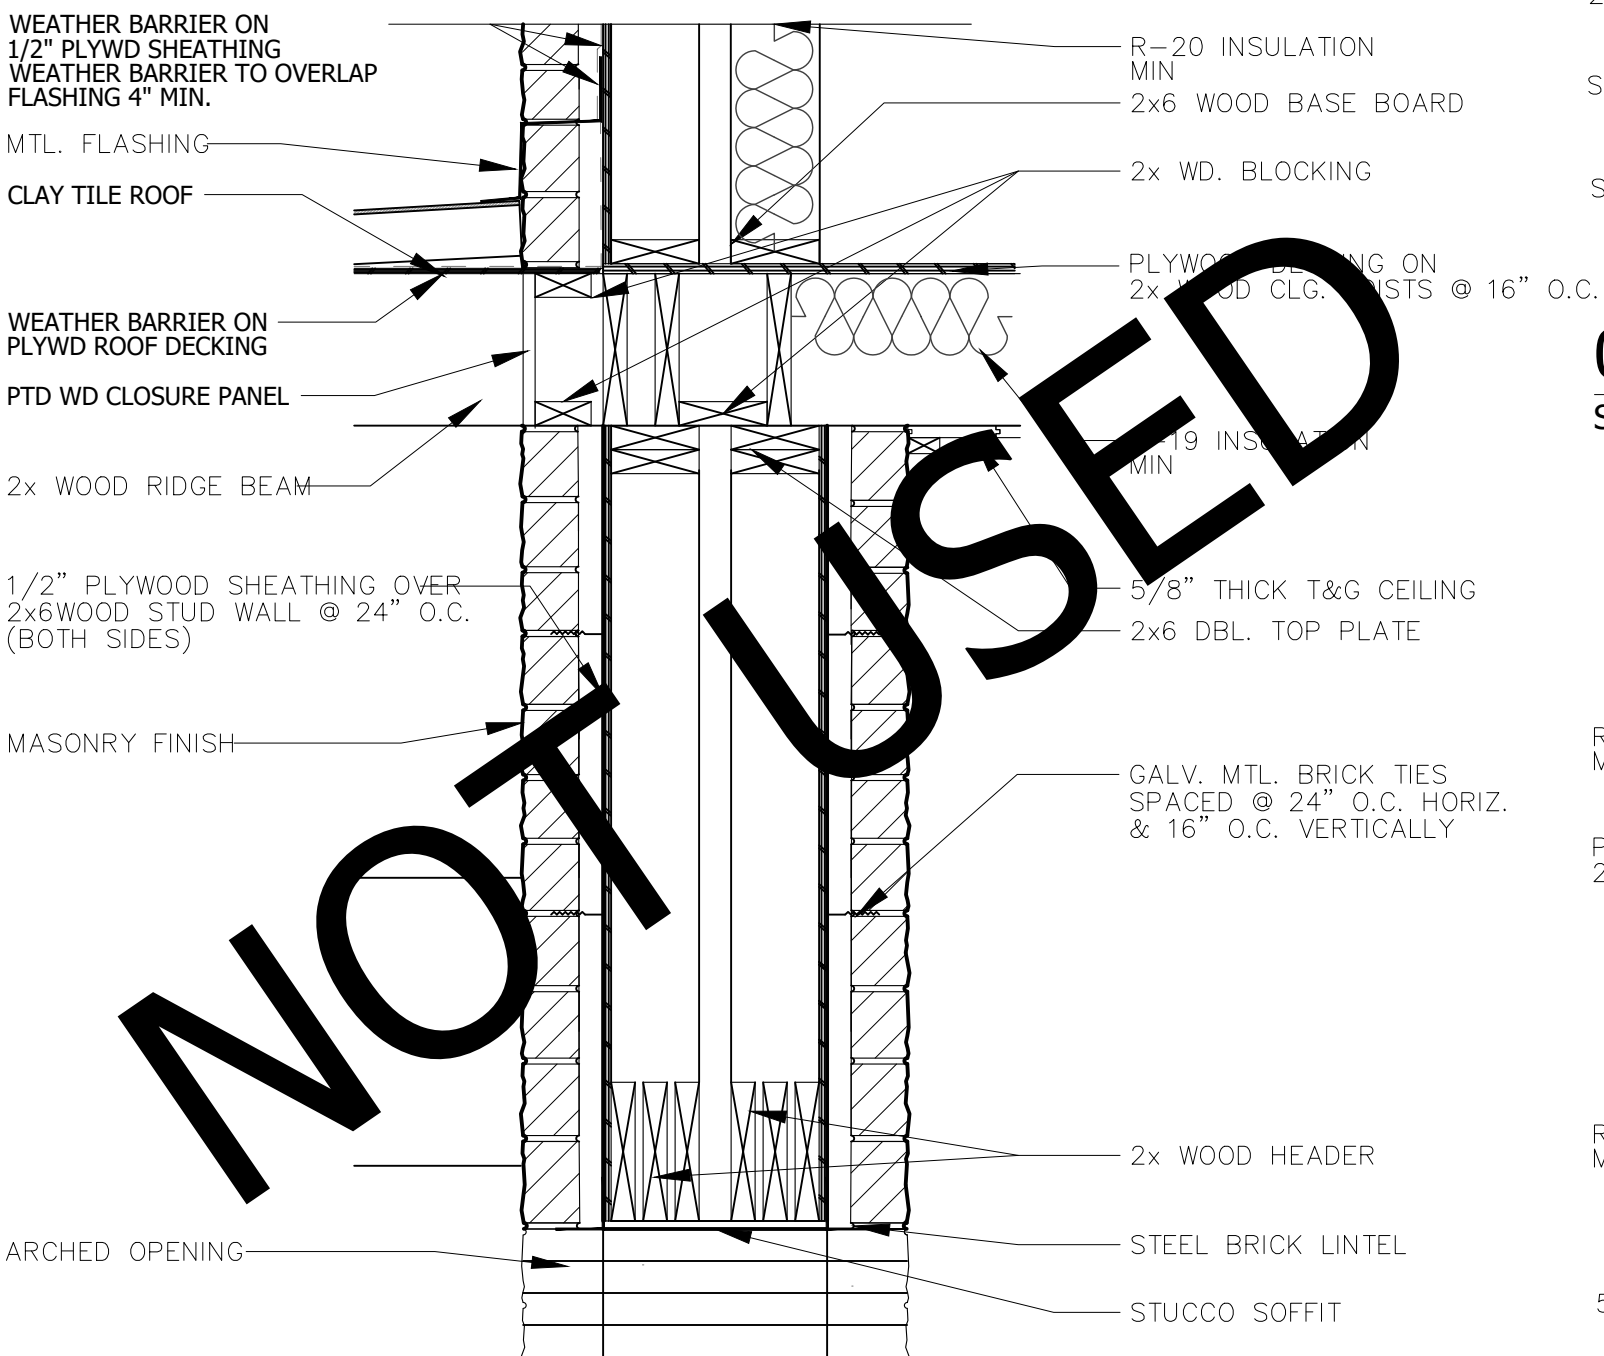


05 ARCHED OPENING DETAIL

SCALE: 1" = 1'-0"

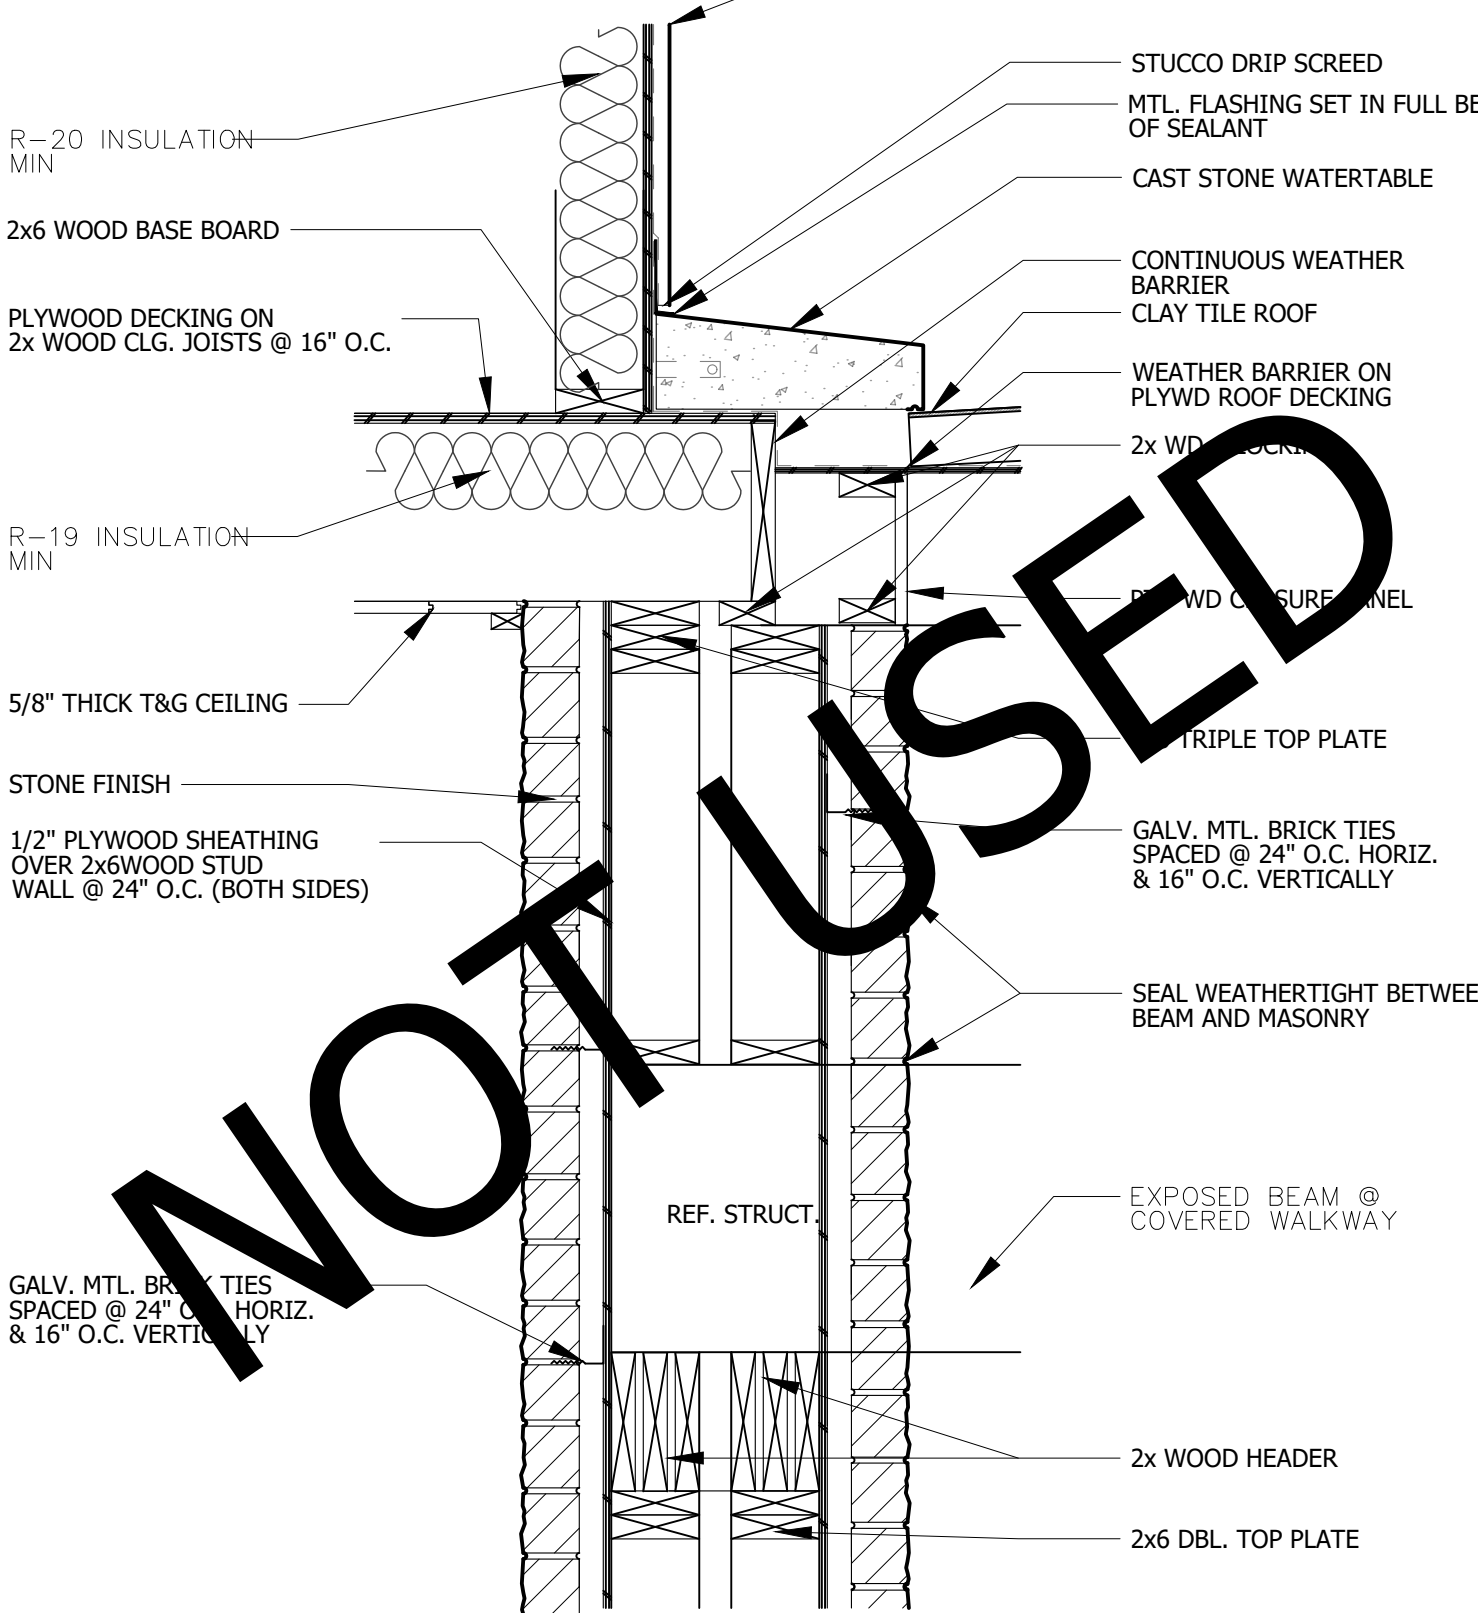


04 WATERTABLE DETAIL

SCALE: 1" = 1'-0"

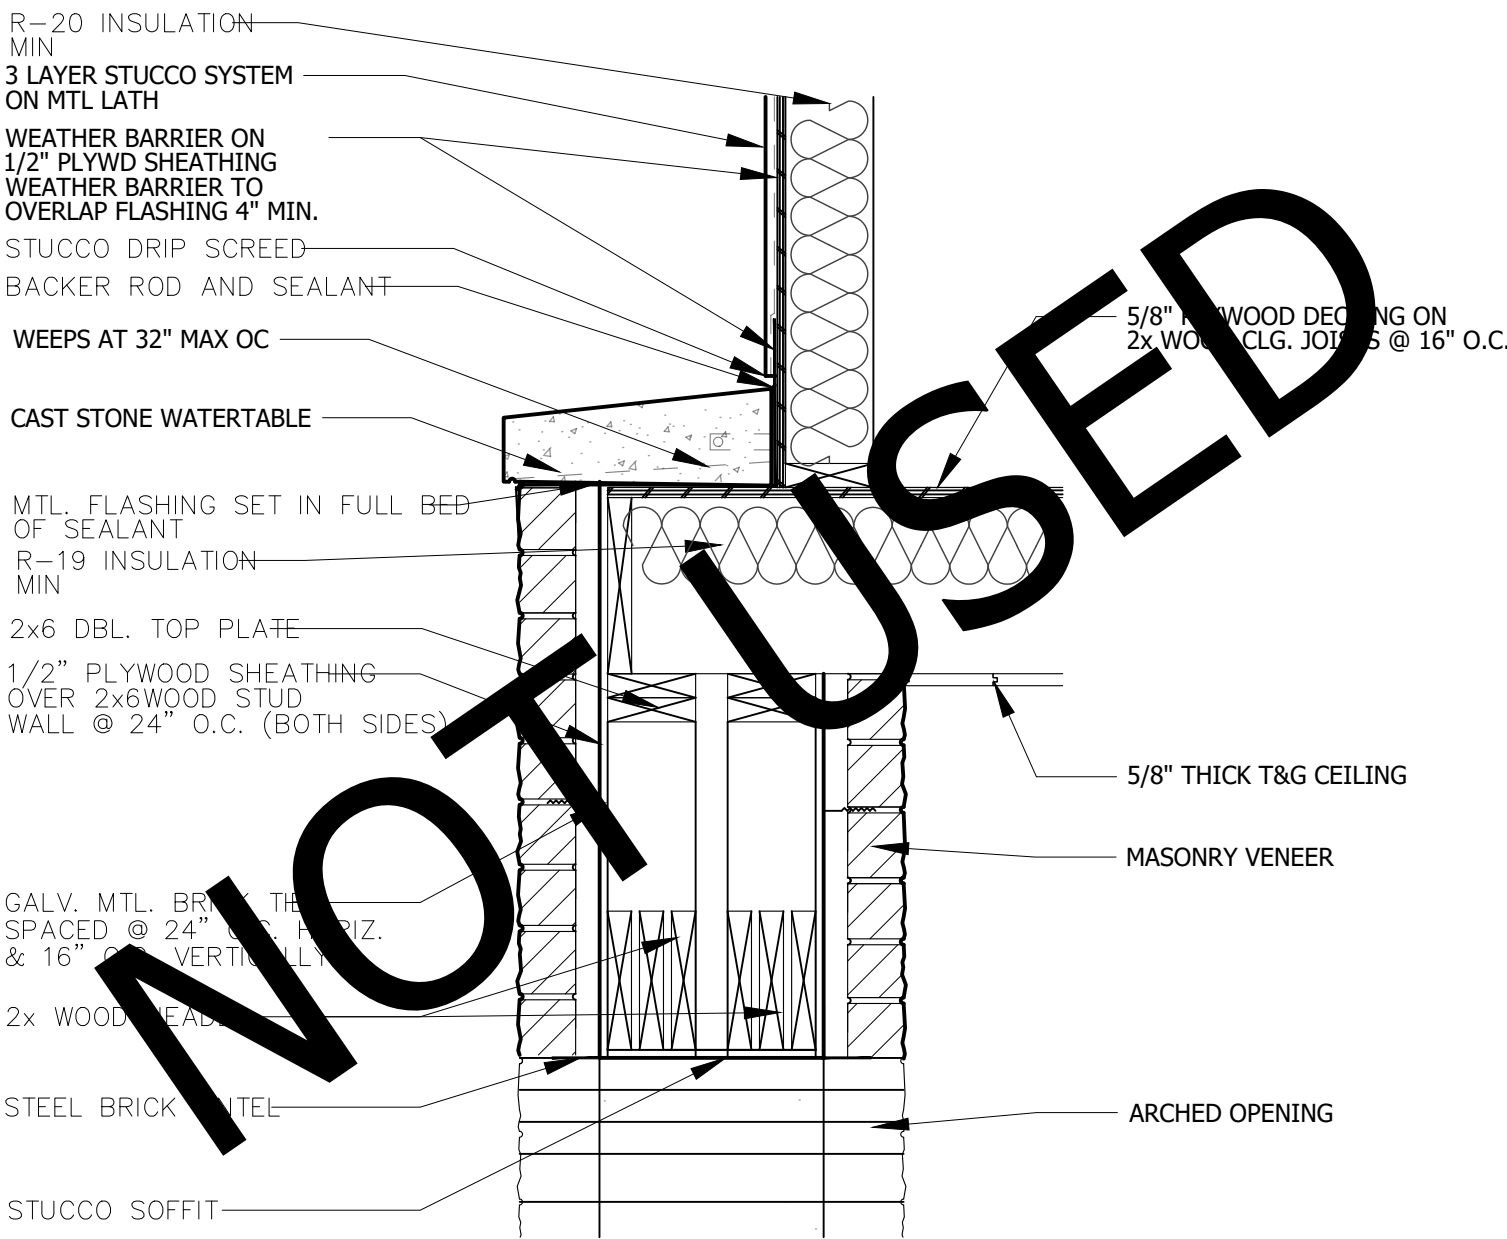


03 WATERTABLE DETAIL

SCALE: 1" = 1'-0"

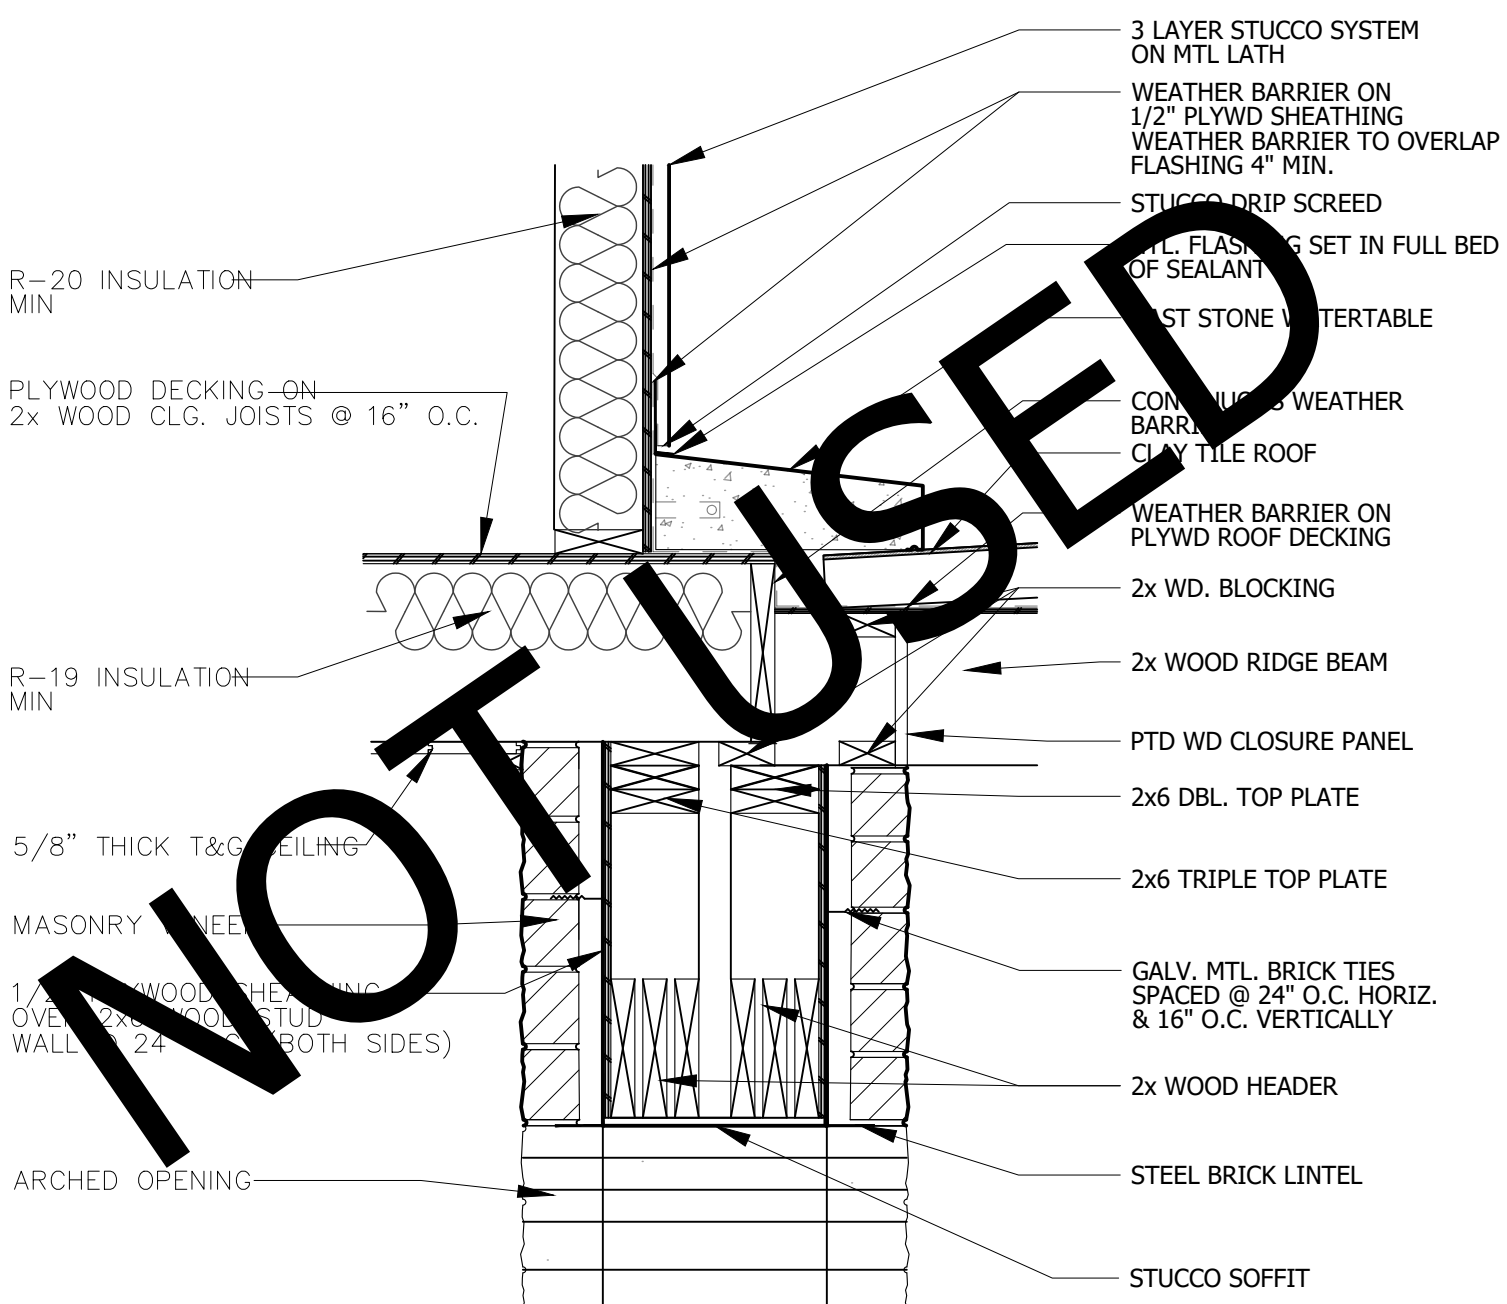

02 WATERTABLE DETAIL

SCALE: 1" = 1'-0"

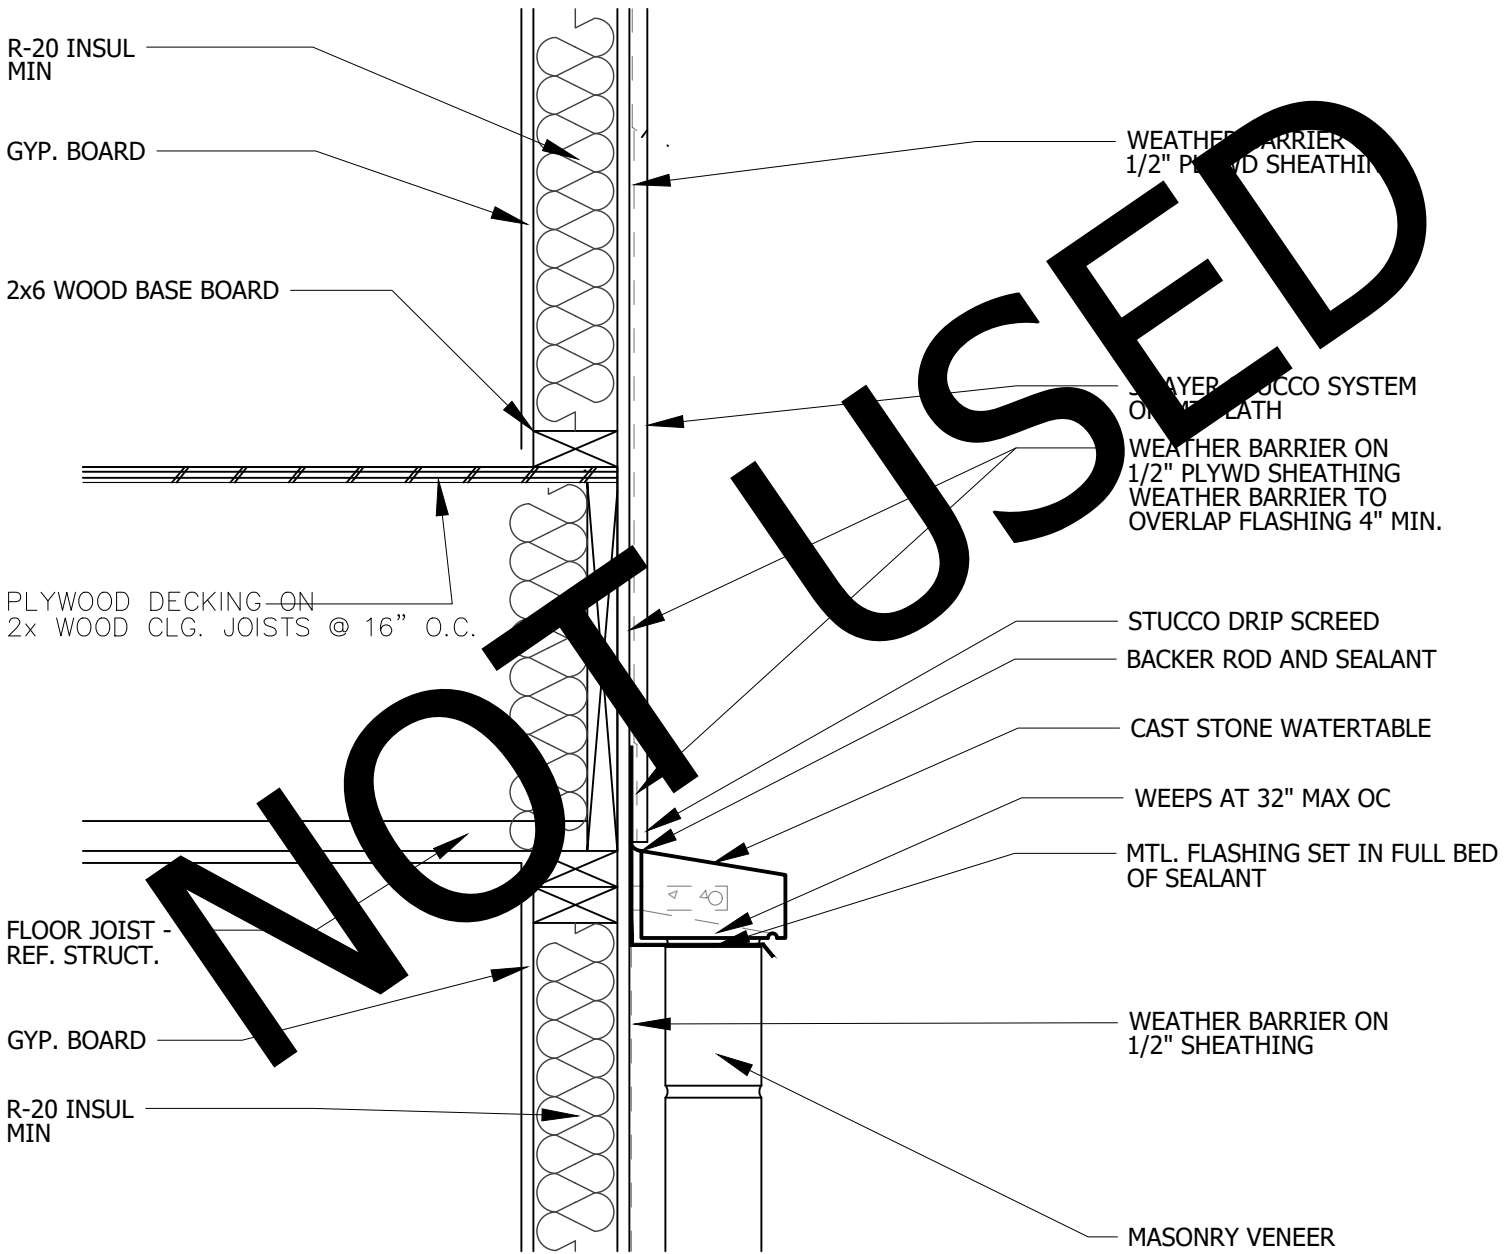

01 STONE/ STUCCO TRANSITION DETAIL

SCALE: 1 1/2" = 1'-0"

REFER TO **ENTRADA DESIGN GUIDELINES** FOR FUTHER DETAILED INFORMATION REGARDING THESE PLANS


ISSUE LOG

NO.	DESCRIPTION	DATE



PROJECT NO:	20-129
ISSUED FOR:	OTP
DRAWN BY:	WLL
DATE:	11/29/21

STANDARD DETAILS


A502

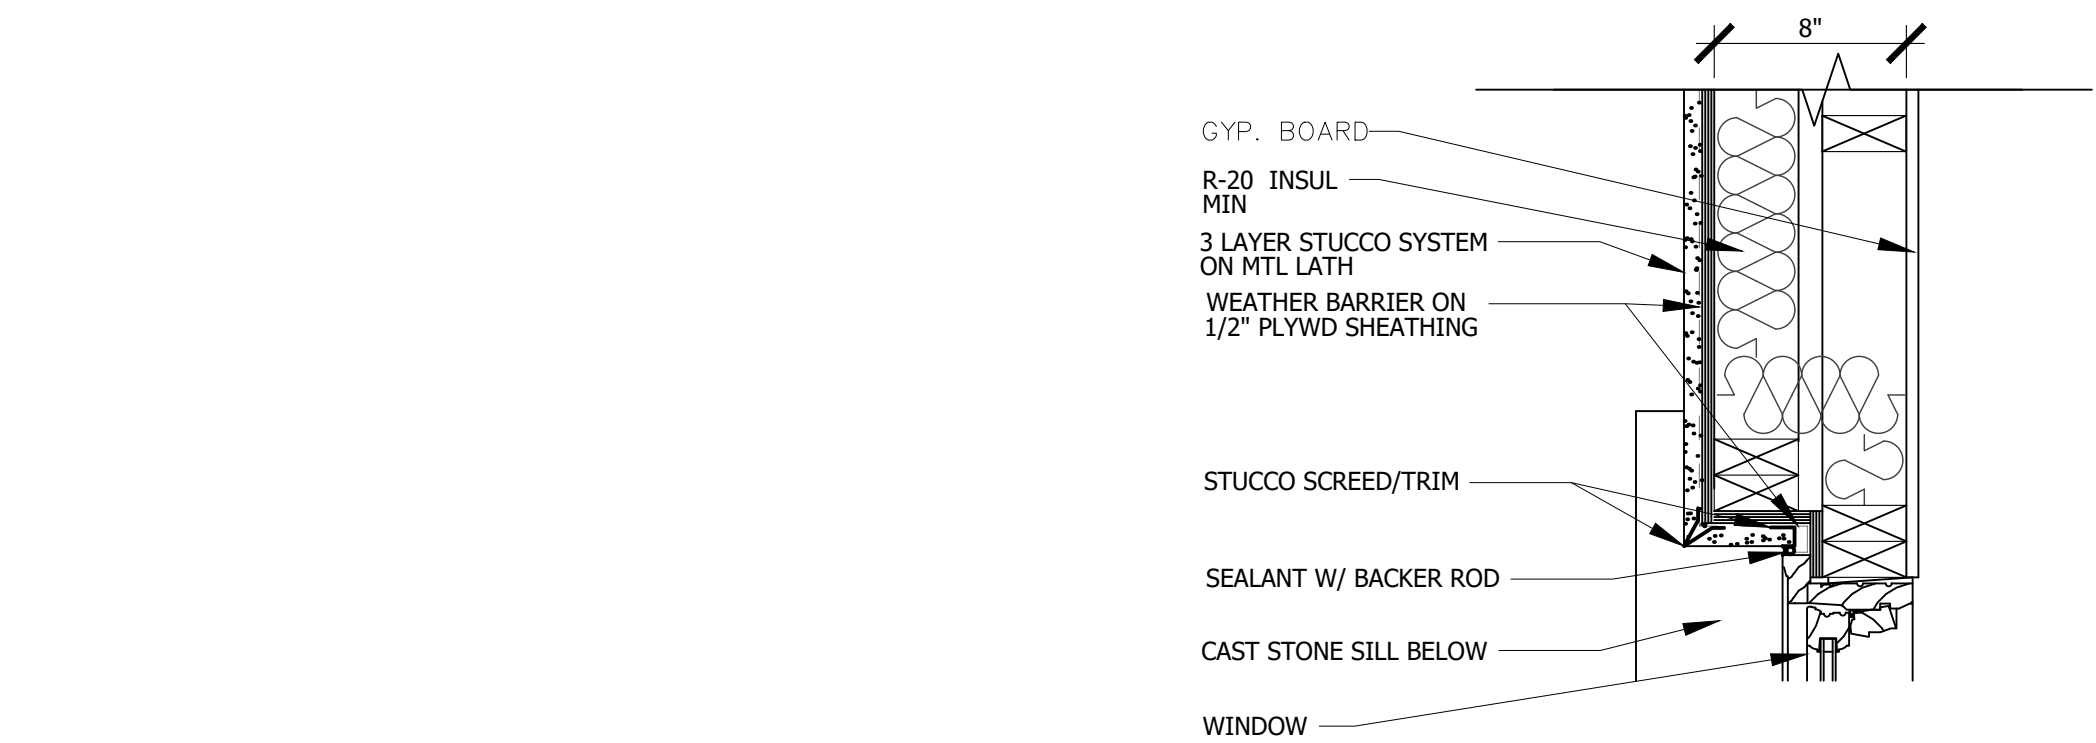


10 WINDOW JAMB
SCALE: 1 1/2" = 1'-0"

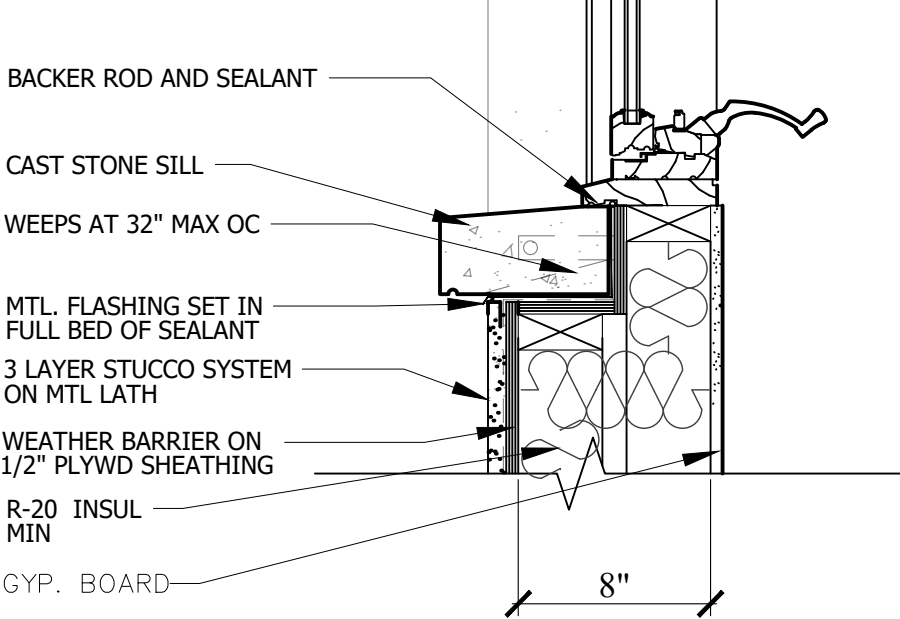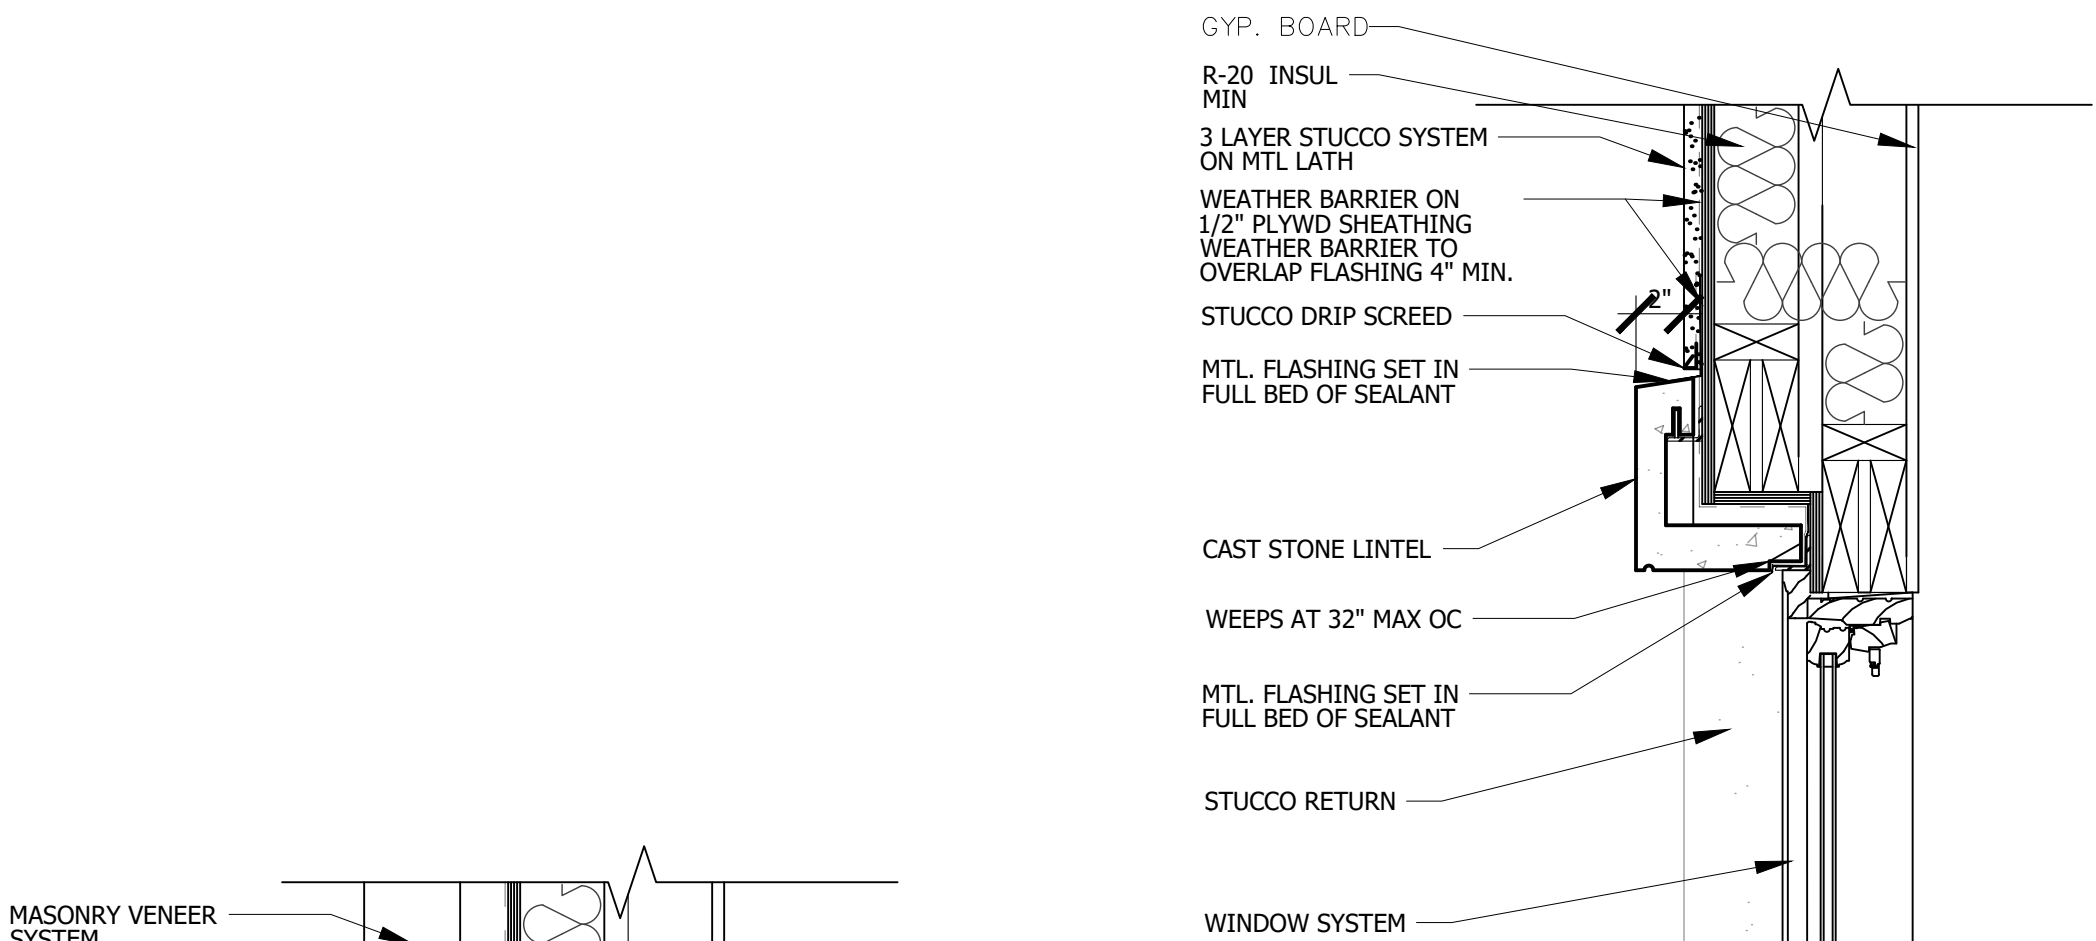


09 WINDOW SECTION
SCALE: 1 1/2" = 1'-0"

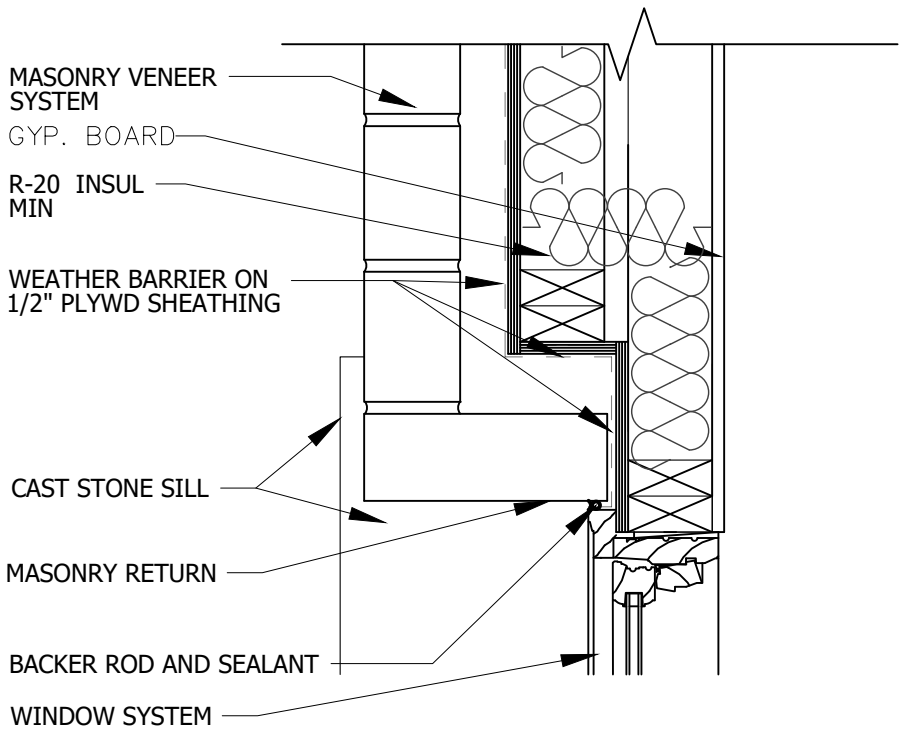


12 WINDOW JAMB
SCALE: 1 1/2" = 1'-0"

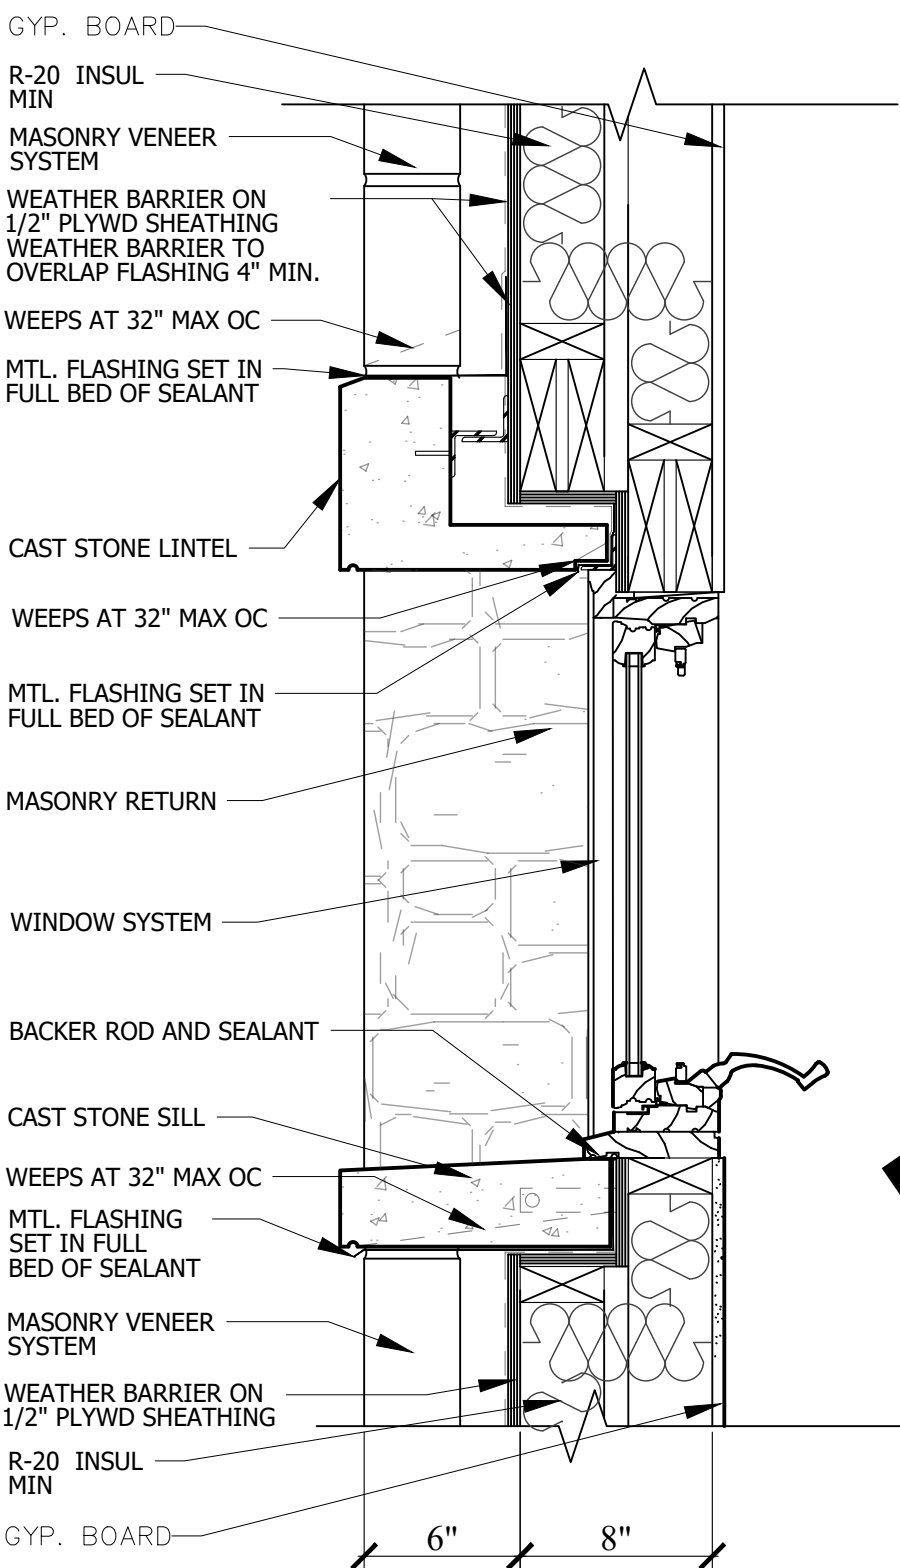


11 WINDOW SECTION
SCALE: 1 1/2" = 1'-0"

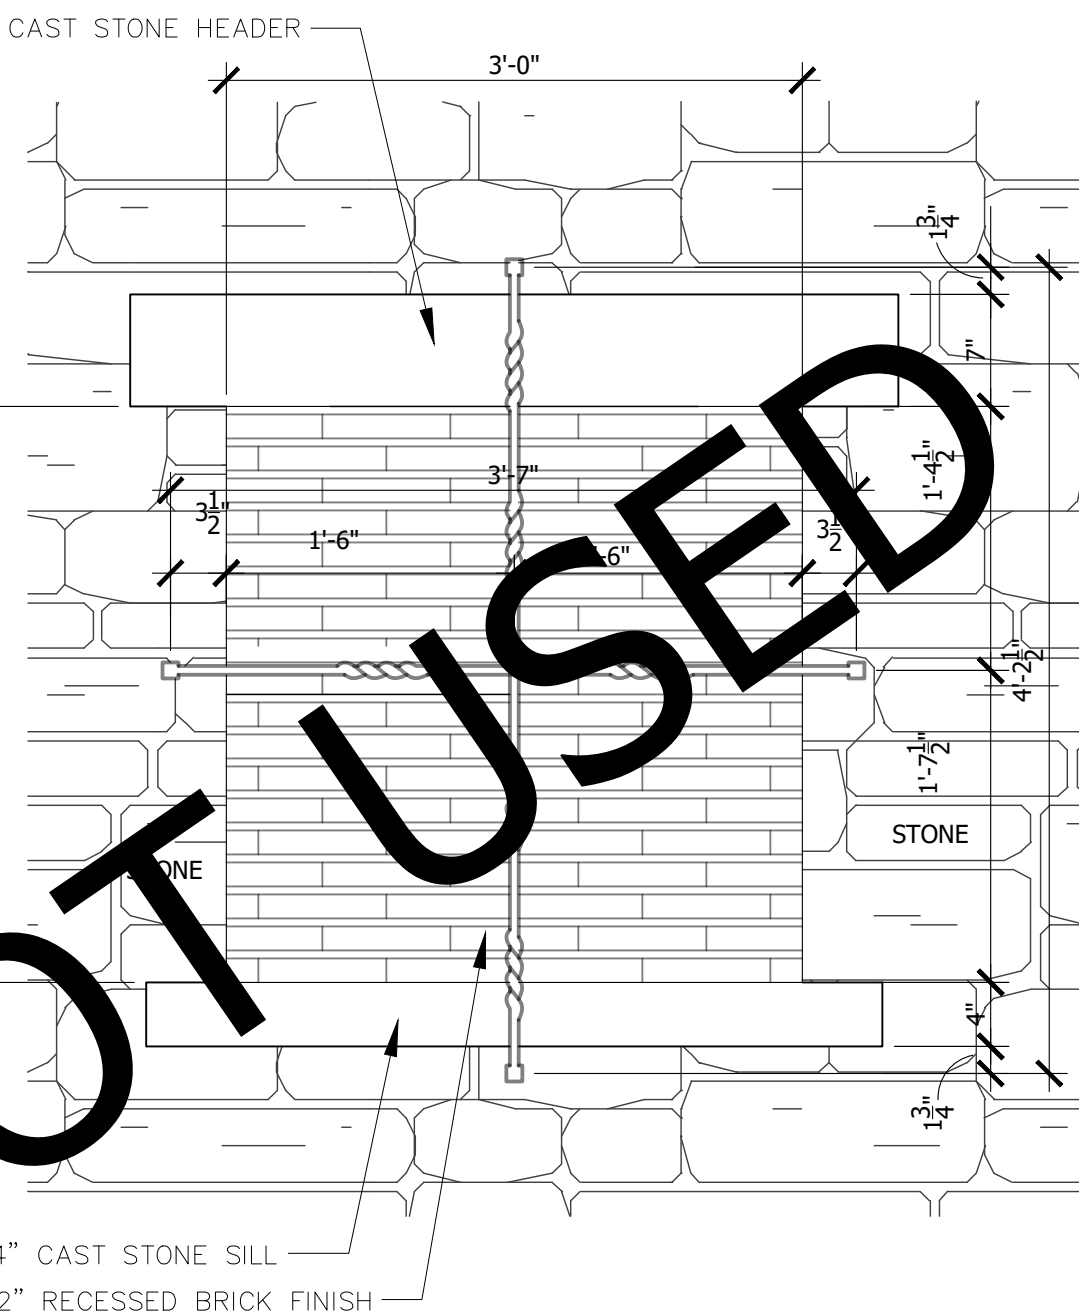


08 INSET BRICK DETAIL
W/ DECORATIVE WROUGHT IRON
SCALE: 1" = 1'-0"

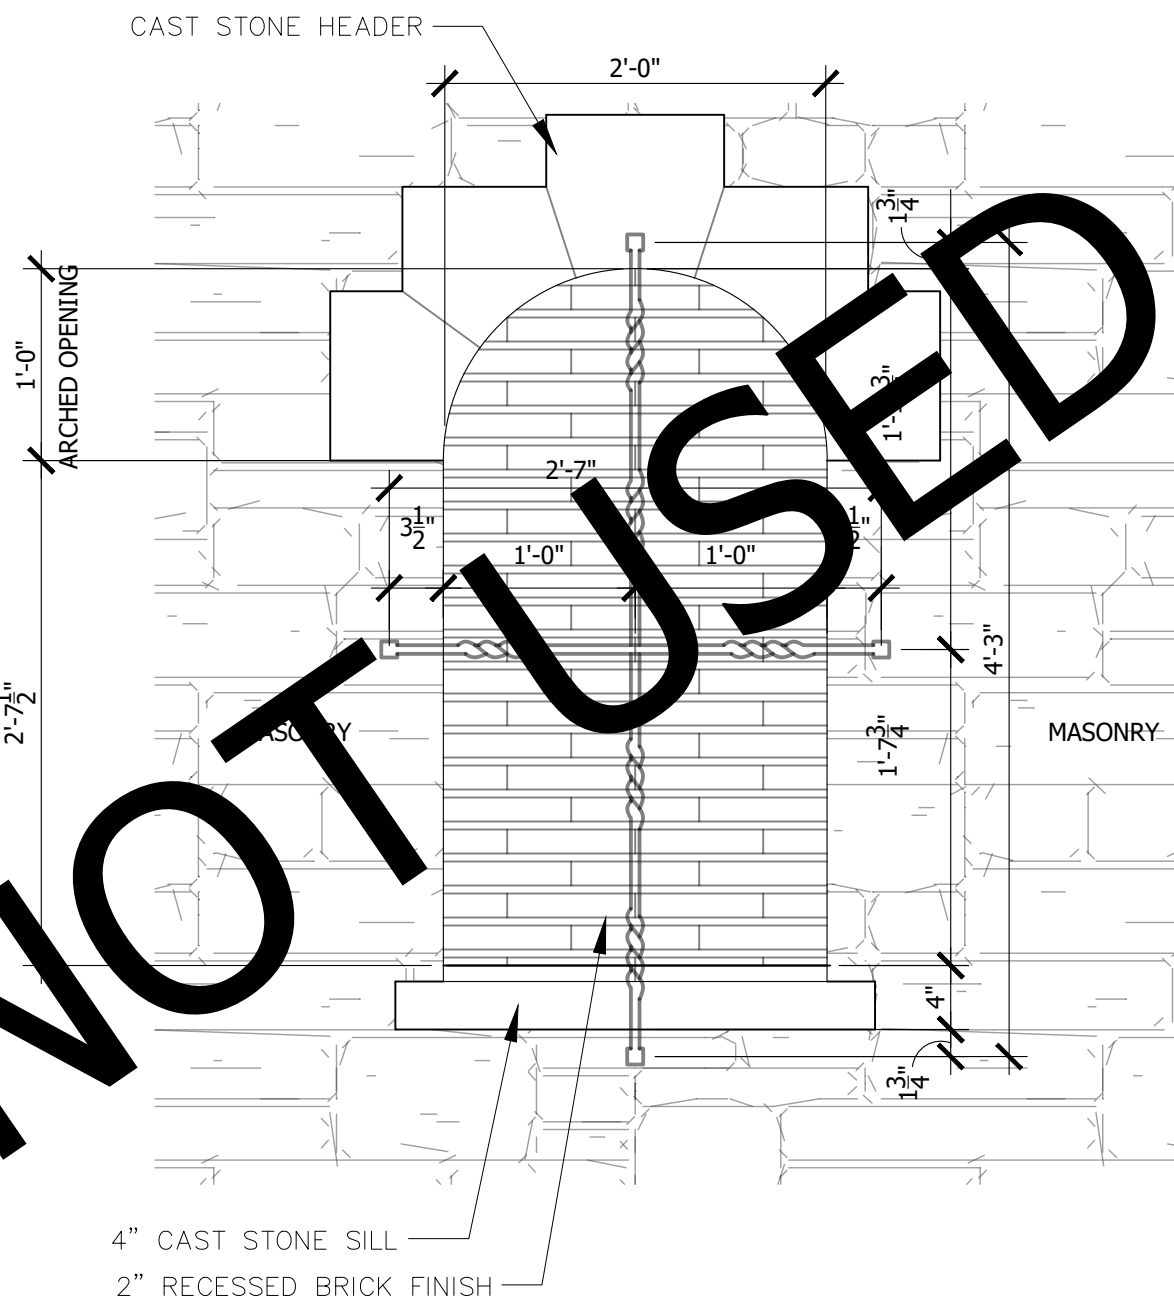


07 INSET BRICK DETAIL
W/ DECORATIVE WROUGHT IRON
SCALE: 1" = 1'-0"

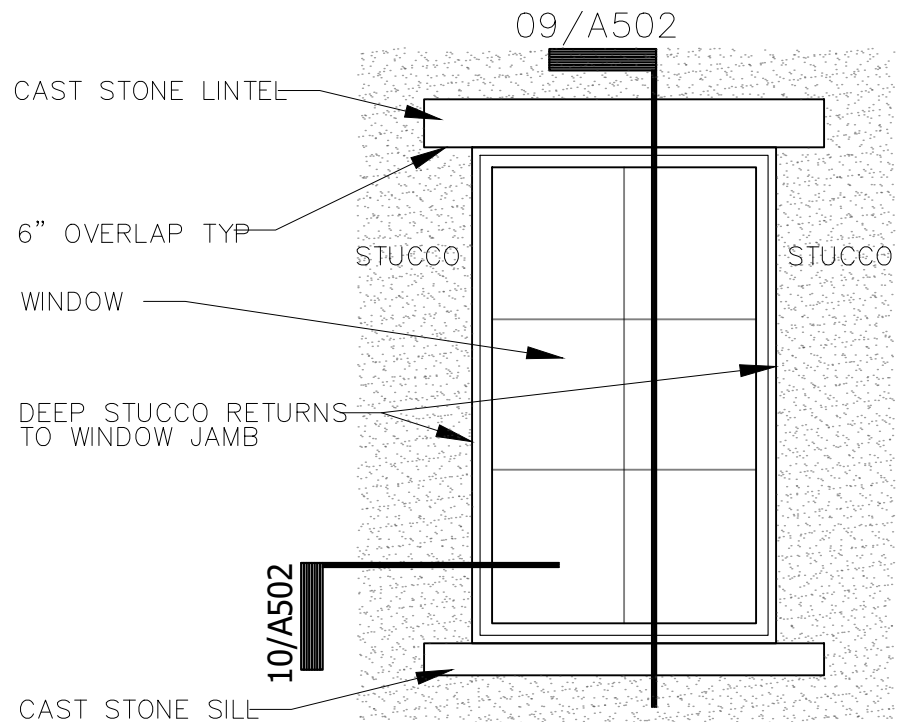


06 CAST STONE LINTEL SILL
SCALE: 1/2" = 1'-0"

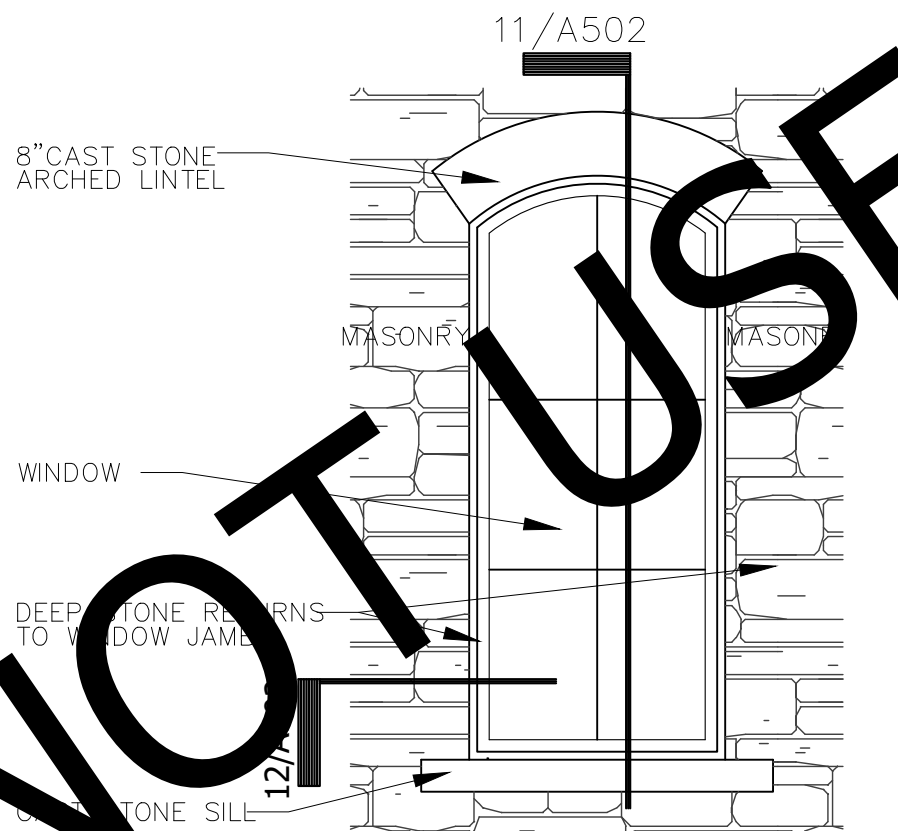


05 CAST STONE LINTEL/SILL
SCALE: 1/2" = 1'-0"

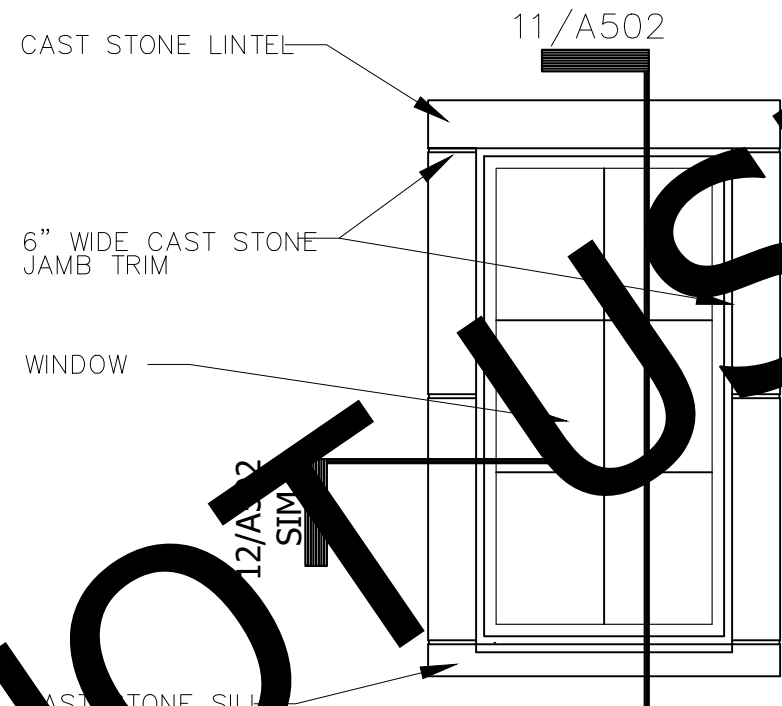


03 CAST STONE
SURROUND DETAIL
SCALE: 1/2" = 1'-0"

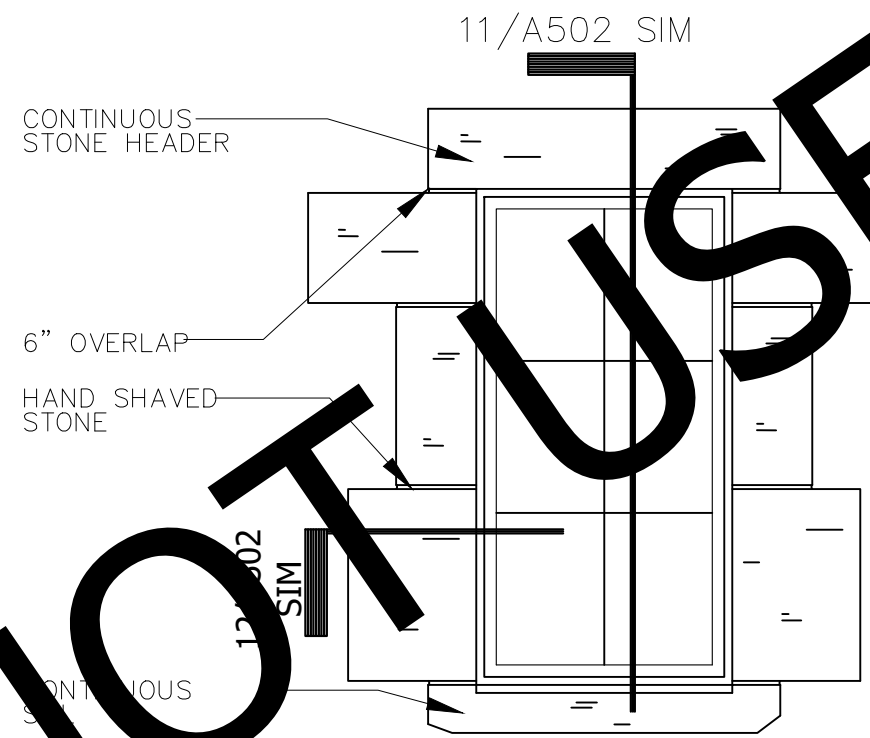

05 NATURAL STONE
SURROUND DETAIL
SCALE: 1/2" = 1'-0"

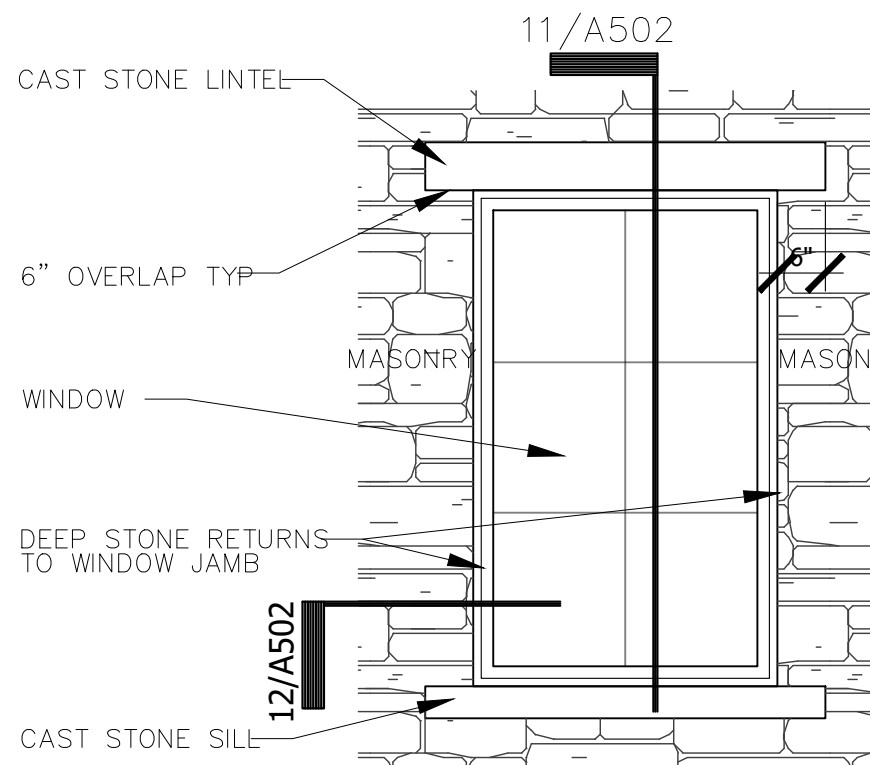

02 CAST STONE LINTEL/SILL
SCALE: 1/2" = 1'-0"

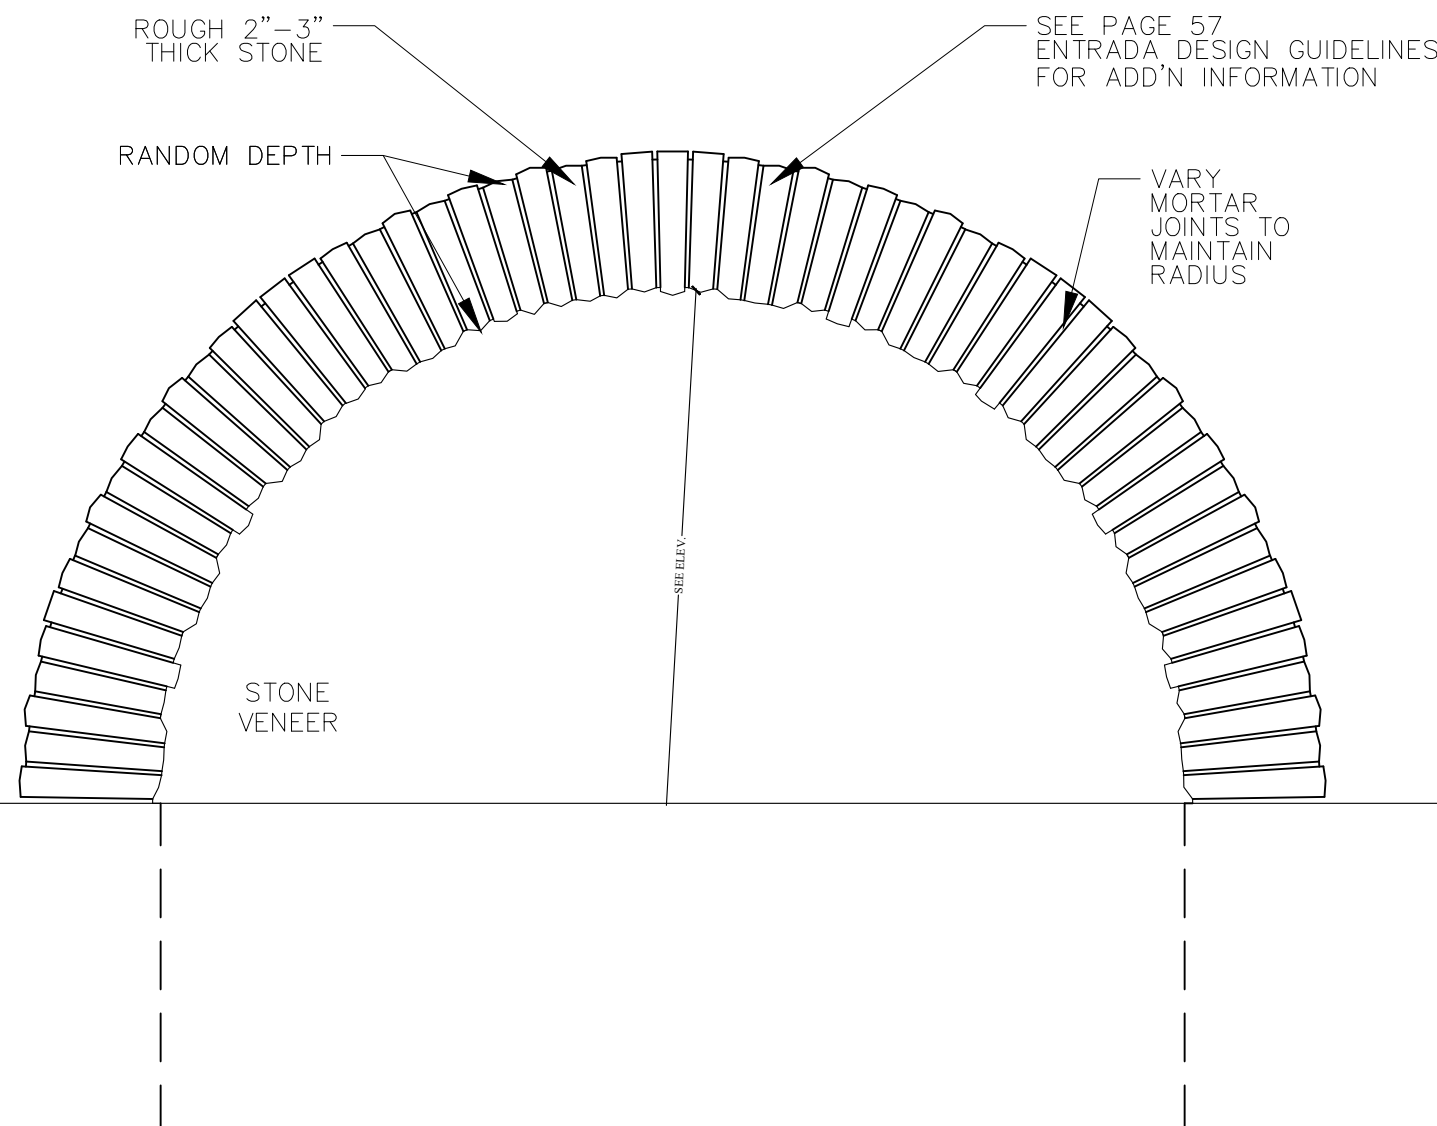

01 ROUGH ARCH DETAIL
SCALE: 1/2" = 1'-0"

REFER TO **ENTRADA DESIGN GUIDELINES** FOR FUTHER DETAILED INFORMATION REGARDING THESE PLANS

ENTRADA







ISSUE LOG

[illegible]

PROJECT NO:	20-129
ISSUED FOR:	OTP
DRAWN BY:	WLL
DATE:	11/29/2

MISC DETAILS

  A503

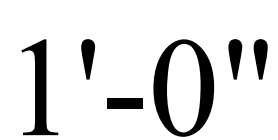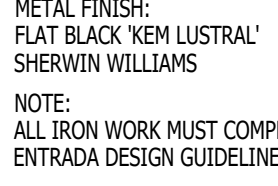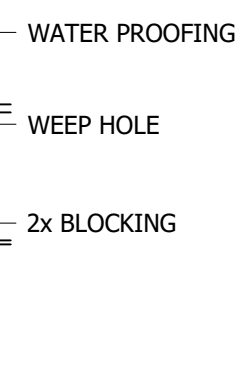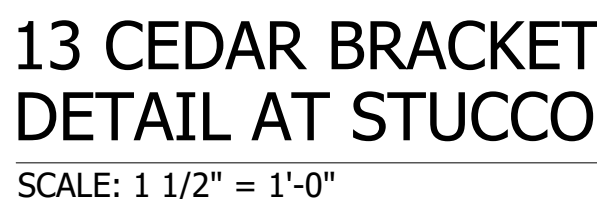

ENTRADA
LOT 1, 2, & 3 - BLOCK H
TOWN OF WESTLAKE TARRANT COUNTY, TEXAS


ISSUE LOG

NO.	DESCRIPTION	DATE

PROJECT NO:	20-129
ISSUED FOR:	OTP
DRAWN BY:	WLL
DATE:	11/29/21


DOOR ELEVATIONS

A504

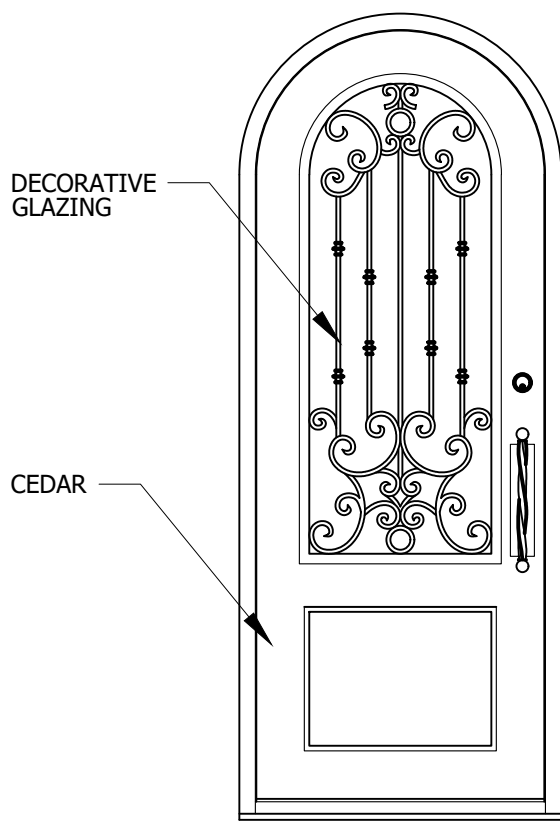


04 FRONT DOOR:

SCALE: 1/2" = 1'-0" ENTRADA DOORS PART: FR WOOD #14

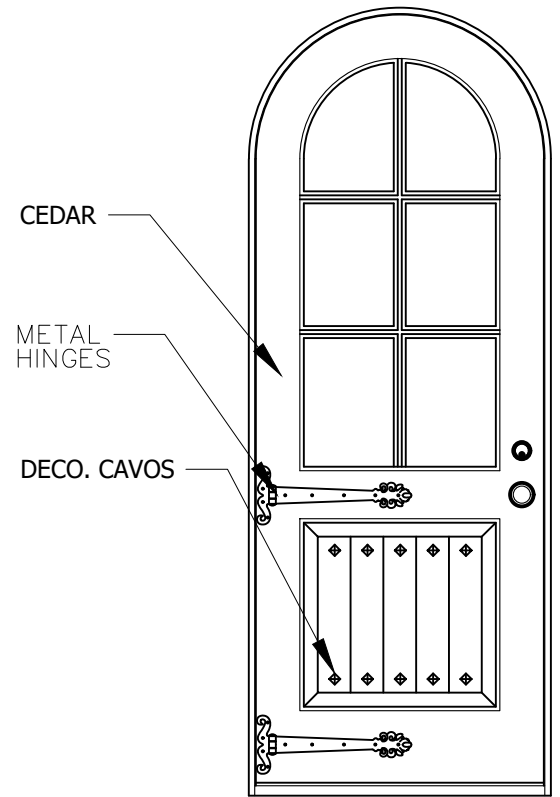


03 FRONT DOOR:

SCALE: 1/2" = 1'-0" ENTRADA DOORS PART: FR WOOD #16

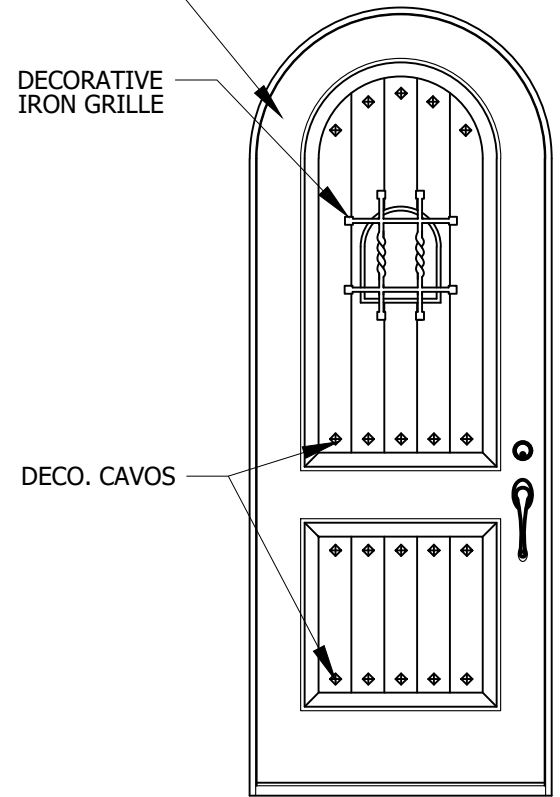


02 FRONT DOOR:

SCALE: 1/2" = 1'-0" ENTRADA DOORS PART: FR WOOD #15

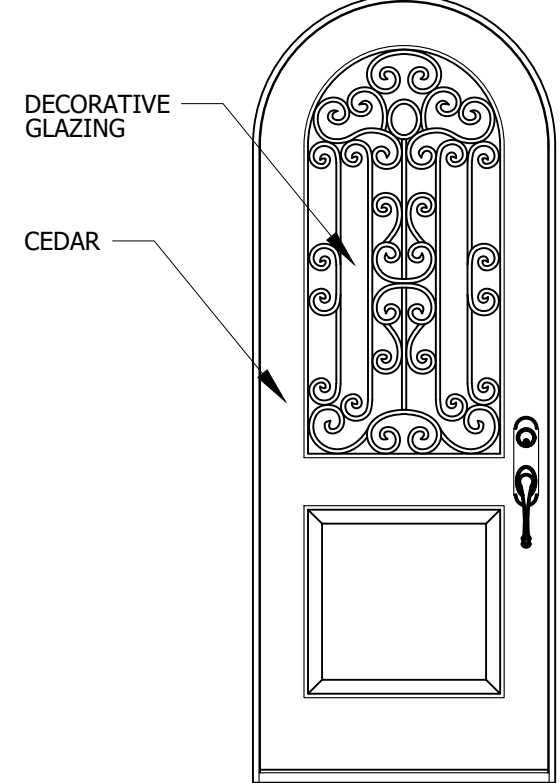


01 FRONT DOOR:

SCALE: 1/2" = 1'-0" ENTRADA DOORS PART: FR WOOD #17

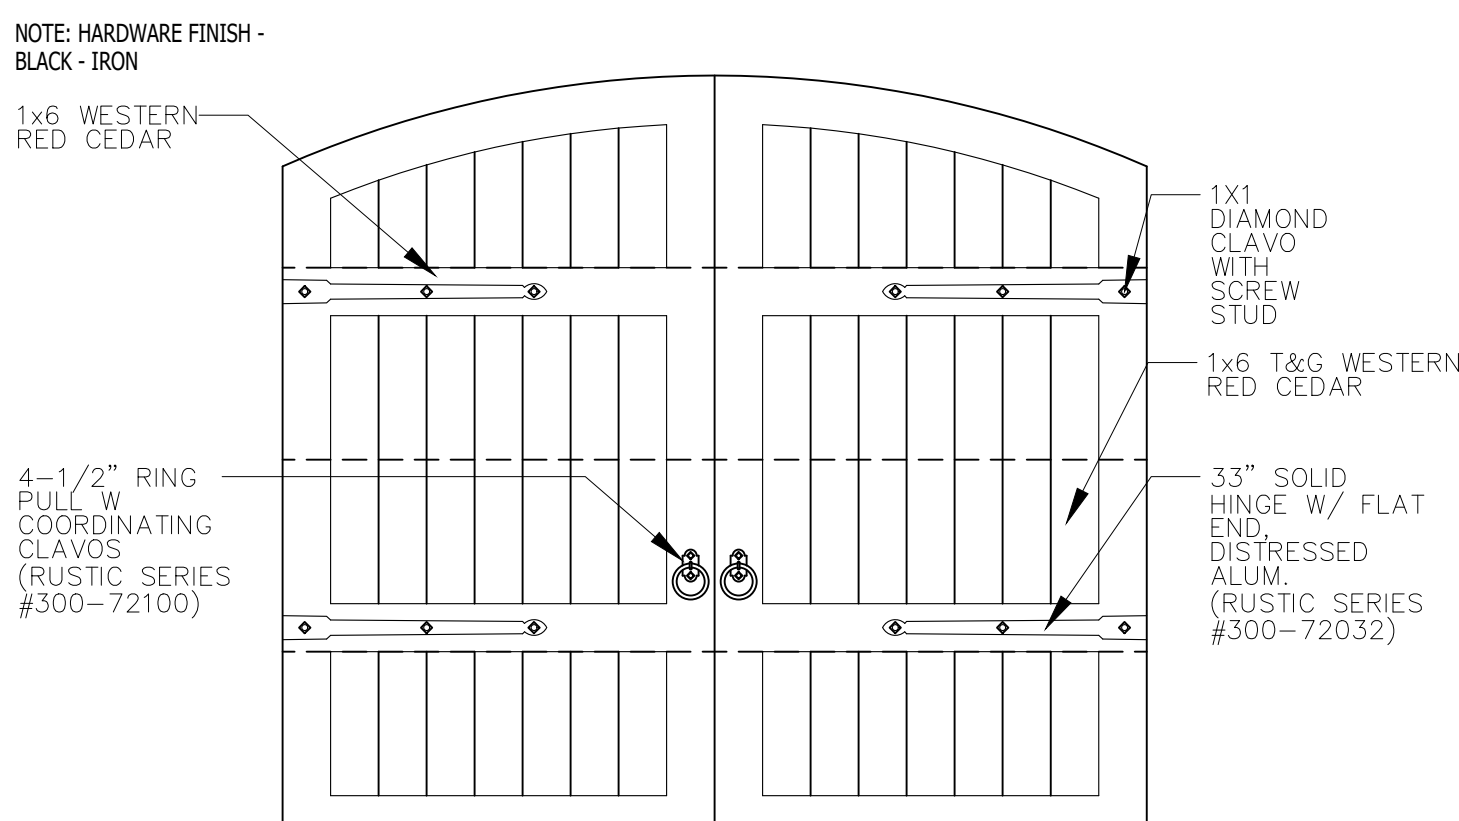


08 GARAGE DOOR:

SCALE: 1/2" = 1'-0" NOTES: GARAGE DOOR THICKNESS 2 3/8" INSET PANEL DEPTH 3/4"

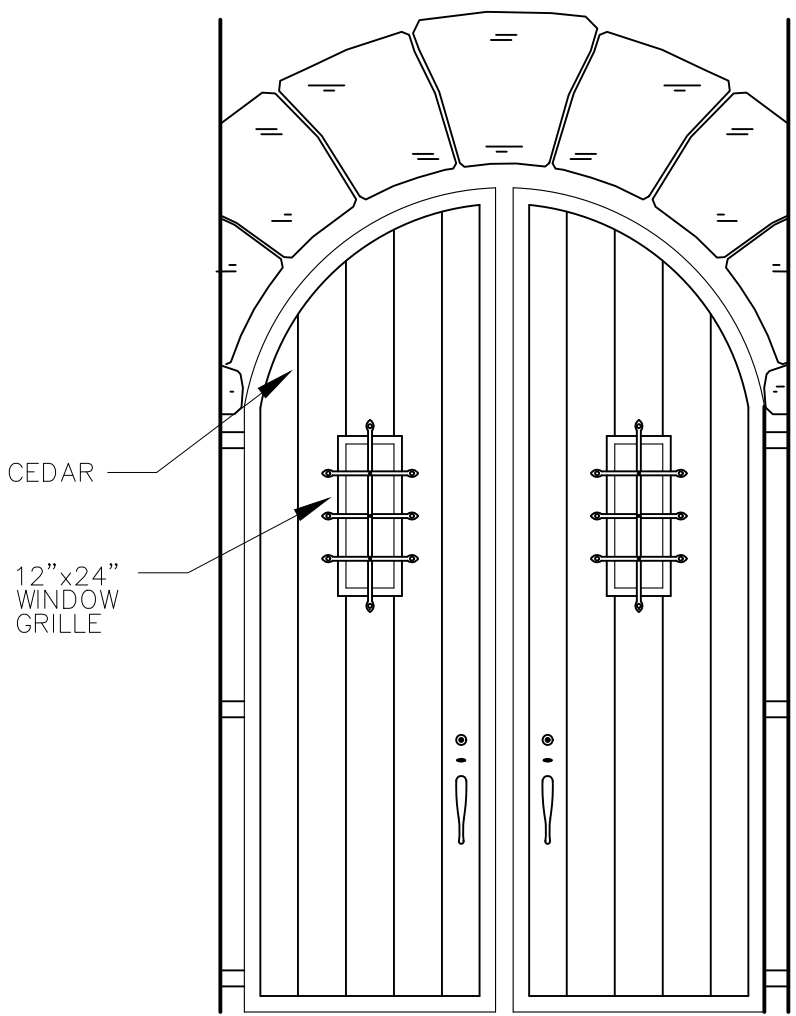


07 PAIR OF WOODEN GATES

SCALE: 1/2" = 1'-0"

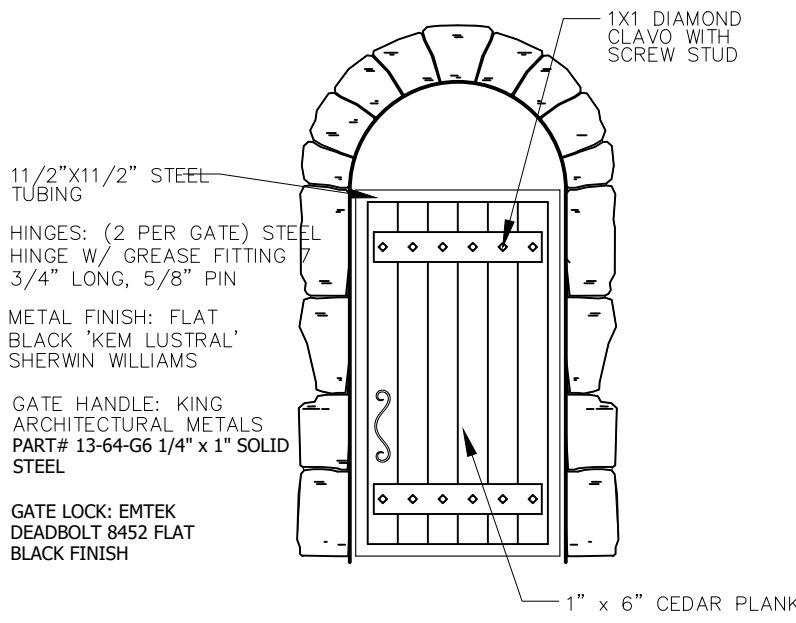


06 CEDAR GATE DETAIL

SCALE: 1/2" = 1'-0"

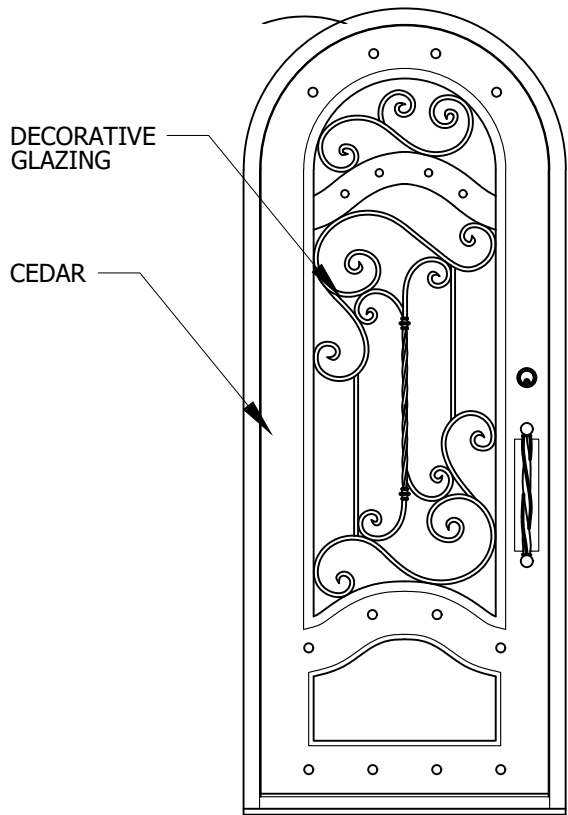


05 FRONT DOOR:

SCALE: 1/2" = 1'-0" ENTRADA DOORS PART: CUST MTL #18

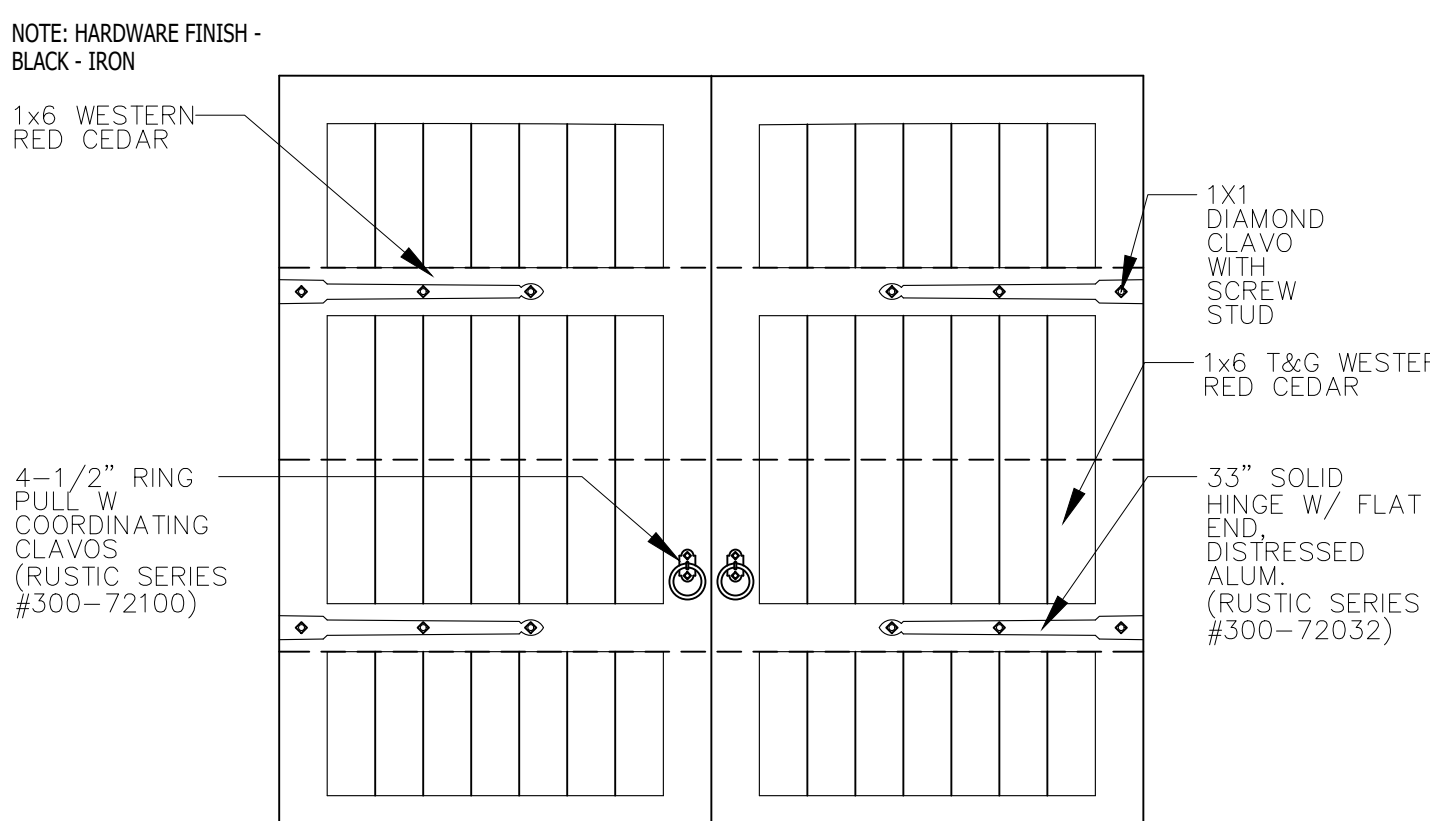


12 GARAGE DOOR:

SCALE: 1/2" = 1'-0" NOTES: GARAGE DOOR THICKNESS 2 3/8" INSET PANEL DEPTH 3/4"

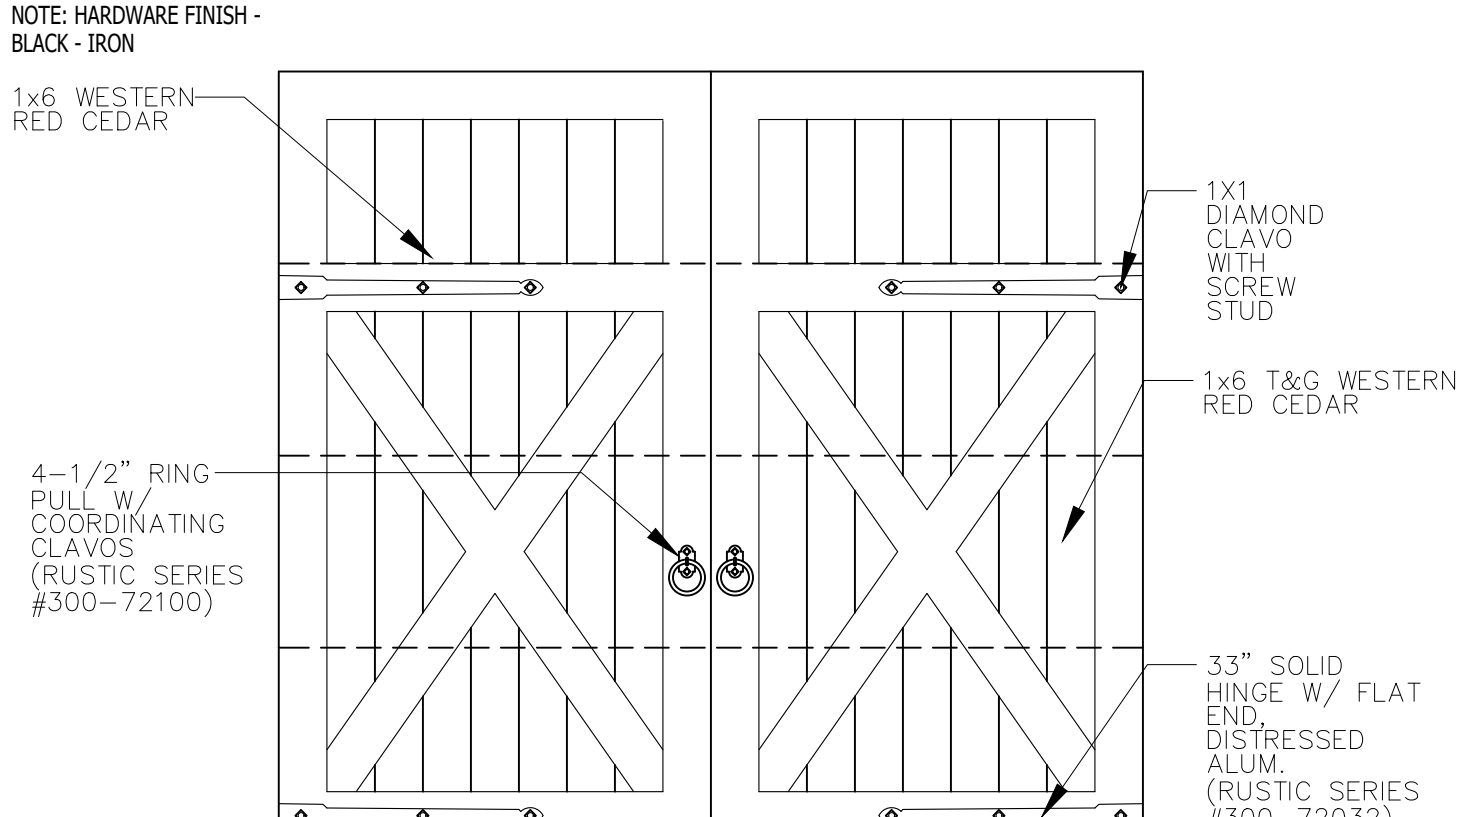


11 GARAGE DOOR:

SCALE: 1/2" = 1'-0" NOTES: GARAGE DOOR THICKNESS 2 3/8" INSET PANEL DEPTH 3/4"

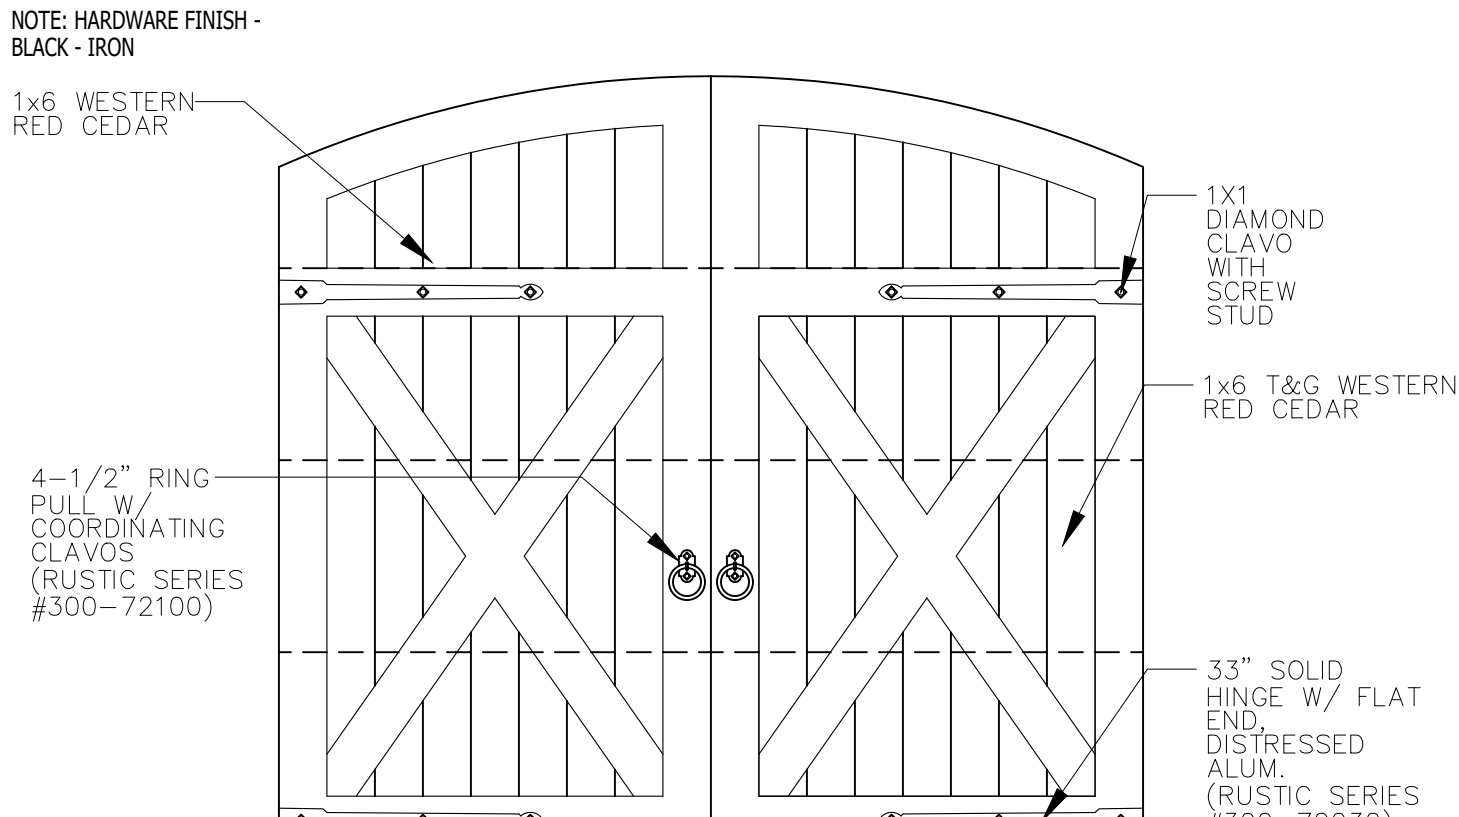


10 GARAGE DOOR:

SCALE: 1/2" = 1'-0" NOTES: GARAGE DOOR THICKNESS 2 3/8" INSET PANEL DEPTH 3/4"

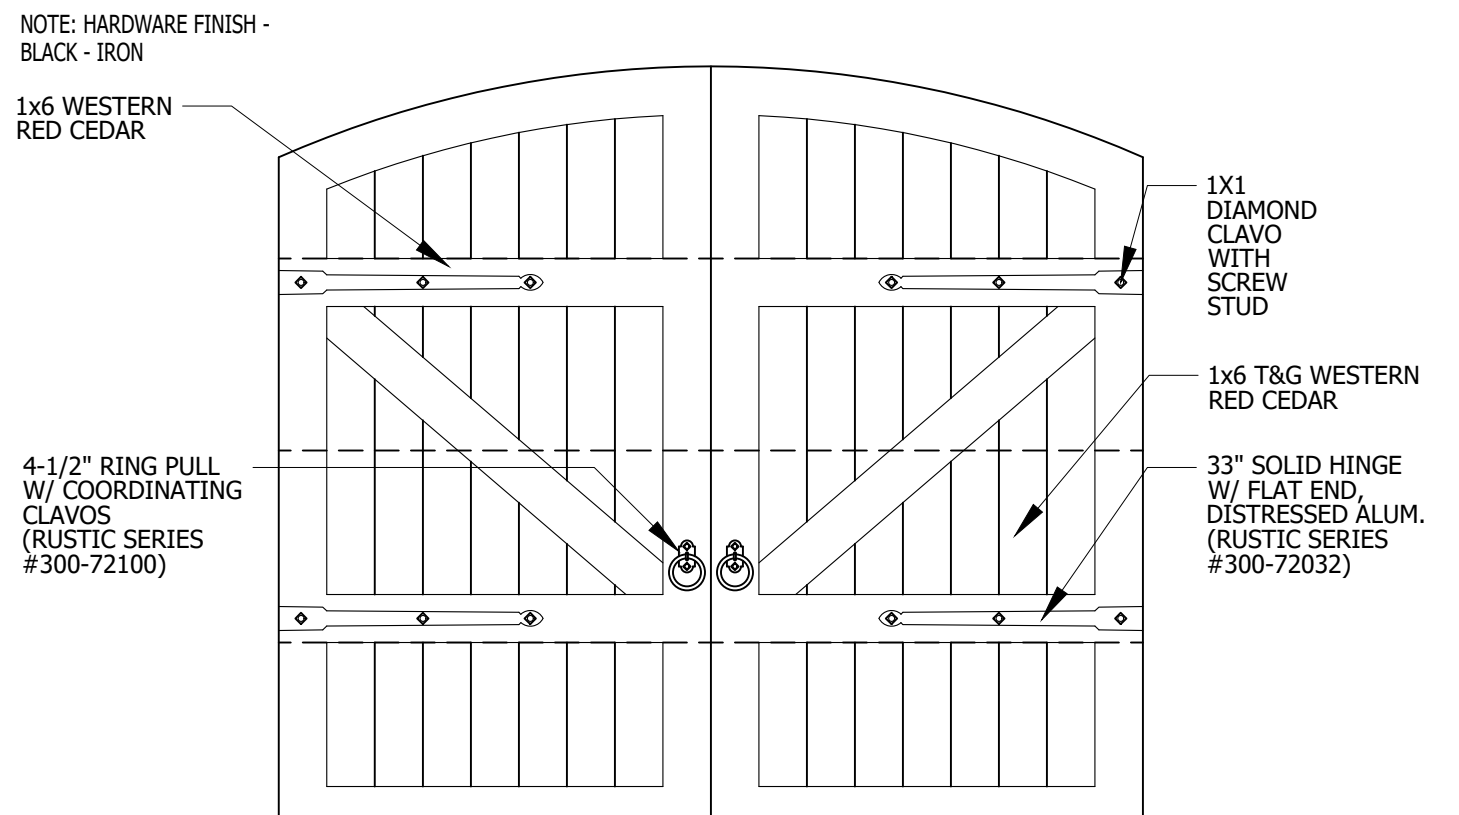

09 GARAGE DOOR:

SCALE: 1/2" = 1'-0" NOTES: GARAGE DOOR THICKNESS 2 3/8" INSET PANEL DEPTH 3/4"

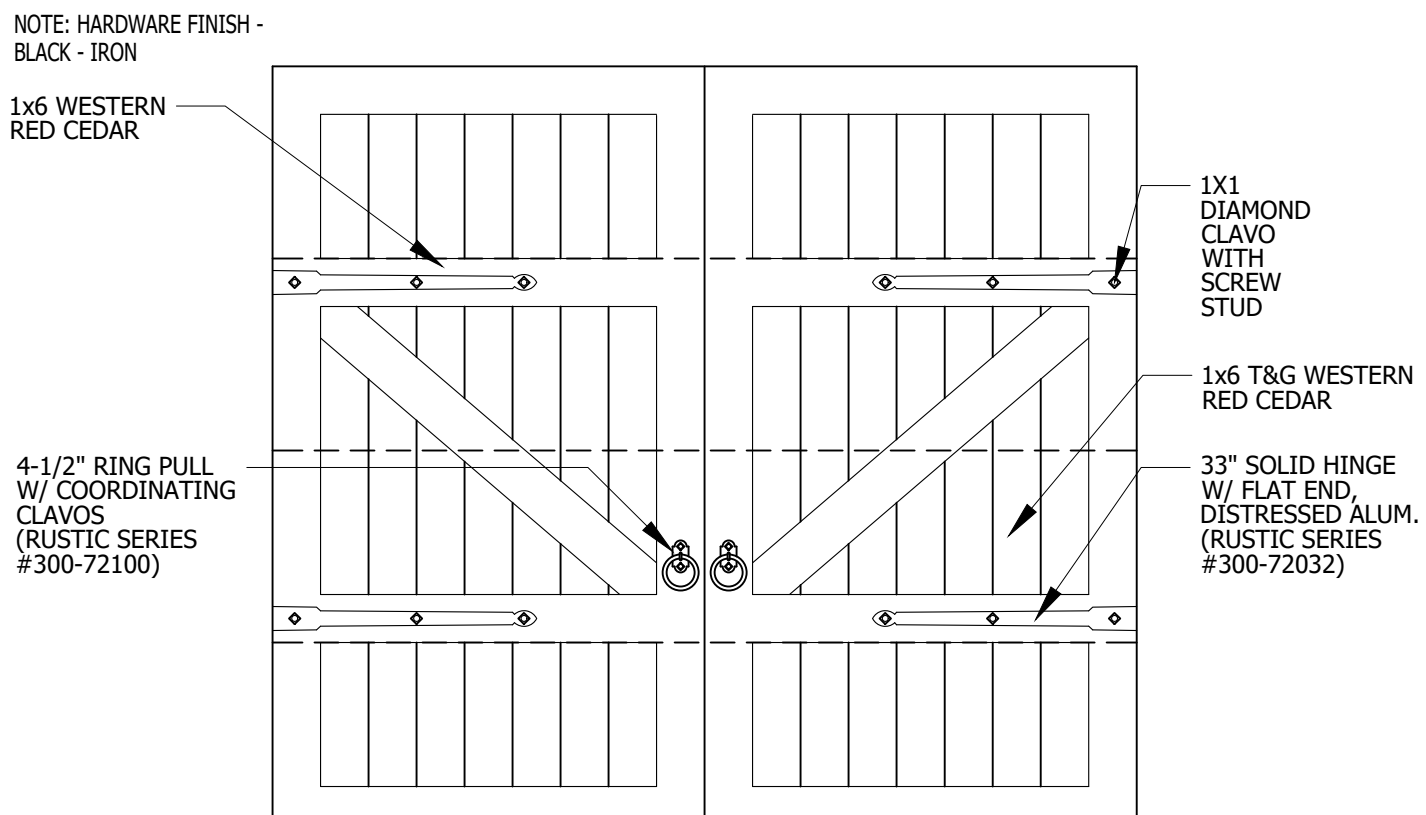

13 GARAGE DOOR:

SCALE: 1/2" = 1'-0" NOTES: GARAGE DOOR THICKNESS 2 3/8" INSET PANEL DEPTH 3/4"

REFER TO **ENTRADA DESIGN GUIDELINES** FOR FUTHER DETAILED INFORMATION REGARDING THESE PLANS



ENTRADA LOT 02, BLOCK H


PROJECT DIRECTORY:

OWNER
MRW INVESTORS
1800 VALLEY VIEW LANE STE. 300
FARMERS BRANCH, TX 75234
PHONE: (817) 239-6528
EMAIL: michael@centurionamerican.com
CONTACT: MICHAEL DEES

PROJECT ADDRESS
LOT 2, BLOCK H
WESTLAKE, TX 76262

ARCHITECT
BUSH ARCHITECTS
1800 VALLEY VIEW LANE STE. 400
FARMERS BRANCH, TX 75234
PHONE: (469) 857-3151
E-MAIL: ralph@busharchitects.design
CONTACT: RALPH BUSH

CIVIL ENGINEER
BGE INC.
2595 DALLAS PARKWAY
SUITE 204
FRISCO, TX 75034
PHONE: (972) 464-4800
CONTACT: JASON FREY
(TBPE F-1046)

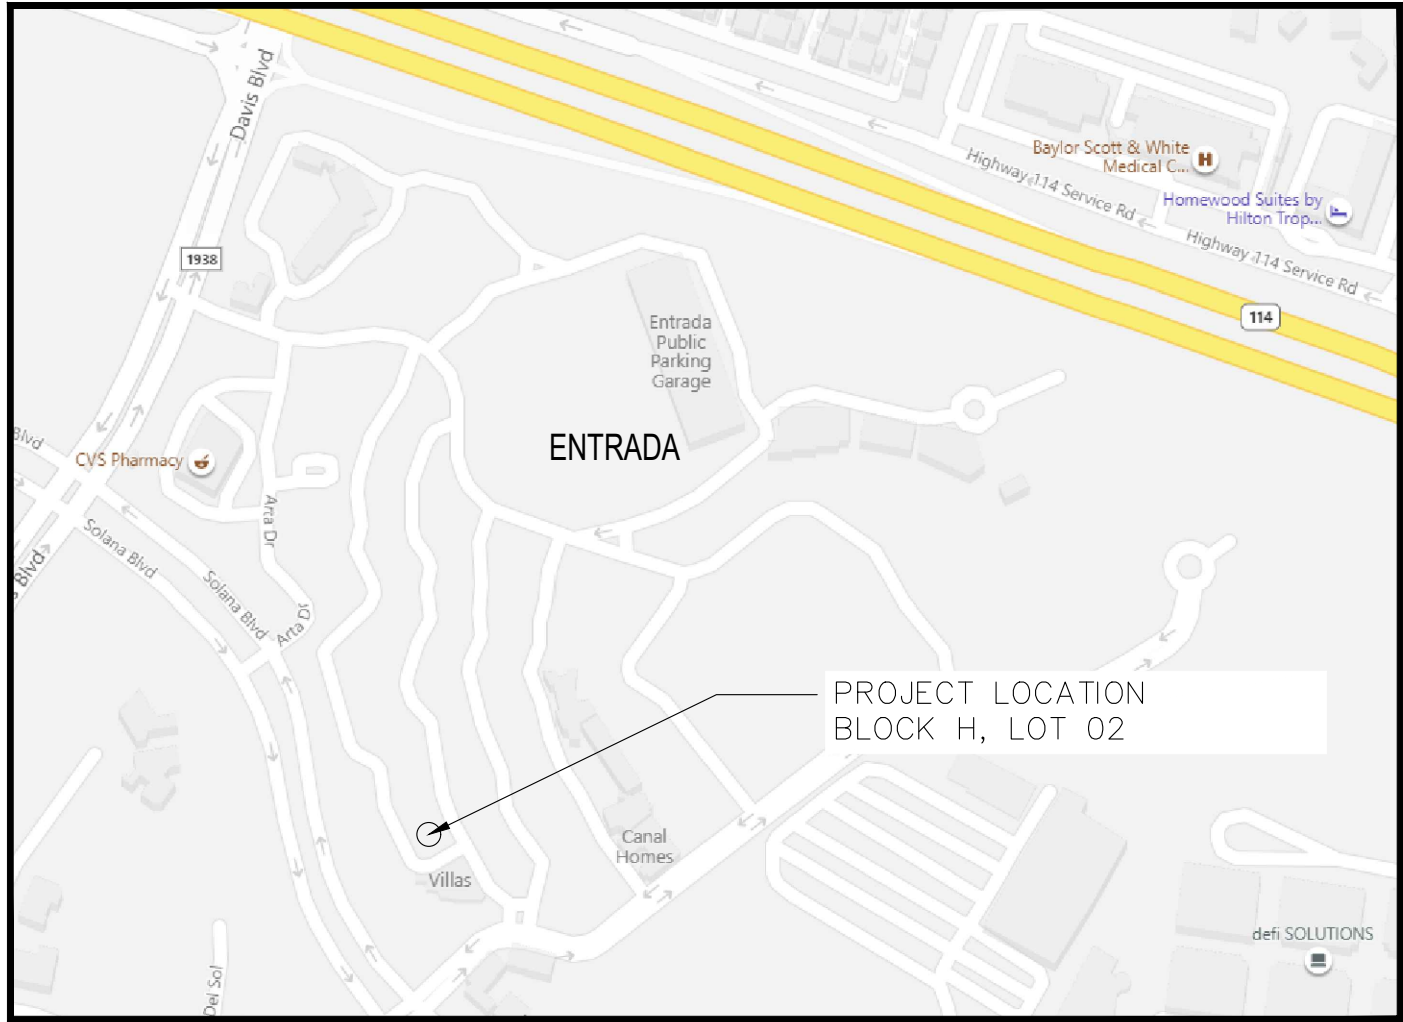

VICINITY MAP
N.T.S.

TOWN OF WESTLAKE
APPROVED:
TITLE:
DATE:

LEGAL DESCRIPTION

LOT 02, BLOCK H
WESTLAKE ENTRADA
TOWN OF WESTLAKE, TARRANT COUNTY, TX.

SHEET INDEX

SHEET INDEX	
CS	COVERSHEET
A001	GENERAL NOTES
A100	ARCHITECTURAL SITE PLAN
A101	FIRST FLOOR PLAN
A102	SECOND FLOOR PLAN
A103	DOOR & WINDOW SCHEDULE
A104	FIRST FLOOR ELECTRICAL PLAN
A105	SECOND FLOOR ELECTRICAL PLAN
A106	ROOF PLAN
A200	FRONT & LEFT ELEVATIONS
A201	REAR & RIGHT ELEVATIONS
A202	ELEVATIONS
A401	WALL SECTIONS
A402	WALL SECTIONS
A500	ROOF DETAILS
A501	STANDARD DETAILS
A502	STANDARD DETAILS
A503	MISC. DETAILS
A504	DOOR ELEVATIONS
A505	DETAILS

ISSUE LOG








NO.	DESCRIPTION	DATE

PROJECT NO: 20-130
ISSUED FOR: OTP
DRAWN BY: Checker
DATE: 06/16/21

COVERSHEET

CS

       SECTION HATCHES & SYMBOLS

	SAND OR GROUT
	EARTH OR NATURAL GROUND
	POROUS FILL (GRAVEL)
	STONE
	CONCRETE
	BRICK (PLAN & SECTION)
	MASONRY
	STEEL
	NON-FERROUS ALUMINUM
	PLYWOOD
	WOOD (FINISH)
	CONTINUOUS NOMINAL LUMBER
	DISCONTINUOUS NOMINAL LUMBER & WOOD BLOCKING (INTERRUPTED MEMBER)
	INSULATION (LOOSE OR BATT)
	RIGID INSULATION
	GLAZING (LARGE SCALE)
	GYPSUM WALL BOARD
	PLASTER WITH LATH
	ACOUSTICAL TILE
	CARPET

ELEVATION HATCHES & SYMBOLS

	STONE
	STONE VENEER
	WOOD (FINISHED)
	GLASS
	BRICK
	STONE
	STUCCO
	CLAY TILE ROOF

CONSTRUCTION SYMBOLS

0	COLUMN GRID
	PARTITION TAG
	ELEVATION DATUM POINT
NAME NUMBER	ROOM TAG
Unit Type	UNIT TAG
	DOOR TAG
	ALIGN WITH ESTABLISHED SURFACES
	SHEET KEYNOTE
	WINDOW MARK
	REVISION REFERENCE
	SECTION IDENTIFIER
	PLAN DETAIL IDENTIFIER
	FIRE EXTINGUISHER WITHOUT CABINET
	FIRE EXTINGUISHER CABINET ON WALL
¢	CENTERLINE
	EXTERIOR ELEVATION
	INTERIOR ELEVATION
	GLAZING ELEVATION
	FINISH TAG
	KEYNOTE TAG
	KEYNOTE TAG
	ELEVATION LEVEL
# / SHEET	DETAIL REFERENCE
	WALL TAG
	WINDOW TAG
05/AS00	SECTION DETAIL IDENTIFIER

CONDITION(ING)	DF DRINKING FOUNTAIN	G	MECH MECHANICAL	REFL REFLECTED	VIF VERIFY IN FIELD
ACCESS ACCESSORY	DIA DIAMETER	GA GAUGE	MTL METAL	REFR REFRIGERATOR	W
ACOUS ACOUSTIC(AL)	DIFF DIFFUSER	GO GRAD(E)(ING)	MEM MEMBRANE	REQD REQUIRED	W/ WITH
AFF ABOVE FINISHED FLOOR	DIM DIMENSION	GRFC GLASS FIBER REINF. CONCRETE	MEZZ MEZZANINE	RESIS RESIST(ANT)(IVE)	WD WATER CLOSET
AL ALUMINUM	DISP DISPENSER	GRFG GLASS FIBER REINF. GYPSUM	MIN MINIMUM	REINF REINFORCE(D)(ING)(MENT)	WD WOOD
ALT ALTERNATE	DIV DIVISION	GRFP GLASS FIBER REINF. PLASTER	MISC MISCELLANEOUS	RESIL RESILIENT	WDW WINDOW
ANNUN ANNUNCIATOR	DN DOWN	GL GLASS	MLWK MILLWORK	RFM ROOFING	W/O WITHOUT
ANOD ANODIZED	\$ DOLLAR (US CURRENCY)	GR GRAD(E)(ING)	MOIST MOISTURE	RM ROOM	WT WEIGHT
APPL APPLIANCE	DR DOOR	GYP GYPSUM	MOT MOTOR(IZED)	RO ROUGH OPENING	WTRPF WATERPROOFING
ARCH ARCHITECT(URAL)	DSCON DISCONNECT	H	MTD MOUNTED	S	
AUTO AUTOMATIC	DWR DRAWER	HD HEAD		SCR SCRIBE	
AVG AVERAGE	E	HDWD HARDWOOD	NIC NOT IN CONTRACT	SECU SECURITY	
& AND	EJ EXPANSION JOINT	HDWR HARDWARE	NO (#) NUMBER	SF SQUARE FEET	
B	ELAST ELASTOMERIC	HM HOLLOW METAL	NTS NOT TO SCALE	SGL SINGLE	
BLDG BUILDING	ELEC ELECTRICAL	HORIZ HORIZONTAL	O	SHORG SHORING	
BOLD BOLLARD	EMBED EMBEDD(ED)(ING)	HVAC HEATING, VENTILATION, & AIR CONDITIONING	OH OPPOSITE HAND	SIM SIMILAR	
BOA BOARD	ENGR ENGINEER(ED)	I	ORN ORNAMENTAL	SS STAINLESS STEEL	
BLKG BLOCKING	ENTR ENTRANCE	INFO INFORMATION	OVFL OVERFLOW	STD STANDARD	
BRDLM BROADLOOM	EQU EQUAL	INSF INFORMATION	OVHD OVERHEAD	STL STEEL	
BU BUILT UP	EQUI EQUIPMENT	INTR INSTRUMENT(ATION)	OPNG OPENING(S)	STRFR STOREFRONT	
C	EXIST EXISTING	INSUL INSULATION	OPR OPERABLE	STRUCT STRUCTURAL	
CAB CABINET	EXP JT EXPANSION JOINT	INTLK INTERLOCK(ING)	P	SURF SURFACE	
CPT CARPET	EXPS EXPOSE(D)	INT INTERIOR	PTN PARTITION	SUSP SUSPENDED	
CEM CEMENT(ITIOUS)	EXT EXTERIOR	INFILTR INFILTRATION	PED PEDESTRIAN	SYS SYSTEM(S)	
CER CERAMIC	F	J	PBD PARTICLE BOARD	T	
CLG CEILING	FAB FABRICATION	JAN JANITOR	PAL PANEL	THK THICK	
COATG COATING	FLD FLOOR DRAIN	JT JOINT	POLYST POLYSTYRENE	TLT RESTROOM	
COILG COILING	FE FIRE EXTINGUISHER	K	PORT PORTABLE	TRAF TRAFFIC	
CONC CONCRETE	FEC FIRE EXTINGUISHER CABINET	KIT KITCHEN	PREFIN PREFINISHED	TRANS TRANSPARENT	
CONST CONSTRUCTION	FHC FIRE HOSE CABINET	LAV LAVATORY	PREFAB PREFABRICATED	TRTD TREATED	
CONT CONTINUOUS(ATION)	FIN FINISH	LB LBOUND	PLAM PLASTIC LAMINATE	T&G TONGUE & GROOVE	
CONTR CONTRACT(OR)	FLDG FOLDING	£ BRITISH POUND (CURRENCY)	PLAS PLASTER	TTY TYPICAL	
COV COVER	FPLC FIREPLACE		PLSTC PLASTIC	U	
CMU CONCRETE MASONRY UNIT	FR FIRE RAT(ING)(ED)	LT LIGHT	PLYWD PLYWOOD	UNDRLAY UNDERLAYMENT	
	FR,G FRAMING	RLG LEVELING	PRTECN PROTECTION	UTIL UTILITY	
	D	FXD FIXED	R	UNO UNLESS NOTED OTHERWISE	
DBL DOUBLE	FXTR FIXTURE	LVR LOUVER	RDR READER	UNO UNLESS OTHERWISE NOTED	
DEPT DEPARTMENT	FLR FLOOR(ING)	M	RECES RECESSED	V	
DES DESIGN(ED)	FURN FURNITURE	MAX MAXIMUM	RECPT RECEPTACLE	VEH VEHICLE	
DET DETAIL	FWC FABRIC WALL COVERING	MFD MANUFACTURED	REF REFERENCE	VERT VERTICAL	

MECHANICAL NOTES

1. PLUMBING AND HVAC SYSTEMS:
 - 1.1. DESIGNED BY CONTRACTORS PLUMBING AND MECHANICAL PERSONNEL.
 - 1.2. PROPOSED LOCATIONS OF HVAC AND WATER HEATERS DETERMINED BY CONTRACTOR AND SUBMITTED TO OWNER AND ARCHITECT FOR APPROVAL.
 - 1.3. PROPOSED LOCATIONS OF HVAC VENTS AND RETURN AIR DETERMINED BY CONTRACTOR AND SUBMITTED TO OWNER AND ARCHITECT FOR APPROVAL.
2. ALL VENTILATION SYSTEMS TO MEET LOCAL CODE REQUIREMENTS AND DESIGNED BY CONTRACTORS PERSONNEL.

MECHANICAL SYMBOLS

	W	COLD WATER TAP FOR REFRIGERATOR OR ICE MAKER
	GAS	GAS SUPPLY
		GAS KEY
	GAS	SWITCHED GAS KEY
	HB	FROST FREE HOSE BIB

CONSTRUCTION NOTES

1. CONSTRUCTION SHALL COMPLY WITH APPLICABLE CODES AND RELATED AMENDMENTS TO THE CITY OF WESTLAKE ORDINANCES (OTC).
2. ALL STRUCTURES IN THIS ZONING DISTRICT MUST COMPLY WITH ALL CITY OF WESTLAKE ORDINANCES (OTC).
3. ALL CONSTRUCTION TO COMPLY WITH ENTRADA DESIGN GUIDELINES.
4. THE CONTRACTOR SHALL PAY ALL FINES, GIVE ALL NOTICES, FILE ALL NECESSARY DRAWINGS, AND PAY AND OBTAIN ALL PERMITS AND INSPECTIONS REQUIRED IN CONNECTION WITH ALL WORK UNDER THE CONTRACT DOCUMENTS.
5. THESE DRAWINGS DO NOT CONTAIN COMPLETE SPECIFICATIONS, DETAILS, OR FULL INFORMATION NECESSARY FOR THE COMPLETE CONSTRUCTION OF THE PROJECT.
6. ELECTRICAL, MECHANICAL AND PLUMBING ITEMS SHOWN ON THE ARCHITECTURAL DRAWINGS ARE DIAGRAMMATIC AND PROVIDED TO SHOW DESIGN INTENT. THE GENERAL CONTRACTORS SUB CONSULTANTS FOR THOSE TRADES ARE RESPONSIBLE FOR THE ACTUAL DESIGN TO OF THOSE SYSTEMS TO MEET NATIONAL, STATE OR CITY CODE REQUIREMENTS THAT HAVE JURISDICTION. FIRE SPRINKLERS SYSTEMS: LICENSED FIRE PROTECTION SUB CONTRACTOR TO SUBMIT TO REED FIRE PROTECTION (214) 638-7599
7. THE CONTRACTOR IS TO COORDINATE TELECOMMUNICATIONS, DATA AND SECURITY SYSTEM INSTALLATIONS.
8. REFER TO CIVIL AND LANDSCAPE DRAWINGS FOR GRADING AND DRAINAGE REQUIREMENTS. CONTRACTOR TO CONSULT WITH A STRUCTURAL ENGINEER FOR STRUCTURAL DESIGN, SPECIFICATIONS, AND DETAILS; INCLUDING REQUIRED RETAINING WALLS, WATERPROOFING, AND FRENCH DRAIN SYSTEMS. COORDINATE SOIL COMPACTION REQUIREMENTS BEHIND RETAINING WALLS WITH STRUCTURAL ENGINEER.
9. CONTRACTOR TO REVIEW DOCUMENTS, VERIFY DIMENSIONS AND FIELD CONDITIONS AND CONFIRM THE WORK IS BUILDABLE AS SHOWN. NOTIFY ARCHITECT AND OWNER OF ERRORS, OMISSIONS, AND DISCREPANCIES IN CONTRACT DOCUMENTS, OR BETWEEN CONTRACT DOCUMENTS AND ACTUAL SITE CONSTRUCTION CONDITIONS. ERRORS, OMISSIONS, AND DISCREPANCIES MUST BE RESOLVED AND DOCUMENTED BEFORE CONTINUING CONSTRUCTION WITH THE WORK IN QUESTION. FAILURE TO NOTIFY THE OWNER AND ARCHITECT IN SUCH AN EVENT SHALL CONSTITUTE ACCEPTANCE OF ANY RESULTING OBLIGATIONS OR RESPONSIBILITIES WITH REGARDS TO DELAYS, COSTS, CODE COMPLIANCE, AND LEGAL REMEDIES RESULTING FROM THIS OR RELATED WORK.
10. SUBMIT REQUESTS FOR SUBSTITUTIONS, REVISIONS, OR CHANGES TO ARCHITECT FOR REVIEW PRIOR TO PURCHASE, FABRICATION OR INSTALLATION. THE CONTRACTOR SHALL VERIFY ALL MEASUREMENTS AT THE SITE AND BE RESPONSIBLE FOR THE ACCURACY AND CORRECTNESS OF SAME.
11. SUBMIT SHOP DRAWINGS AND SELECTIONS FOR ARCHITECTS/OWNERS REVIEW BEFORE ORDERING AND INSTALLING ANY EQUIPMENT, MASONRY, CAST STONE, WINDOWS, STEEL ETC. DO NOT SCALE DRAWINGS, WRITTEN DIMENSIONS GOVERN. IN CASE OF CONFLICT, CONSULT THE ARCHITECT.
12. MAINTAIN WORK AREAS CLEAN, SECURE AND LOCKABLE DURING CONSTRUCTION.
13. PROTECT AREA OF WORK AND ADJACENT PROPERTIES FROM DAMAGE.
14. VERIFY TYPE AND LOCATION OF UTILITIES SERVING SITE.
15. FIREPLACES:
 - 15.1 VERIFY SIZES, INCLUDING HEARTH EXTENSIONS REQUIRED BY CODE.
 - 15.2 PROVIDE OUTSIDE MAKE-UP AIR INLET AND SCREENED LOUVER AND DAMPER.
16. FLOOR ELEVATIONS AT SECOND FLOOR ARE GIVEN TO TOP OF FLOOR DECK.
17. INSTALL STUDS AT CLOSET SIDE WALL ROD LOCATIONS, MEASURED 10" FROM BACK WALL.
18. EXTERIOR MATERIALS AND FINISHES ARE TO BE INSTALLED IN ACCORDANCE WITH MANUFACTURERS WRITTEN INSTRUCTIONS AND DETAILS.
19. STONE WALL CORNERS SHALL BE LAID SO THAT THE COURSES INTERLOCK (TOOTHING). SHOWING THE FULL DIMENSION OF THE STONE.
20. PARTITIONS ARE DIMENSIONED FROM FACE OF STUD TO FACE OF STUD, UNLESS OTHERWISE NOTED, MAINTAIN DIMENSIONS MARKED "CLEAR". ALLOW FOR THICKNESS OR FINISHES.
21. COORDINATE AND PROVIDE BLOCKING/BACKING FOR MILLWORK AND OTHER ITEMS ATTACHED OR MOUNTED TO WALLS OR CEILINGS.
22. STUCCO CONTROL JOINTS ARE TO BE LOCATED AT 12'-0" O.C. EACH WAY MAXIMUM. STUCCO CONTROL JOINTS ARE TO BE CONCEALED.
23. STONE CONTROL JOINTS ARE TO BE LOCATED 25'-0" O.C. MAXIMUM. STONE CONTROL JOINTS SHOULD BE CONCEALED.
24. UNDERCUT INTERIOR DOORS TO CLEAR TOP OF FLOOR FINISH BY 1/4 INCH, UNLESS OTHERWISE NOTED.
25. ALL GUTTERS ARE TO BE PREFINISHED GALVANIZED ALUMINUM DARK BRONZE 6" HALF ROUND PROFILE. ALL HORIZONTAL JOINTS ARE REQUIRED TO BE SOLDERED OR MECHANICALLY FASTENED WITH CONCEALED FASTENERS.
26. ALL DOWNSPOUTS ARE TO BE PREFINISHED ALUMINUM DARK BRONZE 4" MINIMUM PLAIN ROUND. VERTICAL DOWNSPOUT SECTIONS, ELBOWS AND BENDS MAY BE SLIP JOINTED AND/OR RIVETED IF RIVETS ARE CONCEALED.

FOR DIMENSION PURPOSES:

1. DO NOT SCALE DRAWINGS.
2. VERIFY DIMENSIONS: NOTIFY ARCHITECT OF ANY DISCREPANCIES.
3. WOOD STUD WALLS: VERIFY AND REFER TO STRUCTURAL ENGINEER FOR SIZES AND STUD SPACING.
4. WALL PLATE HEIGHTS: CROSS REFERENCE EXTERIOR ELEVATIONS, WALL SECTIONS, AND FASCIA DETAILS TO DETERMINE.
5. WINDOWS AND DOORS:
 - 5.1. VERIFY ROUGH OPENINGS WITH SELECTED MANUFACTURER.
 - 5.2. REFER TO EXTERIOR ELEVATIONS AND FLOOR PLANS OR SCHEDULE FOR HEAD HEIGHTS.

Bush
ARCHITECTS

1800 VALLEY VIEW LANE, STE. 400
FARMERS BRANCH, TX 75234
PHONE: 469-857-3151
© BUSH ARCHITECTS, LLC - 2021

ENTRADA

LOT 02, BLOCK H

TOWN OF WESTLAKE TARRANT COUNTY, TEXAS


ISSUE LOG

[illegible]

GENERAL NOTES

A001

REFER TO **ENTRADA DESIGN GUIDELINES** FOR FUTHER DETAILED INFORMATION REGARDING THESE PLANS

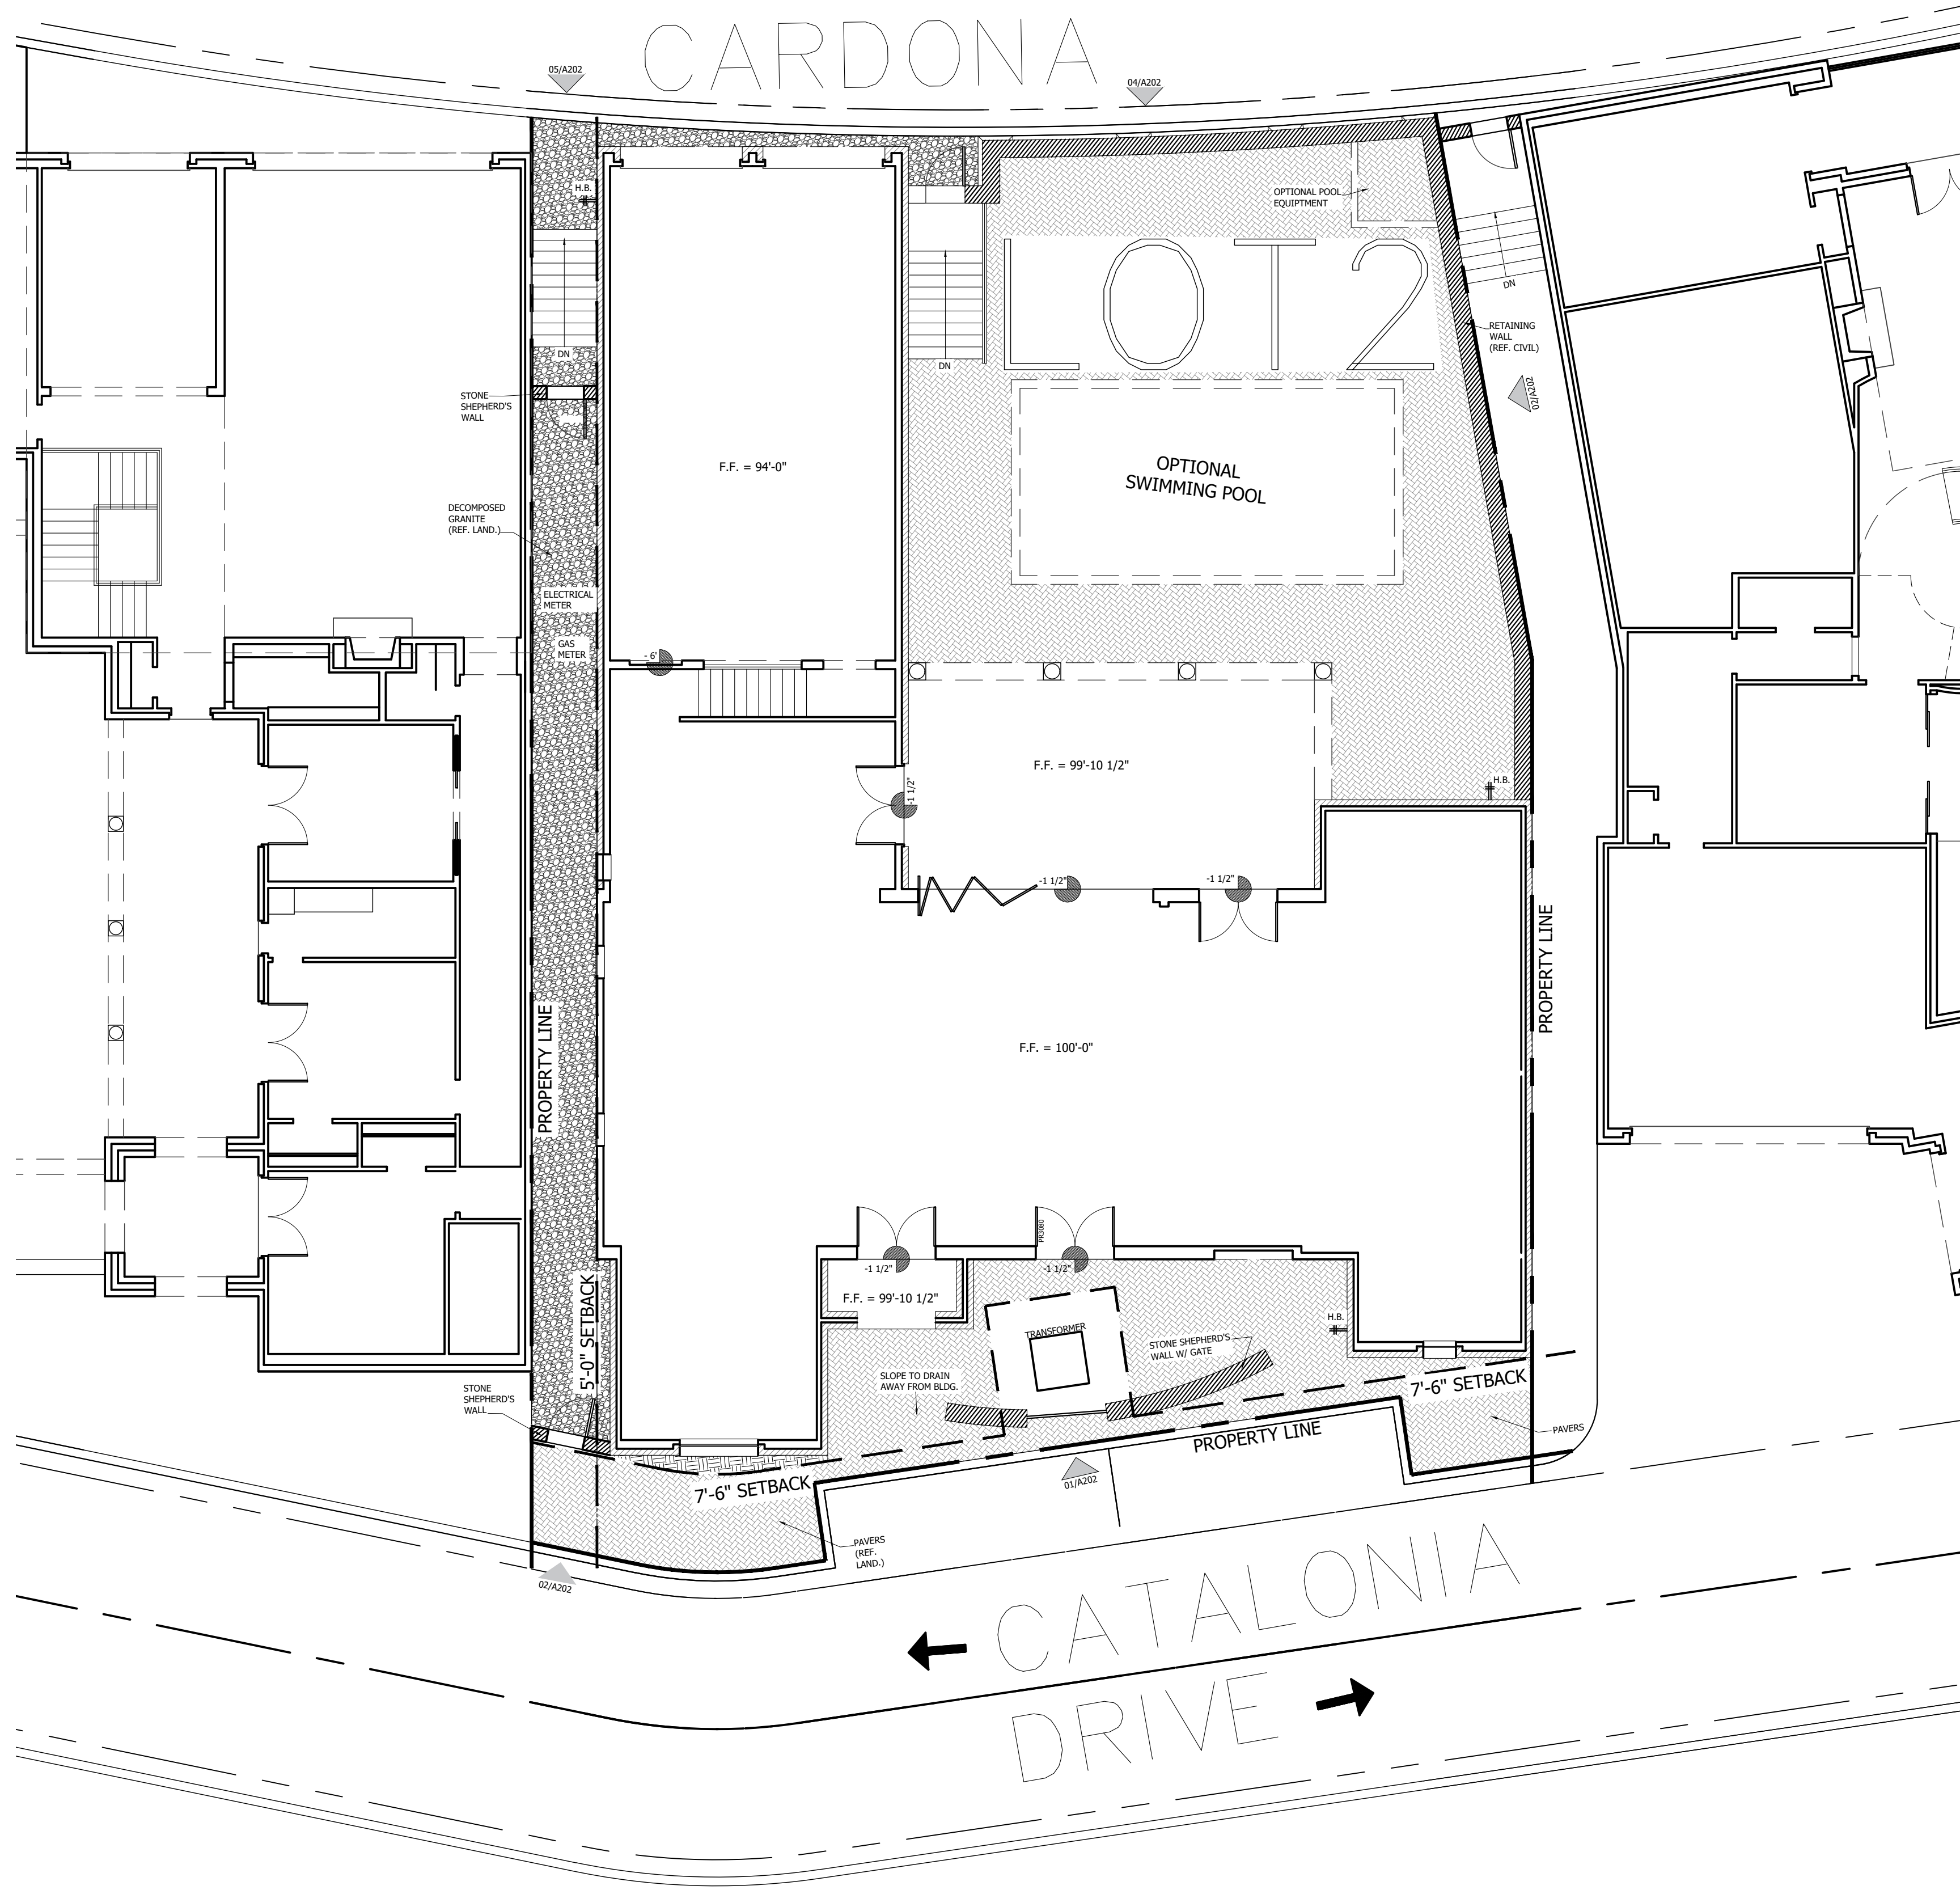

LEGEND

PROPERTY LINE

EASEMENTS/SETBACKS

TARGET MARK

TRAFFIC DIRECTIONAL ARROWS

A/C CONDENSING UNIT

- SITE NOTES
1. CONTRACTOR TO INSTALL ALL EXTERIOR LIGHTING TO MEET ENTRADA GUIDELINES AND ZONING REQUIREMENTS.

2. SEE CIVIL ENGINEERING AND LANDSCAPE PLANS FOR UTILITIES, DIMENSIONS CONTROL, GRADING, DRAINAGE, PAVEMENT, HC RAMPS AND ALL SIDEWALKS.

3. CONTRACTOR TO INSTALL ALL SIGNAGE TO MEET ENTRADA GUIDELINE REQUIREMENTS.

ENTRADA

LOT 02, BLOCK H

TOWN OF WESTLAKE TARRANT COUNTY, TEXAS

ISSUE LOG

NO.	DESCRIPTION	DATE

PROJECT NO:	20-130
ISSUED FOR:	OTP
DRAWN BY:	Checker
DATE:	06/16/21

ARCHITECTURAL

SITE PLAN

A100

01

A100

SITE PLAN

SCALE: 1:100

NOTE: REFER TO CIVIL PLANS FOR SITE DIMENSION CONTROL

ENTRADA

LOT 02, BLOCK H

TOWN OF WESTLAKE TARRANT COUNTY, TEXAS


ISSUE LOG

NO.	DESCRIPTION	DATE

PROJECT NO: 20-130
ISSUED FOR: OTP
DRAWN BY: Checker
DATE: 06/16/21

FIRST FLOOR PLAN

A101

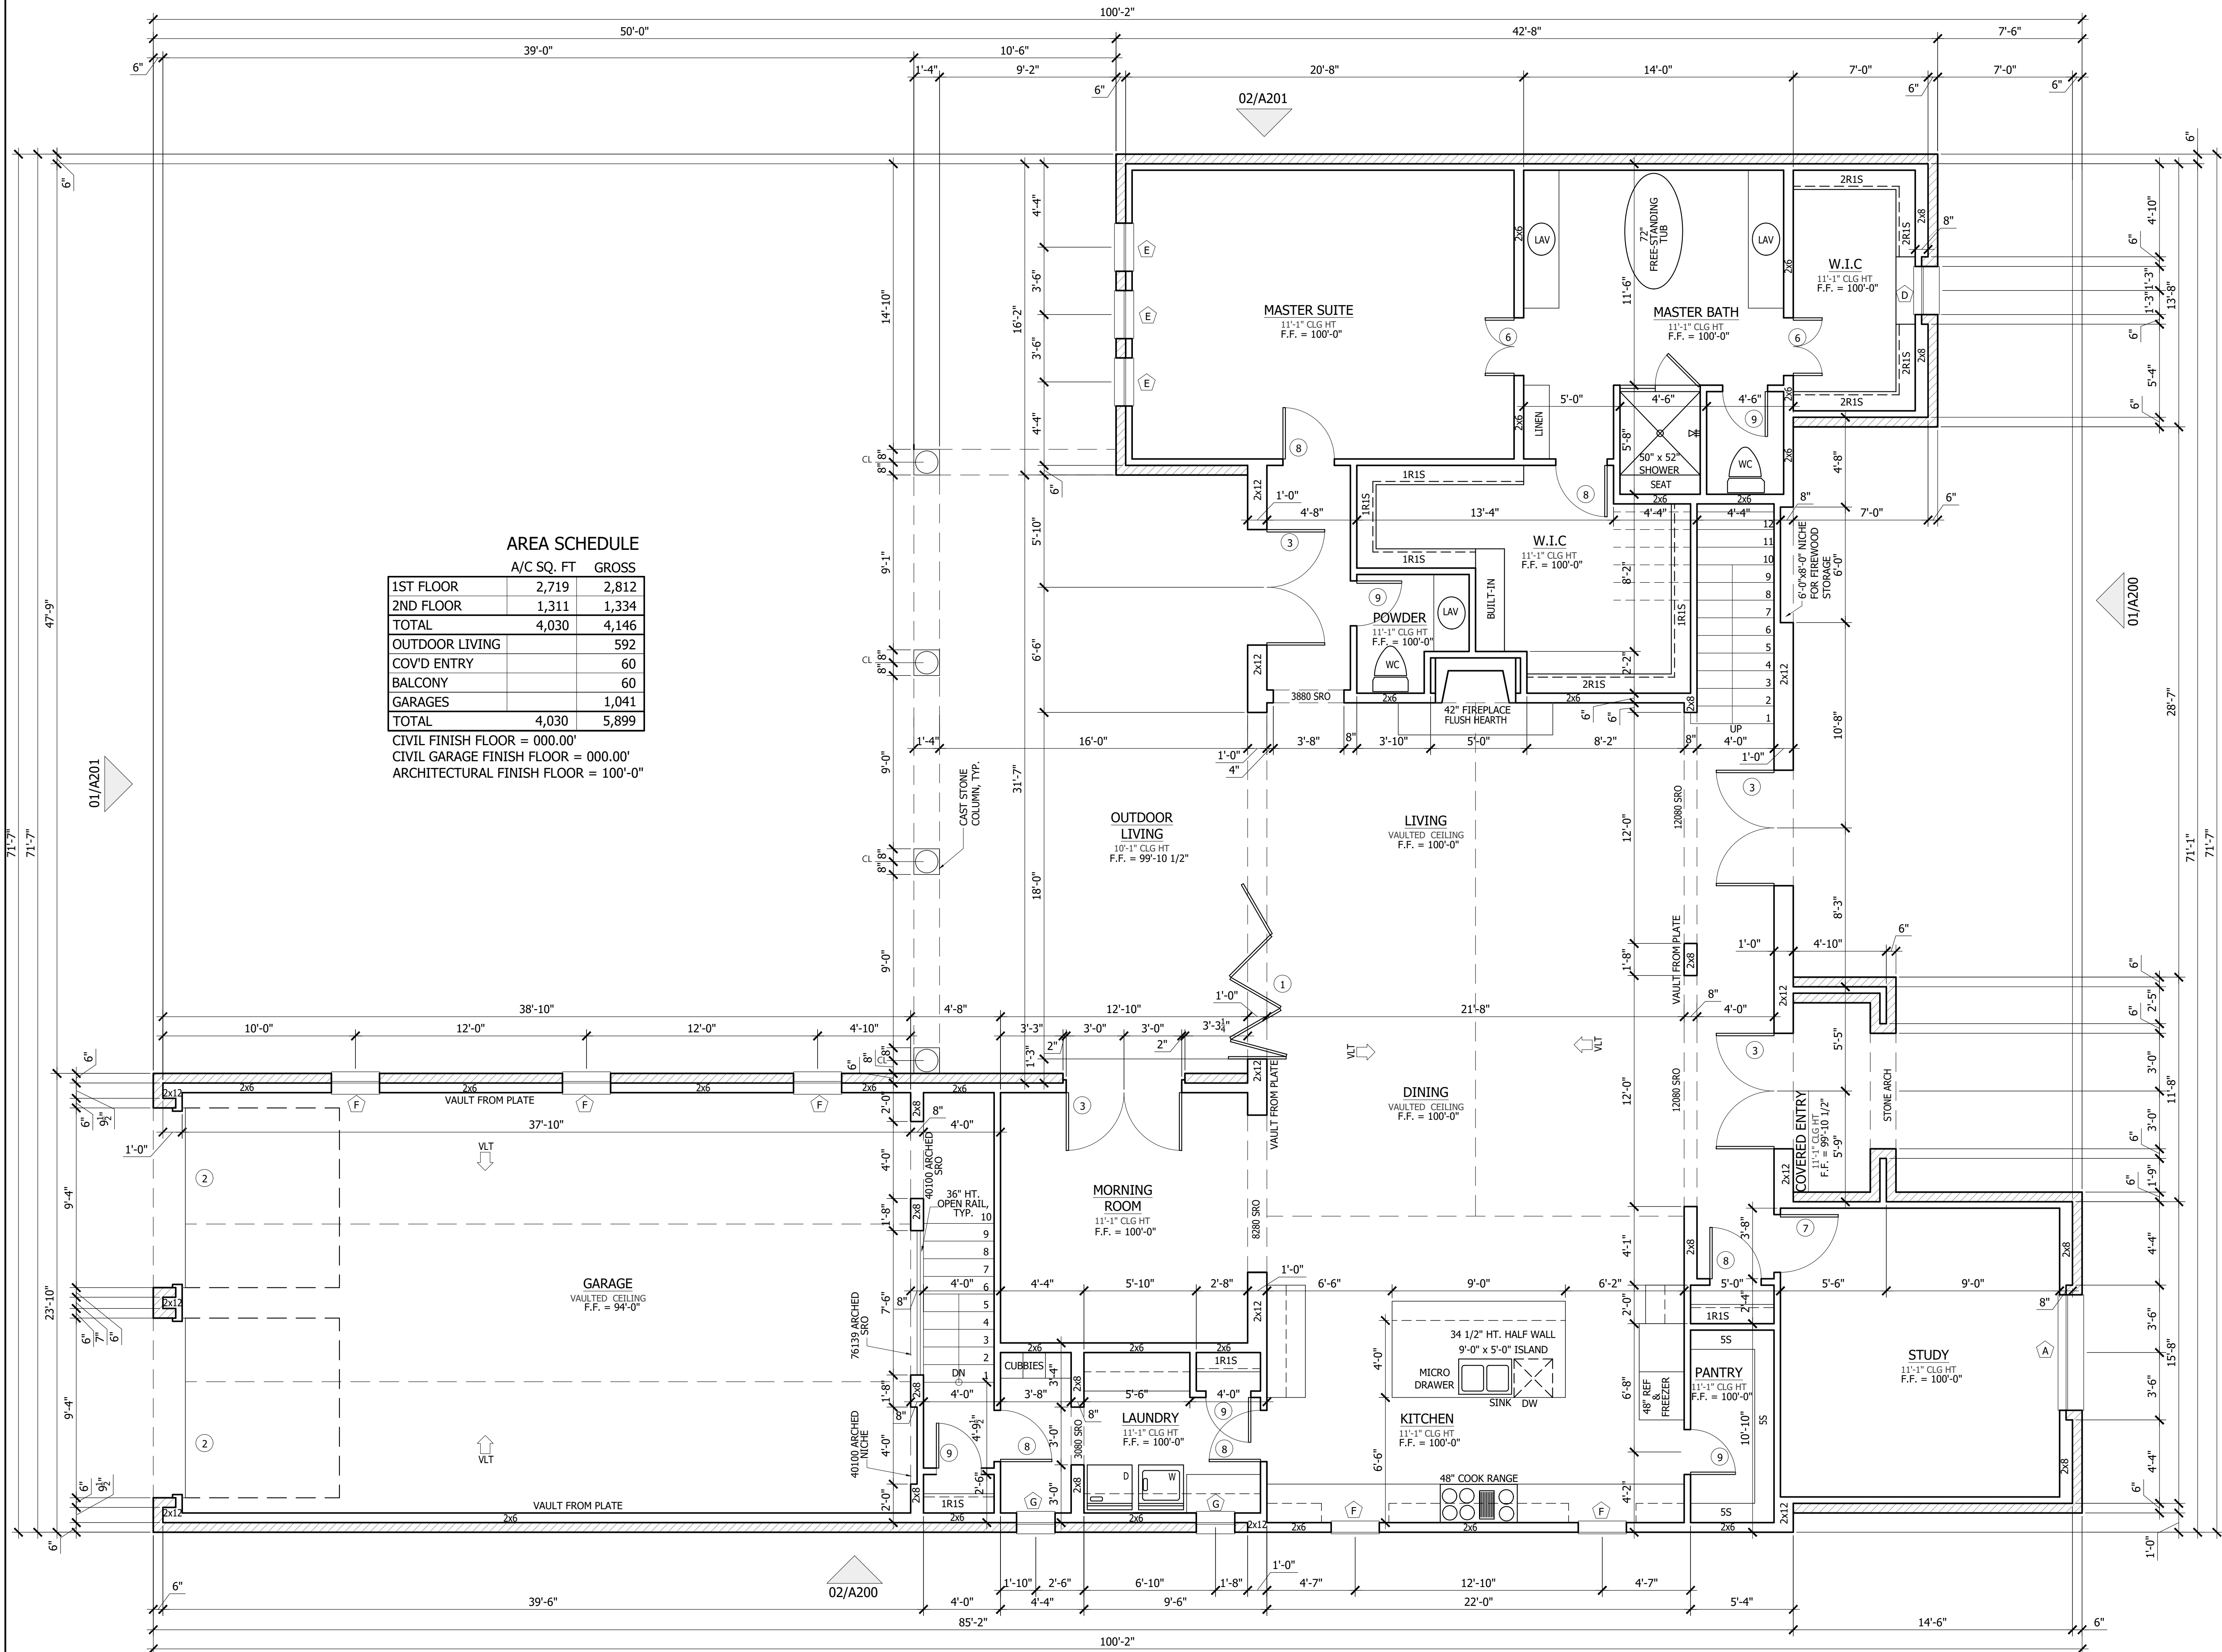

AREA SCHEDULE

	A/C SQ. FT	GROSS
1ST FLOOR	2,719	2,812
2ND FLOOR	1,311	1,334
TOTAL	4,030	4,146
OUTDOOR LIVING		592
COV'D ENTRY		60
BALCONY		60
GARAGES		1,041
TOTAL	4,030	5,899

CIVIL FINISH FLOOR = 000.00'
CIVIL GARAGE FINISH FLOOR = 000.00'
ARCHITECTURAL FINISH FLOOR = 100'-0"

01 FIRST FLOOR PLAN
A101 SCALE: 1/4"=1'-0"

REFER TO **ENTRADA DESIGN GUIDELINES** FOR FUTHER DETAILED INFORMATION REGARDING THESE PLANS

EXTERIOR WALL NOTE:
EXTERIOR WALLS W/ WINDOWS FACING
RIGHT-OF-WAY TO HAVE (2) WIDTHS OF 2x4 STUD
WALLS AT 8" FROM FACE OF STUD TO FACE OF STUD.
(REF. DTL. 09 & 11 / AS02)

ENTRADA

LOT 02, BLOCK H

TOWN OF WESTLAKE TARRANT COUNTY, TEXAS


ISSUE LOG

NO.	DESCRIPTION	DATE

PROJECT NO: 20-130
ISSUED FOR: OTP
DRAWN BY: Checker
DATE: 06/16/21

SECOND FLOOR PLAN

A102

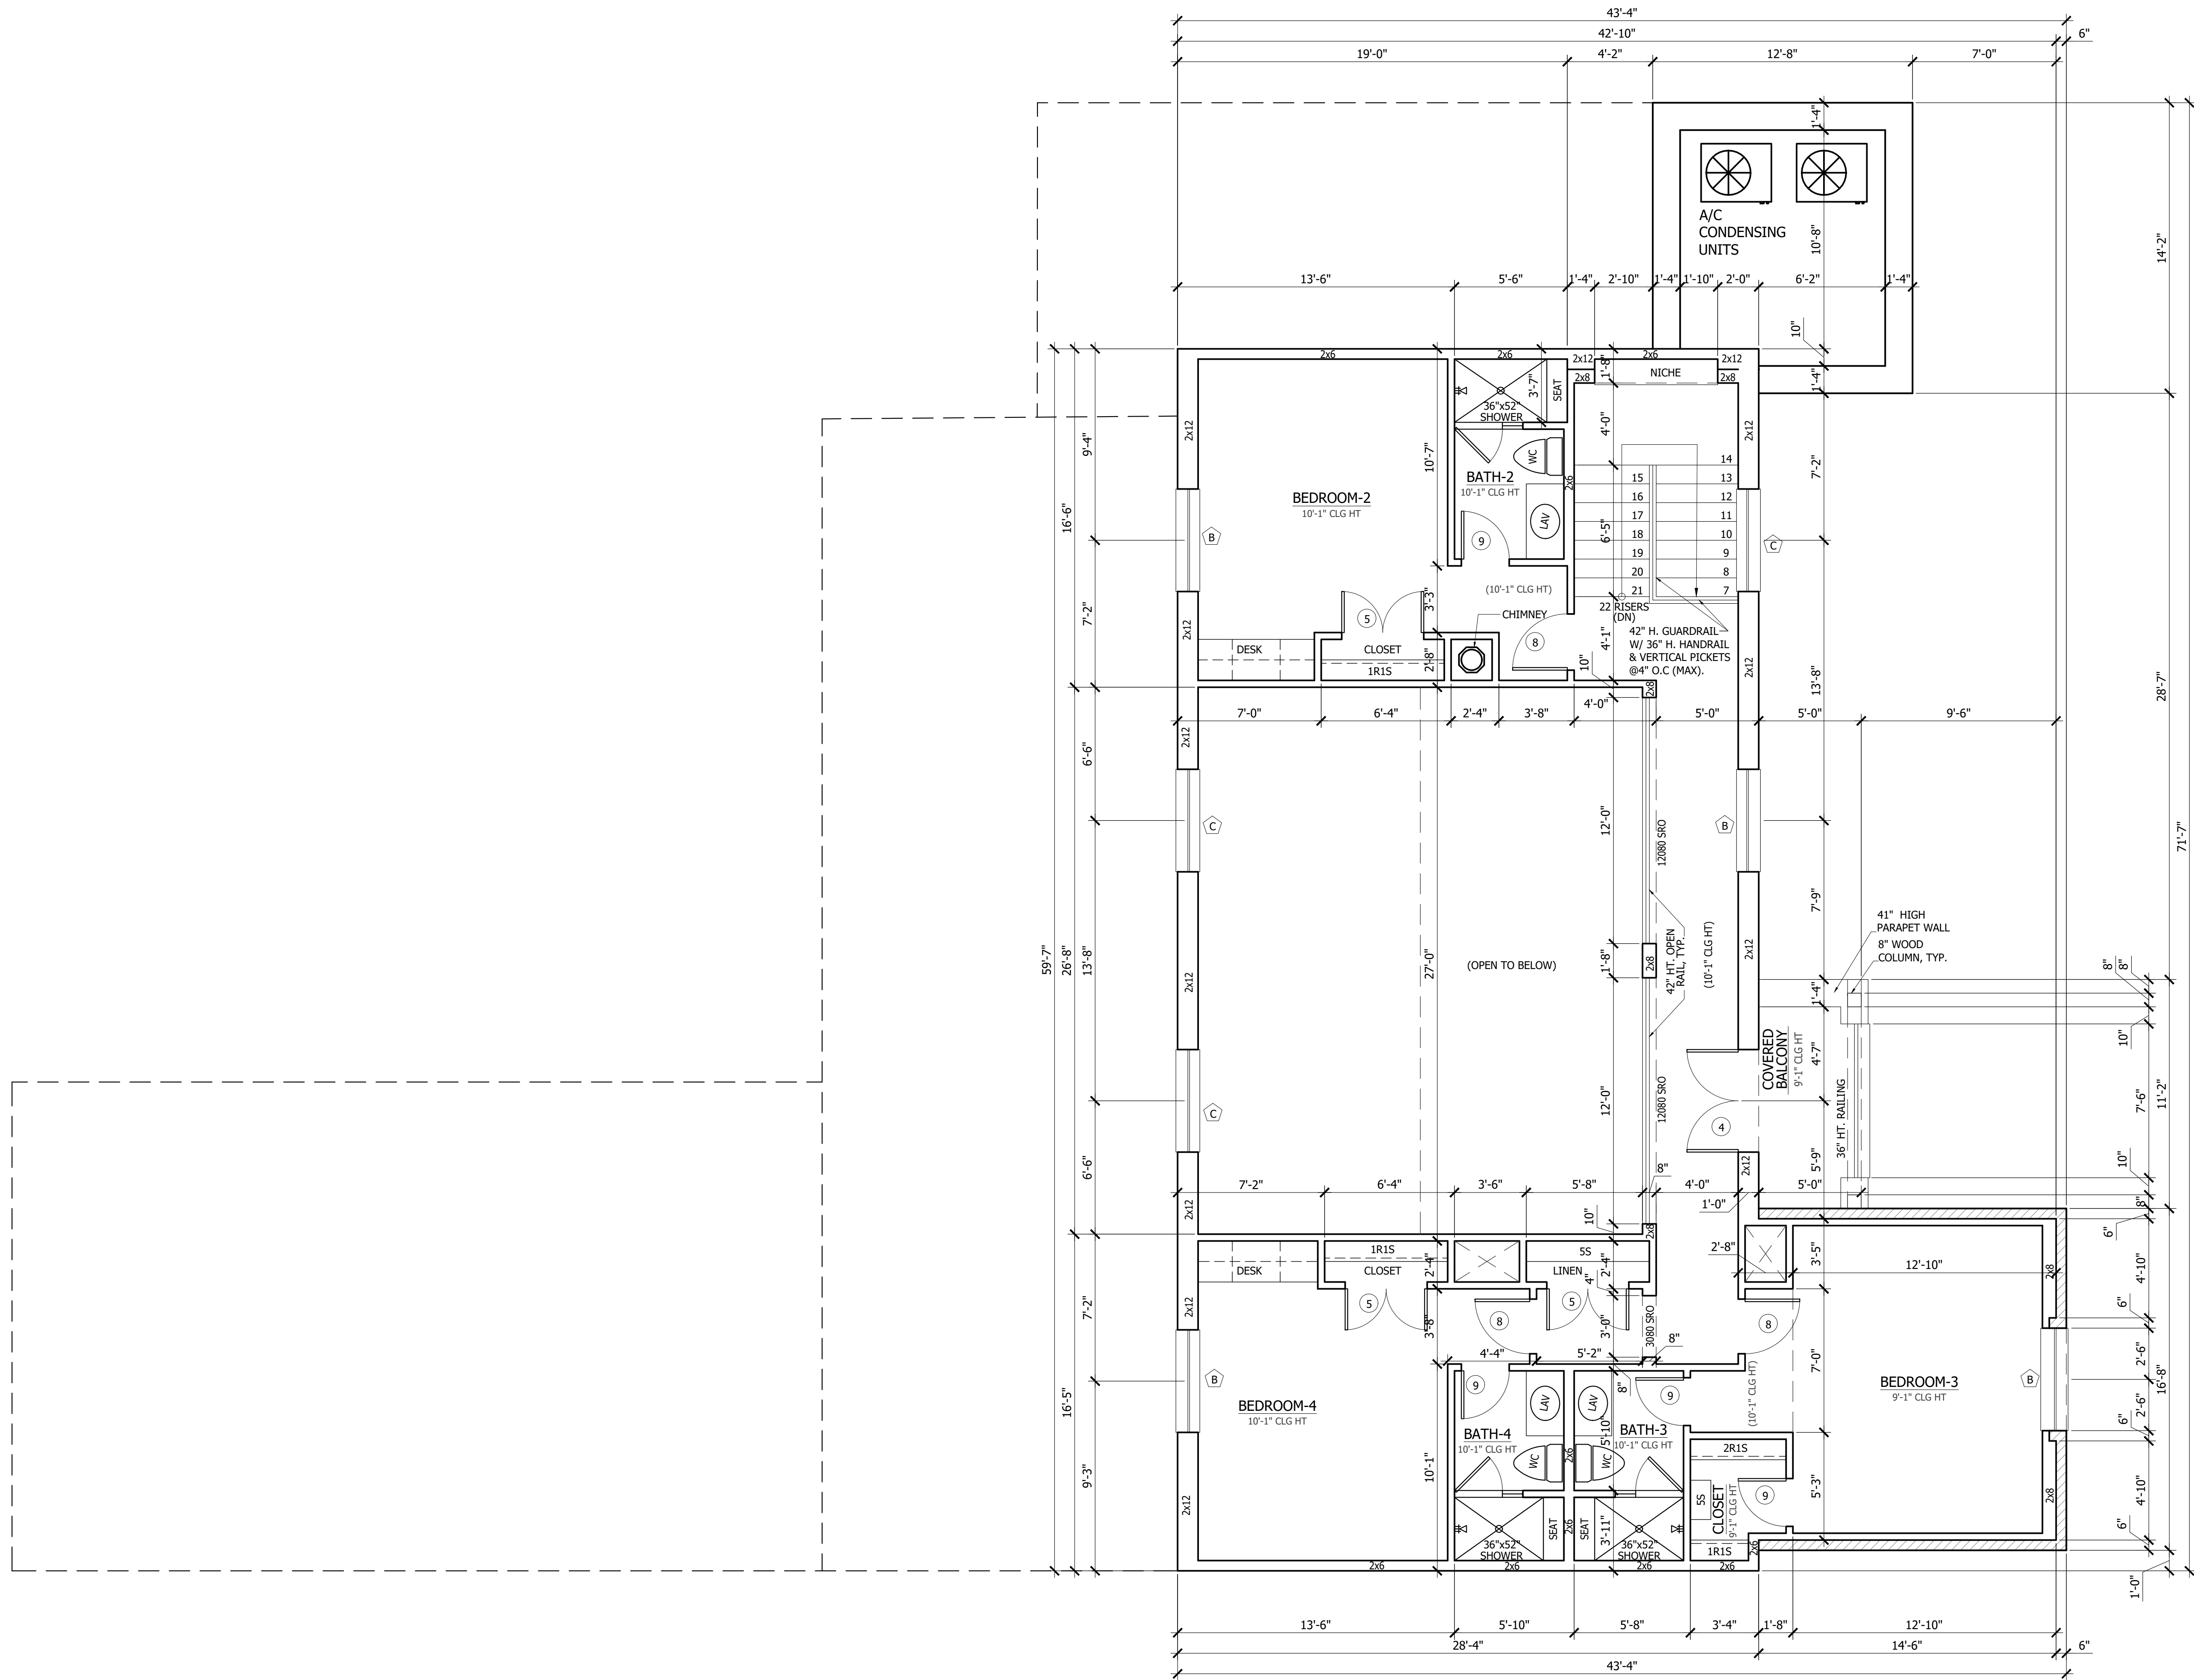

01 SECOND FLOOR PLAN
A102 SCALE: 1/4"=1'-0"

REFER TO **ENTRADA DESIGN GUIDELINES** FOR FUTHER DETAILED INFORMATION REGARDING THESE PLANS



1800 VALLEY VIEW LANE, STE. 400
FARMERS BRANCH, TX 75234
PHONE: 469-857-3151
©BUSH ARCHITECTS, LLC - 2021

ENTRADA

LOT 02, BLOCK H

TOWN OF WESTLAKE TARRANT COUNTY, TEXAS

[illegible]

WINDOW SCHEDULE									
TAG	WINDOW	WIDTH	HEIGHT	HDR	LITE		TYPE	NOTES	
					WIDTH	HEIGHT			
A	2-2670	5'-0"	7'-0"	8'-0"	2	4	FXD DL	ARCH /TEMPERED	
B	2-2650	5'-0"	5'-0"	8'-0"	2	3	CSMT DL		
B	2-2650	5'-0"	5'-0"	8'-0"	2	3	CSMT DL		
B	2-2650	5'-0"	5'-0"	8'-0"	2	3	CSMT DL		
B	2-2650	5'-0"	5'-0"	8'-0"	2	3	CSMT DL		
C	2-2650	5'-0"	5'-0"	20'-8"	2	3	FXD DL		
C	2-2650	5'-0"	5'-0"	20'-8"	2	3	FXD DL		
C	2-2650	5'-0"	5'-0"	8'-0"	2	3	FXD DL		
D	2650	2'-6"	5'-0"	8'-0"	2	3	FXD DL	ARCH	
E	2650	2'-6"	5'-0"	8'-0"	2	3	CSMT DL		
E	2650	2'-6"	5'-0"	8'-0"	2	3	CSMT DL		
E	2650	2'-6"	5'-0"	8'-0"	2	3	CSMT DL		
F	2630	2'-6"	3'-0"	8'-0"	2	3	FXD DL	TEMP	
F	2630	2'-6"	3'-0"	8'-0"	2	3	FXD DL		
F	2630	2'-6"	3'-0"	8'-0"	2	3	FXD DL		
F	2630	2'-6"	3'-0"	8'-0"	2	3	FXD DL		
G	2030	2'-0"	3'-0"	8'-0"	2	2	FXD DL		
G	2030	2'-0"	3'-0"	8'-0"	2	2	FXD DL		

01 DOOR SCHEDULE
A103 SCALE: 1/4"=1'-0"

02 WINDOW SCHEDULE
A103 SCALE: 1/4"=1'-0"

REFER TO **ENTRADA DESIGN GUIDELINES** FOR FUTHER DETAILED INFORMATION REGARDING THESE PLANS

[illegible]

DOOR & WINDOW SCHEDULE

A103

ELECTRICAL NOTES

- ELECTRICAL INSTALLATION SHALL MEET REQUIREMENTS OF APPROVED CODES AND REGULATIONS.
- VERIFY UTILITIES AND LOCATIONS WITH CONTRACTOR.
- SWITCHED CONVENIENCE OUTLETS TO BE SWITCHED AT TOP OUTLET ONLY.
- SWITCHES: 4'-6" ABV. FINISHED FLOOR TO CENTERLINE OF SWITCH, UNLESS NOTED OTHERWISE.
- INTERIOR WALL MOUNTED BRACKET FIXTURES: 6'-6" ABV. FINISHED WALKING SURFACE TO CENTERLINE OF BRACKET, U.N.O.
- EXTERIOR WALL MOUNTED BRACKET FIXTURES: 7'-0" ABV. FINISHED WALKING SURFACE TO CENTERLINE OF BRACKET, U.N.O.
- SMOKE/CARBON MONOXIDE DETECTORS : COORDINATE W/ ALARM SYSTEM. DETECTORS TO COMPLY WITH GOVERNING CODES AND REGULATIONS.
- PROVIDE 220V JUNCTION BOX AND OTHER REQUIRED WIRING FOR HVAC UNITS. VERIFY LOCATION WITH CONTRACTOR.
- VERIFY ALL EQUIPMENT POWER REQUIREMENTS WITH THE MANUFACTURER AND/OR SUPPLIER.
- ALL EXTERIOR CONVENIENCE OUTLETS TO BE WATER PROOF AND ON A GROUND FAULT CIRCUIT.
- ALL OUTLETS SHALL BE COMBINATION TYPE AFCI AND SHALL BE TAMPER PROOF/RESISTENT.

ELECTRICAL SYMBOLS

LIGHT FIXTURES

- CEILING MOUNTED
- CEILING SPEAKER
- WITH PULL CHAIN
- LANDSCAPE LIGHT
- WALL BRACKET - INTERIOR AND EXTERIOR
- RECESSED IN CEILING OR SOFFIT
- RECESSED "WALL WASHER" IN CEILING OR SOFFIT
- FLUORESCENT FIXTURE
- LOW VOLTAGE
- UNDER CABINET LIGHT
- RECESSED "PIN HOLE" IN CEILING OR SOFFIT
- WALL MOUNTED FLOODLIGHT

CONVENIENCE OUTLETS


- 110V. DUPLEX OUTLET;
12" ABOVE FLOOR-TYP.
- 110V. FOURPLEX OUTLET;
12" ABOVE FLOOR-TYP.
- 42" DISTANCE ABOVE FLOOR;
OTHER THAN 12"
- WPGFI WATERPROOF
GROUNDFAULT
OUTLET
- GDO GARAGE DOOR
OPENER
- GFI GROUNDFAULT
OUTLET
- ARC ARC FAULT
- SWITCHED OUTLET
- FLOOR OUTLET
- 220V. OUTLET

SWITCHES

- SINGLE POLE SWITCH
- FOUR WAY SWITCH
- THREE WAY SWITCH
- DIMMER SWITCH

GENERAL

- 110V JUNCTION BOX
- 220V JUNCTION BOX
- 220
- GARBAGE DISPOSAL
- LANTERN
- EXHAUST FAN
- EXHAUST FAN W/ LIGHT
- WALL EXHAUST FAN
- ELECTRICAL PANEL
- TELEVISION OUTLET
- TELEPHONE/DATA OUTLET
- FAUCET
- S.M.D./C.O. SMOKE DETECTOR/
CARBON MONOXIDE
DETECTOR
- PUSH BUTTON
- CHANDELIER
- CEILING FAN
- CEILING FAN W/
LIGHT

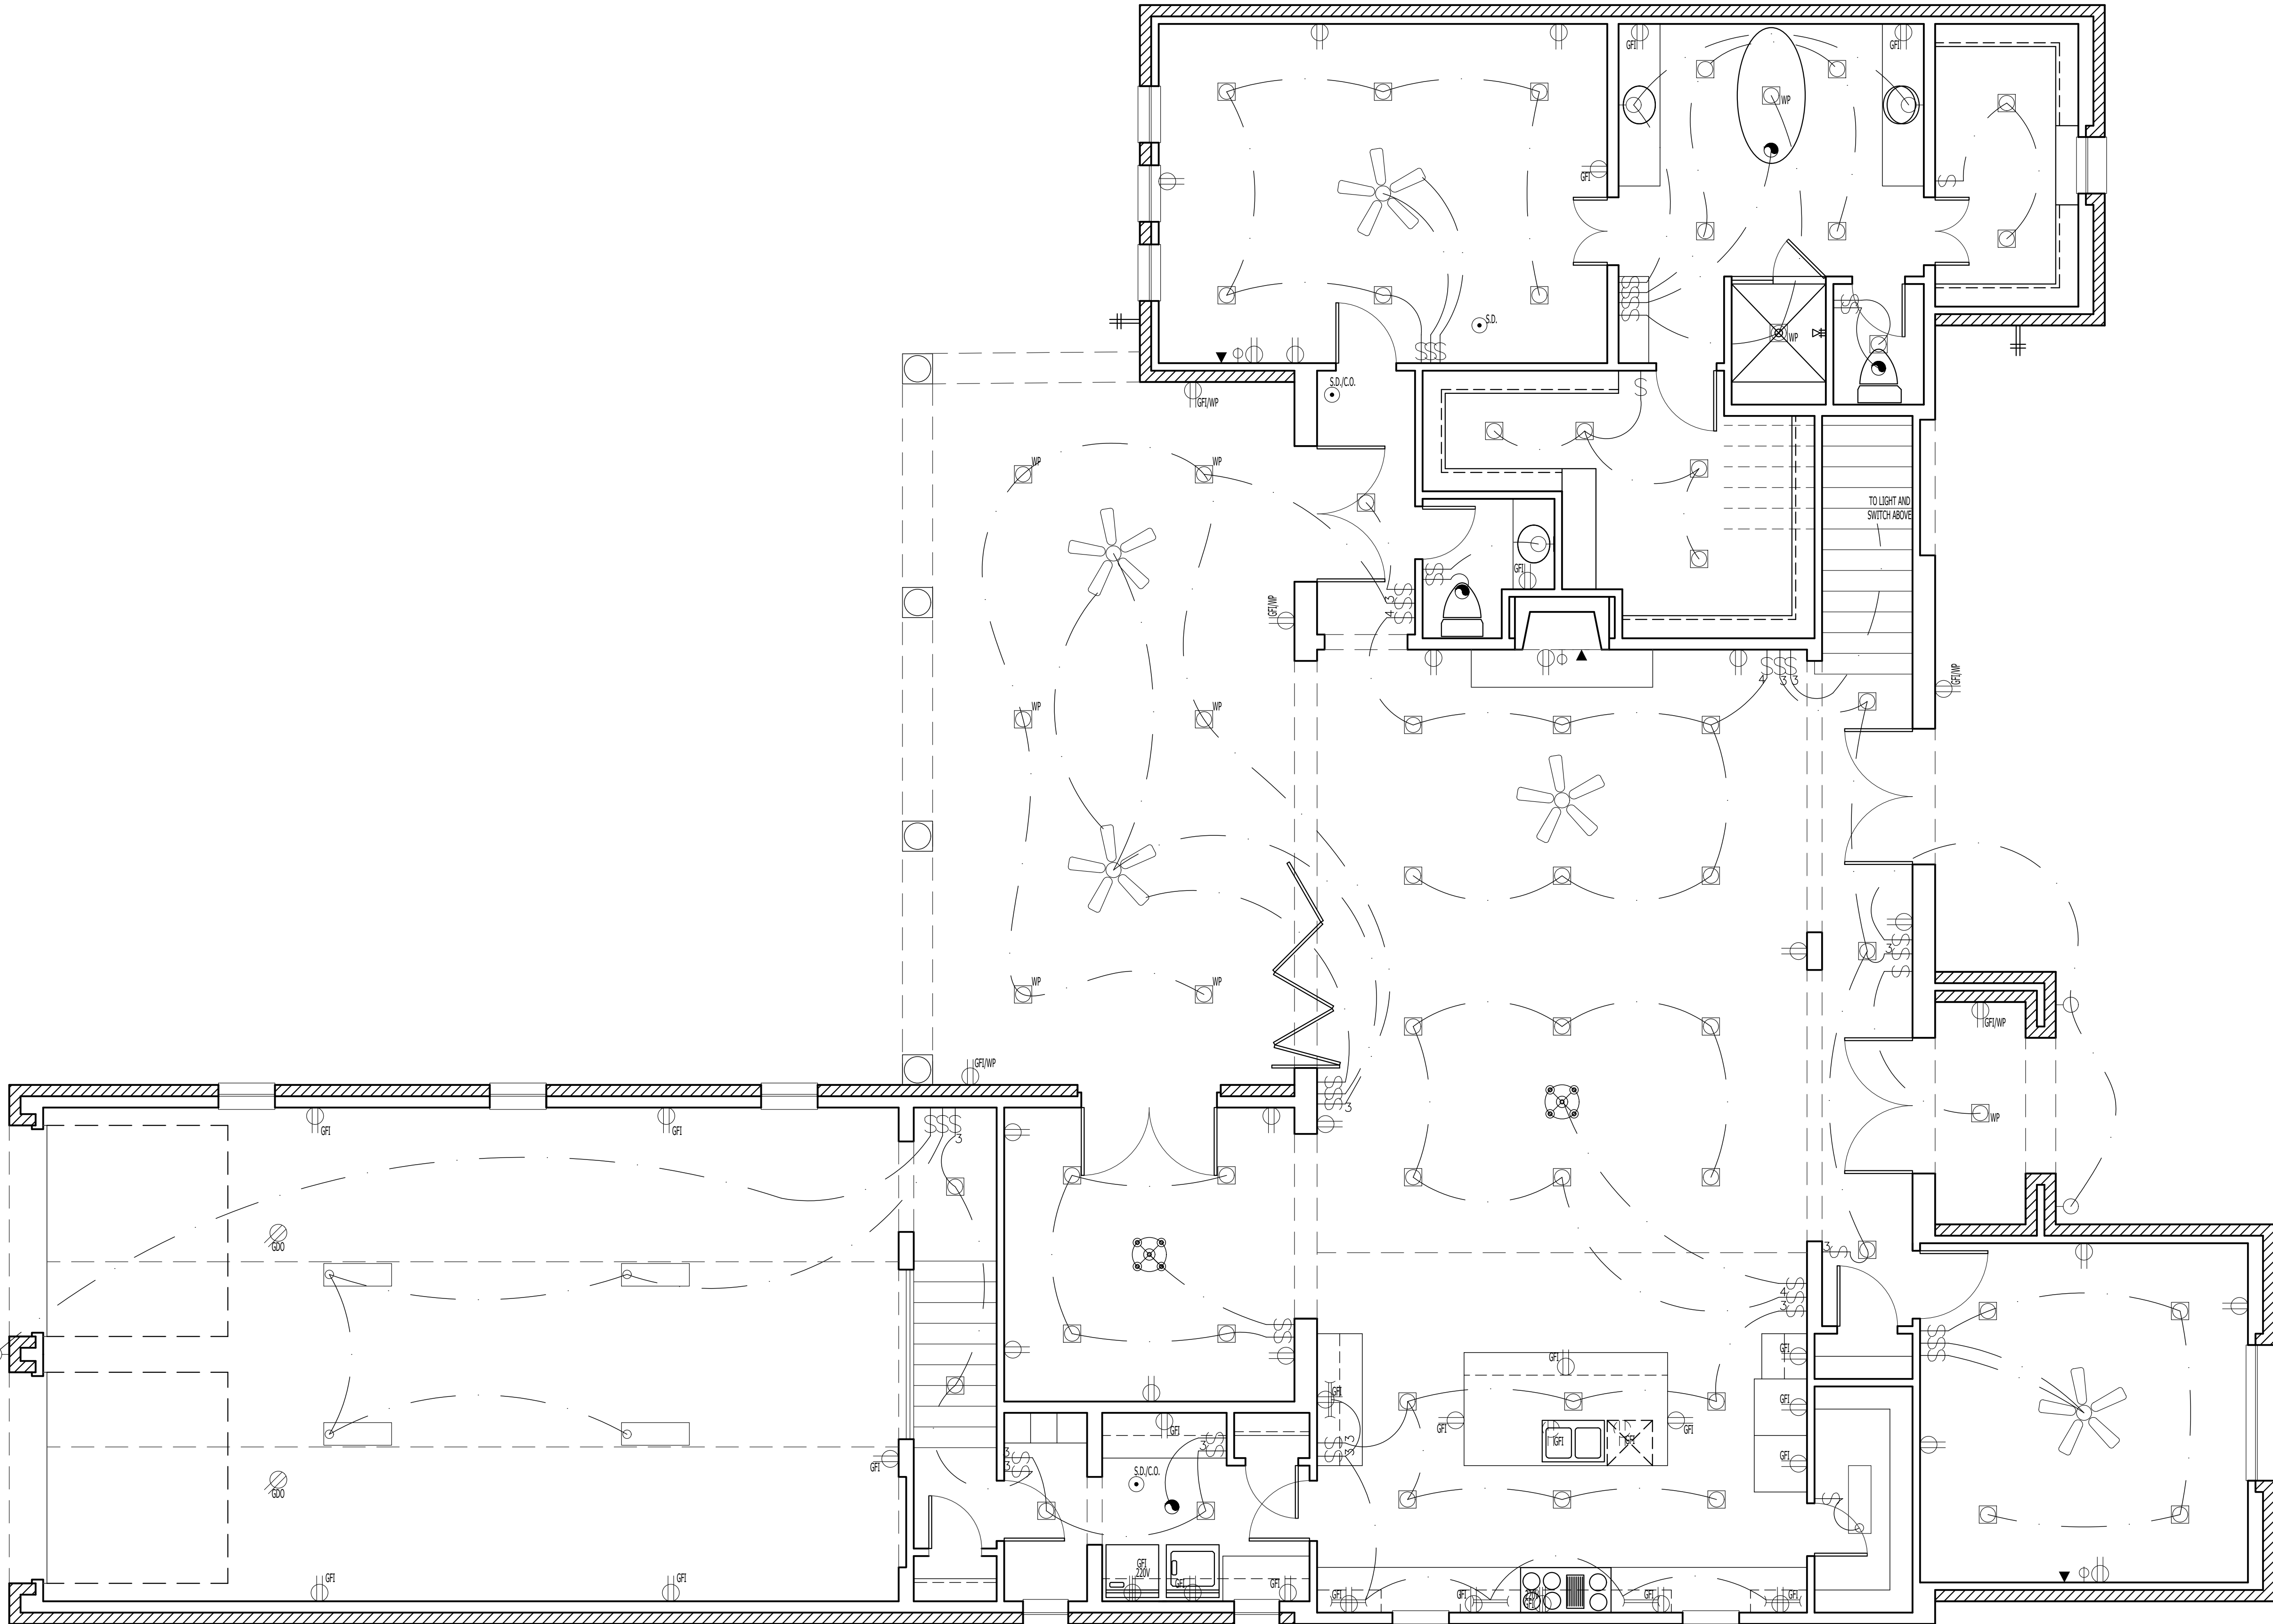

01 FIRST FLOOR ELECTRICAL PLAN
A104 SCALE: 1/4"=1'-0"

REFER TO **ENTRADA DESIGN GUIDELINES** FOR FUTHER DETAILED INFORMATION REGARDING THESE PLANS

ENTRADA

LOT 02, BLOCK H

TOWN OF WESTLAKE TARRANT COUNTY, TEXAS

ISSUE LOG

NO.	DESCRIPTION	DATE

PROJECT NO:	20-130
ISSUED FOR:	OTP
DRAWN BY:	Checker
DATE:	06/16/21

FIRST FLOOR
ELECTRICAL PLAN

A104

ELECTRICAL NOTES

- ELECTRICAL INSTALLATION SHALL MEET REQUIREMENTS OF APPROVED CODES AND REGULATIONS.
- VERIFY UTILITIES AND LOCATIONS WITH CONTRACTOR.
- SWITCHED CONVENIENCE OUTLETS TO BE SWITCHED AT TOP OUTLET ONLY.
- SWITCHES: 4'-6" ABV. FINISHED FLOOR TO CENTERLINE OF SWITCH, UNLESS NOTED OTHERWISE.
- INTERIOR WALL MOUNTED BRACKET FIXTURES: 6'-6" ABV. FINISHED WALKING SURFACE TO CENTERLINE OF BRACKET, U.N.O.
- EXTERIOR WALL MOUNTED BRACKET FIXTURES: 7'-0" ABV. FINISHED WALKING SURFACE TO CENTERLINE OF BRACKET, U.N.O.
- SMOKE/CARBON MONOXIDE DETECTORS : COORDINATE W/ ALARM SYSTEM. DETECTORS TO COMPLY WITH GOVERNING CODES AND REGULATIONS.
- PROVIDE 220V JUNCTION BOX AND OTHER REQUIRED WIRING FOR HVAC UNITS. VERIFY LOCATION WITH CONTRACTOR.
- VERIFY ALL EQUIPMENT POWER REQUIREMENTS WITH THE MANUFACTURER AND/OR SUPPLIER.
- ALL EXTERIOR CONVENIENCE OUTLETS TO BE WATER PROOF AND ON A GROUND FAULT CIRCUIT.
- ALL OUTLETS SHALL BE COMBINATION TYPE AFCI AND SHALL BE TAMPER PROOF/RESISTENT.

ELECTRICAL SYMBOLS

LIGHT FIXTURES

CEILING MOUNTED

CEILING SPEAKER

WITH PULL CHAIN

LANDSCAPE LIGHT

WALL BRACKET - INTERIOR AND EXTERIOR

RECESSED IN CEILING OR SOFFIT

RECESSED "WALL WASHER" IN CEILING OR SOFFIT

FLUORESCENT FIXTURE

LOW VOLTAGE

UNDER CABINET LIGHT

RECESSED "PIN HOLE" IN CEILING OR SOFFIT

WALL MOUNTED FLOODLIGHT

CONVENIENCE OUTLETS

110V. DUPLEX OUTLET;
12" ABOVE FLOOR-TYP.

110V. FOURPLEX OUTLET;
12" ABOVE FLOOR-TYP.

42" DISTANCE ABOVE FLOOR;
OTHER THAN 12"

WPGFI WATERPROOF
GROUNDFAULT
OUTLET

GDO GARAGE DOOR
OPENER

GFI GROUNDFAULT
OUTLET

ARC ARC FAULT

SWITCHED OUTLET

FLOOR OUTLET

220V. OUTLET

SWITCHES

SINGLE POLE SWITCH

FOUR WAY SWITCH

THREE WAY SWITCH

DIMMER SWITCH

GENERAL

110V JUNCTION BOX

S.M.D./C.O. SMOKE DETECTOR/
CARBON MONOXIDE
DETECTOR

220V JUNCTION BOX

PUSH BUTTON

GARBAGE DISPOSAL

LANTERN

CHANDELIER

EXHAUST FAN

EXHAUST FAN W/ LIGHT

WALL EXHAUST FAN

CEILING FAN


ELECTRICAL PANEL

TELEVISION OUTLET

CEILING FAN W/ LIGHT

TELEPHONE/DATA OUTLET

FAUCET

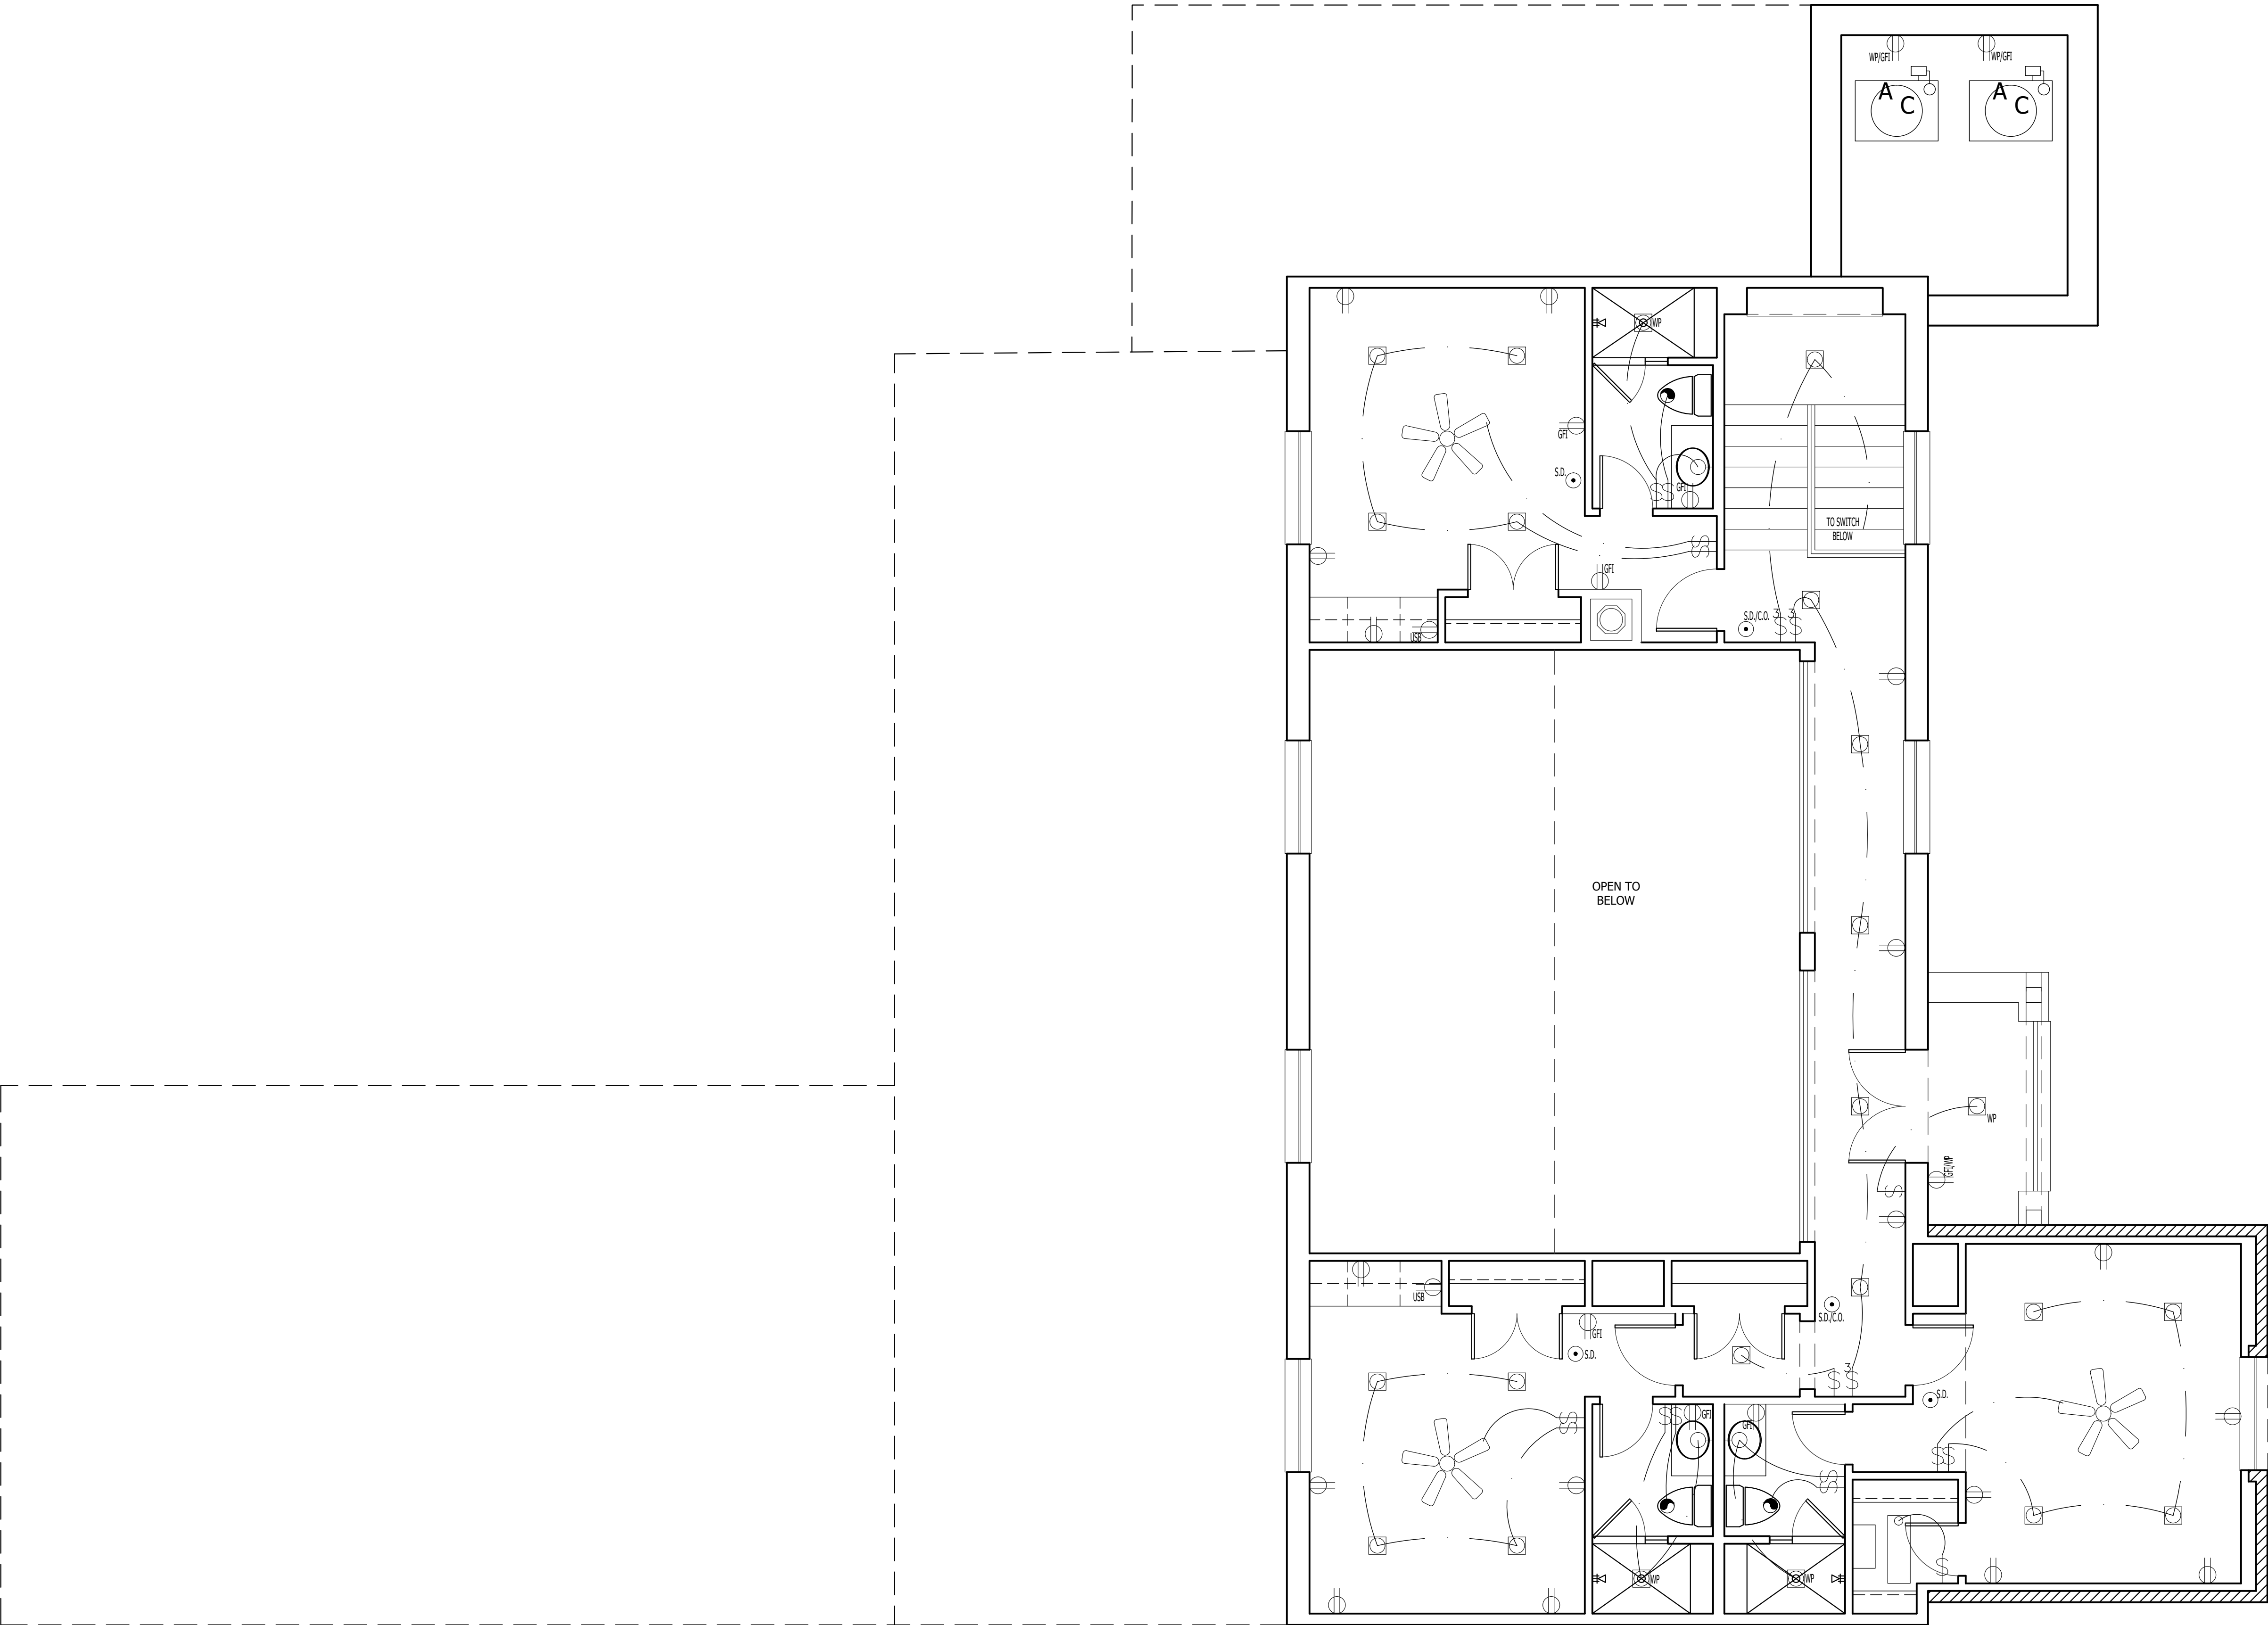

01 SECOND FLOOR ELECTRICAL PLAN
A105 SCALE: 1/4"=1'-0"

REFER TO **ENTRADA DESIGN GUIDELINES** FOR FUTHER DETAILED INFORMATION REGARDING THESE PLANS

ENTRADA

LOT 02, BLOCK H

TOWN OF WESTLAKE TARRANT COUNTY, TEXAS


ISSUE LOG

NO.	DESCRIPTION	DATE

PROJECT NO:	20-130
ISSUED FOR:	OTP
DRAWN BY:	Checker
DATE:	06/16/21

SECOND FLOOR
ELECTRICAL PLAN

A105

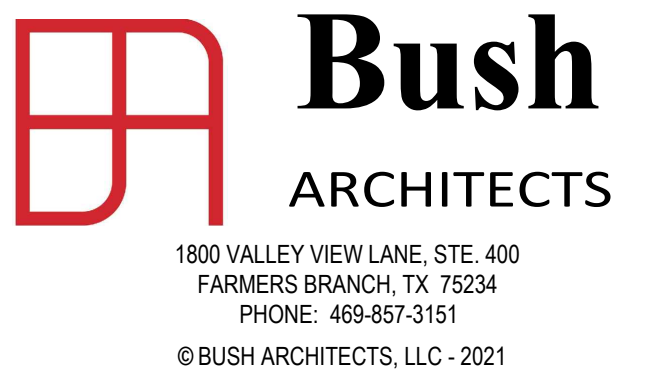

ENTRADA

LOT 02, BLOCK H

TOWN OF WESTLAKE TARRANT COUNTY, TEXAS


ISSUE LOG

[illegible]

PROJECT NO:	20-130
ISSUED FOR:	OTP
DRAWN BY:	Checker
DATE:	06/16/21

ROOF PLAN

A106

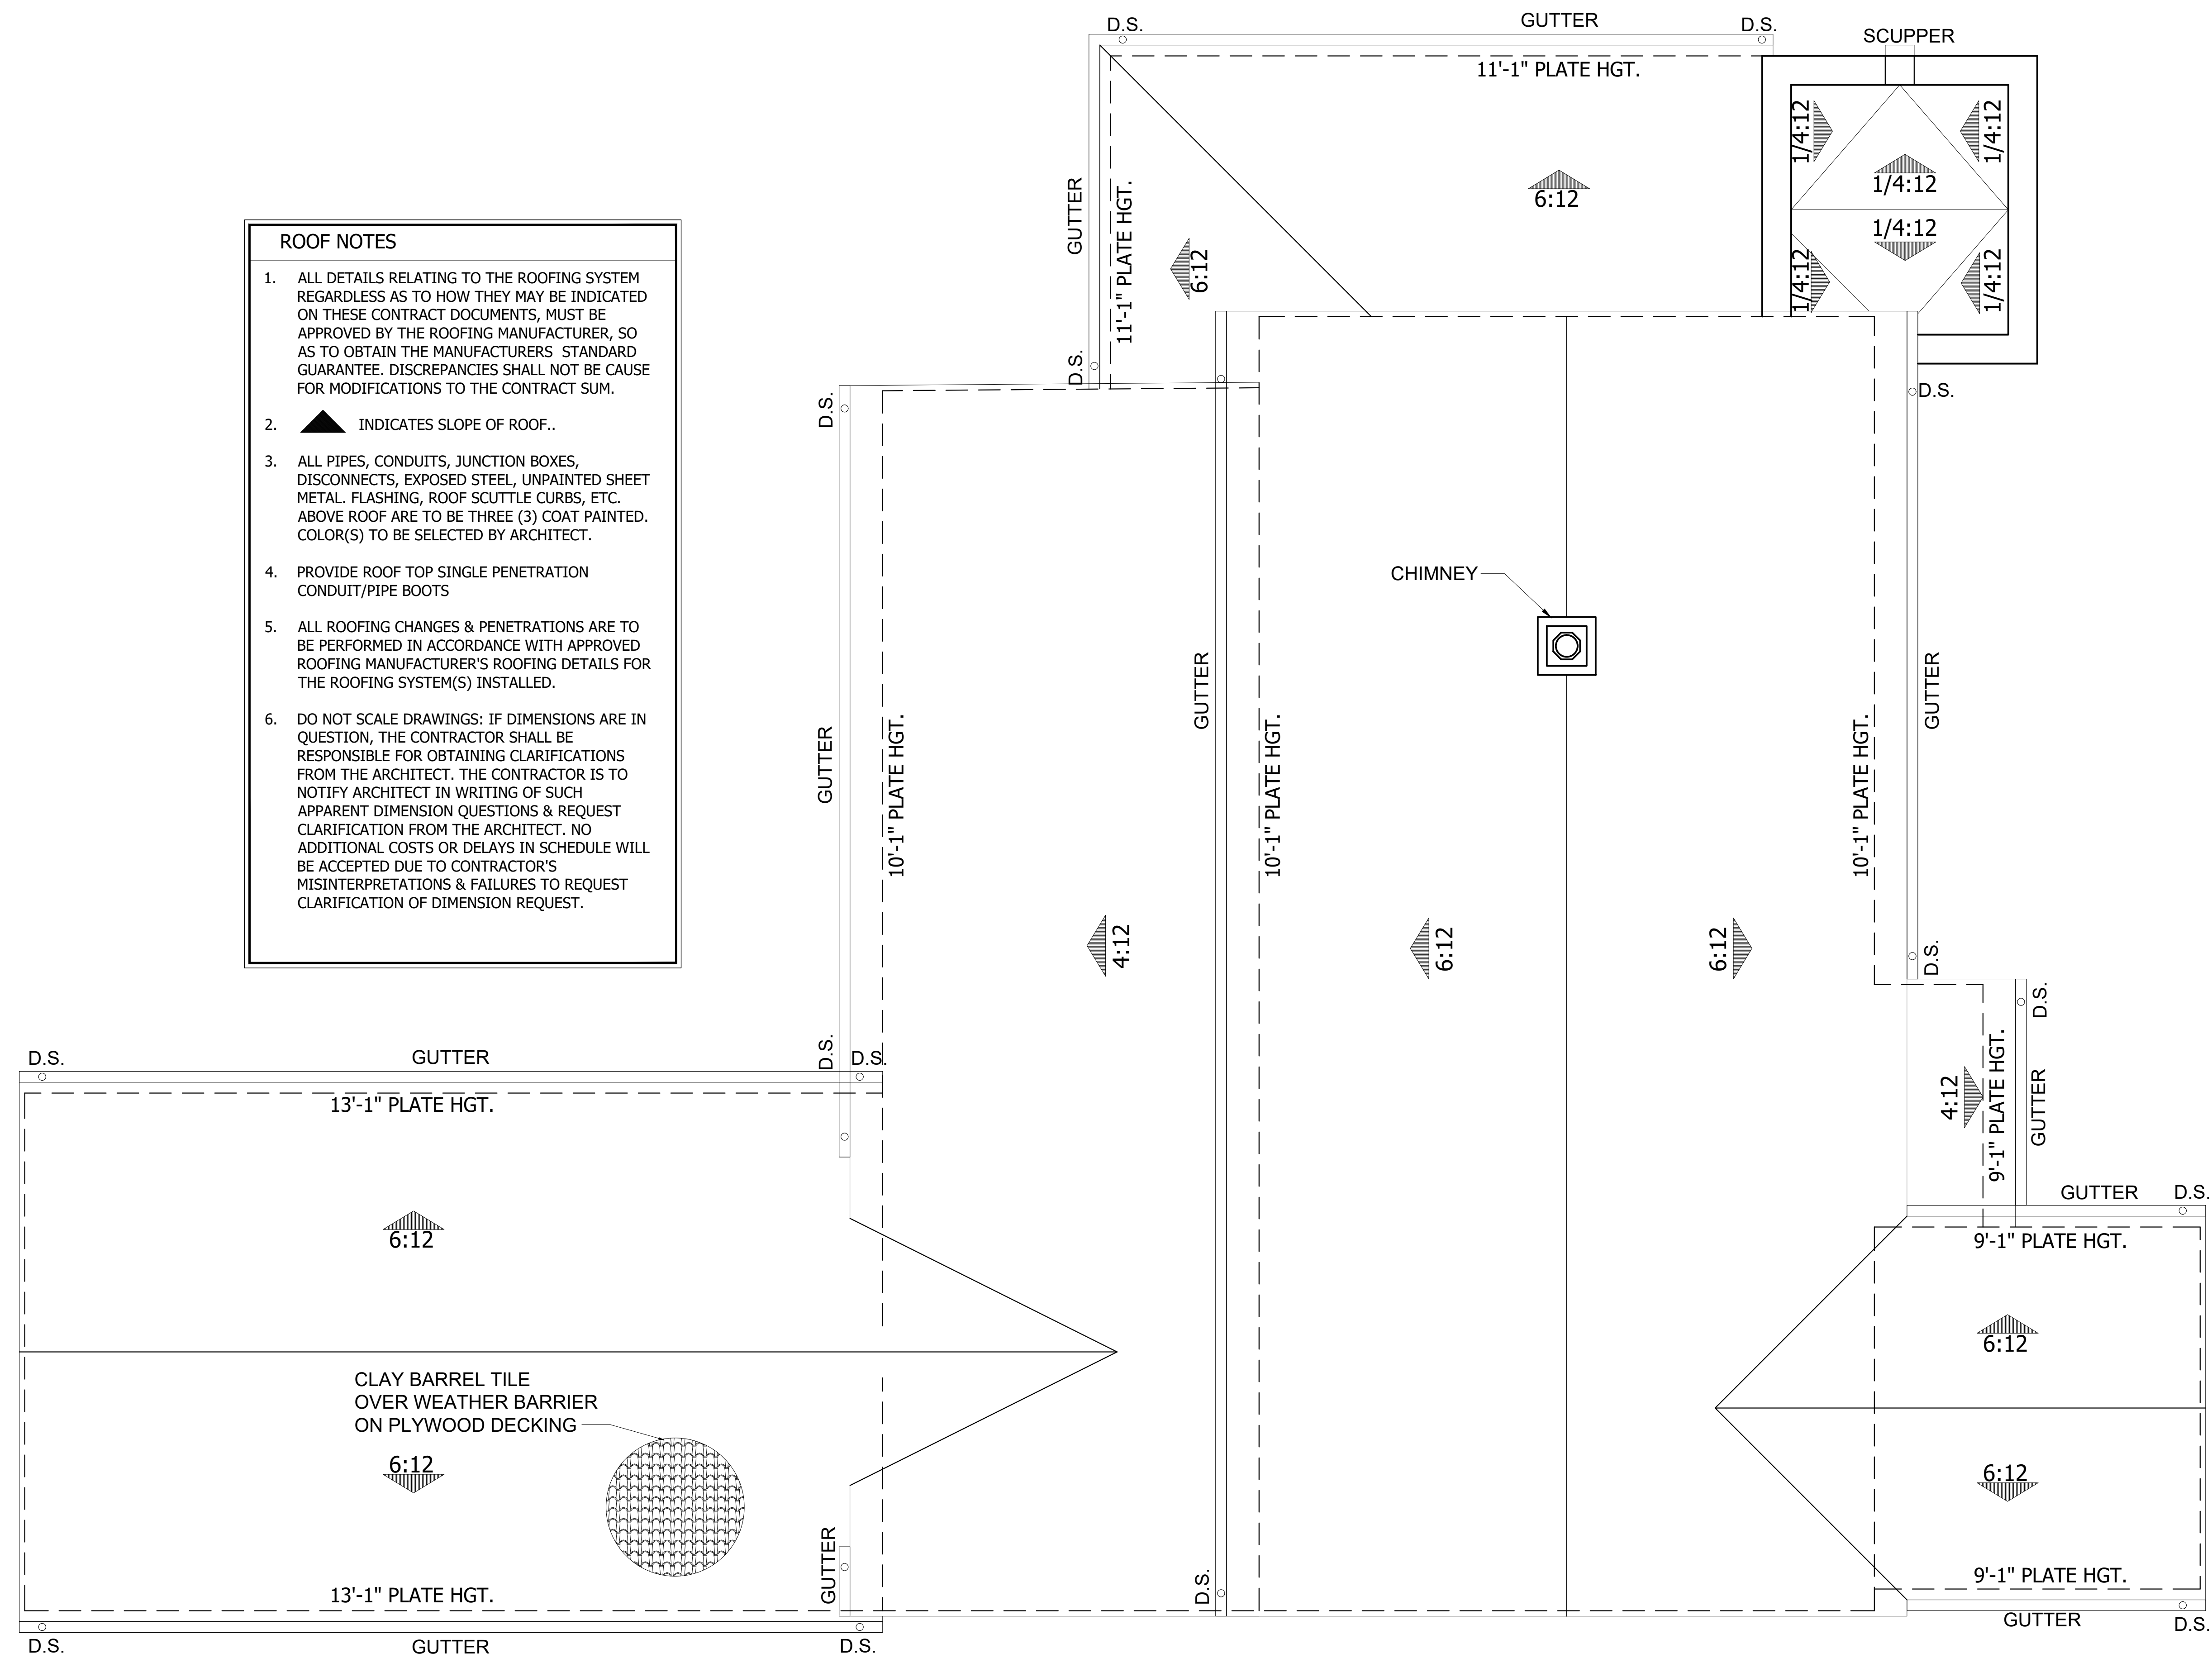

01 ROOF PLAN
A106 SCALE: 3/16"=1'-0"

REFER TO **ENTRADA DESIGN GUIDELINES** FOR FUTHER DETAILED INFORMATION REGARDING THESE PLANS

ENTRADA

LOT 02, BLOCK H

TOWN OF WESTLAKE TARRANT COUNTY, TEXAS



ISSUE LOG

NO.	DESCRIPTION	DATE

PROJECT NO: 20-130
ISSUED FOR: OTP
DRAWN BY: Checker
DATE: 06/16/21

FRONT & LEFT ELEVATIONS

A200

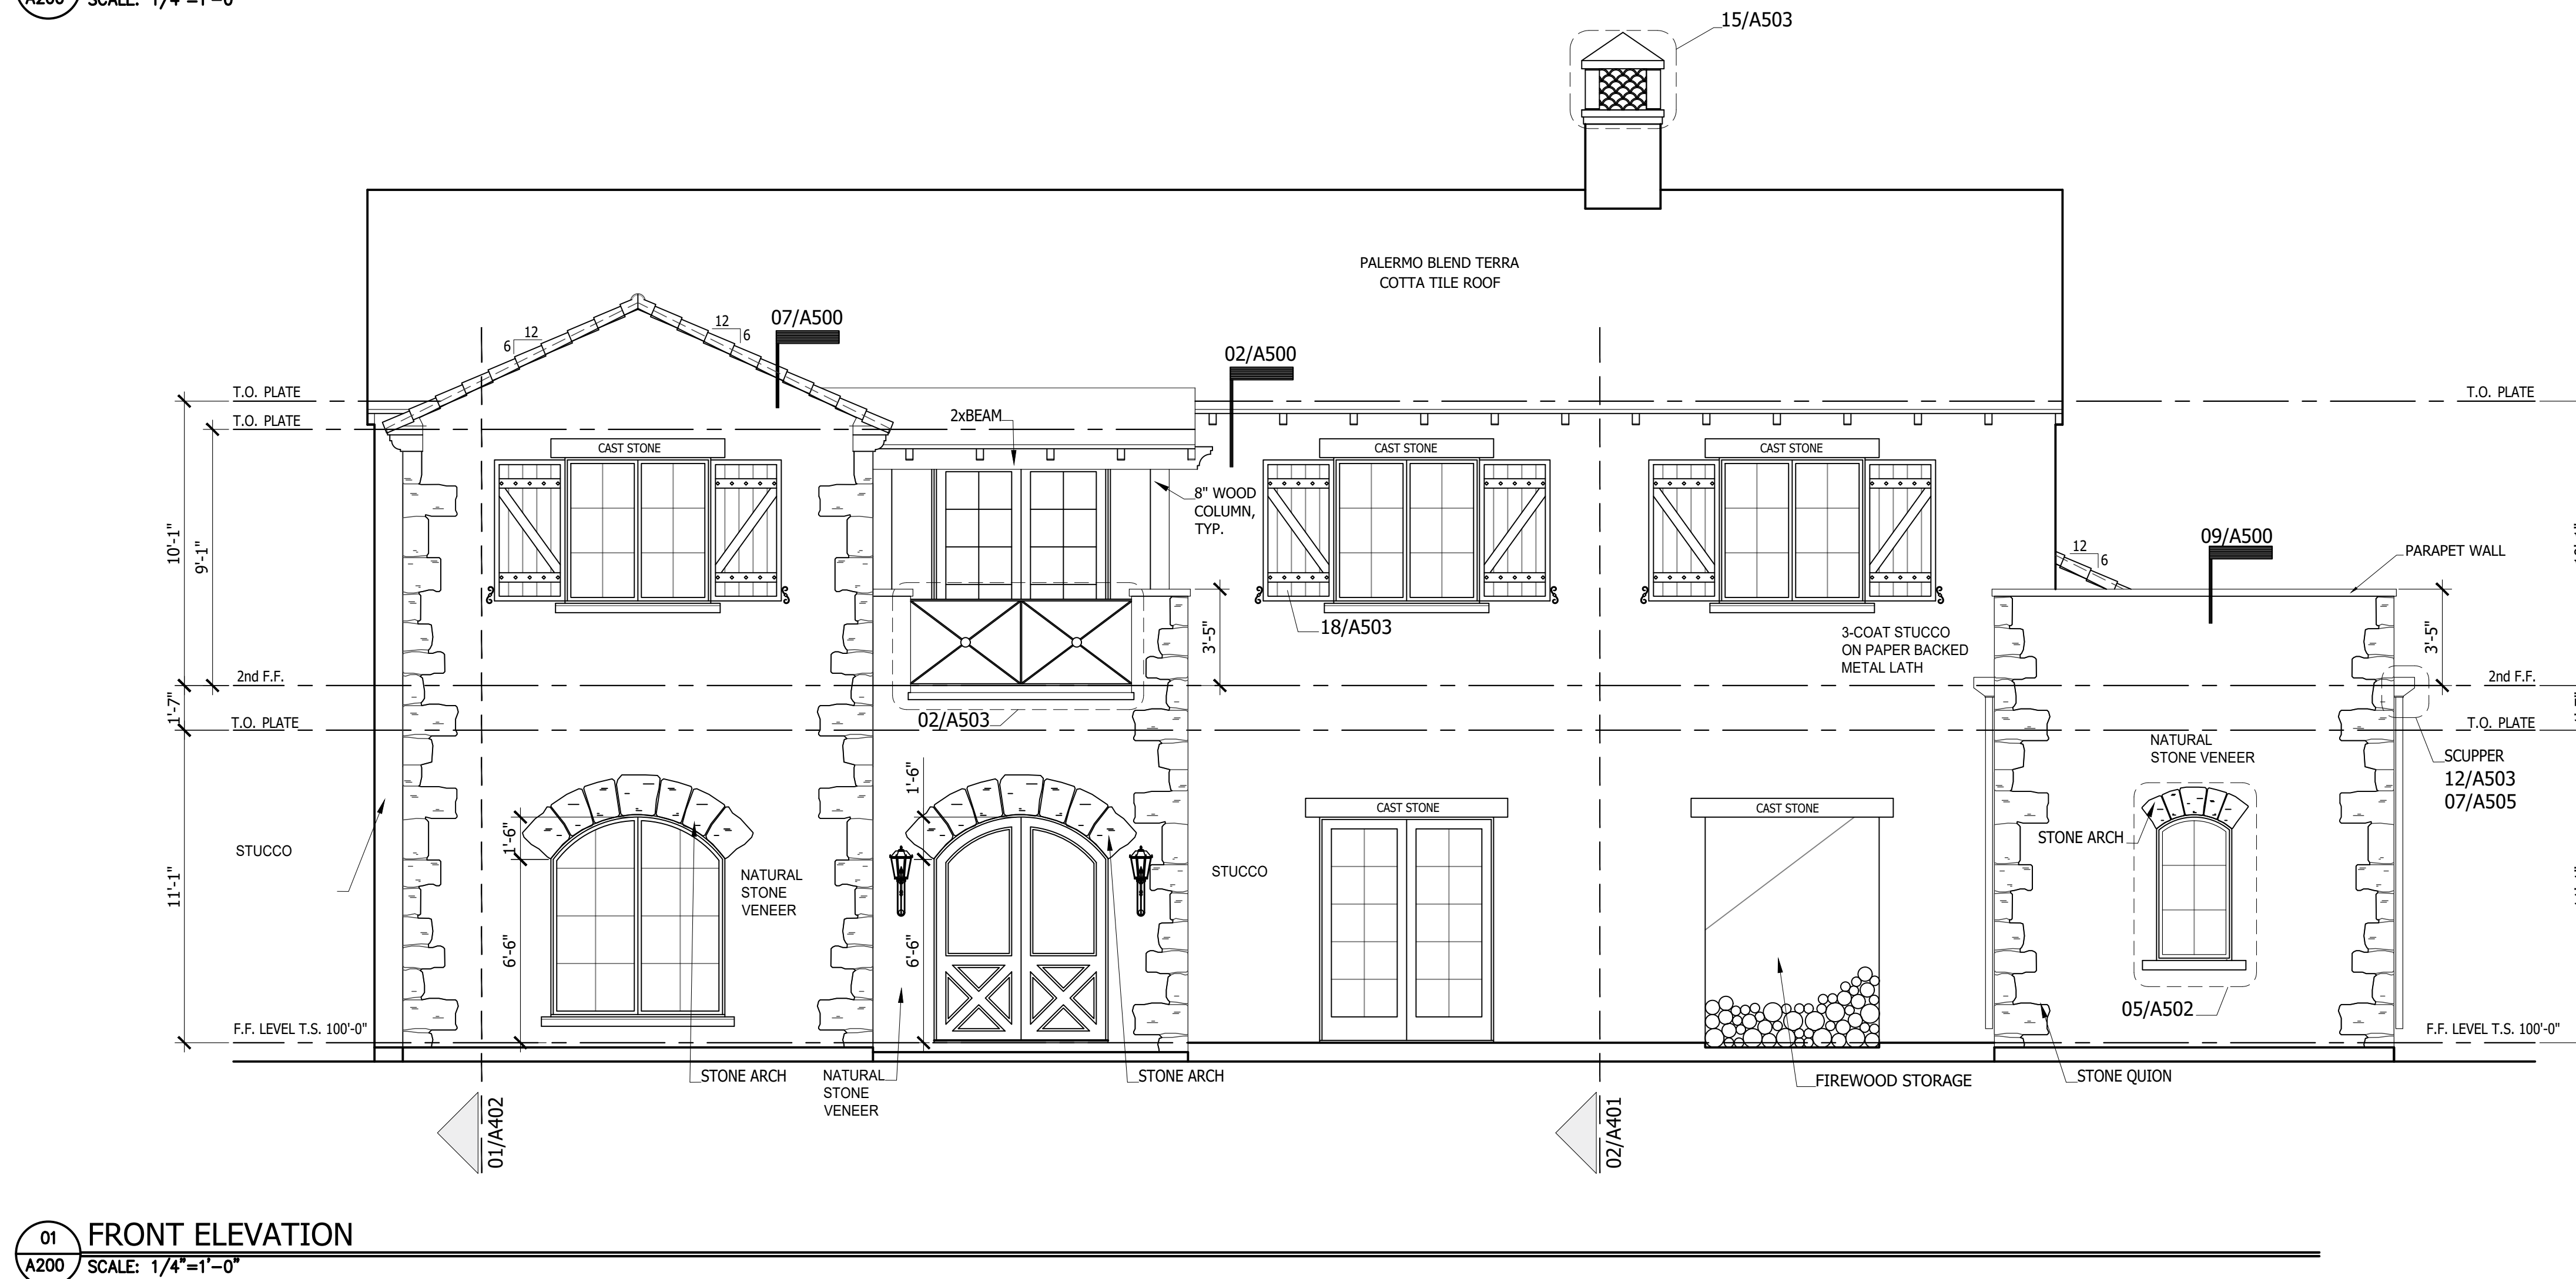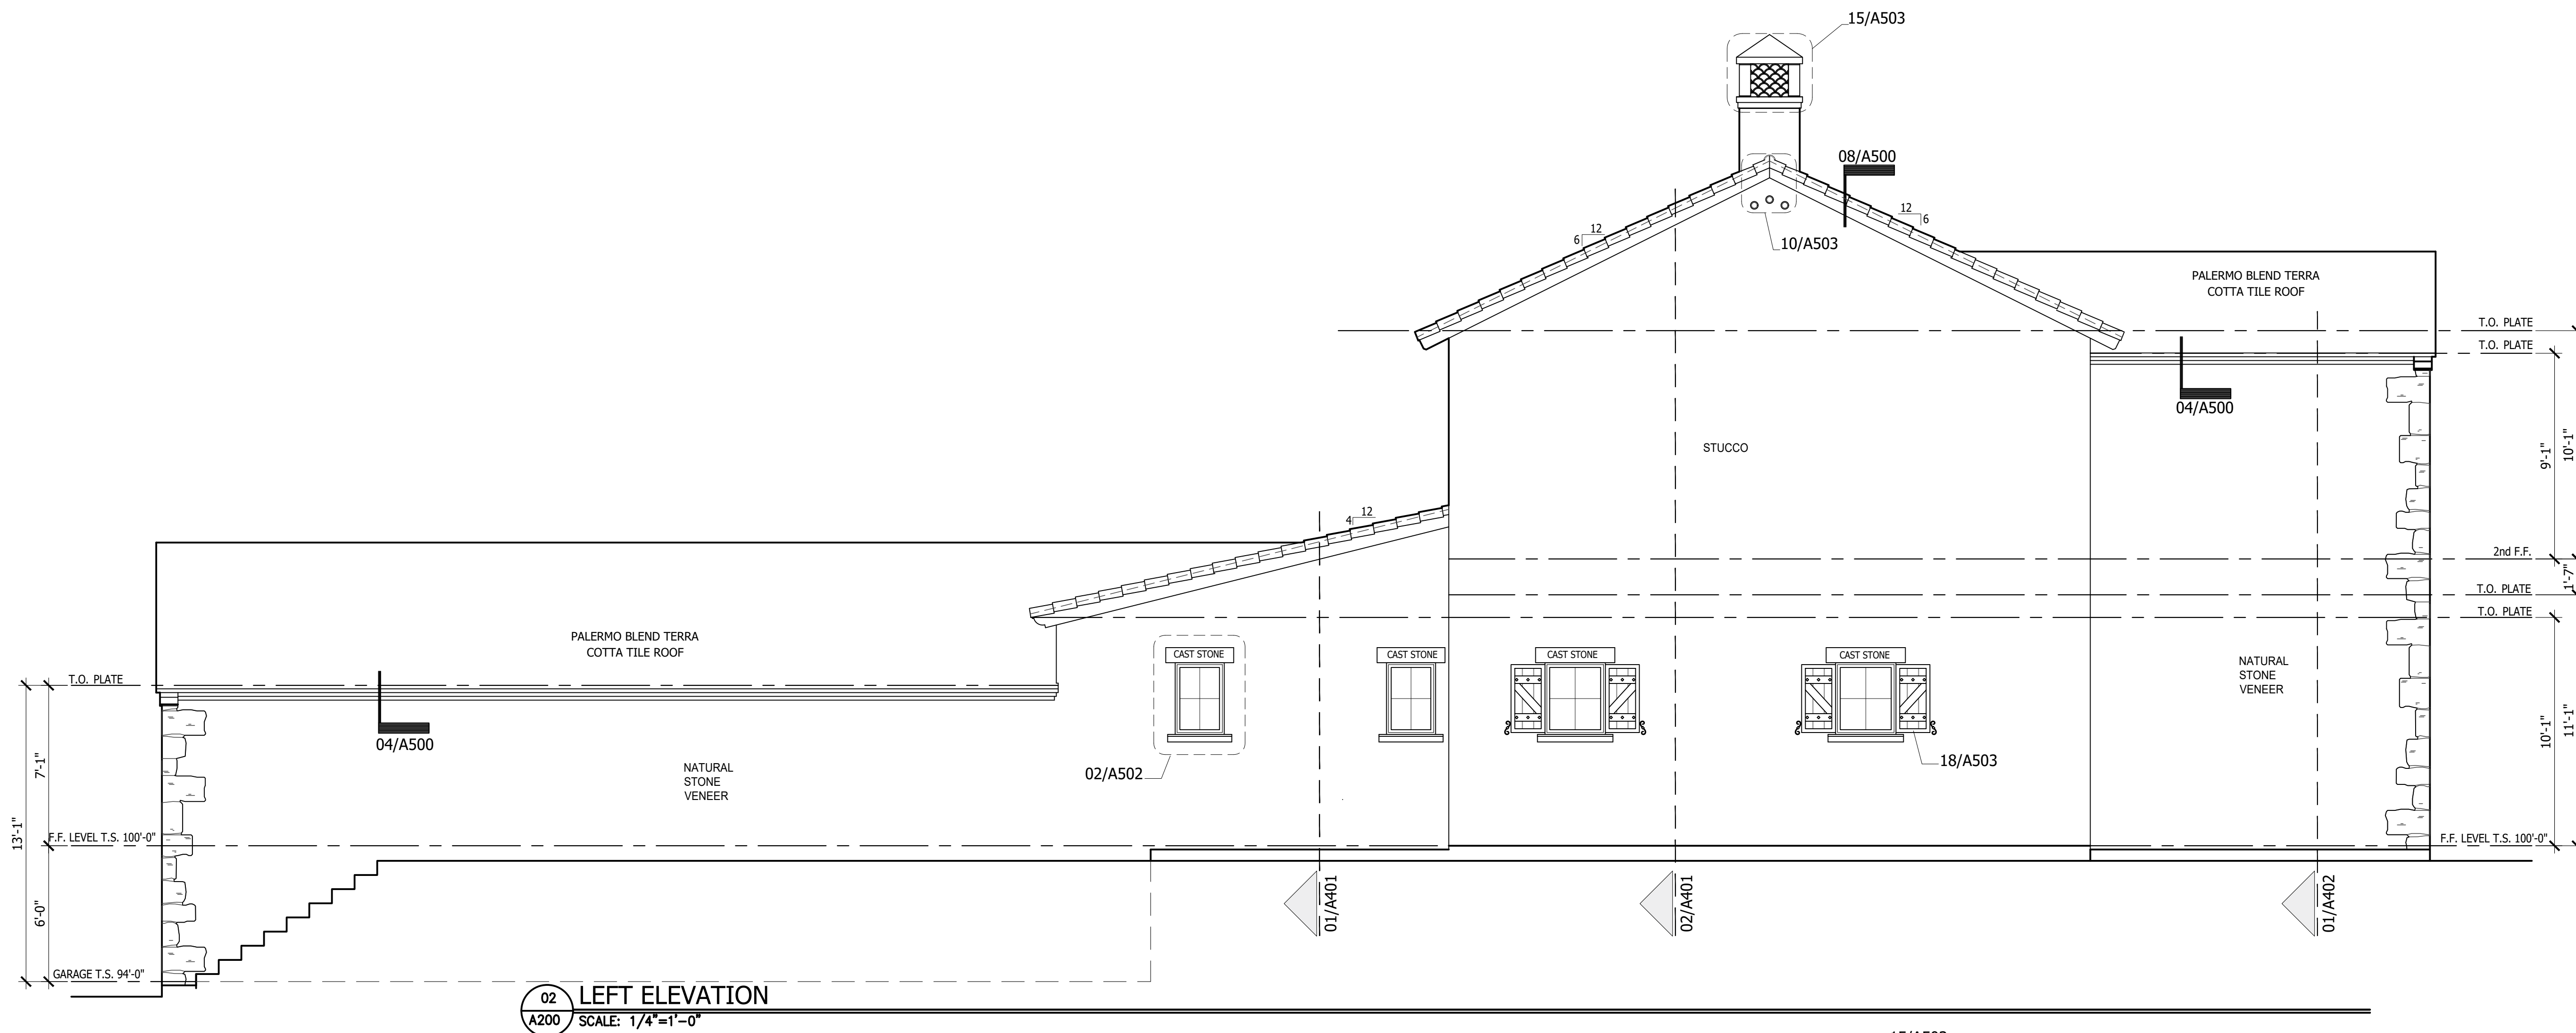

REFER TO **ENTRADA DESIGN GUIDELINES** FOR FUTHER DETAILED INFORMATION REGARDING THESE PLANS

ENTRADA

LOT 02, BLOCK H

TOWN OF WESTLAKE TARRANT COUNTY, TEXAS


ISSUE LOG

NO.	DESCRIPTION	DATE


PROJECT NO: 20-130
ISSUED FOR: OTP
DRAWN BY: Checker
DATE: 06/16/21

REAR & RIGHT ELEVATIONS

A201

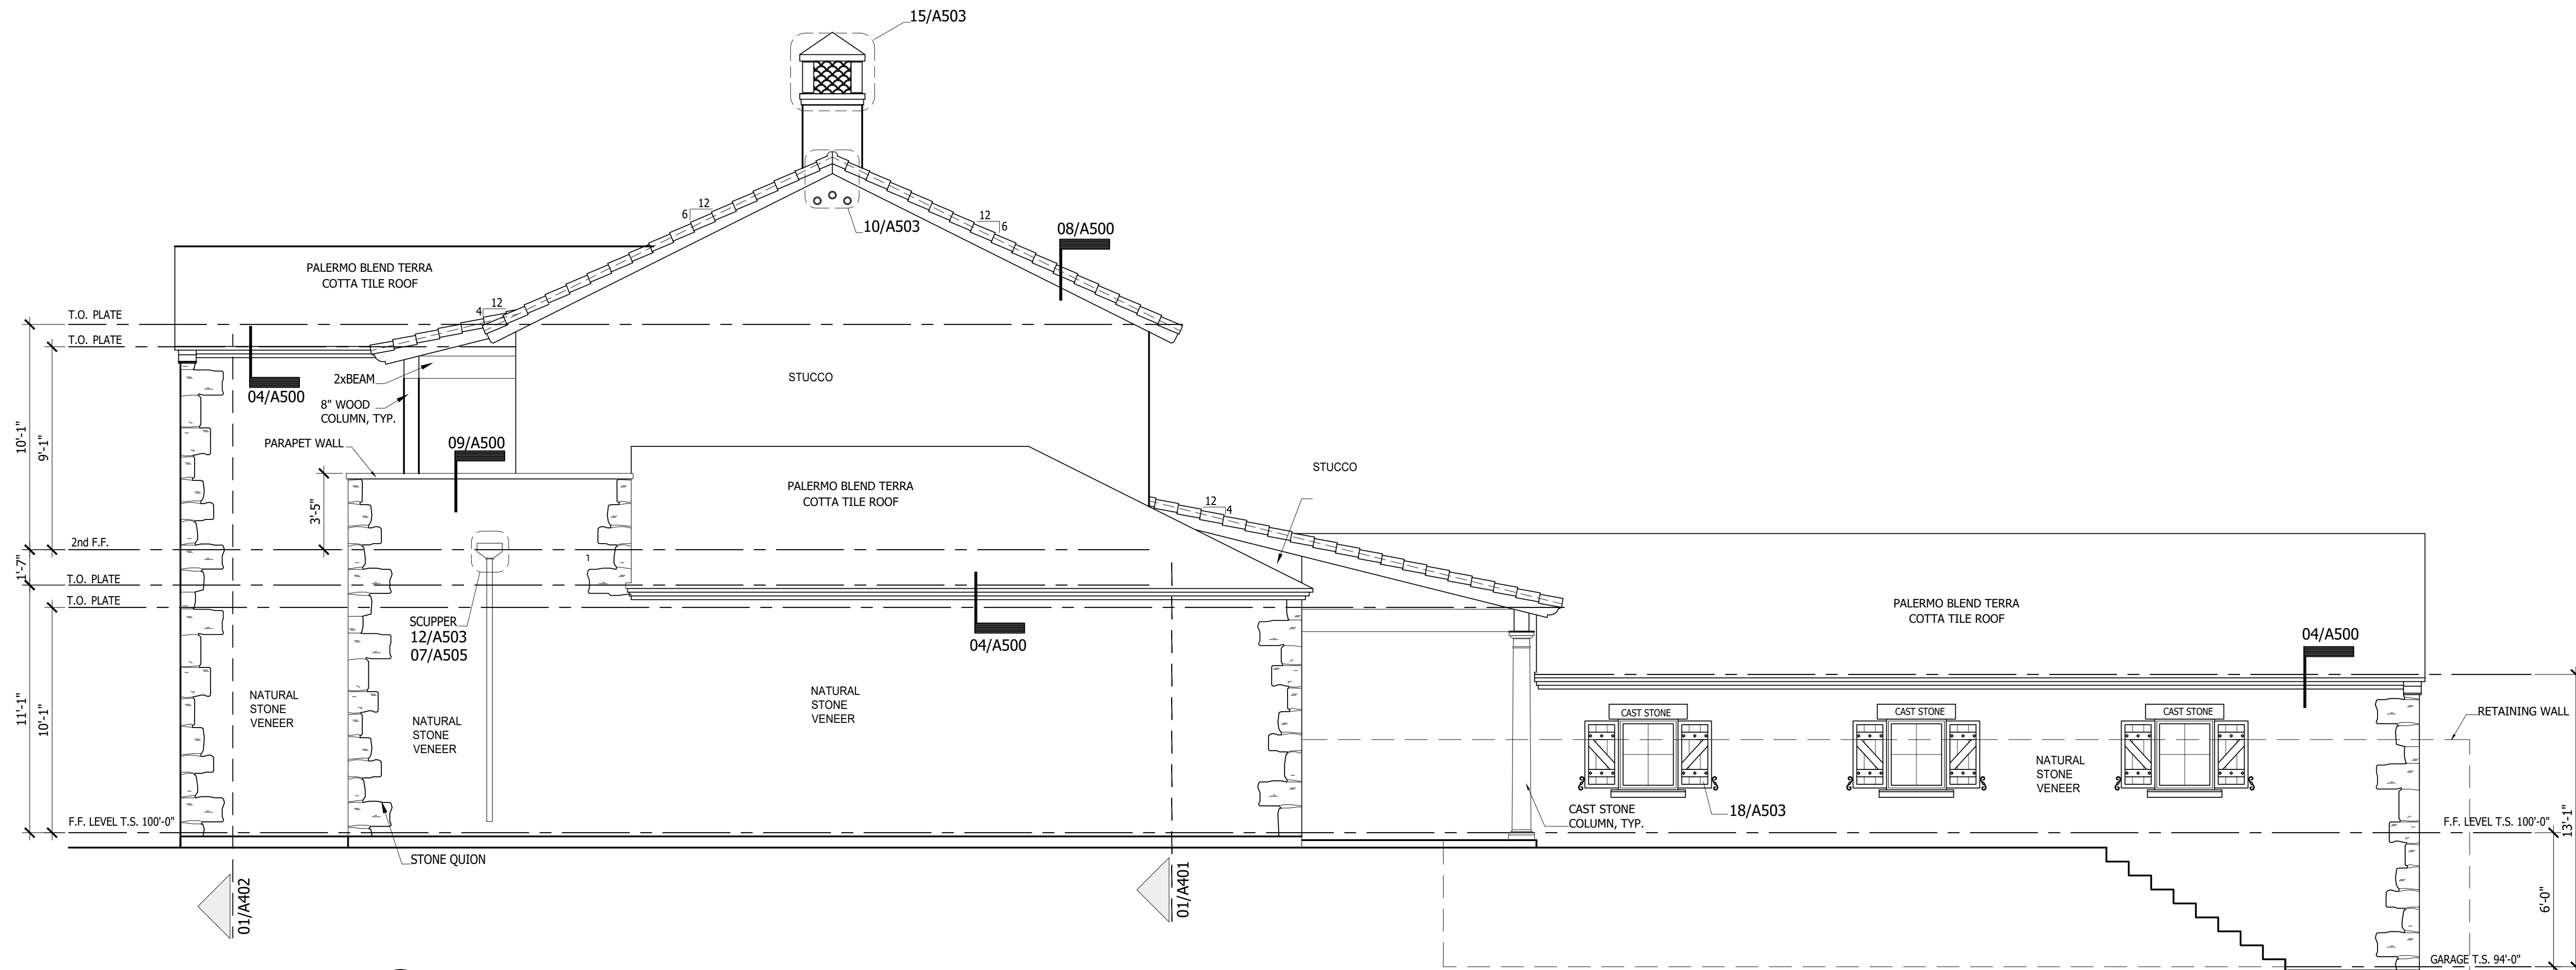

02 RIGHT ELEVATION
A201 SCALE: 1/4"=1'-0"

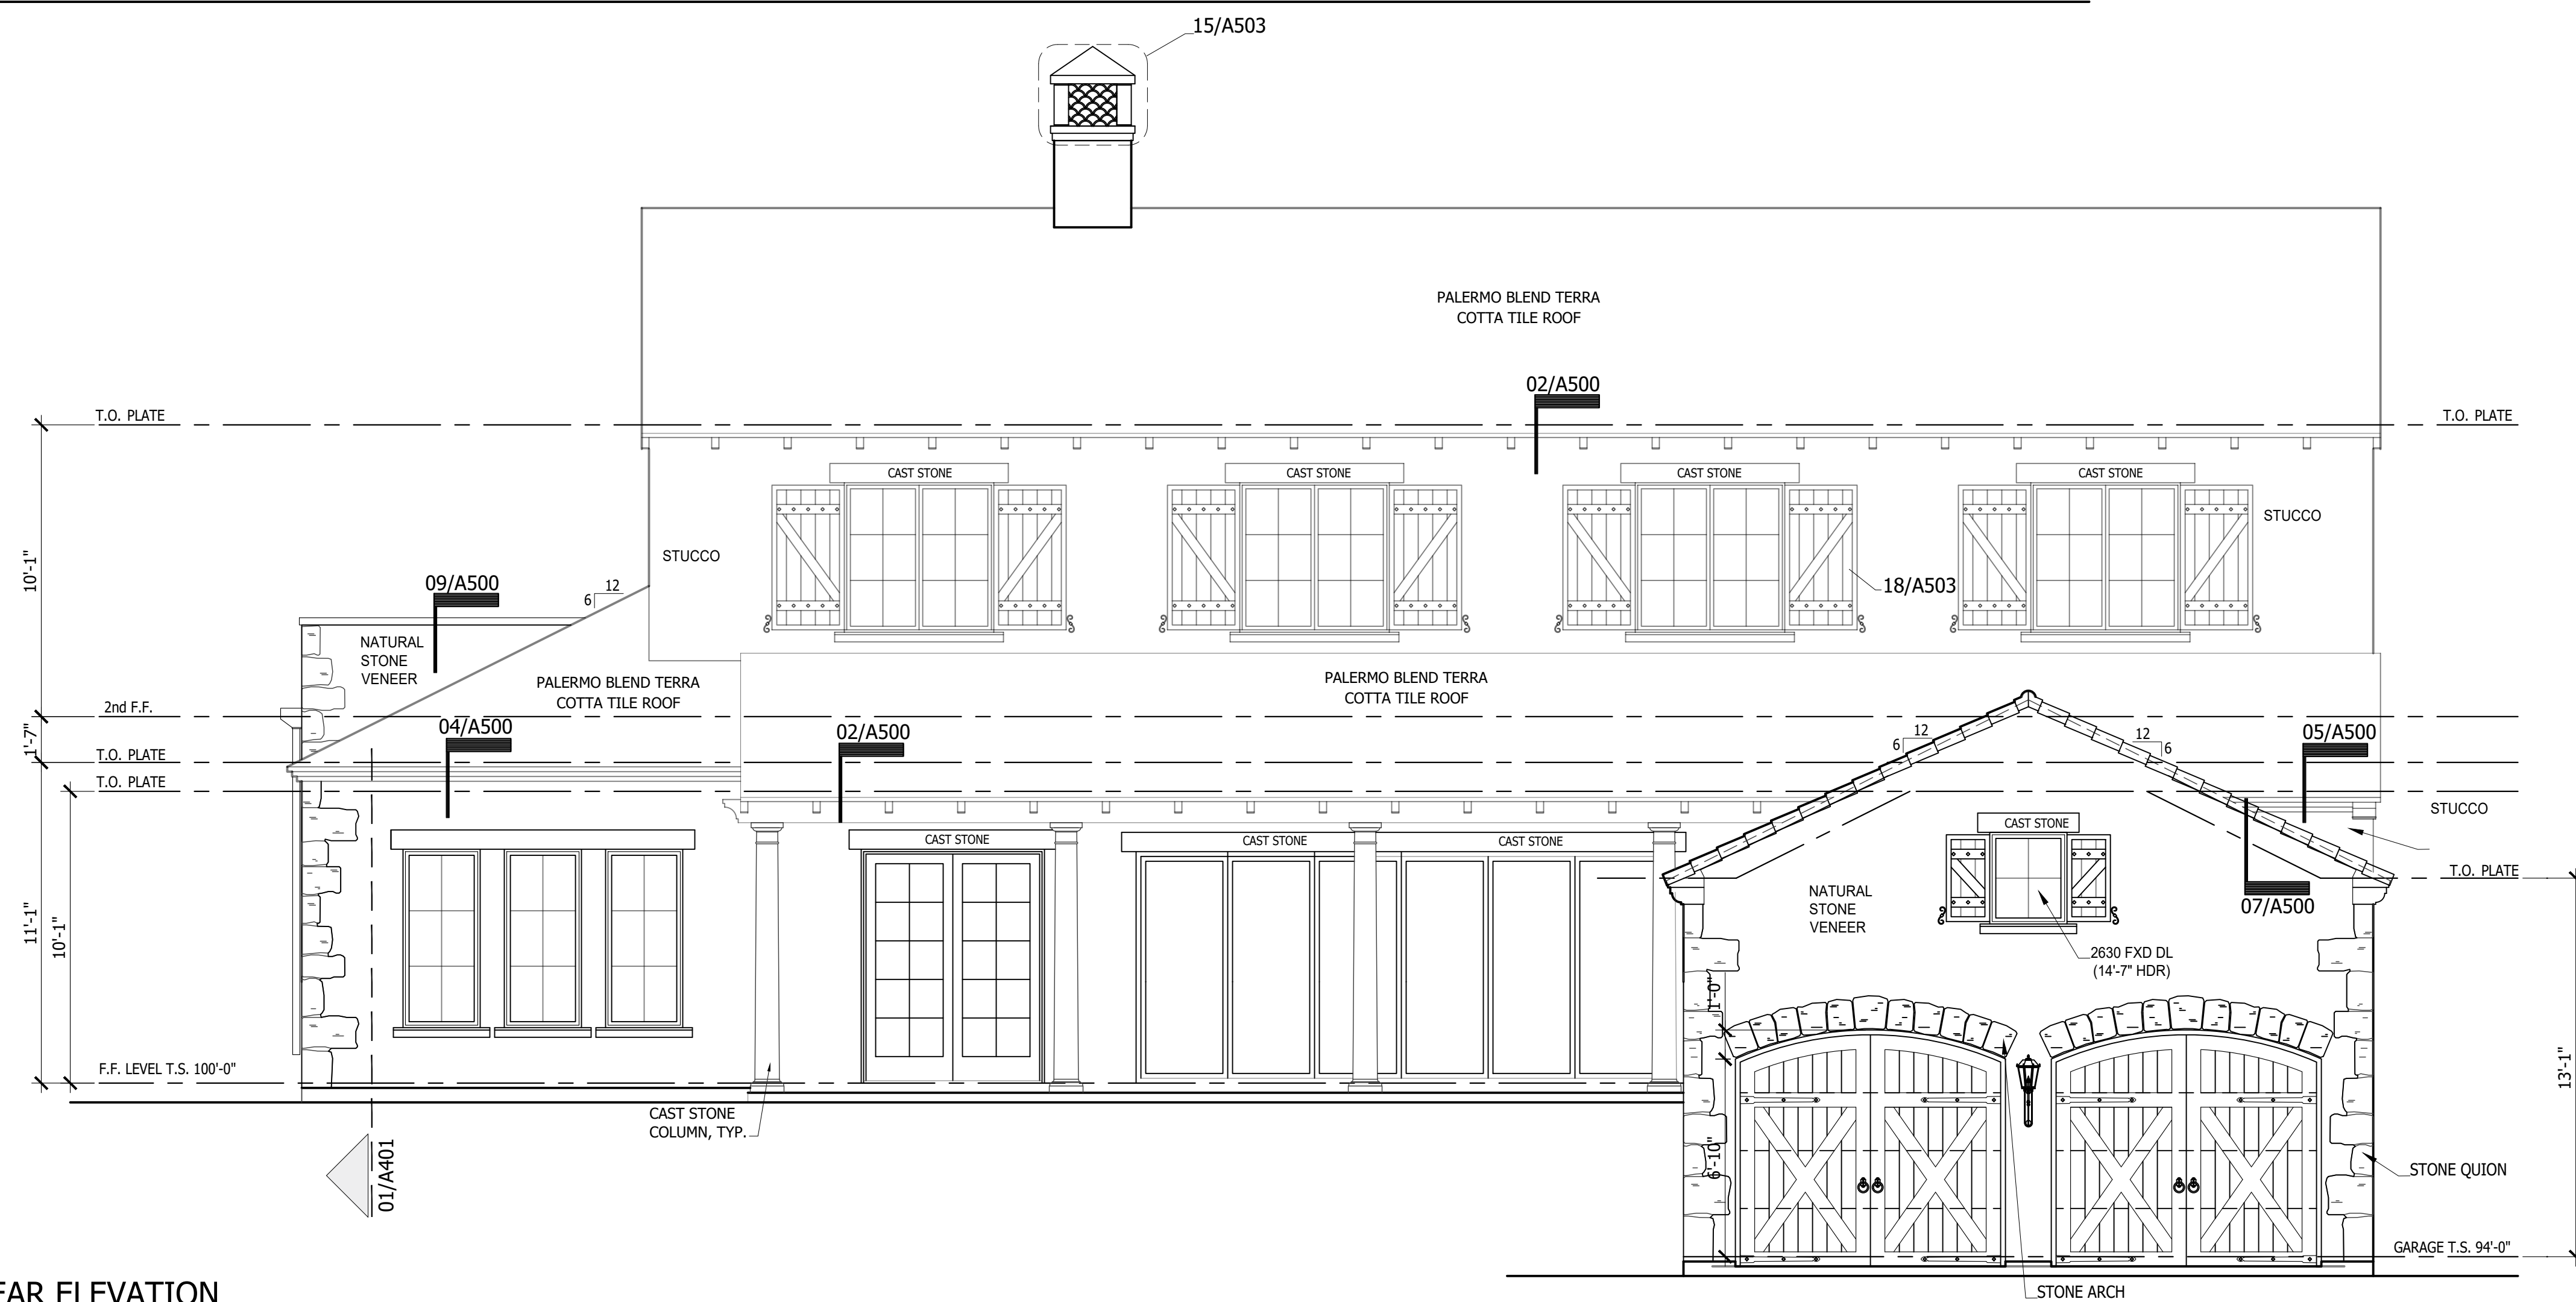

01 REAR ELEVATION
A201 SCALE: 1/4"=1'-0"


REFER TO **ENTRADA DESIGN GUIDELINES** FOR FUTHER DETAILED INFORMATION REGARDING THESE PLANS




ENTRADA

LOT 02, BLOCK H


TOWN OF WESTLAKE TARRANT COUNTY, TEXAS

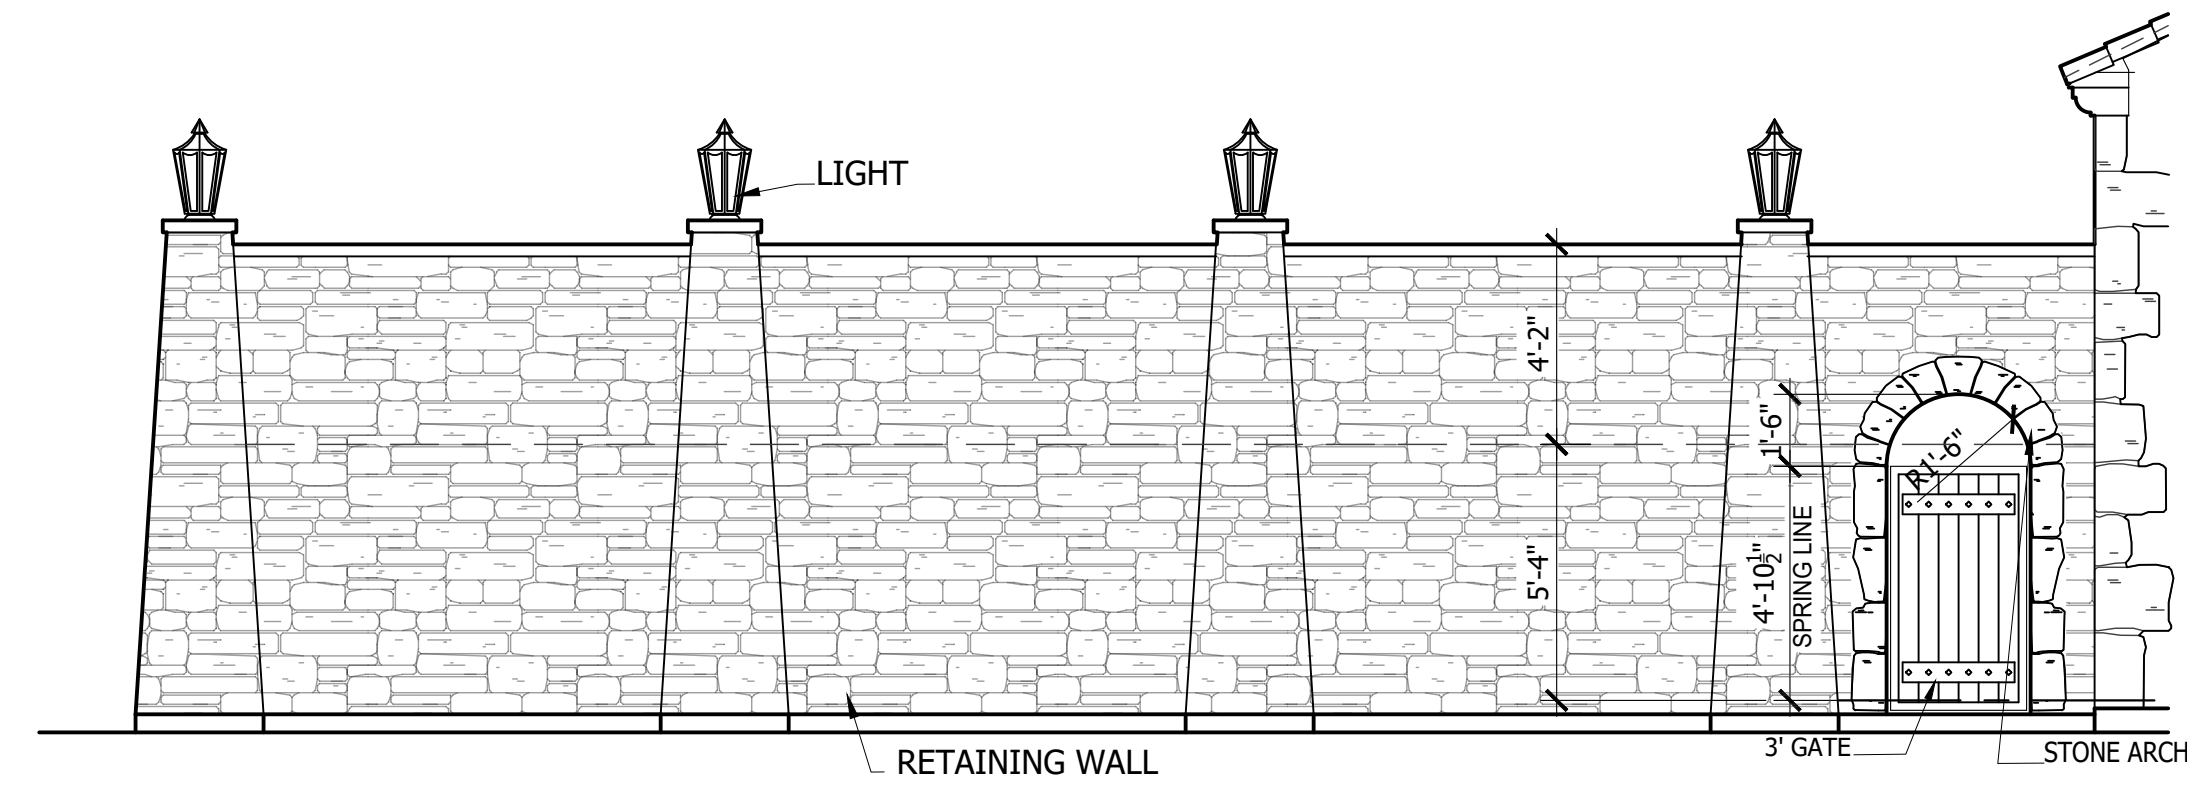


04 RETAINING WALL REAR ELEVATION
A202 SCALE: 1/4"=1'-0"

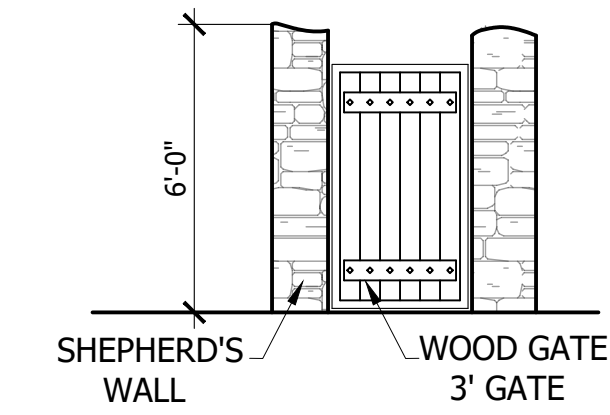


05 SHEPARD'S WALL
A202 SCALE: 1/4"=1'-0"

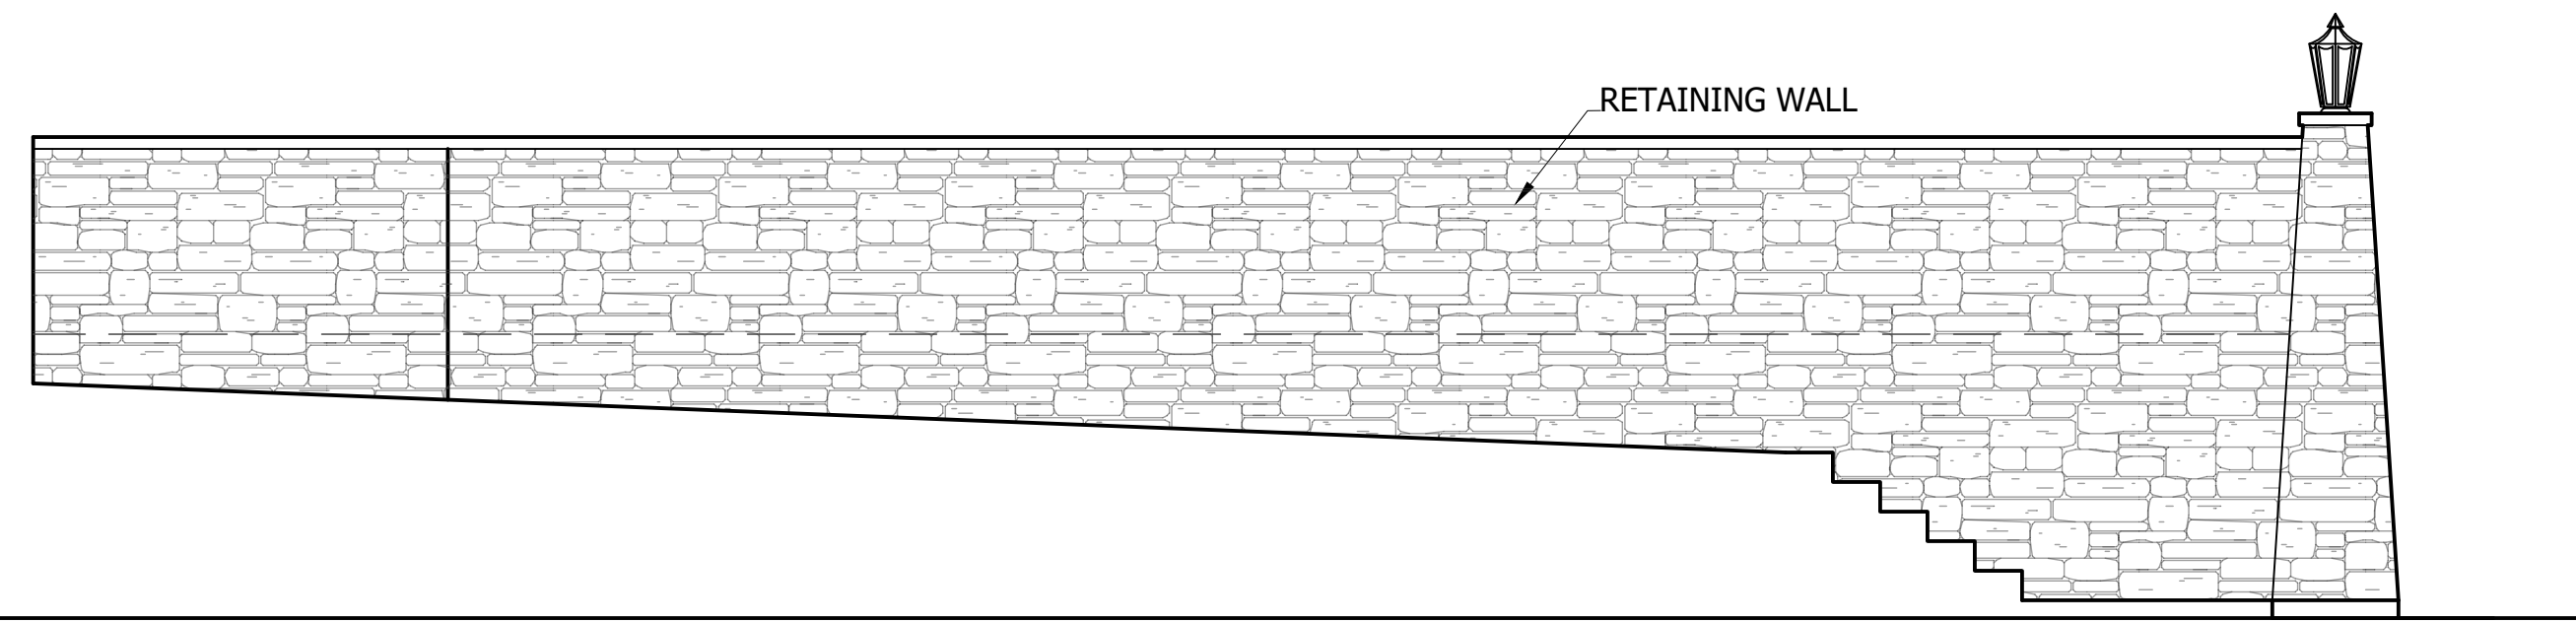

03 RETAINING WALL SIDE ELEVATION
A202 SCALE: 1/4"=1'-0"

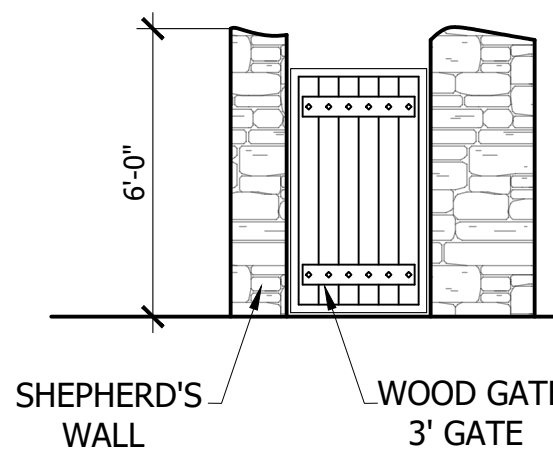

02 SHEPHERD'S WALL FRONT ELEVATION
A202 SCALE: 1/4"=1'-0"

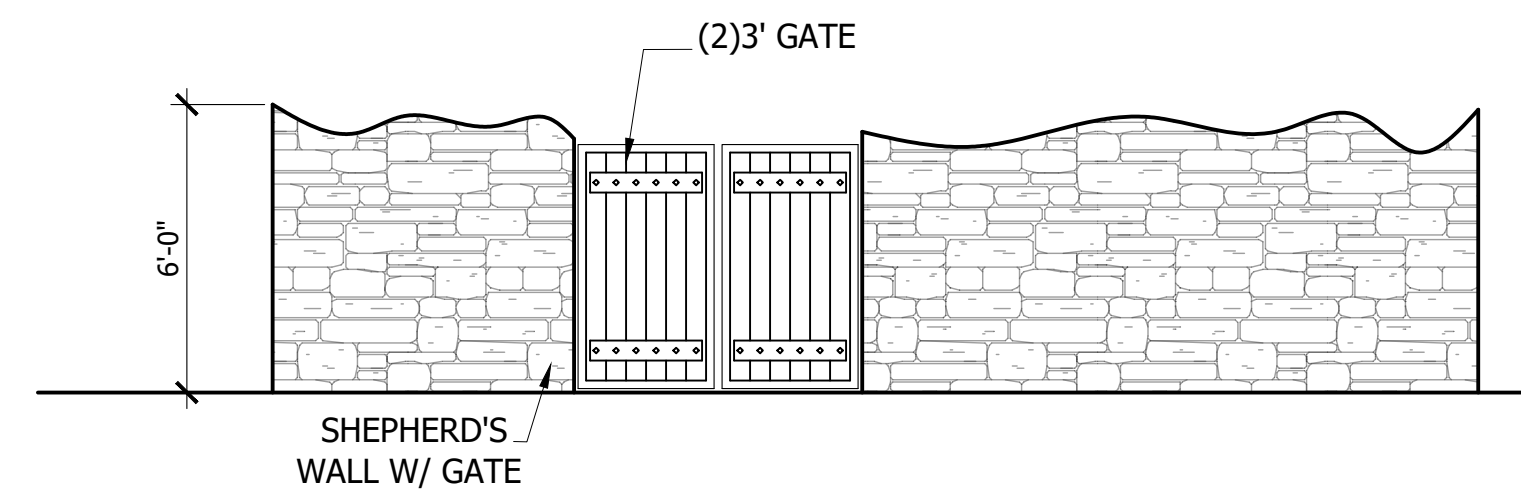

01 SHEPHERD'S WALL FRONT ELEVATION
A202 SCALE: 1/4"=1'-0"

ISSUE LOG

[illegible]

PROJECT NO:	20-130
ISSUED FOR:	OTP
DRAWN BY:	Checker
DATE:	06/16/21

SHEPHERD'S WALL ELEVATIONS

A202

REFER TO **ENTRADA DESIGN GUIDELINES** FOR FUTHER DETAILED INFORMATION REGARDING THESE PLANS

ENTRADA

LOT 02, BLOCK H

TOWN OF WESTLAKE TARRANT COUNTY, TEXAS


ISSUE LOG

NO.	DESCRIPTION	DATE

PROJECT NO:	20-130
ISSUED FOR:	OTP
DRAWN BY:	Checker
DATE:	06/16/21


WALL SECTIONS

A401

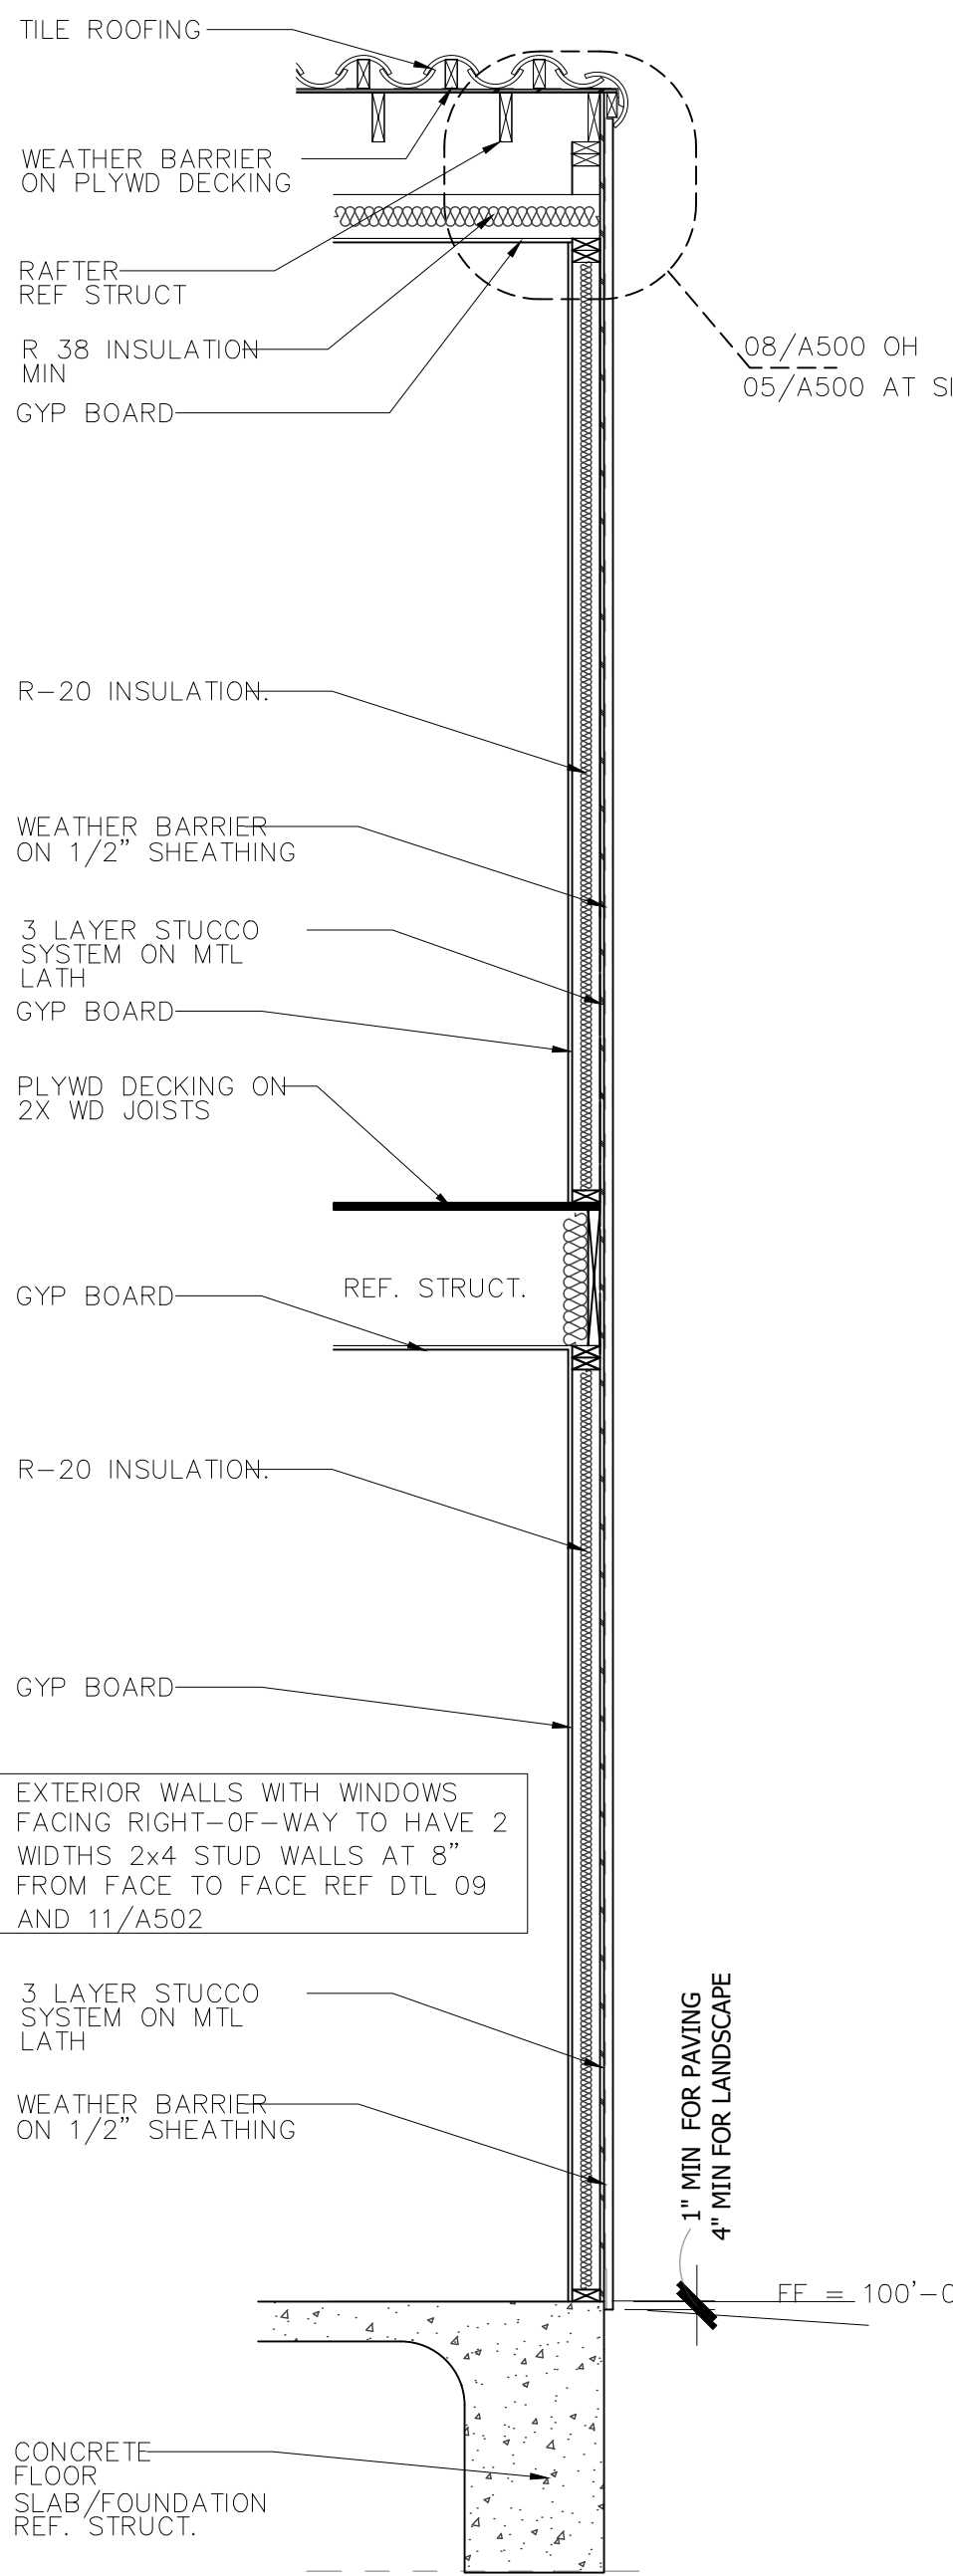


02 WALL SECTION

SCALE: 1/2" = 1'-0"

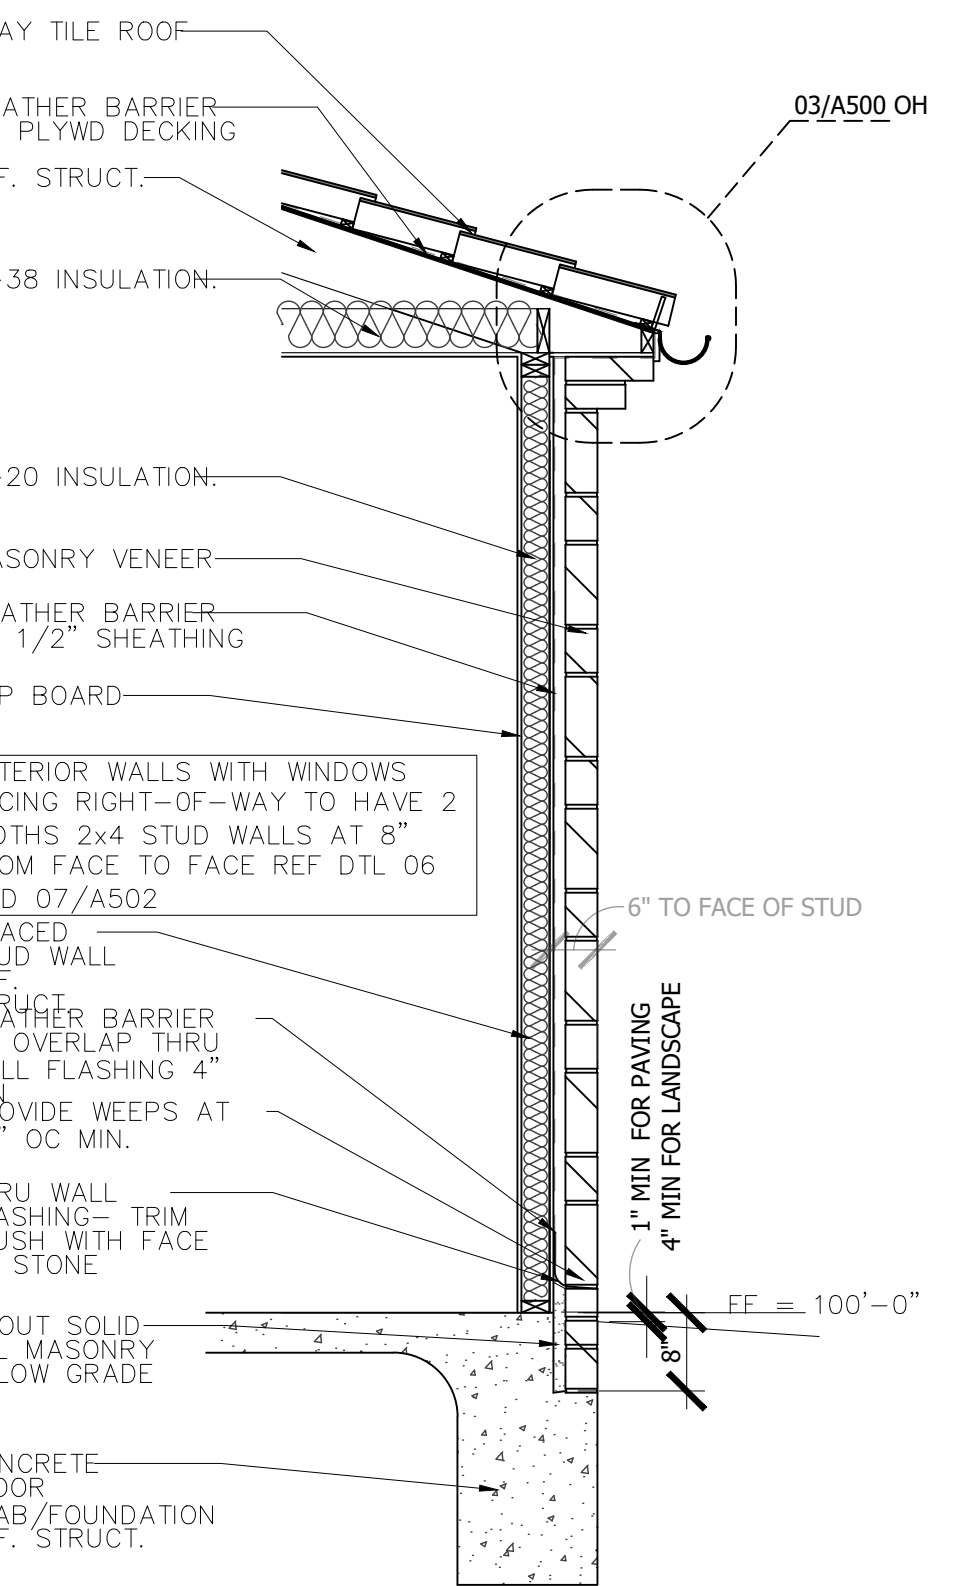


01 WALL SECTION

SCALE: 1/2" = 1'-0"

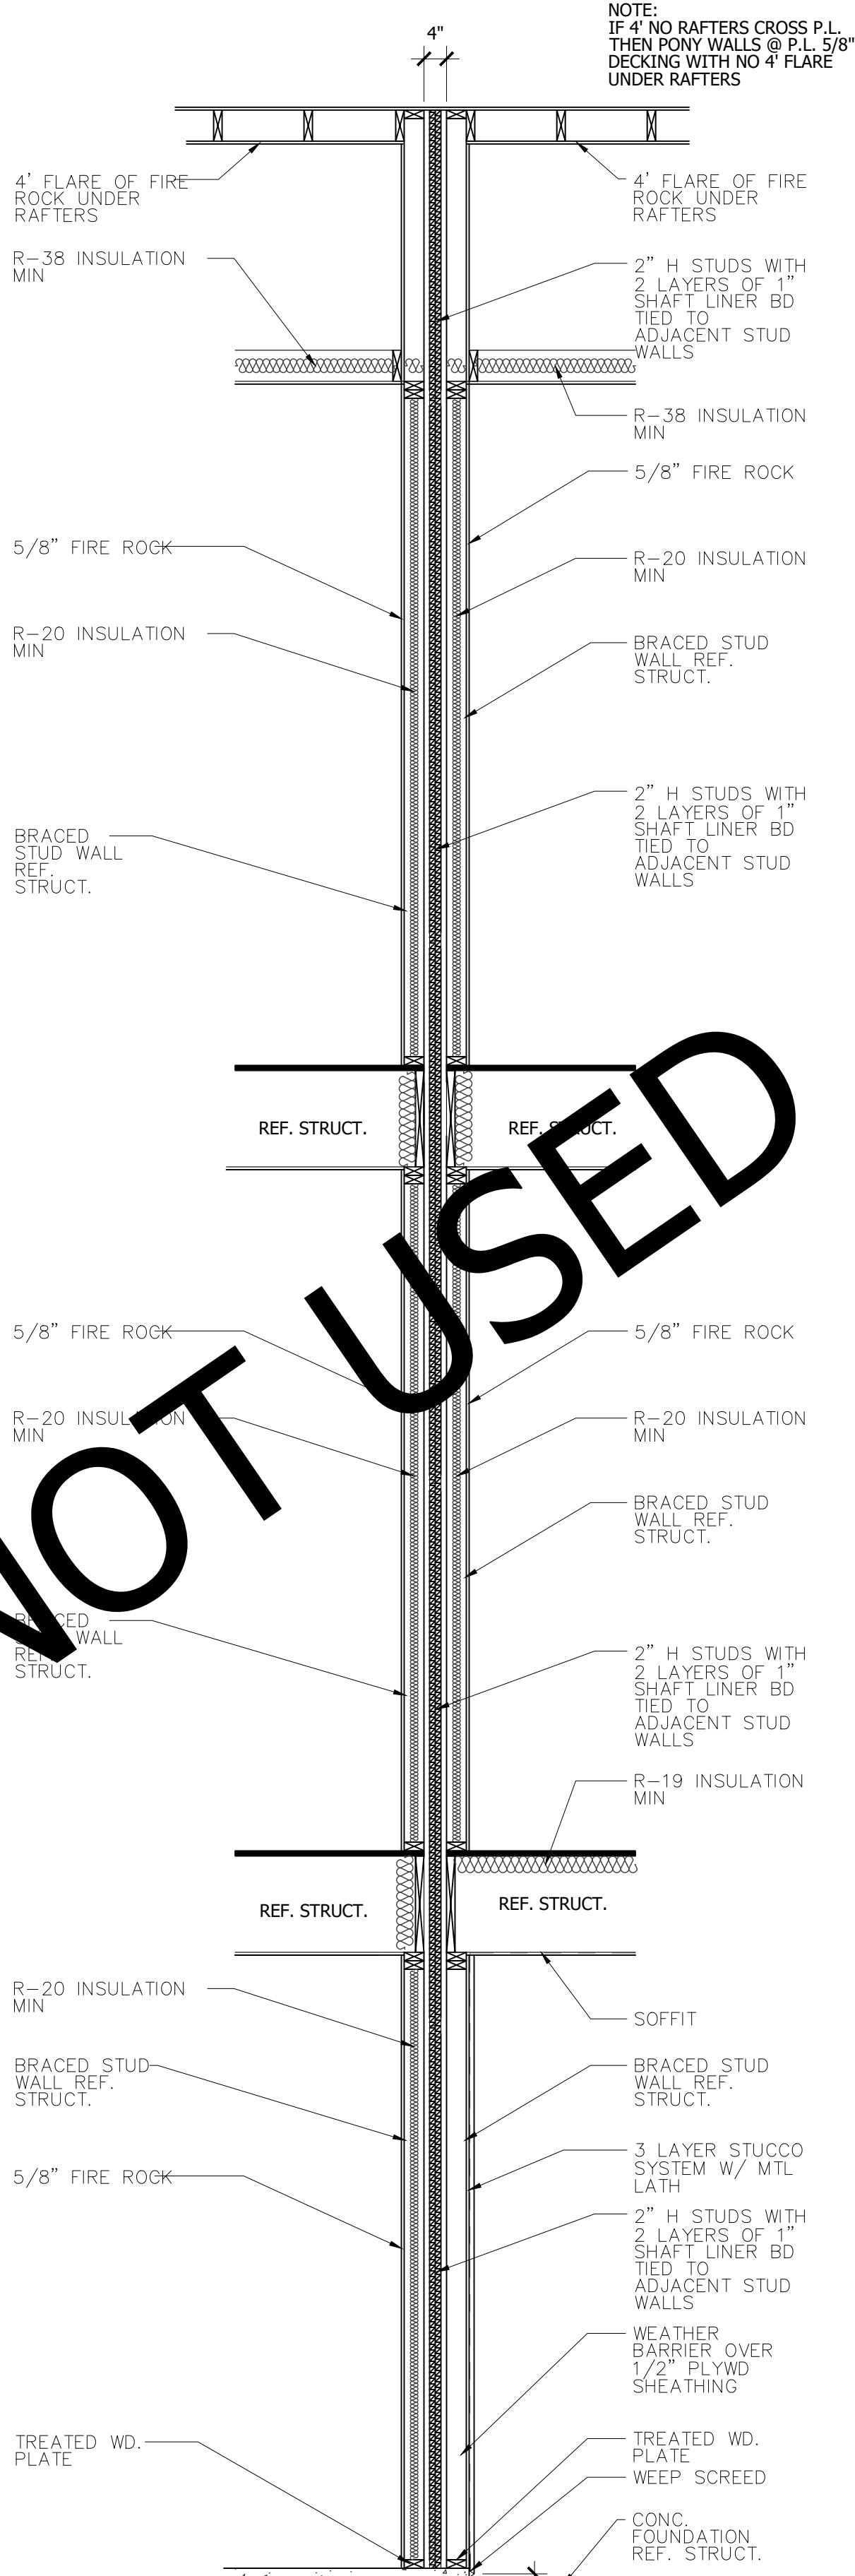


03 WALL SECTION

SCALE: 1/2" = 1'-0"

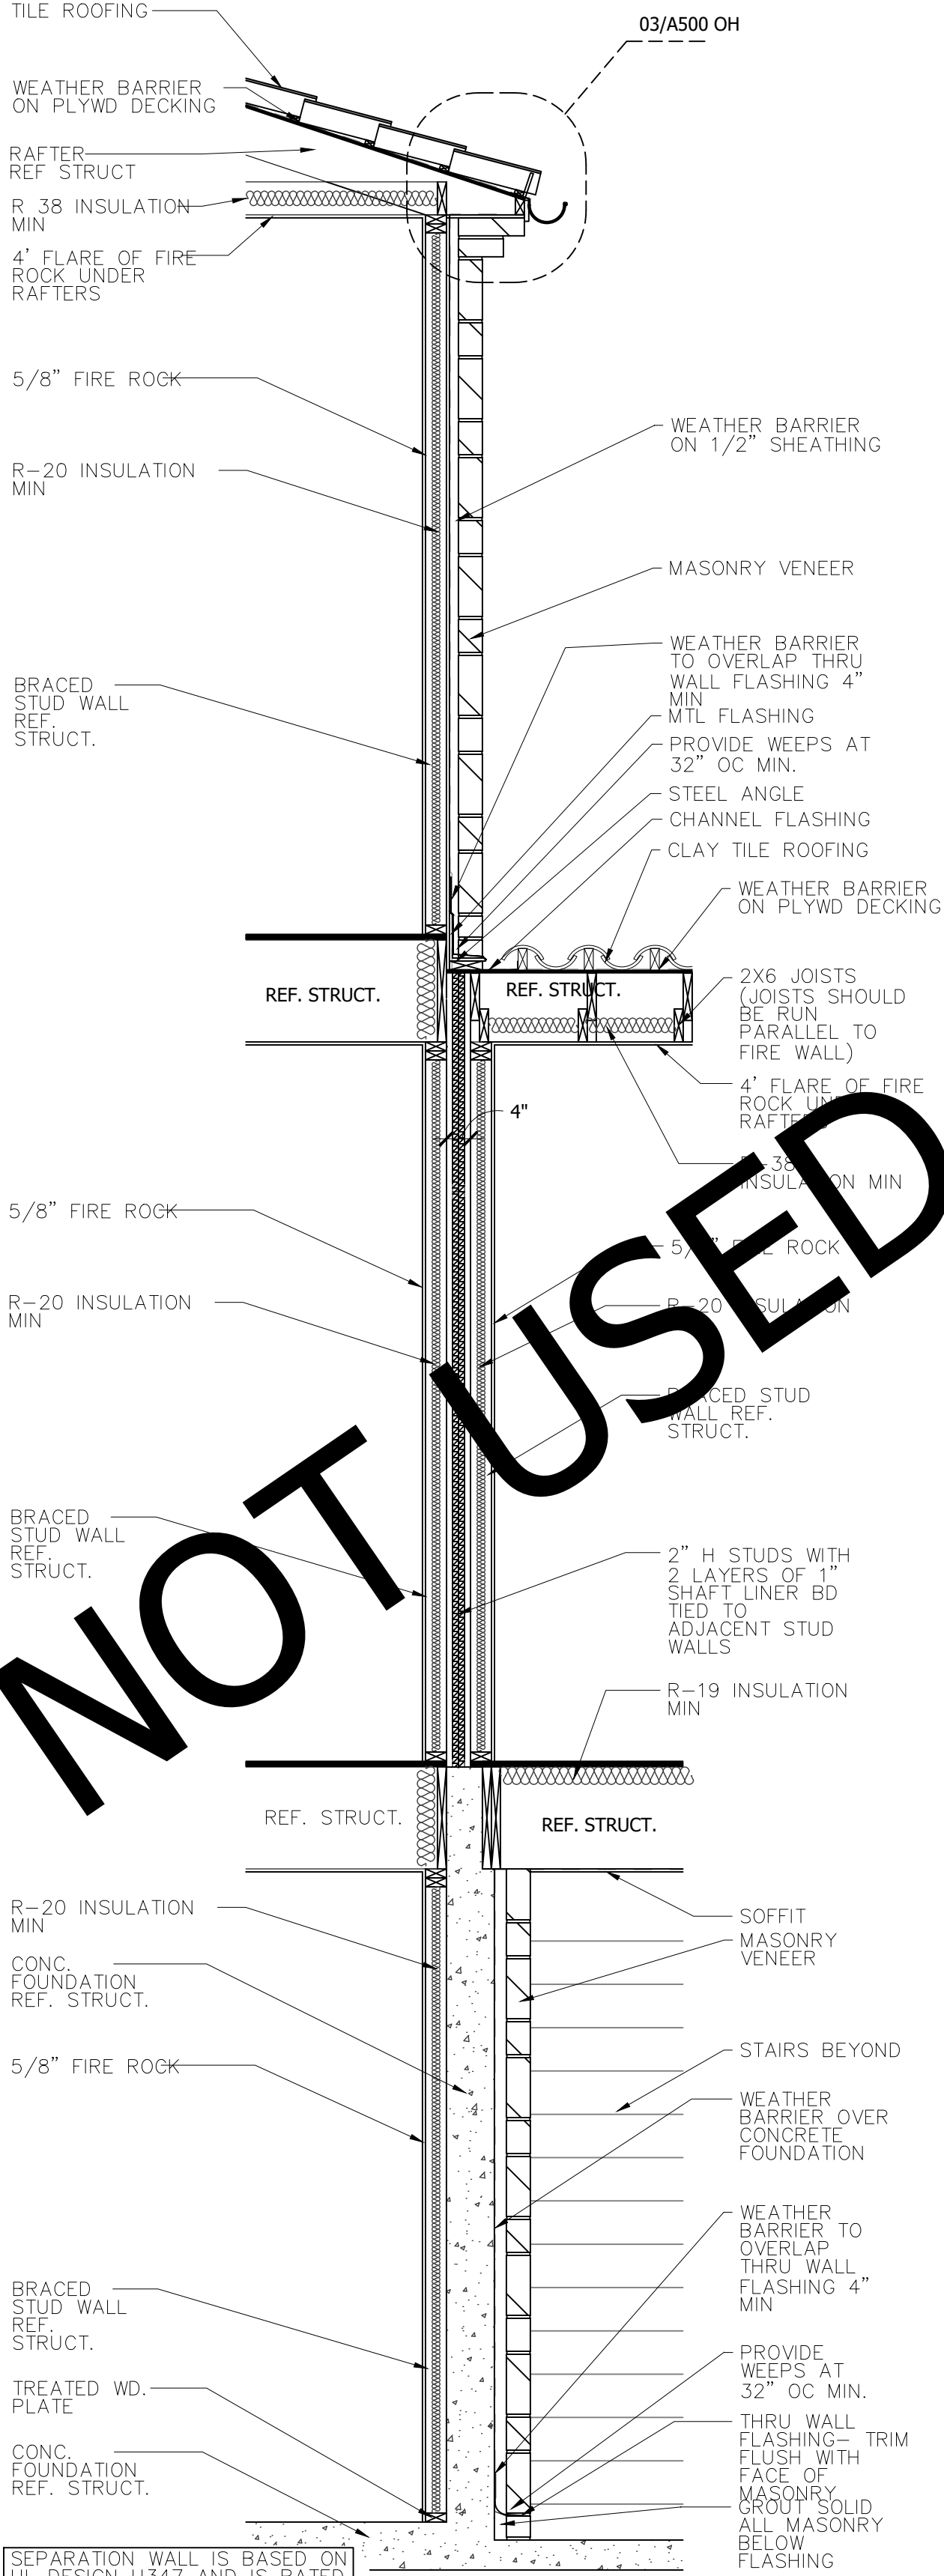


04 WALL SECTION

SCALE: 1/2" = 1'-0"

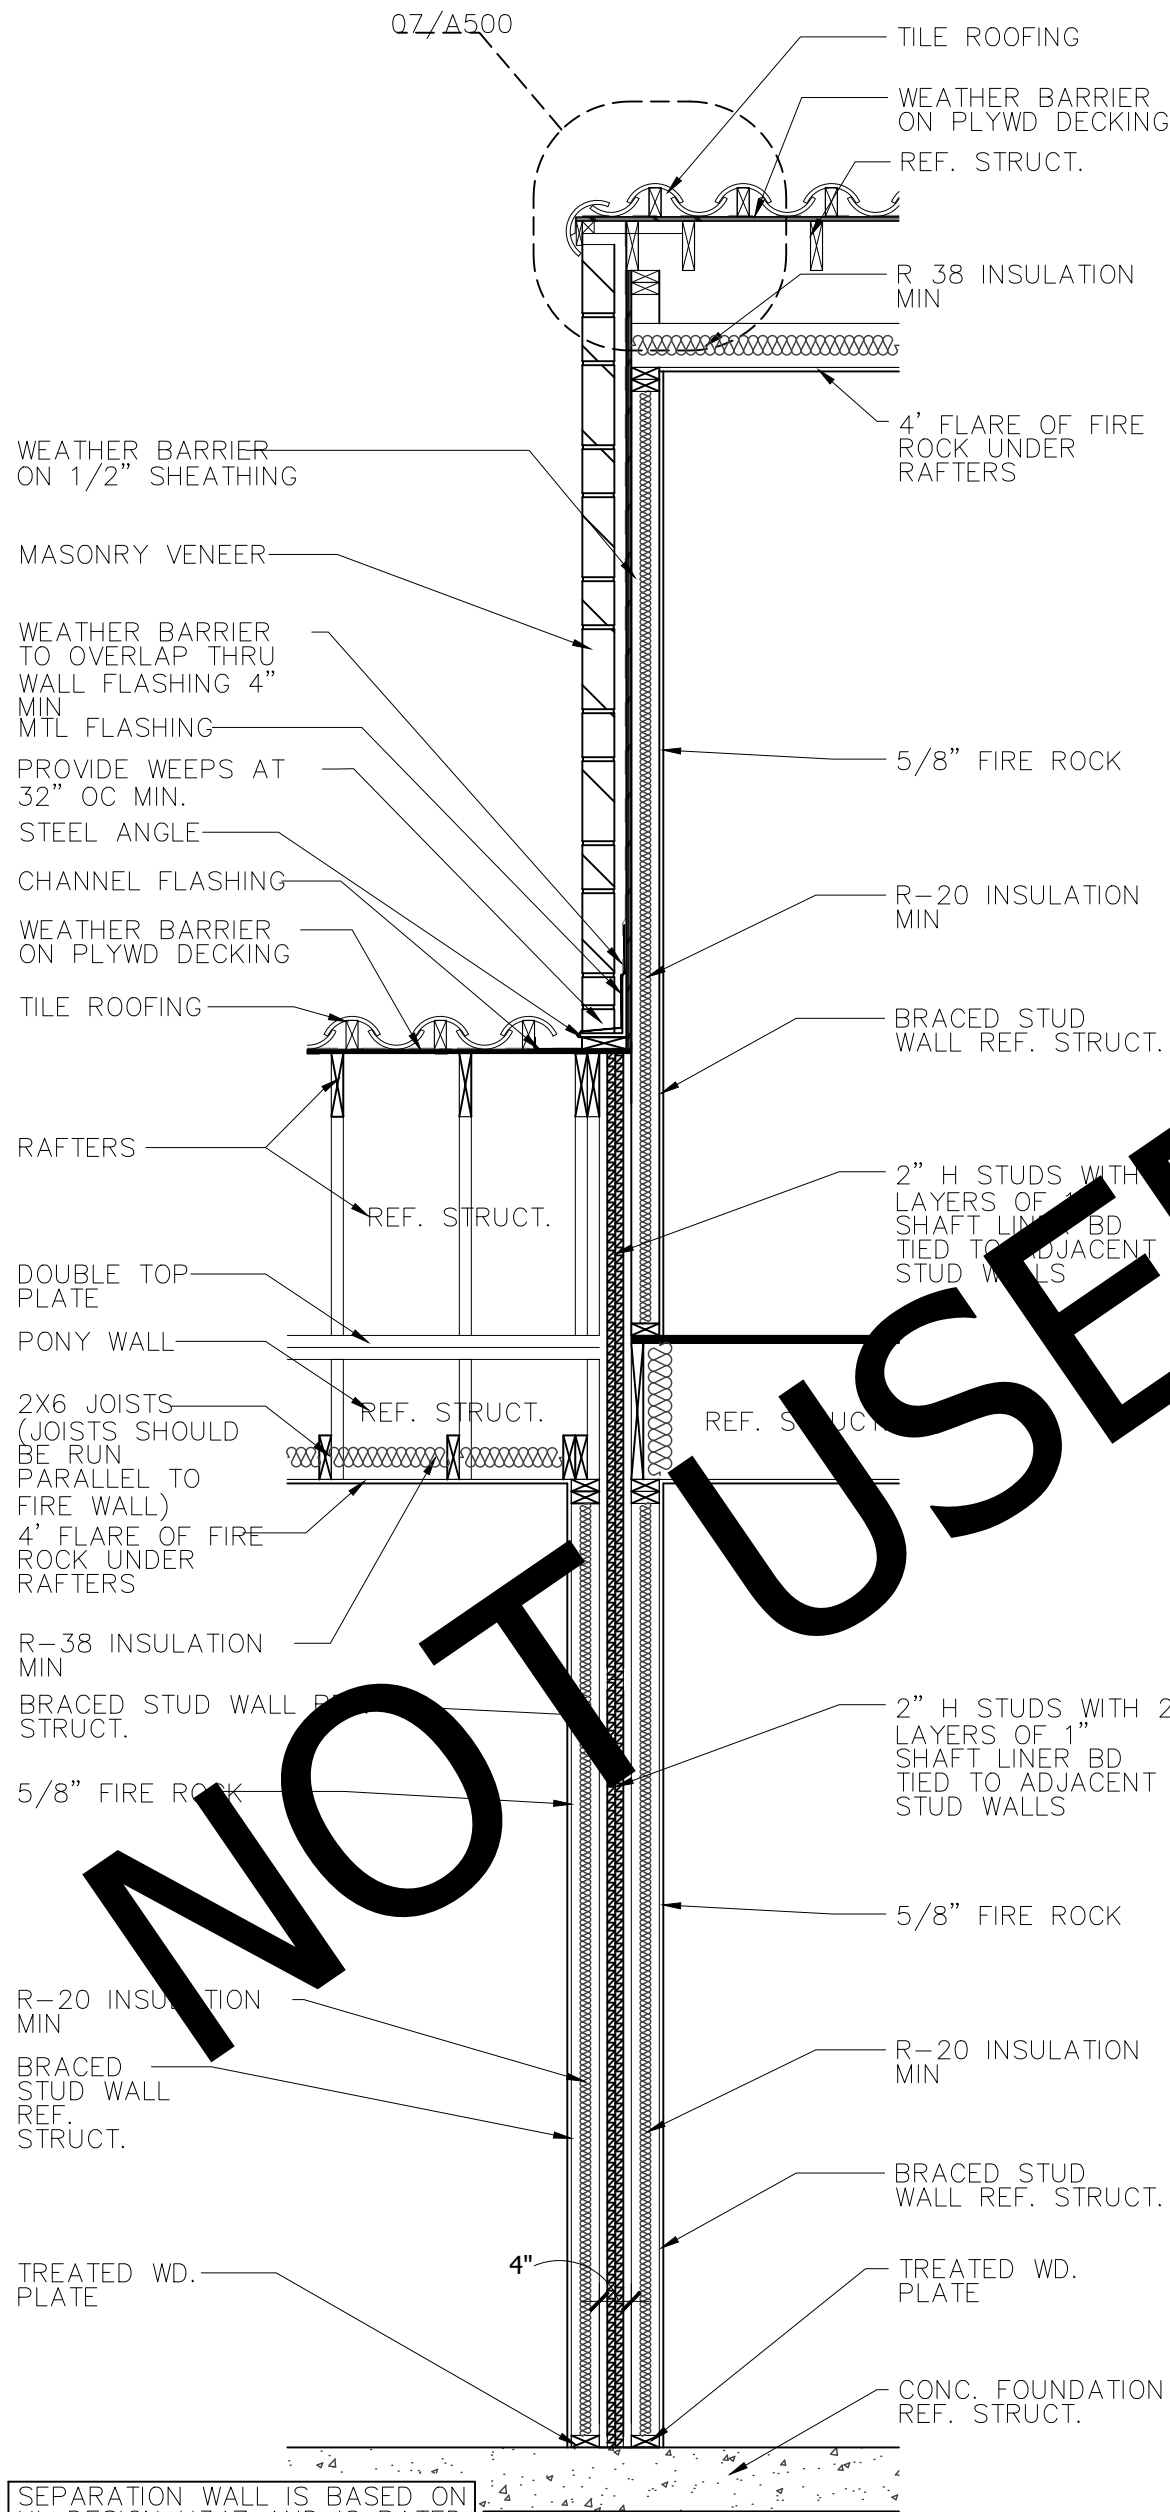

06 WALL SECTION

SCALE: 1/2" = 1'-0"

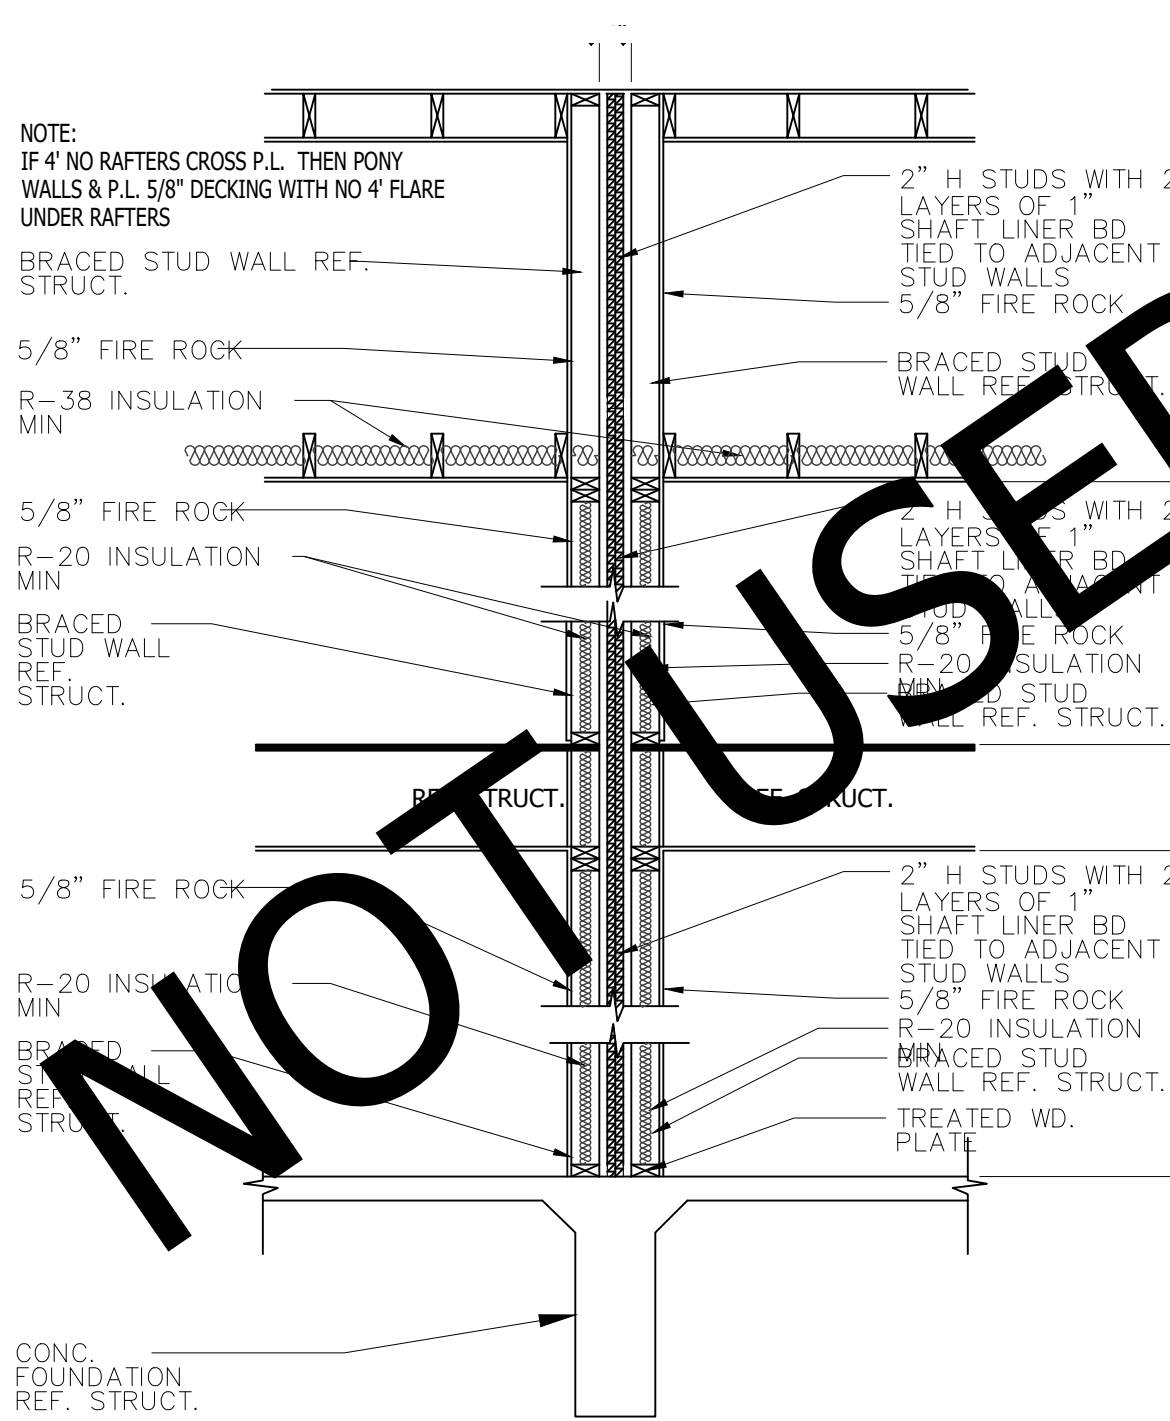

05 FIRE WALL DETAIL


SCALE: 1/2" = 1'-0"

REFER TO ENTRADA DESIGN GUIDELINES FOR FUTHER DETAILED INFORMATION REGARDING THESE PLANS

ENTRADA

LOT 02, BLOCK H

TOWN OF WESTLAKE TARRANT COUNTY, TEXAS

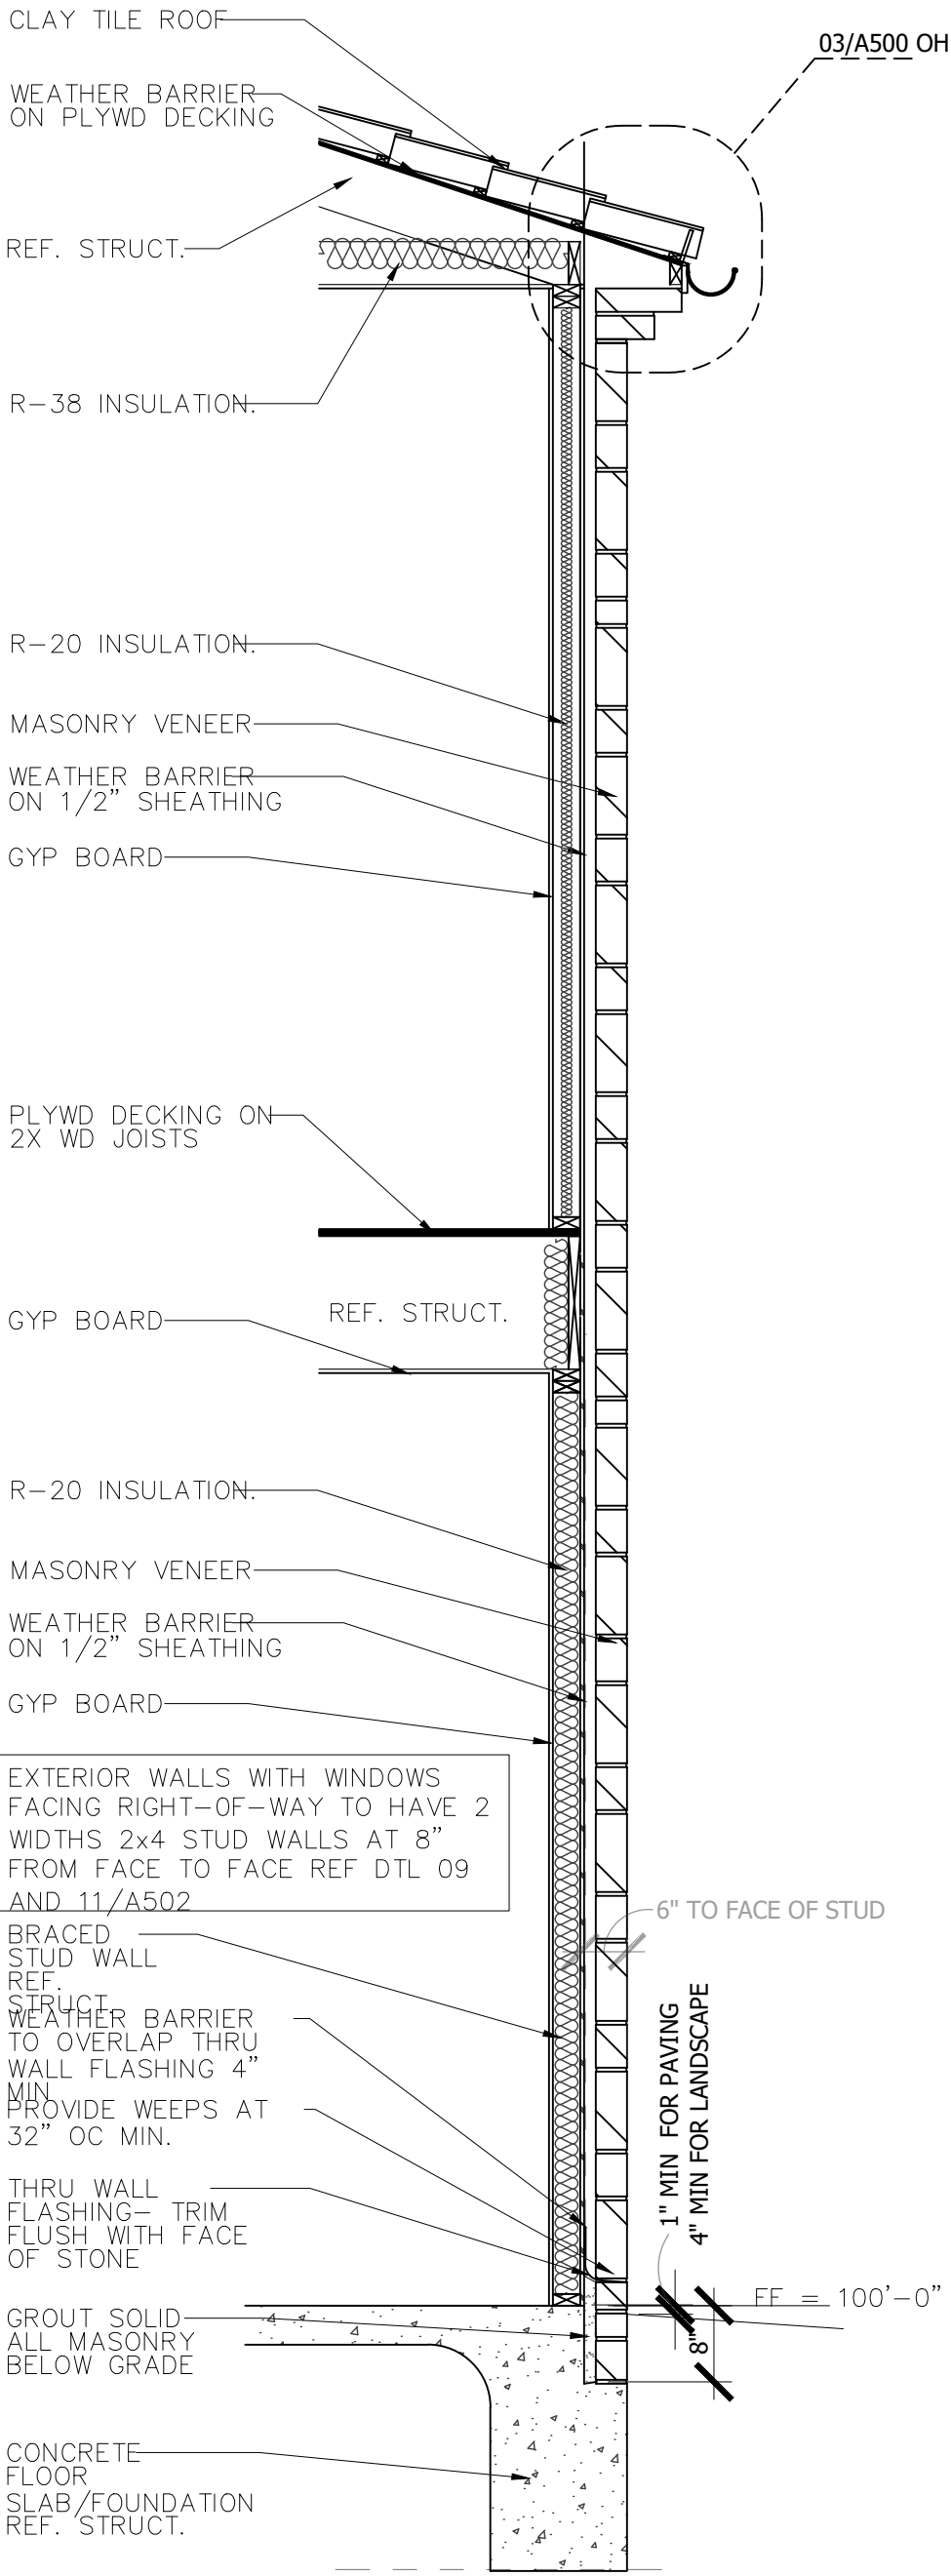

01 WALL SECTION

SCALE: 1/2" = 1'-0"

ISSUE LOG

NO.	DESCRIPTION	DATE

PROJECT NO:	20-130
ISSUED FOR:	OTP
DRAWN BY:	Checker
DATE:	06/16/21

WALL SECTIONS

A402

ENTRADA

LOT 02, BLOCK H

TOWN OF WESTLAKE TARRANT COUNTY, TEXAS










ISSUE LOG

NO.	DESCRIPTION	DATE

PROJECT NO:	20-130
ISSUED FOR:	OTP
DRAWN BY:	Checker
DATE:	06/16/21

ROOF DETAILS

A500

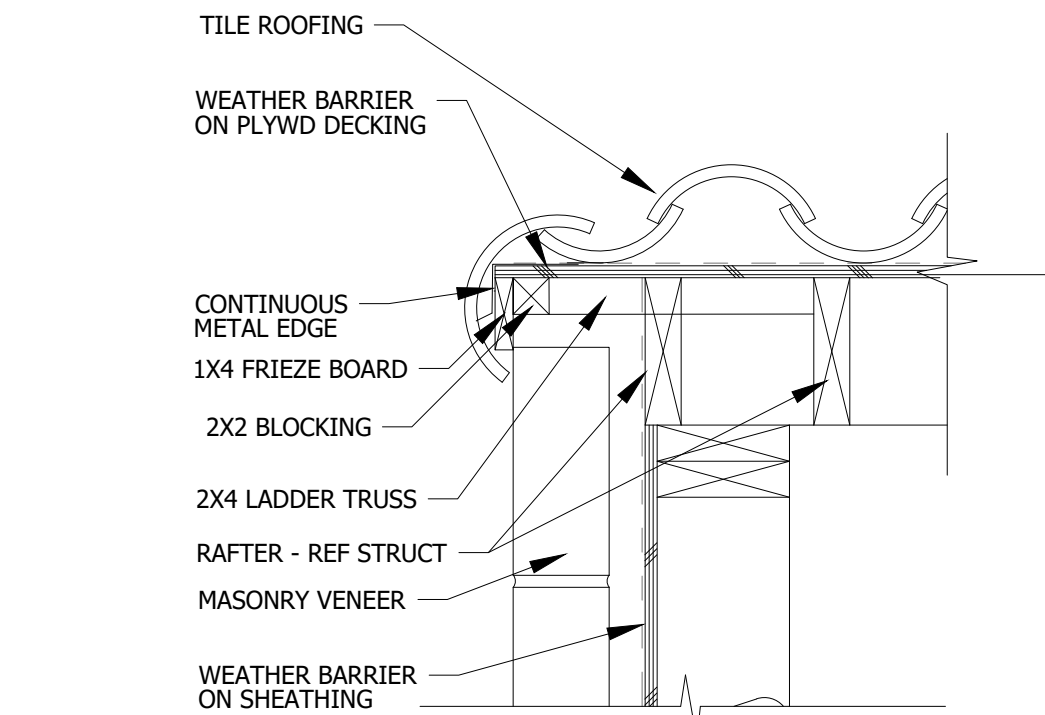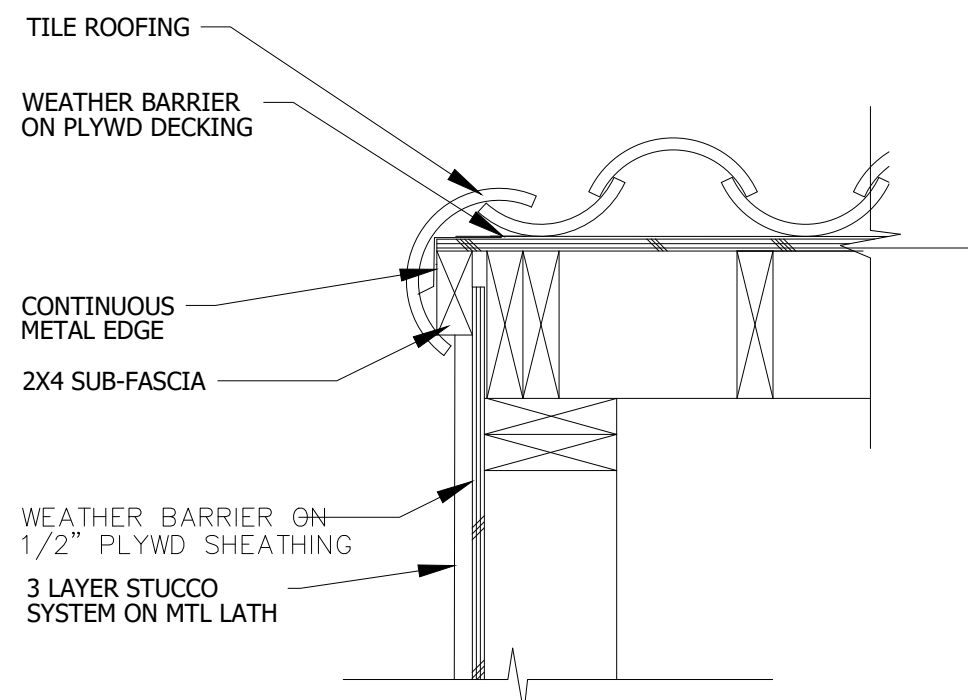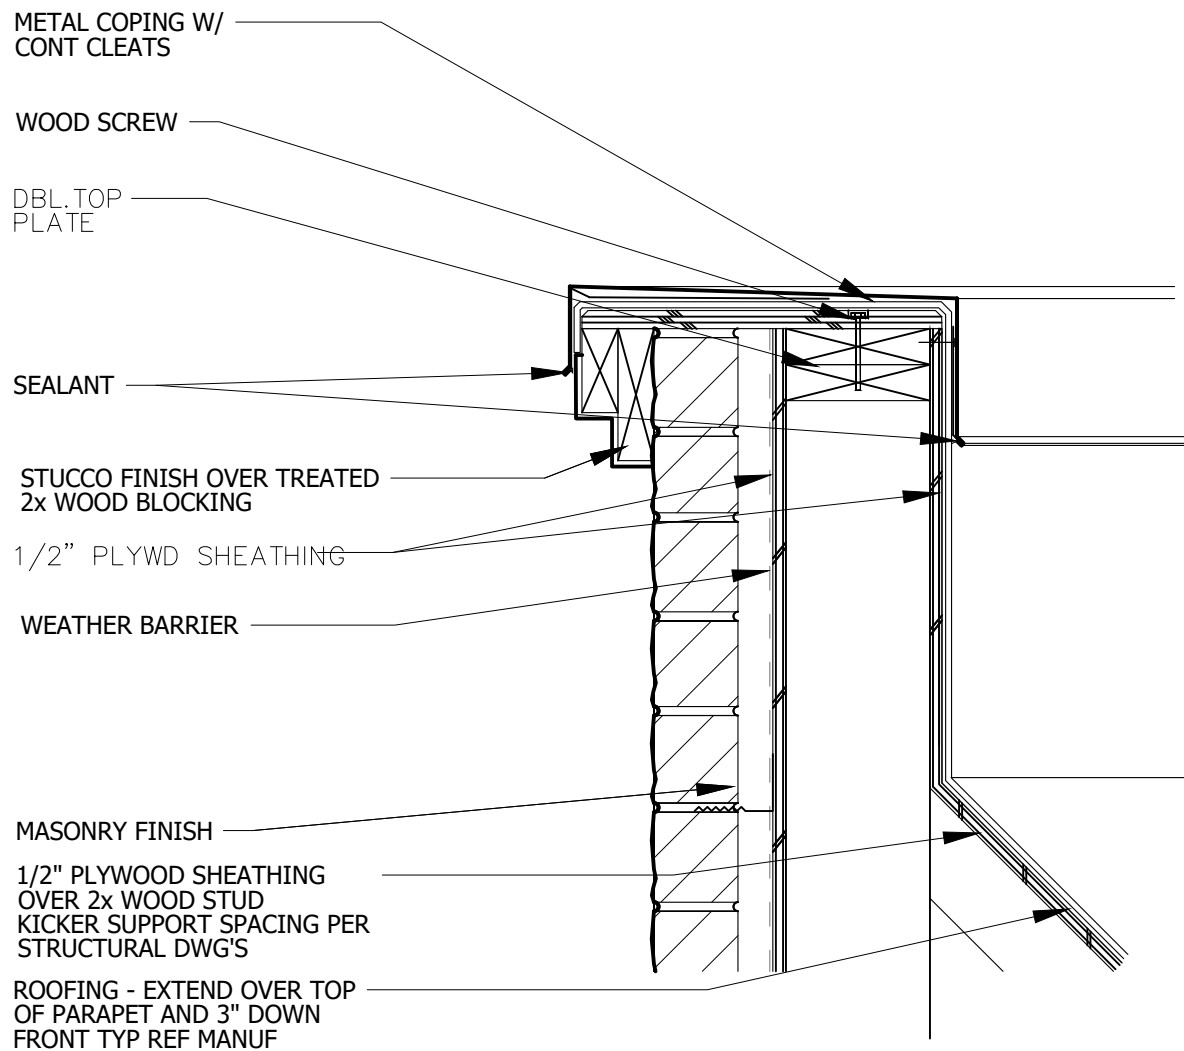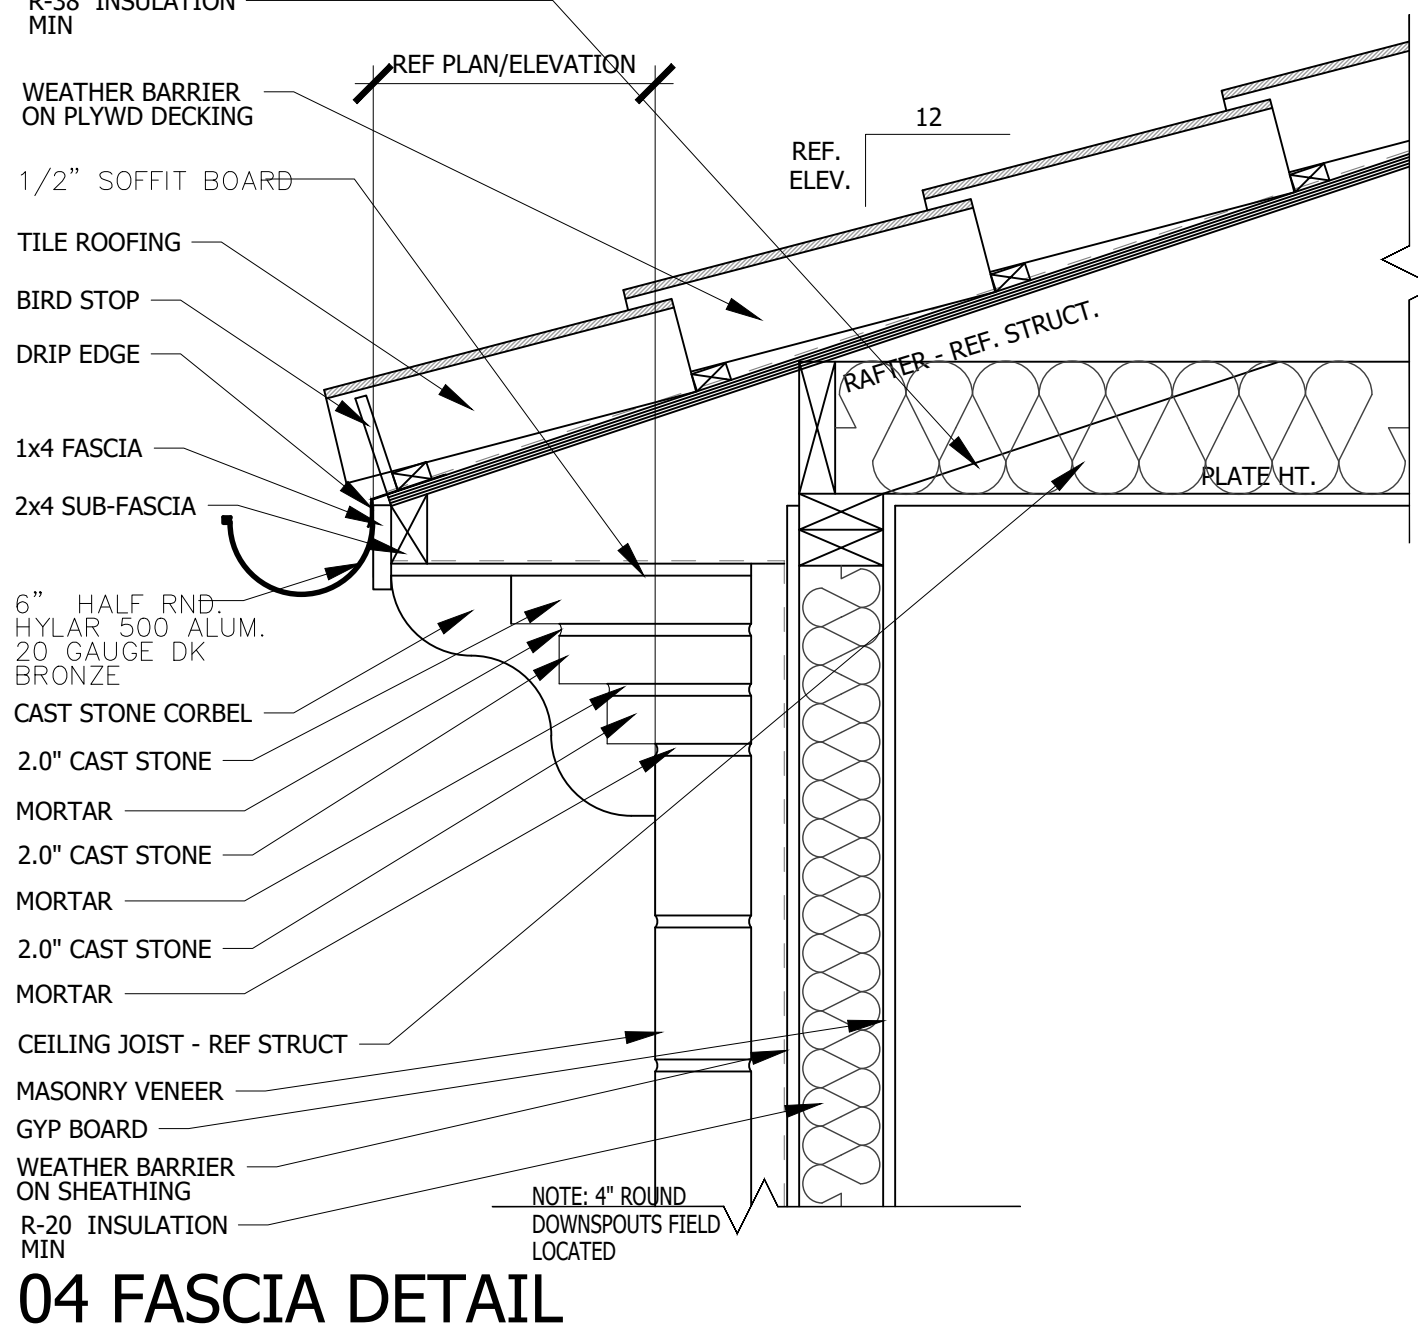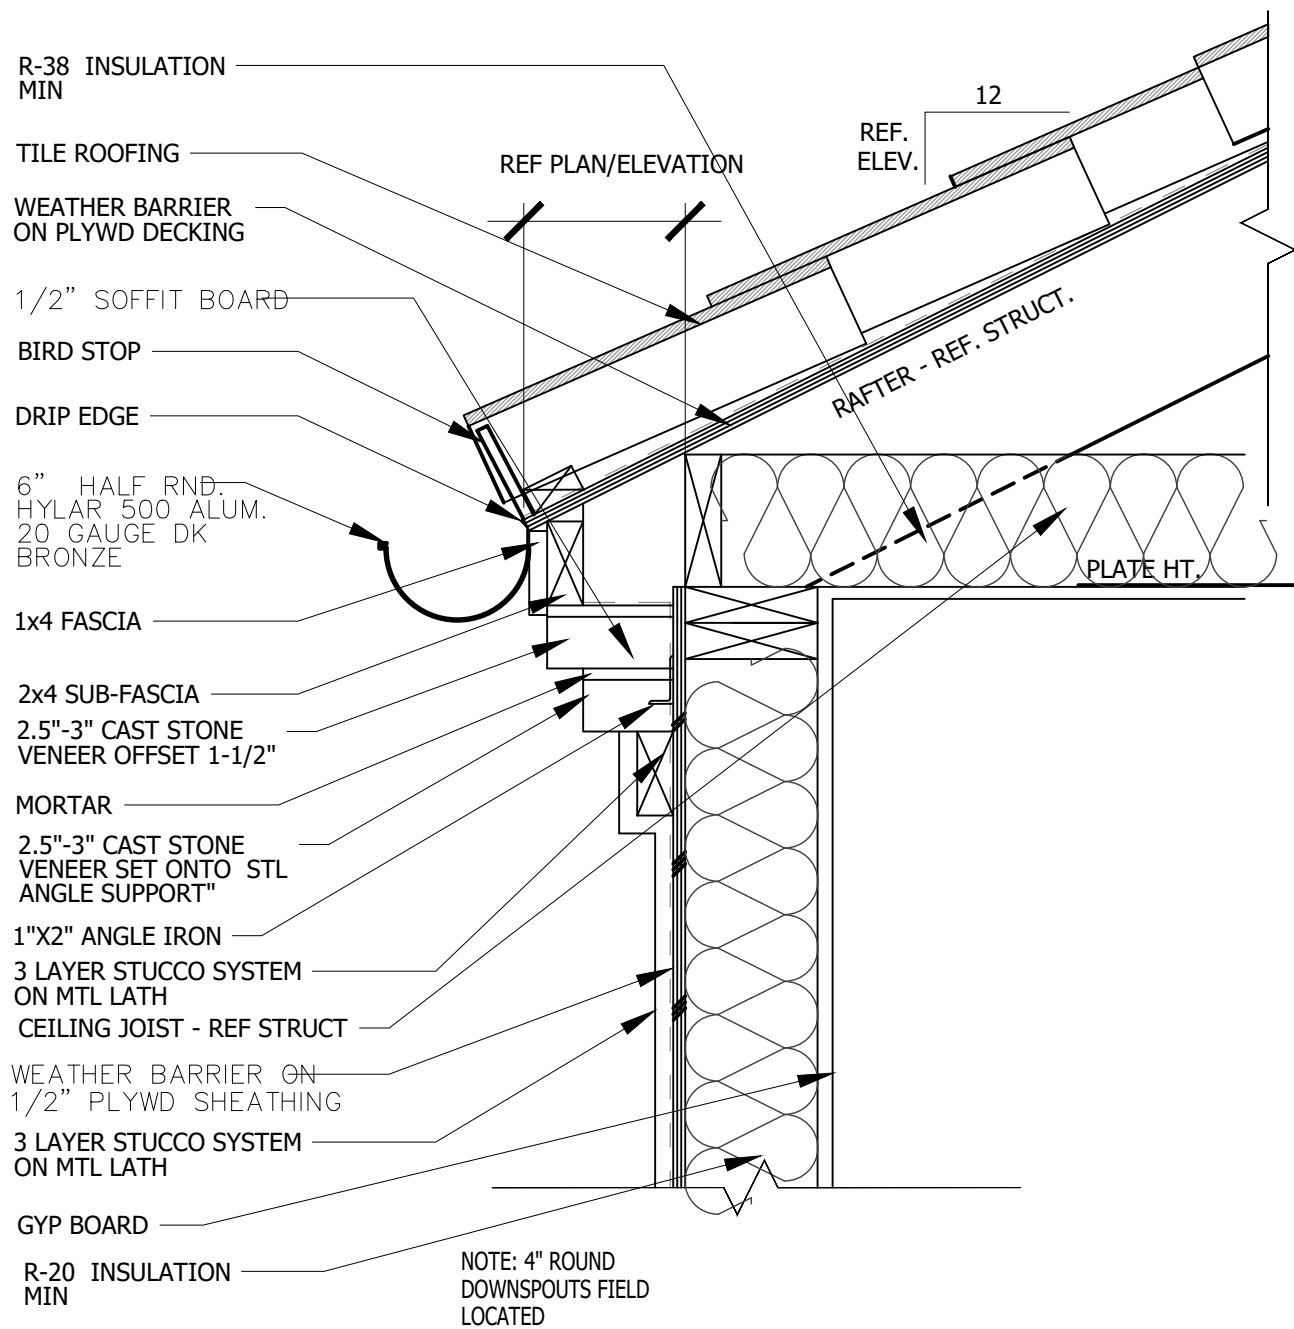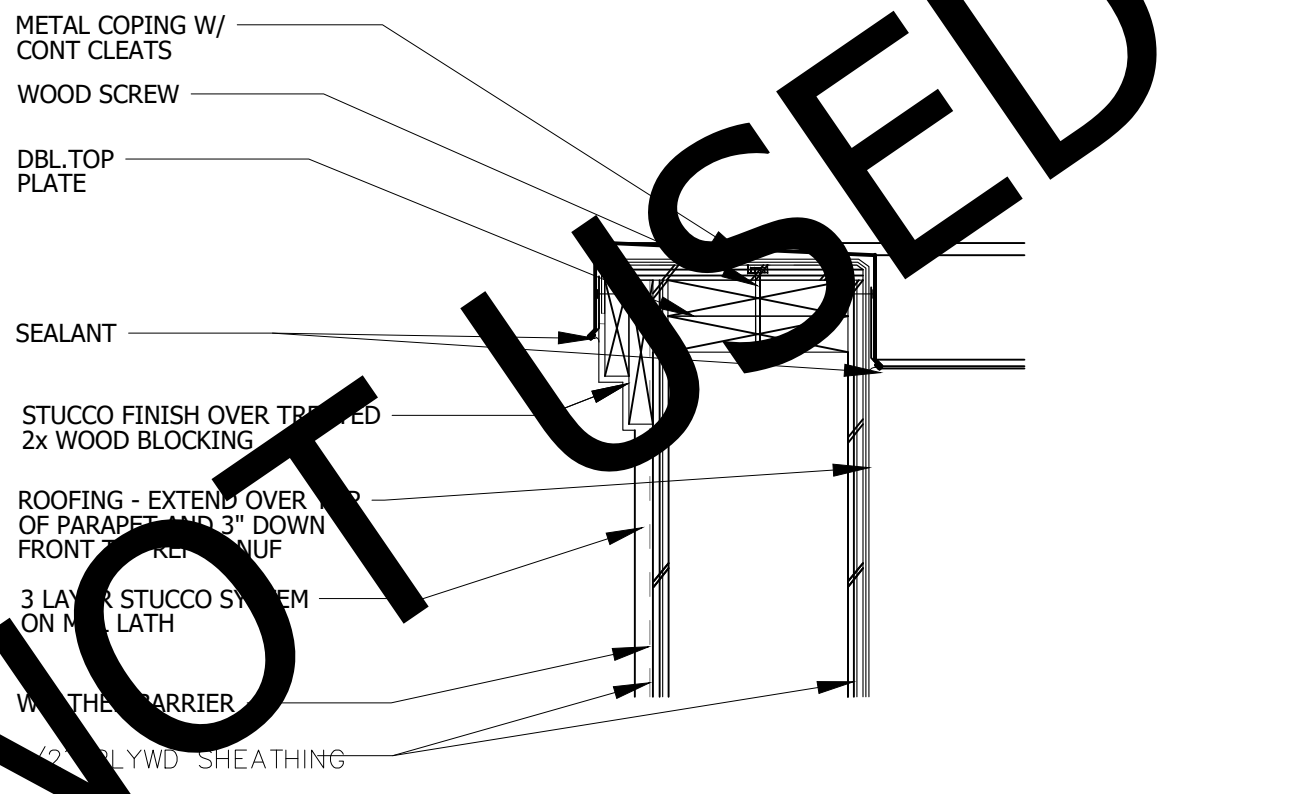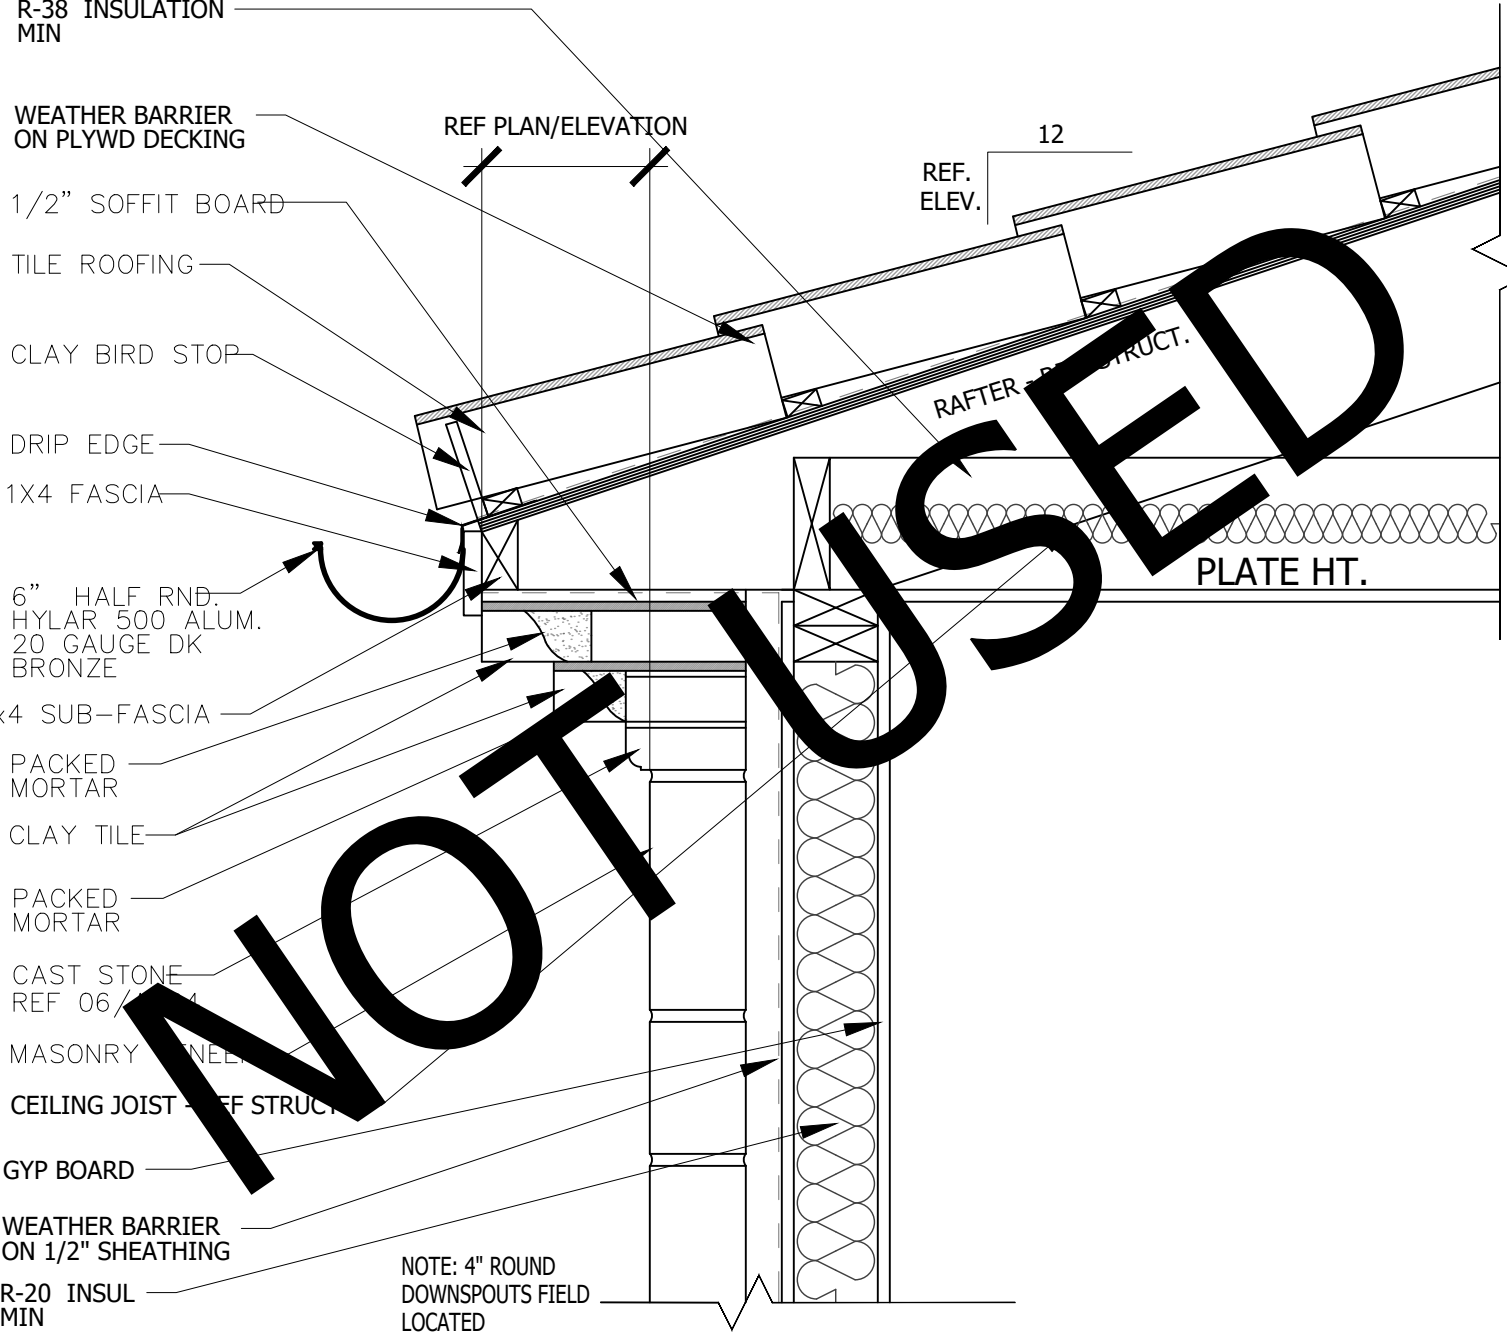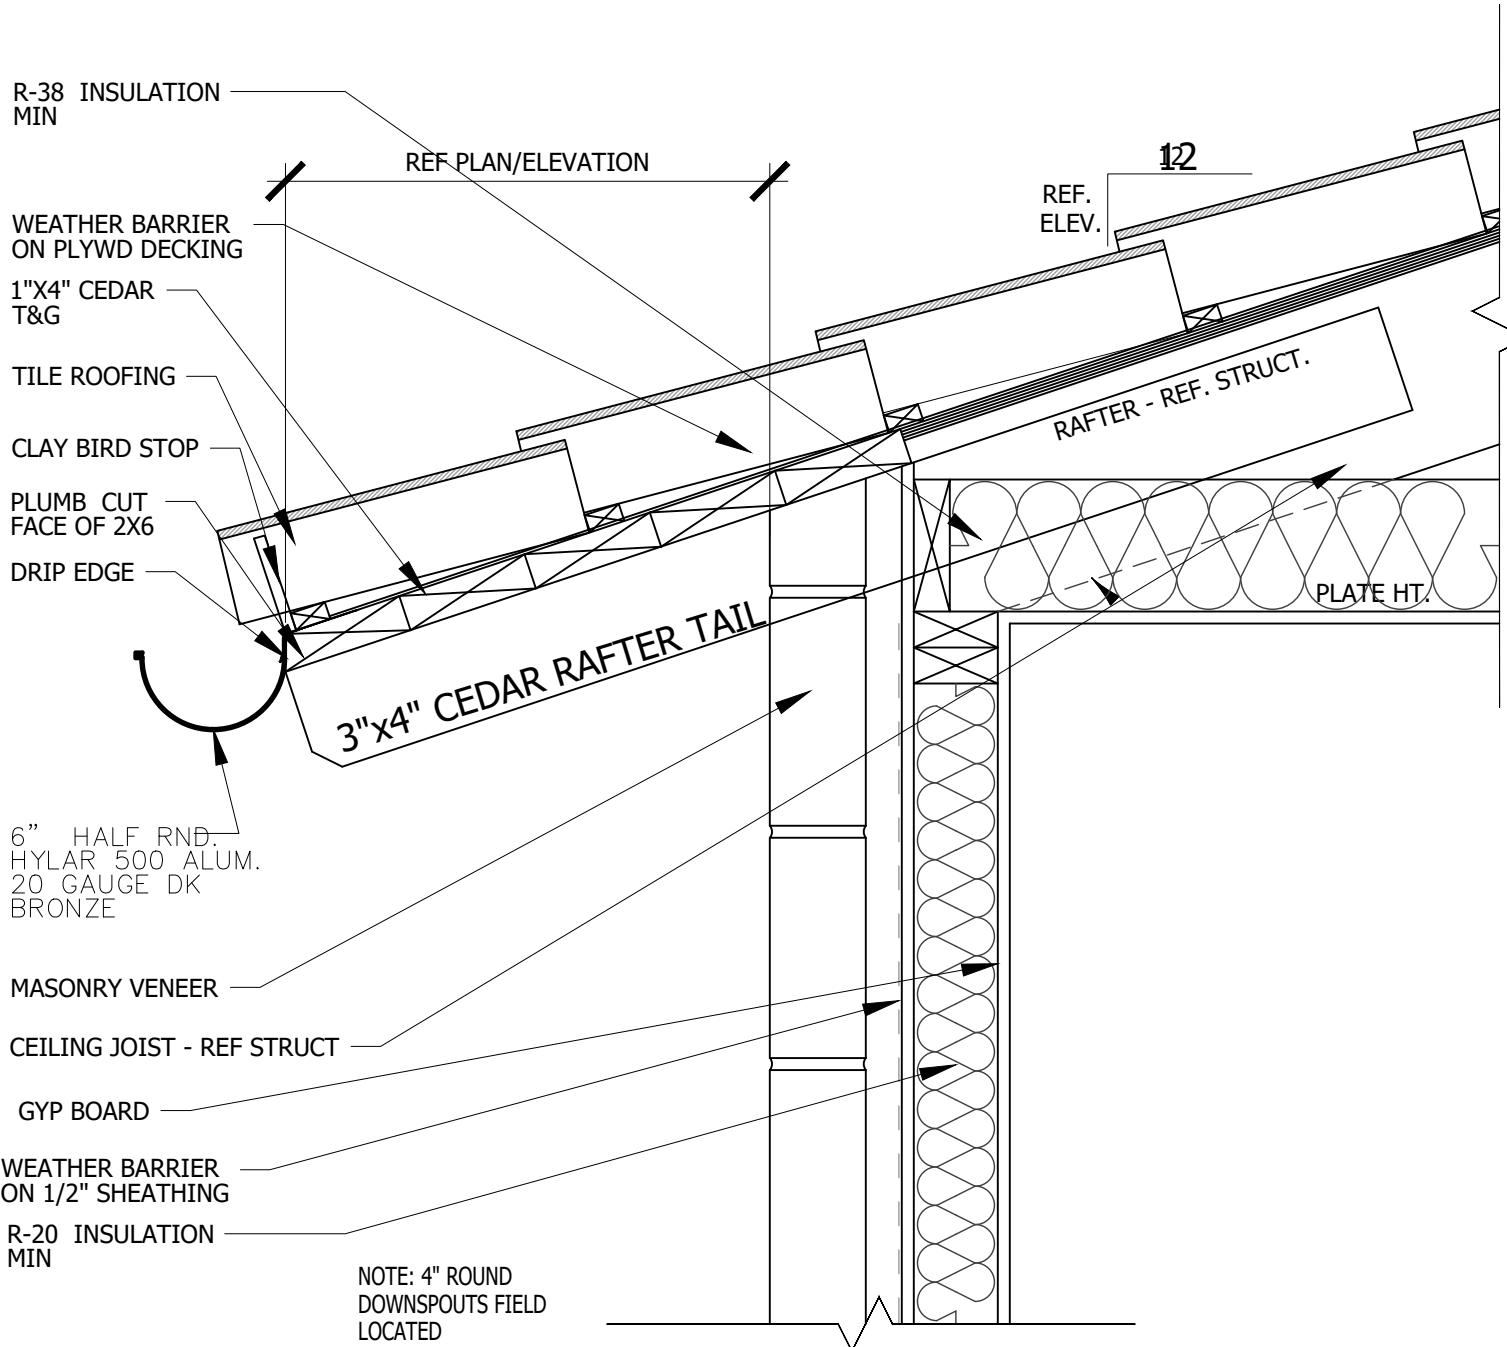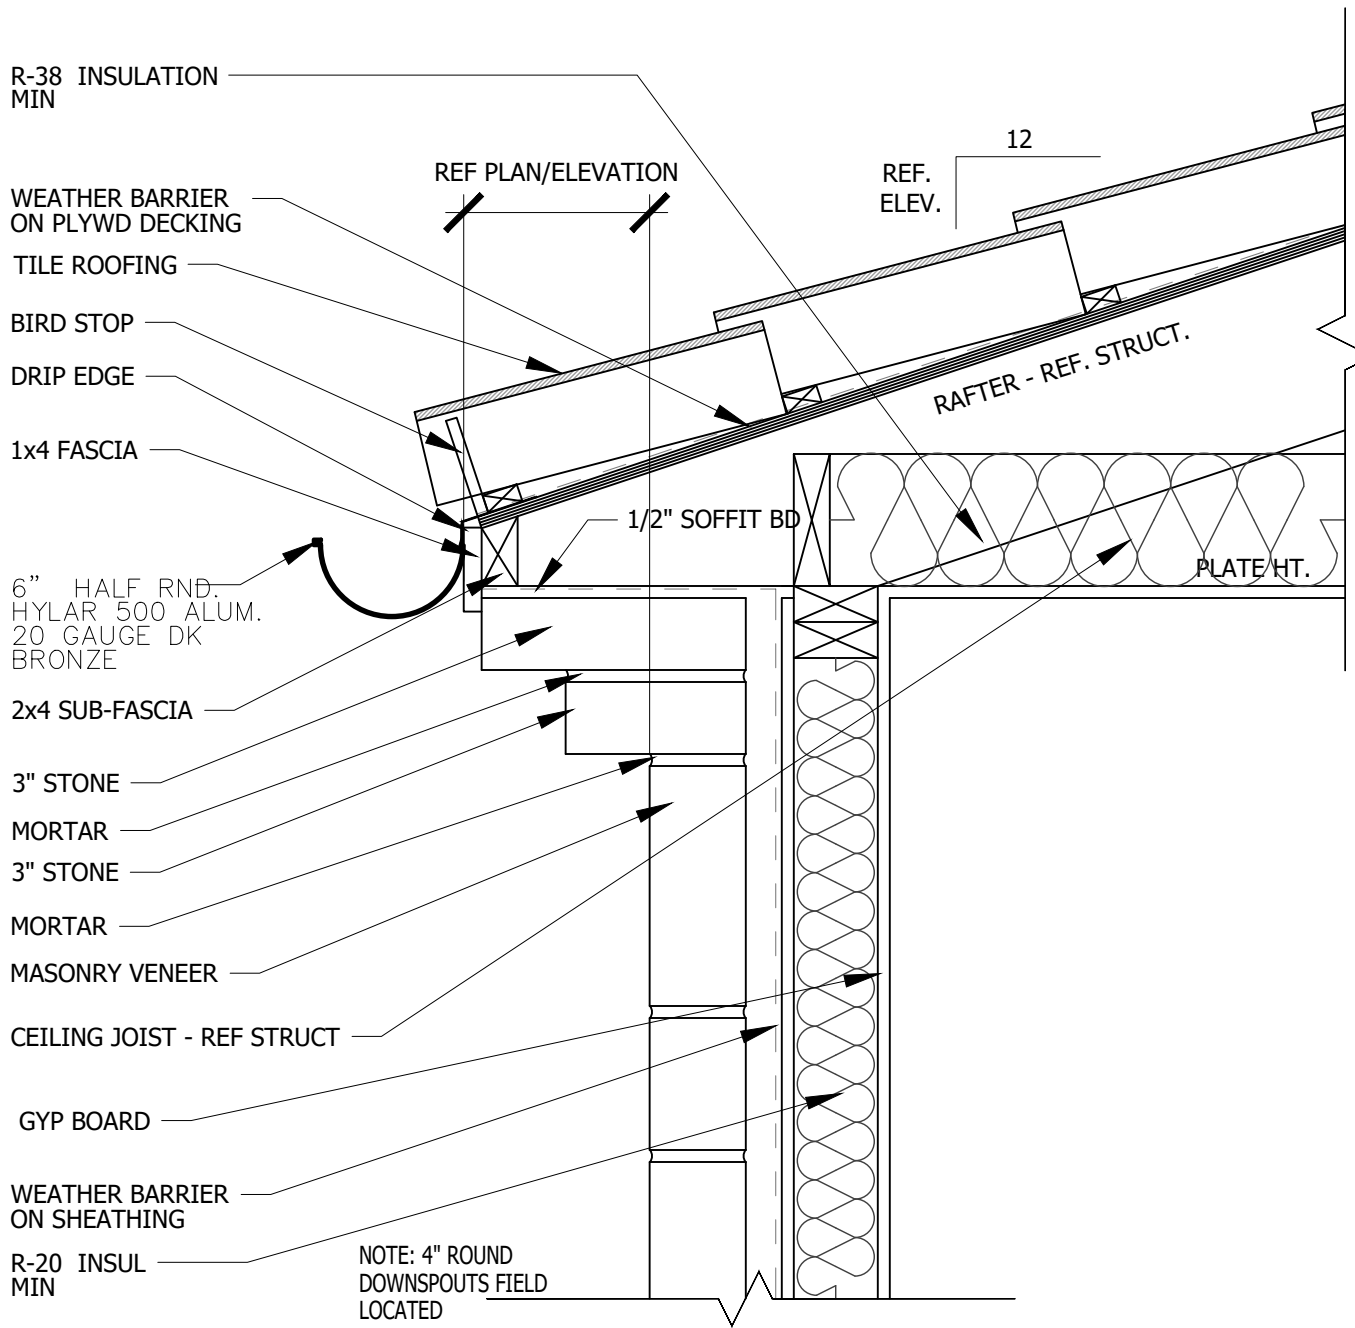

REFER TO **ENTRADA DESIGN GUIDELINES** FOR FUTHER DETAILED INFORMATION REGARDING THESE PLANS

ENTRADA

LOT 02, BLOCK H

TOWN OF WESTLAKE TARRANT COUNTY, TEXAS

ISSUE LOG

NO.	DESCRIPTION	DATE

PROJECT NO:	20-130
ISSUED FOR:	OTP
DRAWN BY:	Checker
DATE:	06/16/21


STANDARD DETAILS

A501


07 INSET BRICK DETAIL
W/ DECORATIVE WROUGHT IRON
SCALE: 1" = 1'-0"

REFER TO ENTRADA DESIGN GUIDELINES FOR FUTHER DETAILED INFORMATION REGARDING THESE PLANS


08 STOREFRONT HEADER
SCALE: 1 1/2" = 1'-0"

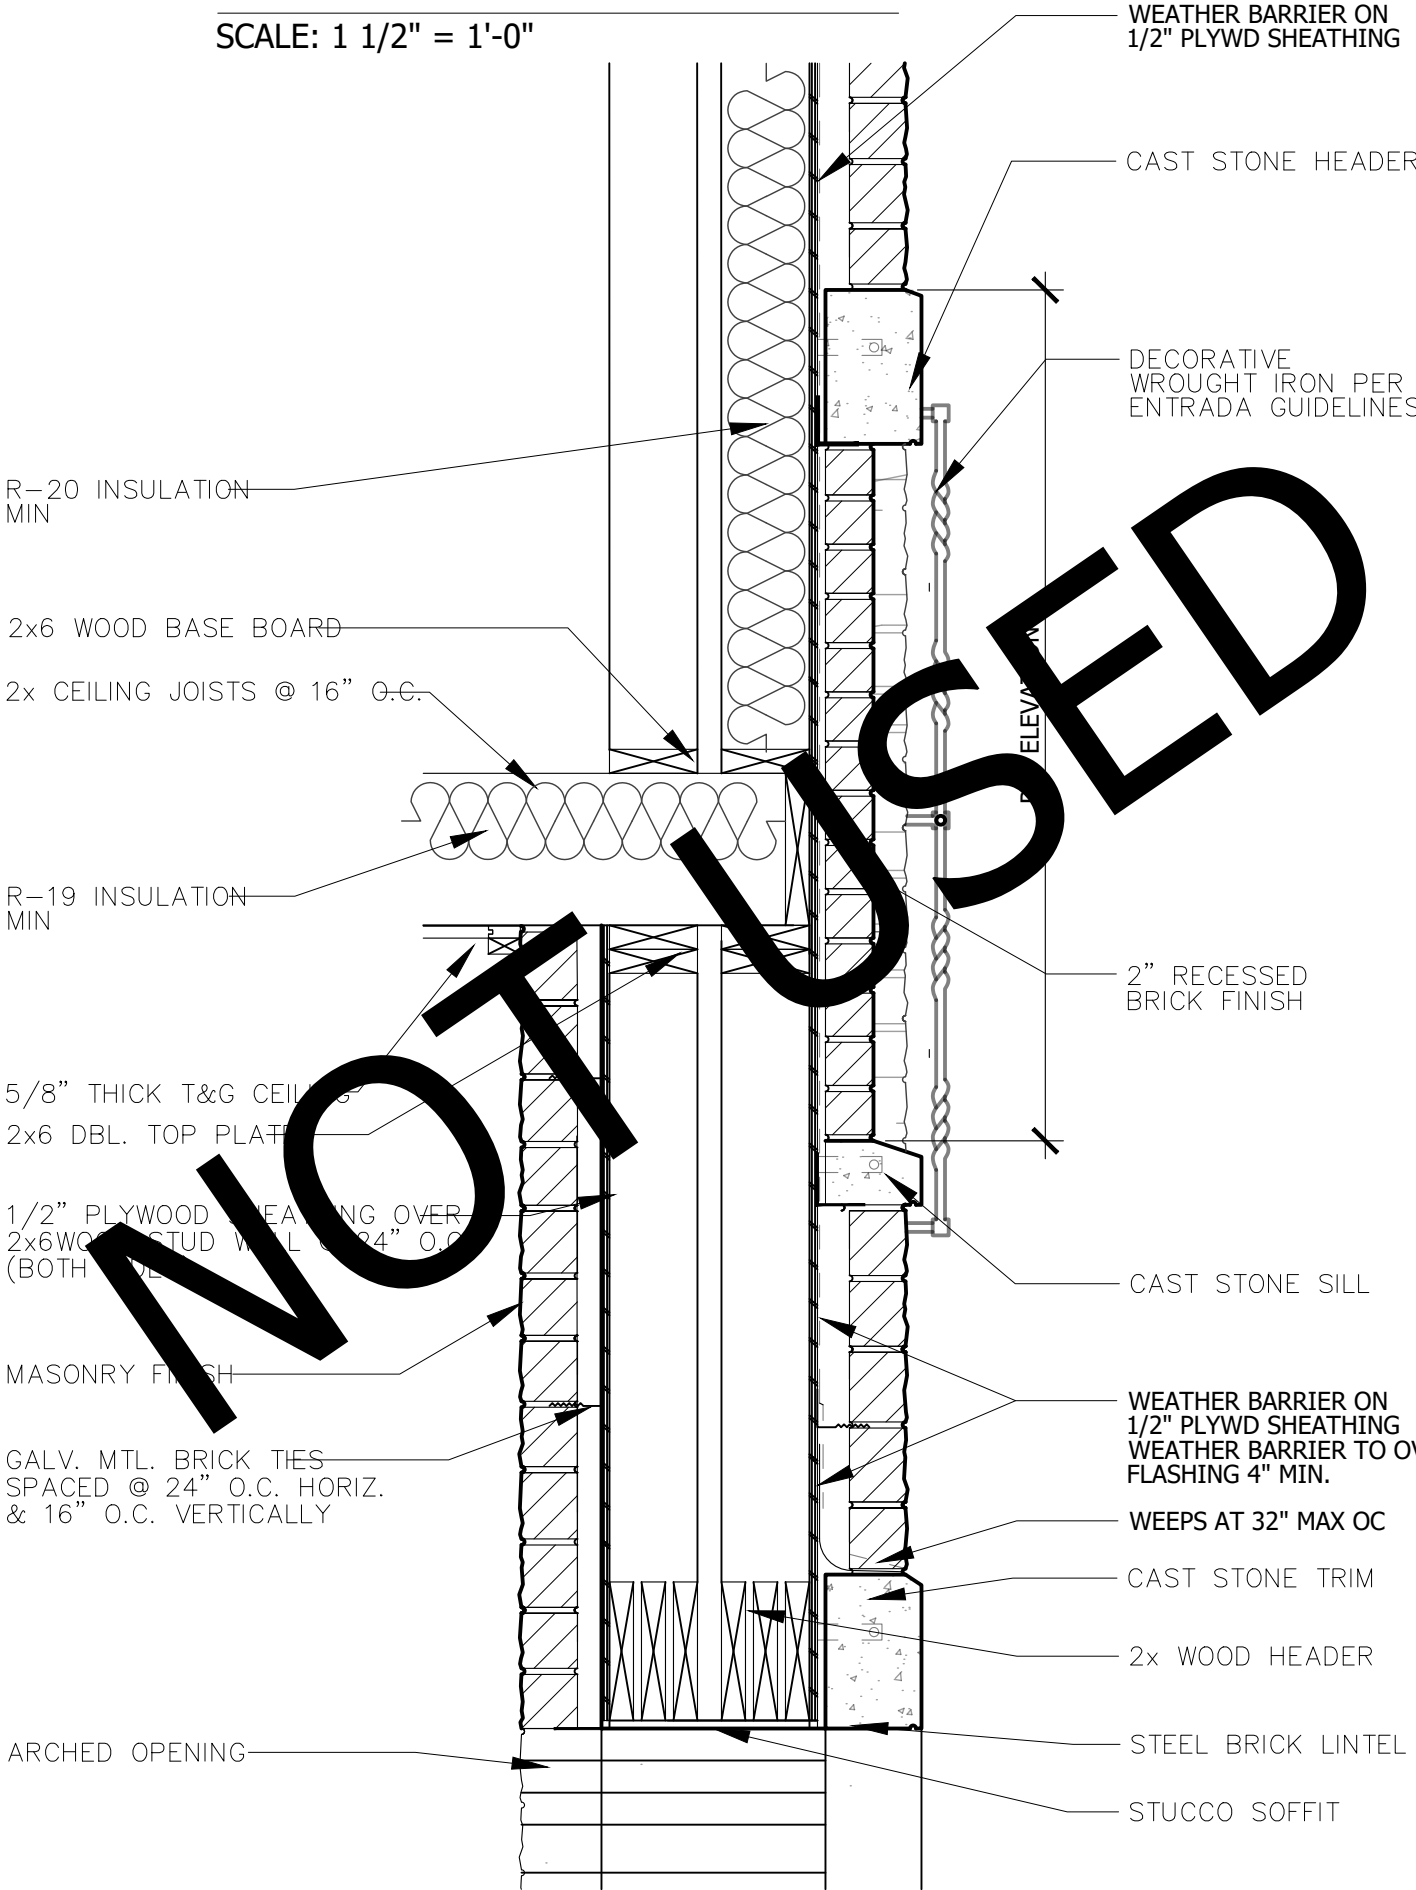

06 ATTIC ACCESS DETAIL
SCALE: 1" = 1'-0"

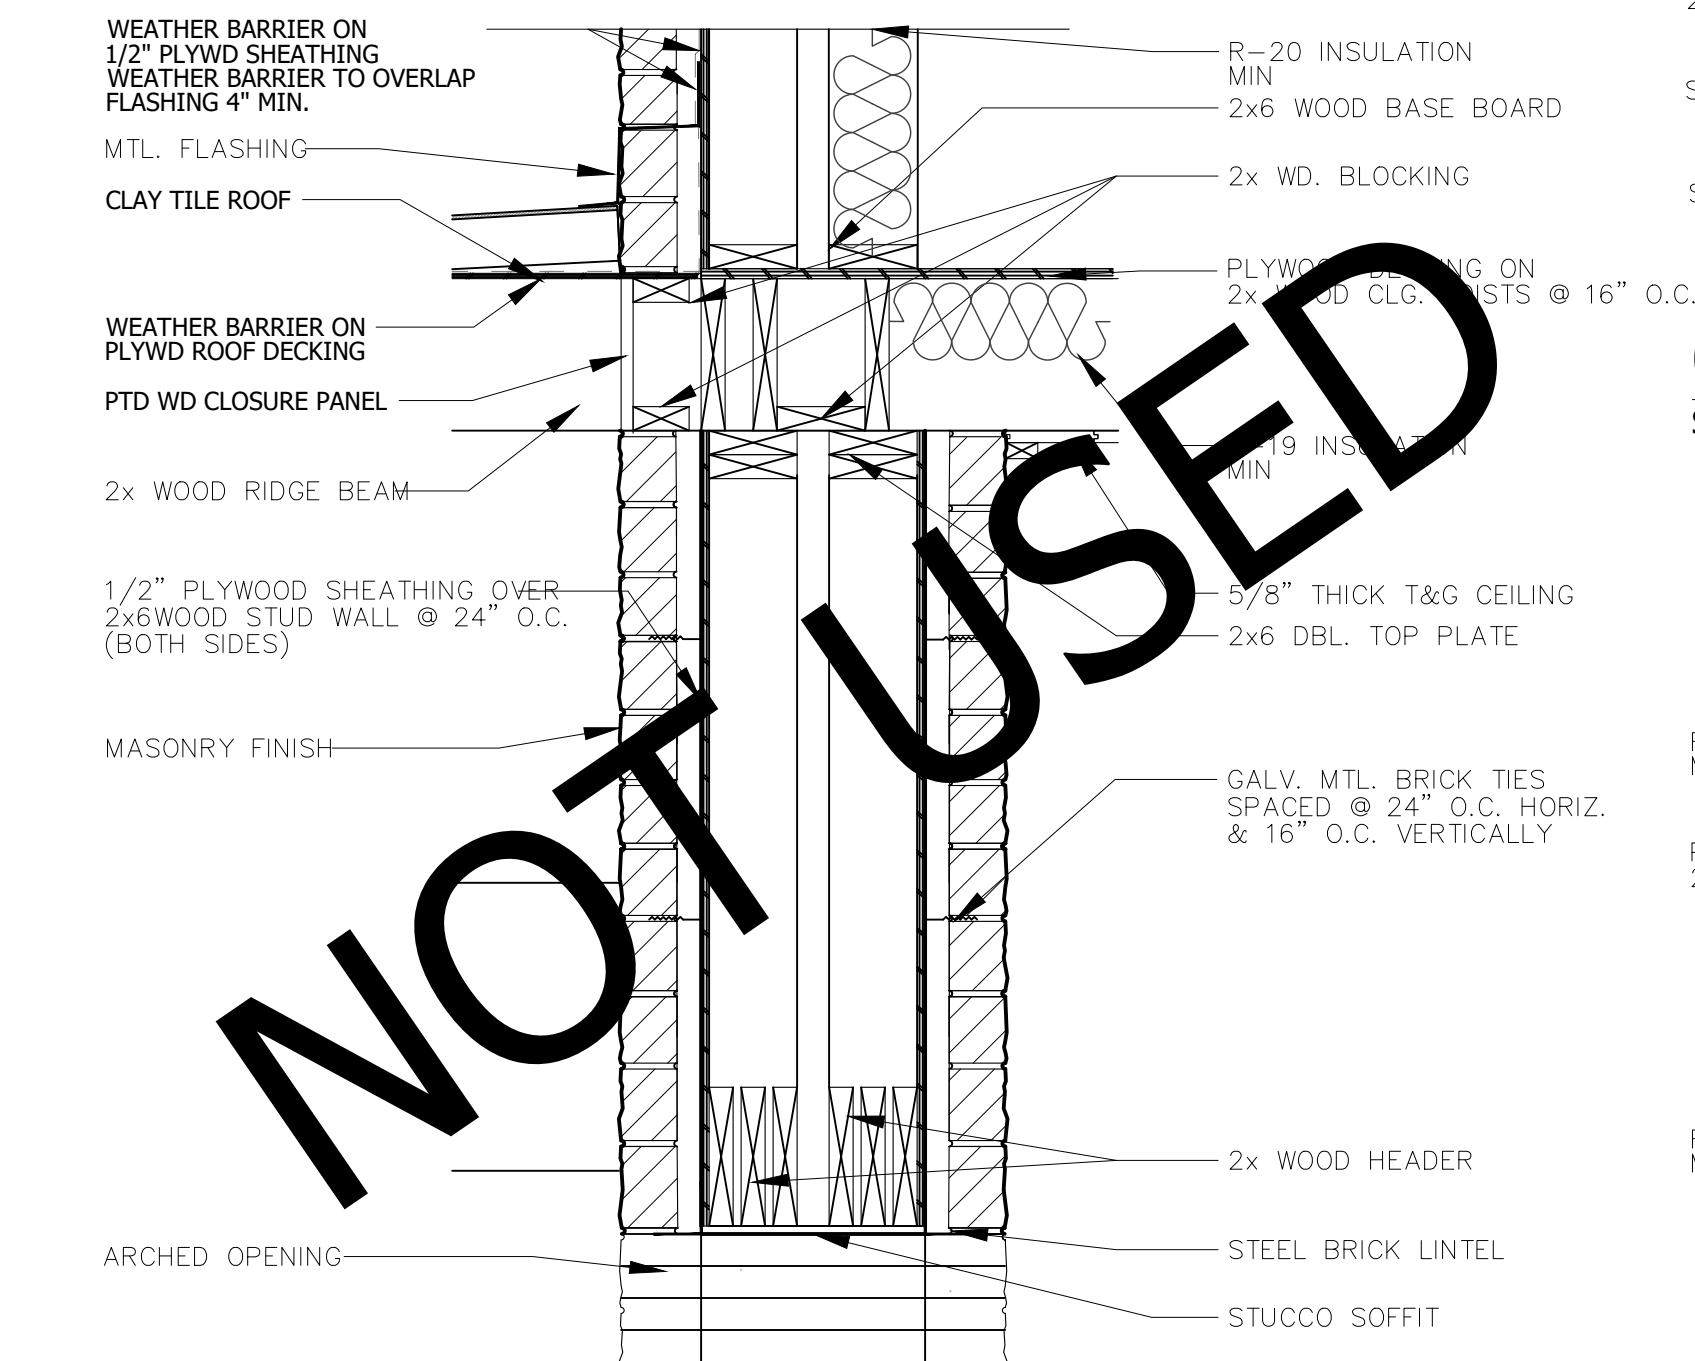


05 ARCHED OPENING DETAIL
SCALE: 1" = 1'-0"

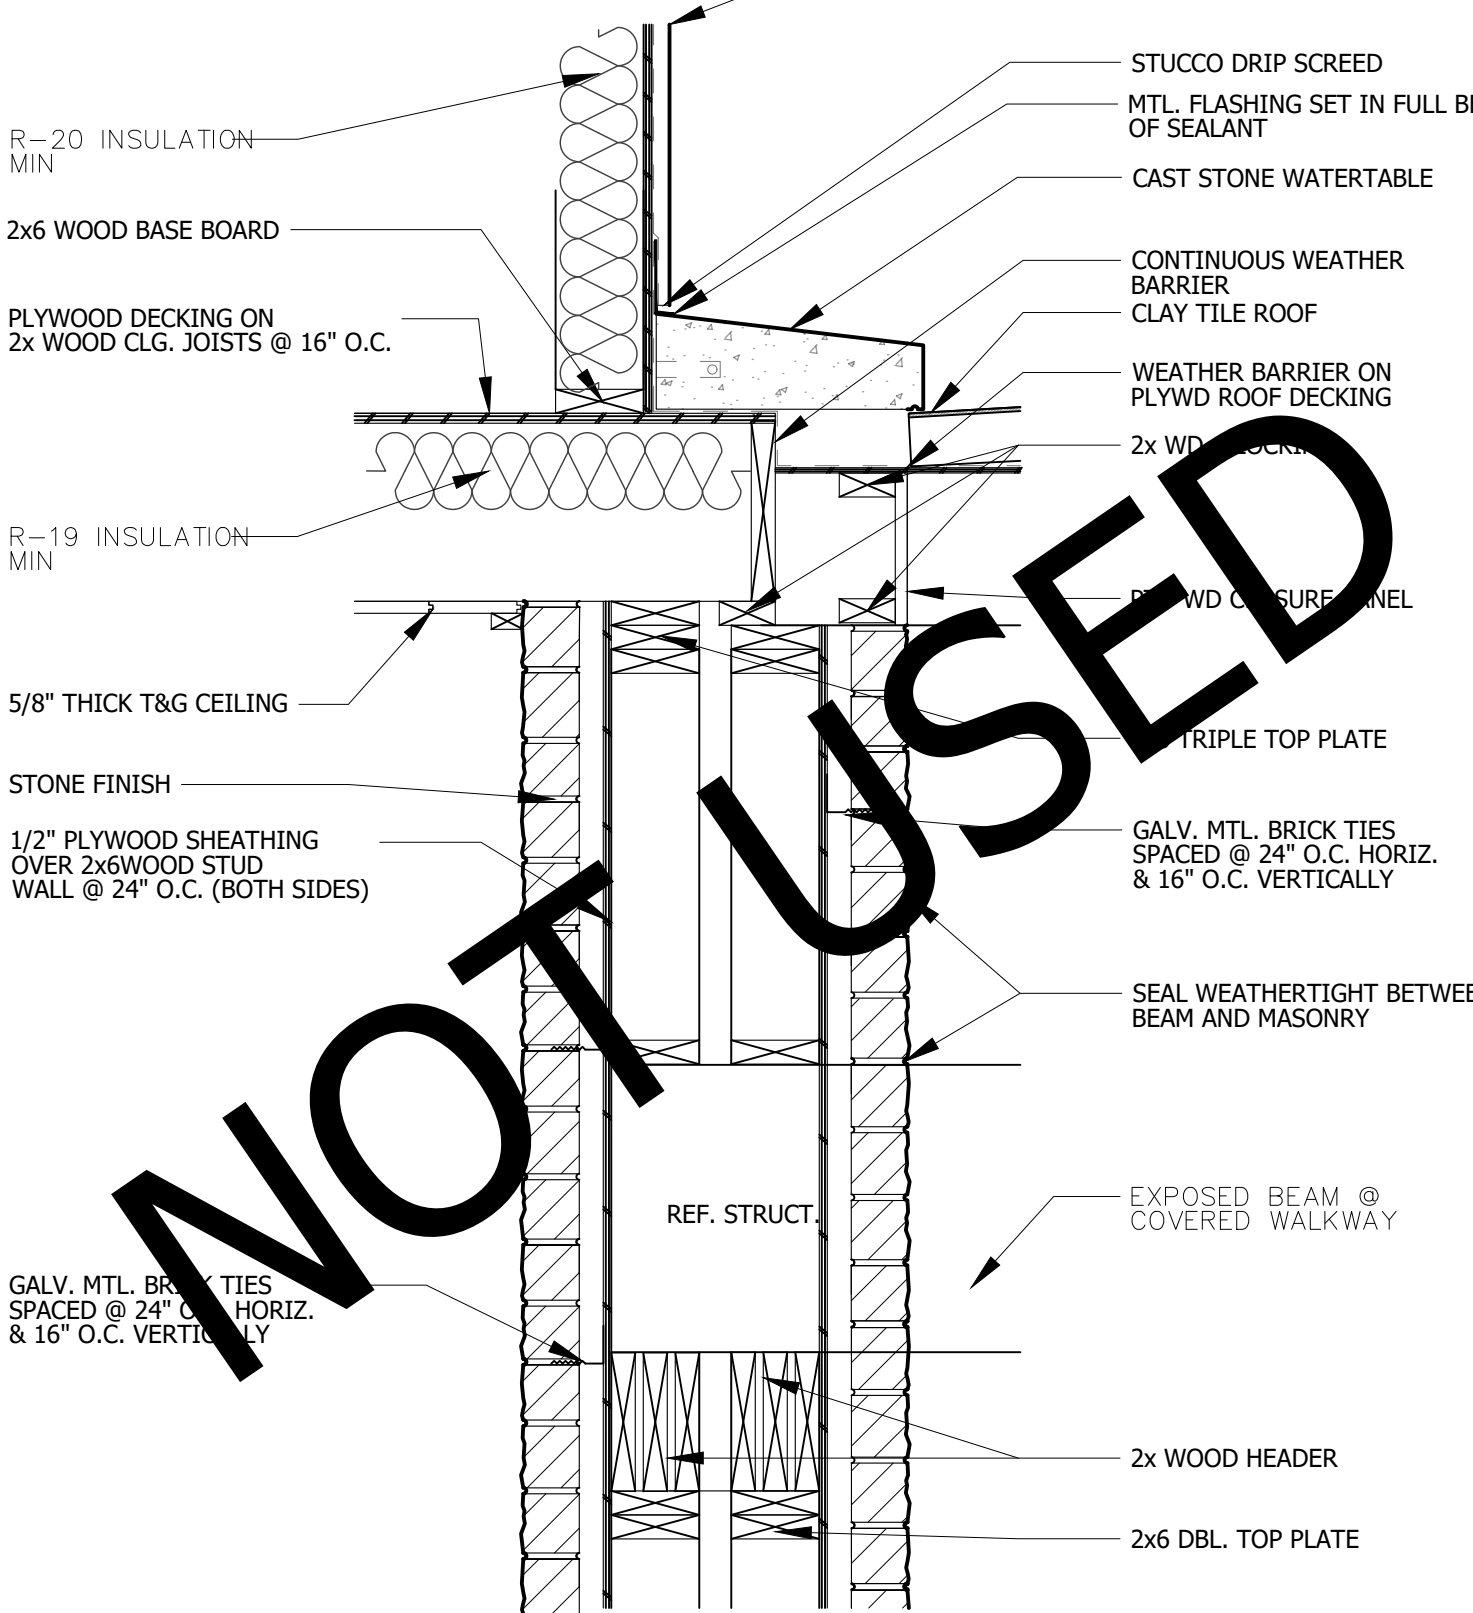


04 WATERTABLE DETAIL
SCALE: 1" = 1'-0"

03 WATERTABLE DETAIL
SCALE: 1" = 1'-0"

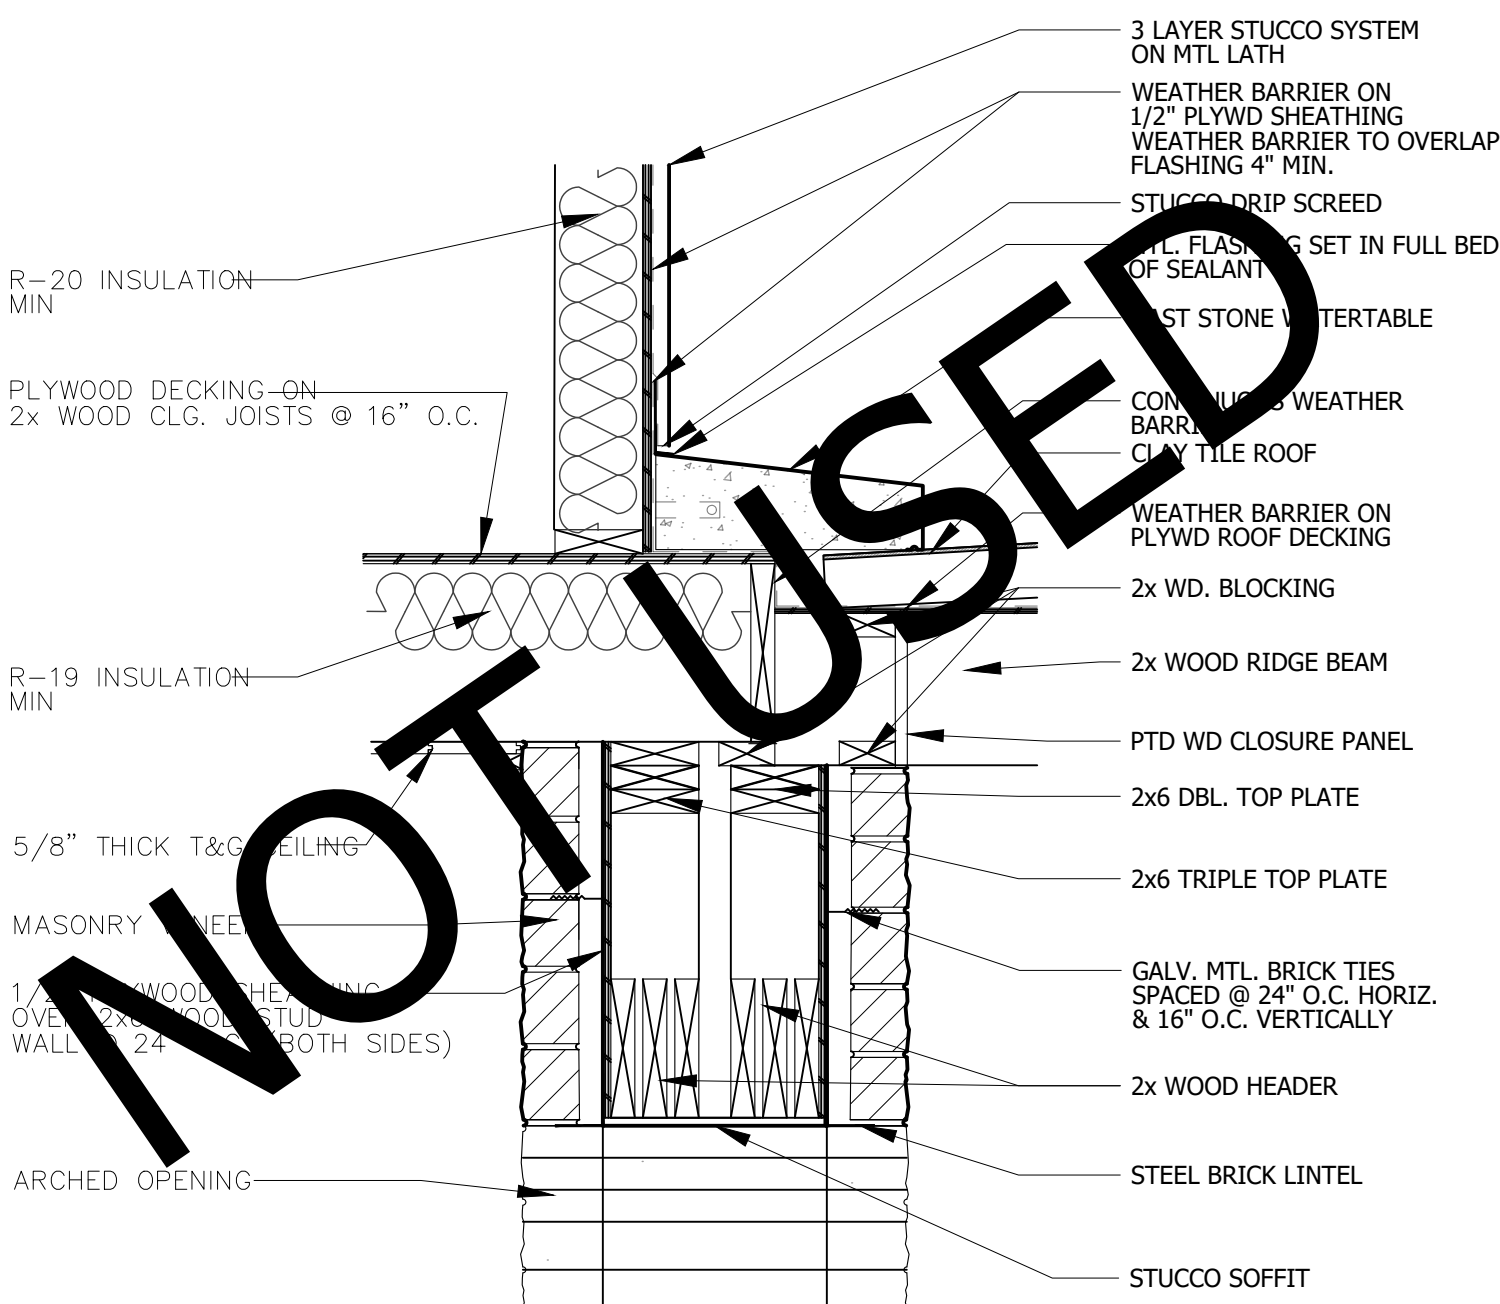

02 WATERTABLE DETAIL
SCALE: 1" = 1'-0"

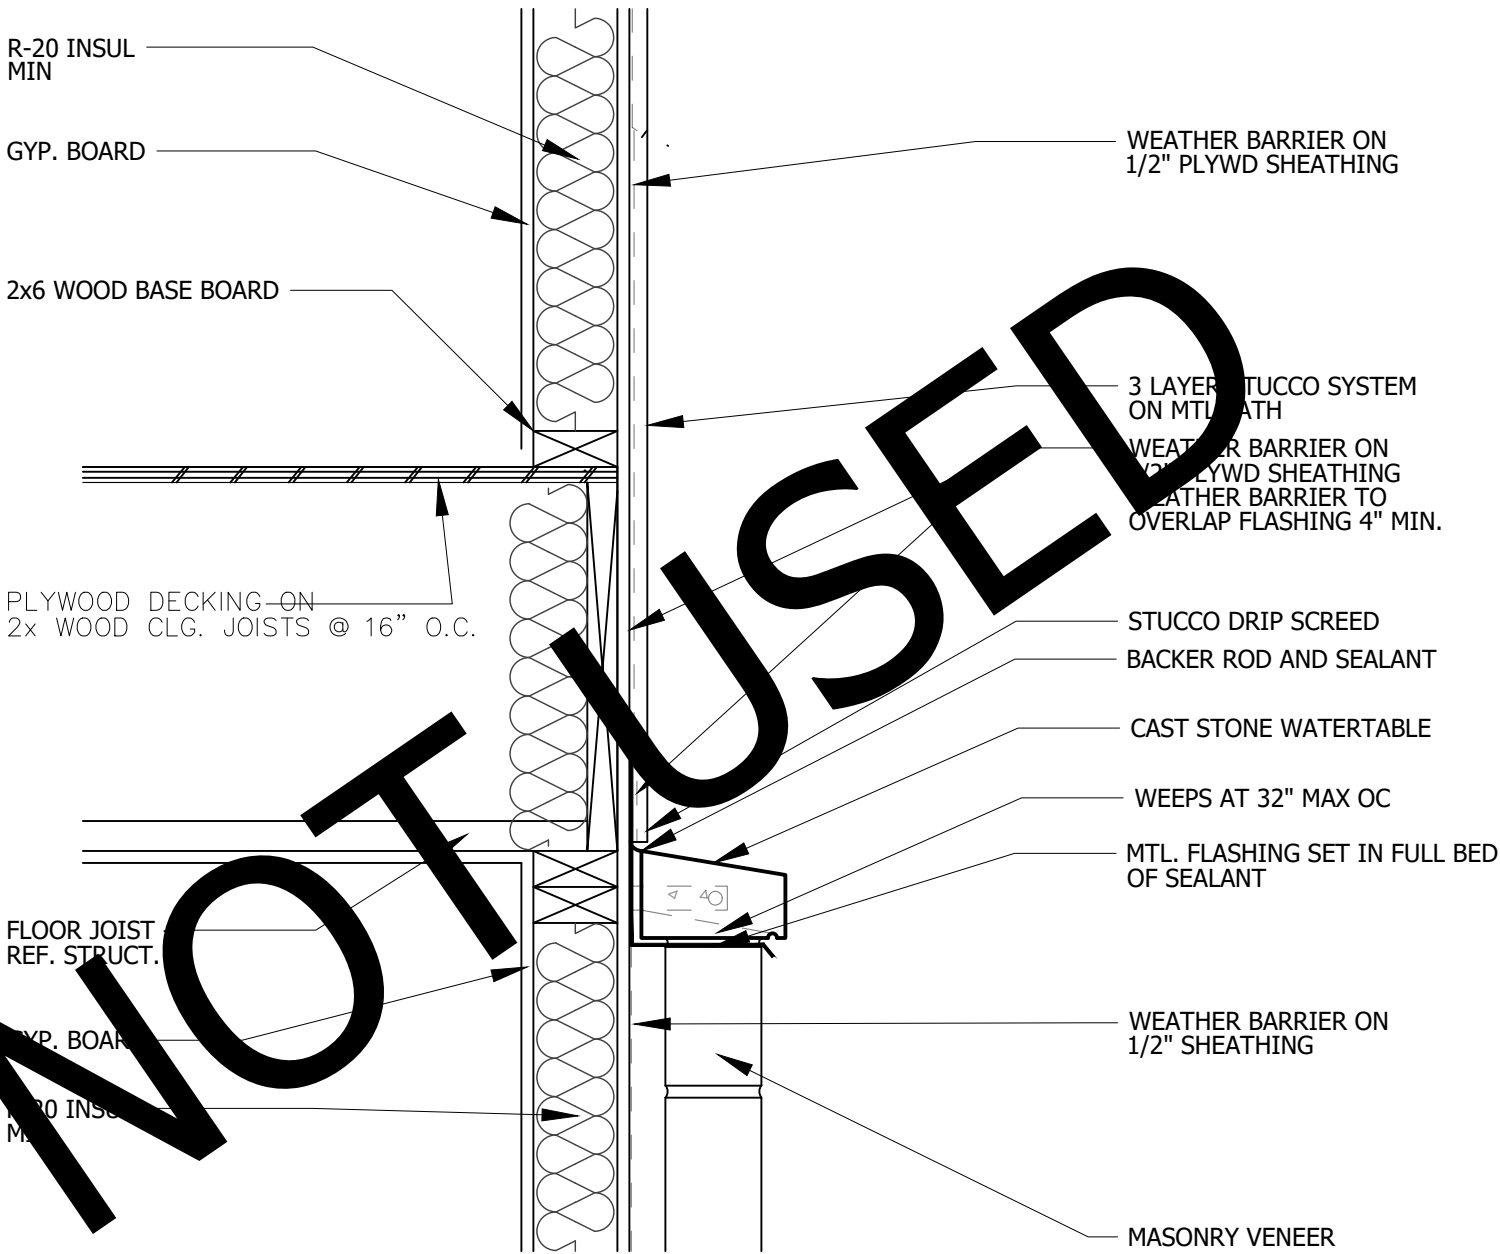

01 STONE/ STUCCO TRANSITION DETAIL
SCALE: 1 1/2" = 1'-0"

ENTRADA

LOT 02, BLOCK H

TOWN OF WESTLAKE TARRANT COUNTY, TEXAS


ISSUE LOG

NO.	DESCRIPTION	DATE



PROJECT NO:	20-130
ISSUED FOR:	OTP
DRAWN BY:	Checker
DATE:	06/16/21

STANDARD DETAILS


A502

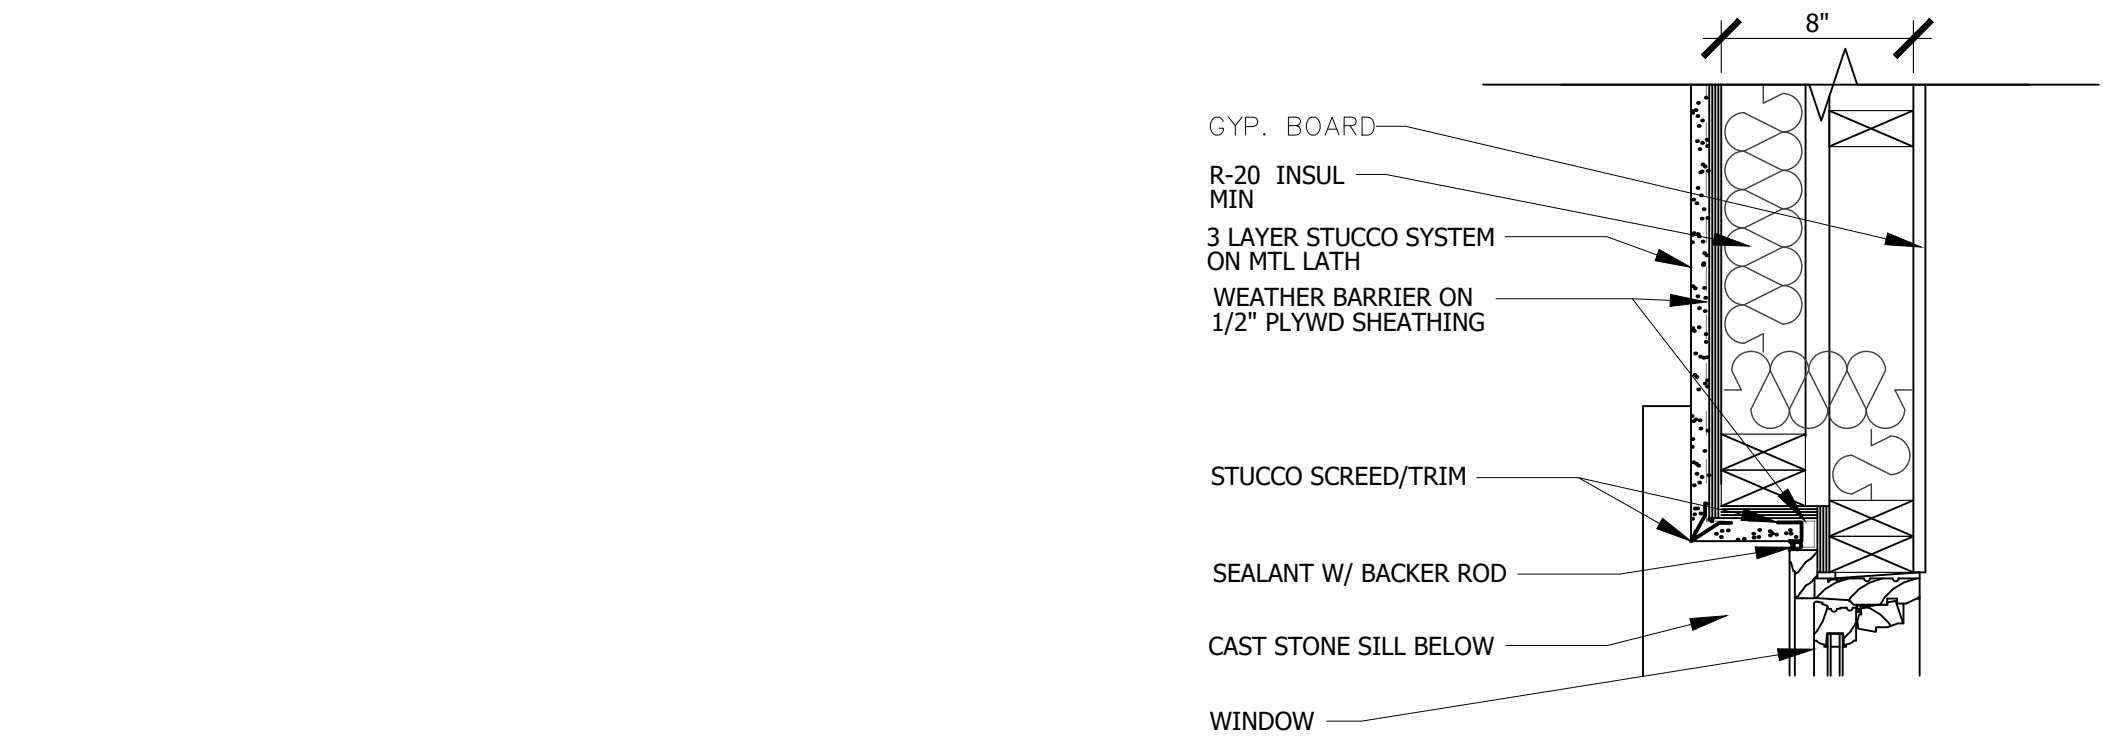


10 WINDOW JAMB
SCALE: 1 1/2" = 1'-0"

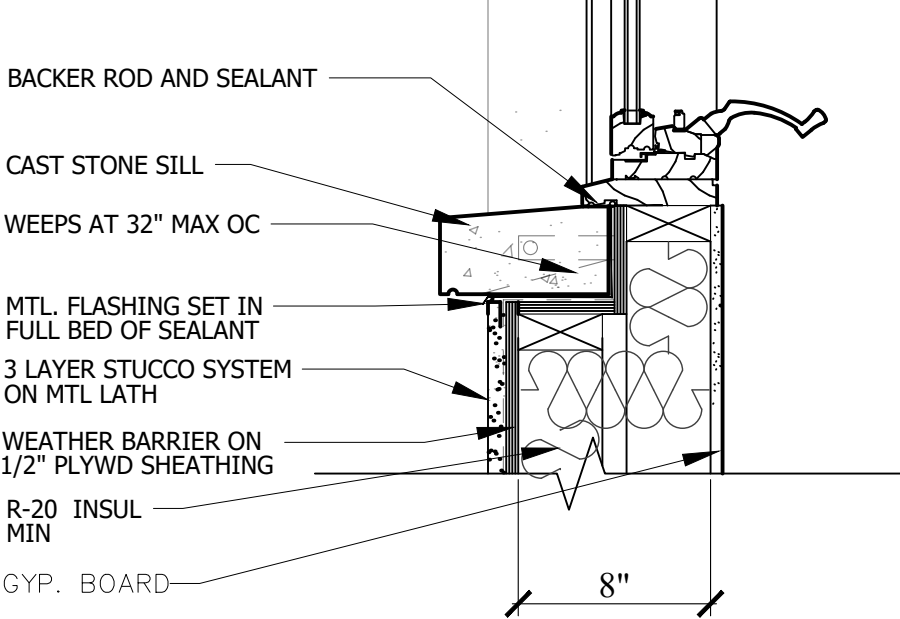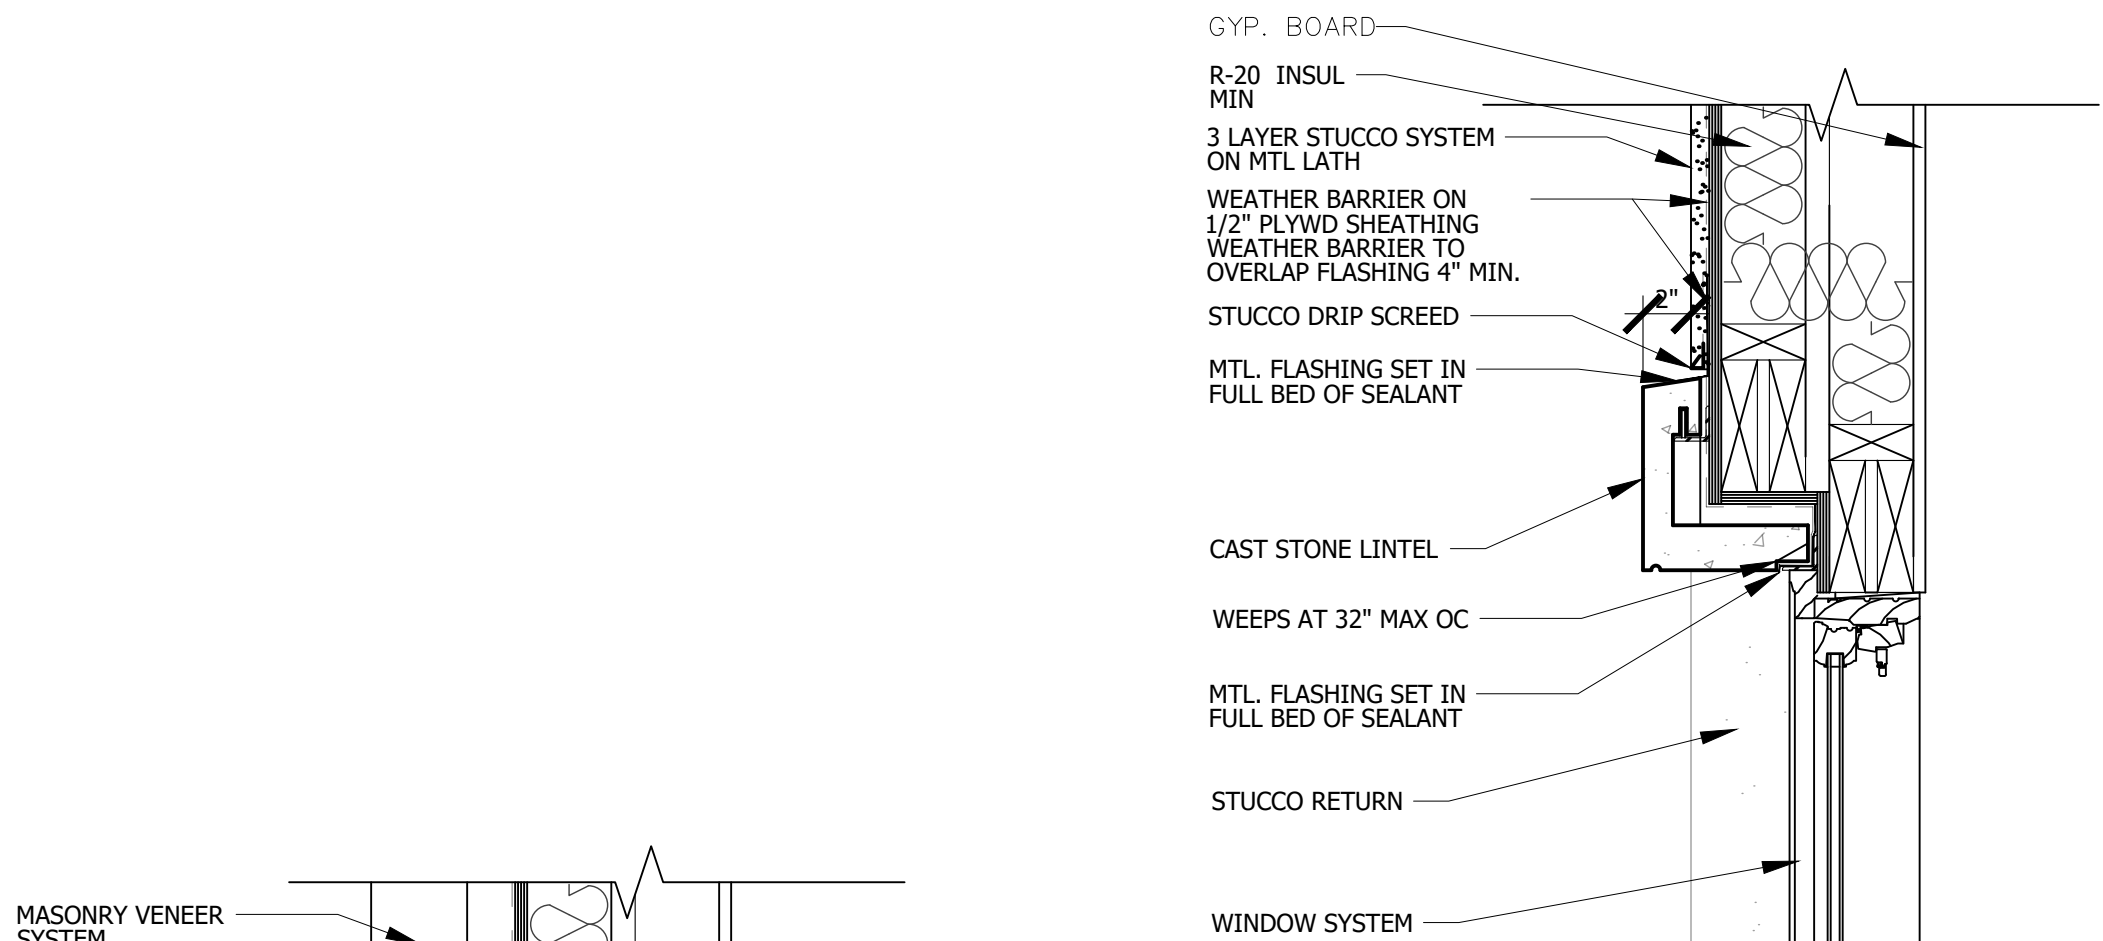


09 WINDOW SECTION
SCALE: 1 1/2" = 1'-0"

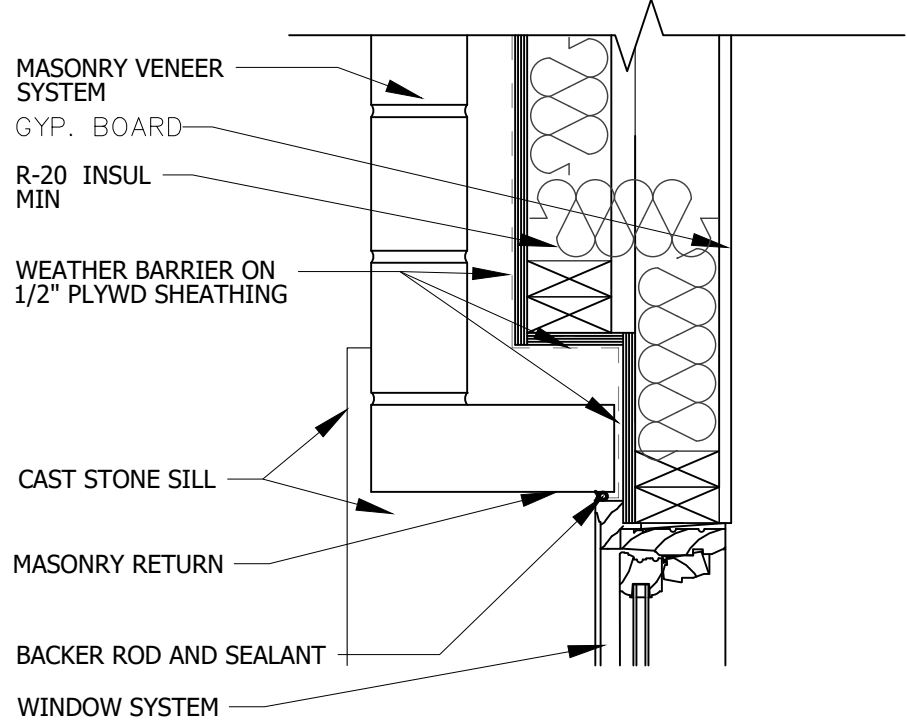


12 WINDOW JAMB
SCALE: 1 1/2" = 1'-0"

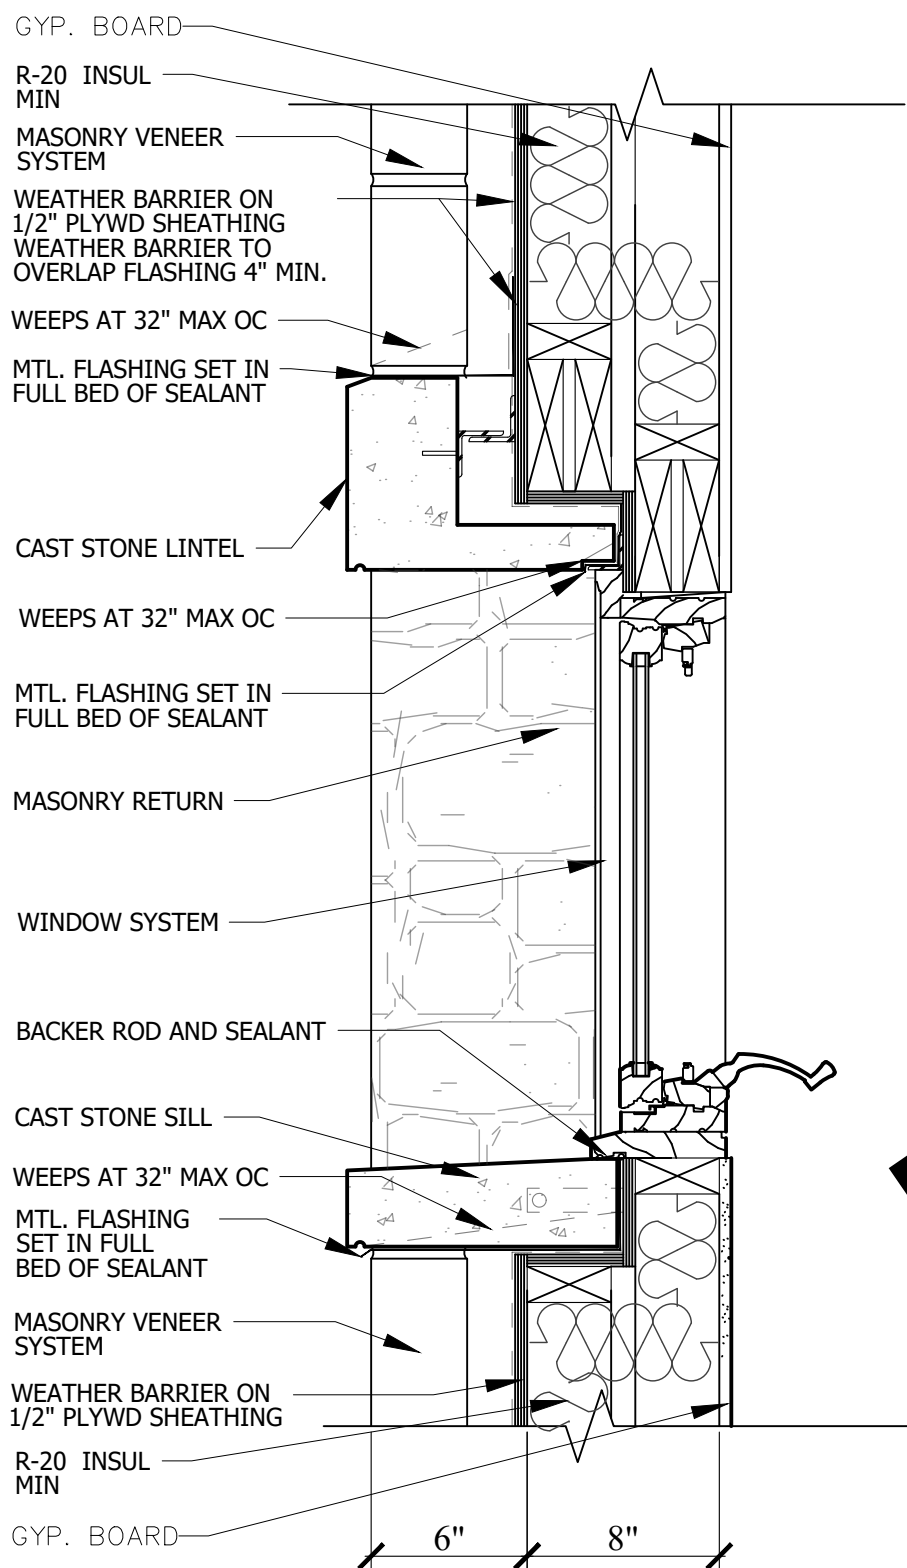


11 WINDOW SECTION
SCALE: 1 1/2" = 1'-0"

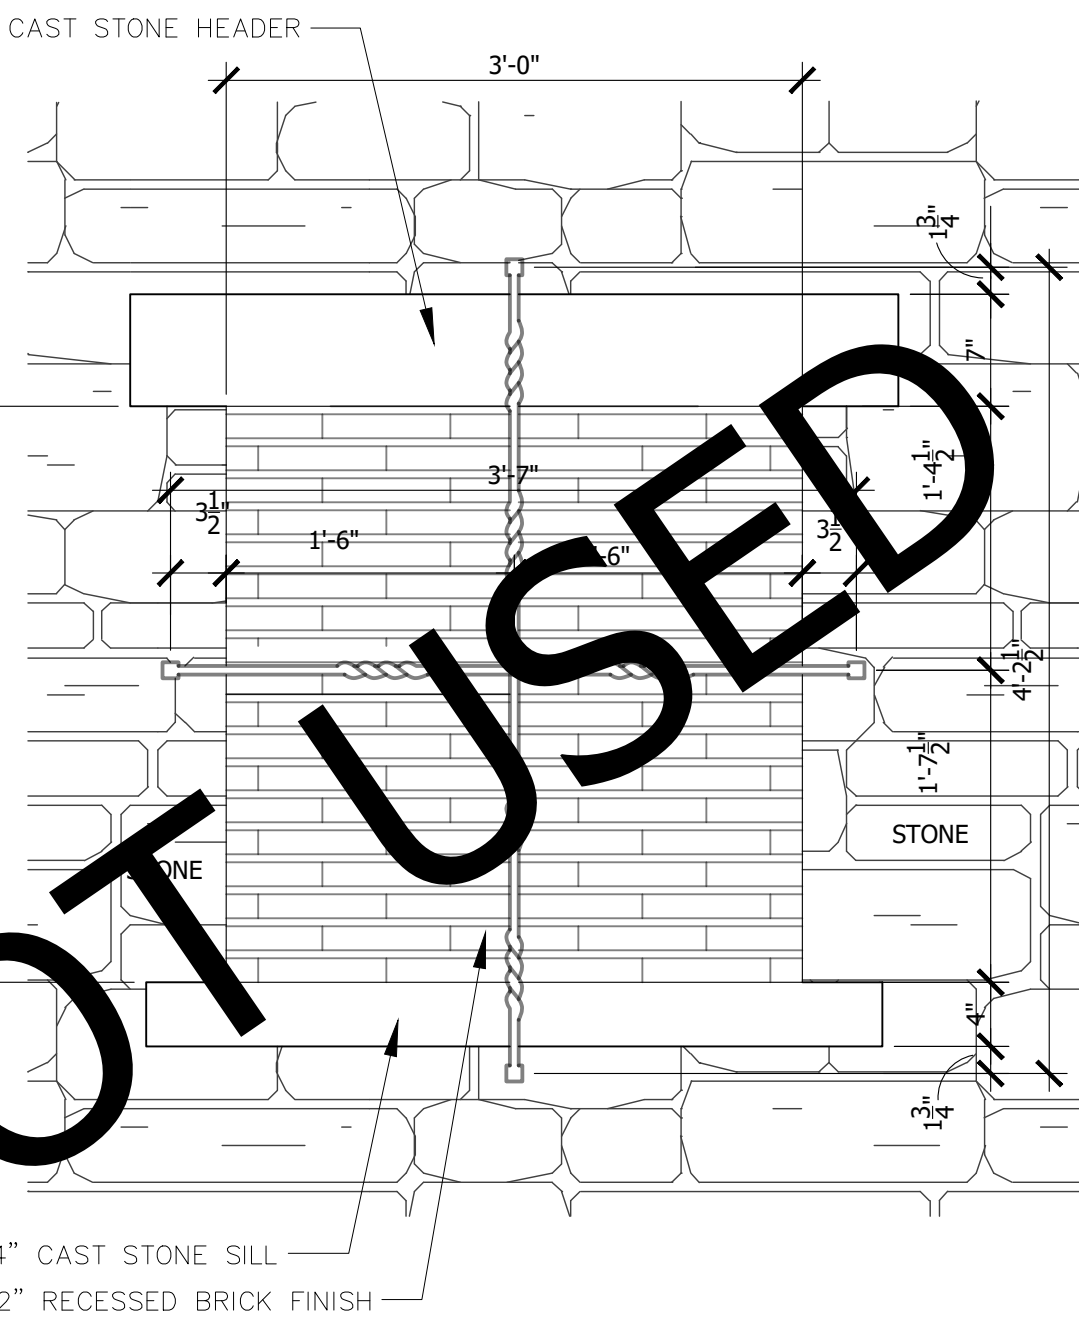


08 INSET BRICK DETAIL
W/ DECORATIVE WROUGHT IRON
SCALE: 1" = 1'-0"

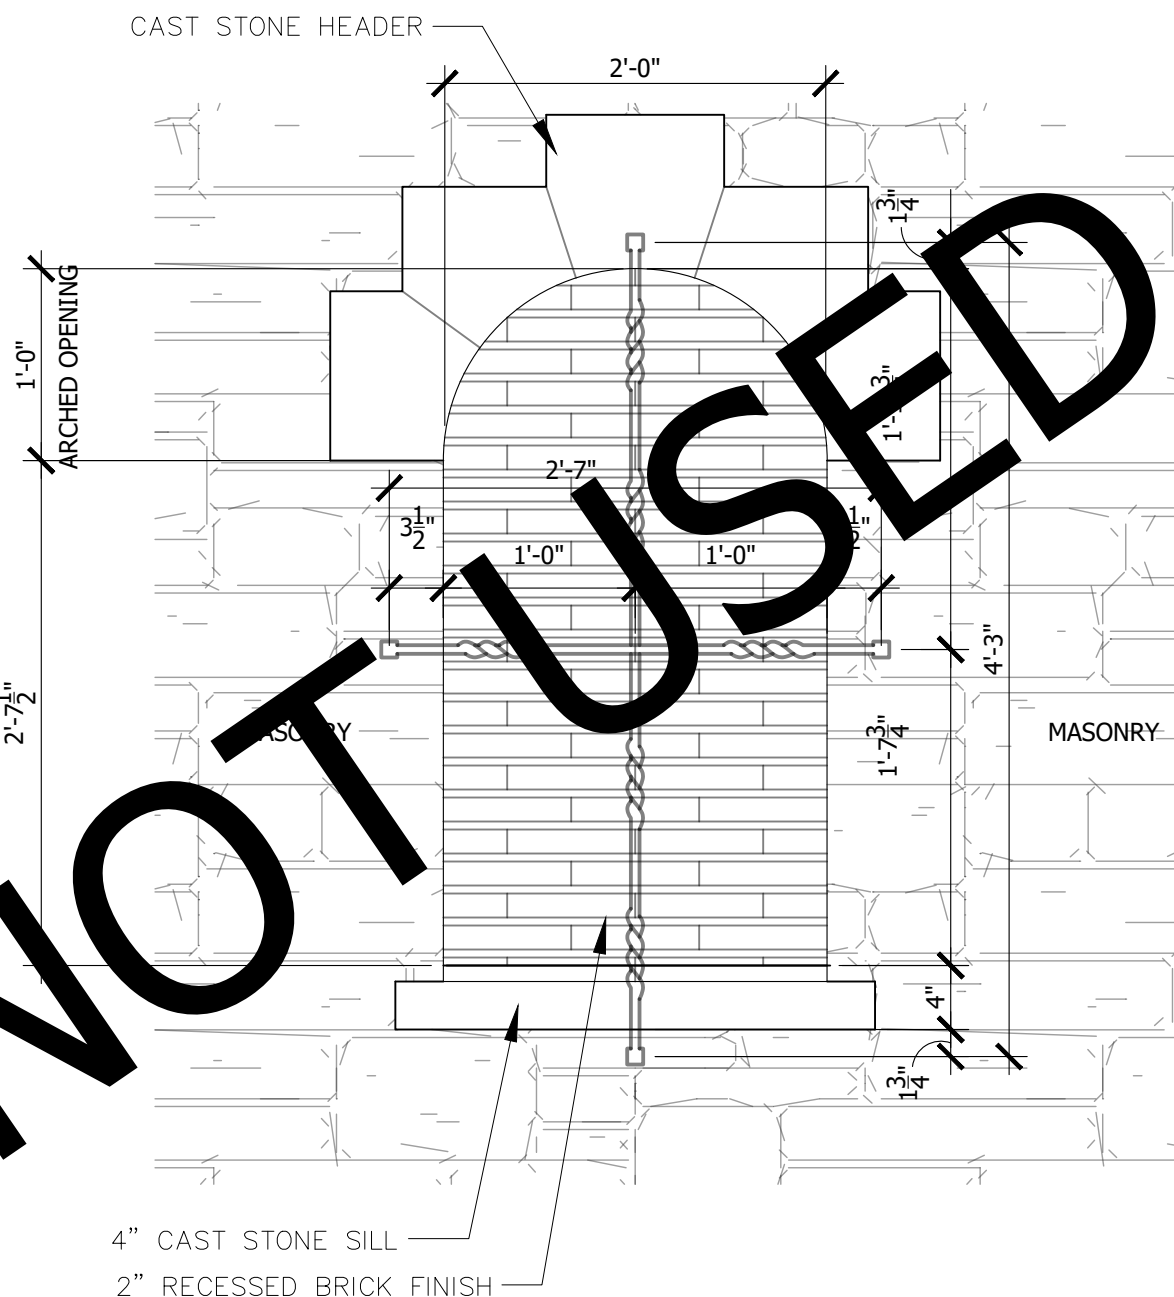


07 INSET BRICK DETAIL
W/ DECORATIVE WROUGHT IRON
SCALE: 1" = 1'-0"

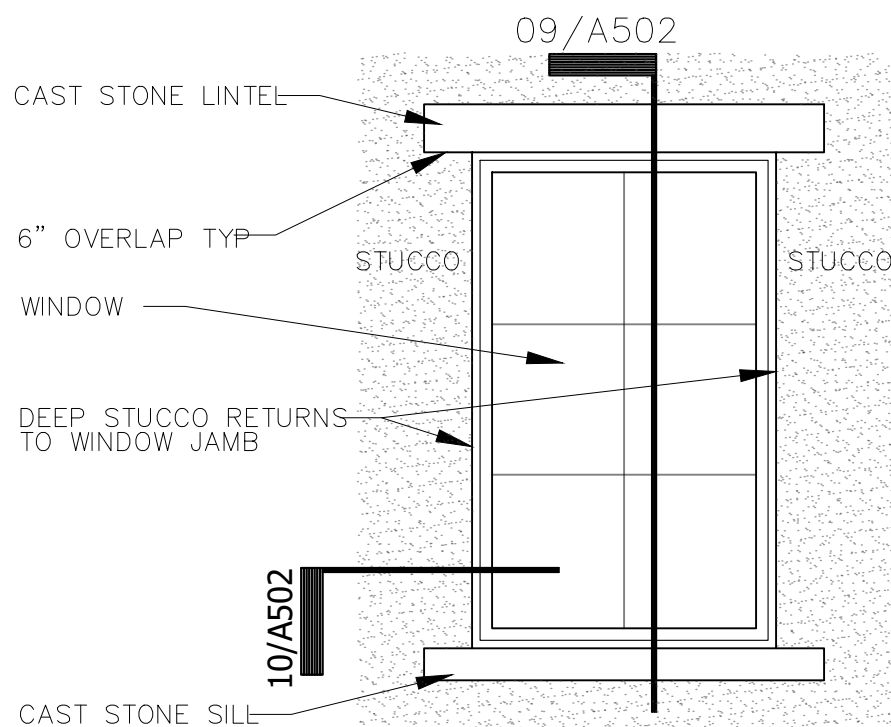


06 CAST STONE LINTEL SILL
SCALE: 1/2" = 1'-0"

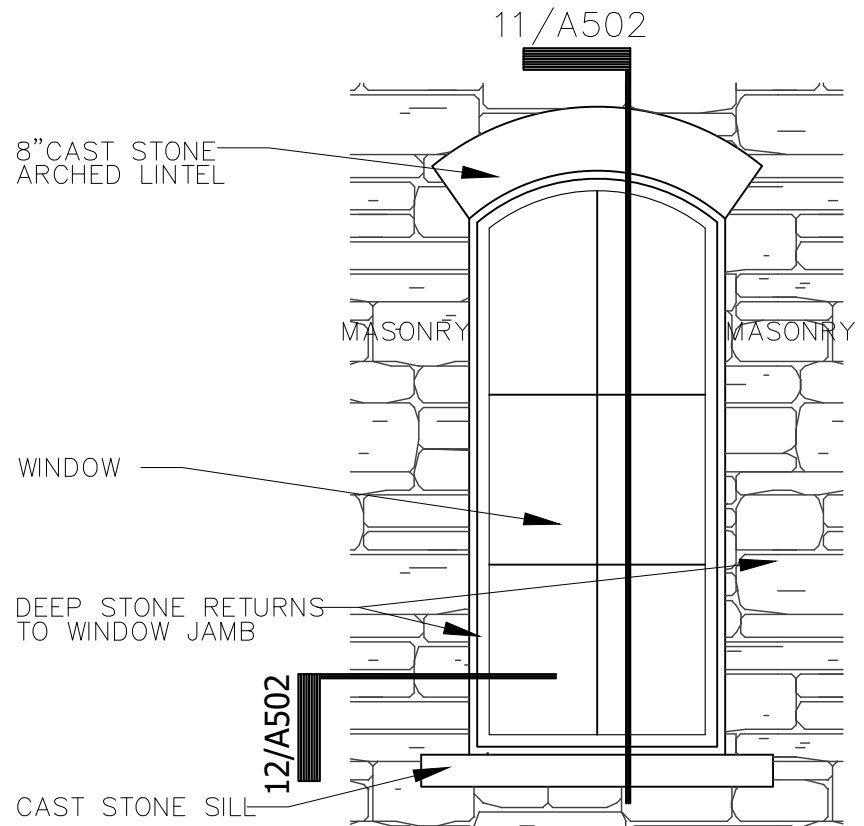


05 CAST STONE LINTEL/SILL
SCALE: 1/2" = 1'-0"

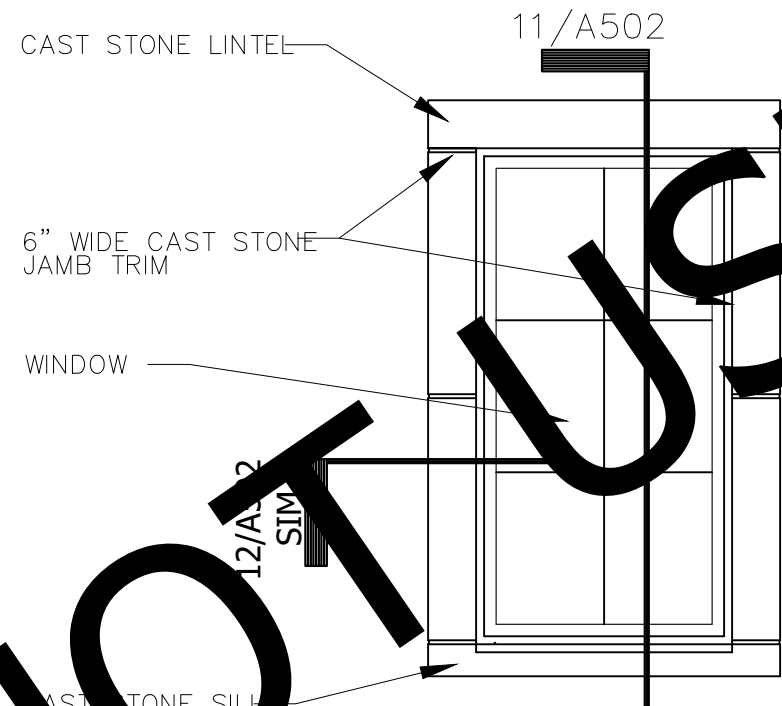


03 CAST STONE
SURROUND DETAIL
SCALE: 1/2" = 1'-0"

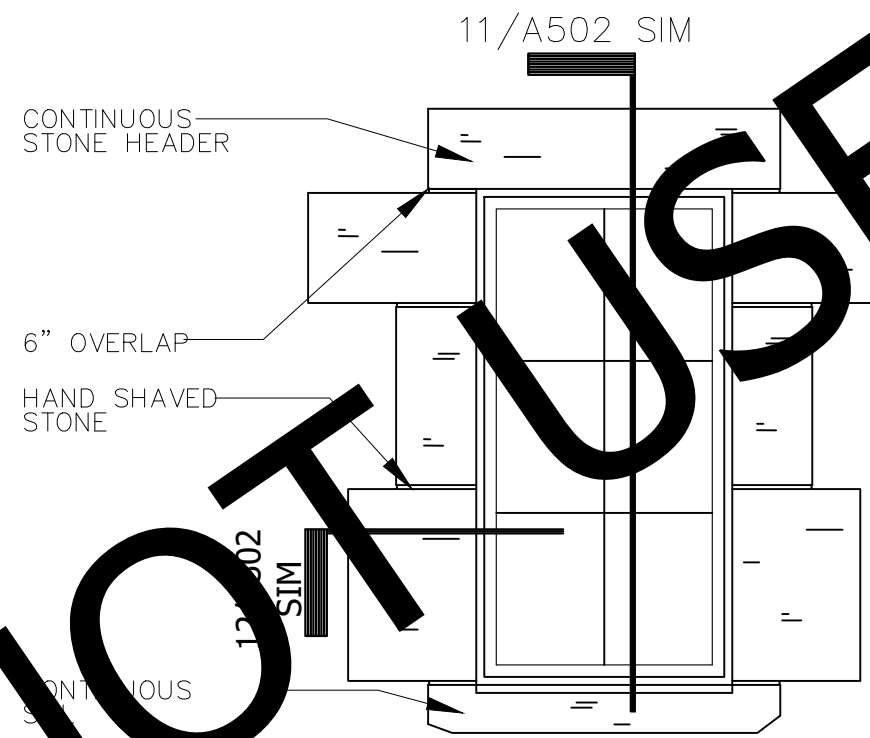

05 NATURAL STONE
SURROUND DETAIL
SCALE: 1/2" = 1'-0"

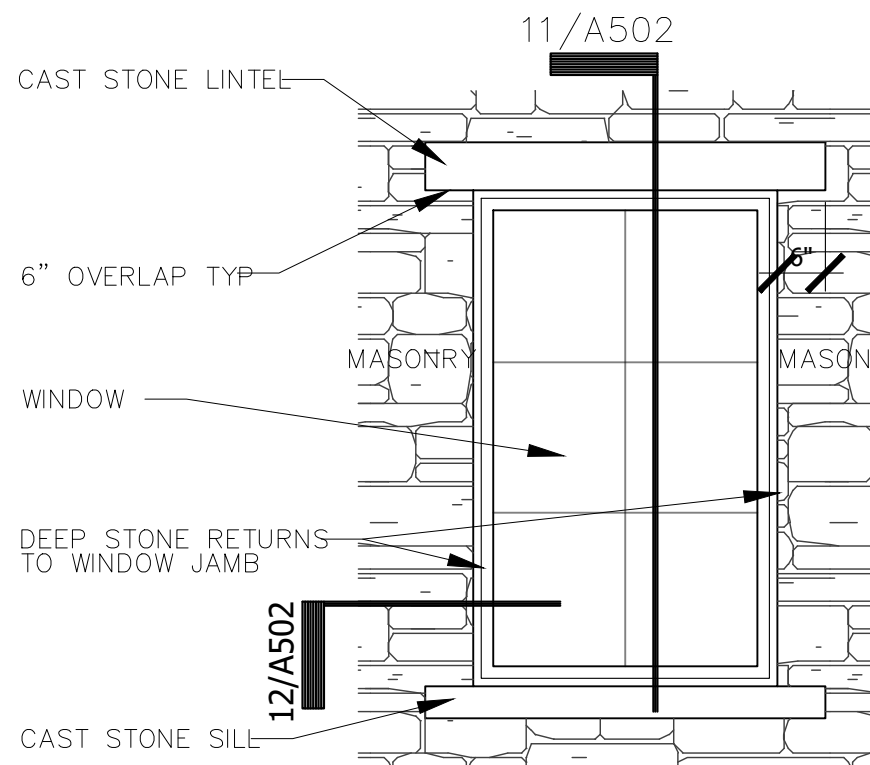

02 CAST STONE LINTEL/SILL
SCALE: 1/2" = 1'-0"

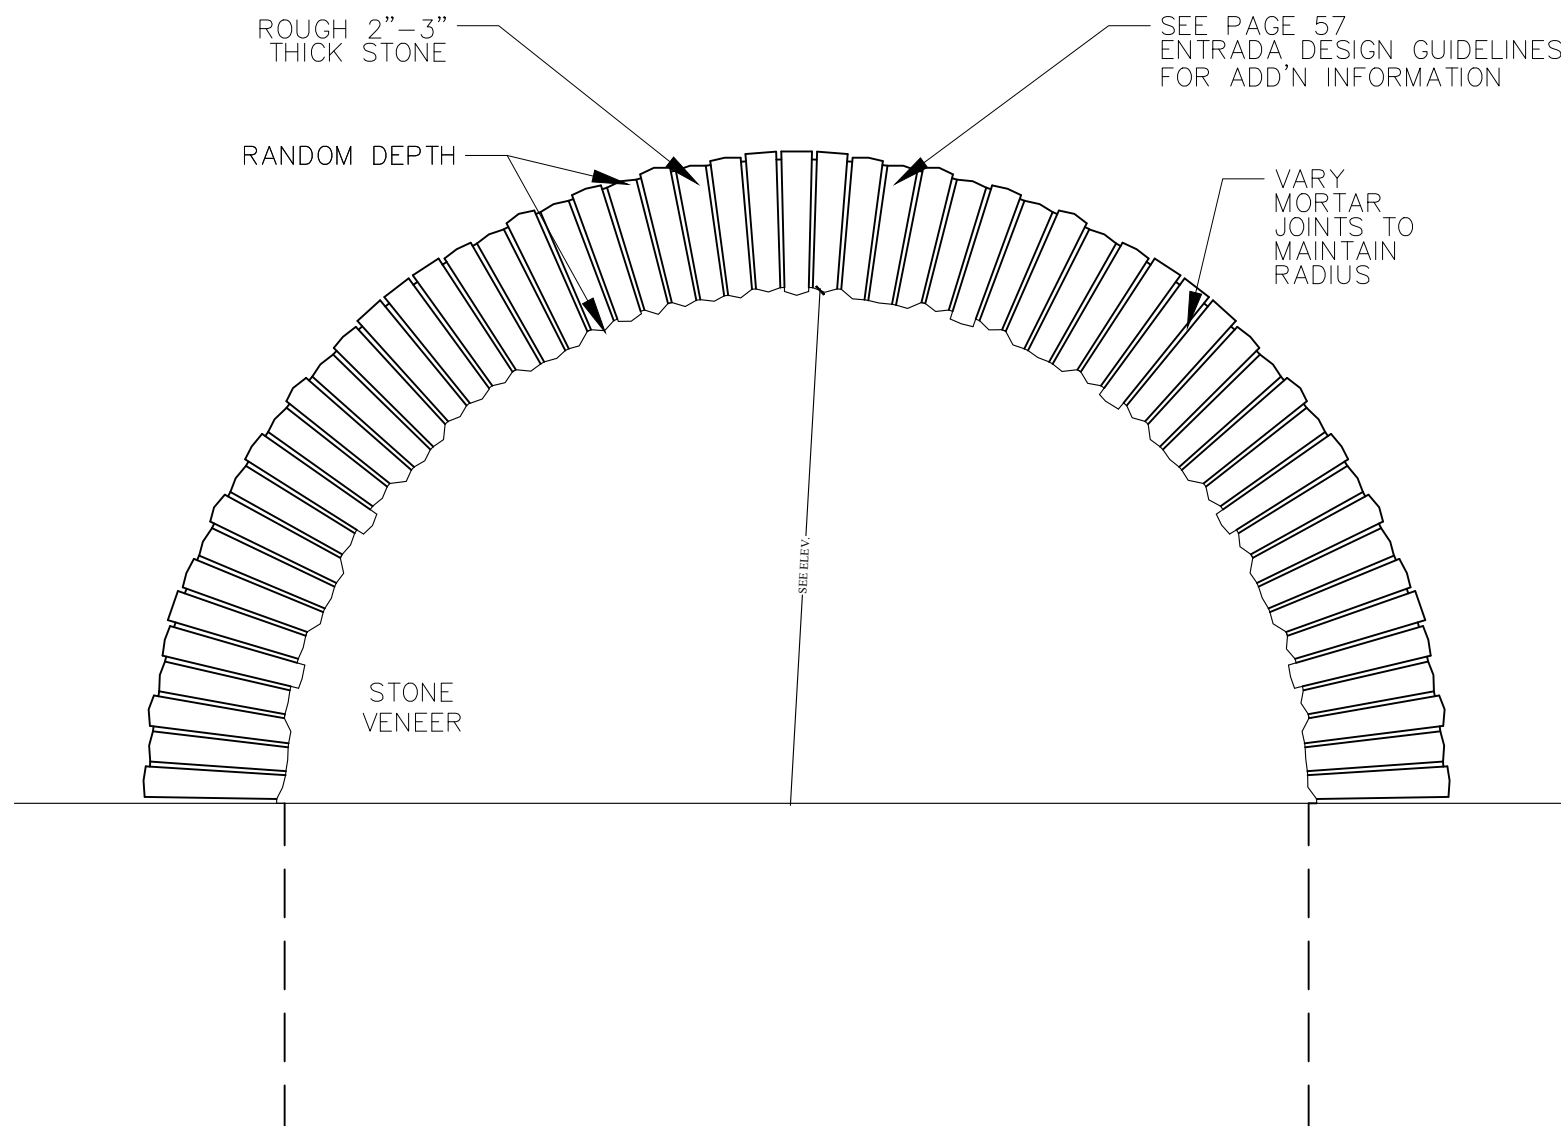

01 ROUGH ARCH DETAIL
SCALE: 1/2" = 1'-0"

REFER TO **ENTRADA DESIGN GUIDELINES** FOR FUTHER DETAILED INFORMATION REGARDING THESE PLANS

ENTRADA

LOT 02, BLOCK H

TOWN OF WESTLAKE TARRANT COUNTY, TEXAS












ISSUE LOG

NO.	DESCRIPTION	DATE

PROJECT NO:	20-130
ISSUED FOR:	OTP
DRAWN BY:	Checker
DATE:	06/16/21

MISC DETAILS

A503

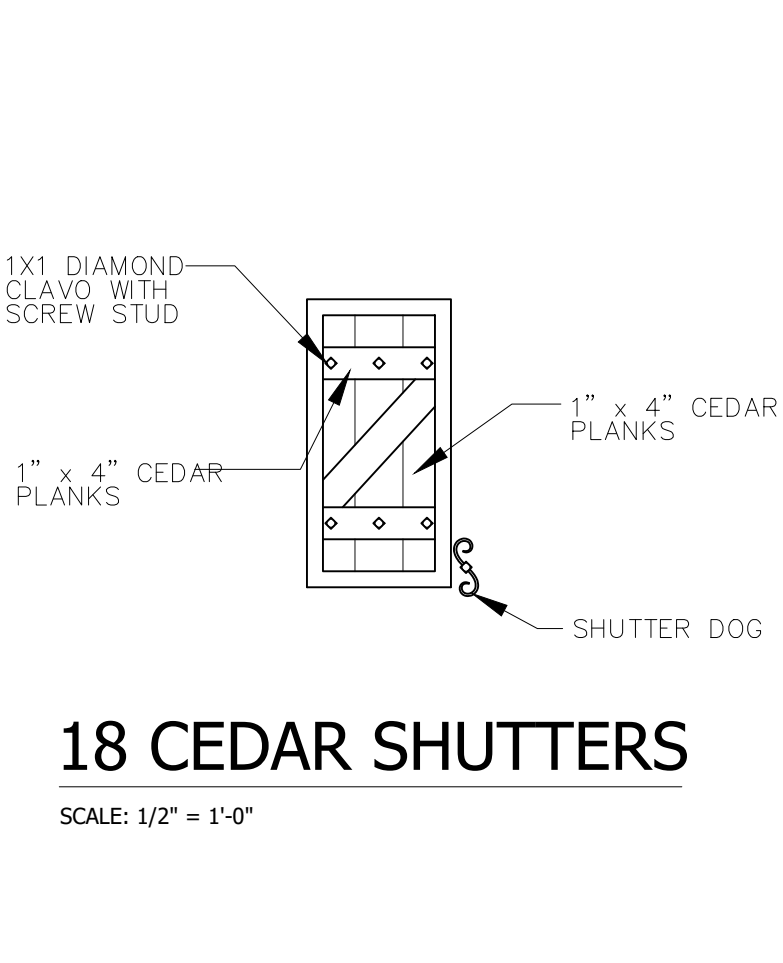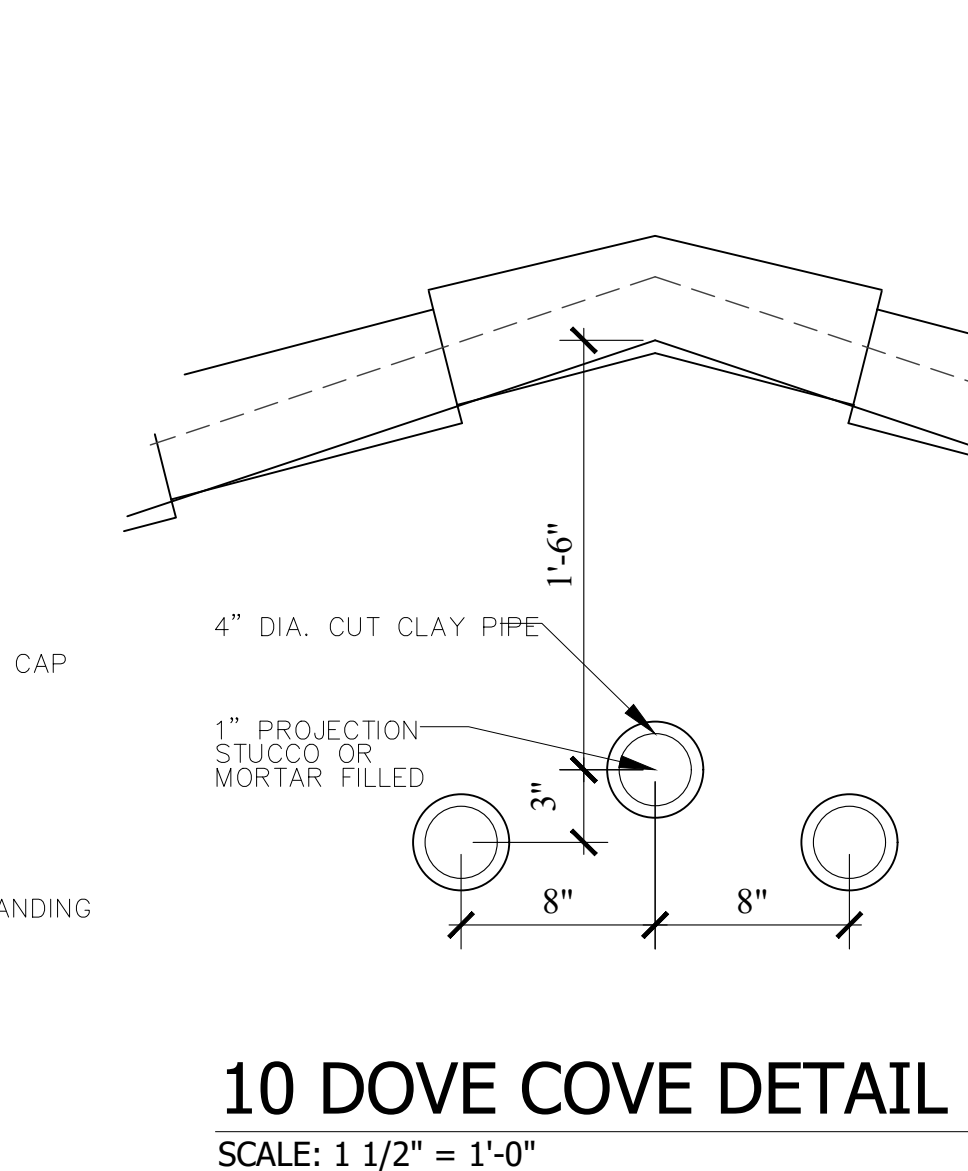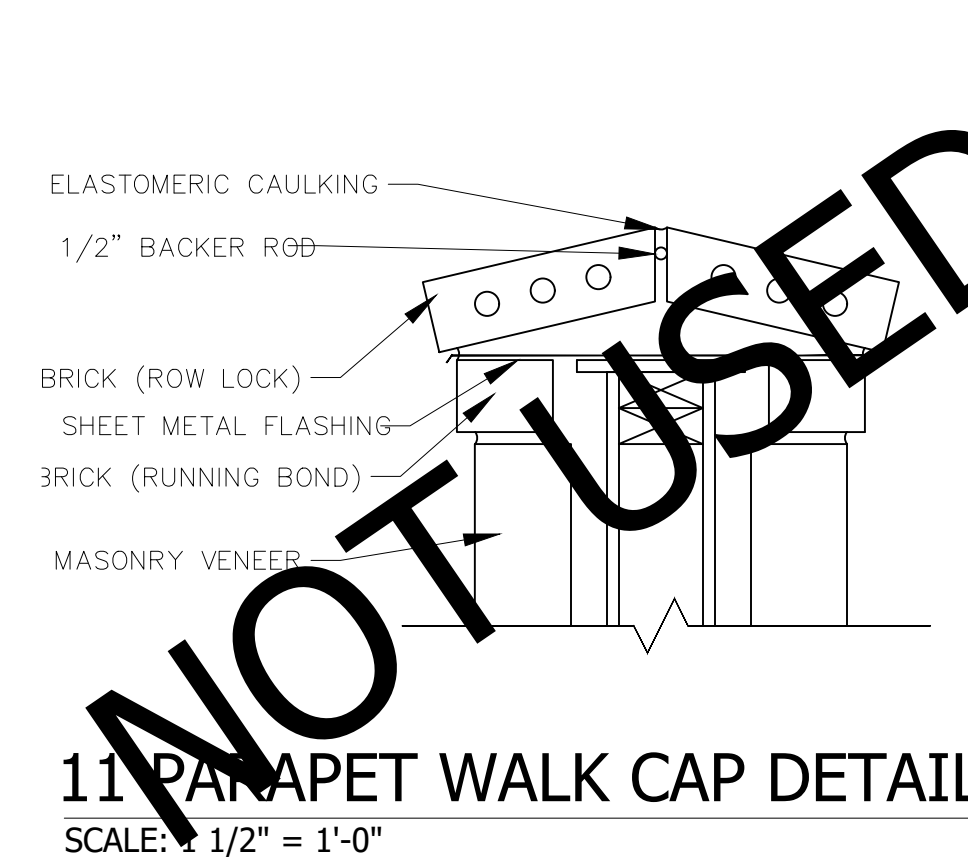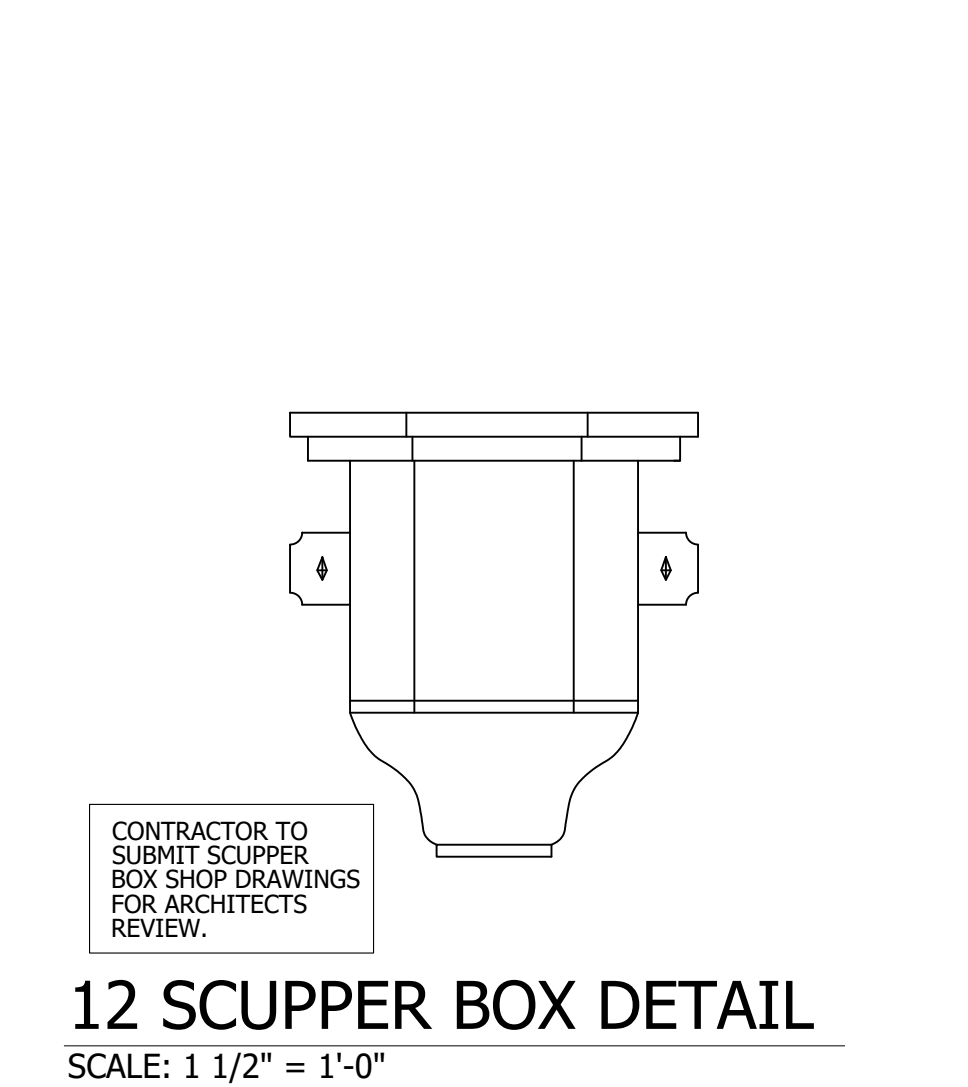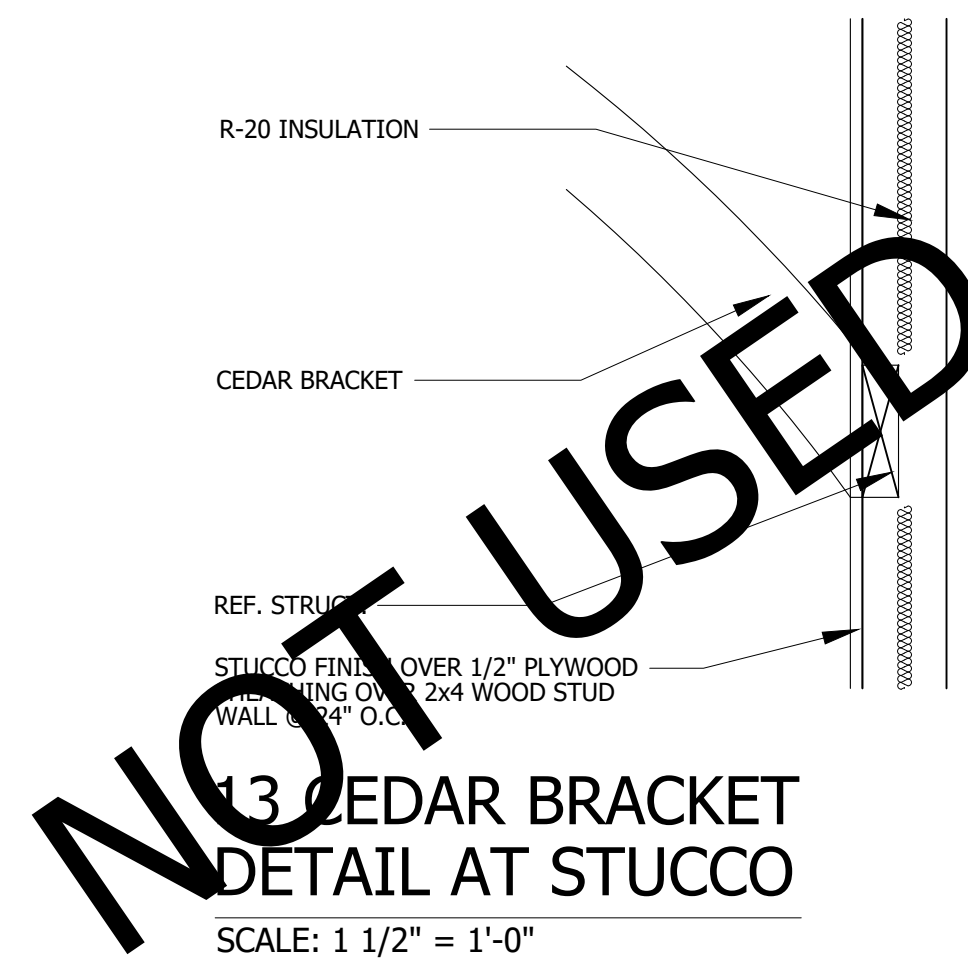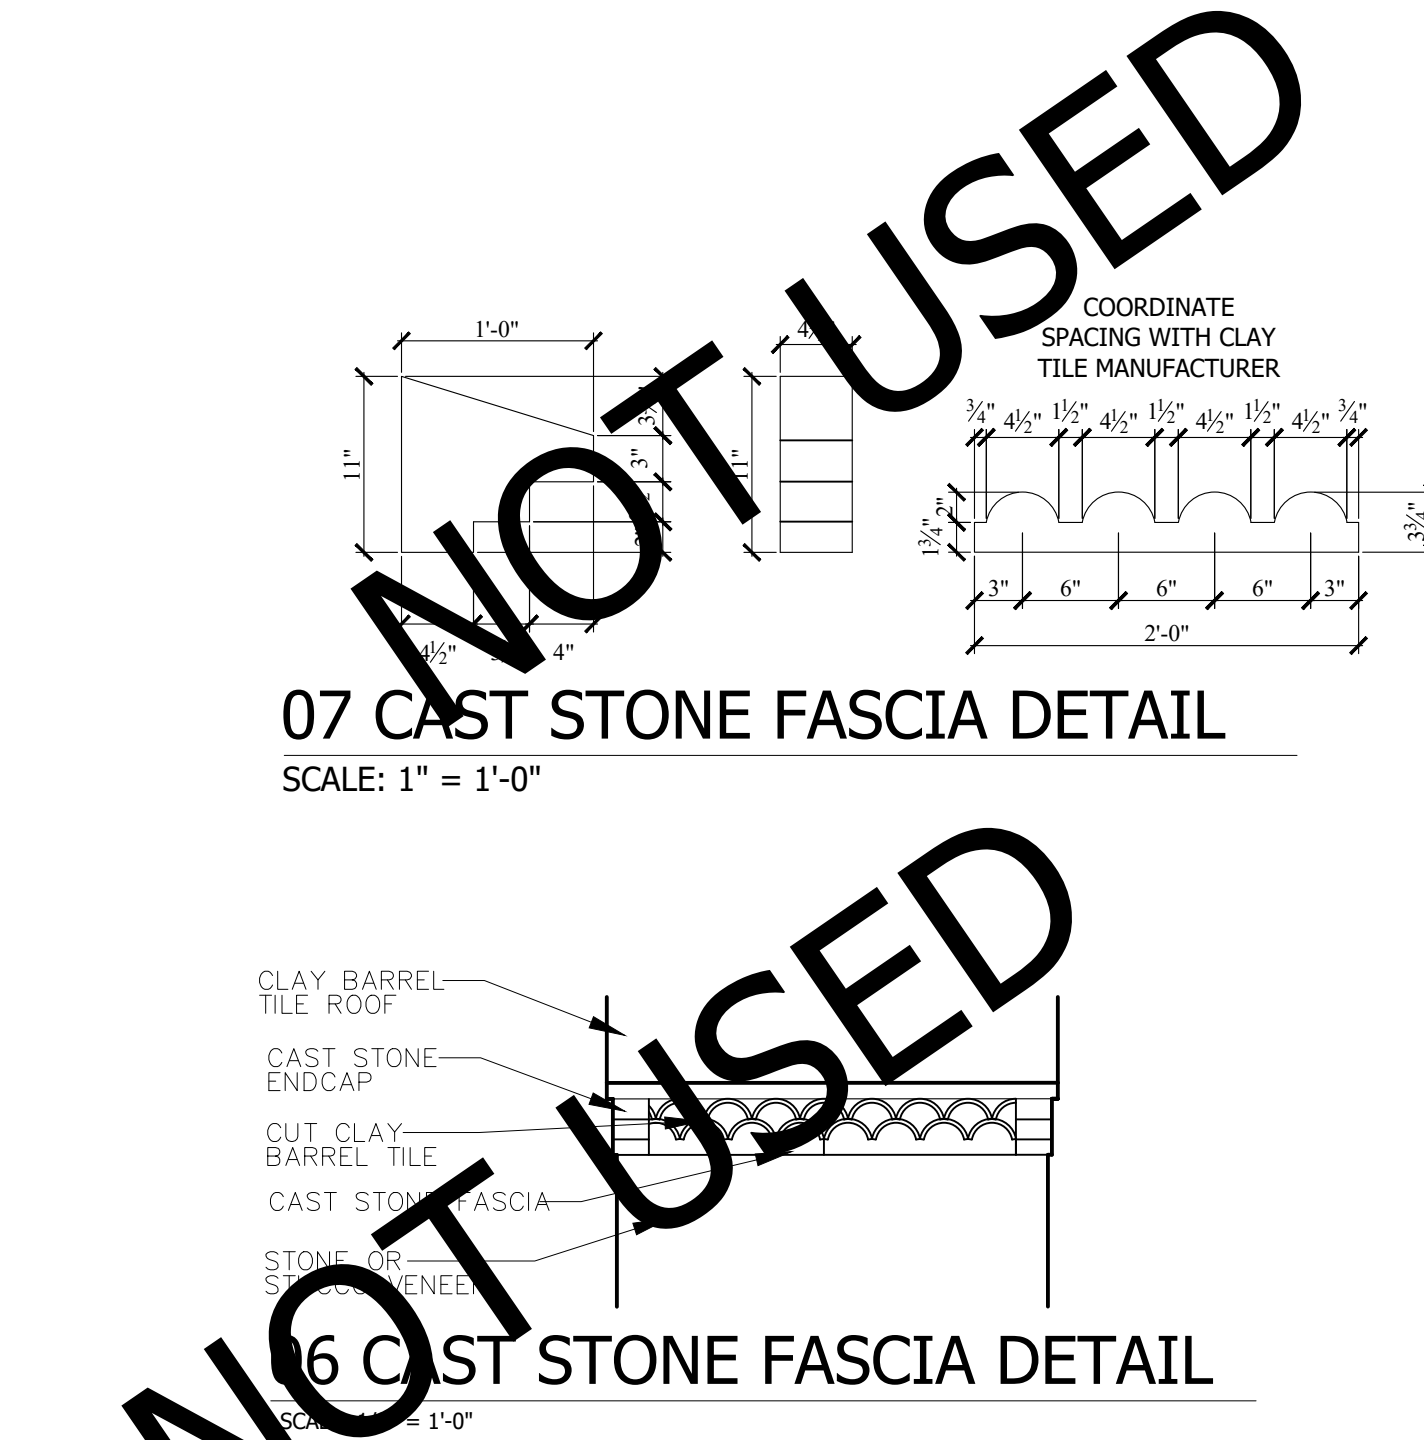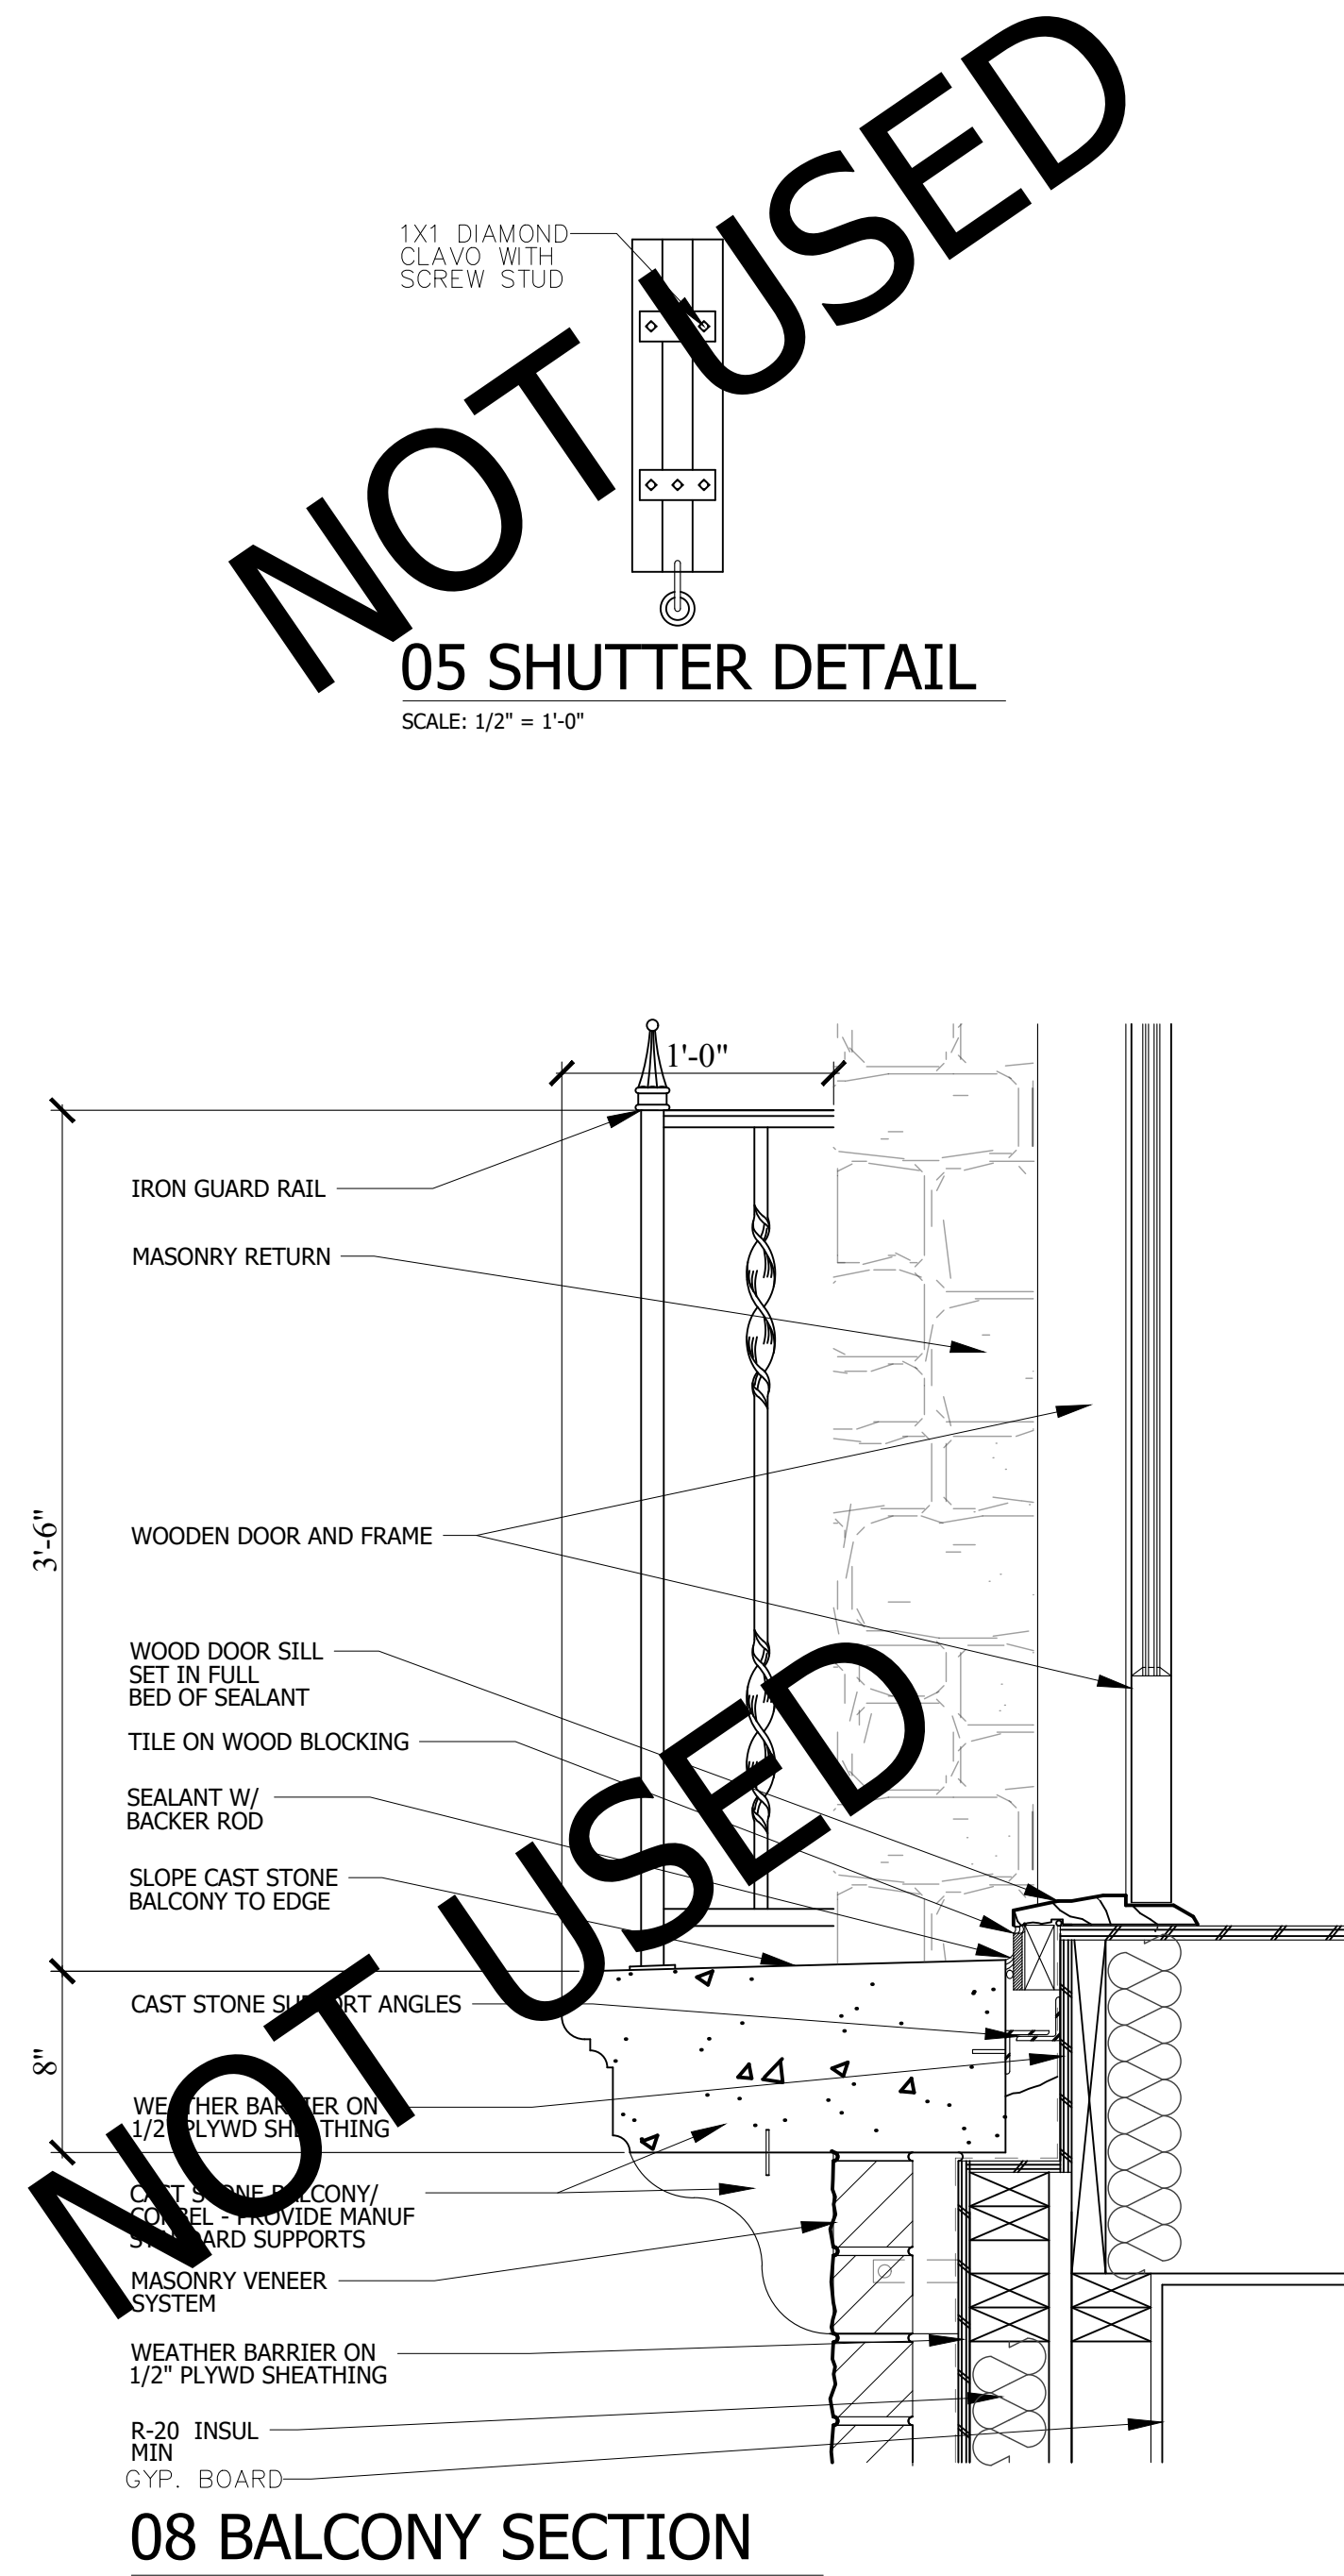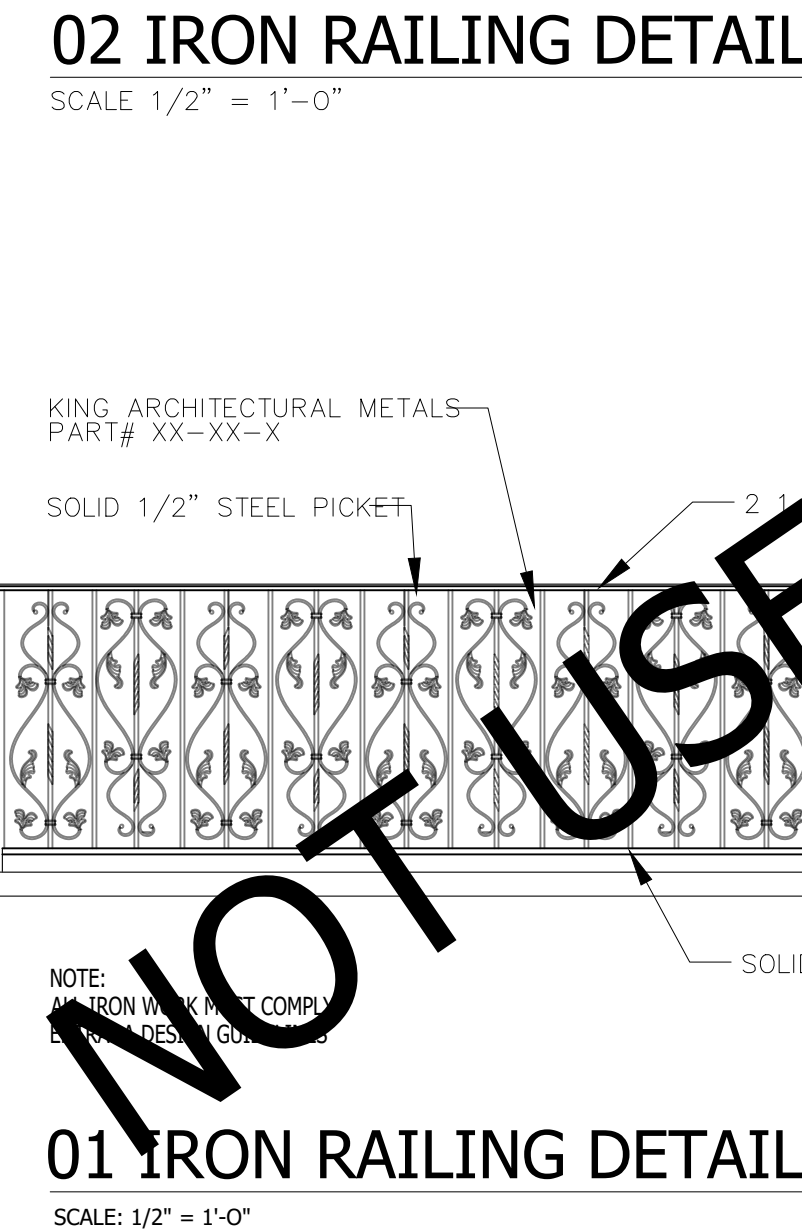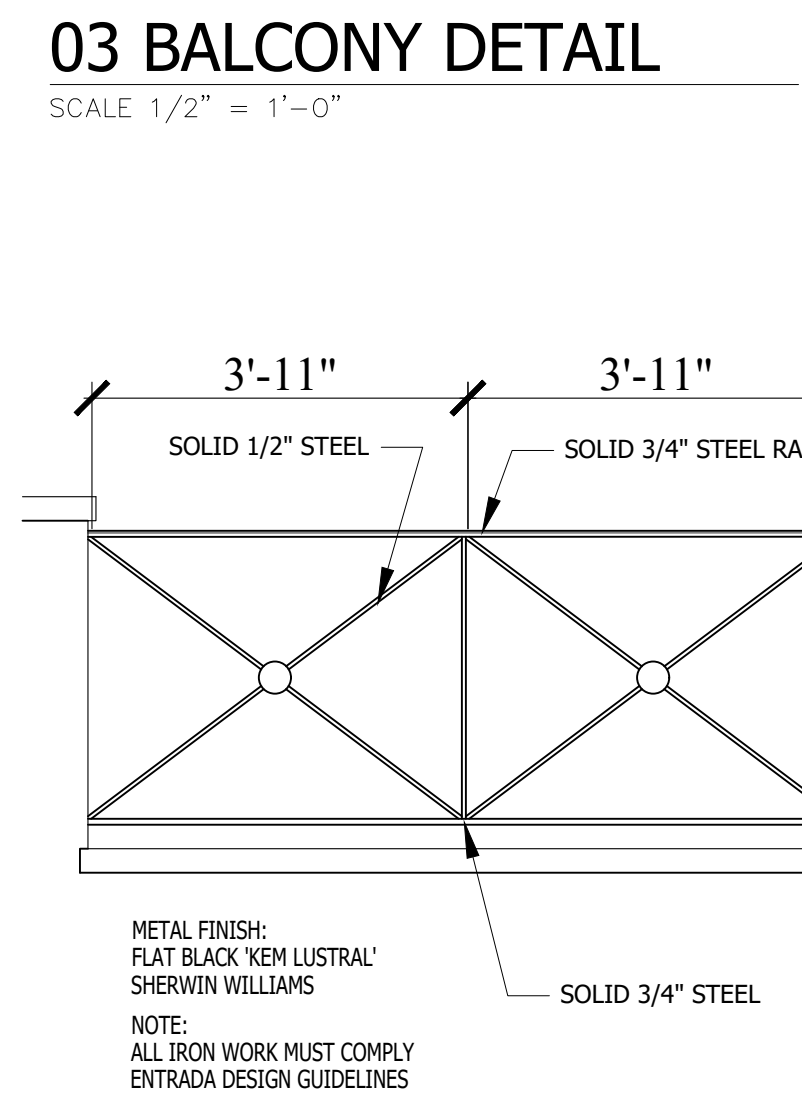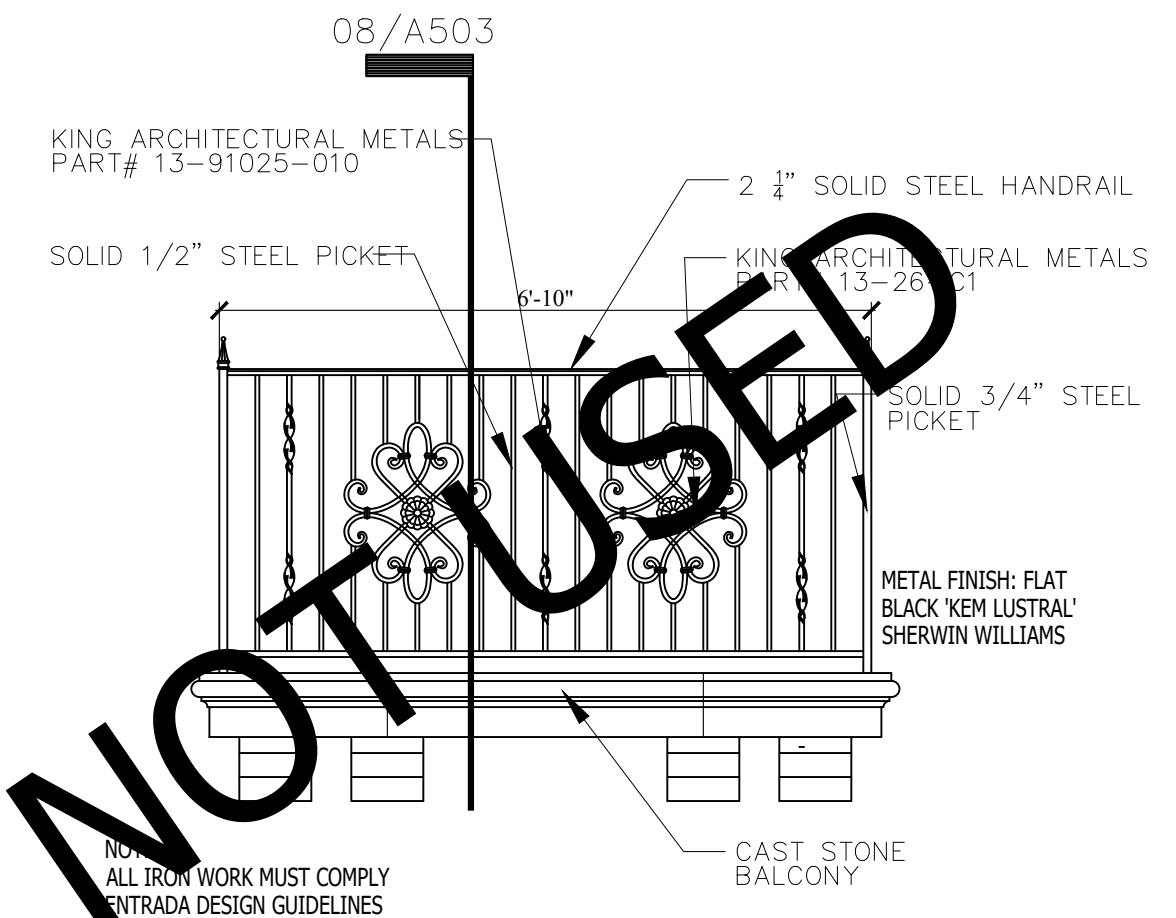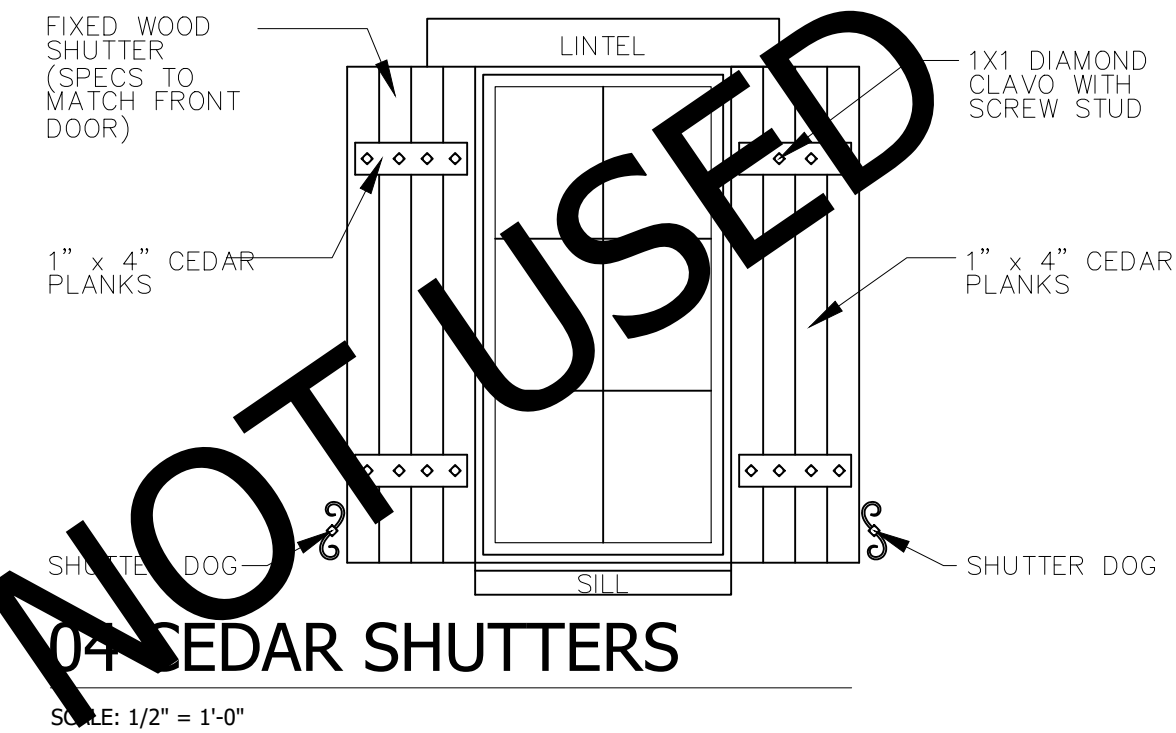

REFER TO **ENTRADA DESIGN GUIDELINES** FOR FUTHER DETAILED INFORMATION REGARDING THESE PLANS














ISSUE LOG

NO.	DESCRIPTION	DATE

PROJECT NO:	20-130
ISSUED FOR:	OTP
DRAWN BY:	Checker
DATE:	06/16/21

DOOR ELEVATIONS

A504

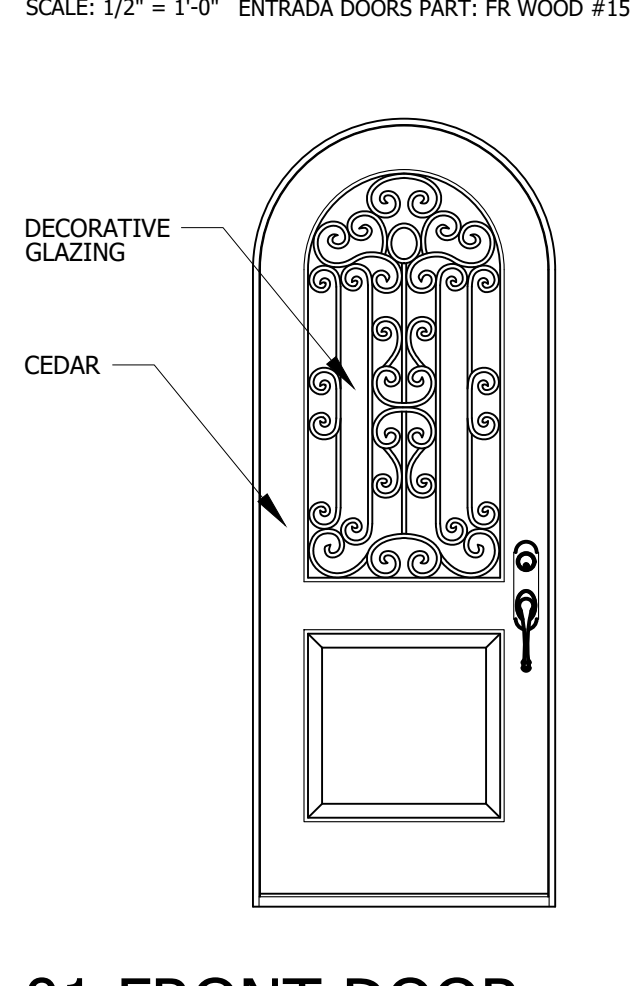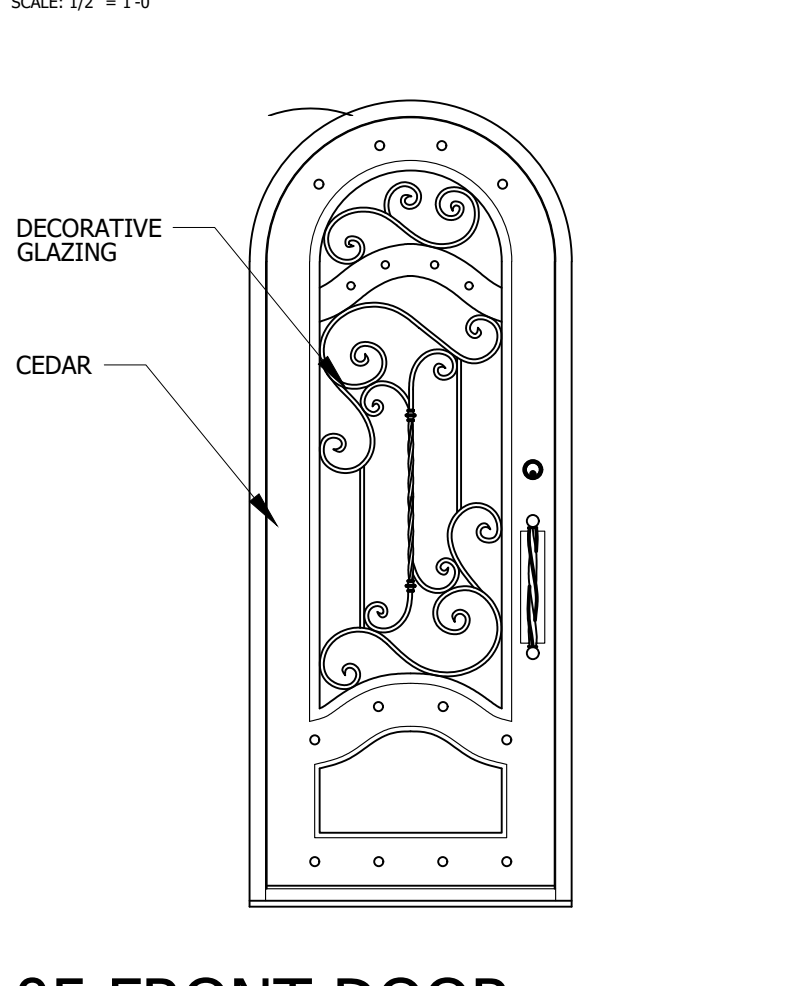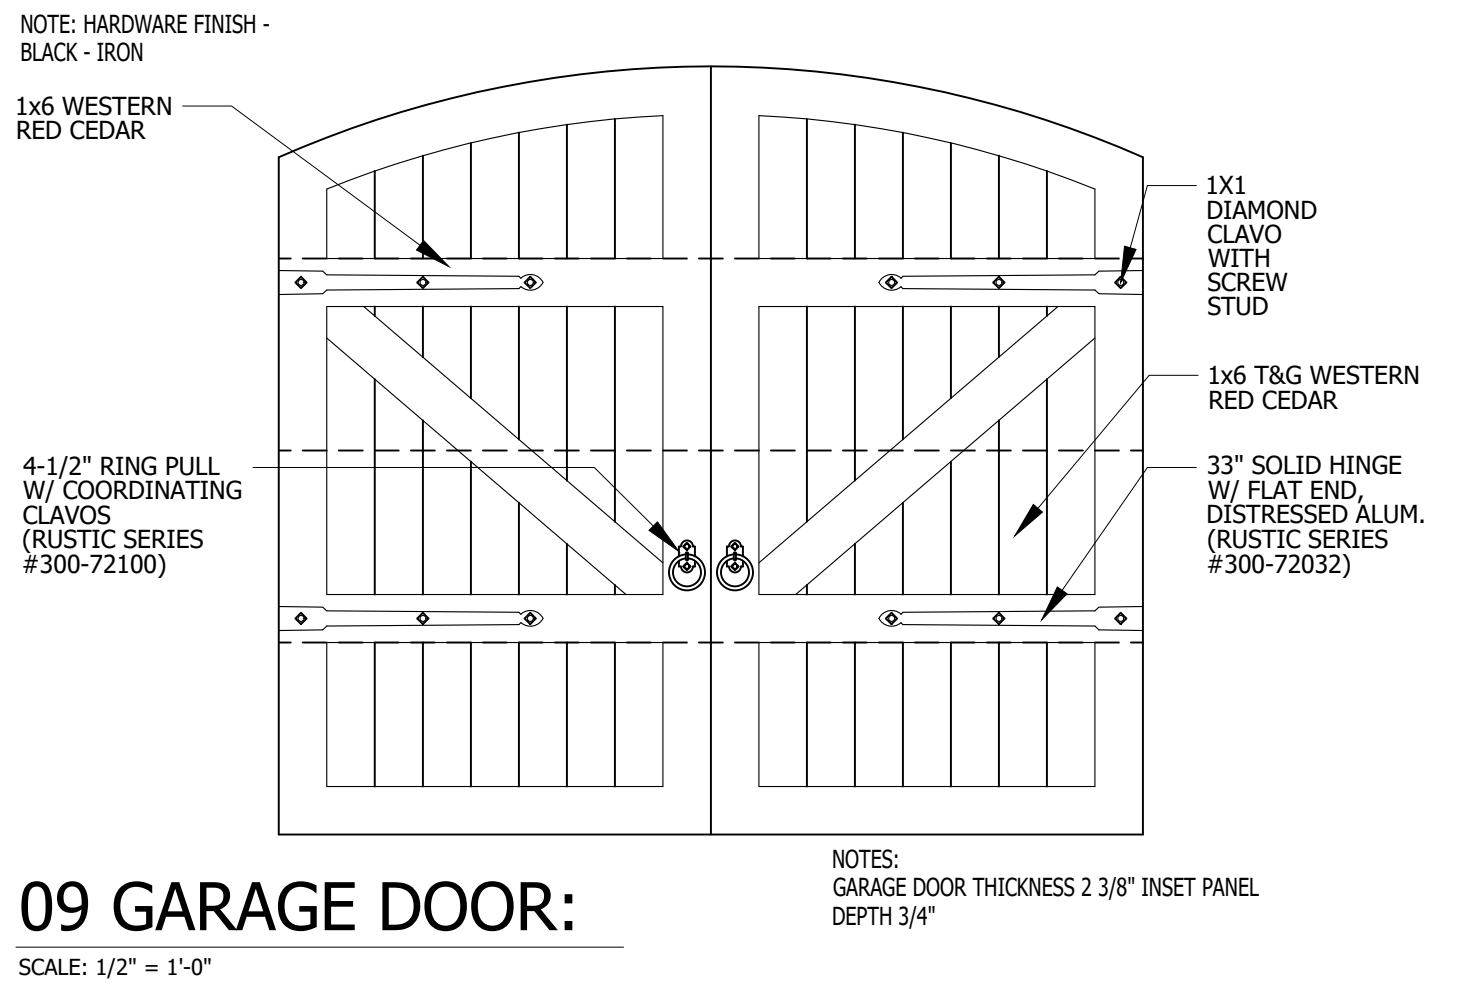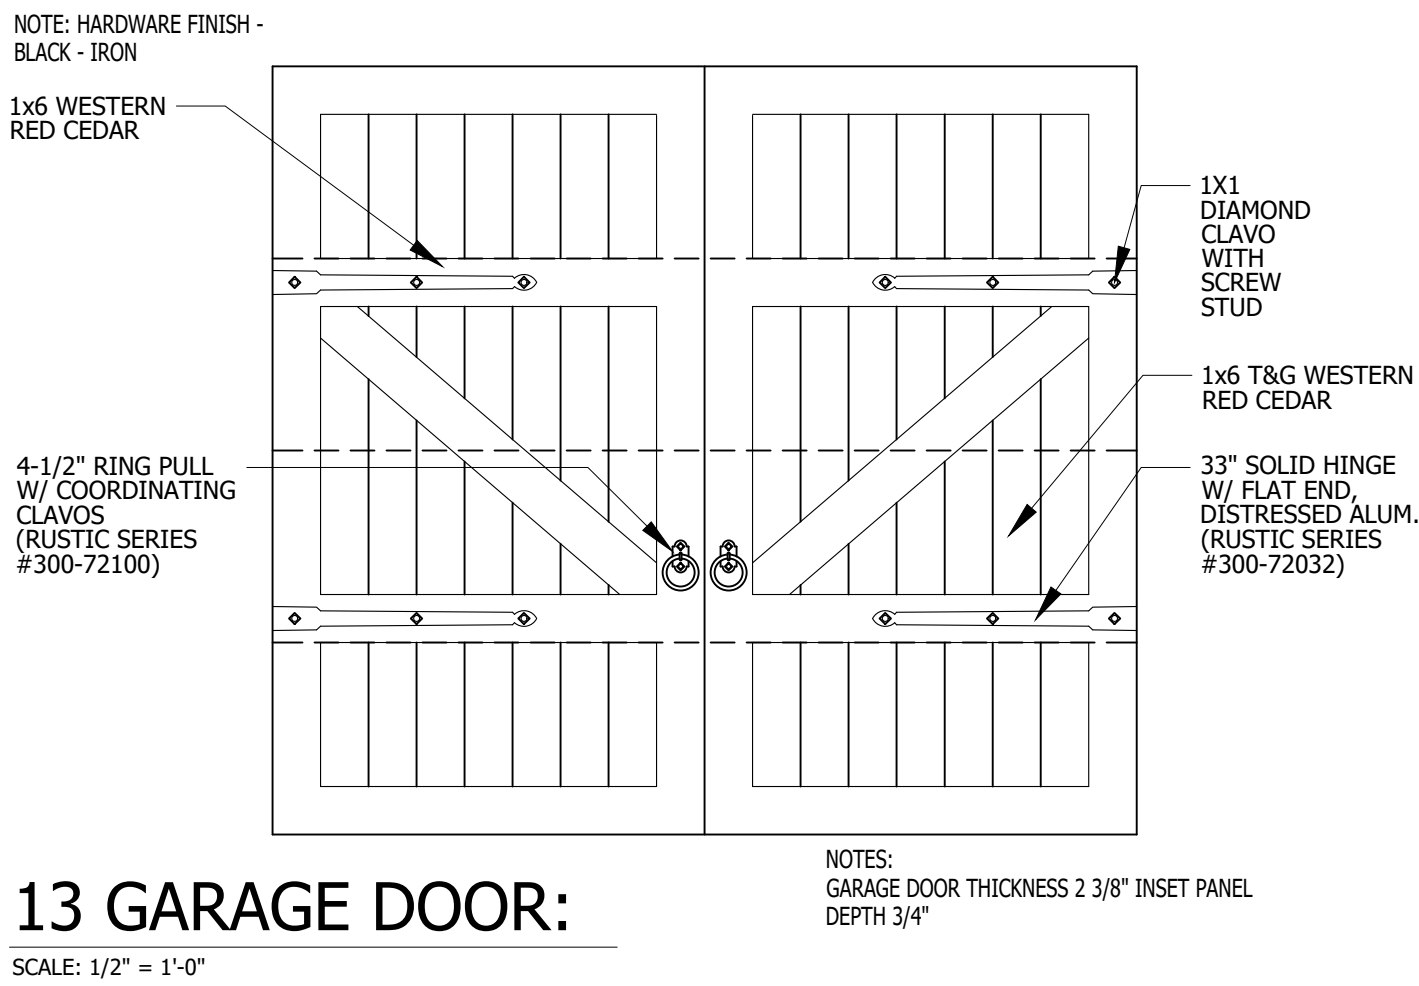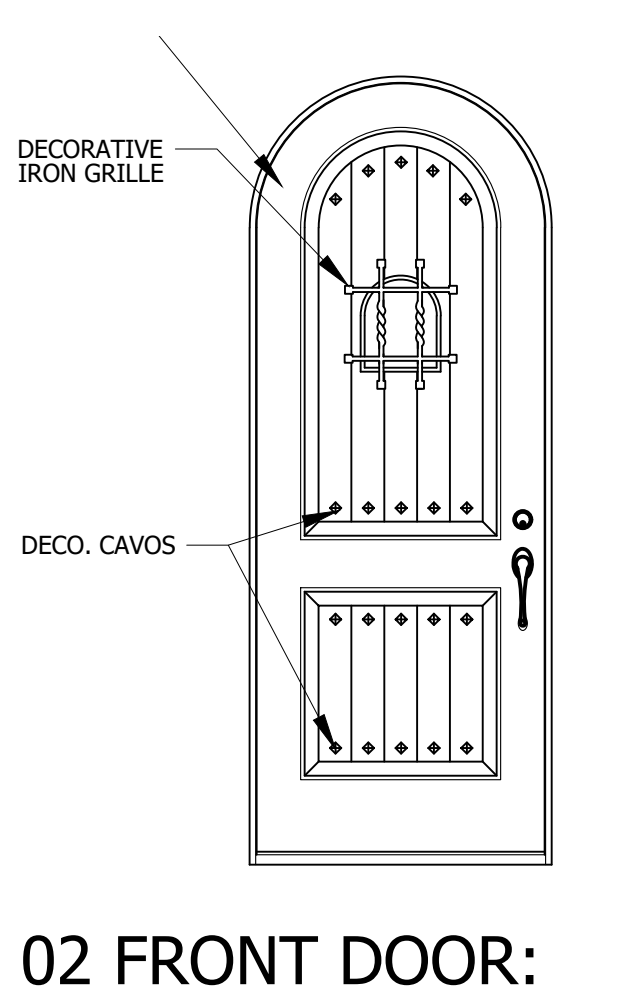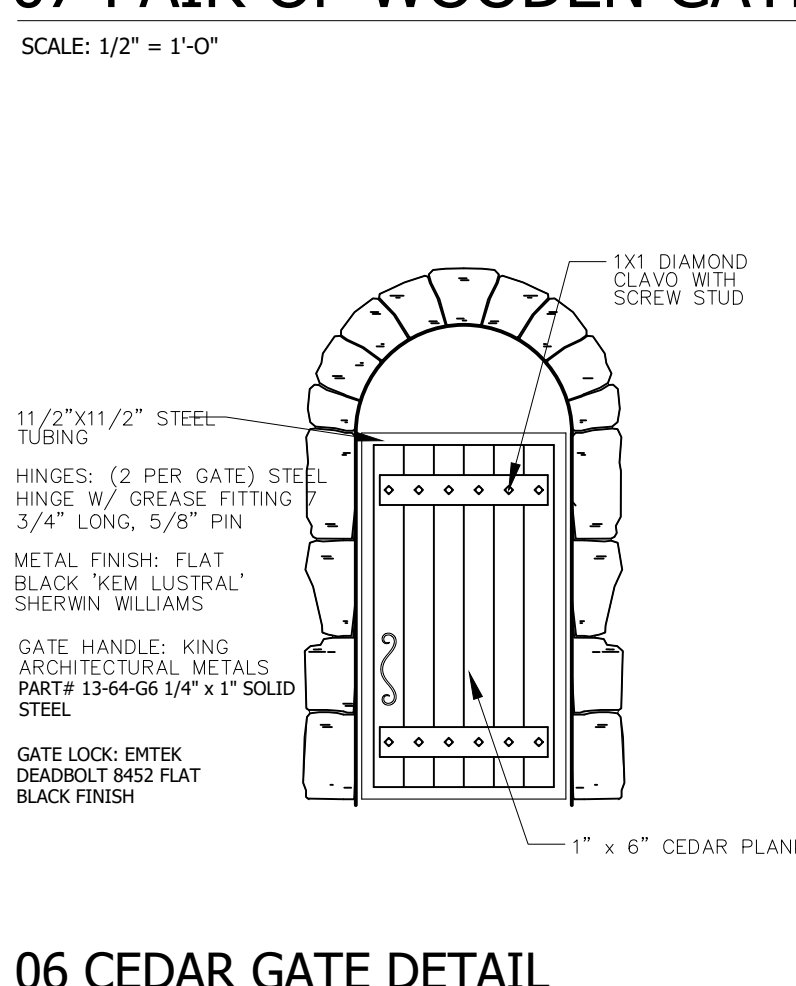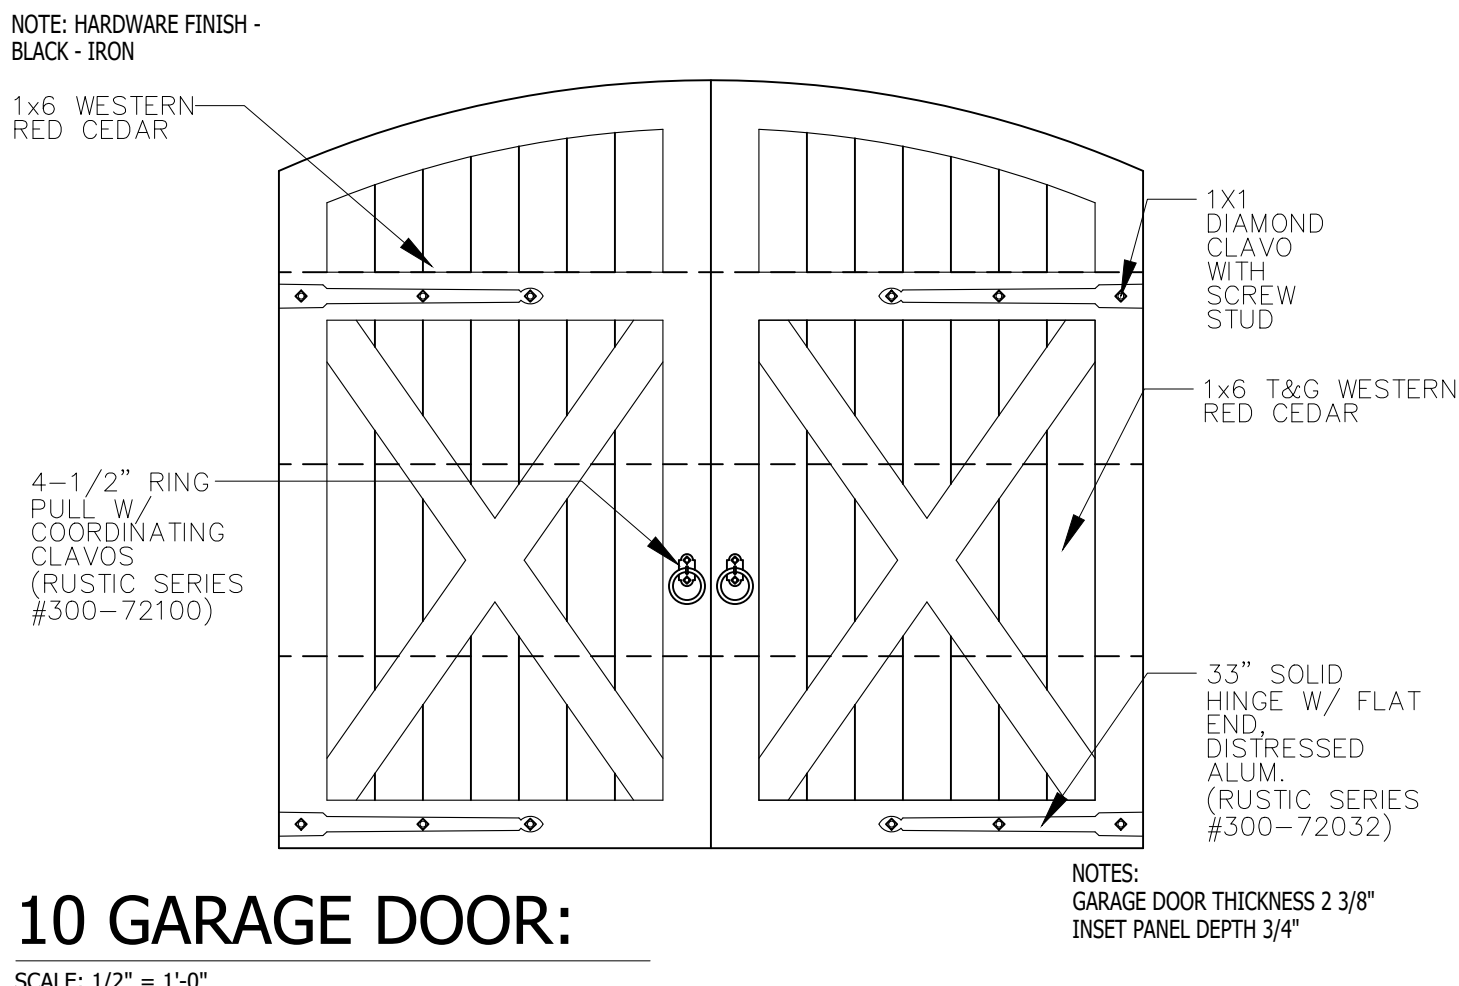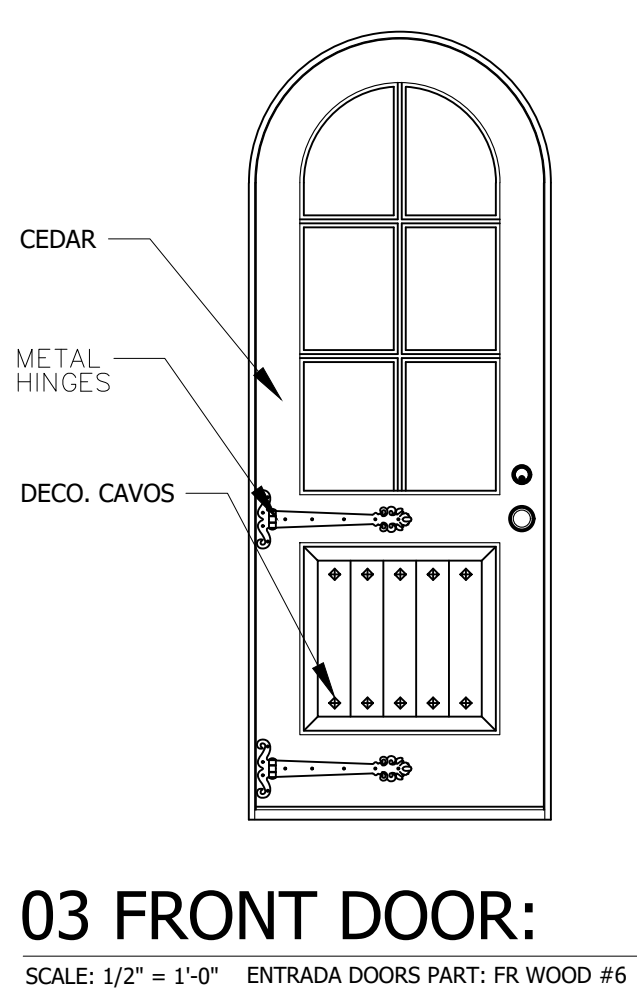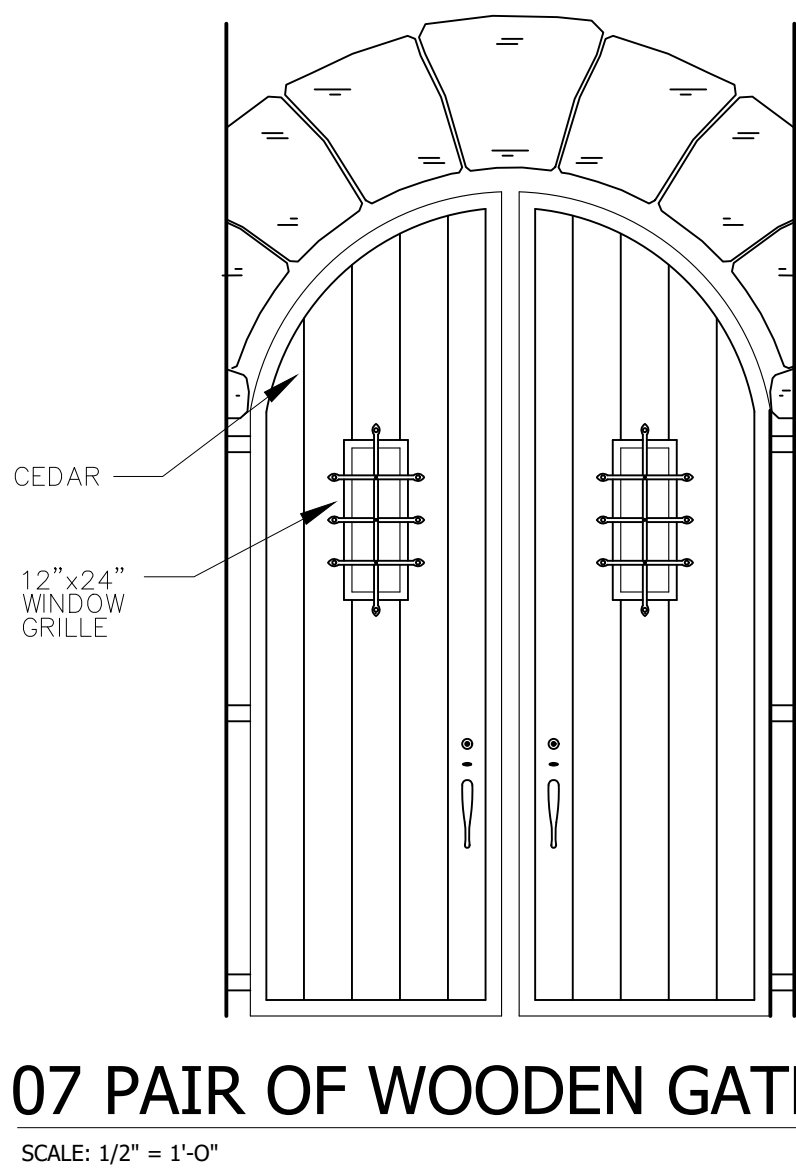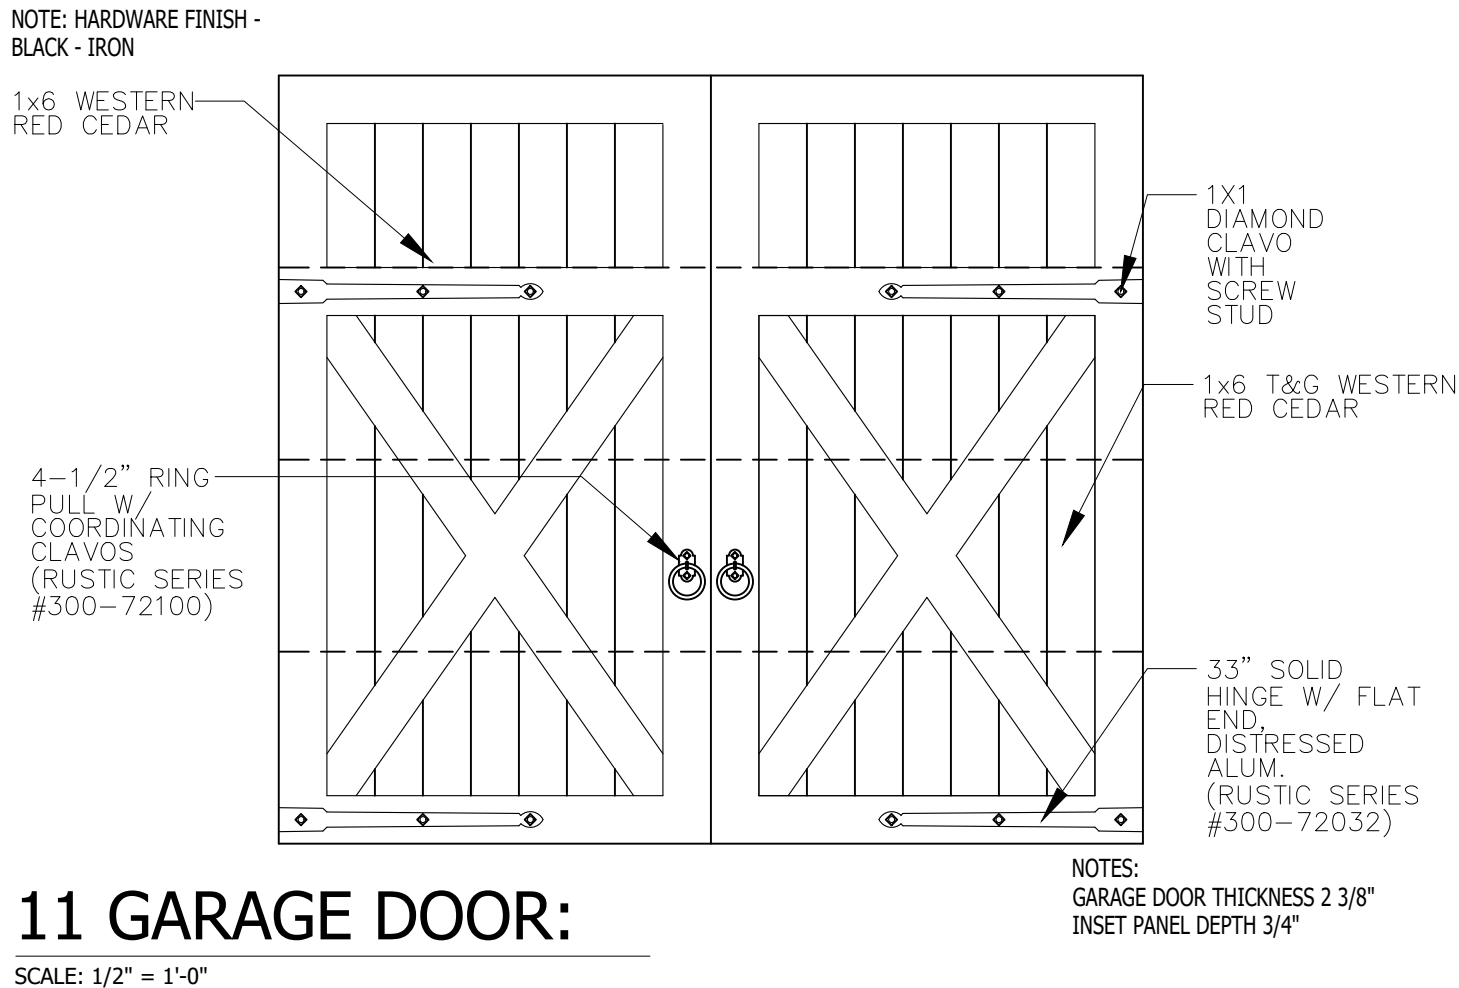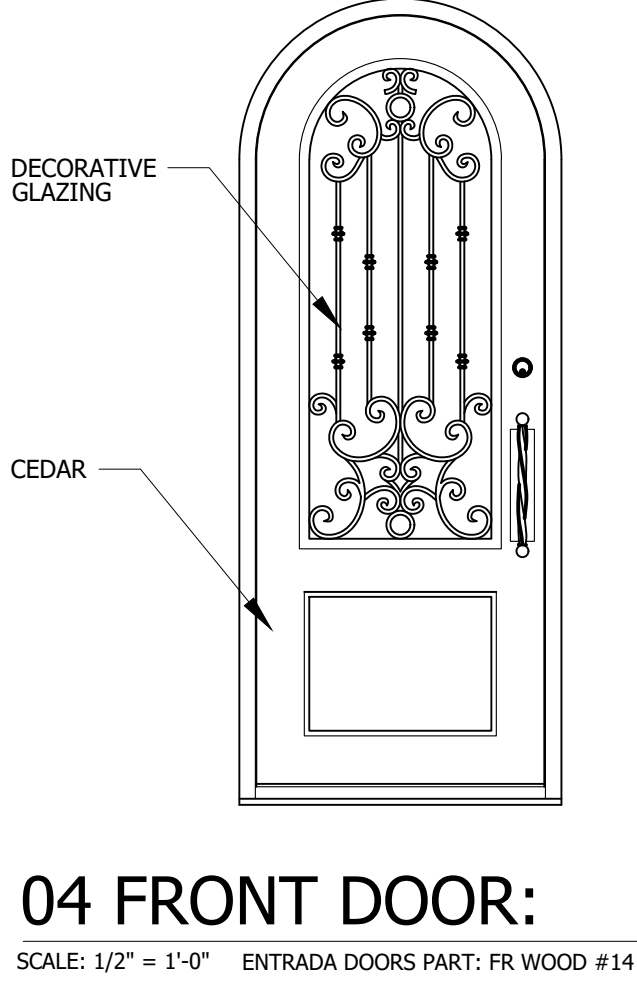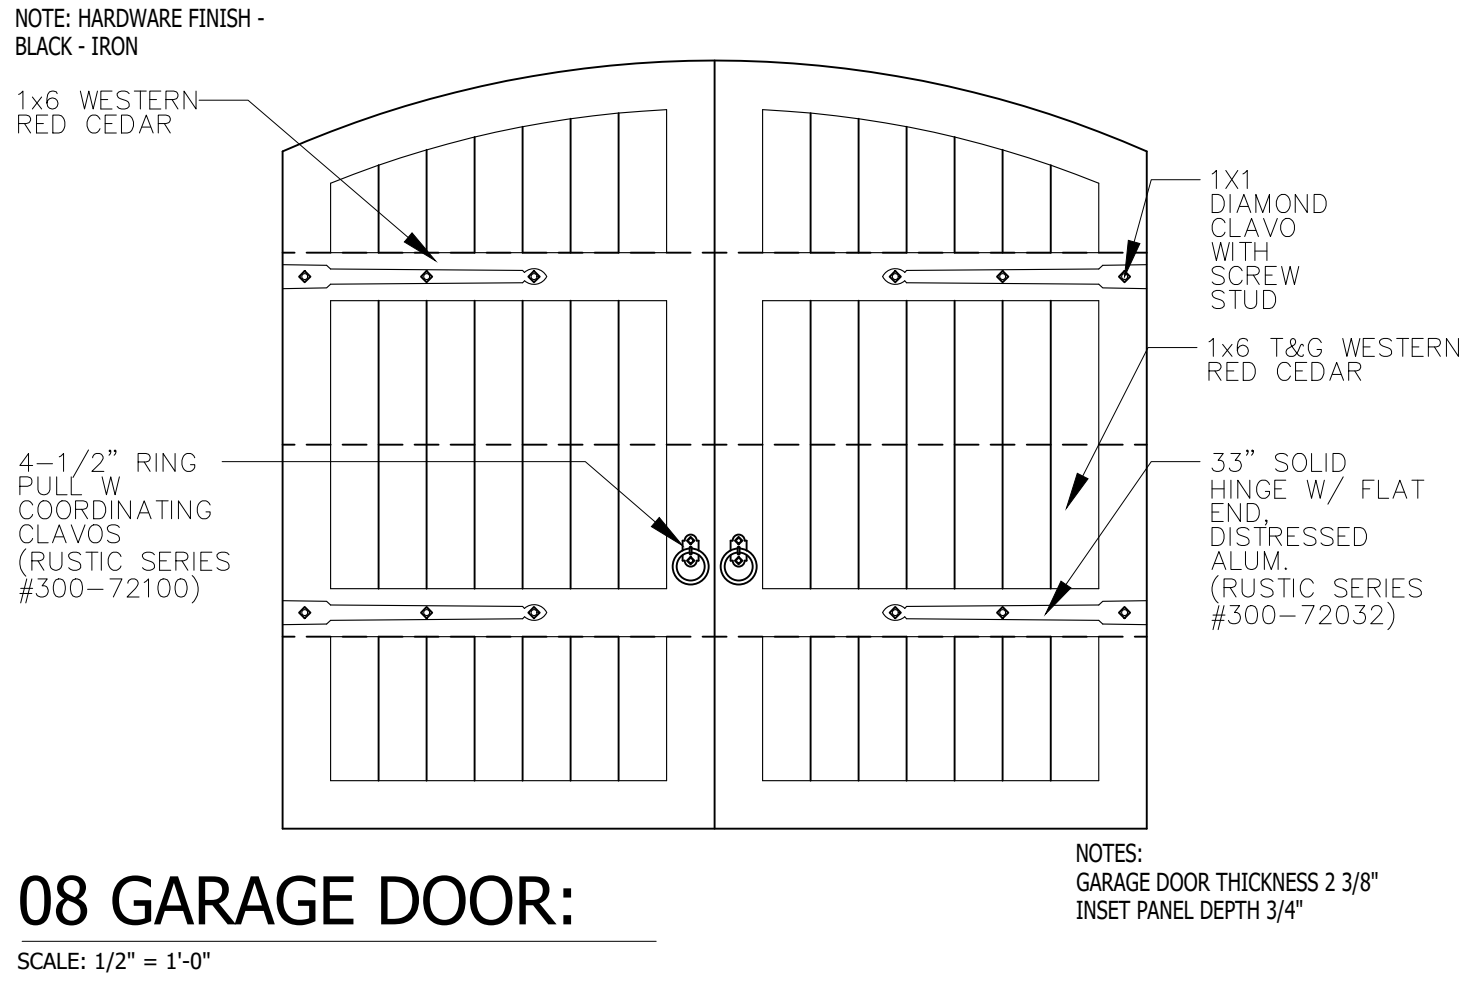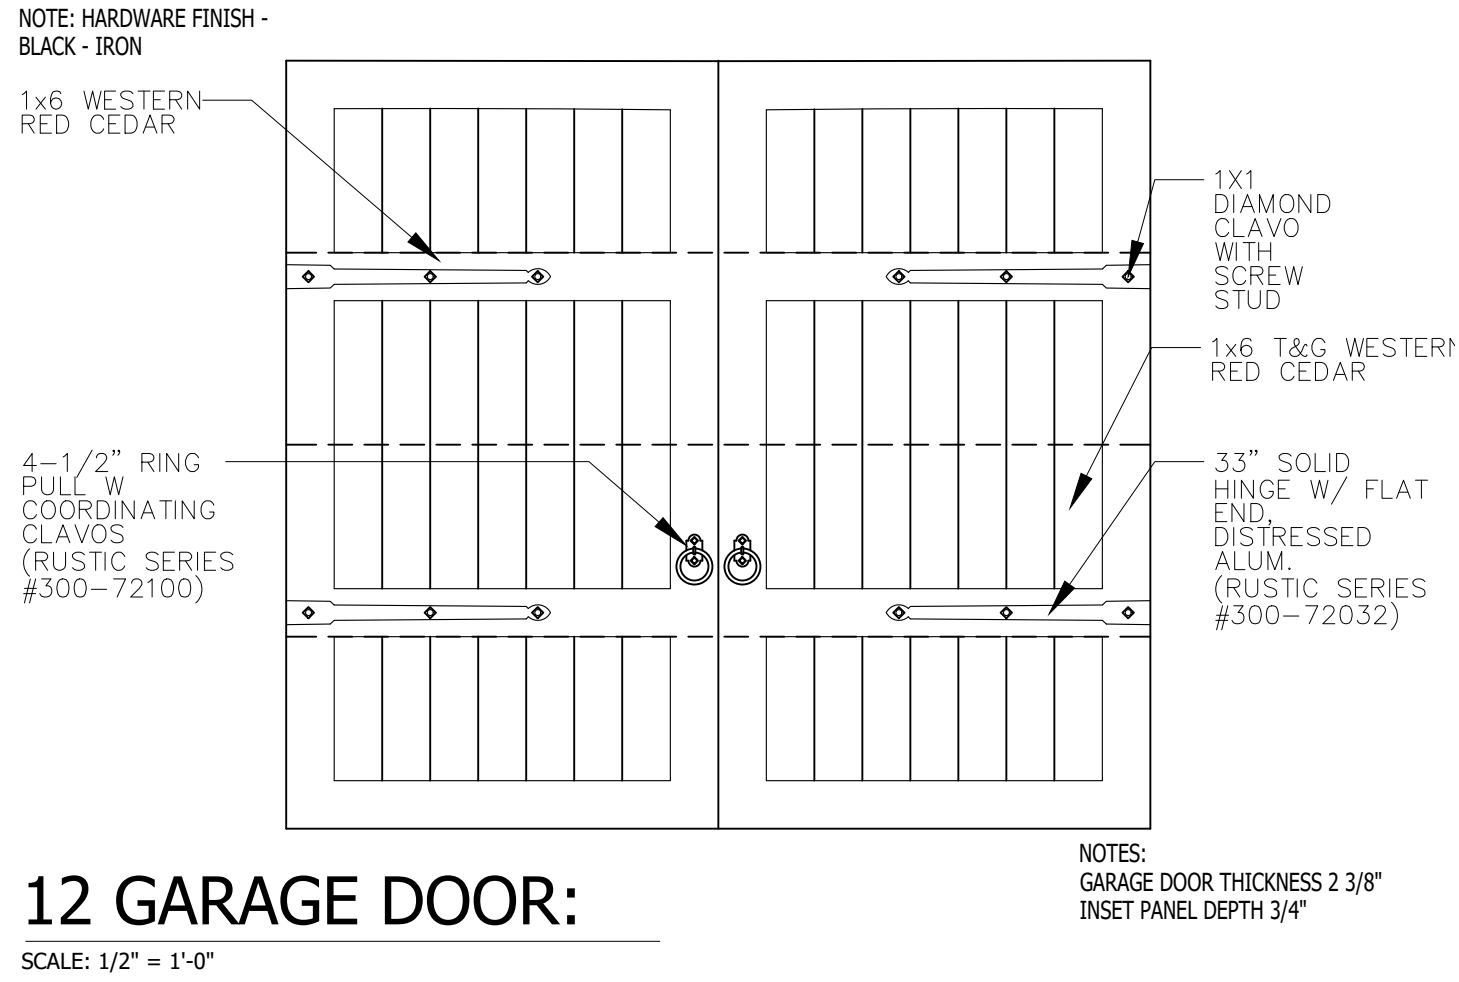

REFER TO **ENTRADA DESIGN GUIDELINES** FOR FUTHER DETAILED INFORMATION REGARDING THESE PLANS


ISSUE LOG

NO.	DESCRIPTION	DATE

PROJECT NO:	20-130
ISSUED FOR:	OTP
DRAWN BY:	Checker
DATE:	06/16/21


DETAILS

A505

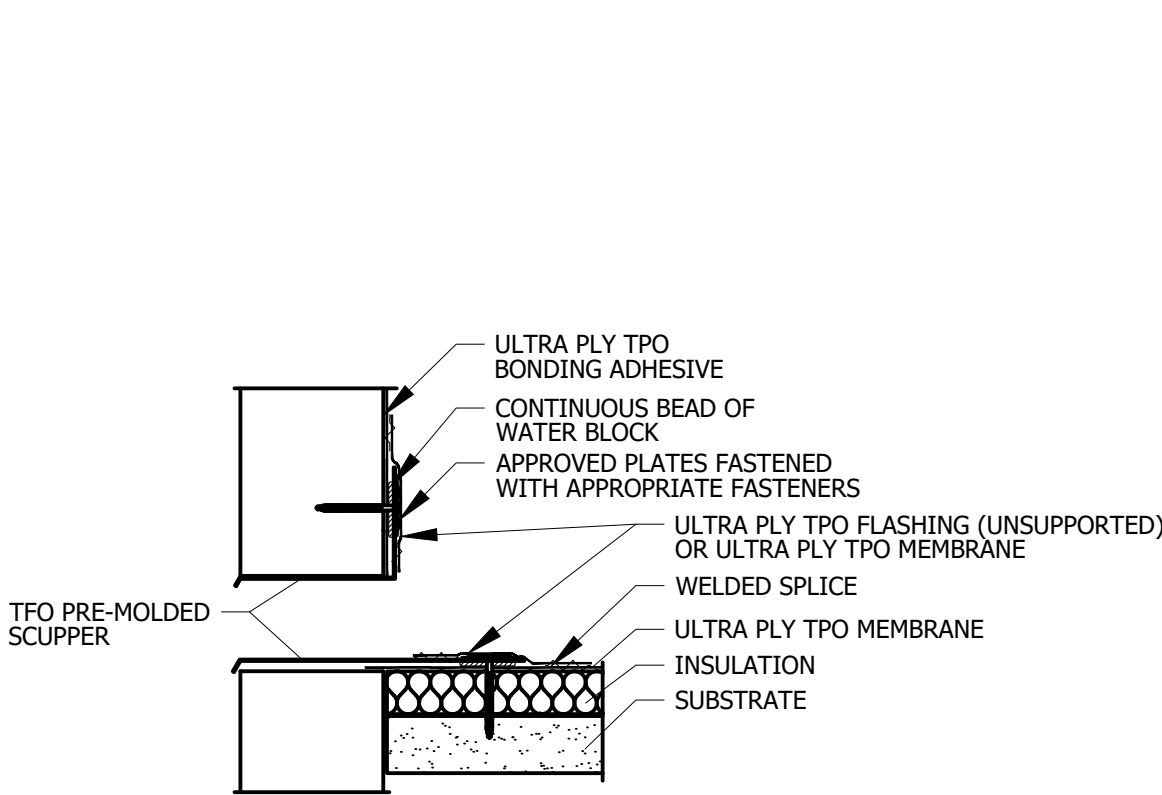

07 SCUPPER DETAIL


SCALE: 1 1/2" = 1'-0"

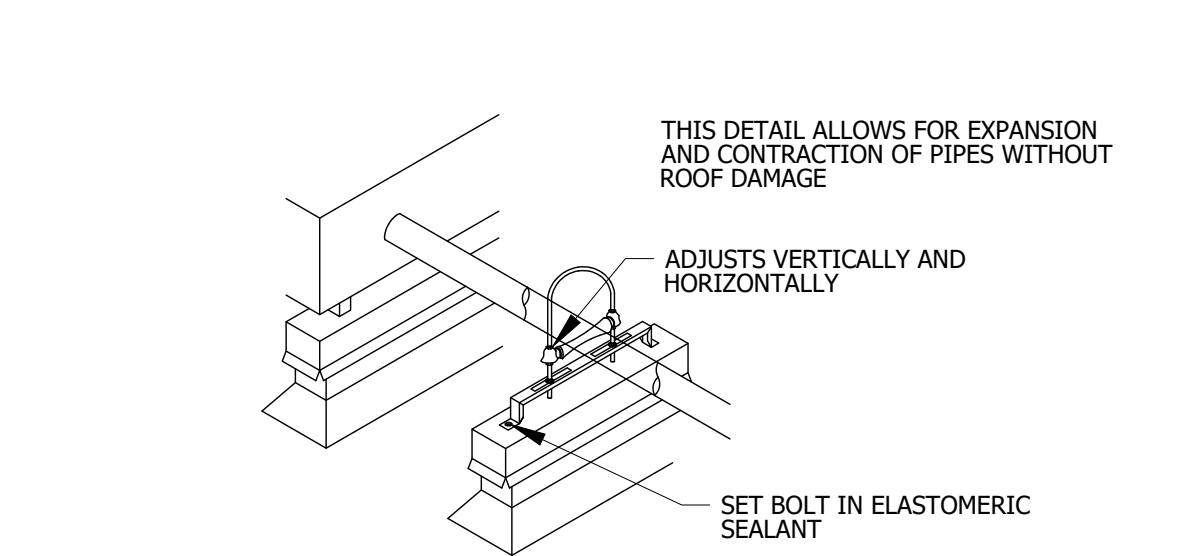

06 PIPE OVER ROOF DETAIL


SCALE: 1 1/2" = 1'-0"

- NOTES:
1. NRCA REAFFIRMS ITS OPPOSITION TO PIPES AND CONDUITS BEING PLACED ON ROOFS. HOWEVER, WHERE THEY ARE NECESSARY AND AVAILABLE, A PIPE ROLLER SUPPORT IS RECOMMENDED. THE DETAIL SHOWN IS GENERIC ONLY.

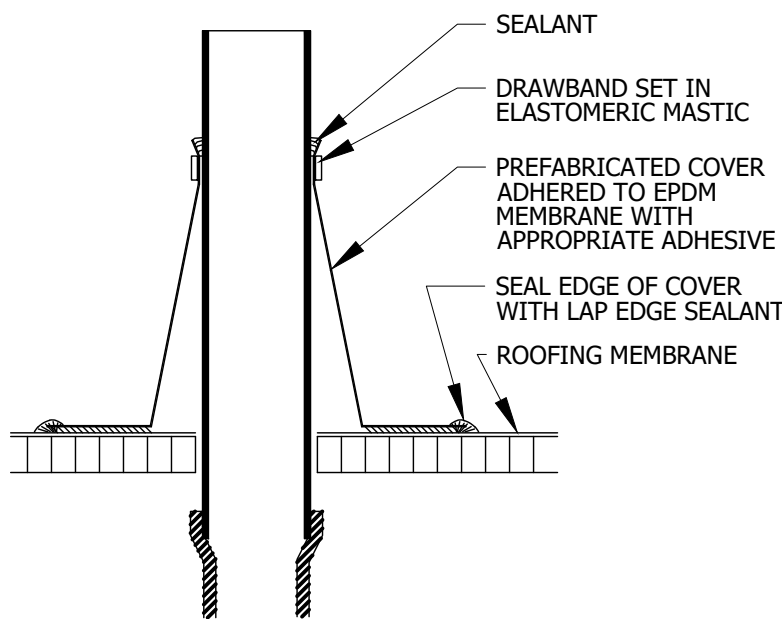


05 PLUMBING PENETRATION DETAIL

SCALE: 1 1/2" = 1'-0"

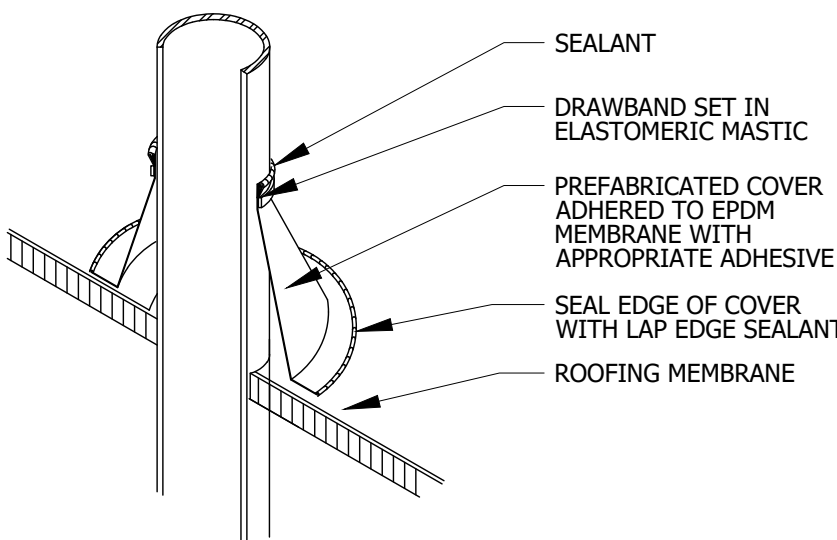

04 PLUMBING THROUGH ROOF DETAIL



SCALE: 1 1/2" = 1'-0"

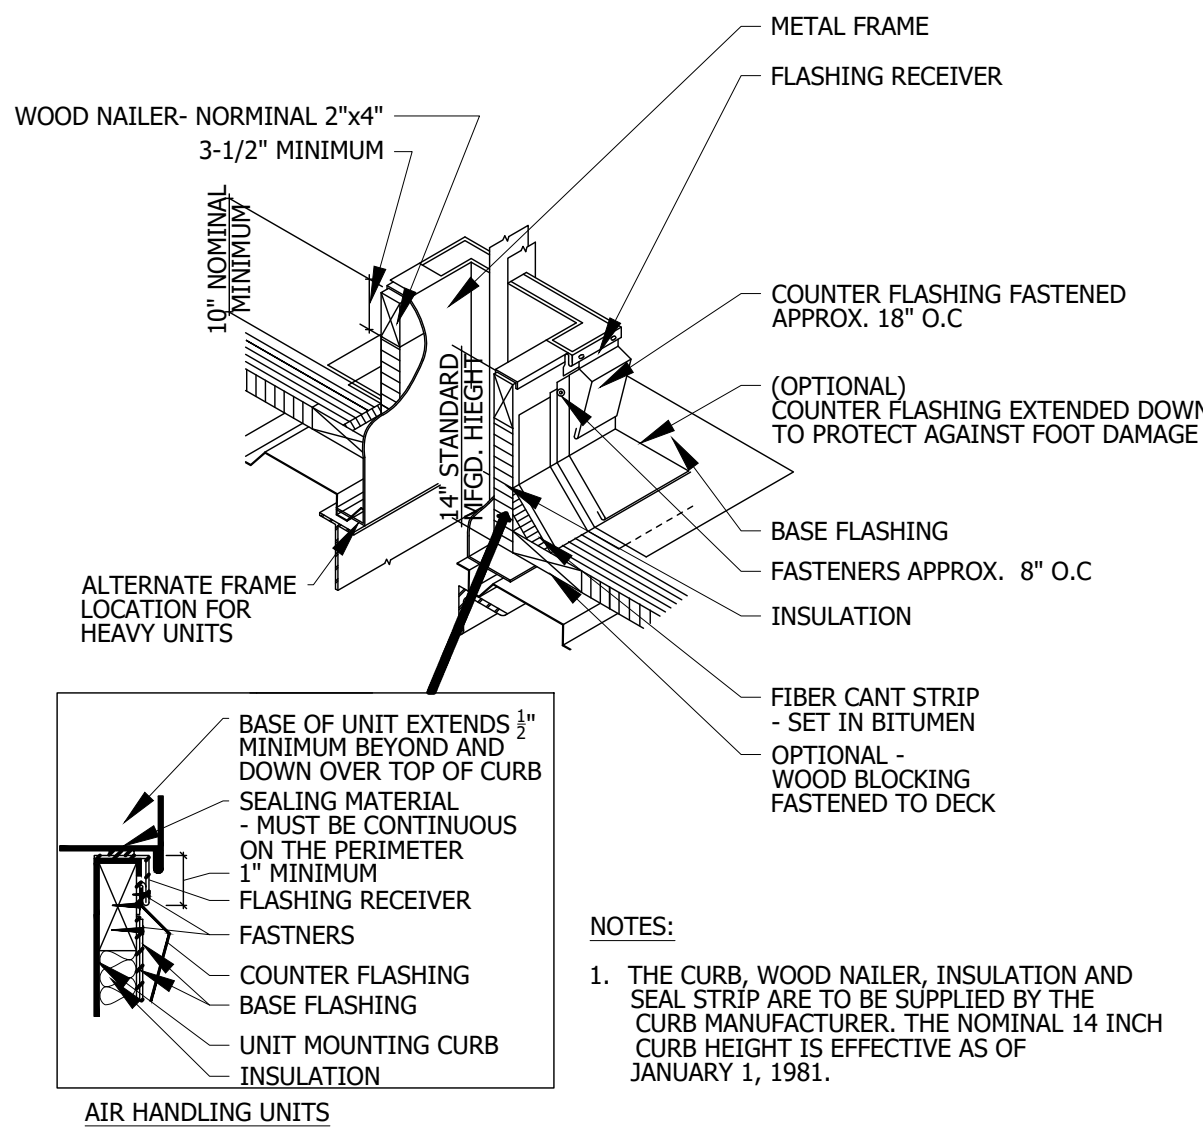

03 DETAIL AT ROOF CURB

SCALE: 1 1/2" = 1'-0"


- NOTES:
1. THE CURB, WOOD NAILER, INSULATION AND SEAL STRIP ARE TO BE SUPPLIED BY THE CURB MANUFACTURER. THE NOMINAL 14 INCH CURB HEIGHT IS EFFECTIVE AS OF JANUARY 1, 1981.

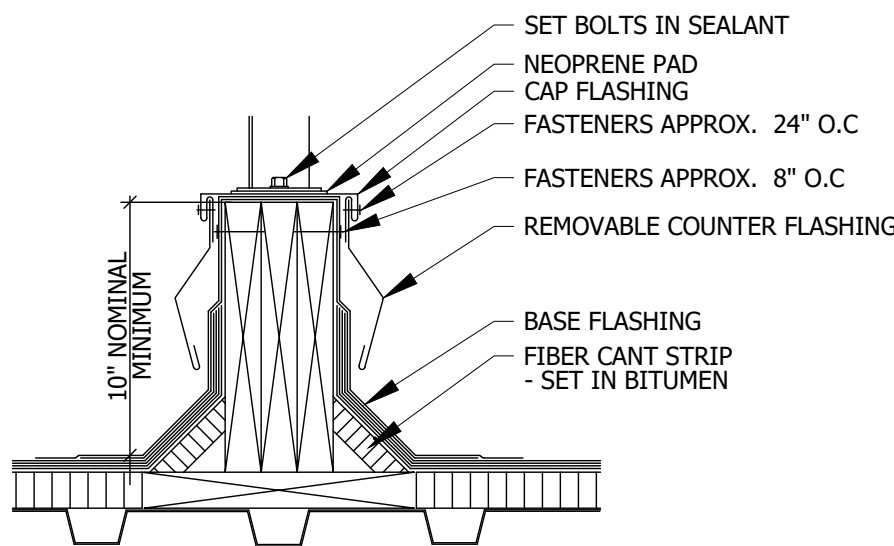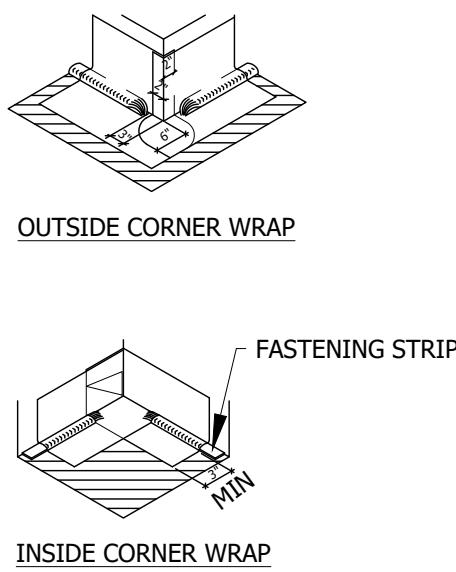

02 DETAIL AT ROOF CURB

SCALE: 1 1/2" = 1'-0"


- NOTES:
1. THIS DETAIL ALLOWS FOR ROOF MAINTENANCE AROUND THE EQUIPMENT SIGN. THE CONTINUOUS SUPPORT IS PREFERRED IN LIGHTWEIGHT ROOF SYSTEMS BECAUSE THE EQUIPMENT WEIGHT CAN BE SPREAD OVER TWO OR MORE SUPPORTING MEMBERS. WHERE HEAVY STRUCTURAL SYSTEMS ARE USED OR WHERE THE LOAD CAN BE CONCENTRATED OVER A COLUMN, DETAIL 'M' IS PREFERRED. CLEARANCE MUST BE PROVIDED FOR REMOVAL AND REPLACEMENT OF ROOFING AND FLASHING BETWEEN PARALLEL SUPPORTS.

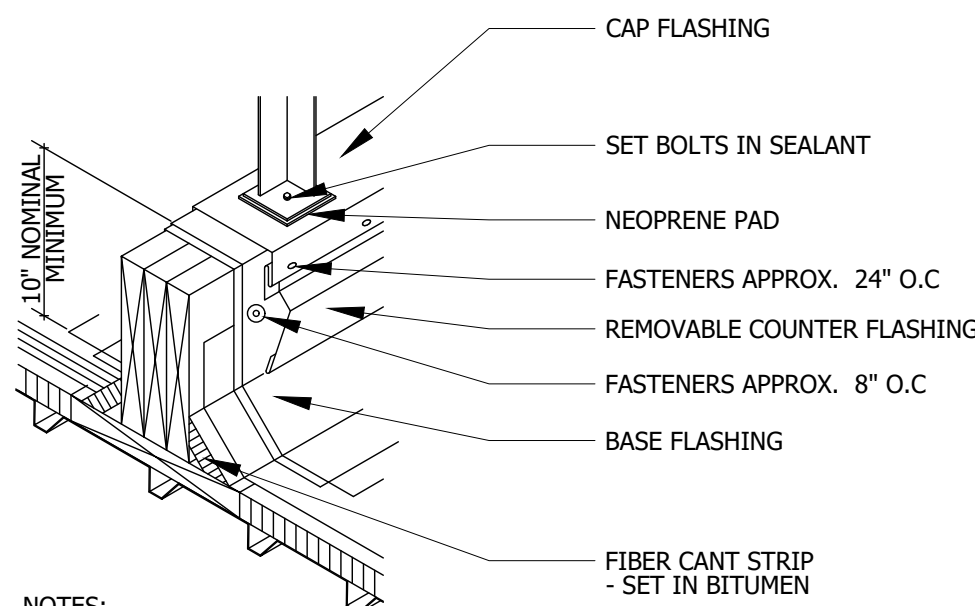

01 DETAIL AT ROOF CURB

SCALE: 1 1/2" = 1'-0"

- NOTES:
1. THIS DETAIL ALLOWS FOR ROOF MAINTENANCE AROUND THE EQUIPMENT SIGN. THE CONTINUOUS SUPPORT IS PREFERRED IN LIGHTWEIGHT ROOF SYSTEMS BECAUSE THE EQUIPMENT WEIGHT CAN BE SPREAD OVER TWO OR MORE SUPPORTING MEMBERS. WHERE HEAVY STRUCTURAL SYSTEMS ARE USED OR WHERE THE LOAD CAN BE CONCENTRATED OVER A COLUMN, DETAIL 'M' IS PREFERRED. CLEARANCE MUST BE PROVIDED FOR REMOVAL AND REPLACEMENT OF ROOFING AND FLASHING BETWEEN PARALLEL SUPPORTS.

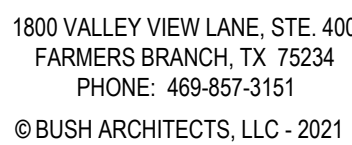

ENTRADA LOT 03, BLOCK H


OWNER

OWNER
MRW INVESTORS
1800 VALLEY VIEW LANE STE. 300
FARMERS BRANCH, TX 75234
PHONE: (817) 239-6528
EMAIL: michael@centurionamerican.com
CONTACT: MICHAEL DEES

LOT 3, BLOCK H
WESTLAKE, TX 76262

BUSH ARCHITECTS
1800 VALLEY VIEW LANE STE. 400
FARMERS BRANCH, TX 75234
PHONE: (469) 857-3151
E-MAIL: ralph@busharchitects.design
CONTACT: RALPH BUSH

BGE INC.
2595 DALLAS PARKWAY
SUITE 204
FRISCO, TX 75034
PHONE: (972) 464-4800
CONTACT: JASON FREY
(TBPE F-1046)

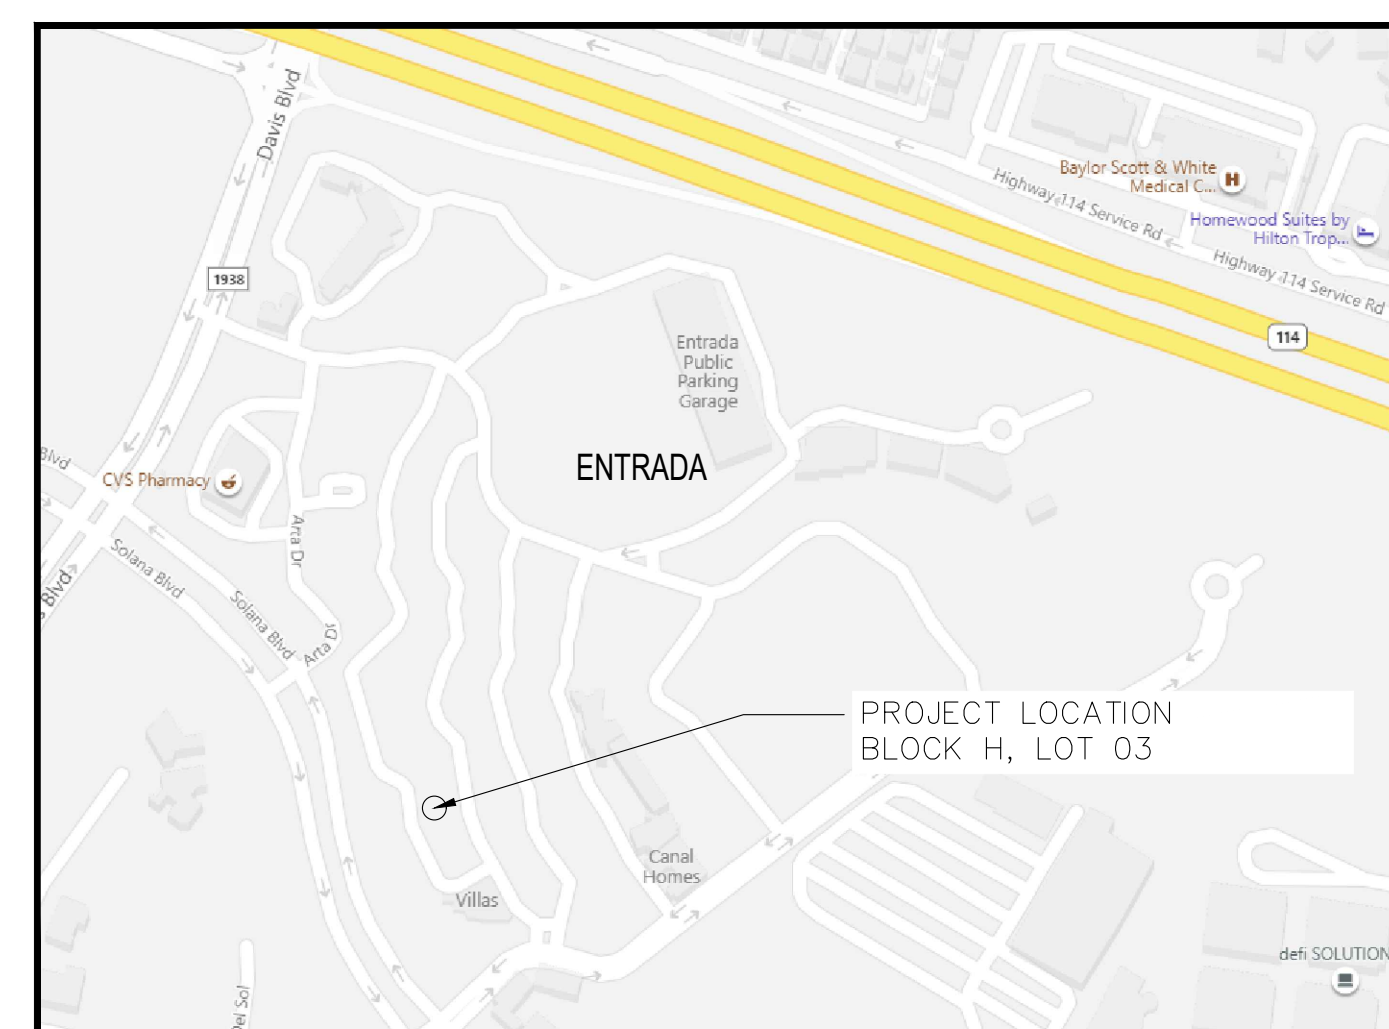VICINITY MAP
NTS 

APPROVED:

TITLE:

DATE:

LOT 03, BLOCK H

WESTLAKE ENTRADA
TOWN OF WESTLAKE, TARRANT COUNTY, TX.

SHEET INDEX	
CS	COVERSHEET
A001	GENERAL NOTES
A100	ARCHITECTURAL SITE PLAN
A101	BASEMENT FLOOR PLAN
A102	FIRST FLOOR PLAN
A103	DOOR & WINDOW SCHEDULE
A104	BASEMENT FLOOR ELECTRICAL PLAN
A105	FIRST FLOOR ELECTRICAL PLAN
A106	ROOF PLAN
A200	FRONT & LEFT ELEVATIONS
A201	REAR & RIGHT ELEVATIONS
A202	COURTYARD ELEVATIONS
A203	ELEVATIONS
A401	WALL SECTIONS
A402	WALL SECTIONS
A500	ROOF DETAILS
A501	STANDARD DETAILS
A502	STANDARD DETAILS
A503	MISC. DETAILS
A504	DOOR ELEVATIONS

[illegible]

PROJECT NO:	21-131
-------------	--------

ISSUED FOR:	OTP
-------------	-----

DRAWN BY: _____ Checker: _____

 
 
 
 
 
 
 
DATE: 06/24/21

COVERSHEET

CS

REFER TO **ENTRADA DESIGN GUIDELINES** FOR FUTHER DETAILED INFORMATION REGARDING THESE PLANS

SECTION HATCHES & SYMBOLS

	SAND OR GROUT
	EARTH OR NATURAL GROUND
	POROUS FILL (GRAVEL)
	STONE
	CONCRETE
	BRICK (PLAN & SECTION)
	MASONRY
	STEEL
	NON-FERROUS ALUMINUM
	PLYWOOD
	WOOD (FINISH)
	CONTINUOUS NOMINAL LUMBER
	DISCONTINUOUS NOMINAL LUMBER & WOOD BLOCKING (INTERRUPTED MEMBER)
	INSULATION (LOOSE OR BATT)
	RIGID INSULATION
	GLAZING (LARGE SCALE)
	GYPSUM WALL BOARD
	PLASTER WITH LATH
	ACOUSTICAL TILE
	CARPET

ELEVATION HATCHES & SYMBOLS

	STONE
	STONE VENEER
	WOOD (FINISHED)
	GLASS
	BRICK
	STONE
	STUCCO
	CLAY TILE ROOF

CONSTRUCTION SYMBOLS

0	COLUMN GRID
	PARTITION TAG
	ELEVATION DATUM POINT
NAME NUMBER	ROOM TAG
Unit Type	UNIT TAG
	DOOR TAG
	ALIGN WITH ESTABLISHED SURFACES
	SHEET KEYNOTE
	WINDOW MARK
	REVISION REFERENCE
	SECTION IDENTIFIER
	PLAN DETAIL IDENTIFIER
	FIRE EXTINGUISHER WITHOUT CABINET
	FIRE EXTINGUISHER CABINET ON WALL
¢	CENTERLINE
	EXTERIOR ELEVATION
	INTERIOR ELEVATION
	GLAZING ELEVATION
	FINISH TAG
	KEYNOTE TAG
	KEYNOTE TAG
	ELEVATION LEVEL
# / SHEET	DETAIL REFERENCE
	WALL TAG
	WINDOW TAG
05/AS00	SECTION DETAIL IDENTIFIER

CONDITION(ING)	DF DRINKING FOUNTAIN	G	MECH MECHANICAL	REFL REFLECTED	VIF VERIFY IN FIELD
ACCESS ACCESSORY	DIA DIAMETER	GA GAUGE	MTL METAL	REFR REFRIGERATOR	W
ACOUS ACOUSTIC(AL)	DIFF DIFFUSER	GO GRAD(E)(ING)	MEM MEMBRANE	REQD REQUIRED	W/ WITH
AFB ABOVE FINISHED FLOOR	DIM DIMENSION	GRFC GLASS FIBER REINF. CONCRETE	MEZZ MEZZANINE	RESIS RESIST(ANT)(IVE)	WD WATER CLOSET
AL ALUMINUM	DISP DISPENSER	GRFP GLASS FIBER REINF. GYPSUM	MIN MINIMUM	REINF REINFORCE(D)(ING)(MENT)	WD WOOD
ALT ALTERNATE	DIV DIVISION	GRFP GLASS FIBER REINF. PLASTER	MISC MISCELLANEOUS	RESIL RESILIENT	WDW WINDOW
ANNUN ANNUNCIATOR	DN DOWN	GL GLASS	MLWK MILLWORK	RFM ROOFING	W/O WITHOUT
ANOD ANODIZED	\$ DOLLAR (US CURRENCY)	GR GRAD(E)(ING)	MOIST MOISTURE	RM ROOM	WT WEIGHT
APPL APPLIANCE	DR DOOR	GYP GYPSUM	MOT MOTOR(IZED)	RO ROUGH OPENING	WTRPF WATERPROOFING
ARCH ARCHITECT(URAL)	DSCON DISCONNECT	H	MTD MOUNTED	S	
AUTO AUTOMATIC	DWR DRAWER	HD HEAD		SCR SCRIBE	
AVG AVERAGE	E	HDWD HARDWOOD	NIC NOT IN CONTRACT	SECU SECURITY	
& AND	EJ EXPANSION JOINT	HDWR HARDWARE	NO (#) NUMBER	SF SQUARE FEET	
B	ELAST ELASTOMERIC	HM HOLLOW METAL	NTS NOT TO SCALE	SGL SINGLE	
BLDG BUILDING	ELEC ELECTRICAL	HORIZ HORIZONTAL	O	SHORG SHORING	
BOLD BOLLARD	EMBED EMBEDD(ED)(ING)	HVAC HEATING, VENTILATION, & AIR CONDITIONING	OH OPPOSITE HAND	SIM SIMILAR	
BOA BOARD	ENGR ENGINEER(ED)	INT AIR CONDITIONING	ORN ORNAMENTAL	SS STAINLESS STEEL	
BLKG BLOCKING	ENTR ENTRANCE	I	OVFL OVERFLOW	STD STANDARD	
BRDLM BROADLOOM	EQU EQUI	INFO INFORMATION	OVHD OVERHEAD	STL STEEL	
BU BUILT UP	EQUI EQUIPMENT	INSTR INSTRUMENT(ATION)	OPNG OPENING(S)	STFR STOREFRONT	
C	EXIST EXISTING	INSUL INSULATION	OPR OPERABLE	STRUCT STRUCTURAL	
CAB CABINET	EXP JT EXPANSION JOINT	INTLK INTERLOCK(ING)	P	SURF SURFACE	
CPT CARPET	EXPS EXPOSE(D)	INT INTERIOR	PTN PARTITION	SUSP SUSPENDED	
CEM CEMENT(ITIOUS)	EXT EXTERIOR	INFILTR INFILTRATION	PED PEDESTRIAN	SYS SYSTEM(S)	
CER CERAMIC	F	J	PBD PARTICLE BOARD	T	
CLG CEILING	FAB FABRICATION	JAN JANITOR	PAL PANEL	THK THICK	
COATG COATING	FLD FLOOR DRAIN	JT JOINT	POLYST POLYSTYRENE	TLT RESTROOM	
COILG COILING	FE FIRE EXTINGUISHER	K	PORT PORTABLE	TRAF TRAFFIC	
CONC CONCRETE	FEC FIRE EXTINGUISHER CABINET	KIT KITCHEN	PREFIN PREFINISHED	TRANS TRANSPARENT	
CONST CONSTRUCTION	FHC FIRE HOSE CABINET	L	PREFAB PREFABRICATED	TRTD TREATED	
CONT CONTINUOUS(ATION)	FIN FINISH	LAV LAVATORY	PLAM PLASTIC LAMINATE	T&G TONGUE & GROOVE	
CONTR CONTRACT(OR)	FLDG FOLDING	LB LBOUND	PLAS PLASTER	TYP TYPICAL	
COV COVER	FPLC FIREPLACE	£ BRITISH POUND (CURRENCY)	PLSTC PLASTIC	U	
CMU CONCRETE MASONRY UNIT	FR FIRE RAT(ING)(ED)	LT LIGHT	PLYWD PLYWOOD	UNDRLAY UNDERLAYMENT	
	FR,G FRAMING	FLG LEVELING	PRTECN PROTECTION	UTIL UTILITY	
	D	FXD FIXED	R	UNO UNLESS NOTED OTHERWISE	
DBL DOUBLE	FXTR FIXTURE	LVR LOUVER	RDR READER	UNO UNLESS OTHERWISE NOTED	
DEPT DEPARTMENT	FLR FLOOR(ING)	M	RECES RECESSED	V	
DES DESIGN(ED)	FURN FURNITURE	MAX MAXIMUM	RECPT RECEPTACLE	VEH VEHICLE	
DET DETAIL	FWC FABRIC WALL COVERING	MFD MANUFACTURED	REF REFERENCE	VERT VERTICAL	

MECHANICAL NOTES

1. PLUMBING AND HVAC SYSTEMS:
 - 1.1. DESIGNED BY CONTRACTORS PLUMBING AND MECHANICAL PERSONNEL.
 - 1.2. PROPOSED LOCATIONS OF HVAC AND WATER HEATERS DETERMINED BY CONTRACTOR AND SUBMITTED TO OWNER AND ARCHITECT FOR APPROVAL.
 - 1.3. PROPOSED LOCATIONS OF HVAC VENTS AND RETURN AIR DETERMINED BY CONTRACTOR AND SUBMITTED TO OWNER AND ARCHITECT FOR APPROVAL.
2. ALL VENTILATION SYSTEMS TO MEET LOCAL CODE REQUIREMENTS AND DESIGNED BY CONTRACTORS PERSONNEL.

MECHANICAL SYMBOLS

	W	COLD WATER TAP FOR REFRIGERATOR OR ICE MAKER
	GAS	GAS SUPPLY
		GAS KEY
	GAS	SWITCHED GAS KEY
	HB	FROST FREE HOSE BIB

CONSTRUCTION NOTES

1. CONSTRUCTION SHALL COMPLY WITH APPLICABLE CODES AND RELATED AMENDMENTS TO THE CITY OF WESTLAKE ORDINANCES (OTC).
2. ALL STRUCTURES IN THIS ZONING DISTRICT MUST COMPLY WITH ALL CITY OF WESTLAKE ORDINANCES (OTC).
3. ALL CONSTRUCTION TO COMPLY WITH ENTRADA DESIGN GUIDELINES.
4. THE CONTRACTOR SHALL PAY ALL FINES, GIVE ALL NOTICES, FILE ALL NECESSARY DRAWINGS, AND PAY AND OBTAIN ALL PERMITS AND INSPECTIONS REQUIRED IN CONNECTION WITH ALL WORK UNDER THE CONTRACT DOCUMENTS.
5. THESE DRAWINGS DO NOT CONTAIN COMPLETE SPECIFICATIONS, DETAILS, OR FULL INFORMATION NECESSARY FOR THE COMPLETE CONSTRUCTION OF THE PROJECT.
6. ELECTRICAL, MECHANICAL AND PLUMBING ITEMS SHOWN ON THE ARCHITECTURAL DRAWINGS ARE DIAGRAMMATIC AND PROVIDED TO SHOW DESIGN INTENT. THE GENERAL CONTRACTORS SUB CONSULTANTS FOR THOSE TRADES ARE RESPONSIBLE FOR THE ACTUAL DESIGN TO OF THOSE SYSTEMS TO MEET NATIONAL, STATE OR CITY CODE REQUIREMENTS THAT HAVE JURISDICTION. FIRE SPRINKLERS SYSTEMS: LICENSED FIRE PROTECTION SUB CONTRACTOR TO SUBMIT TO REED FIRE PROTECTION (214) 638-7599
7. THE CONTRACTOR IS TO COORDINATE TELECOMMUNICATIONS, DATA AND SECURITY SYSTEM INSTALLATIONS.
8. REFER TO CIVIL AND LANDSCAPE DRAWINGS FOR GRADING AND DRAINAGE REQUIREMENTS. CONTRACTOR TO CONSULT WITH A STRUCTURAL ENGINEER FOR STRUCTURAL DESIGN, SPECIFICATIONS, AND DETAILS; INCLUDING REQUIRED RETAINING WALLS, WATERPROOFING, AND FRENCH DRAIN SYSTEMS. COORDINATE SOIL COMPACTION REQUIREMENTS BEHIND RETAINING WALLS WITH STRUCTURAL ENGINEER.
9. CONTRACTOR TO REVIEW DOCUMENTS, VERIFY DIMENSIONS AND FIELD CONDITIONS AND CONFIRM THE WORK IS BUILDABLE AS SHOWN. NOTIFY ARCHITECT AND OWNER OF ERRORS, OMISSIONS, AND DISCREPANCIES IN CONTRACT DOCUMENTS, OR BETWEEN CONTRACT DOCUMENTS AND ACTUAL SITE CONSTRUCTION CONDITIONS. ERRORS, OMISSIONS, AND DISCREPANCIES MUST BE RESOLVED AND DOCUMENTED BEFORE CONTINUING CONSTRUCTION WITH THE WORK IN QUESTION. FAILURE TO NOTIFY THE OWNER AND ARCHITECT IN SUCH AN EVENT SHALL CONSTITUTE ACCEPTANCE OF ANY RESULTING OBLIGATIONS OR RESPONSIBILITIES WITH REGARDS TO DELAYS, COSTS, CODE COMPLIANCE, AND LEGAL REMEDIES RESULTING FROM THIS OR RELATED WORK.
10. SUBMIT REQUESTS FOR SUBSTITUTIONS, REVISIONS, OR CHANGES TO ARCHITECT FOR REVIEW PRIOR TO PURCHASE, FABRICATION OR INSTALLATION. THE CONTRACTOR SHALL VERIFY ALL MEASUREMENTS AT THE SITE AND BE RESPONSIBLE FOR THE ACCURACY AND CORRECTNESS OF SAME.
11. SUBMIT SHOP DRAWINGS AND SELECTIONS FOR ARCHITECTS/OWNERS REVIEW BEFORE ORDERING AND INSTALLING ANY EQUIPMENT, MASONRY, CAST STONE, WINDOWS, STEEL ETC. DO NOT SCALE DRAWINGS, WRITTEN DIMENSIONS GOVERN. IN CASE OF CONFLICT, CONSULT THE ARCHITECT.
12. MAINTAIN WORK AREAS CLEAN, SECURE AND LOCKABLE DURING CONSTRUCTION.
13. PROTECT AREA OF WORK AND ADJACENT PROPERTIES FROM DAMAGE.
14. VERIFY TYPE AND LOCATION OF UTILITIES SERVING SITE.
15. FIREPLACES:
 - 15.1 VERIFY SIZES, INCLUDING HEARTH EXTENSIONS REQUIRED BY CODE.
 - 15.2 PROVIDE OUTSIDE MAKE-UP AIR INLET AND SCREENED LOUVER AND DAMPER.
16. FLOOR ELEVATIONS AT SECOND FLOOR ARE GIVEN TO TOP OF FLOOR DECK.
17. INSTALL STUDS AT CLOSET SIDE WALL ROD LOCATIONS, MEASURED 10" FROM BACK WALL.
18. EXTERIOR MATERIALS AND FINISHES ARE TO BE INSTALLED IN ACCORDANCE WITH MANUFACTURERS WRITTEN INSTRUCTIONS AND DETAILS.
19. STONE WALL CORNERS SHALL BE LAID SO THAT THE COURSES INTERLOCK (TOOTHING). SHOWING THE FULL DIMENSION OF THE STONE.
20. PARTITIONS ARE DIMENSIONED FROM FACE OF STUD TO FACE OF STUD, UNLESS OTHERWISE NOTED, MAINTAIN DIMENSIONS MARKED "CLEAR". ALLOW FOR THICKNESS OR FINISHES.
21. COORDINATE AND PROVIDE BLOCKING/BACKING FOR MILLWORK AND OTHER ITEMS ATTACHED OR MOUNTED TO WALLS OR CEILINGS.
22. STUCCO CONTROL JOINTS ARE TO BE LOCATED AT 12'-0" O.C. EACH WAY MAXIMUM. STUCCO CONTROL JOINTS ARE TO BE CONCEALED.
23. STONE CONTROL JOINTS ARE TO BE LOCATED 25'-0" O.C. MAXIMUM. STONE CONTROL JOINTS SHOULD BE CONCEALED.
24. UNDERCUT INTERIOR DOORS TO CLEAR TOP OF FLOOR FINISH BY 1/4 INCH, UNLESS OTHERWISE NOTED.
25. ALL GUTTERS ARE TO BE PREFINISHED GALVANIZED ALUMINUM DARK BRONZE 6" HALF ROUND PROFILE. ALL HORIZONTAL JOINTS ARE REQUIRED TO BE SOLDERED OR MECHANICALLY FASTENED WITH CONCEALED FASTENERS.
26. ALL DOWNSPOUTS ARE TO BE PREFINISHED ALUMINUM DARK BRONZE 4" MINIMUM PLAIN ROUND. VERTICAL DOWNSPOUT SECTIONS, ELBOWS AND BENDS MAY BE SLIP JOINTED AND/OR RIVETED IF RIVETS ARE CONCEALED.

FOR DIMENSION PURPOSES:

1. DO NOT SCALE DRAWINGS.
2. VERIFY DIMENSIONS: NOTIFY ARCHITECT OF ANY DISCREPANCIES.
3. WOOD STUD WALLS: VERIFY AND REFER TO STRUCTURAL ENGINEER FOR SIZES AND STUD SPACING.
4. WALL PLATE HEIGHTS: CROSS REFERENCE EXTERIOR ELEVATIONS, WALL SECTIONS, AND FASCIA DETAILS TO DETERMINE.
5. WINDOWS AND DOORS:
 - 5.1. VERIFY ROUGH OPENINGS WITH SELECTED MANUFACTURER.
 - 5.2. REFER TO EXTERIOR ELEVATIONS AND FLOOR PLANS OR SCHEDULE FOR HEAD HEIGHTS.

Bush
ARCHITECTS

1800 VALLEY VIEW LANE, STE. 400
FARMERS BRANCH, TX 75234
PHONE: 469-857-3151
© BUSH ARCHITECTS, LLC - 2021

ENTRADA

LOT 03, BLOCK H

TOWN OF WESTLAKE TARRANT COUNTY, TEXAS


ISSUE LOG

[illegible]

GENERAL NOTES

A001

REFER TO **ENTRADA DESIGN GUIDELINES** FOR FUTHER DETAILED INFORMATION REGARDING THESE PLANS

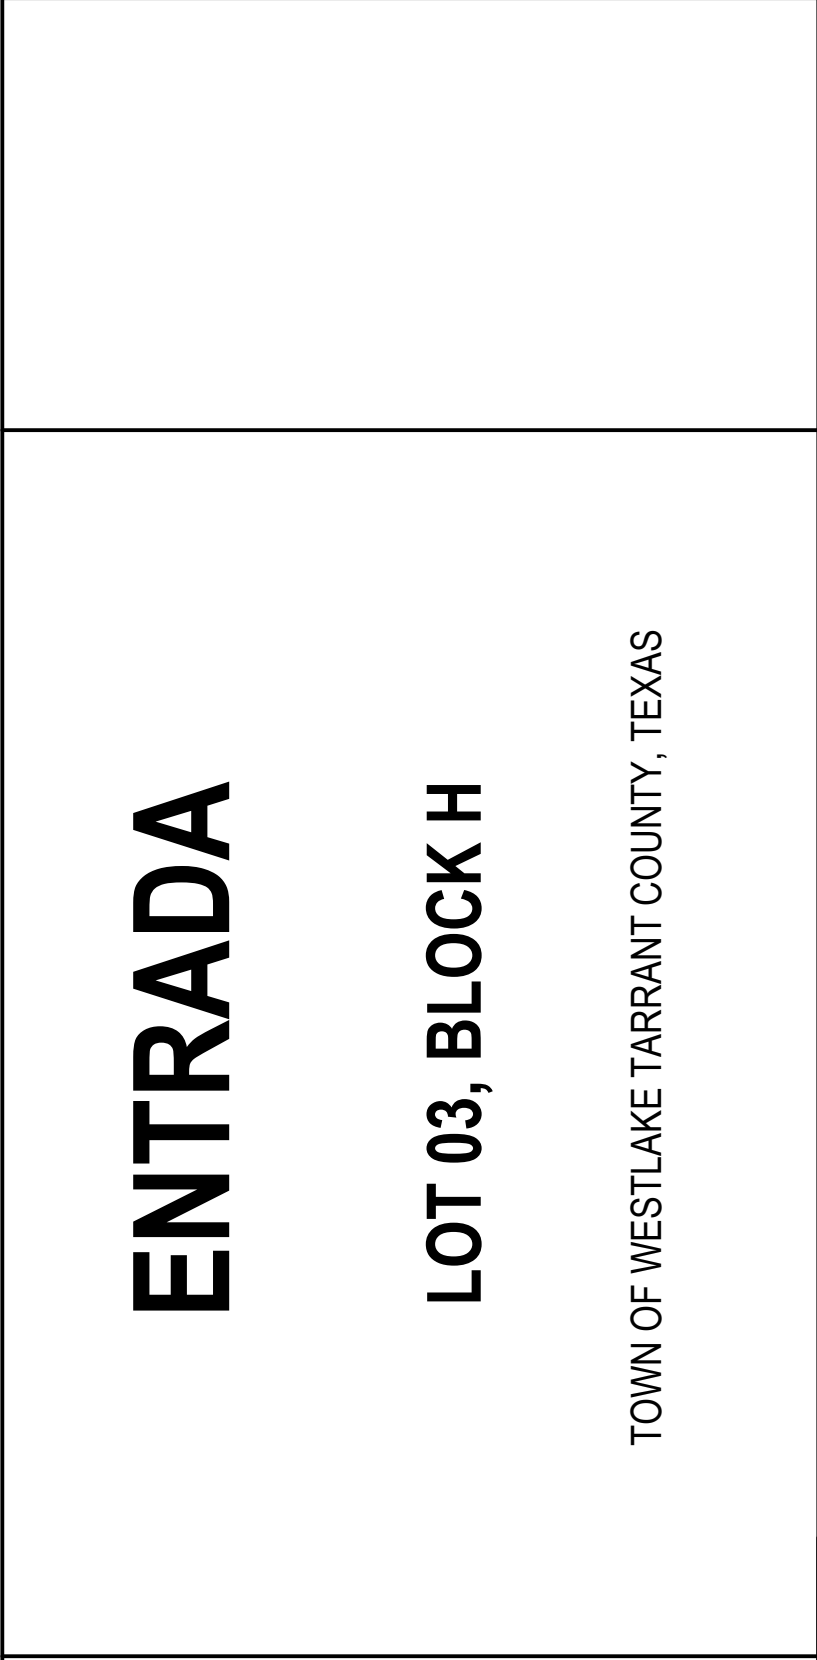


LOT 03, BLOCK H

TOWN OF WESTLAKE TARRANT COUNTY, TEXAS

[illegible]


ARCHITECTURAL SITE PLAN

A100

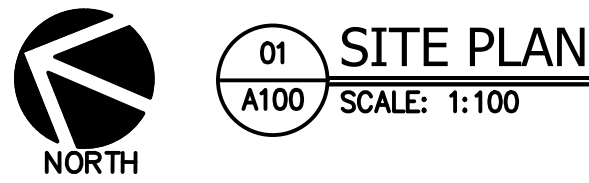

NOTE: REFER TO CIVIL PLANS FOR SITE DIMENSION CONTROL

REFER TO **ENTRADA DESIGN GUIDELINES** FOR FUTHER DETAILED INFORMATION REGARDING THESE PLANS

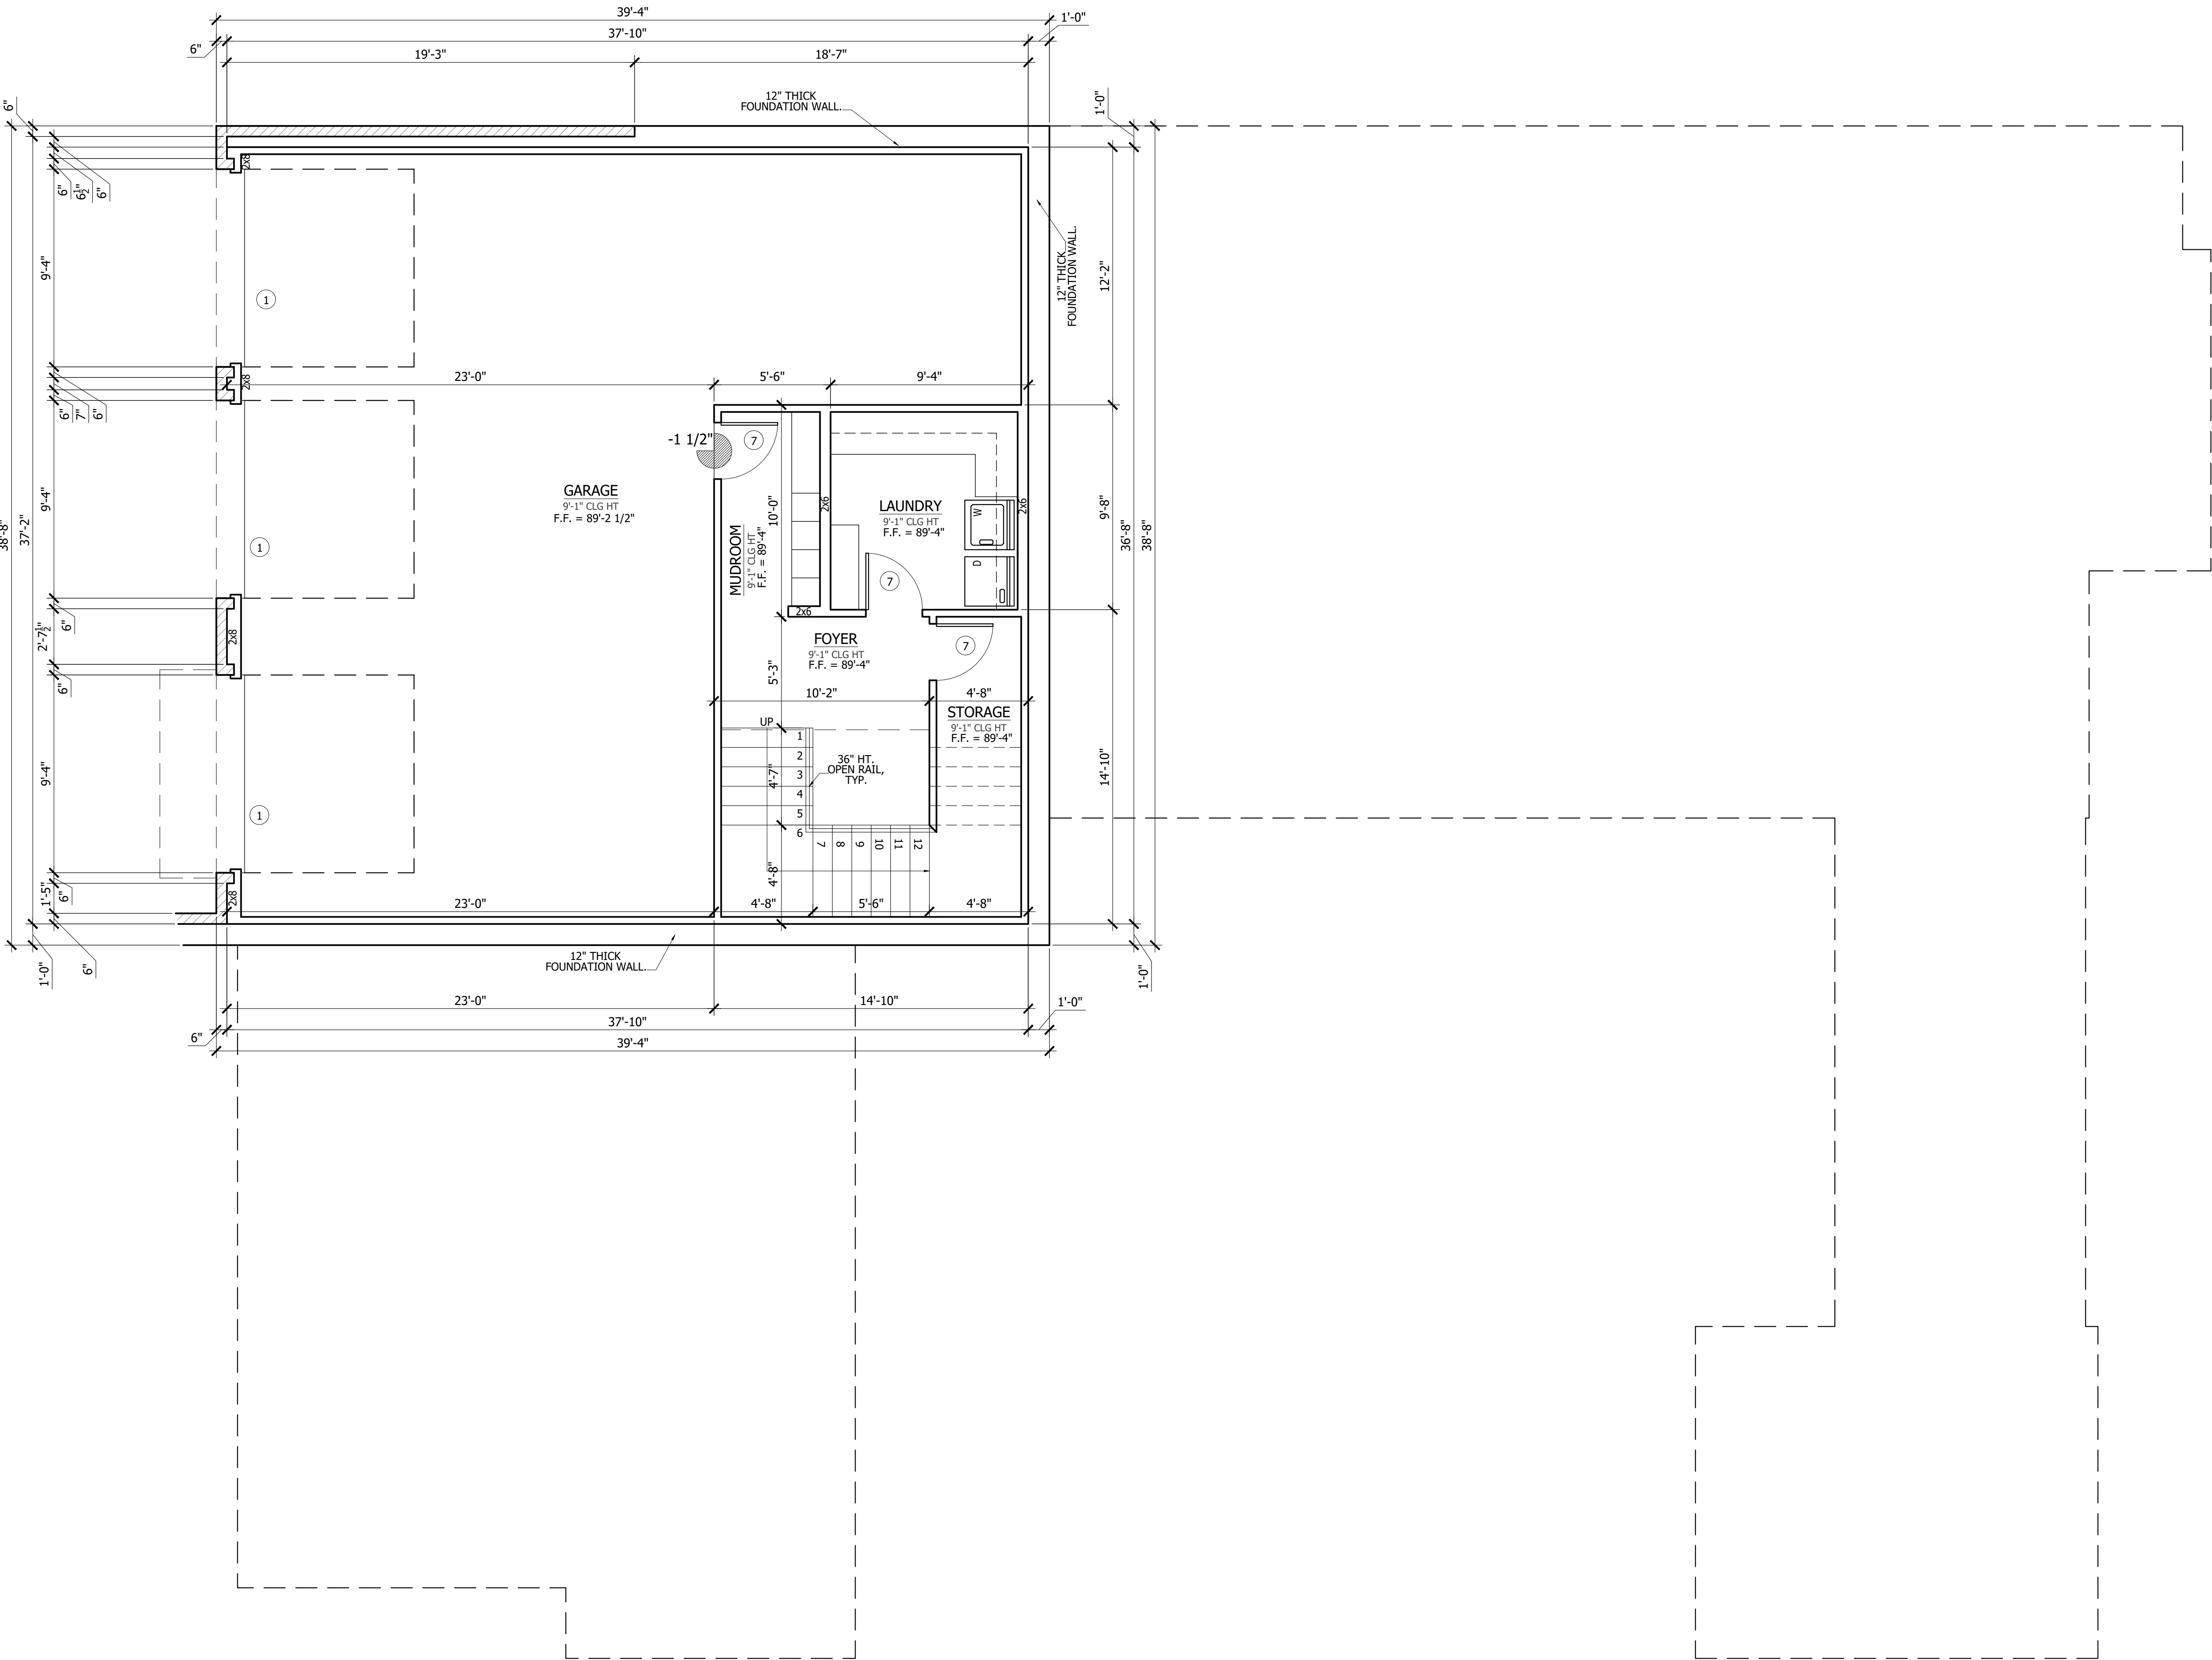

01 BASEMENT PLAN
A101 SCALE: 1/4"=1'-0"

REFER TO **ENTRADA DESIGN GUIDELINES** FOR FUTHER DETAILED INFORMATION REGARDING THESE PLANS

ENTRADA

LOT 03, BLOCK H

TOWN OF WESTLAKE TARRANT COUNTY, TEXAS

ISSUE LOG		
NO.	DESCRIPTION	DATE
PROJECT NO: 21-131		
ISSUED FOR: OTP		
DRAWN BY: Checker		
DATE: 06/24/21		

BASEMENT
FLOOR PLAN

A101

ENTRADA

LOT 03, BLOCK H

TOWN OF WESTLAKE TARRANT COUNTY, TEXAS


ISSUE LOG

NO.	DESCRIPTION	DATE

PROJECT NO: 21-131
ISSUED FOR: OTP
DRAWN BY: Checker
DATE: 06/24/21

FIRST FLOOR PLAN

A102

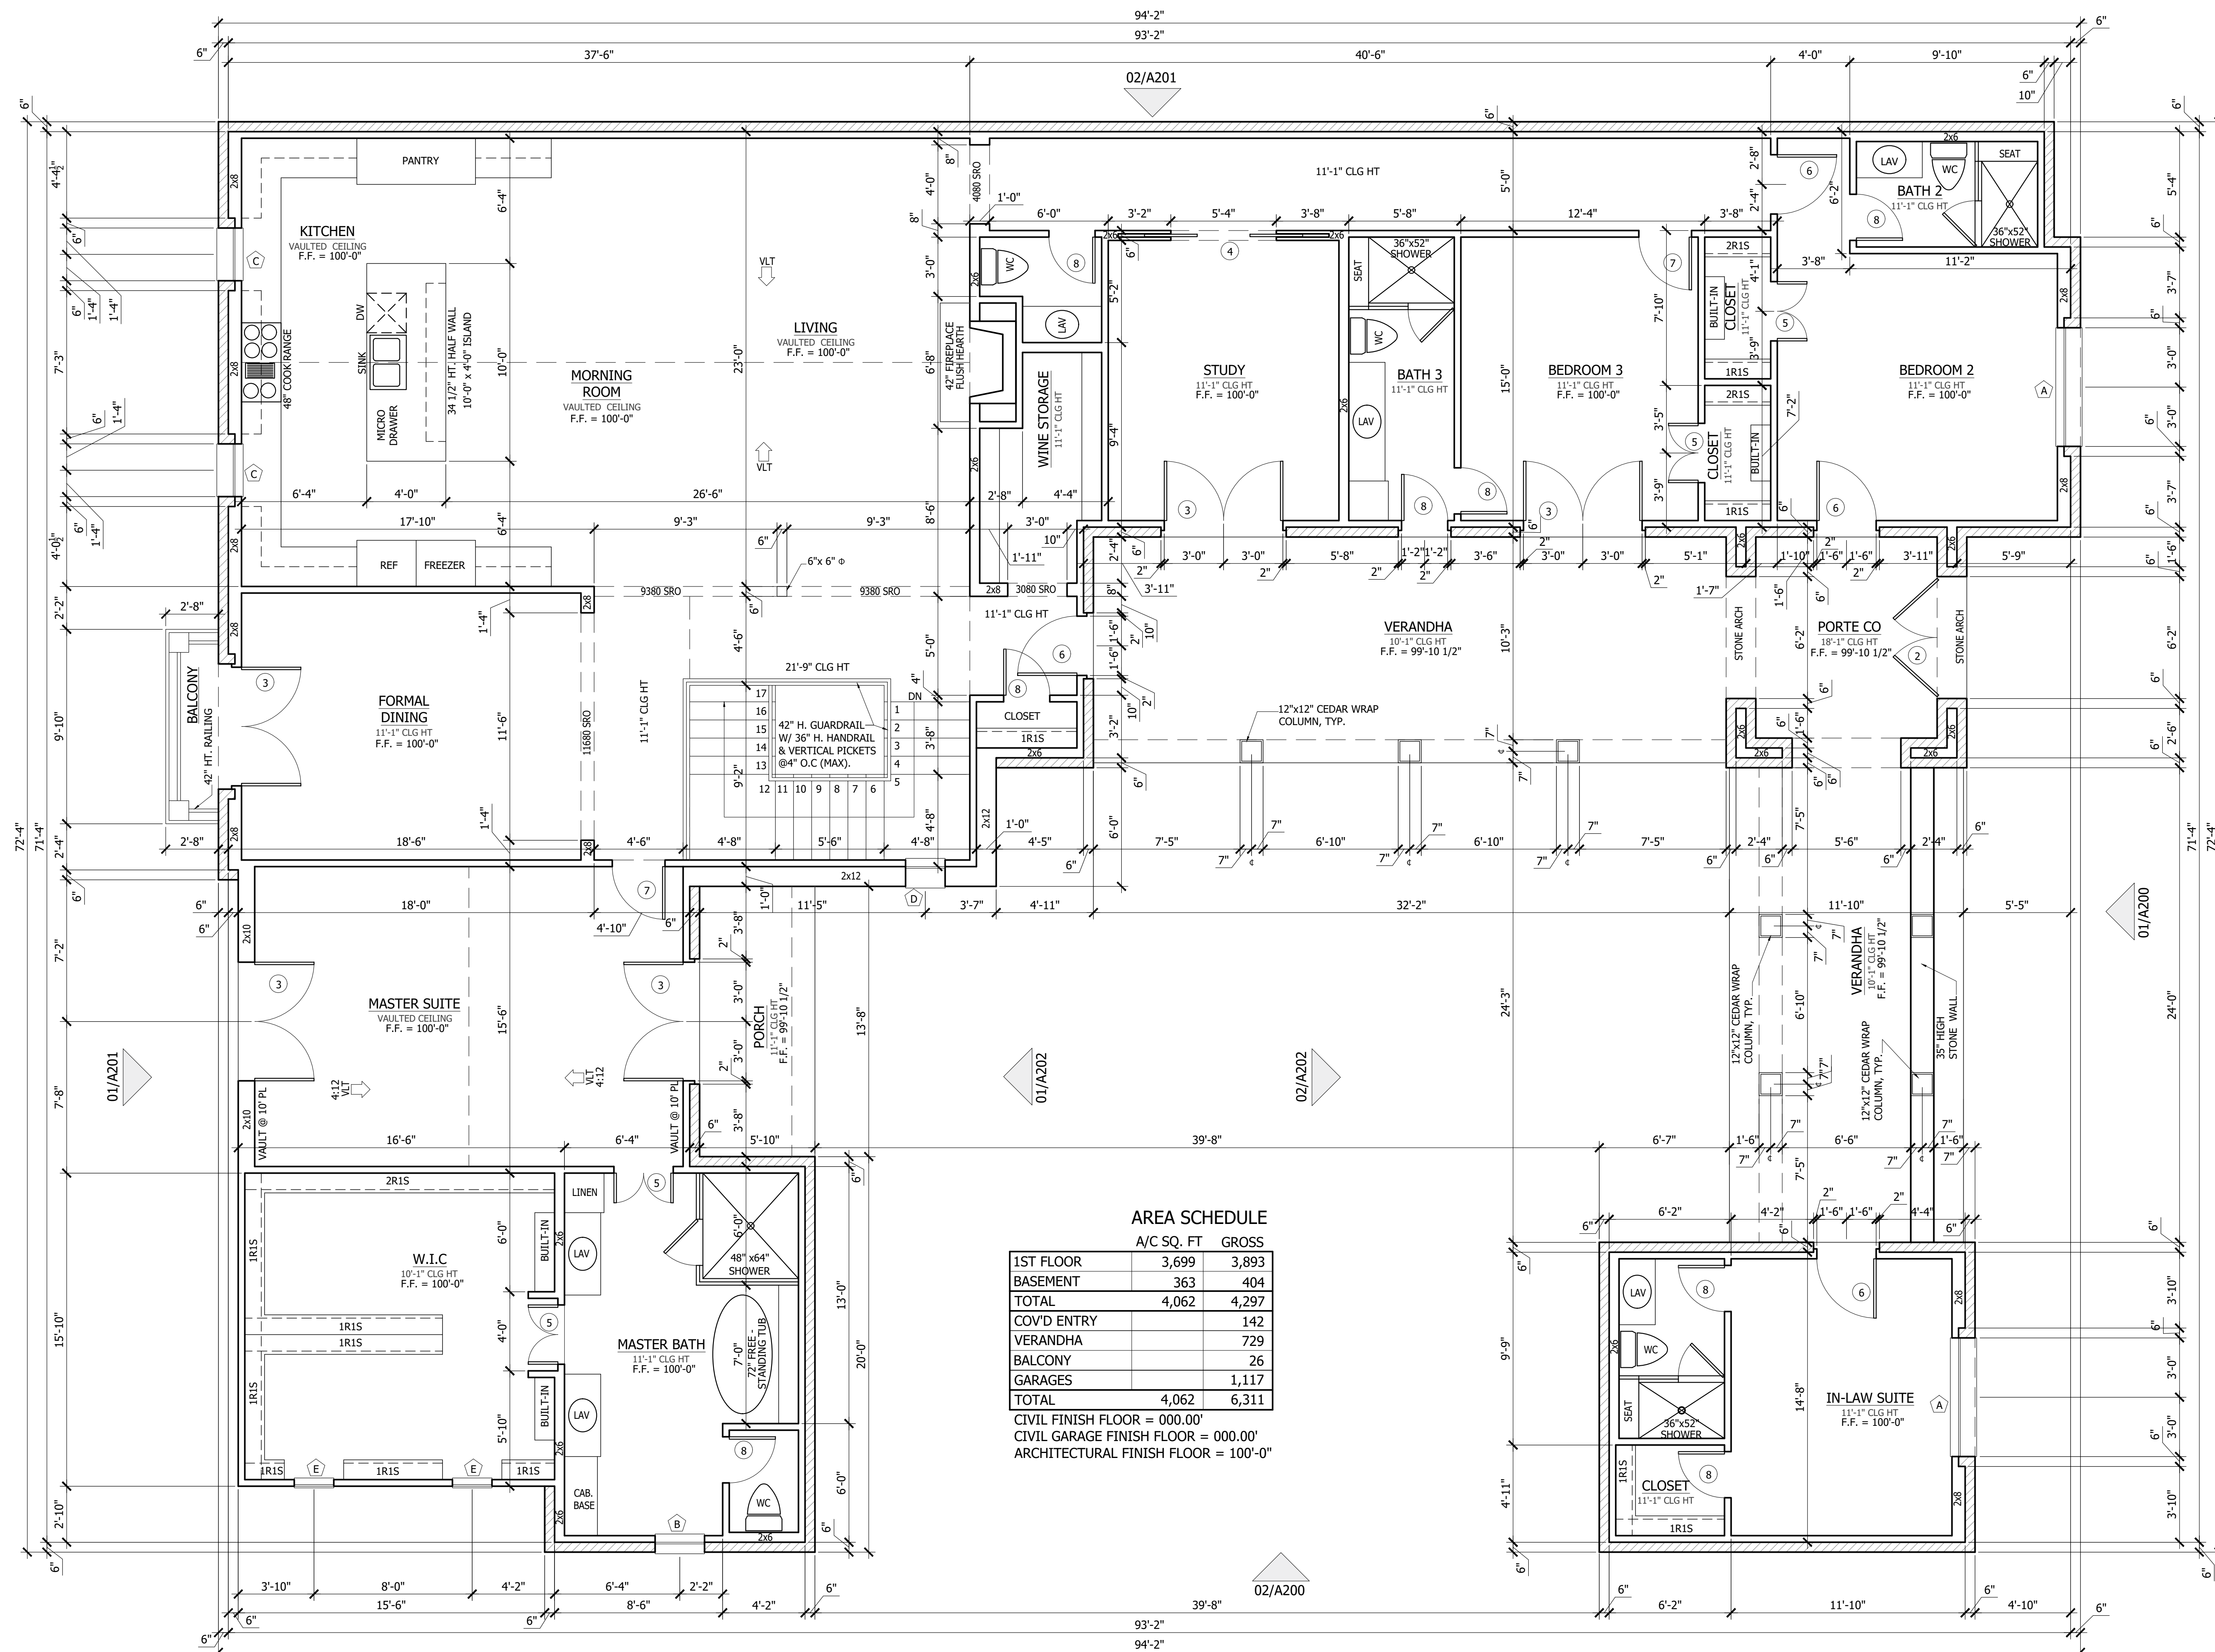

EXTERIOR WALL NOTE:
EXTERIOR WALLS W/ WINDOWS FACING
RIGHT-OF-WAY TO HAVE (2) WIDTHS OF 2x4 STUD
WALLS AT 8" FROM FACE OF STUD TO FACE OF STUD.
(REF. DTL. 09 & 11 / AS02)

ENTRADA

LOT 03, BLOCK H

TOWN OF WESTLAKE TARRANT COUNTY, TEXAS

ISSUE LOG

NO.	DESCRIPTION	DATE

PROJECT NO:	21-131
ISSUED FOR:	OTP
DRAWN BY:	Checker
DATE:	06/24/21

DOOR &
WINDOW SCHEDULE

A103

DOOR SCHEDULE							
TAG	DOOR	WIDTH	HEIGHT	TYPE	MATERIAL	STYLE	NOTES
1	9080	9'-0"	8'-0"	EXTERIOR	WOOD		ARCH / O' HEAD
1	9080	9'-0"	8'-0"	EXTERIOR	WOOD		ARCH / O' HEAD
1	9080	9'-0"	8'-0"	EXTERIOR	WOOD		ARCH / O' HEAD
2	PR3090	6'0"	9'-0"	EXTERIOR	WOOD	PAIR	ARCH / WOODEN GATE
3	PR3080	6'0"	8'-0"	EXTERIOR	WOOD	PAIR	
3	PR3080	6'0"	8'-0"	EXTERIOR	WOOD	PAIR	
3	PR3080	6'0"	8'-0"	EXTERIOR	WOOD	PAIR	
3	PR3080	6'0"	8'-0"	EXTERIOR	WOOD	PAIR	
3	PR3080	6'0"	8'-0"	EXTERIOR	WOOD	PAIR	
3	PR3080	6'0"	8'-0"	EXTERIOR	WOOD	PAIR	
4	PK2880	5'4"	8'-0"	INTERIOR	WOOD	PAIR	
5	PR1680	3'-0"	8'-0"	INTERIOR	WOOD	PAIR	
5	PR1680	3'-0"	8'-0"	INTERIOR	WOOD	PAIR	
5	PR1680	3'-0"	8'-0"	INTERIOR	WOOD	PAIR	
6	3080	3'-0"	8'-0"	EXTERIOR	WOOD		
6	3080	3'-0"	8'-0"	EXTERIOR	WOOD		
6	3080	3'-0"	8'-0"	EXTERIOR	WOOD		
7	2880	2'-8"	8'-0"	EXTERIOR	WOOD		
7	2880	2'-8"	8'-0"	INTERIOR	WOOD		
7	2880	2'-8"	8'-0"	INTERIOR	WOOD		
7	2880	2'-8"	8'-0"	INTERIOR	WOOD		
8	2480	2'-4"	8'-0"	EXTERIOR	WOOD		
8	2480	2'-4"	8'-0"	INTERIOR	WOOD		
8	2480	2'-4"	8'-0"	INTERIOR	WOOD		
8	2480	2'-4"	8'-0"	INTERIOR	WOOD		
8	2480	2'-4"	8'-0"	INTERIOR	WOOD		
8	2480	2'-4"	8'-0"	INTERIOR	WOOD		
8	2480	2'-4"	8'-0"	INTERIOR	WOOD		

01

DOOR SCHEDULE

A103

SCALE: 1/4"=1'-0"

WINDOW SCHEDULE								
TAG	WINDOW	WIDTH	HEIGHT	HDR	LITE		TYPE	NOTES
					WIDTH	HEIGHT		
A	2-3070	3'-0"	7'-0"	9'-0"	2	4	CSMT DL	ARCH /TEMPERED
A	2-3070	3'-0"	7'-0"	9'-0"	2	4	CSMT DL	ARCH /TEMPERED
B	2650	2'-6"	5'-0"	8'-0"	2	3	FXD DL	ARCH / TEMP
C	2650	2'-6"	5'-0"	8'-0"	2	3	FXD DL	
C	2650	2'-6"	5'-0"	8'-0"	2	3	FXD DL	
D	2030	2'-0"	3'-0"	8'-0"	2	2	FXD DL	TEMP
D	2030	2'-0"	3'-0"	19'-3"	2	2	FXD DL	
D	2030	2'-0"	3'-0"	19'-3"	2	2	FXD DL	
D	2030	2'-0"	3'-0"	19'-3"	2	2	FXD DL	
D	2030	2'-0"	3'-0"	19'-3"	2	2	FXD DL	
D	2030	2'-0"	3'-0"	19'-3"	2	2	FXD DL	
D	2030	2'-0"	3'-0"	19'-3"	2	2	FXD DL	
D	2030	2'-0"	3'-0"	16'-7"	2	2	FXD DL	
D	2030	2'-0"	3'-0"	16'-7"	2	2	FXD DL	
E	2020	2'-0"	2'-0"	8'-0"	2	2	FXD DL	
E	2020	2'-0"	2'-0"	8'-0"	2	2	FXD DL	
F	1026	1'-0"	2'-6"	14'-3"	1	2	FXD DL	

02

WINDOW SCHEDULE

A103

SCALE: 1/4"=1'-0"

ELECTRICAL NOTES

- ELECTRICAL INSTALLATION SHALL MEET REQUIREMENTS OF APPROVED CODES AND REGULATIONS.
- VERIFY UTILITIES AND LOCATIONS WITH CONTRACTOR.
- SWITCHED CONVENIENCE OUTLETS TO BE SWITCHED AT TOP OUTLET ONLY.
- SWITCHES: 4'-6" ABV. FINISHED FLOOR TO CENTERLINE OF SWITCH, UNLESS NOTED OTHERWISE.
- INTERIOR WALL MOUNTED BRACKET FIXTURES: 6'-6" ABV. FINISHED WALKING SURFACE TO CENTERLINE OF BRACKET, U.N.O.
- EXTERIOR WALL MOUNTED BRACKET FIXTURES: 7'-0" ABV. FINISHED WALKING SURFACE TO CENTERLINE OF BRACKET, U.N.O.
- SMOKE/CARBON MONOXIDE DETECTORS : COORDINATE W/ ALARM SYSTEM. DETECTORS TO COMPLY WITH GOVERNING CODES AND REGULATIONS.
- PROVIDE 220V JUNCTION BOX AND OTHER REQUIRED WIRING FOR HVAC UNITS. VERIFY LOCATION WITH CONTRACTOR.
- VERIFY ALL EQUIPMENT POWER REQUIREMENTS WITH THE MANUFACTURER AND/OR SUPPLIER.
- ALL EXTERIOR CONVENIENCE OUTLETS TO BE WATER PROOF AND ON A GROUND FAULT CIRCUIT.
- ALL OUTLETS SHALL BE COMBINATION TYPE AFCI AND SHALL BE TAMPER PROOF/RESISTENT.

ELECTRICAL SYMBOLS

LIGHT FIXTURES

	CEILING MOUNTED		CEILING SPEAKER
	WITH PULL CHAIN		LANDSCAPE LIGHT
	WALL BRACKET - INTERIOR AND EXTERIOR		
	RECESSED IN CEILING OR SOFFIT		
	RECESSED "WALL WASHER" IN CEILING OR SOFFIT		
	FLUORESCENT FIXTURE		LOW VOLTAGE
	UNDER CABINET LIGHT		
	RECESSED "PIN HOLE" IN CEILING OR SOFFIT		
	WALL MOUNTED FLOODLIGHT		

CONVENIENCE OUTLETS


	110V. DUPLEX OUTLET; 12" ABOVE FLOOR-TYP.		GROUNDFAULT OUTLET
	110V. FOURPLEX OUTLET; 12" ABOVE FLOOR-TYP.		ARC FAULT
	42" DISTANCE ABOVE FLOOR; OTHER THAN 12"		SWITCHED OUTLET
	WPGFI WATERPROOF GROUNDFAULT OUTLET		FLOOR OUTLET
	GDO GARAGE DOOR OPENER		220V. OUTLET

SWITCHES

	SINGLE POLE SWITCH		FOUR WAY SWITCH
	THREE WAY SWITCH		DIMMER SWITCH

GENERAL

	110V JUNCTION BOX		SMOKE DETECTOR/ CARBON MONOXIDE DETECTOR
	220V JUNCTION BOX		S.D./C.O.
	220		PUSH BUTTON
	GARBAGE DISPOSAL		LANTERN
	EXHAUST FAN		CHANDELIER
	EXHAUST FAN W/ LIGHT		CEILING FAN
	WALL EXHAUST FAN		
	ELECTRICAL PANEL		
	TELEVISION OUTLET		
	TELEPHONE/DATA OUTLET		CEILING FAN W/ LIGHT
	FAUCET		

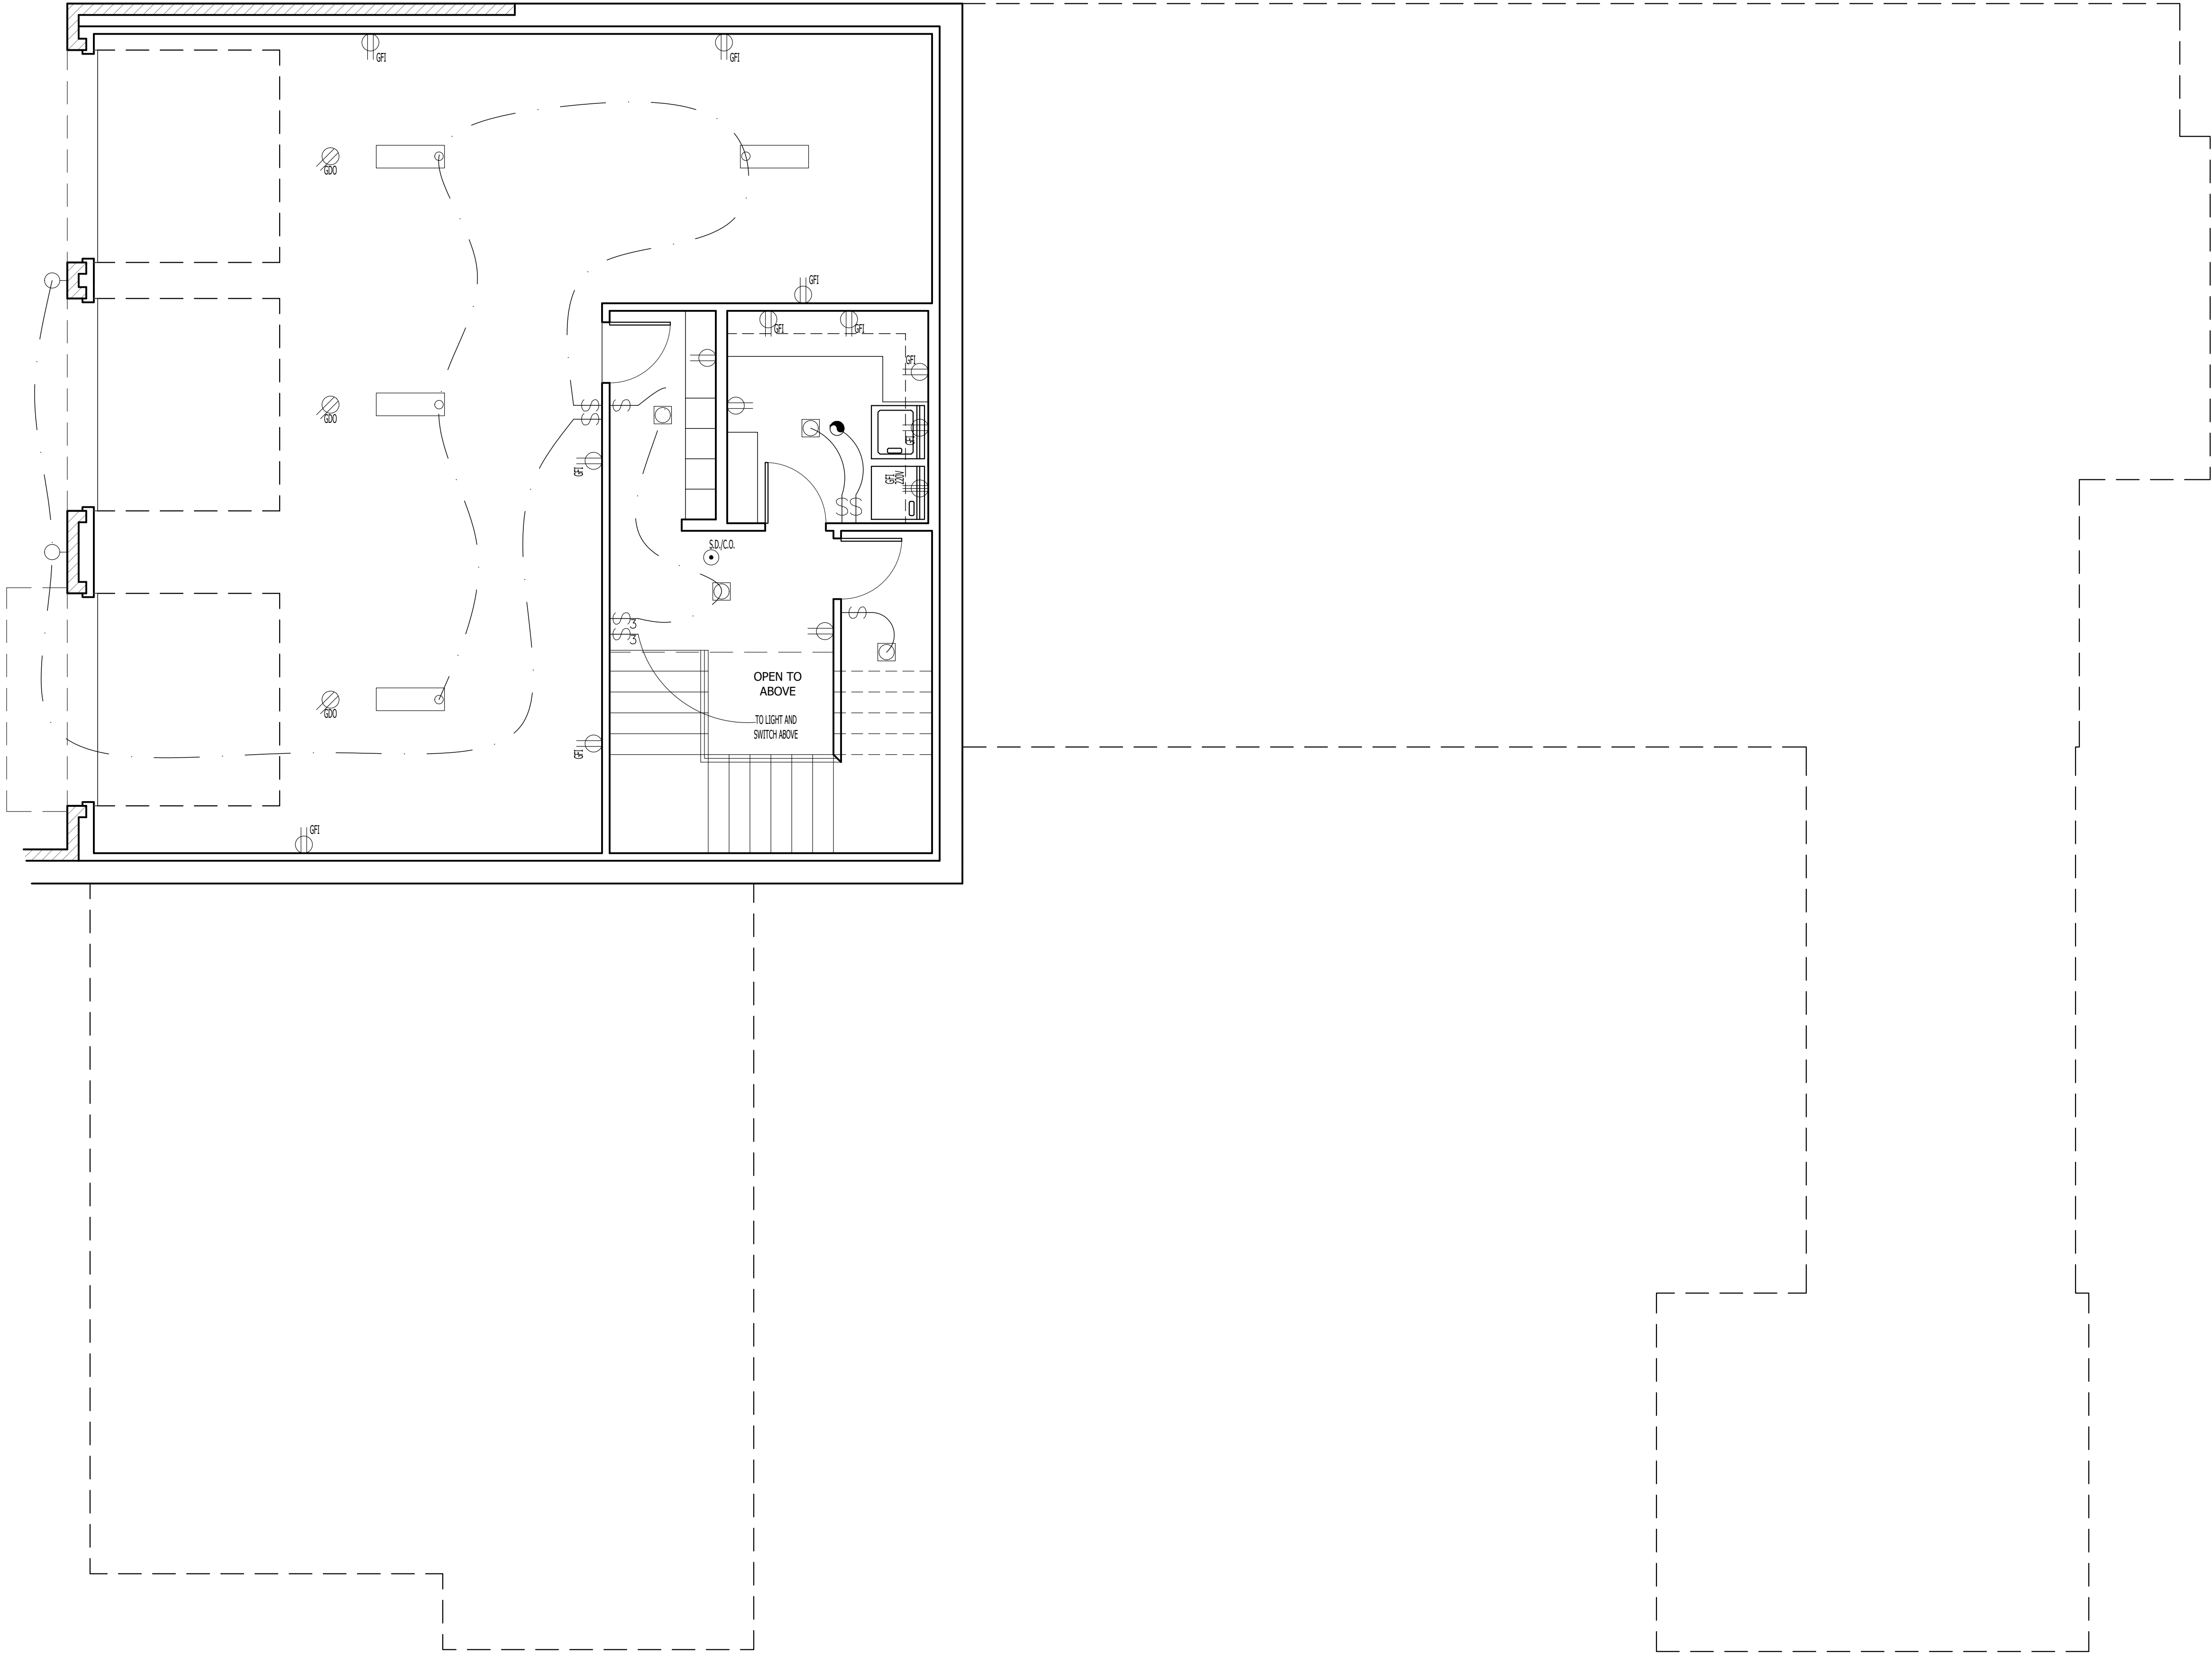

01 BASEMENT ELECTRICAL PLAN
A104 SCALE: 1/4"=1'-0"

ENTRADA

LOT 03, BLOCK H

TOWN OF WESTLAKE TARRANT COUNTY, TEXAS

ISSUE LOG

NO.	DESCRIPTION	DATE

PROJECT NO:	21-131
ISSUED FOR:	OTP
DRAWN BY:	Checker
DATE:	06/24/21

BASEMENT
ELECTRICAL PLAN

A104

REFER TO **ENTRADA DESIGN GUIDELINES** FOR FUTHER DETAILED INFORMATION REGARDING THESE PLANS

ELECTRICAL NOTES

- ELECTRICAL INSTALLATION SHALL MEET REQUIREMENTS OF APPROVED CODES AND REGULATIONS.
- VERIFY UTILITIES AND LOCATIONS WITH CONTRACTOR.
- SWITCHED CONVENIENCE OUTLETS TO BE SWITCHED AT TOP OUTLET ONLY.
- SWITCHES: 4'-6" ABV. FINISHED FLOOR TO CENTERLINE OF SWITCH, UNLESS NOTED OTHERWISE.
- INTERIOR WALL MOUNTED BRACKET FIXTURES: 6'-6" ABV. FINISHED WALKING SURFACE TO CENTERLINE OF BRACKET, U.N.O.
- EXTERIOR WALL MOUNTED BRACKET FIXTURES: 7'-0" ABV. FINISHED WALKING SURFACE TO CENTERLINE OF BRACKET, U.N.O.
- SMOKE/CARBON MONOXIDE DETECTORS : COORDINATE W/ ALARM SYSTEM. DETECTORS TO COMPLY WITH GOVERNING CODES AND REGULATIONS.
- PROVIDE 220V JUNCTION BOX AND OTHER REQUIRED WIRING FOR HVAC UNITS. VERIFY LOCATION WITH CONTRACTOR.
- VERIFY ALL EQUIPMENT POWER REQUIREMENTS WITH THE MANUFACTURER AND/OR SUPPLIER.
- ALL EXTERIOR CONVENIENCE OUTLETS TO BE WATER PROOF AND ON A GROUND FAULT CIRCUIT.
- ALL OUTLETS SHALL BE COMBINATION TYPE AFCI AND SHALL BE TAMPER PROOF/RESISTENT.

ELECTRICAL SYMBOLS

LIGHT FIXTURES

 CEILING MOUNTED WITH PULL CHAIN

 CEILING SPEAKER

 WALL BRACKET - INTERIOR AND EXTERIOR

 LANDSCAPE LIGHT

 RECESSED IN CEILING OR SOFFIT

 RECESSED "WALL WASHER" IN CEILING OR SOFFIT

 FLUORESCENT FIXTURE

 LOW VOLTAGE

 UNDER CABINET LIGHT

 RECESSED "PIN HOLE" IN CEILING OR SOFFIT

 WALL MOUNTED FLOODLIGHT

CONVENIENCE OUTLETS

 110V. DUPLEX OUTLET, 12" ABOVE FLOOR-TYP.

 110V. FOURPLEX OUTLET, 12" ABOVE FLOOR-TYP.

 42" DISTANCE ABOVE FLOOR, OTHER THAN 12"

 WP/GFI WATERPROOF GROUNDFAULT OUTLET

 GDO GARAGE DOOR OPENER

 GFI GROUNDFAULT OUTLET

 AFC ARC FAULT

 SWITCHED OUTLET

 FLOOR OUTLET

 220V. OUTLET

SWITCHES

 SINGLE POLE SWITCH

 FOUR WAY SWITCH

 THREE WAY SWITCH

 DIMMER SWITCH

GENERAL

 110V JUNCTION BOX

 220V JUNCTION BOX

 220

 GARBAGE DISPOSAL

 EXHAUST FAN

 EXHAUST FAN W/ LIGHT

 WALL EXHAUST FAN

 ELECTRICAL PANEL

 TELEVISION OUTLET

 TELEPHONE/DATA OUTLET

 FAUCET

 SMOKE DETECTOR/ CARBON MONOXIDE DETECTOR

 S.D./C.O.


 PUSH BUTTON

 LANTERN

 CHANDELIER

 CEILING FAN

 CEILING FAN W/ LIGHT

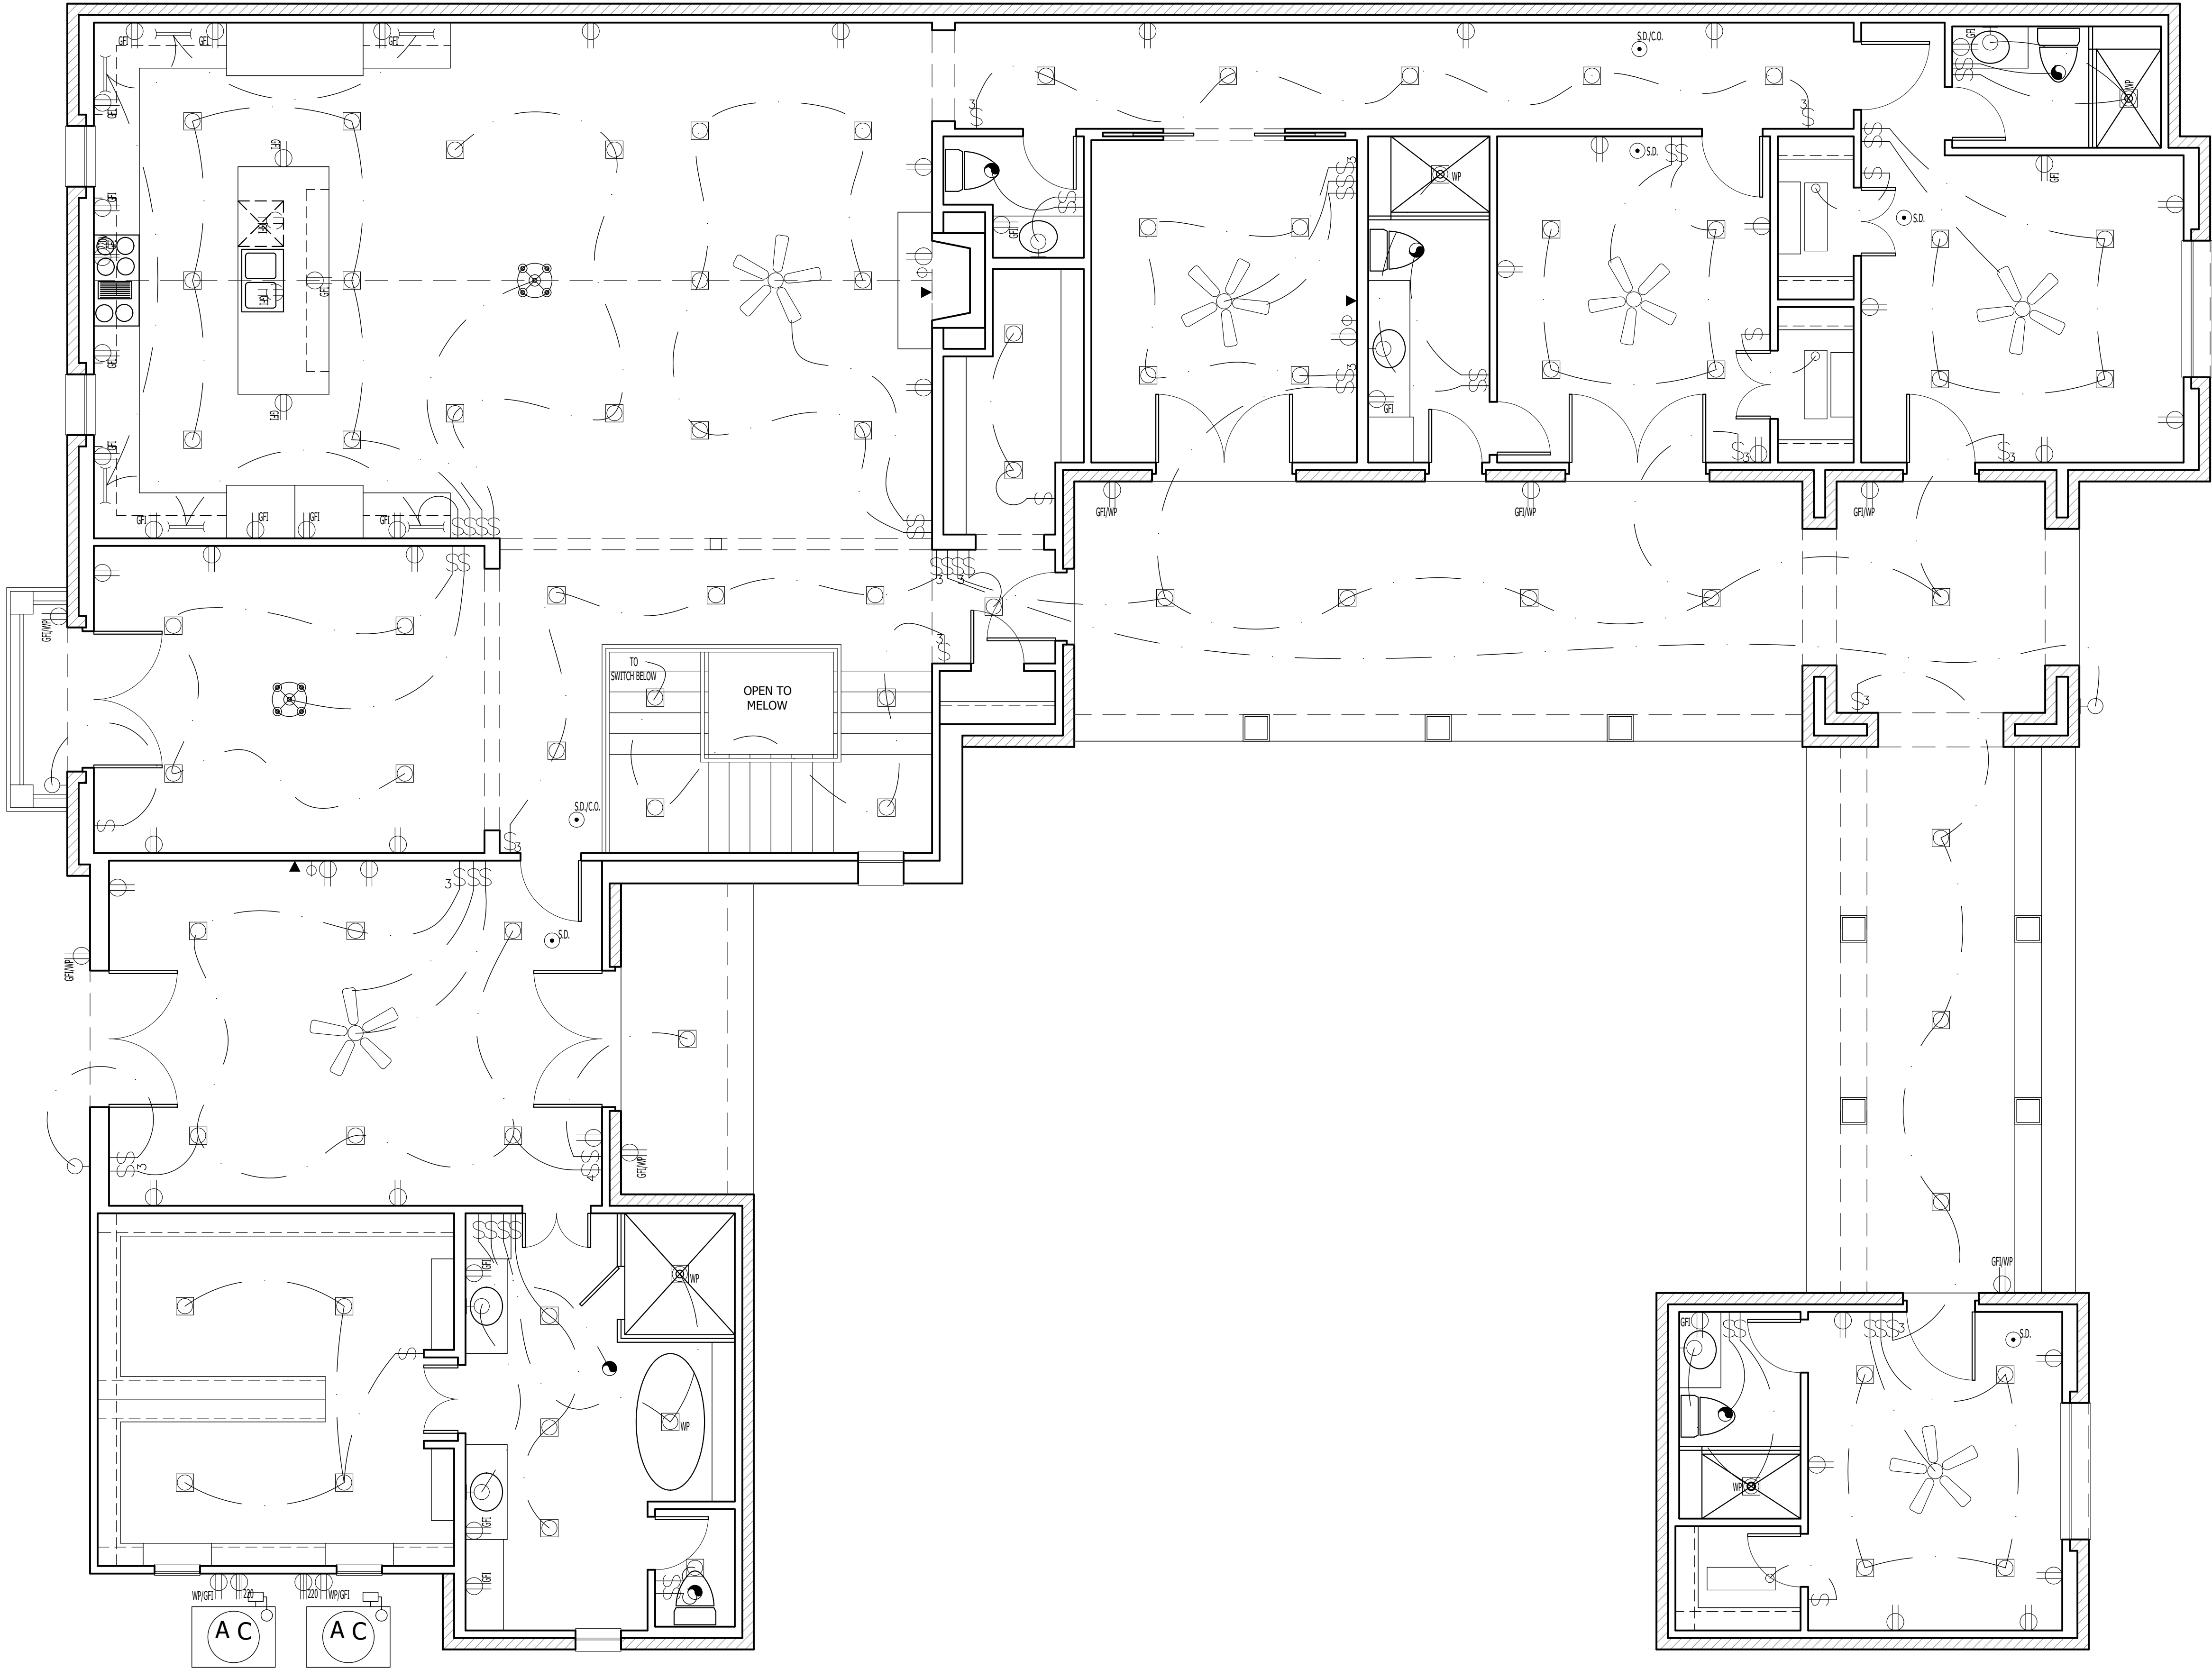

01 FIRST FLOOR ELECTRICAL PLAN
A105 SCALE: 1/4"=1'-0"

ENTRADA

LOT 03, BLOCK H

TOWN OF WESTLAKE TARRANT COUNTY, TEXAS

ISSUE LOG


NO.	DESCRIPTION	DATE

PROJECT NO:	21-131
ISSUED FOR:	OTP
DRAWN BY:	Checker
DATE:	06/24/21

FIRST FLOOR
ELECTRICAL PLAN

A105

REFER TO **ENTRADA DESIGN GUIDELINES** FOR FUTHER DETAILED INFORMATION REGARDING THESE PLANS

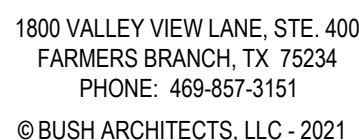

LOT 03, BLOCK H

TOWN OF WESTLAKE TARRANT COUNTY, TEXAS

[illegible]

ROOF PLAN

A106



REFER TO **ENTRADA DESIGN GUIDELINES** FOR FUTHER DETAILED INFORMATION REGARDING THESE PLANS

ENTRADA

LOT 03, BLOCK H

TOWN OF WESTLAKE TARRANT COUNTY, TEXAS


ISSUE LOG

NO.	DESCRIPTION	DATE


PROJECT NO: 21-131
ISSUED FOR: OTP
DRAWN BY: Checker
DATE: 06/24/21

FRONT & LEFT ELEVATIONS

A200

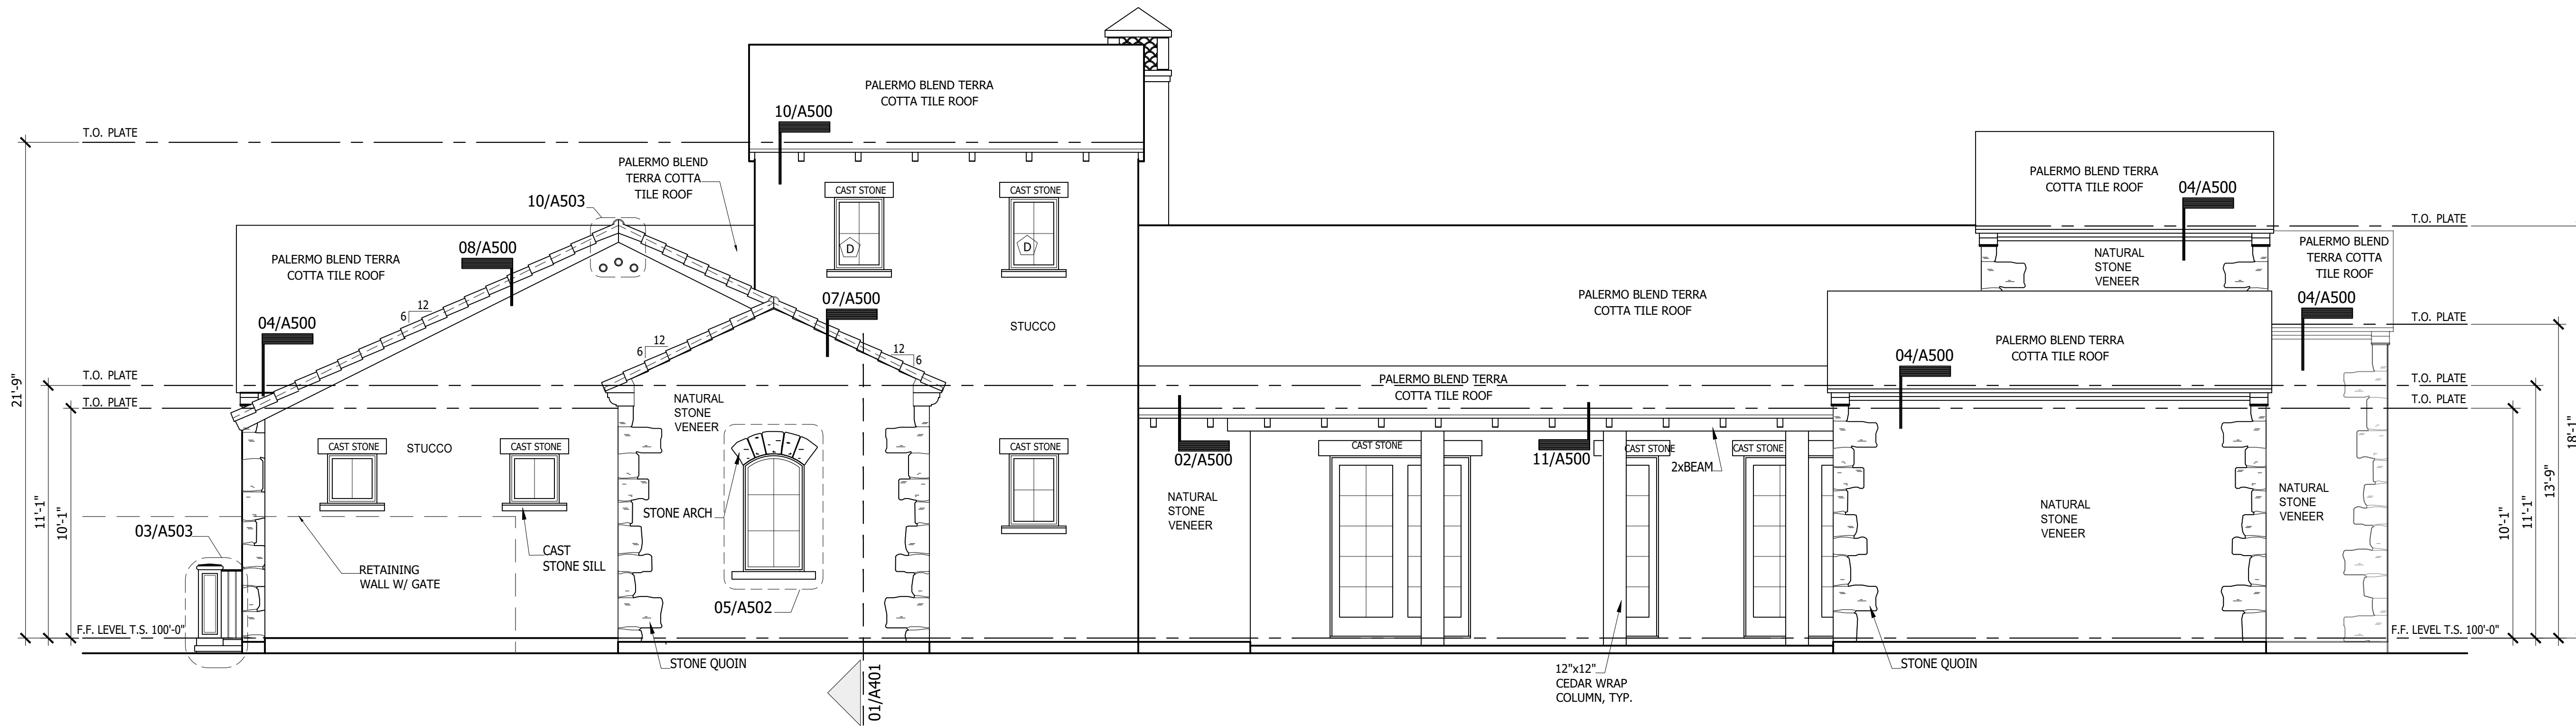

02 LEFT ELEVATION
A200 SCALE: 1/4"=1'-0"

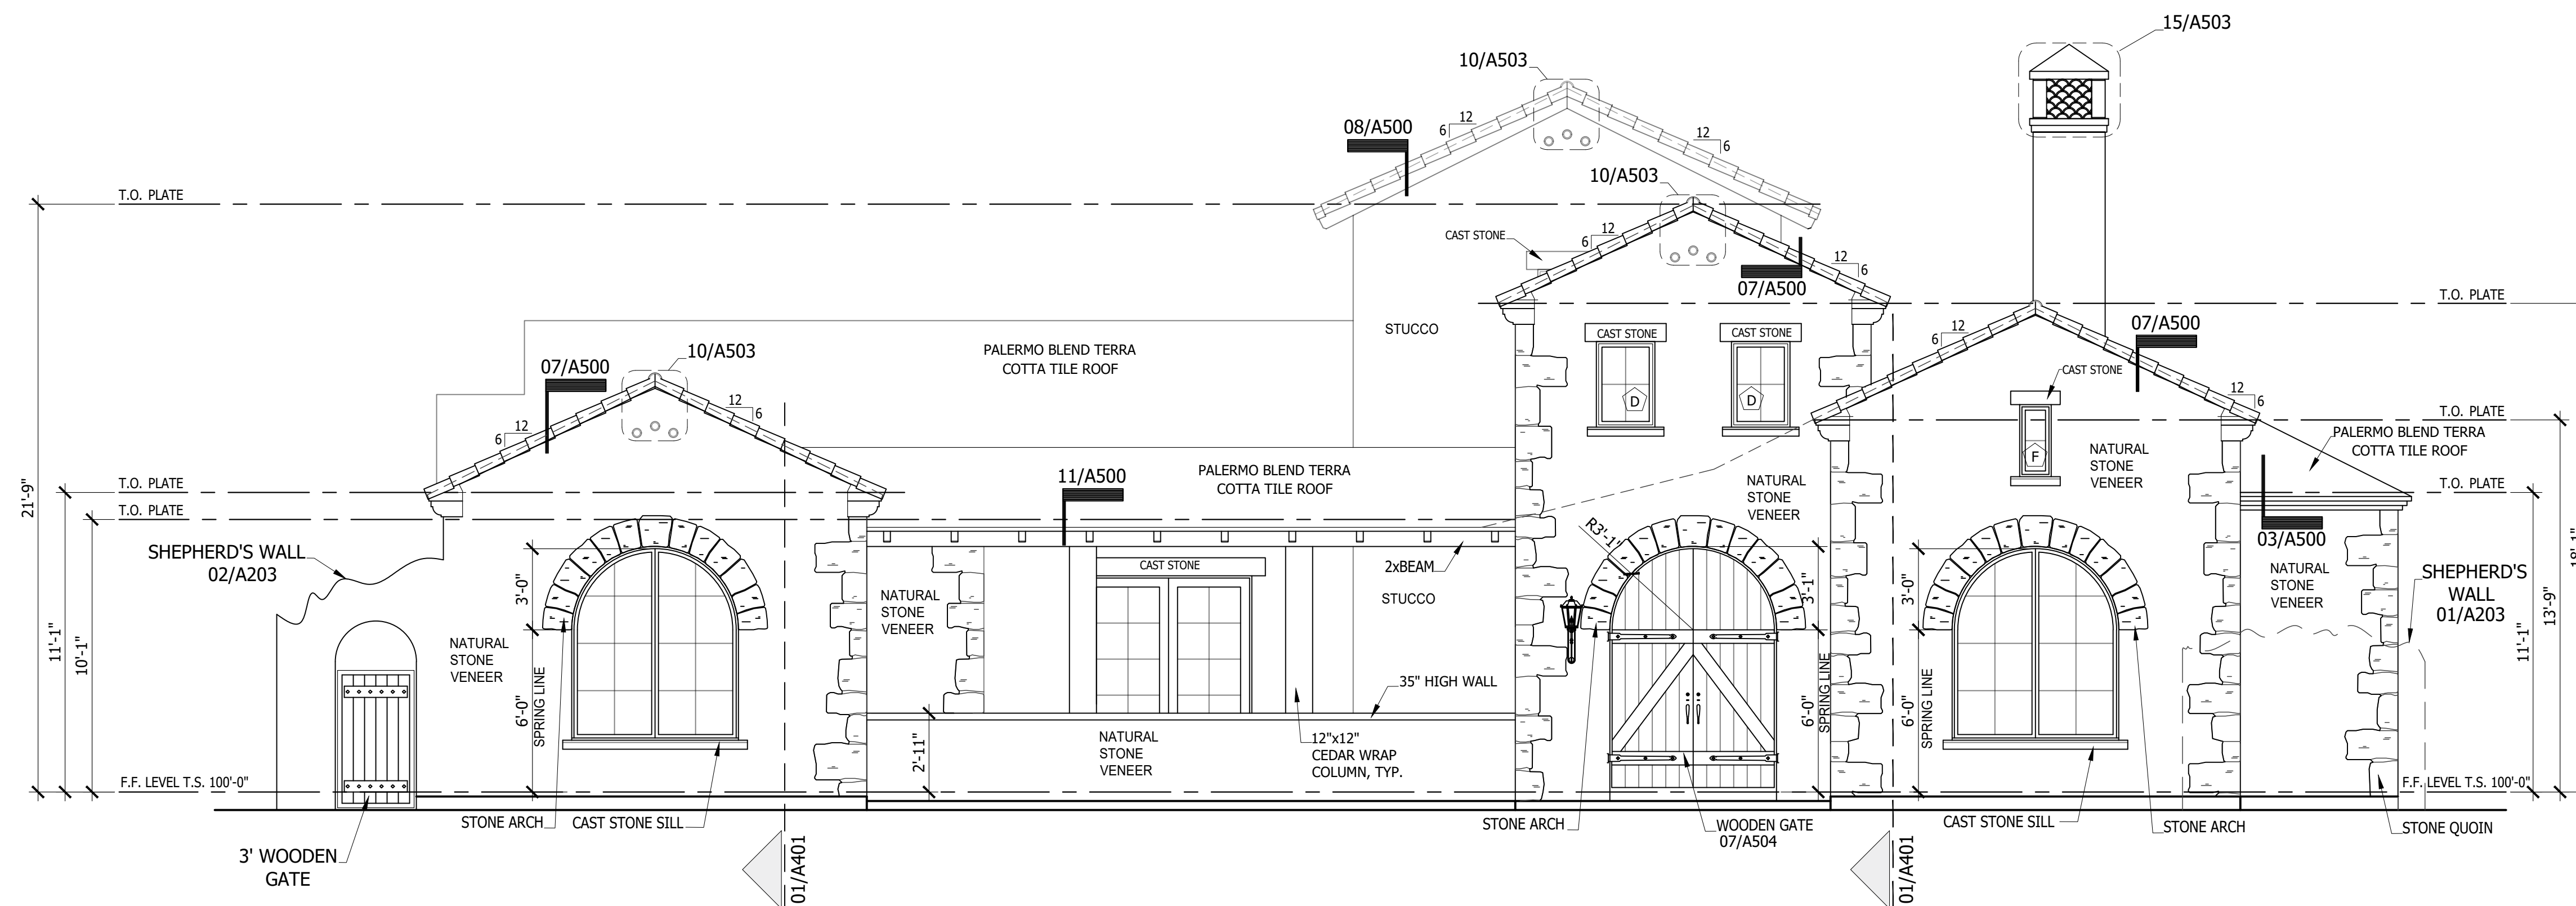

01 FRONT ELEVATION
A200 SCALE: 1/4"=1'-0"

REFER TO **ENTRADA DESIGN GUIDELINES** FOR FUTHER DETAILED INFORMATION REGARDING THESE PLANS

ENTRADA

LOT 03, BLOCK H

TOWN OF WESTLAKE TARRANT COUNTY, TEXAS


ISSUE LOG

NO.	DESCRIPTION	DATE


PROJECT NO: 21-131
ISSUED FOR: OTP
DRAWN BY: Checker
DATE: 06/24/21

REAR & RIGHT ELEVATIONS

A201

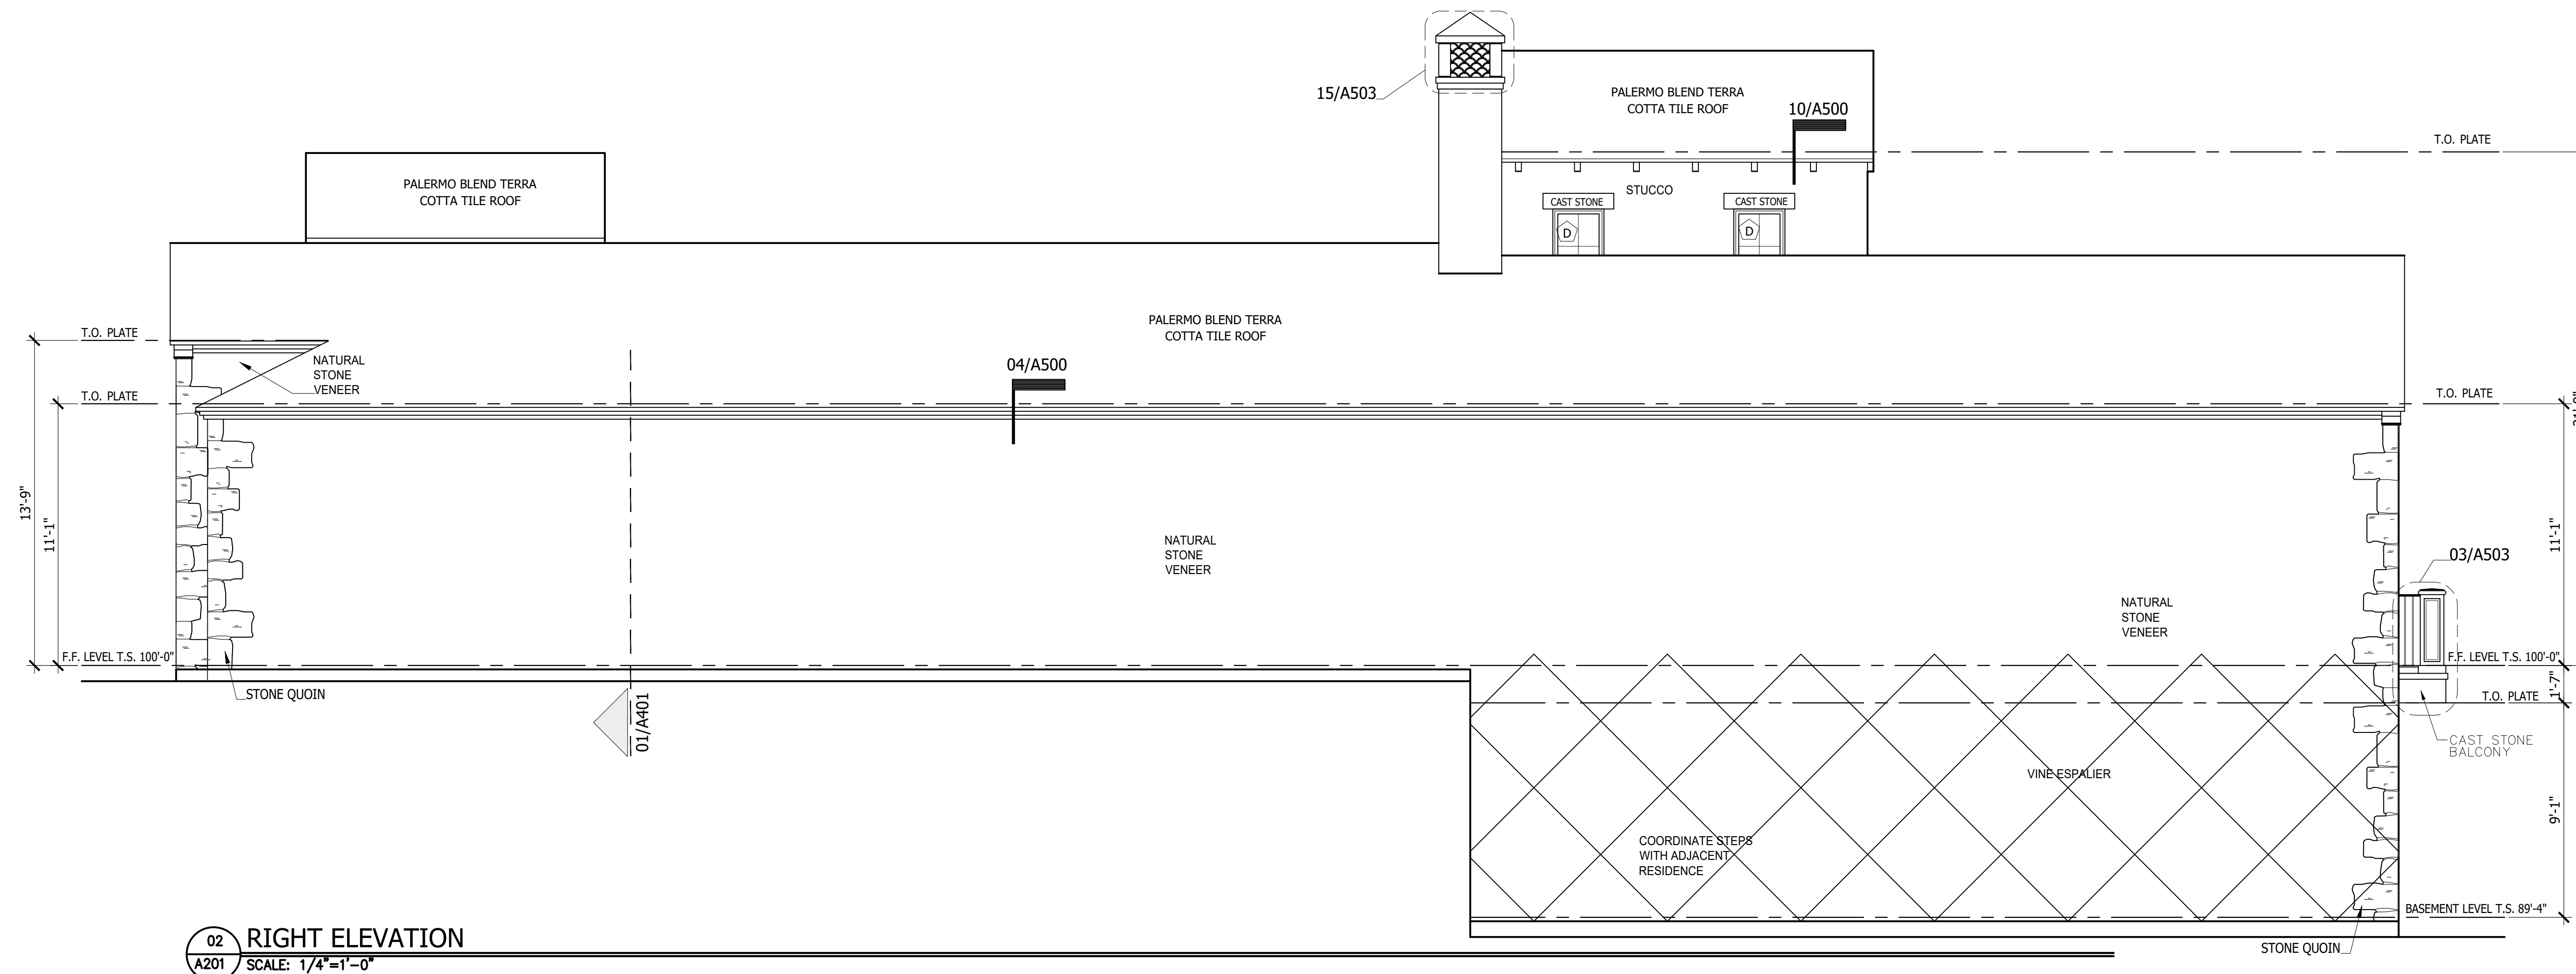

02 RIGHT ELEVATION
A201 SCALE: 1/4"=1'-0"

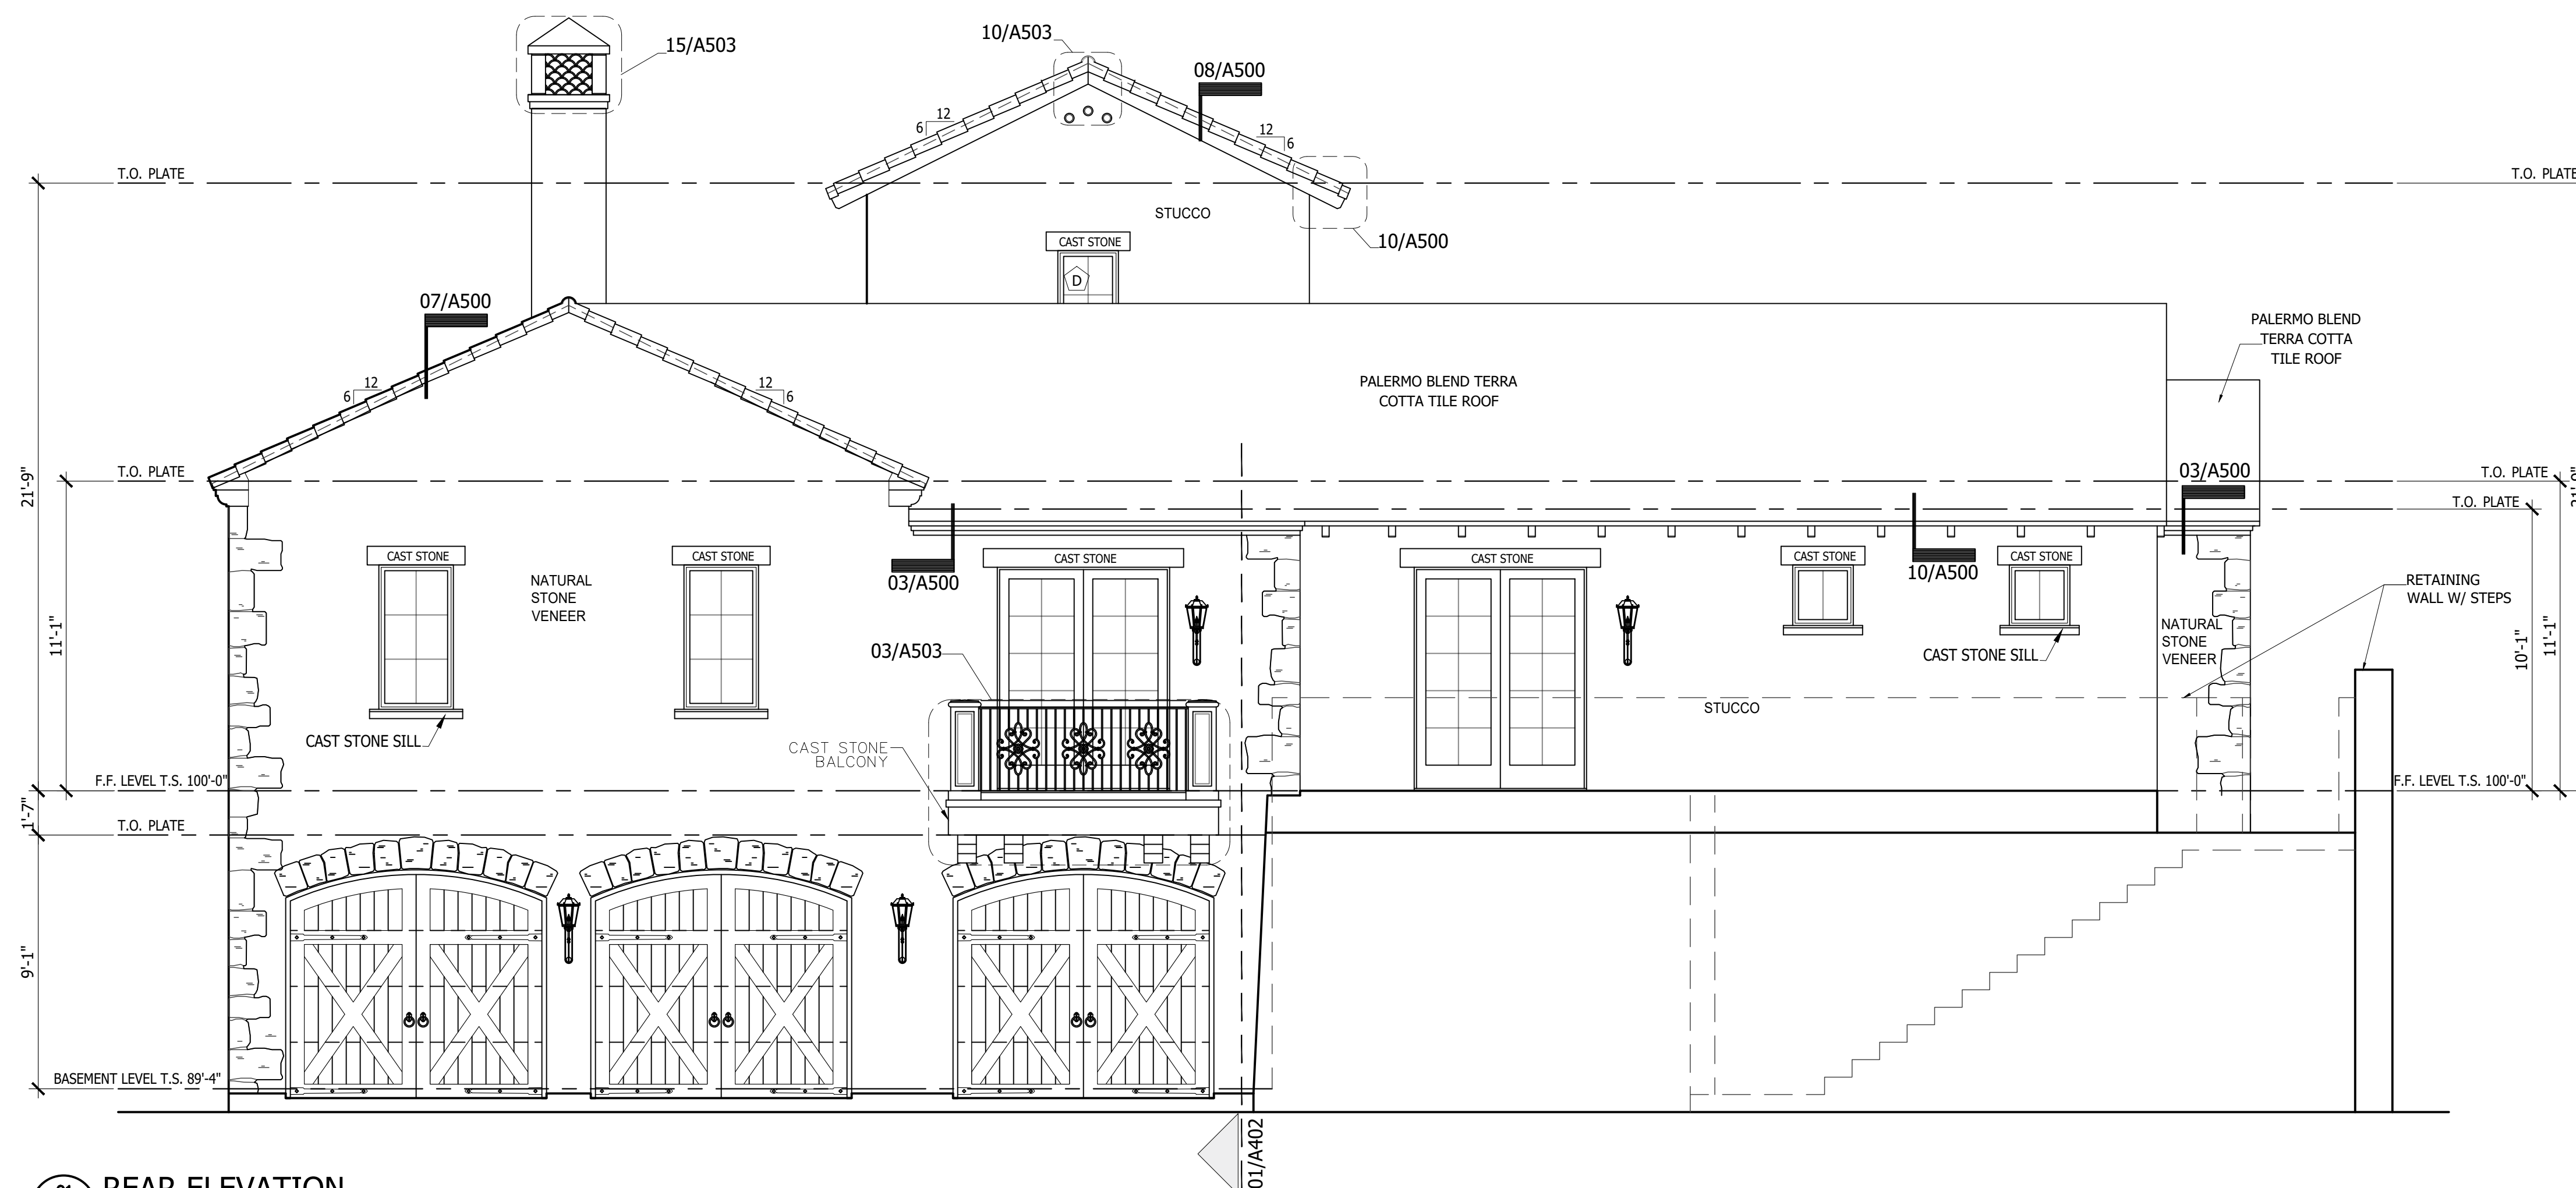

01 REAR ELEVATION
A201 SCALE: 1/4"=1'-0"

REFER TO **ENTRADA DESIGN GUIDELINES** FOR FUTHER DETAILED INFORMATION REGARDING THESE PLANS

ENTRADA

LOT 03, BLOCK H

TOWN OF WESTLAKE TARRANT COUNTY, TEXAS


ISSUE LOG

NO.	DESCRIPTION	DATE

PROJECT NO:	21-131
ISSUED FOR:	OTP
DRAWN BY:	Checker
DATE:	06/24/21

COURTYARD ELEVATIONS

A202

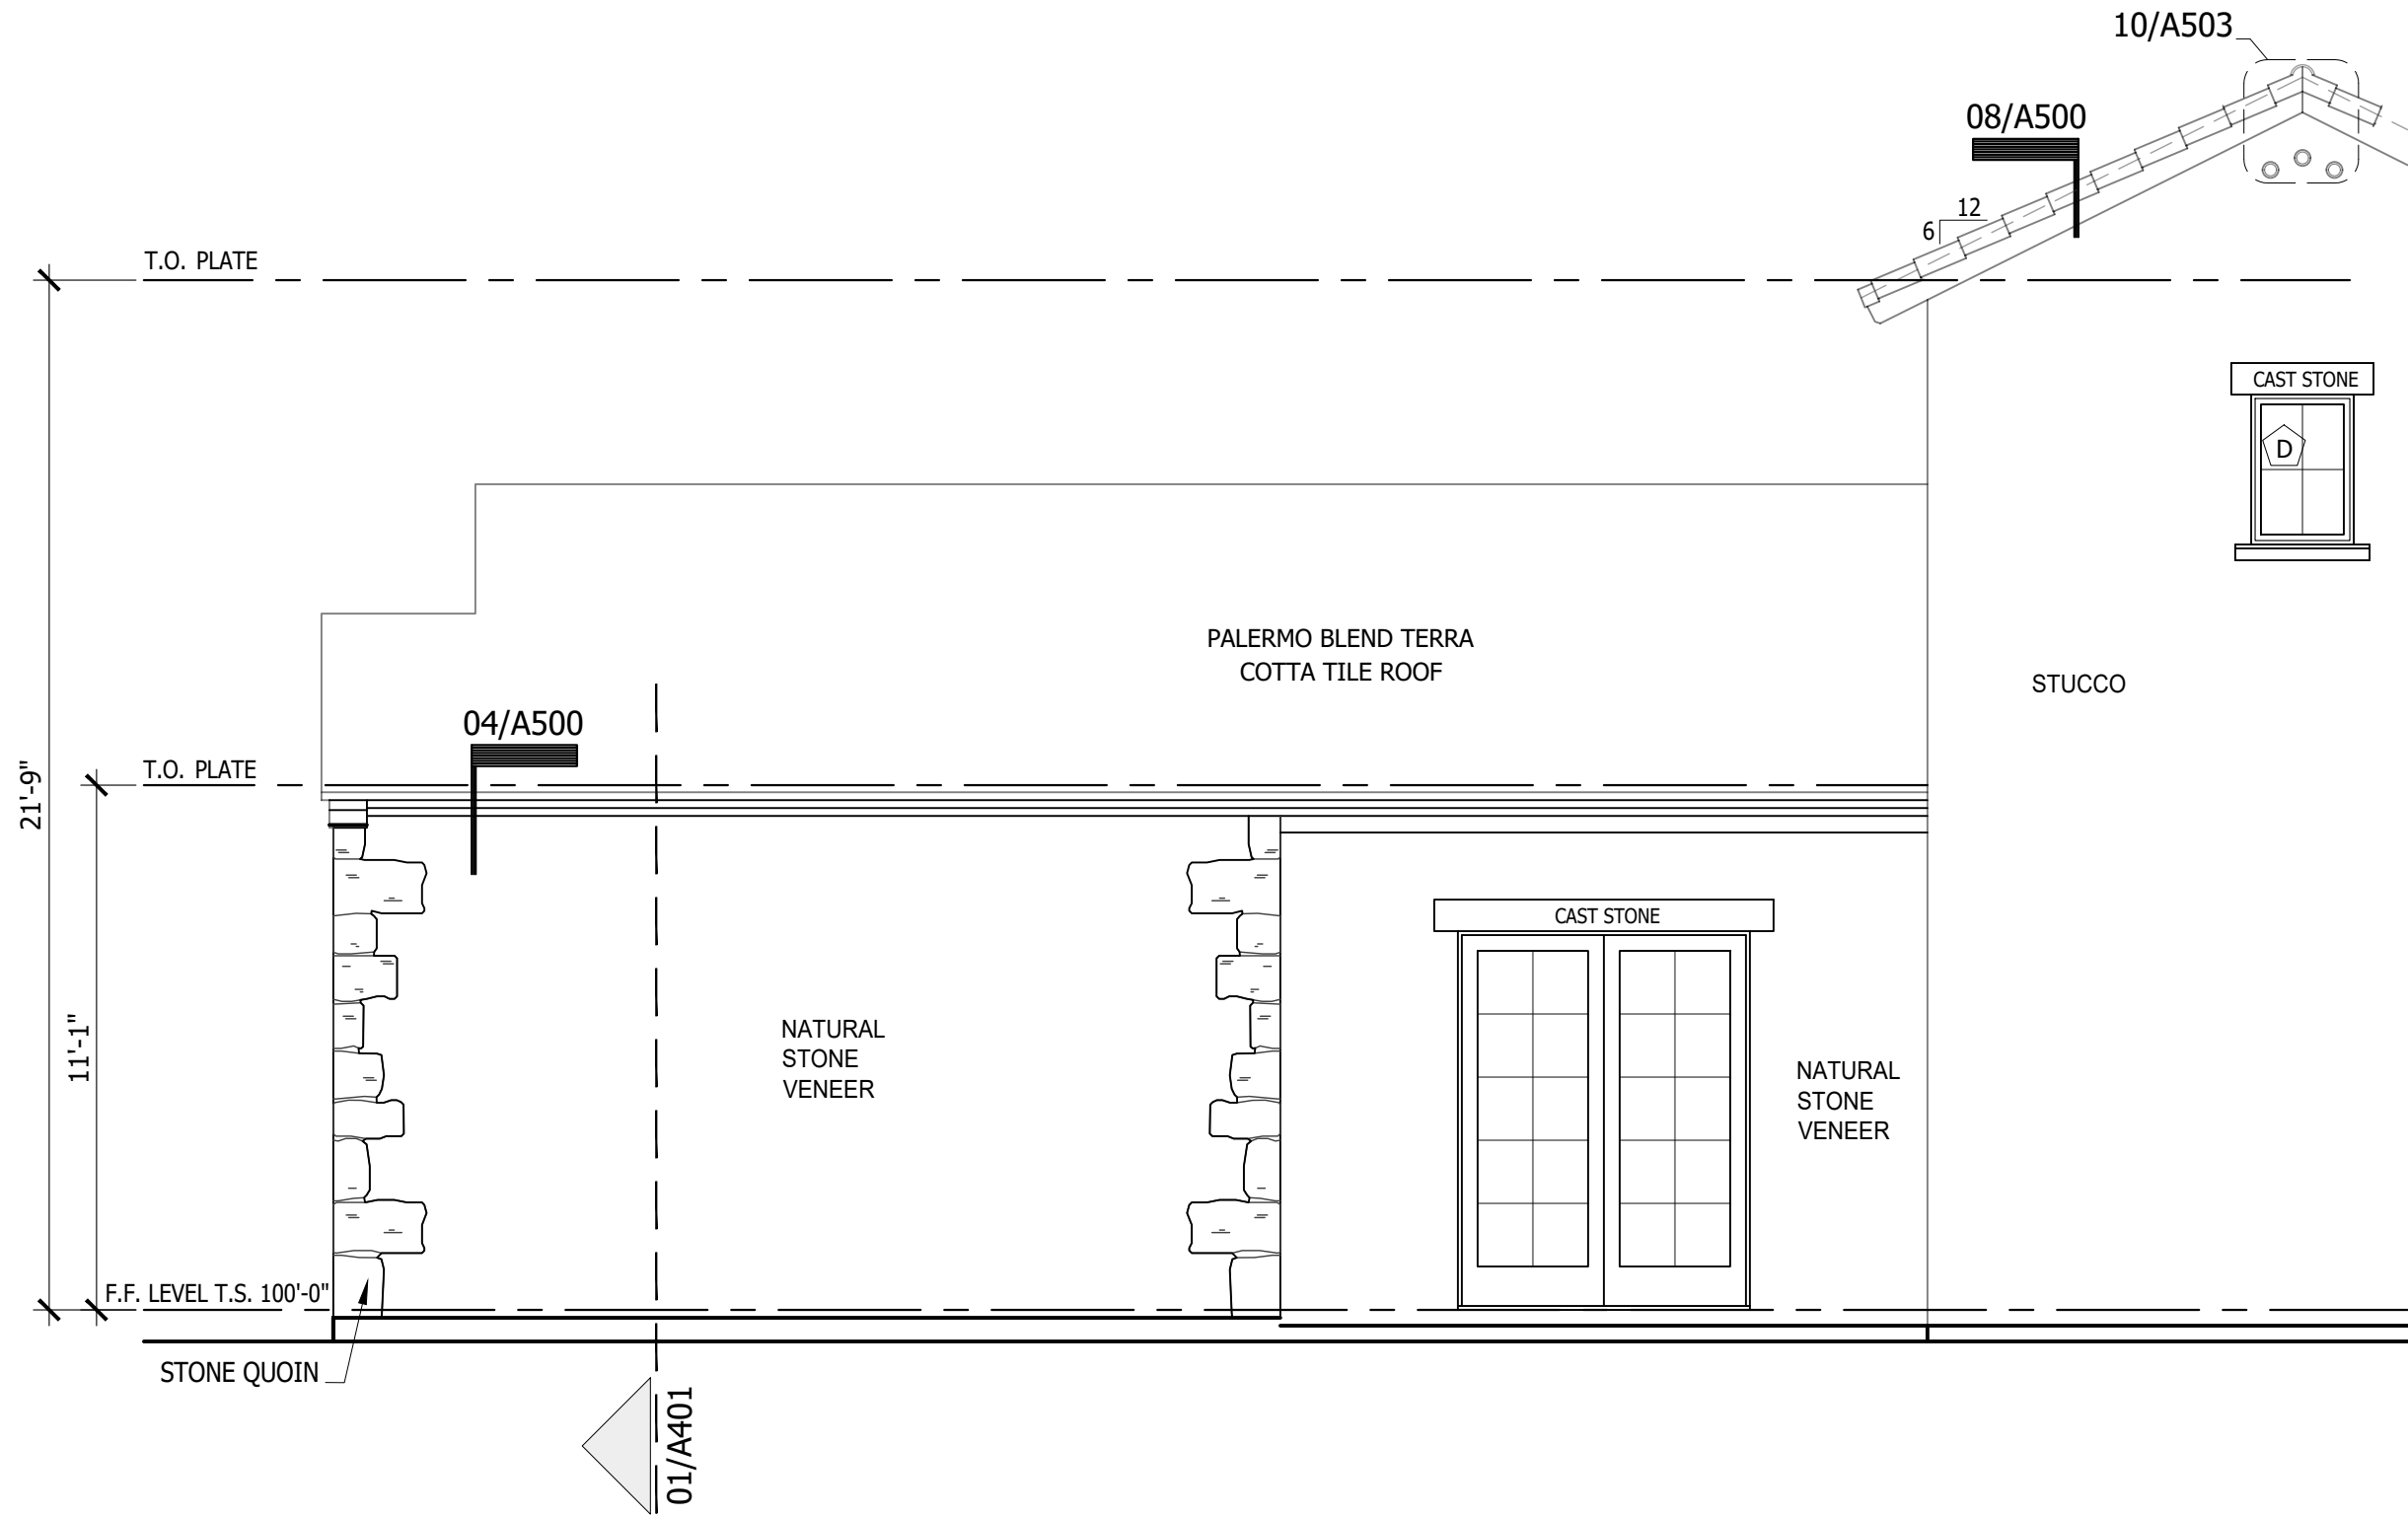


01

COUTYARD ELEVATION

A202

SCALE: 1/4"=1'-0"

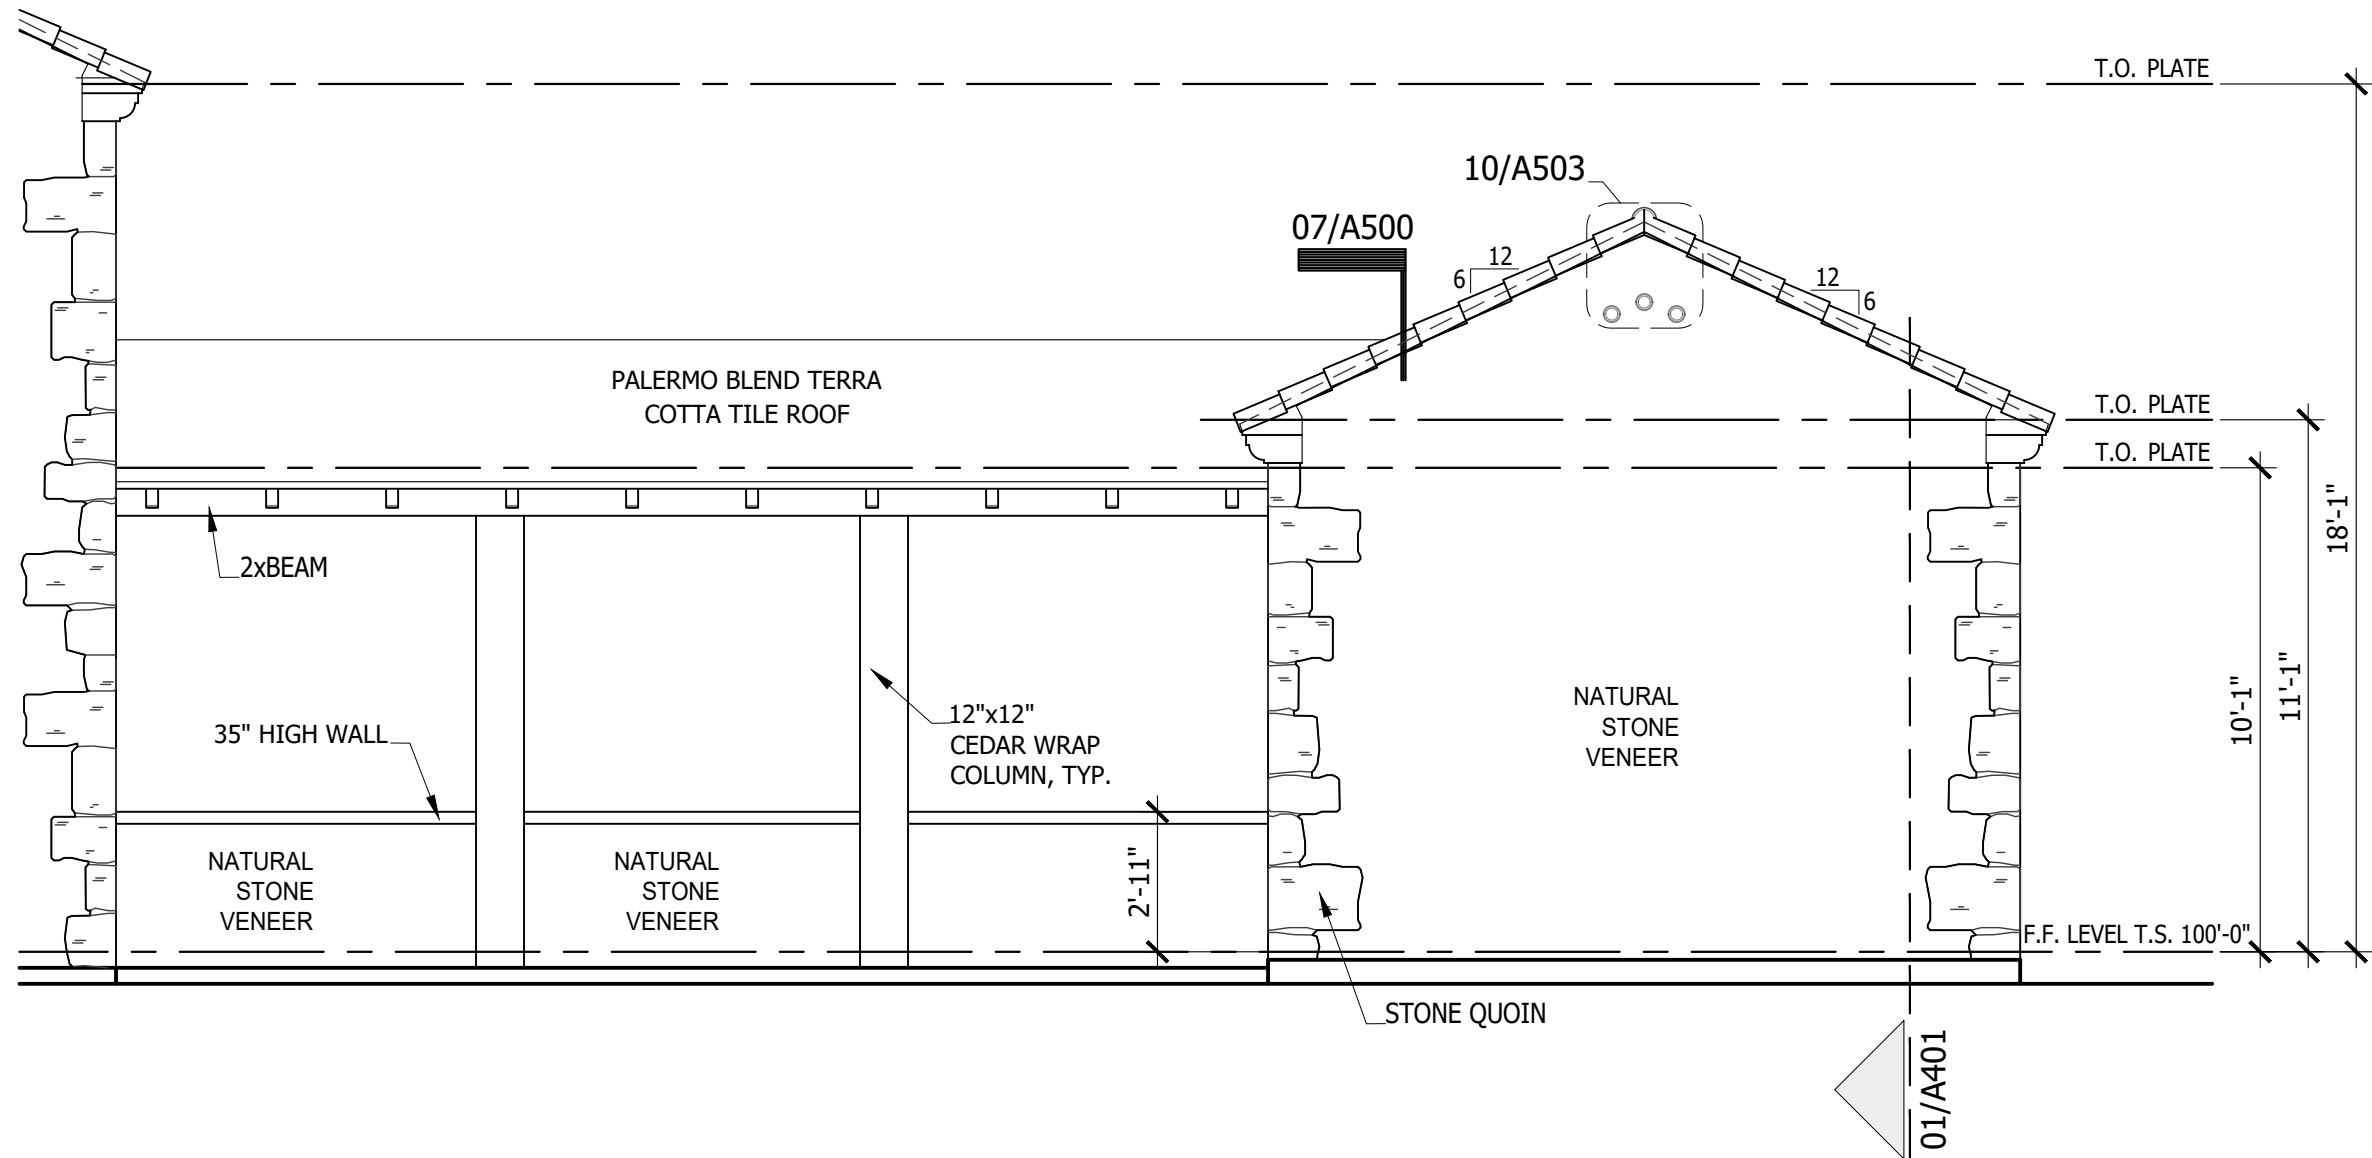

02

COURTYARD ELEVATION


A202

SCALE: 1/4"=1'-0"


ENTRADA

LOT 03, BLOCK H


TOWN OF WESTLAKE TARRANT COUNTY, TEXAS

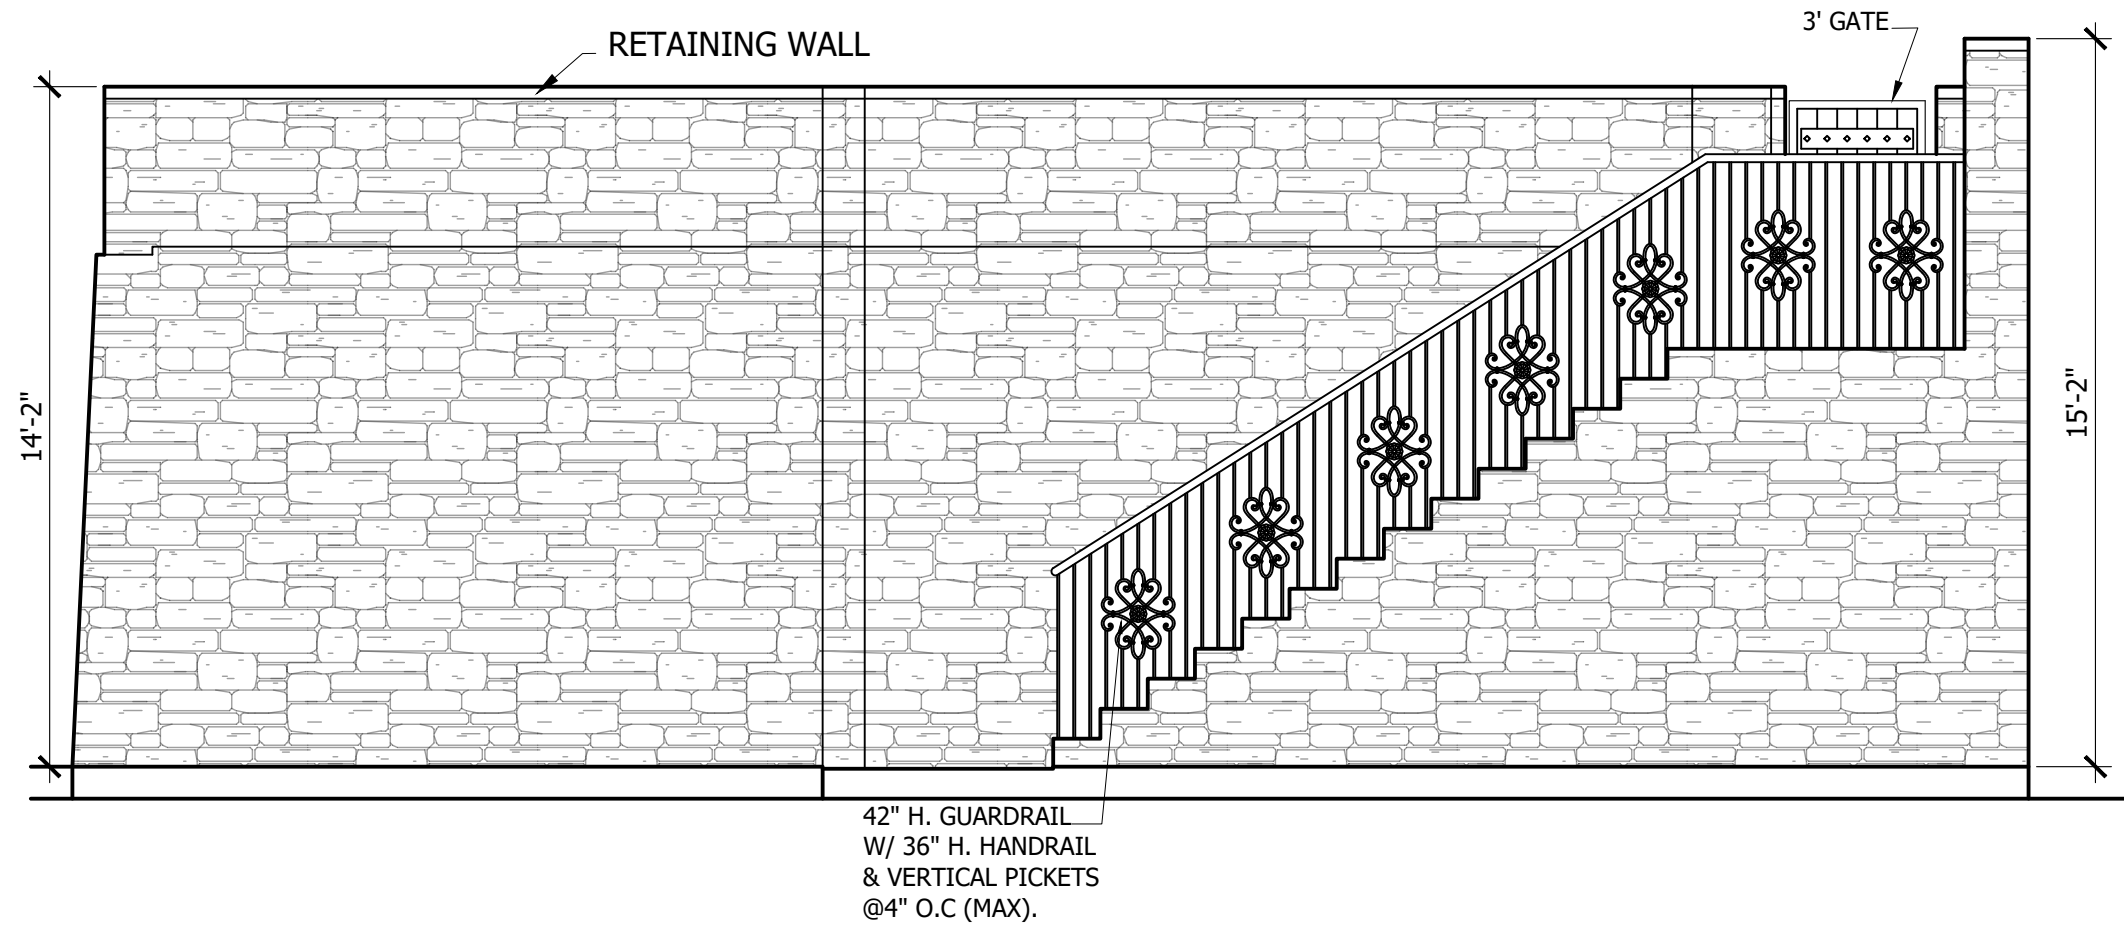


03
A203
RETAINING WALL SIDE ELEVATION
SCALE: 1/4"=1'-0"

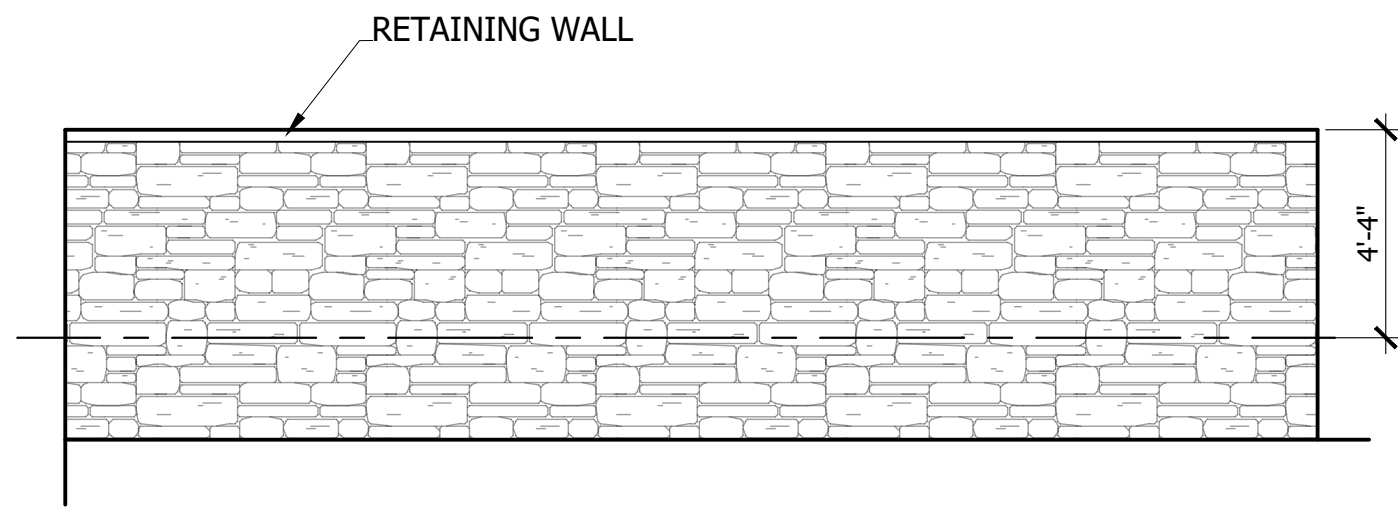

04
A203
RETAINING WALL SIDE ELEVATION
SCALE: 1/4"=1'-0"

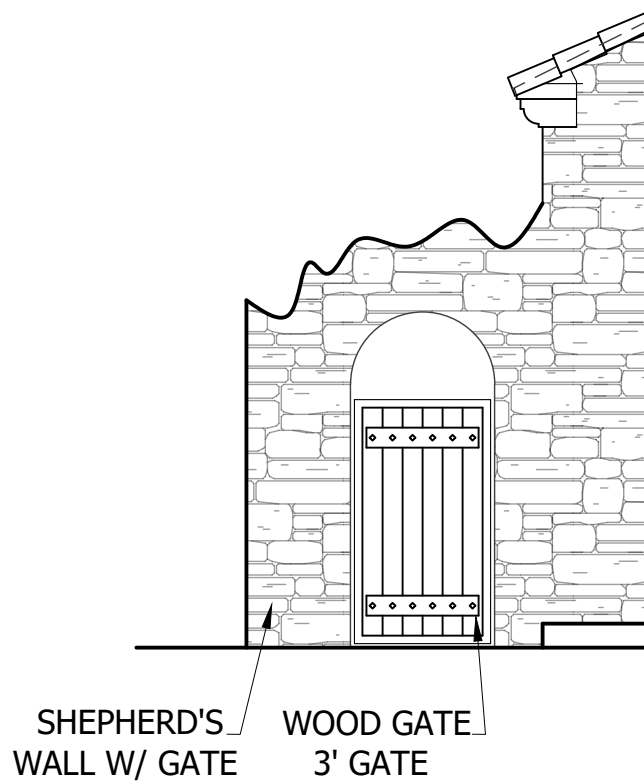

02
A203
SHEPHERD'S WALL FRONT ELEVATION
SCALE: 1/4"=1'-0"

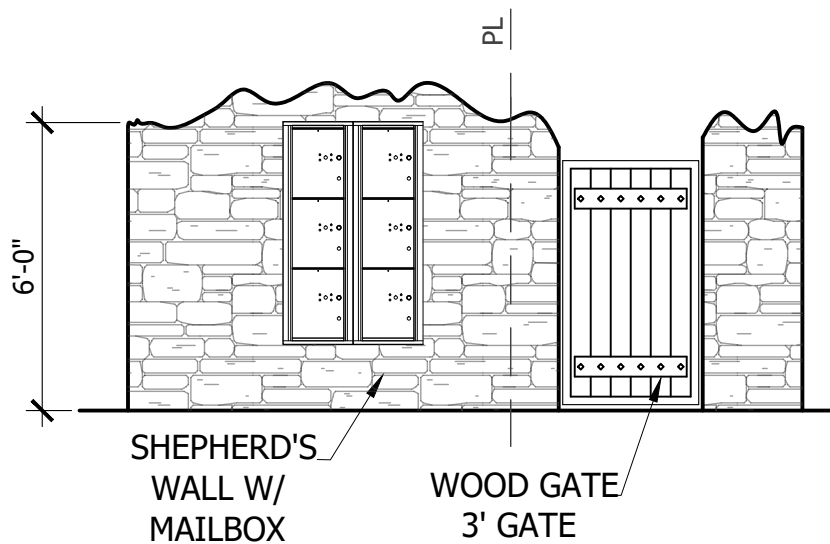

01
A203
SHEPHERD'S WALL FRONT ELEVATION
SCALE: 1/4"=1'-0"

ISSUE LOG

NO.	DESCRIPTION	DATE

PROJECT NO:	21-131
ISSUED FOR:	OTP
DRAWN BY:	Checker
DATE:	06/24/21

SHEPHERD'S WALL ELEVATIONS

A203

ENTRADA

LOT 03, BLOCK H

TOWN OF WESTLAKE TARRANT COUNTY, TEXAS


ISSUE LOG

NO.	DESCRIPTION	DATE

PROJECT NO: 21-131
ISSUED FOR: OTP
DRAWN BY: Checker
DATE: 06/24/21


WALL SECTIONS

A401

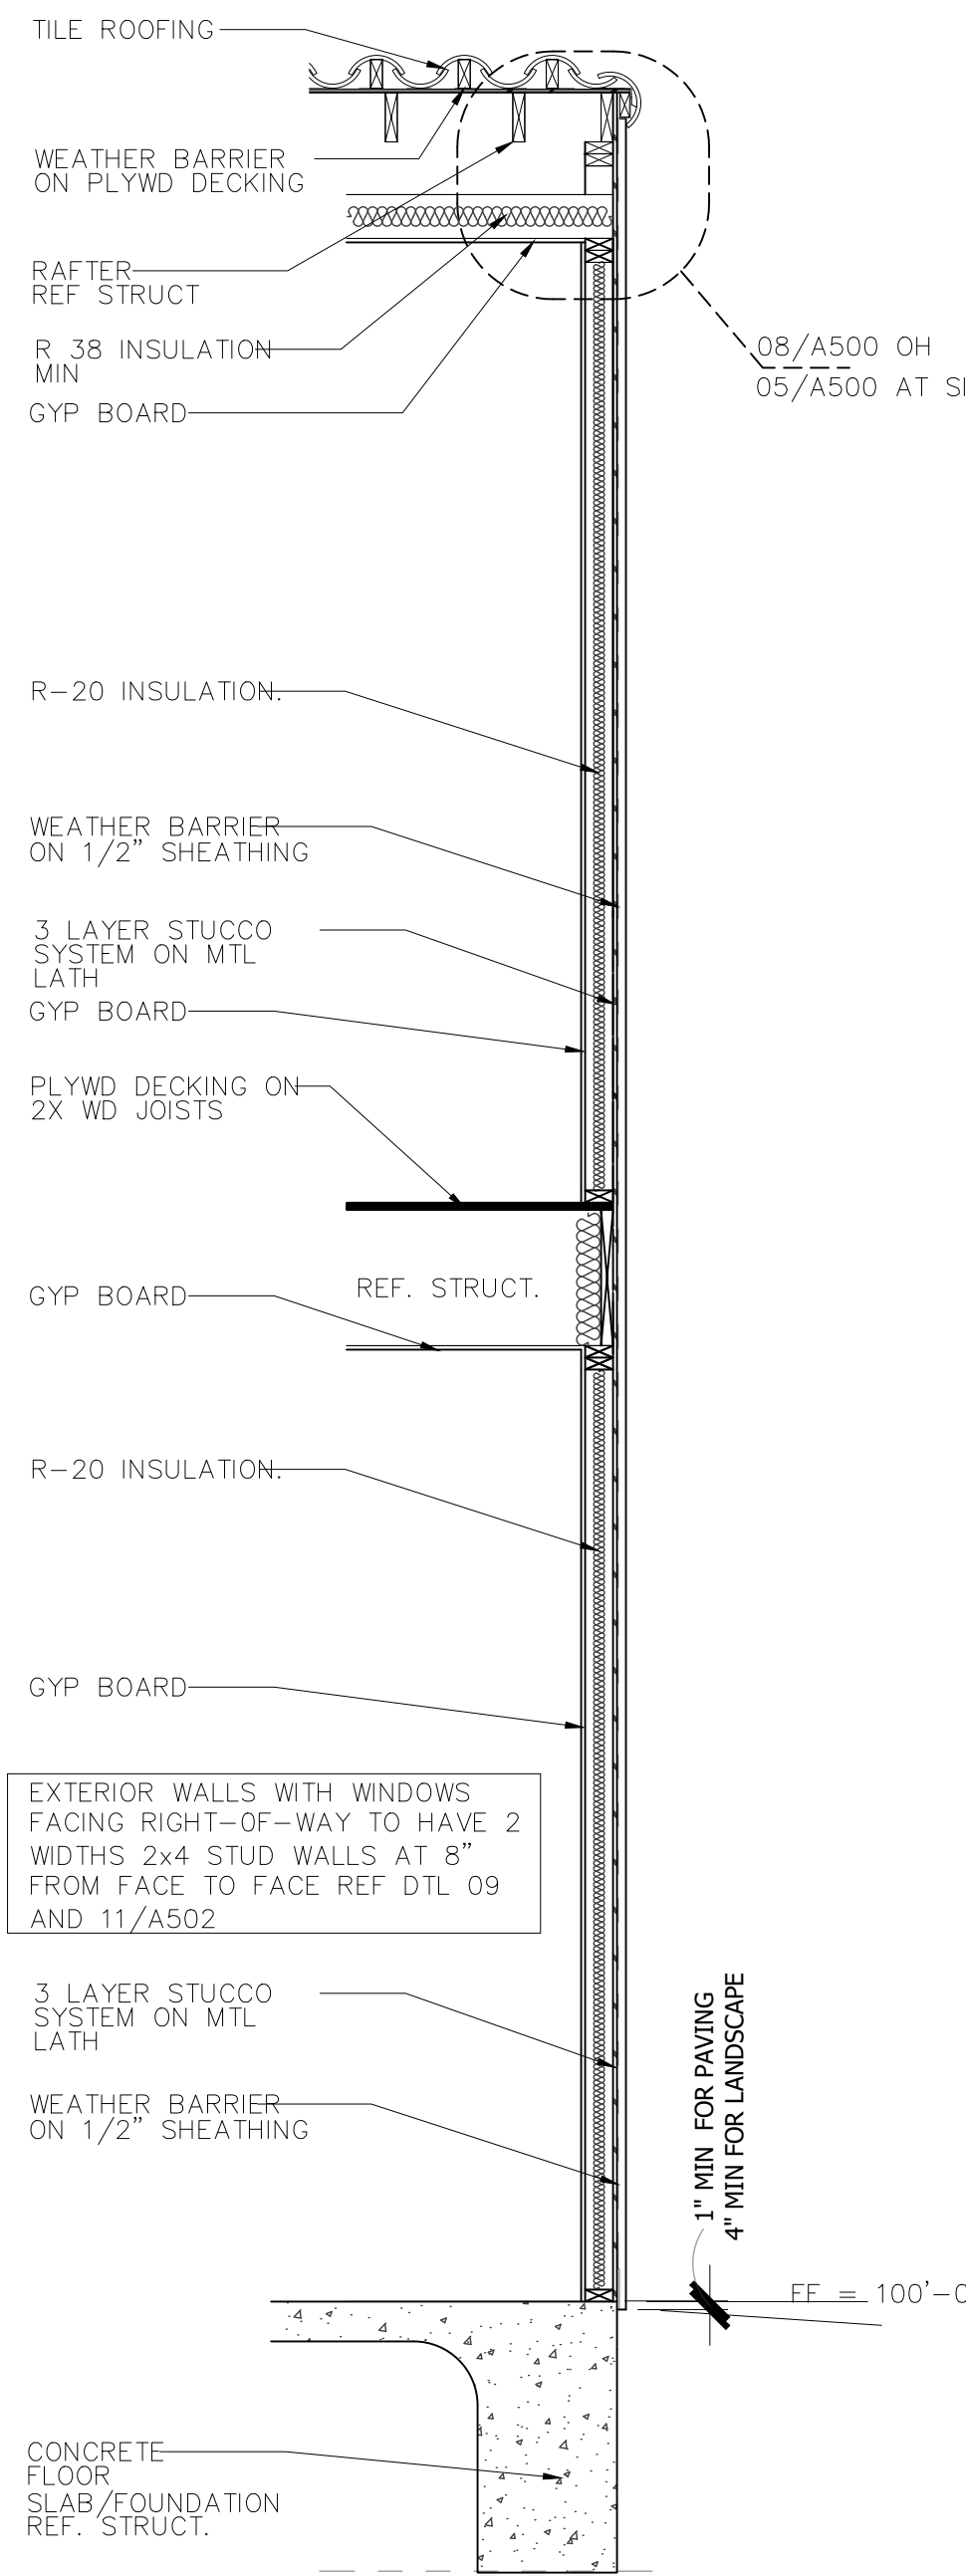


02 WALL SECTION

SCALE: 1/2" = 1'-0"

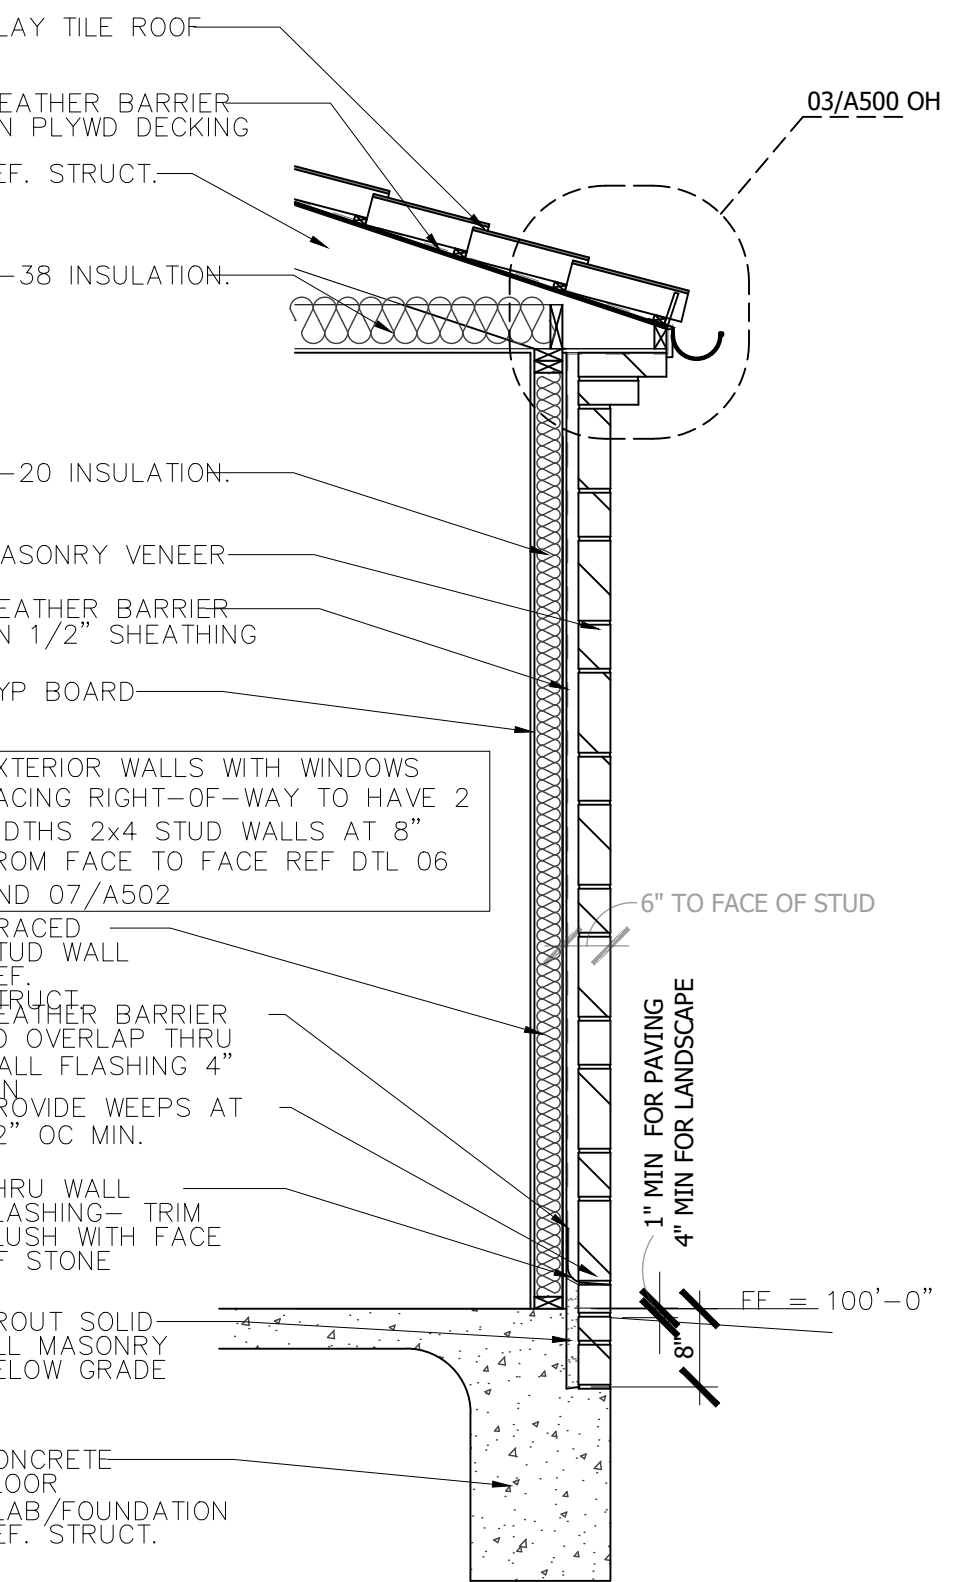


01 WALL SECTION

SCALE: 1/2" = 1'-0"

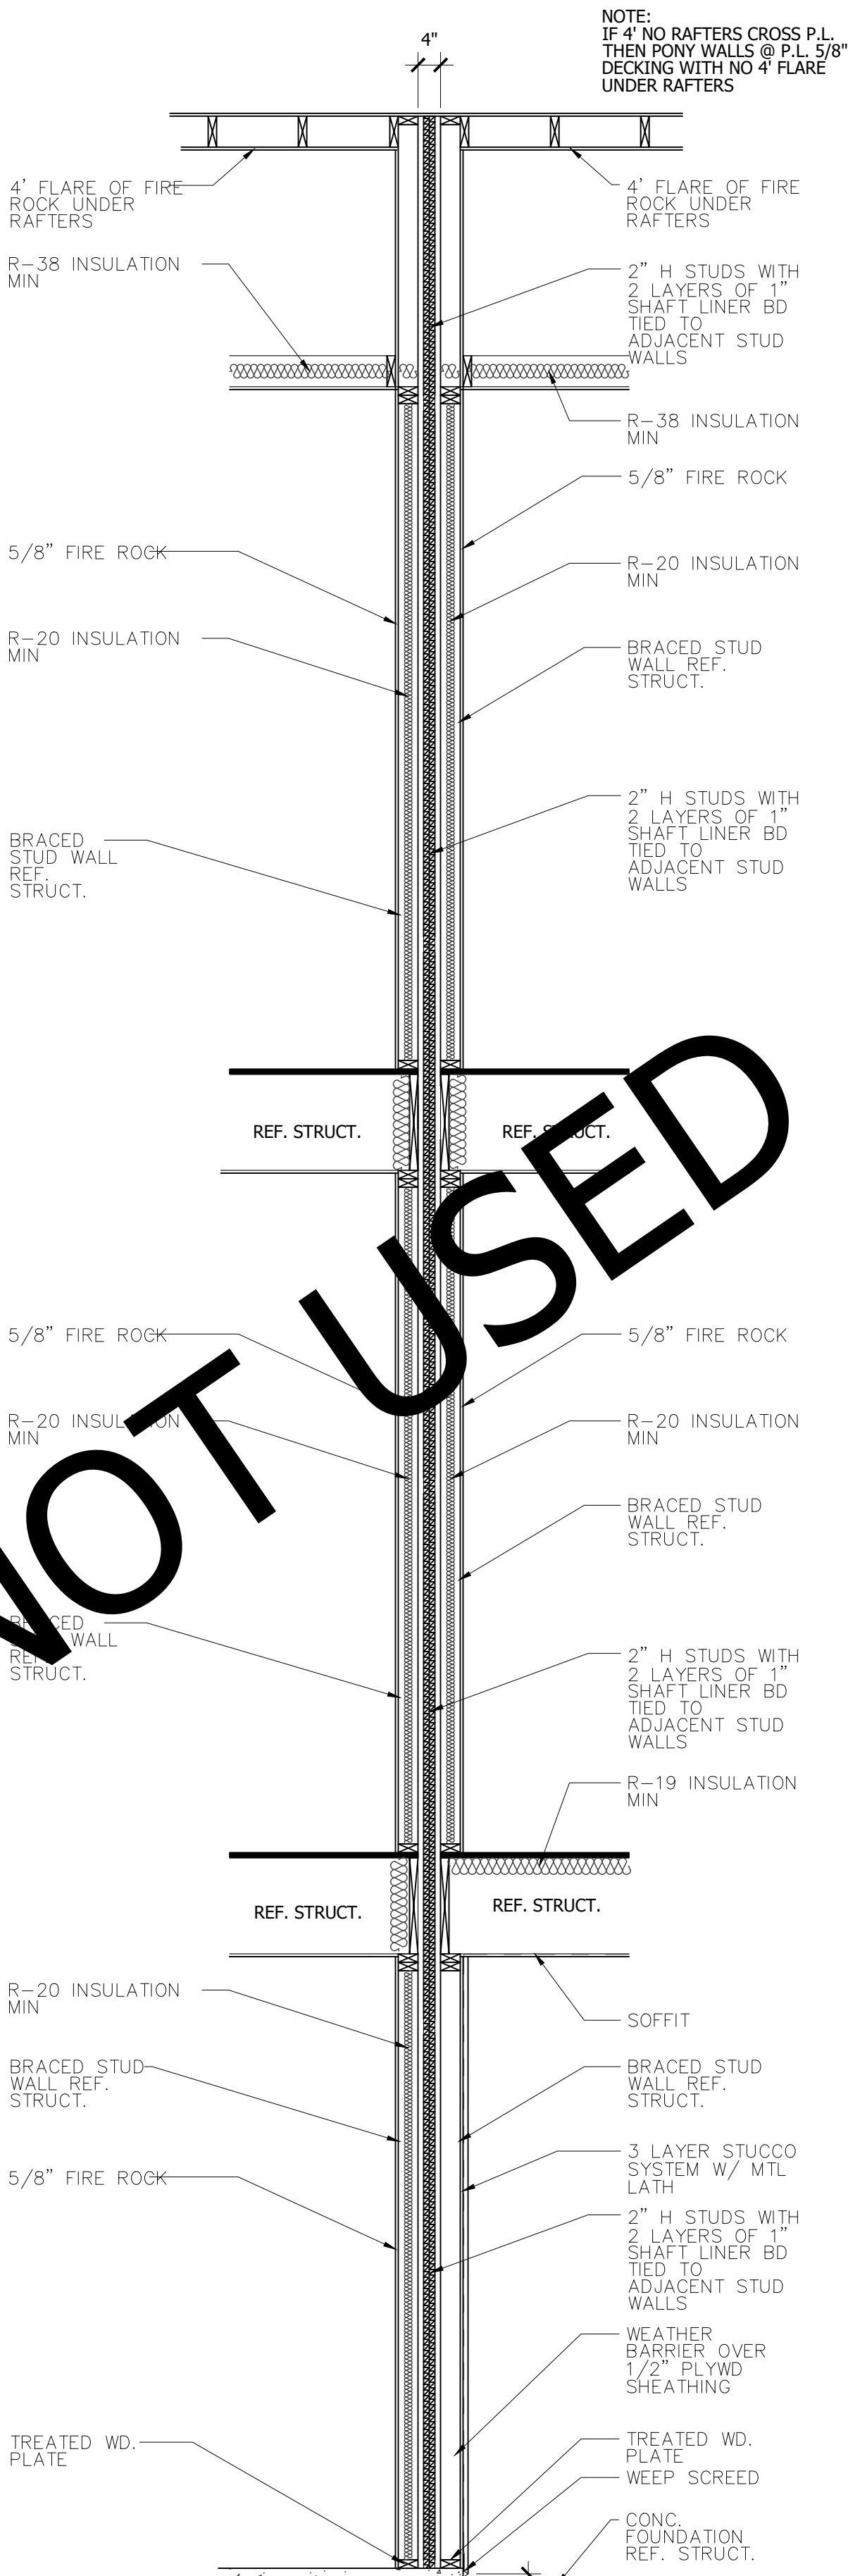


03 WALL SECTION

SCALE: 1/2" = 1'-0"

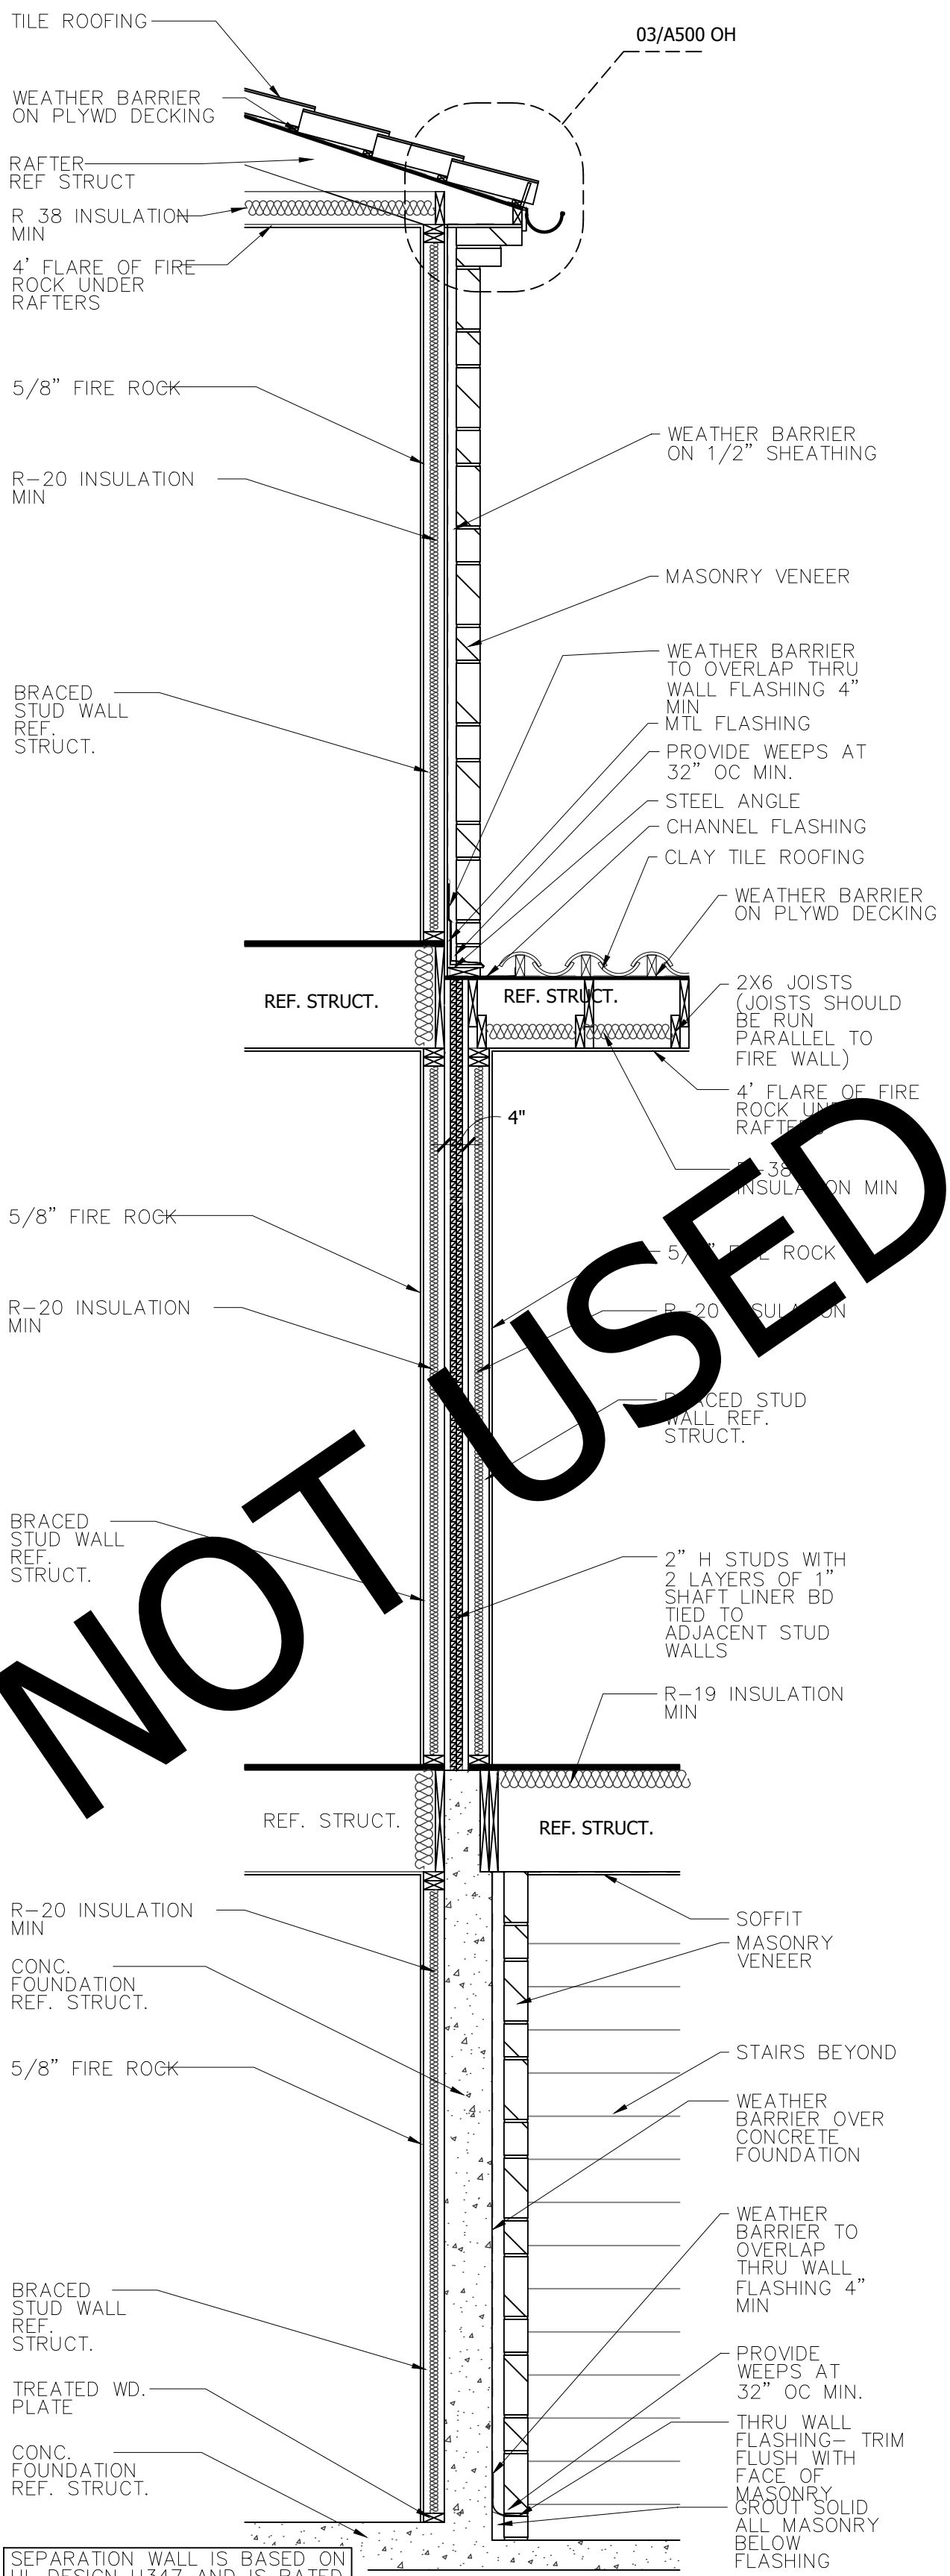


04 WALL SECTION

SCALE: 1/2" = 1'-0"

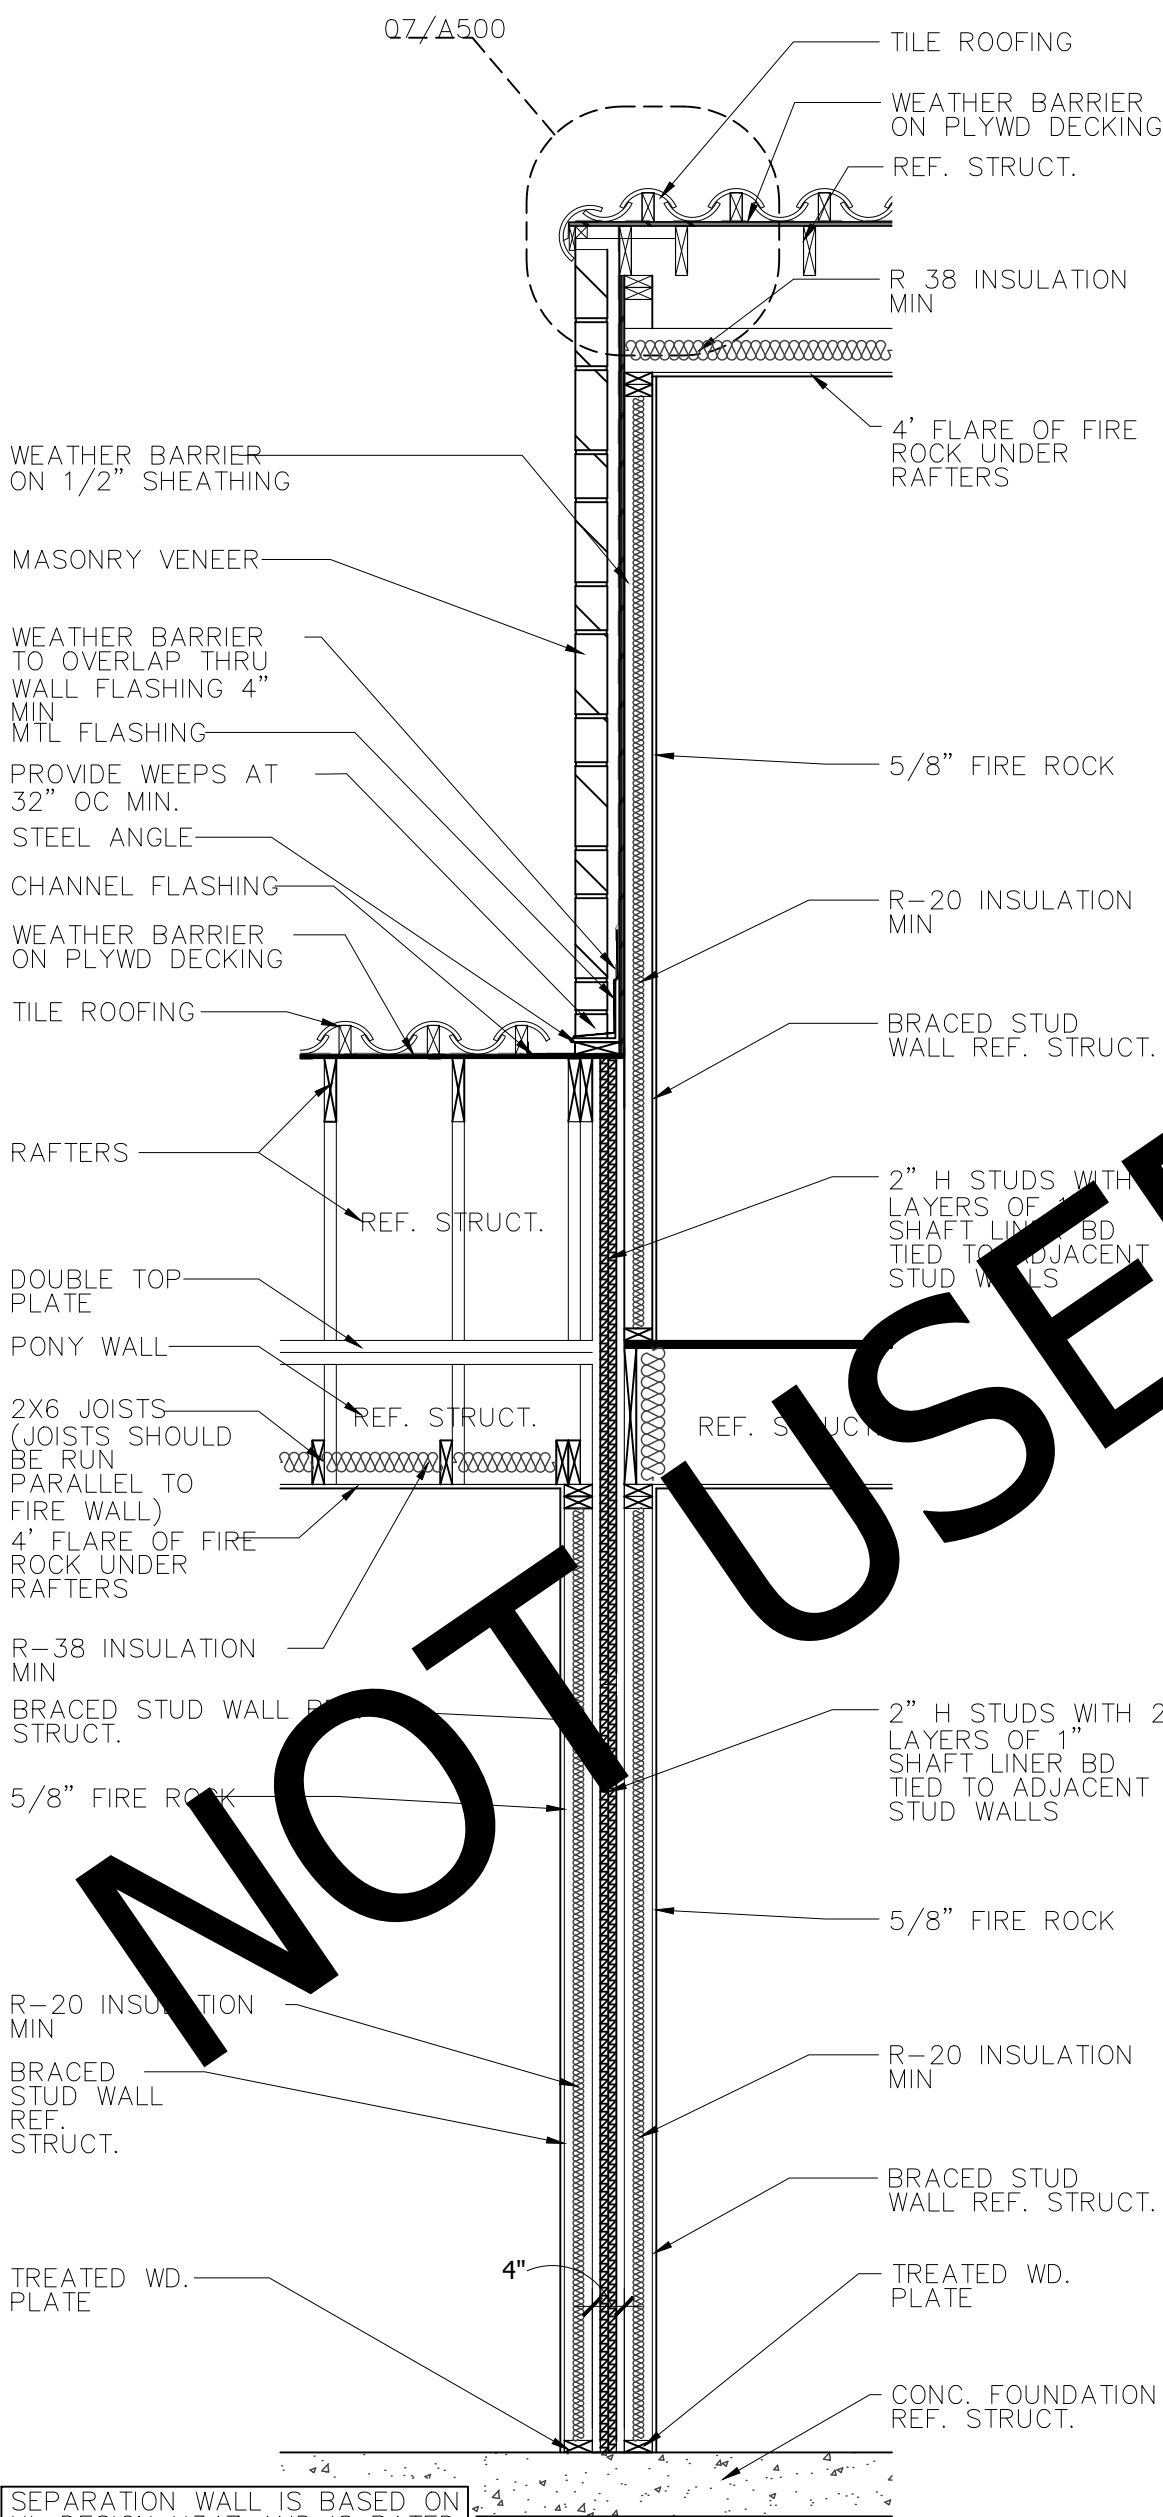

06 WALL SECTION

SCALE: 1/2" = 1'-0"

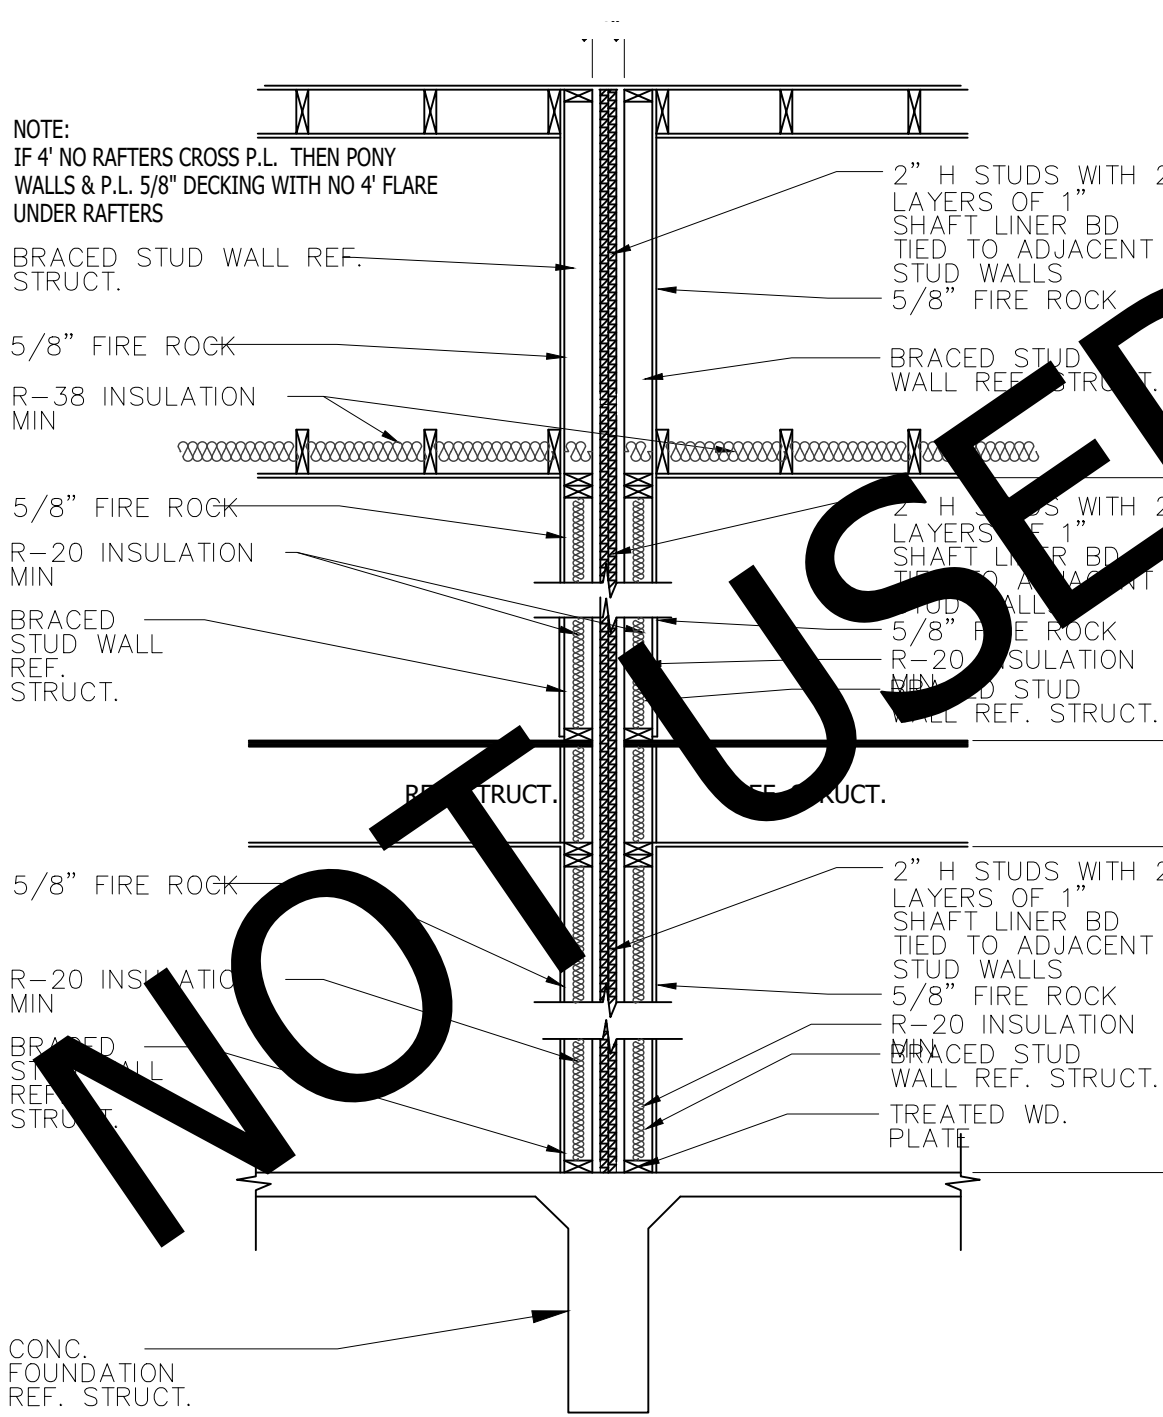


05 FIRE WALL DETAIL

SCALE: 1/2" = 1'-0"

ENTRADA

LOT 03, BLOCK H

TOWN OF WESTLAKE TARRANT COUNTY, TEXAS

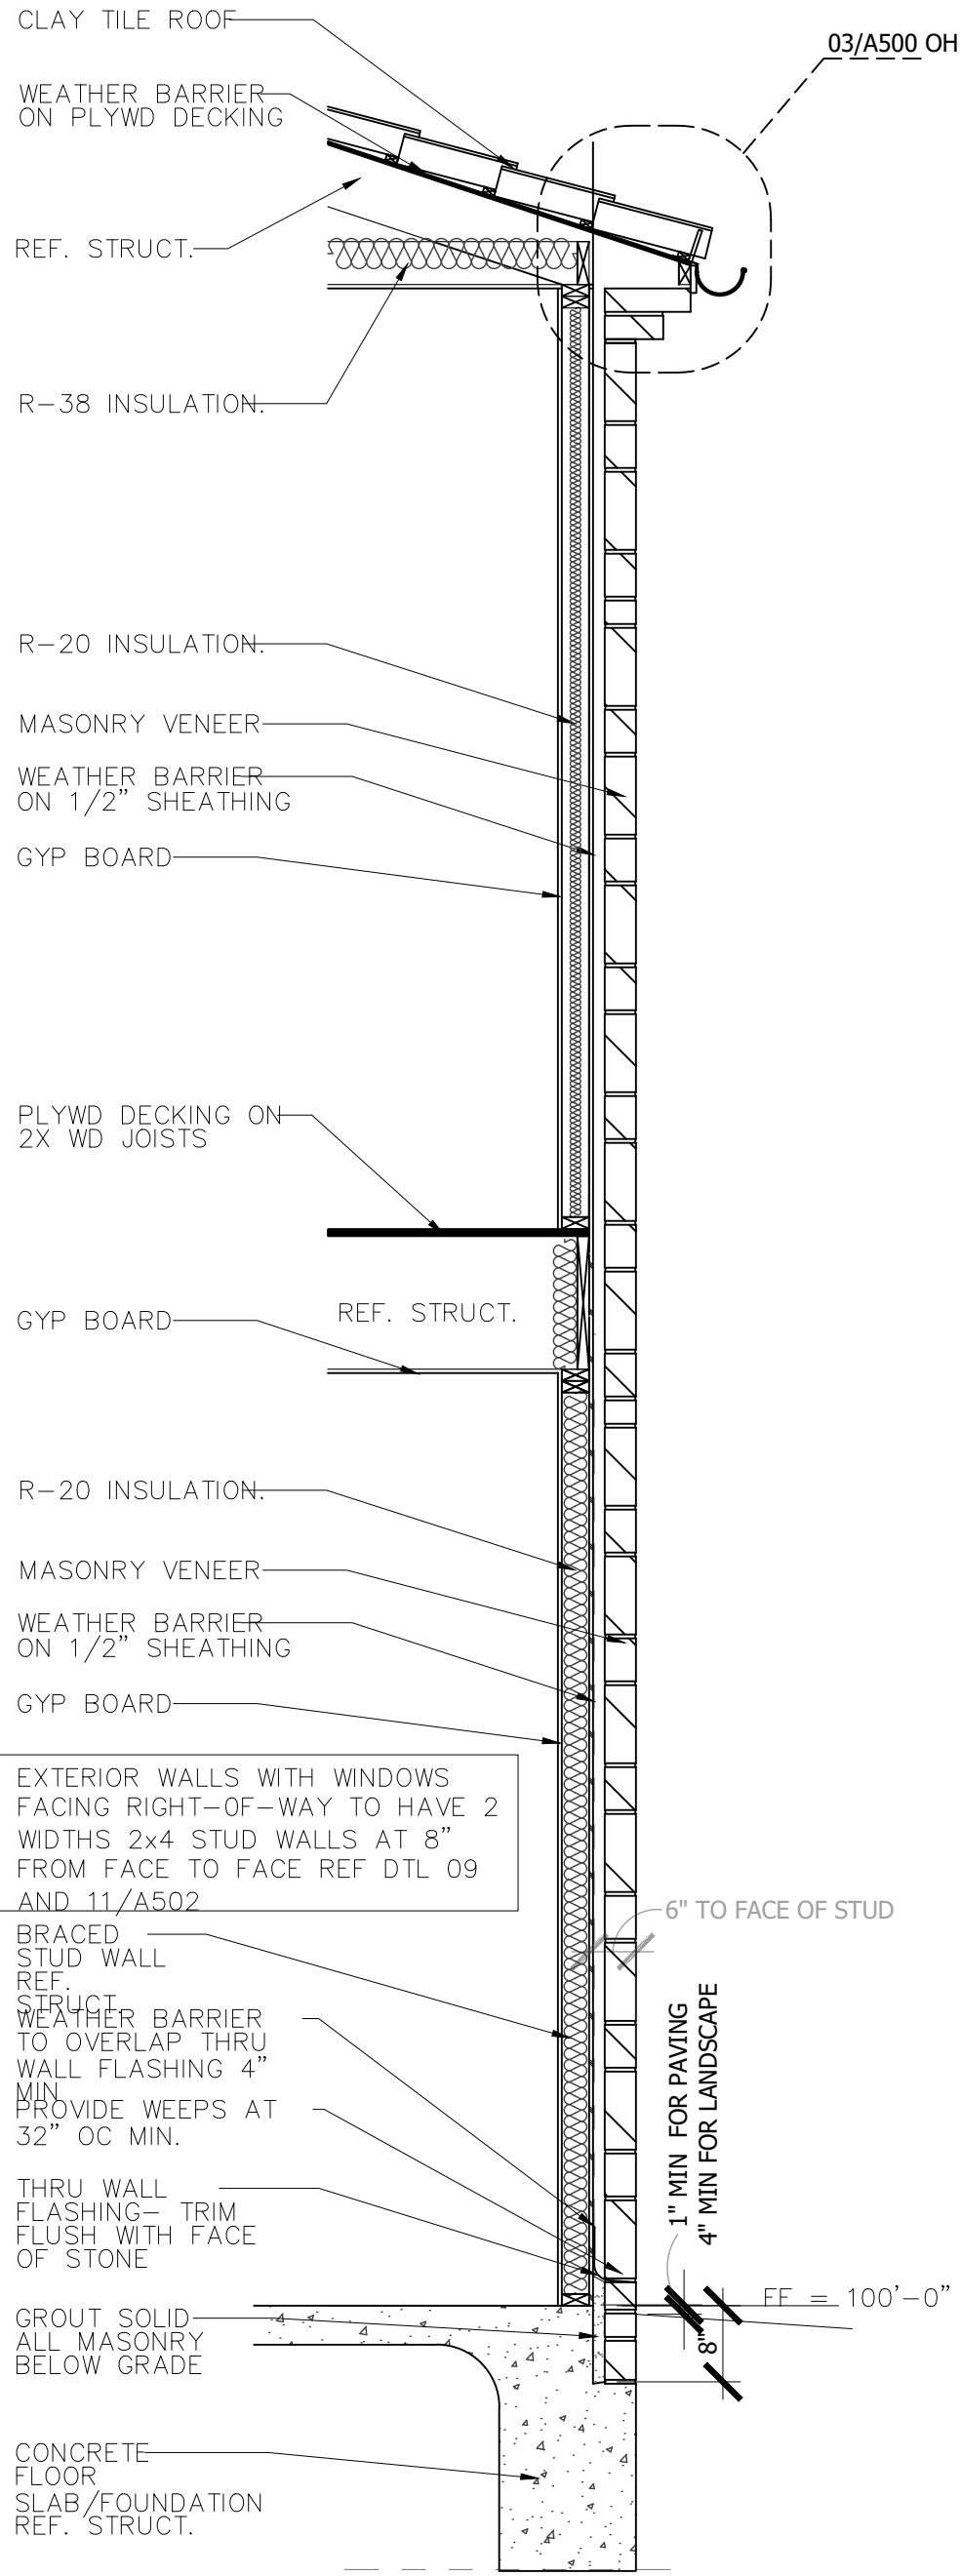

01 WALL SECTION


SCALE: 1/2" = 1'-0"

REFER TO **ENTRADA DESIGN GUIDELINES** FOR FUTHER DETAILED INFORMATION REGARDING THESE PLANS


ENTRADA

LOT 03, BLOCK H


TOWN OF WESTLAKE TARRANT COUNTY, TEXAS

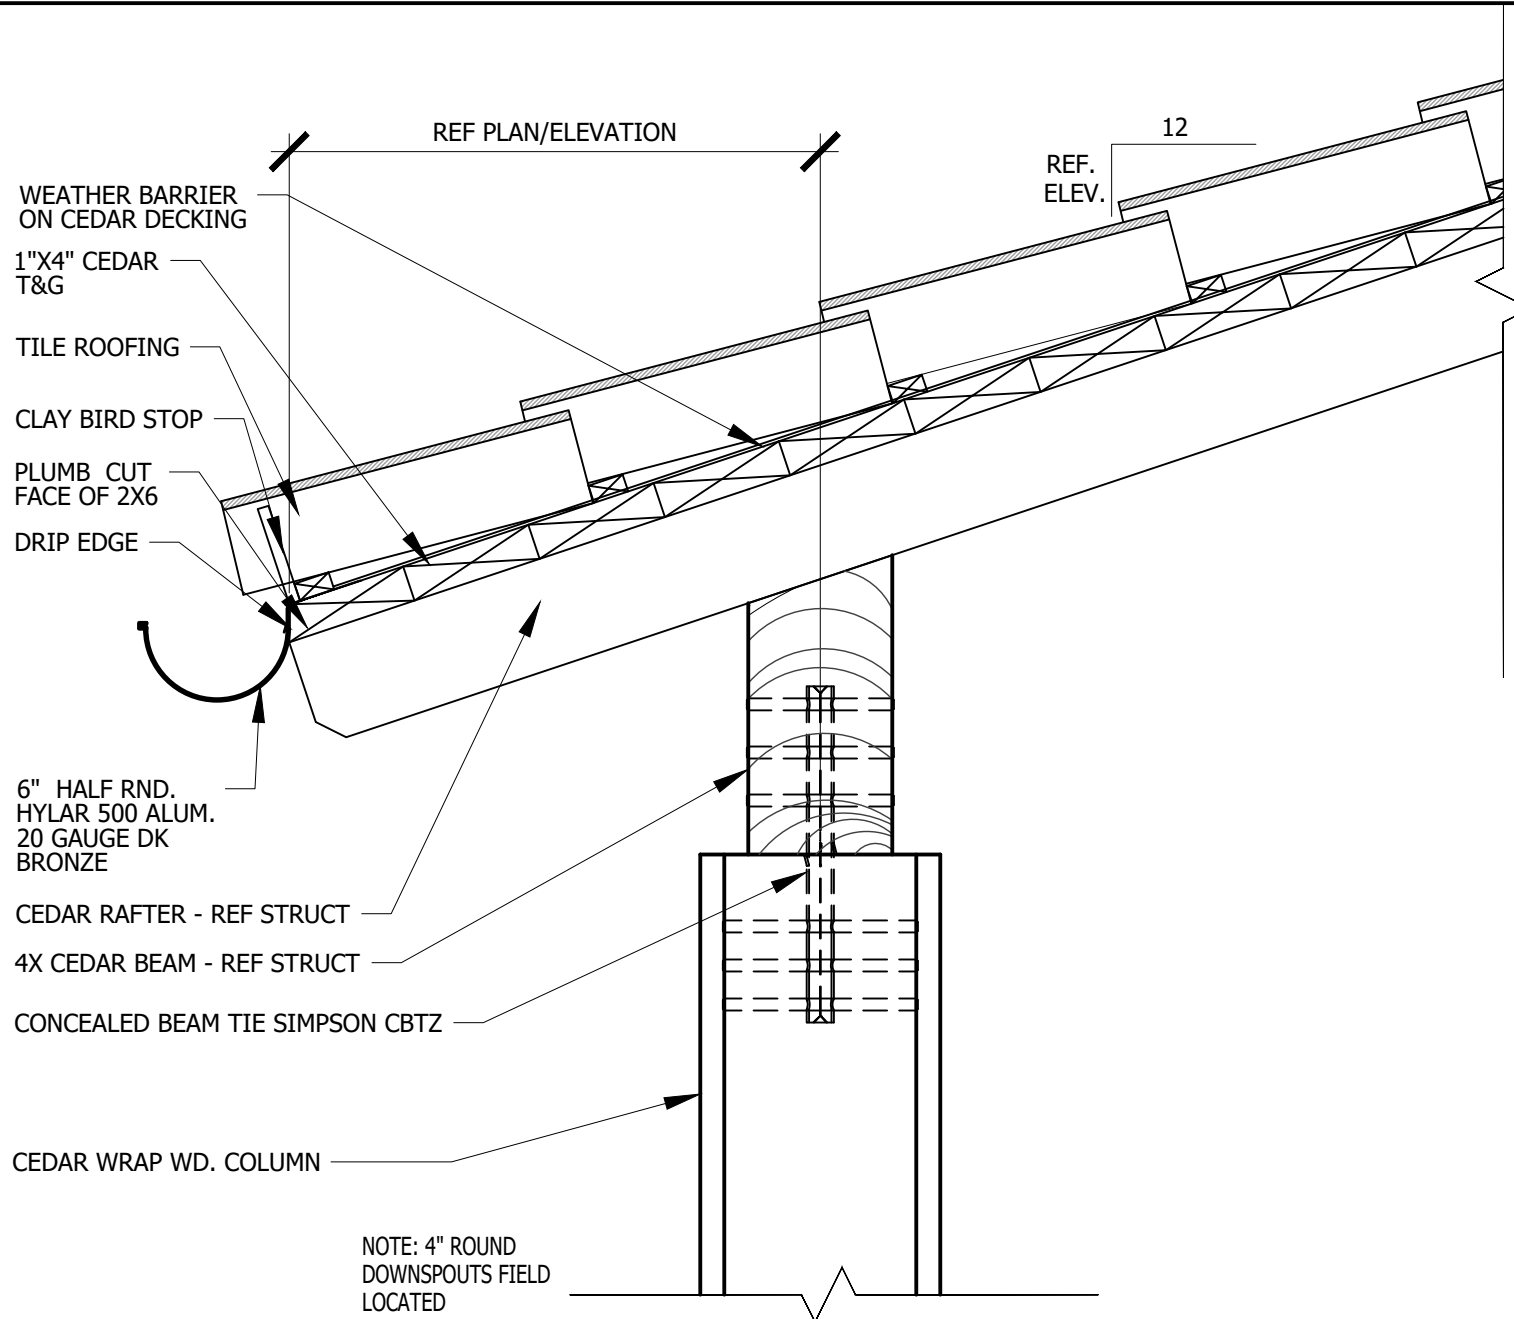


11 COVERED PORCH DETAIL
SCALE: 1 1/2" = 1'-0"

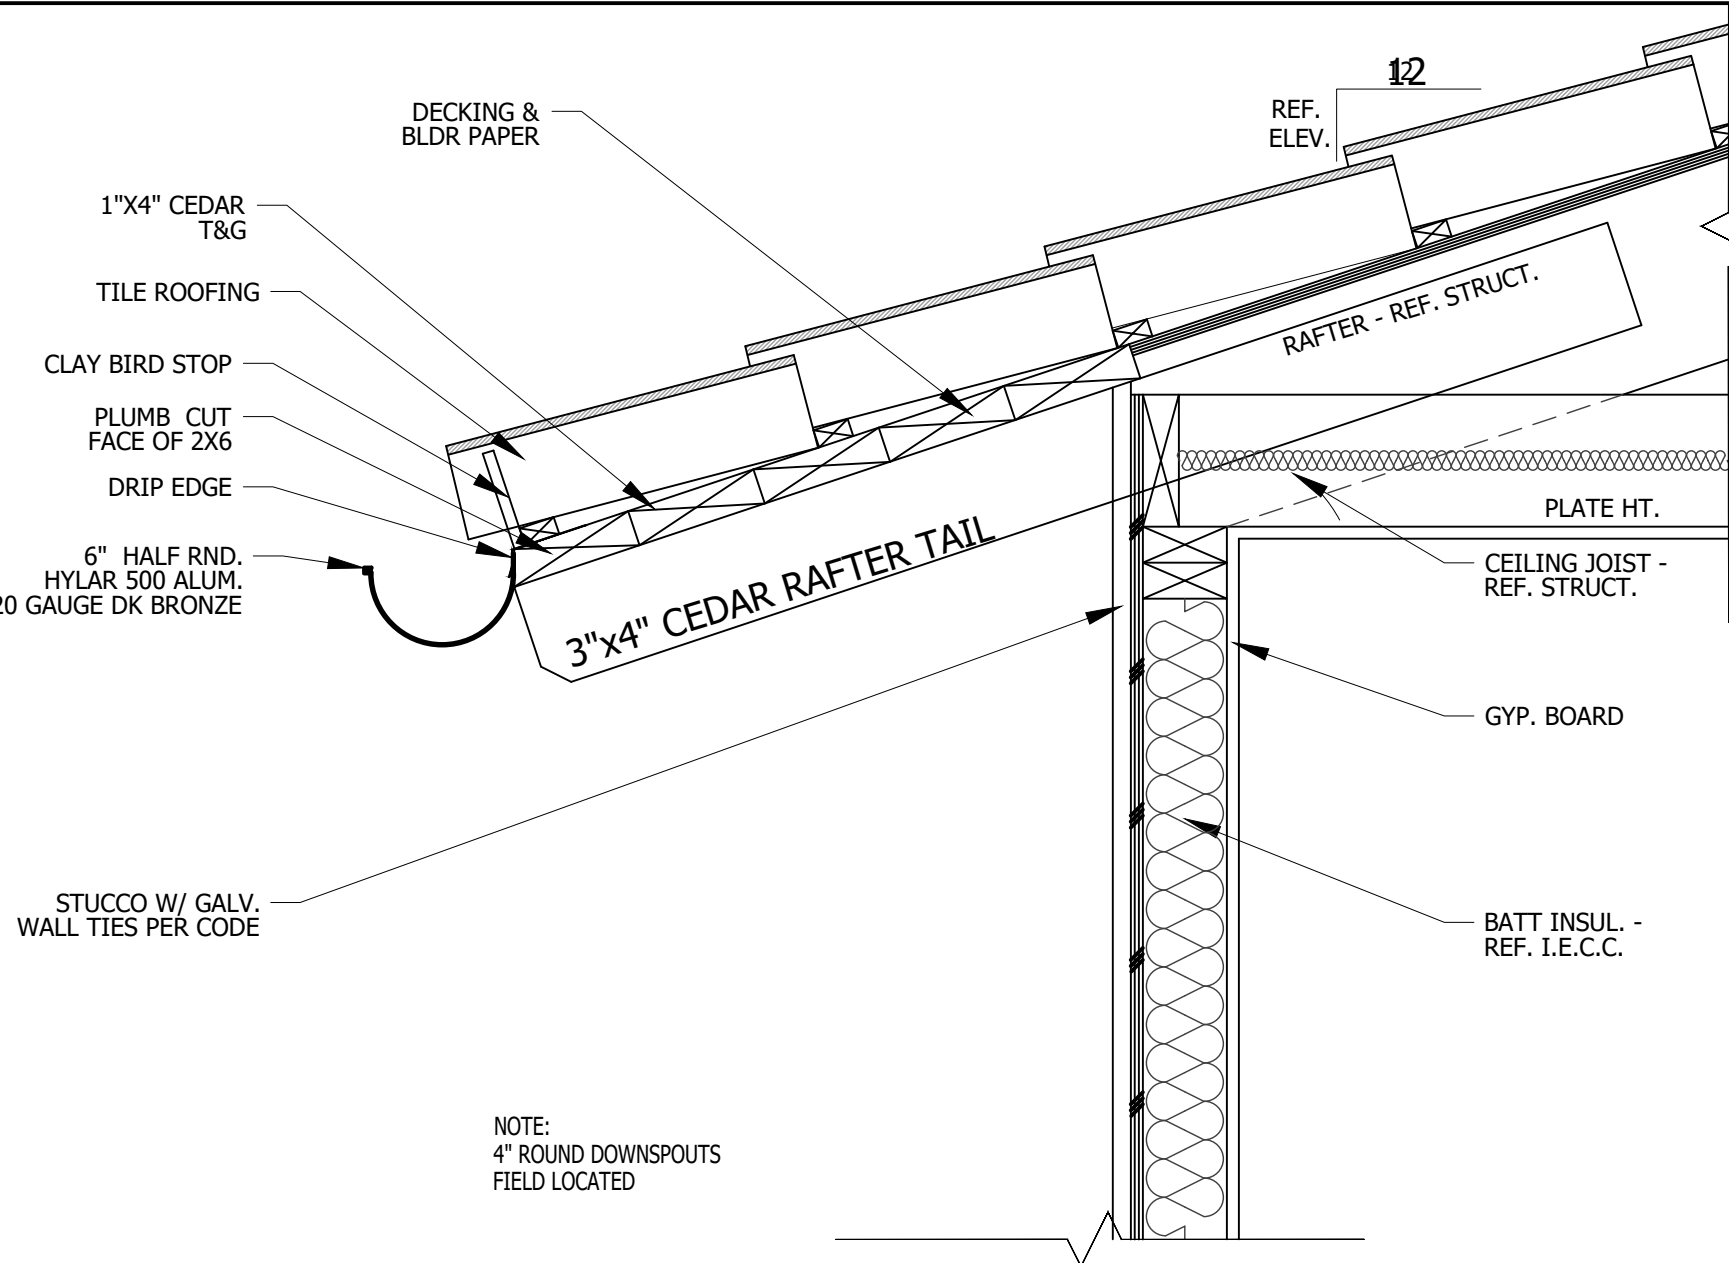


10 FASCIA DETAIL
SCALE: 1 1/2" = 1'-0"

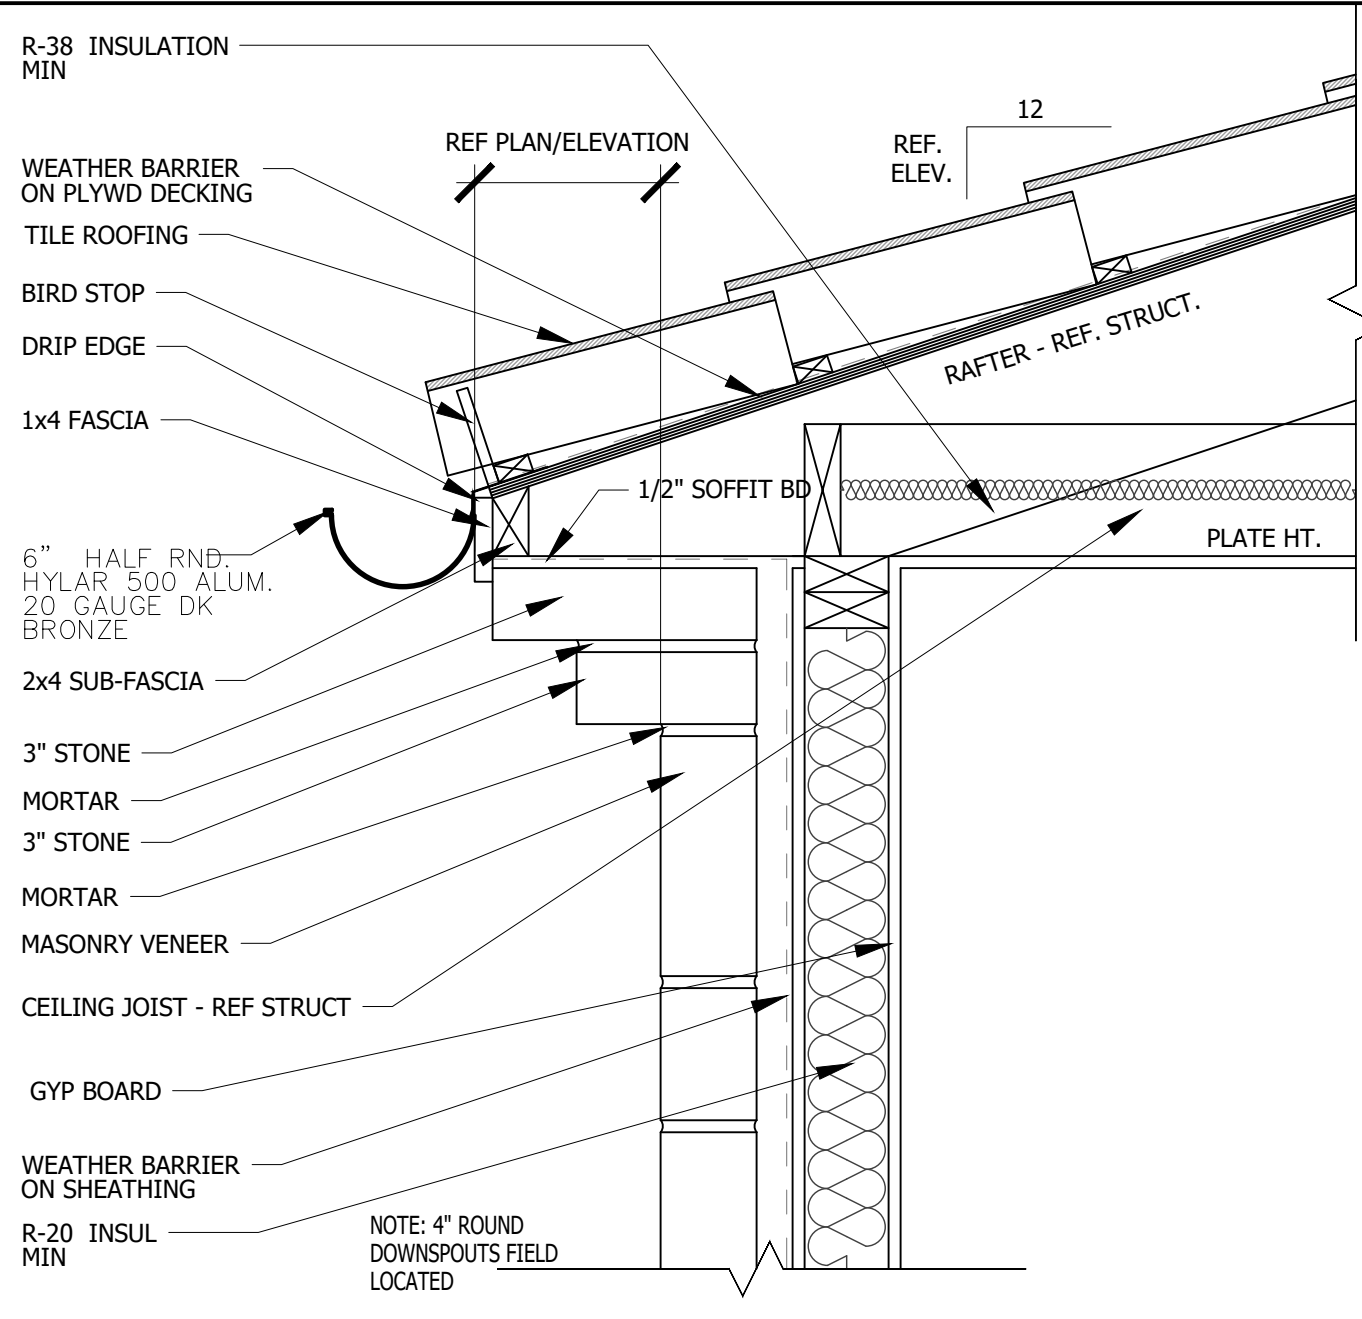


03 FASCIA DETAIL
SCALE: 1 1/2" = 1'-0"

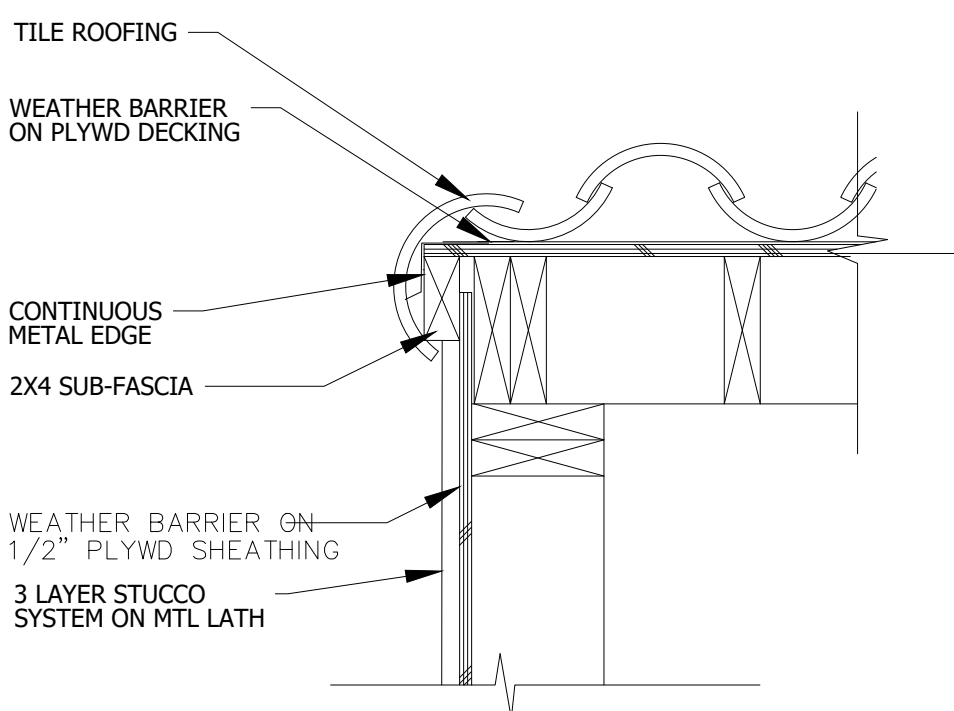


08 STUCCO RAKE DETAIL
SCALE: 1 1/2" = 1'-0"

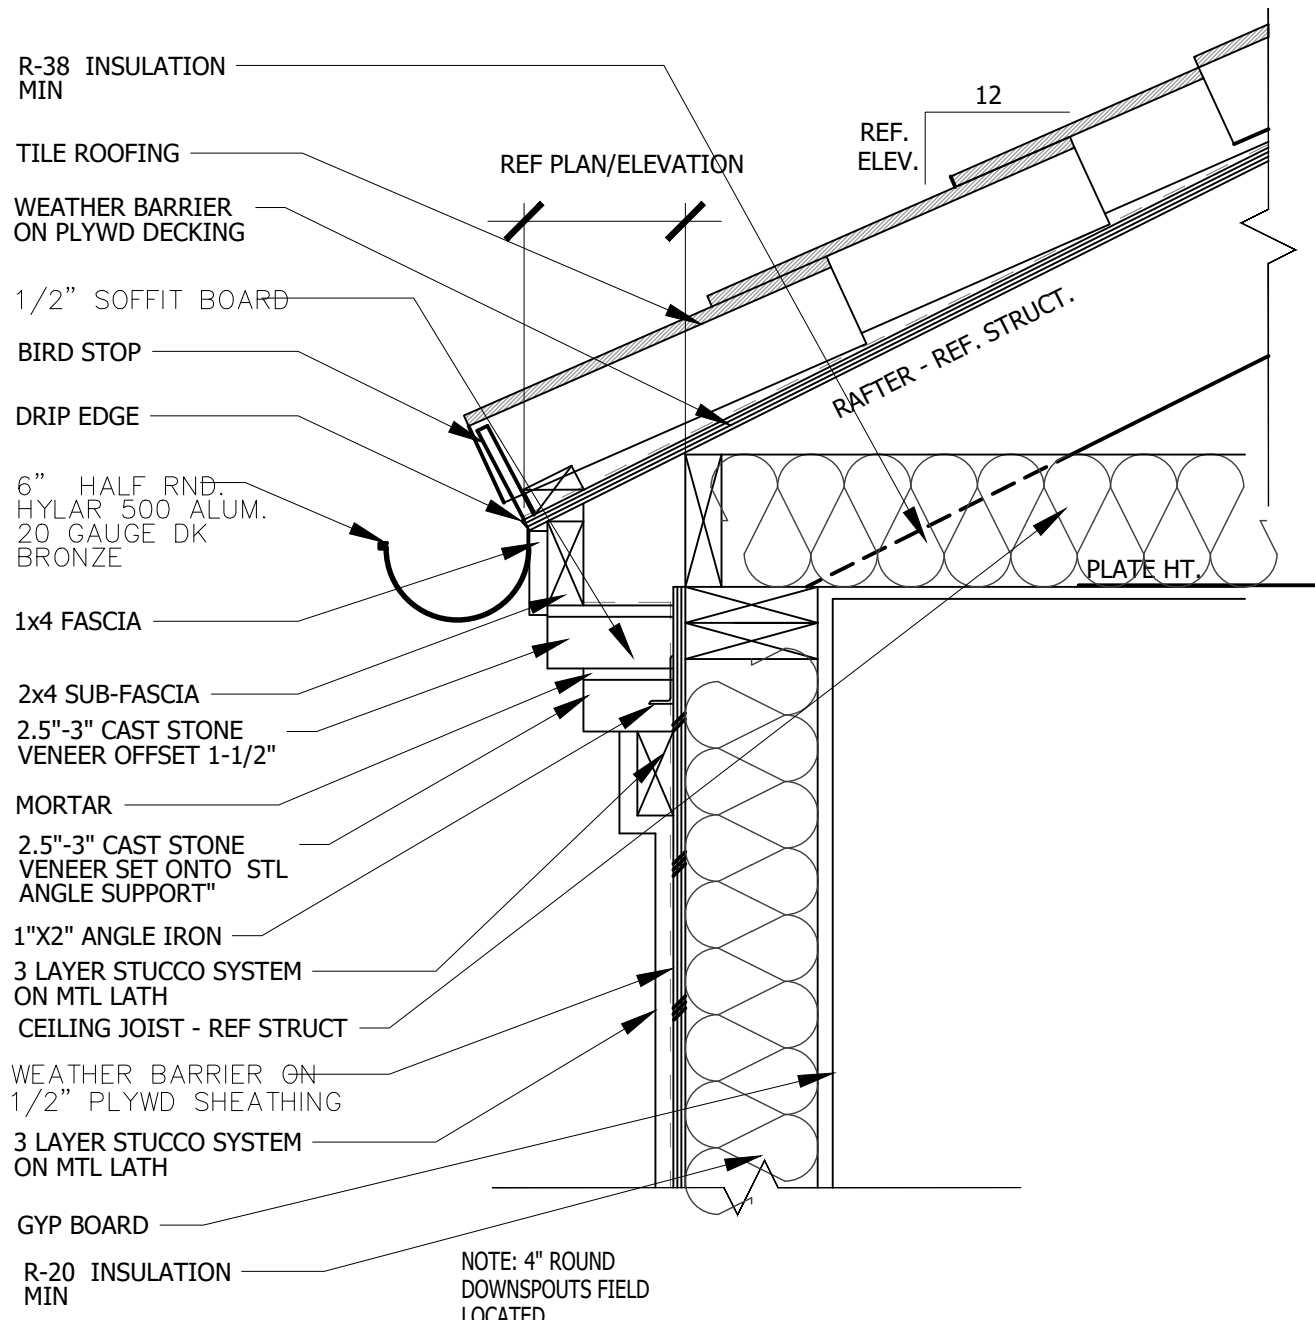


05 FASCIA DETAIL
SCALE: 1 1/2" = 1'-0"

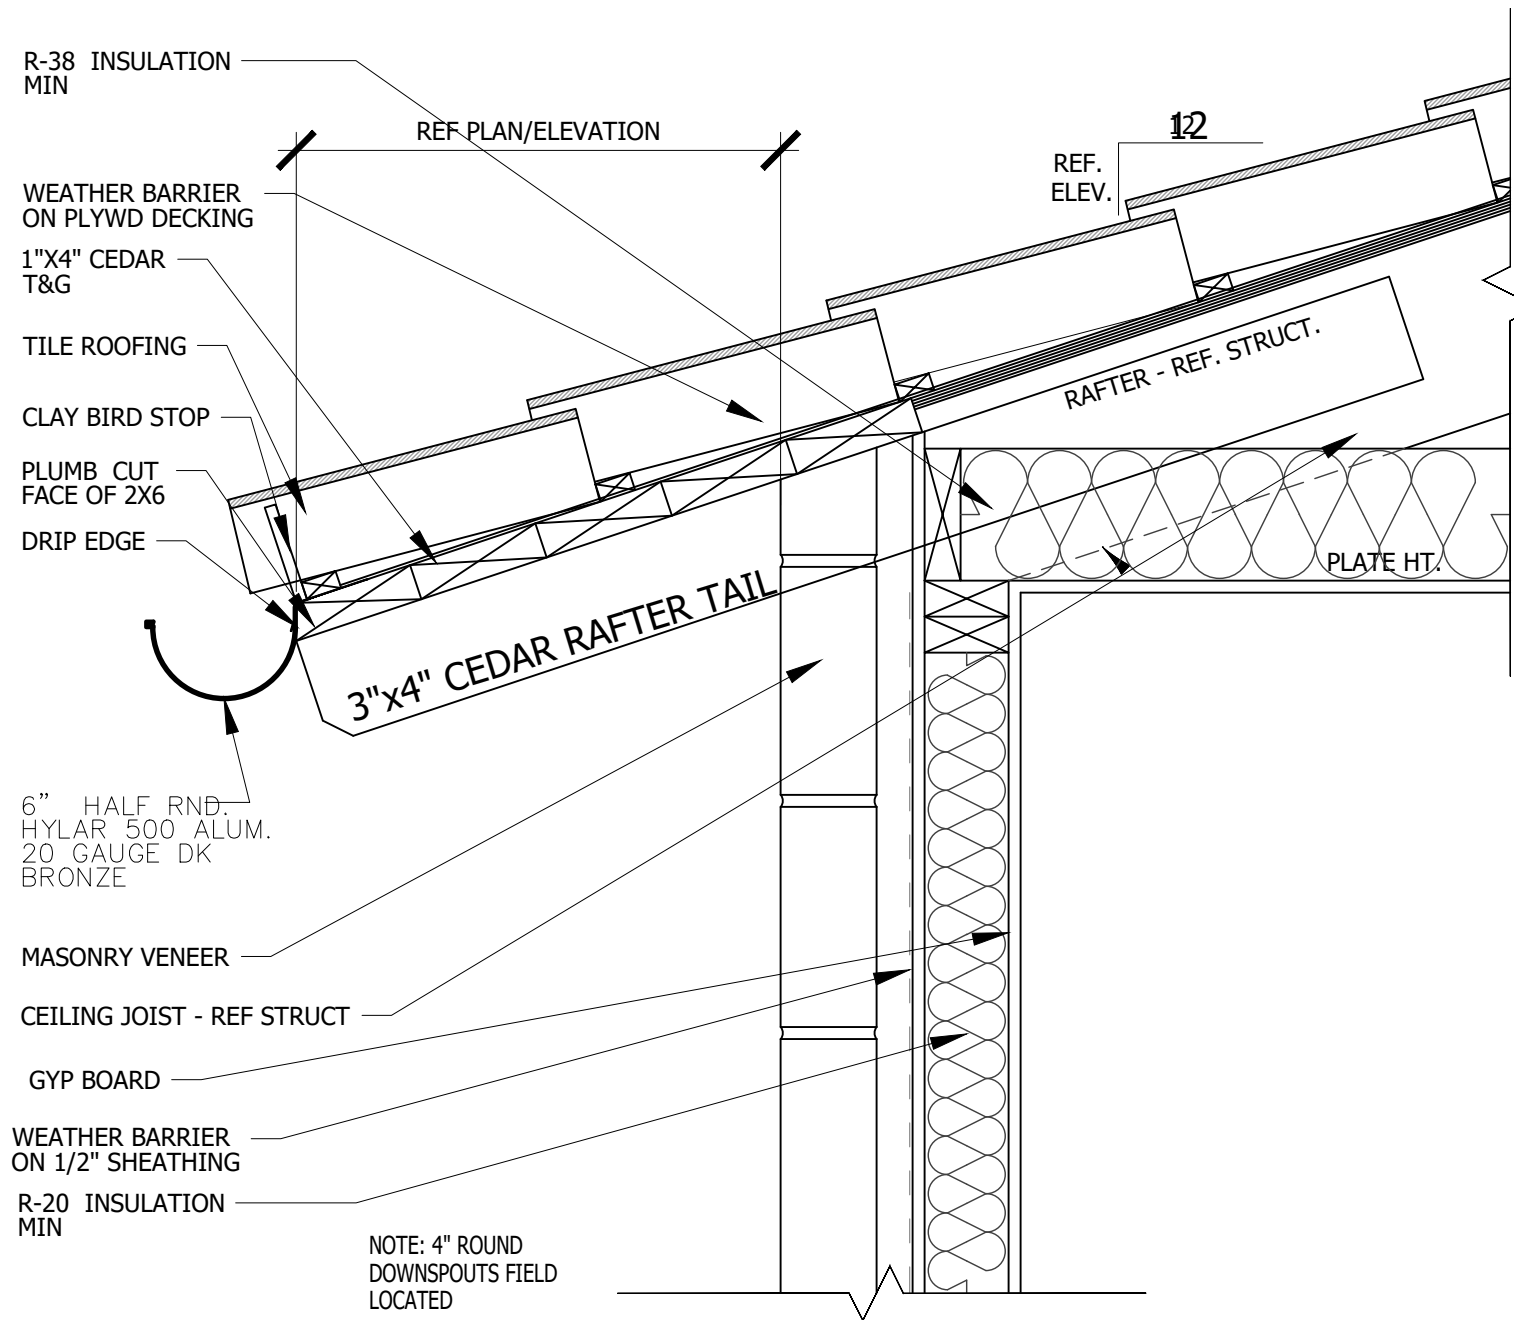


02 FASCIA DETAIL
SCALE: 1 1/2" = 1'-0"

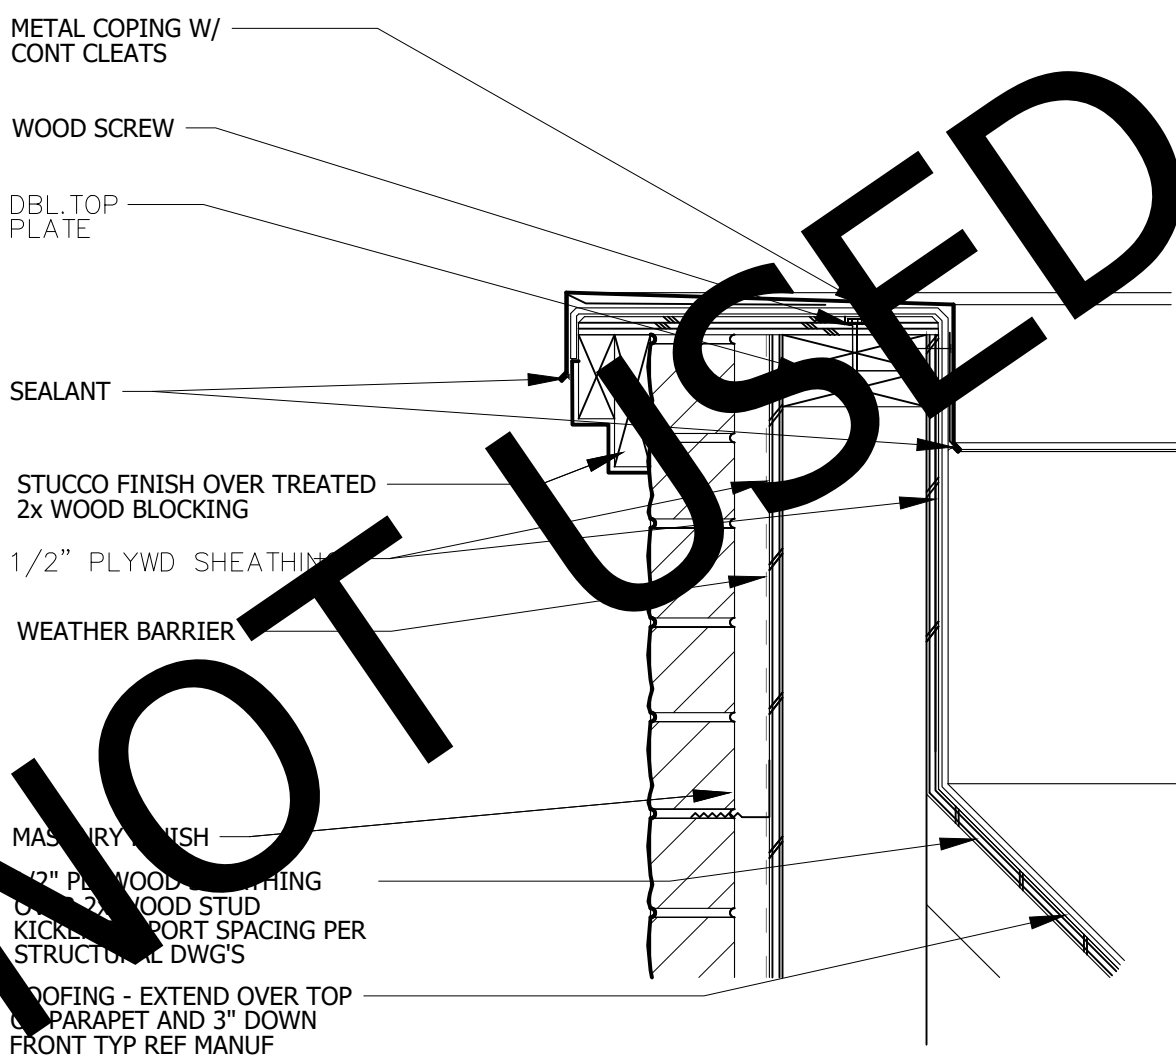


09 PARAPET DETAIL
SCALE: 1-1/2" = 1'-0"

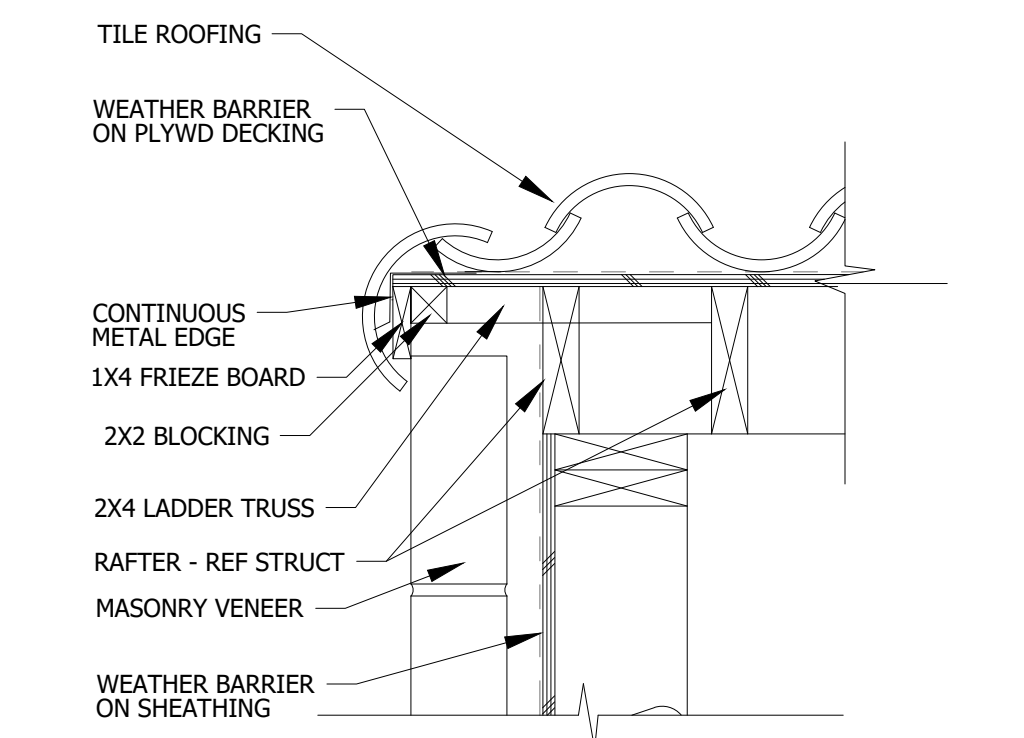


07 STONE RAKE DETAIL
SCALE: 1 1/2" = 1'-0"

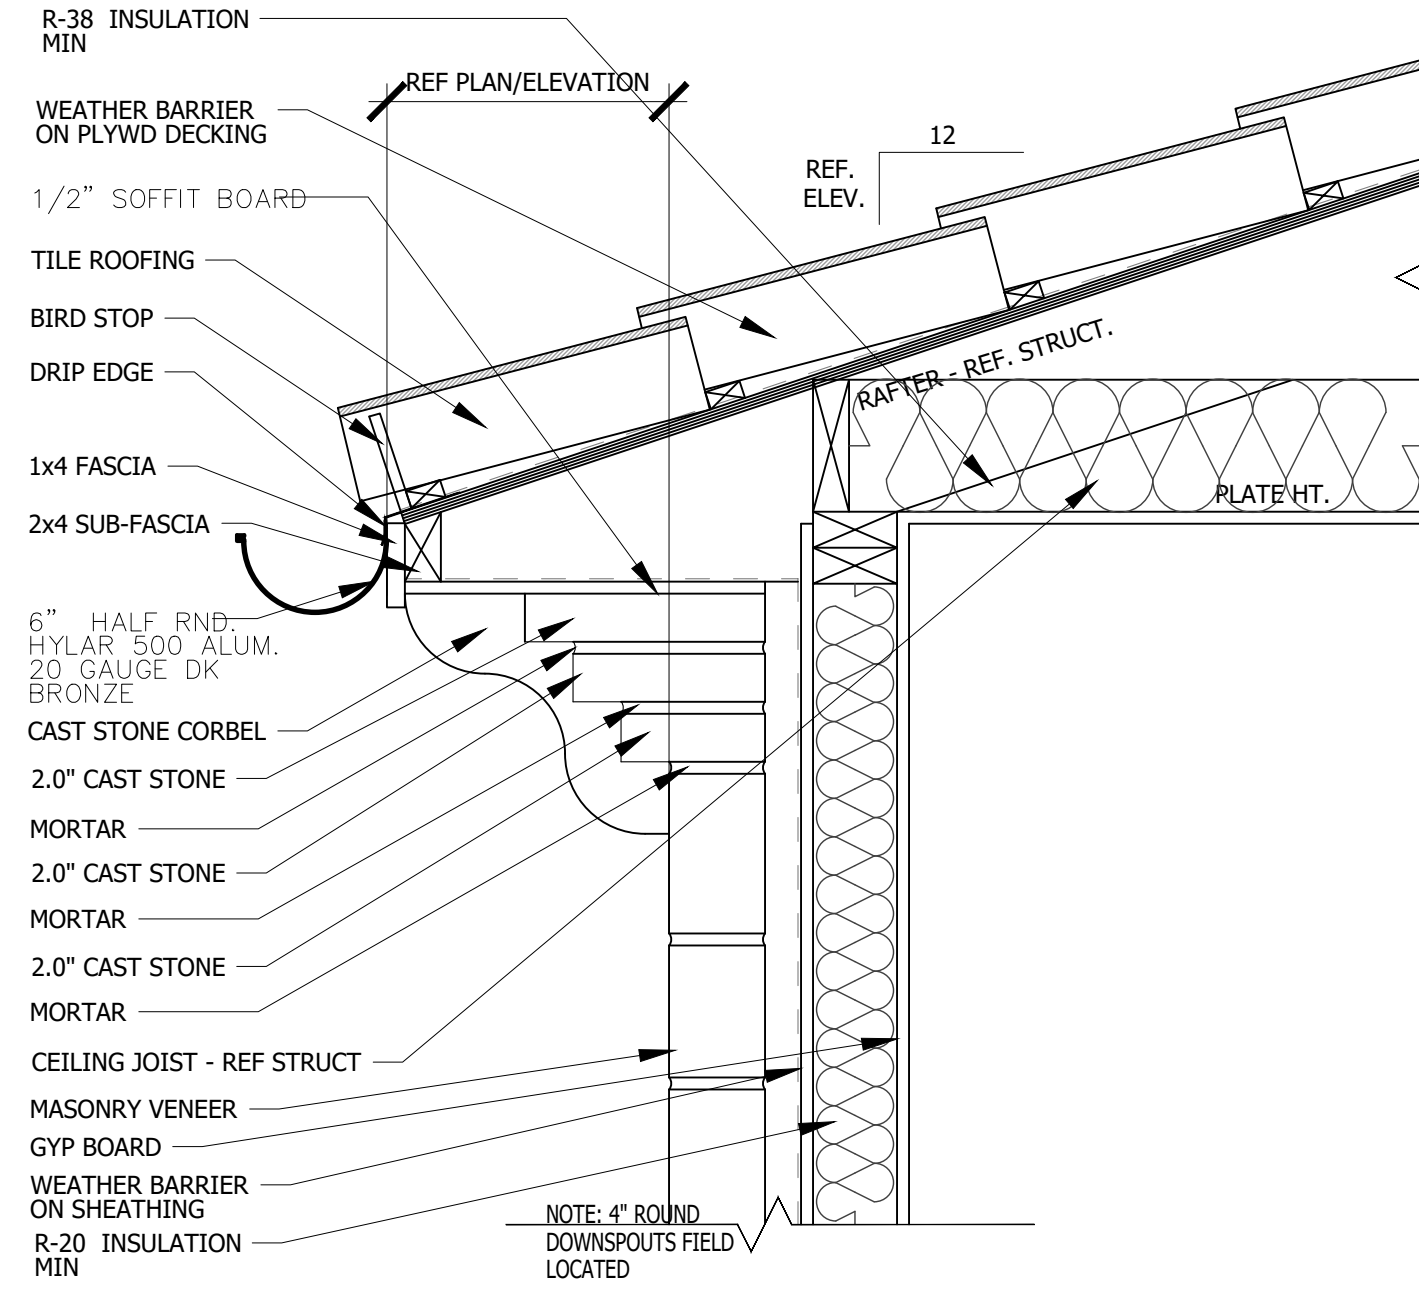

04 FASCIA DETAIL
SCALE: 1 1/2" = 1'-0"

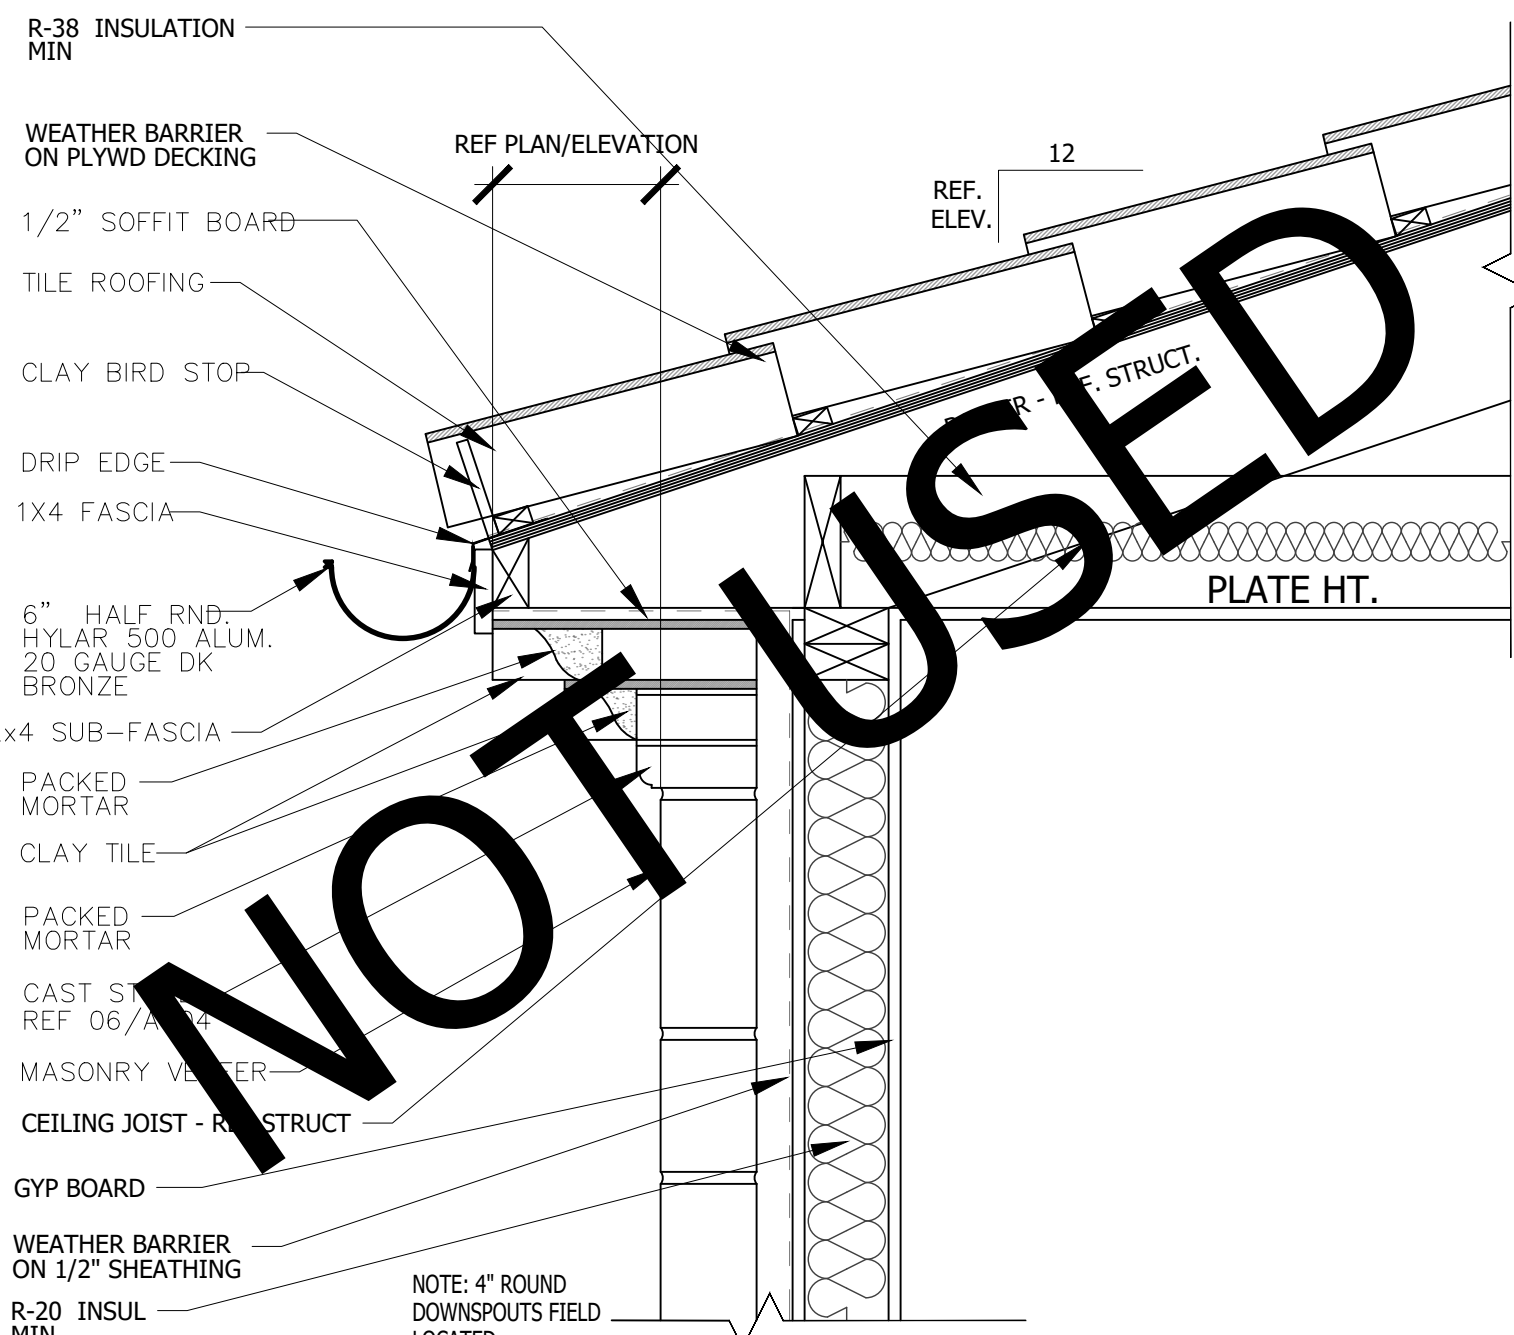

01 FASCIA DETAIL
SCALE: 1 1/2" = 1'-0"

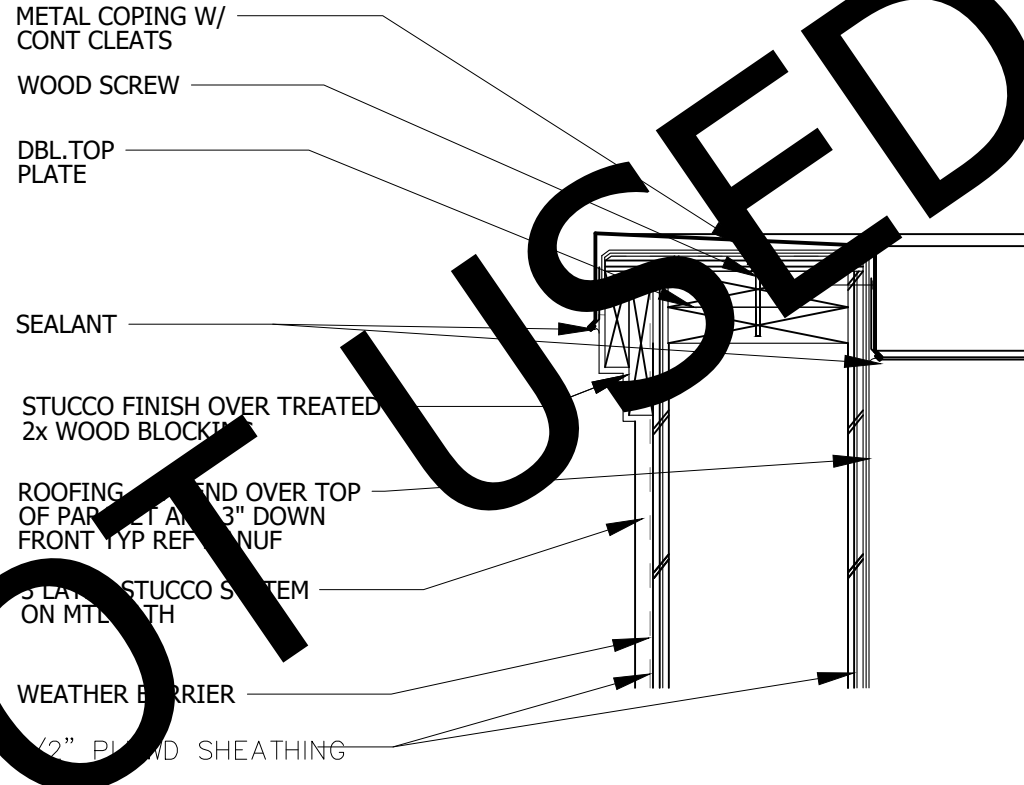

06 PARAPET DETAIL
SCALE: 1 1/2" = 1'-0"

REFER TO **ENTRADA DESIGN GUIDELINES** FOR FUTHER DETAILED INFORMATION REGARDING THESE PLANS

ISSUE LOG

NO.	DESCRIPTION	DATE

PROJECT NO:	21-131
ISSUED FOR:	OTP
DRAWN BY:	Checker
DATE:	06/24/21

ROOF DETAILS

A500


ISSUE LOG

NO.	DESCRIPTION	DATE


PROJECT NO:	21-131
ISSUED FOR:	OTP
DRAWN BY:	Checker
DATE:	06/24/21

STANDARD DETAILS


A501

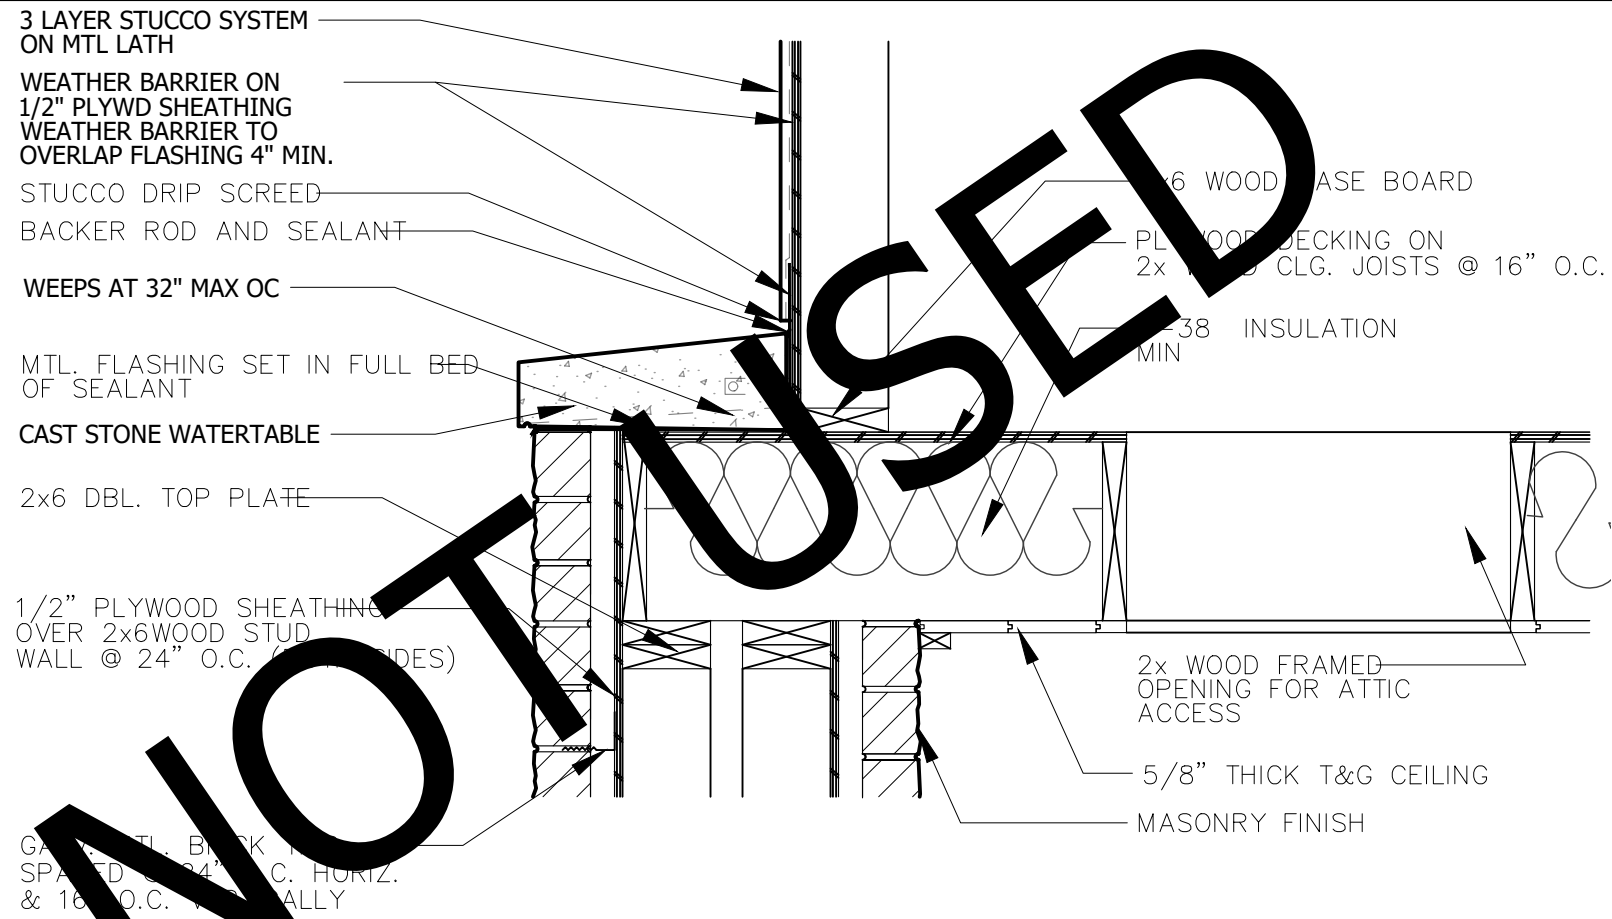


06 ATTIC ACCESS DETAIL
SCALE: 1" = 1'-0"

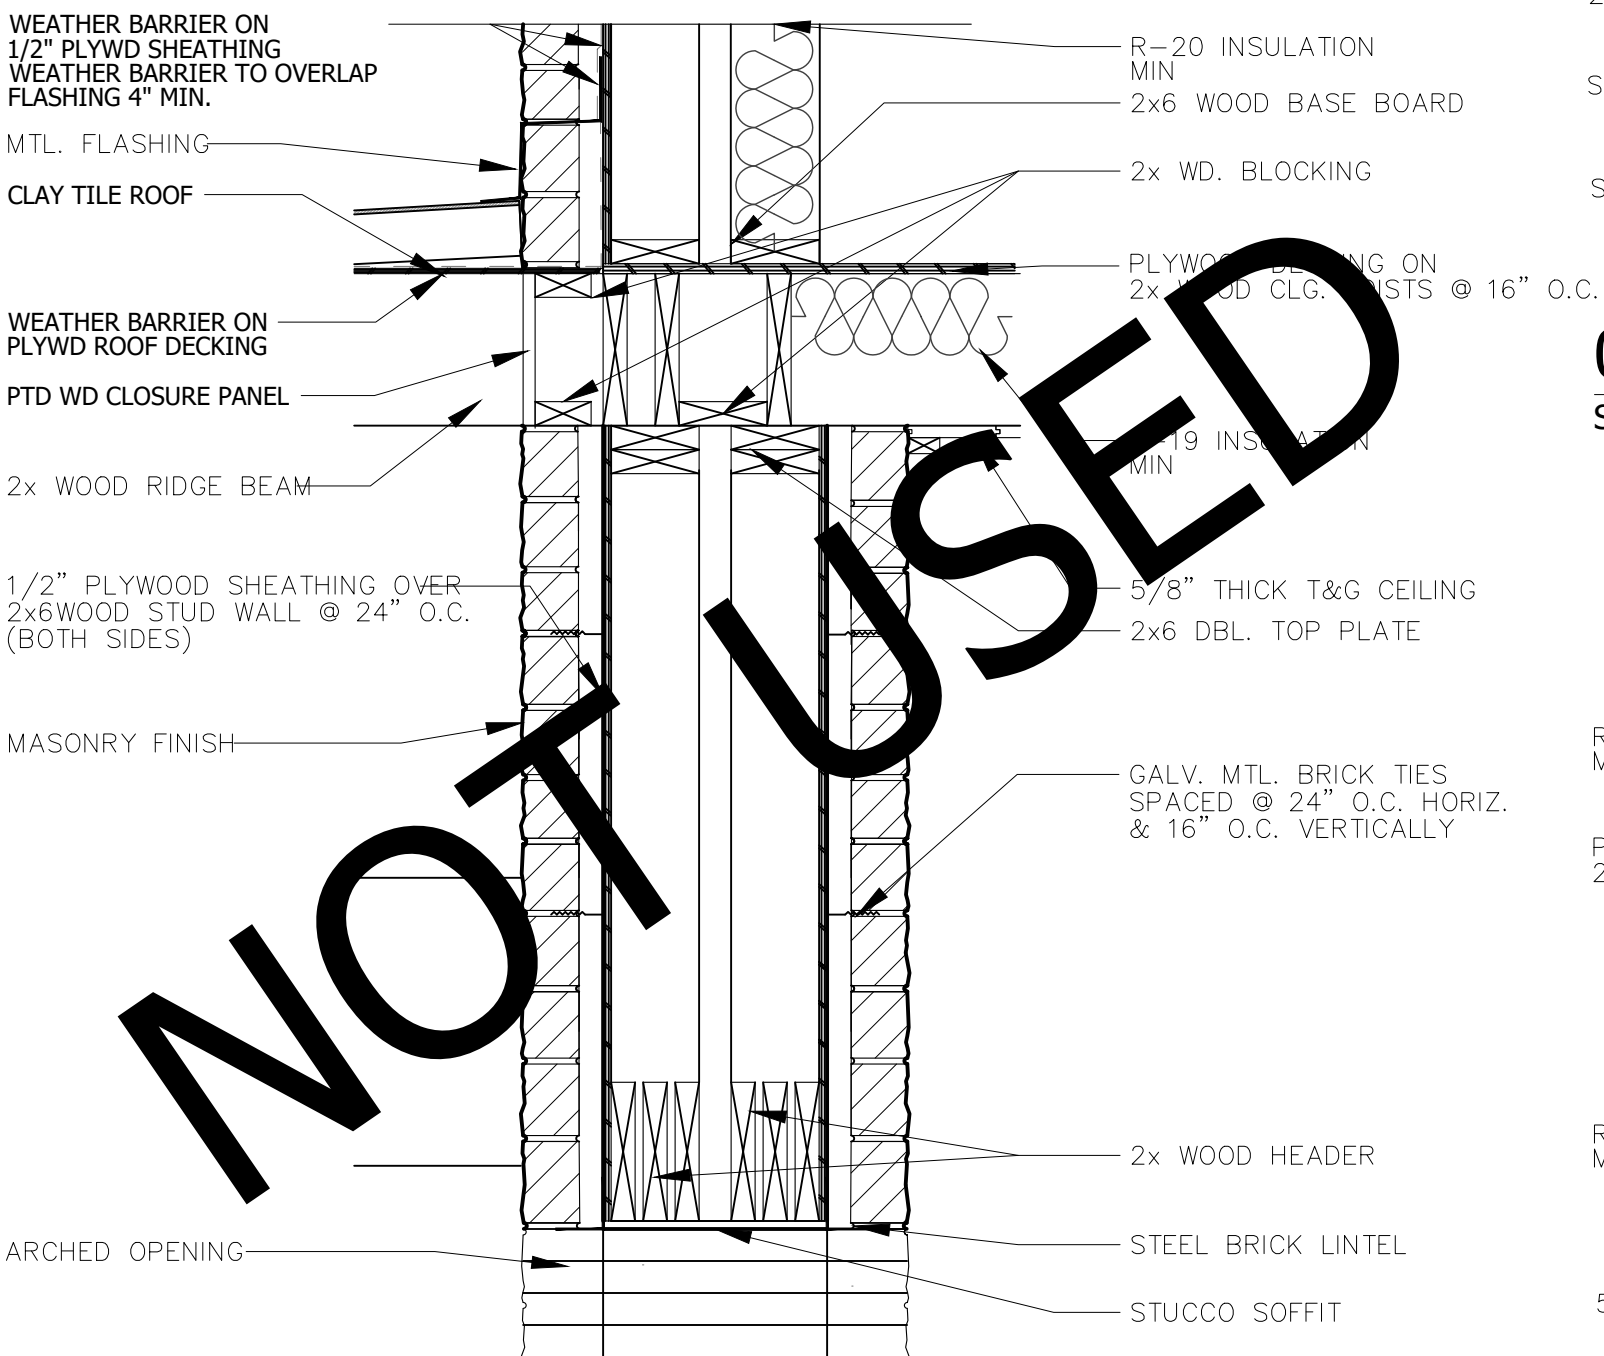


05 ARCHED OPENING DETAIL
SCALE: 1" = 1'-0"

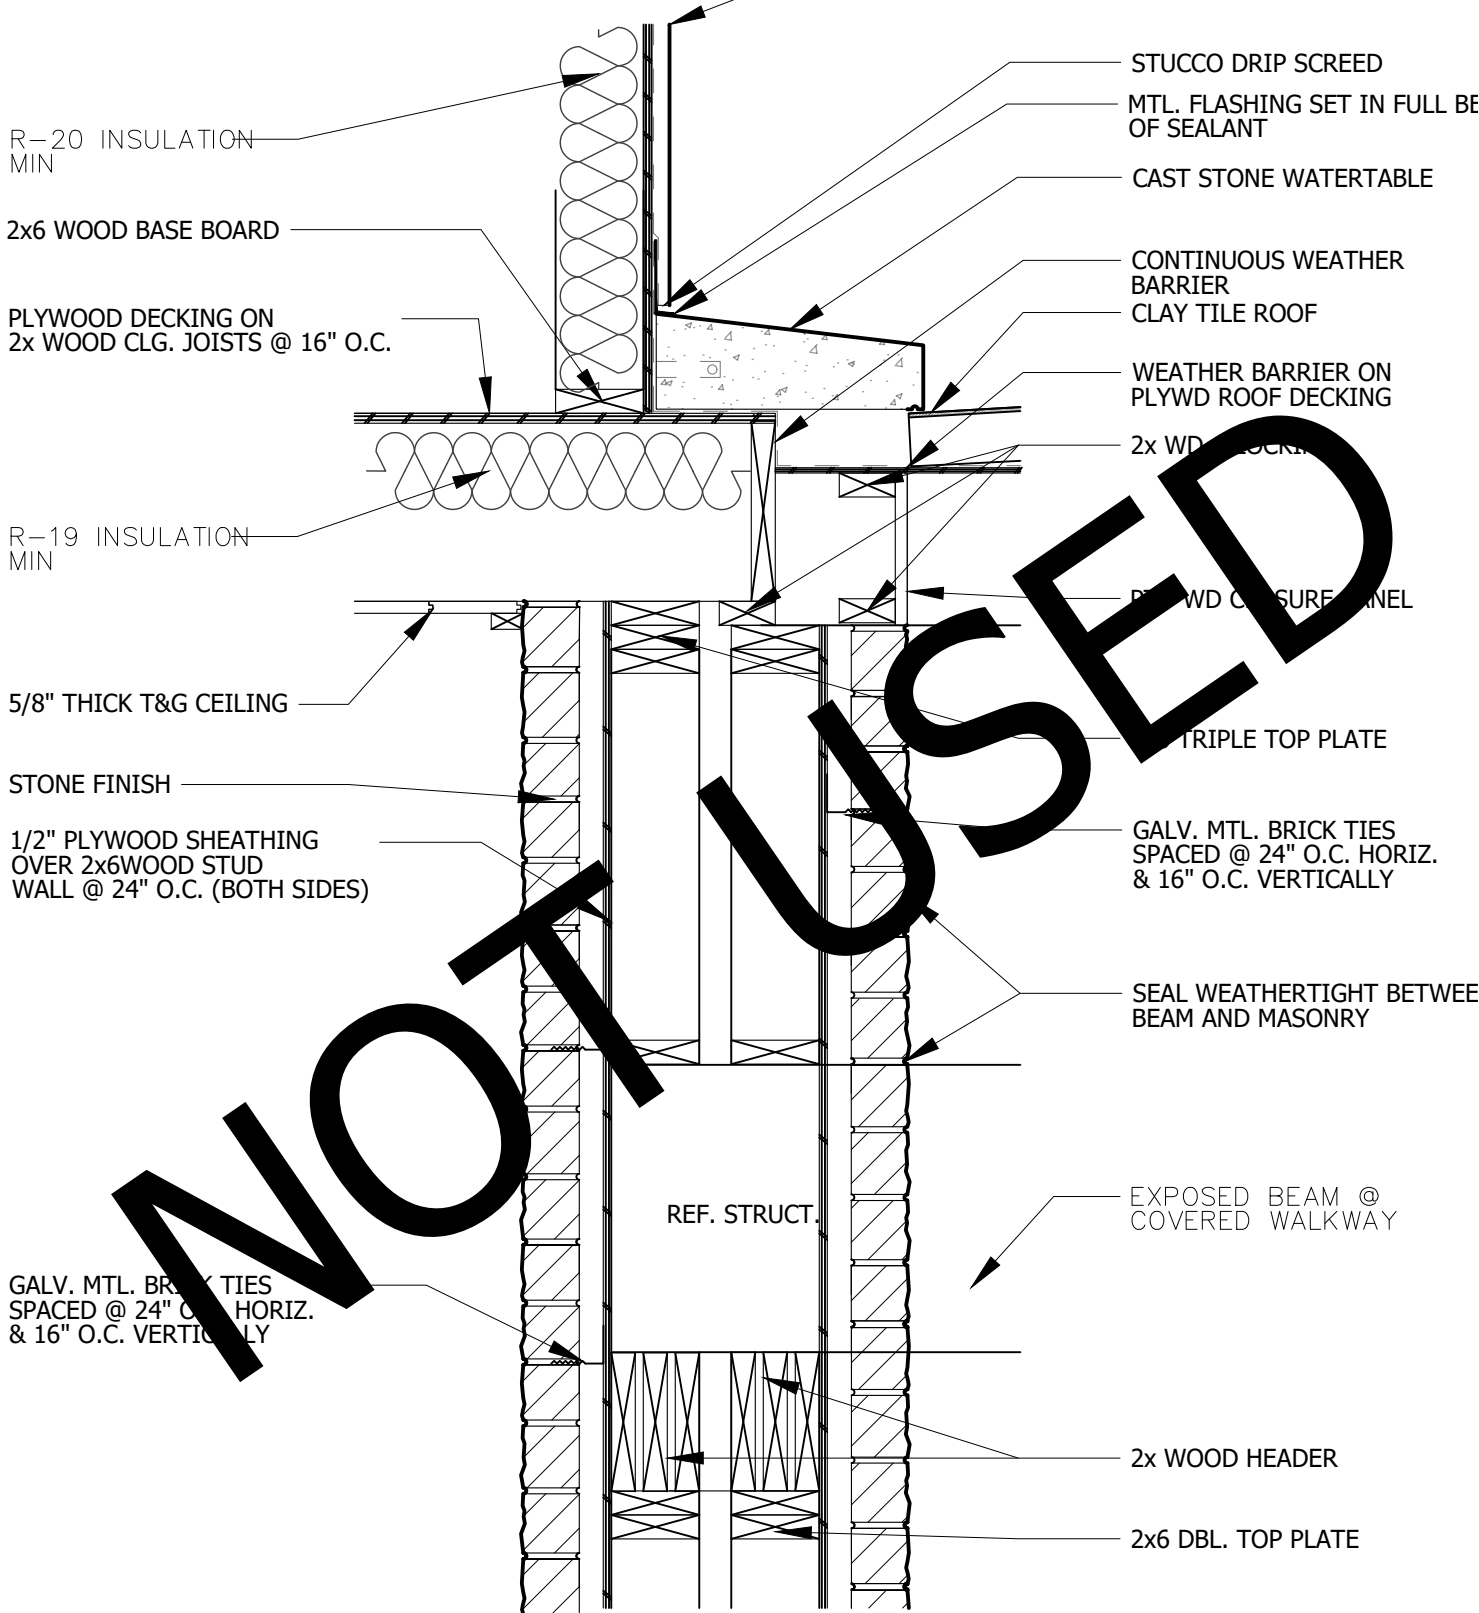


04 WATERTABLE DETAIL
SCALE: 1" = 1'-0"

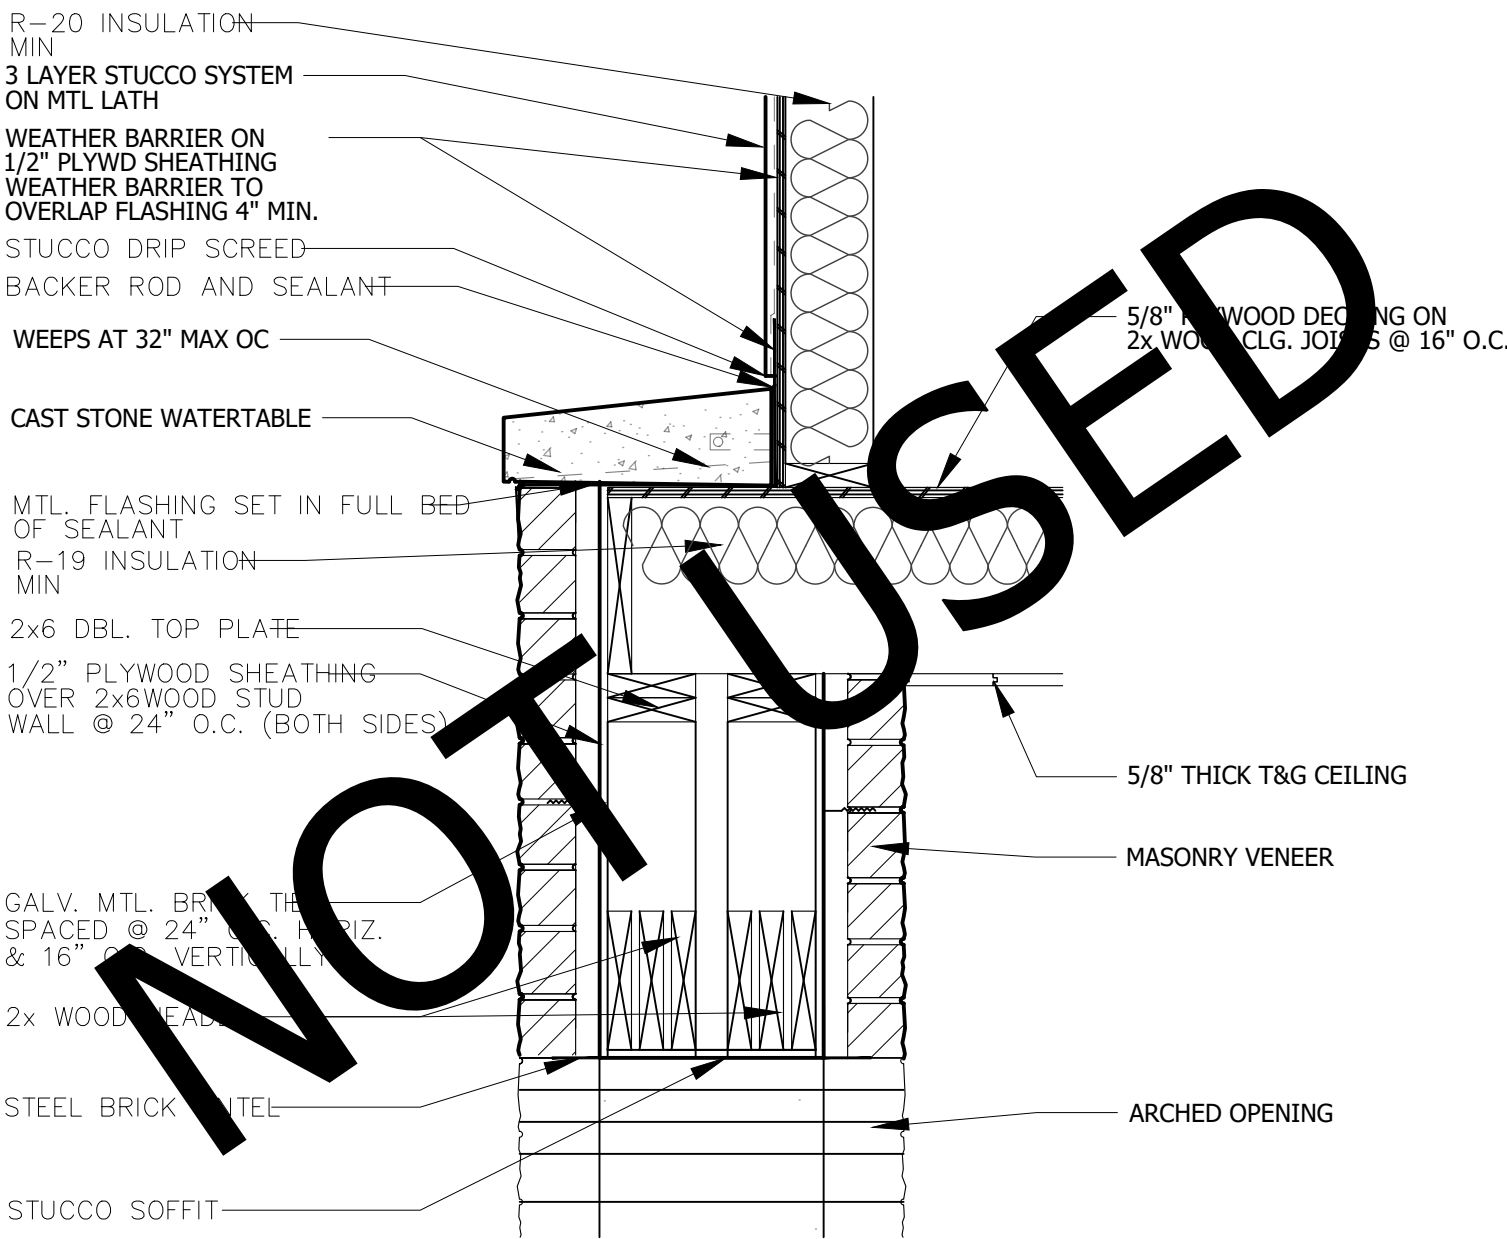


03 WATERTABLE DETAIL
SCALE: 1" = 1'-0"

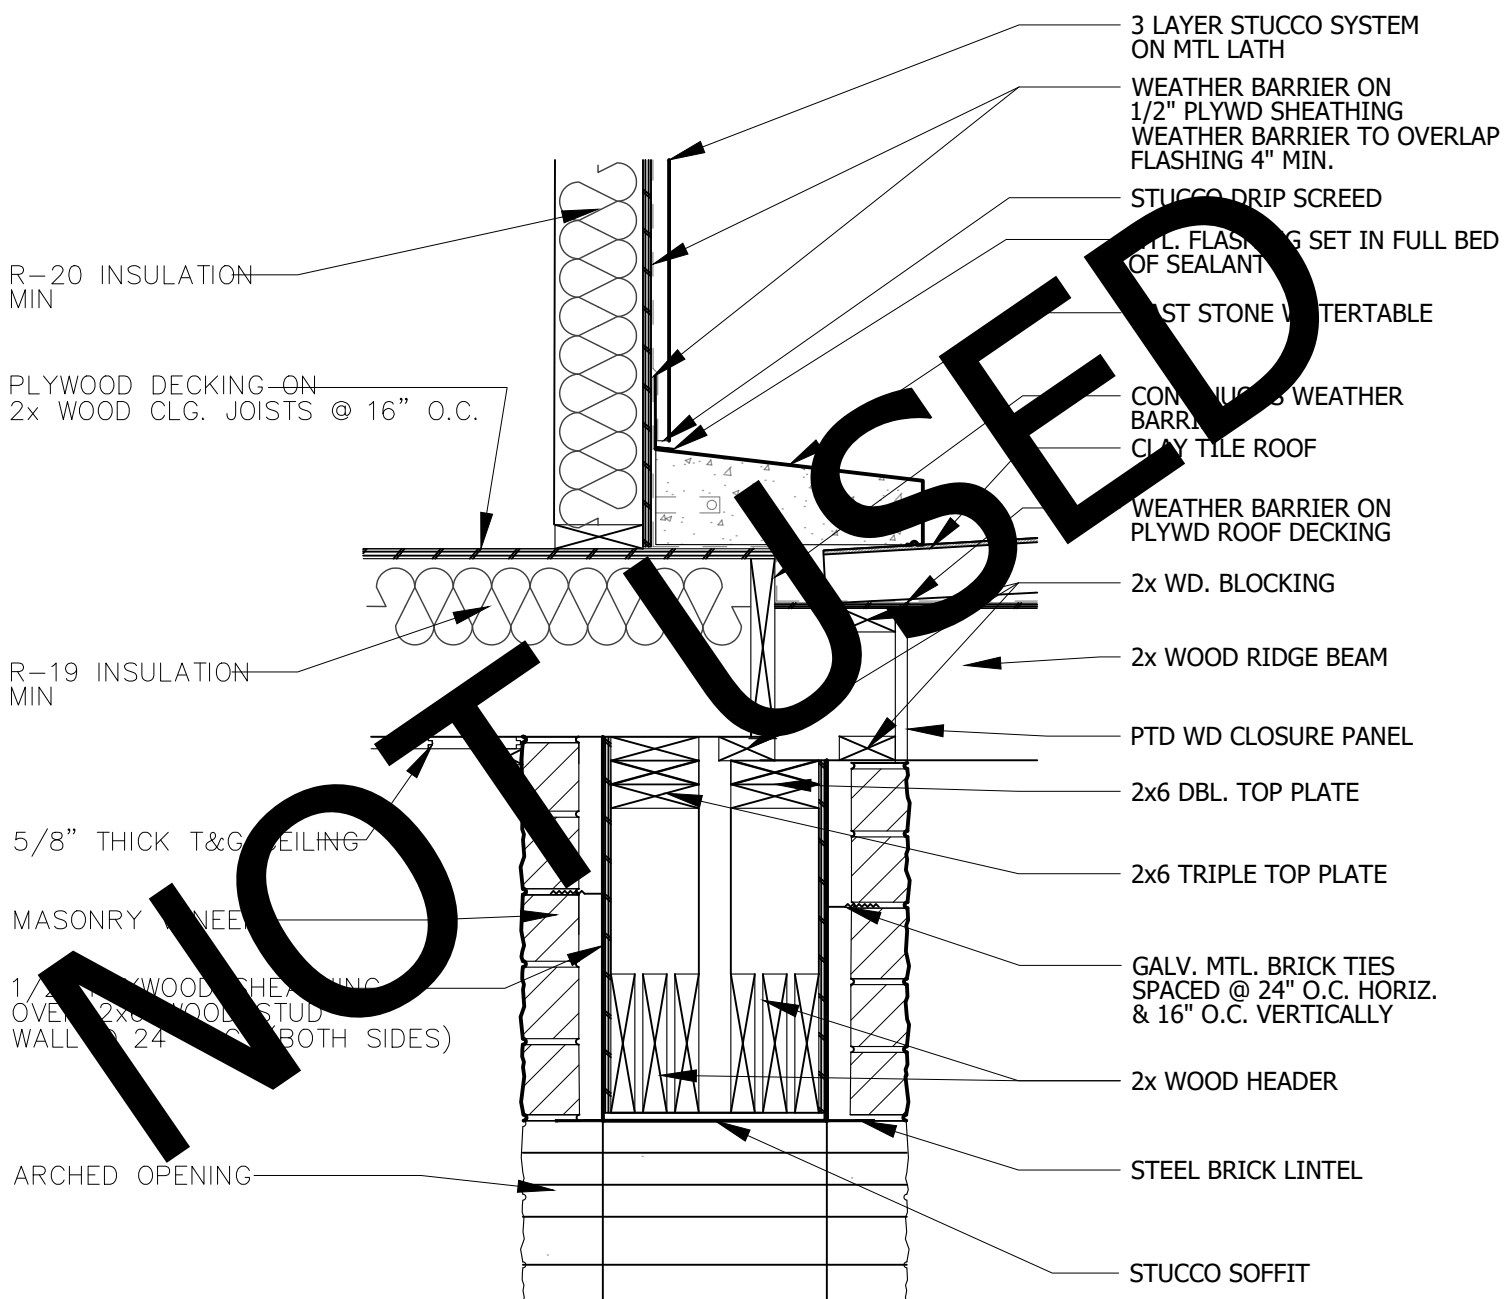


02 WATERTABLE DETAIL
SCALE: 1" = 1'-0"

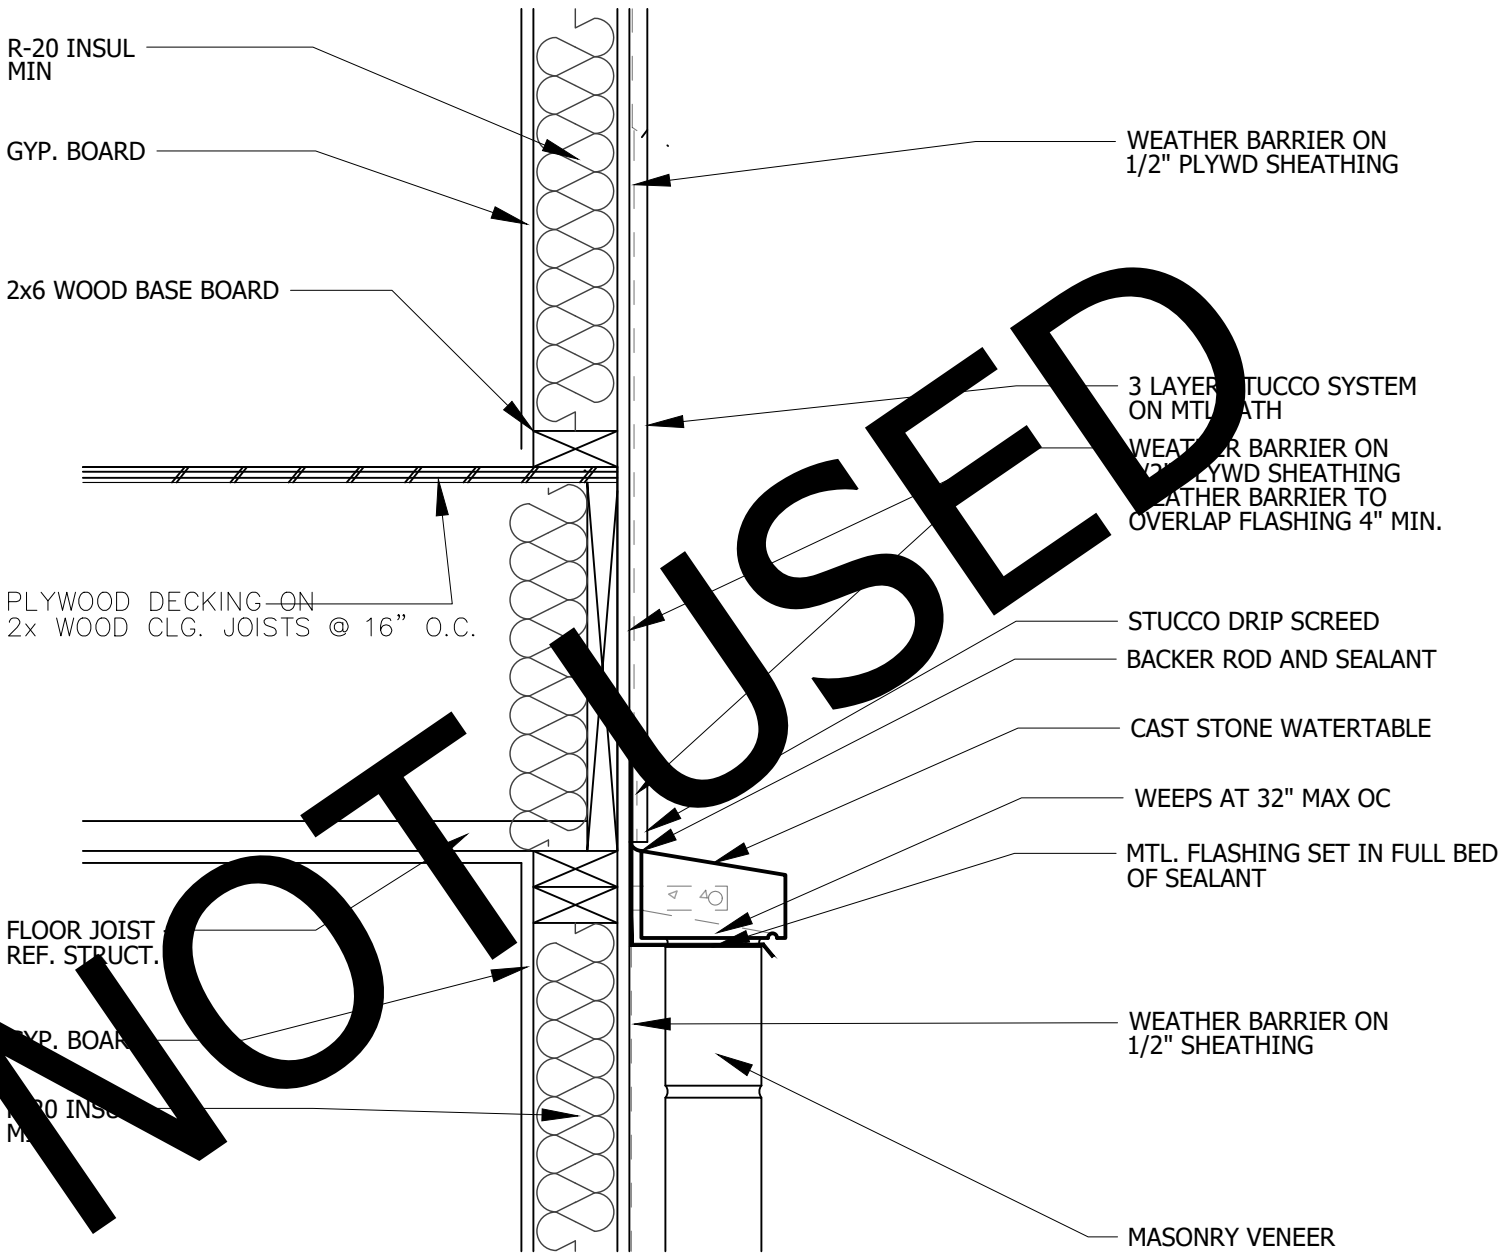

01 STONE/ STUCCO TRANSITION DETAIL
SCALE: 1 1/2" = 1'-0"

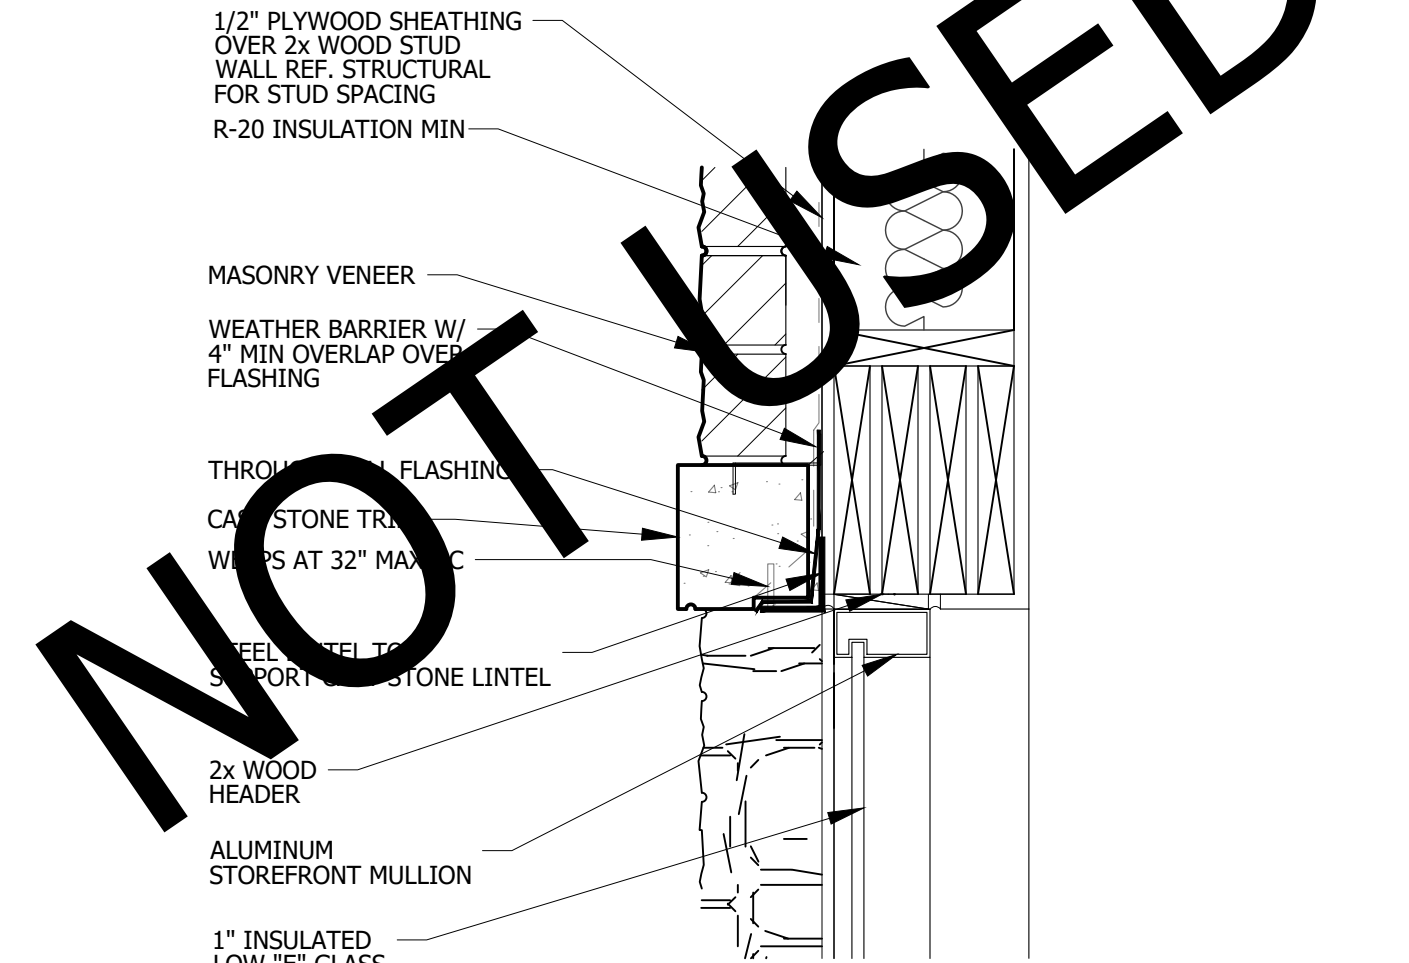


08 STOREFRONT HEADER
SCALE: 1 1/2" = 1'-0"

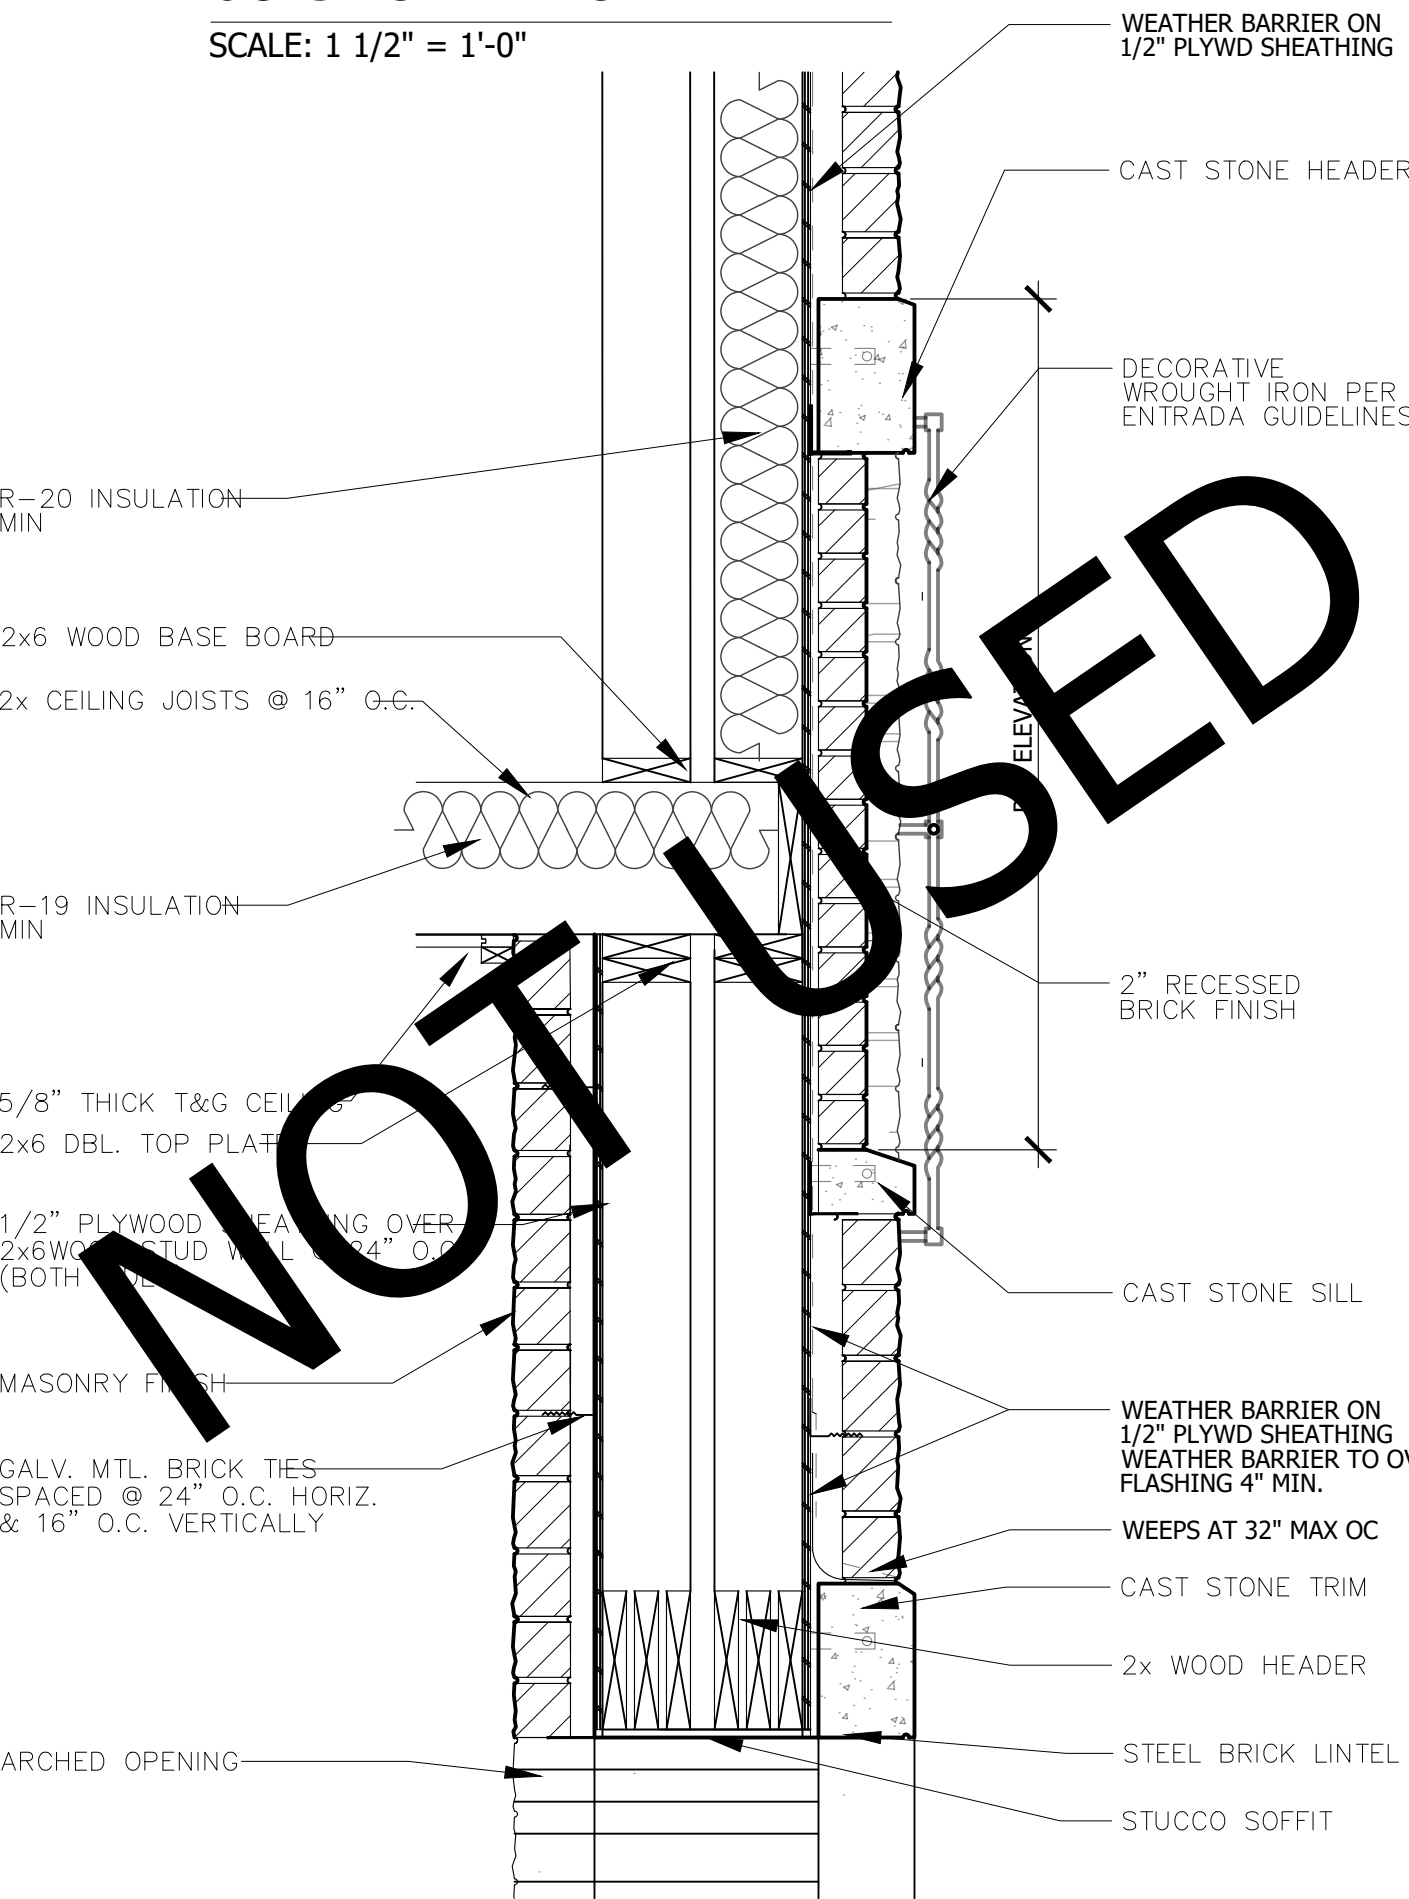

07 INSET BRICK DETAIL
W/ DECORATIVE WROUGHT IRON
SCALE: 1" = 1'-0"

REFER TO **ENTRADA DESIGN GUIDELINES** FOR FUTHER DETAILED INFORMATION REGARDING THESE PLANS

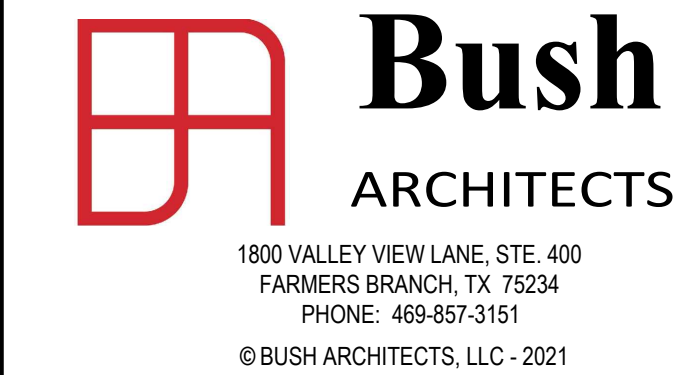

ENTRADA

LOT 03, BLOCK H

TOWN OF WESTLAKE TARRANT COUNTY, TEXAS


ISSUE LOG

[illegible]


PROJECT NO:	21-131
ISSUED FOR:	OTP
DRAWN BY:	Checke
DATE:	06/24/2

STANDARD DETAILS


A502

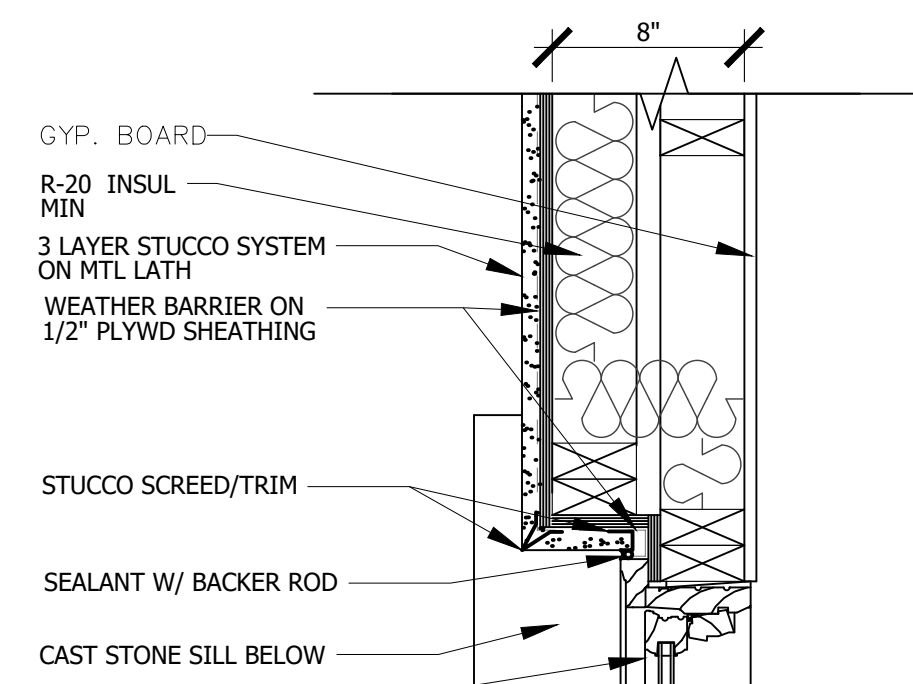

10 WINDOW JAMB

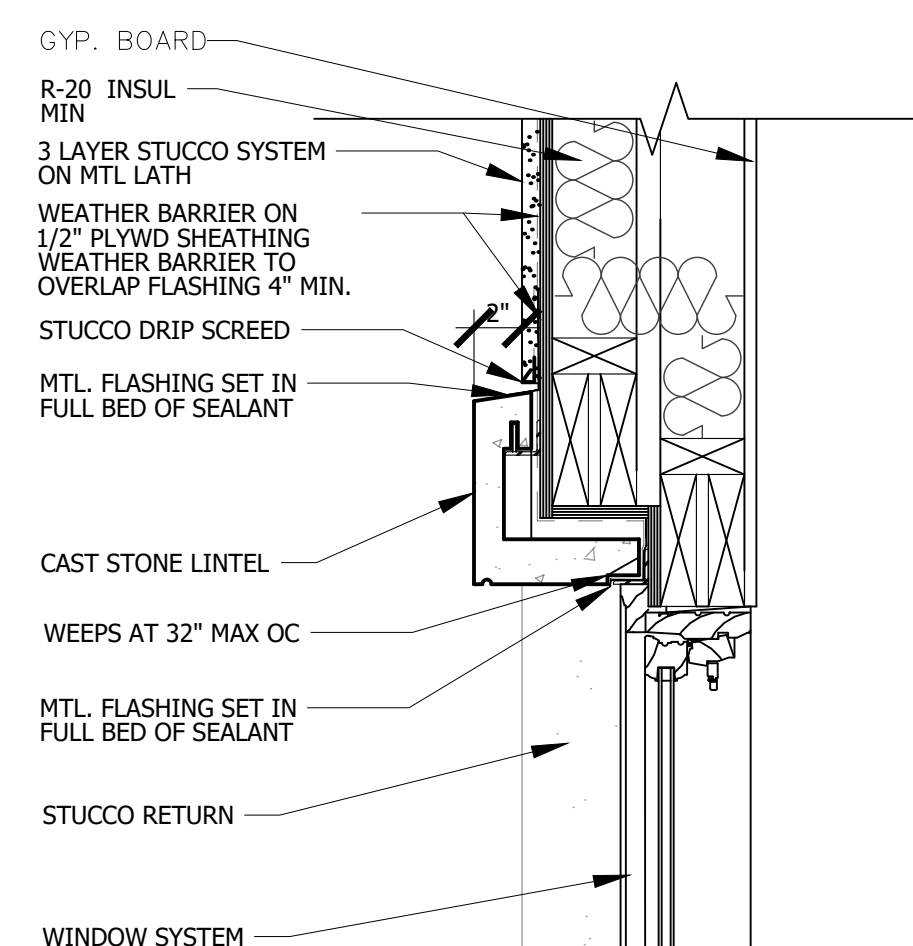


09 WINDOW SECTION
SCALE: 1 1/2" = 1'-0"

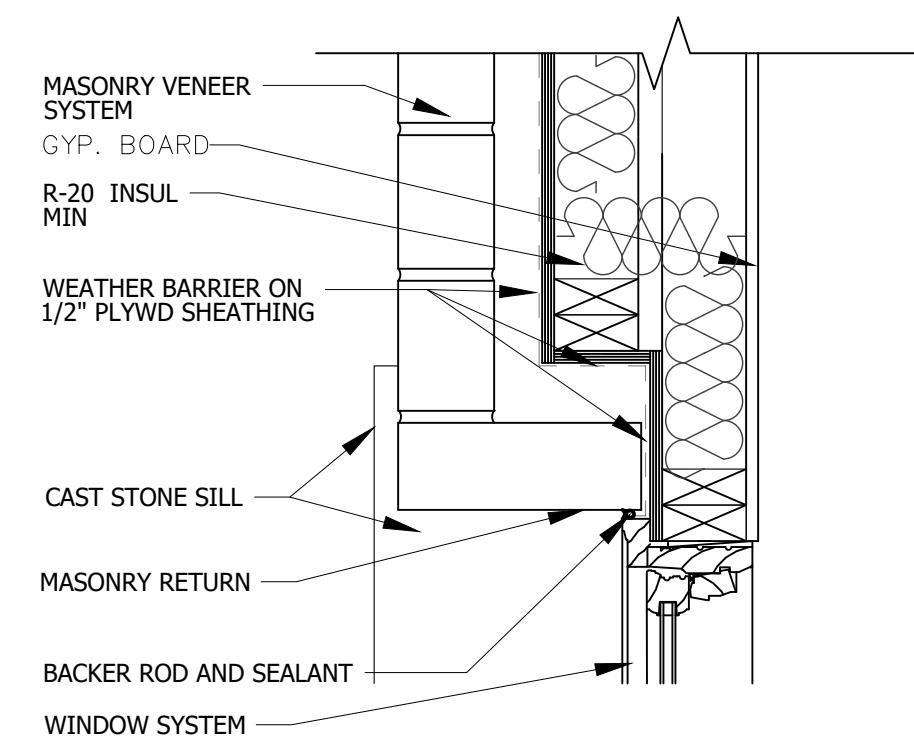


12 WINDOW JAMB

SCALE: 1 1/2" = 1'-0"

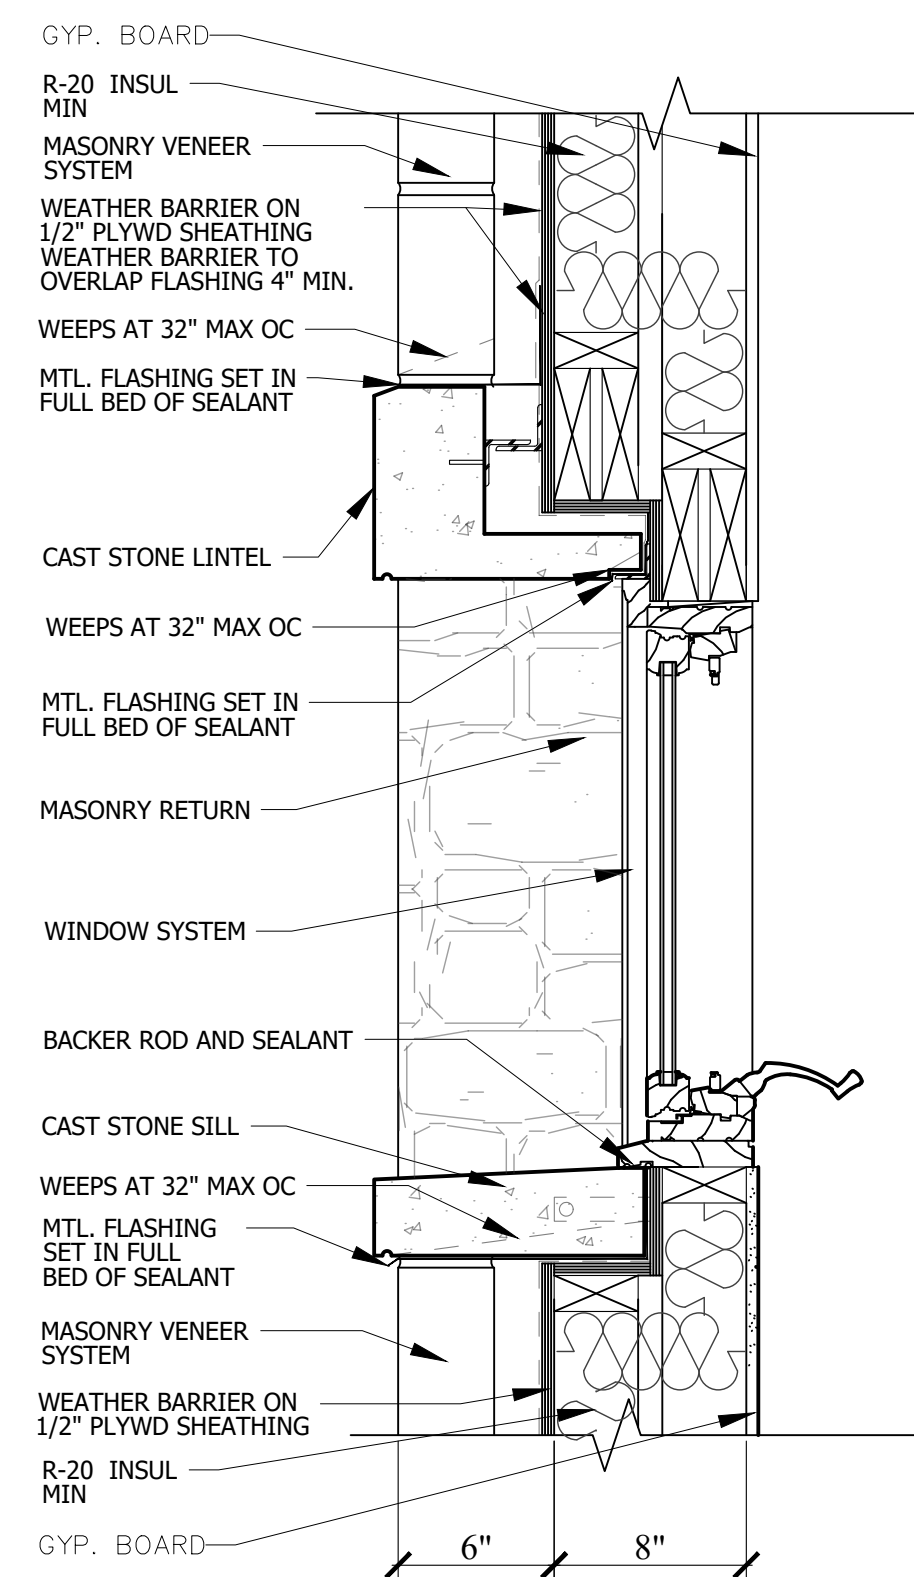


11 WINDOW SECTION

SCALE: 1 1/2" = 1'-0"

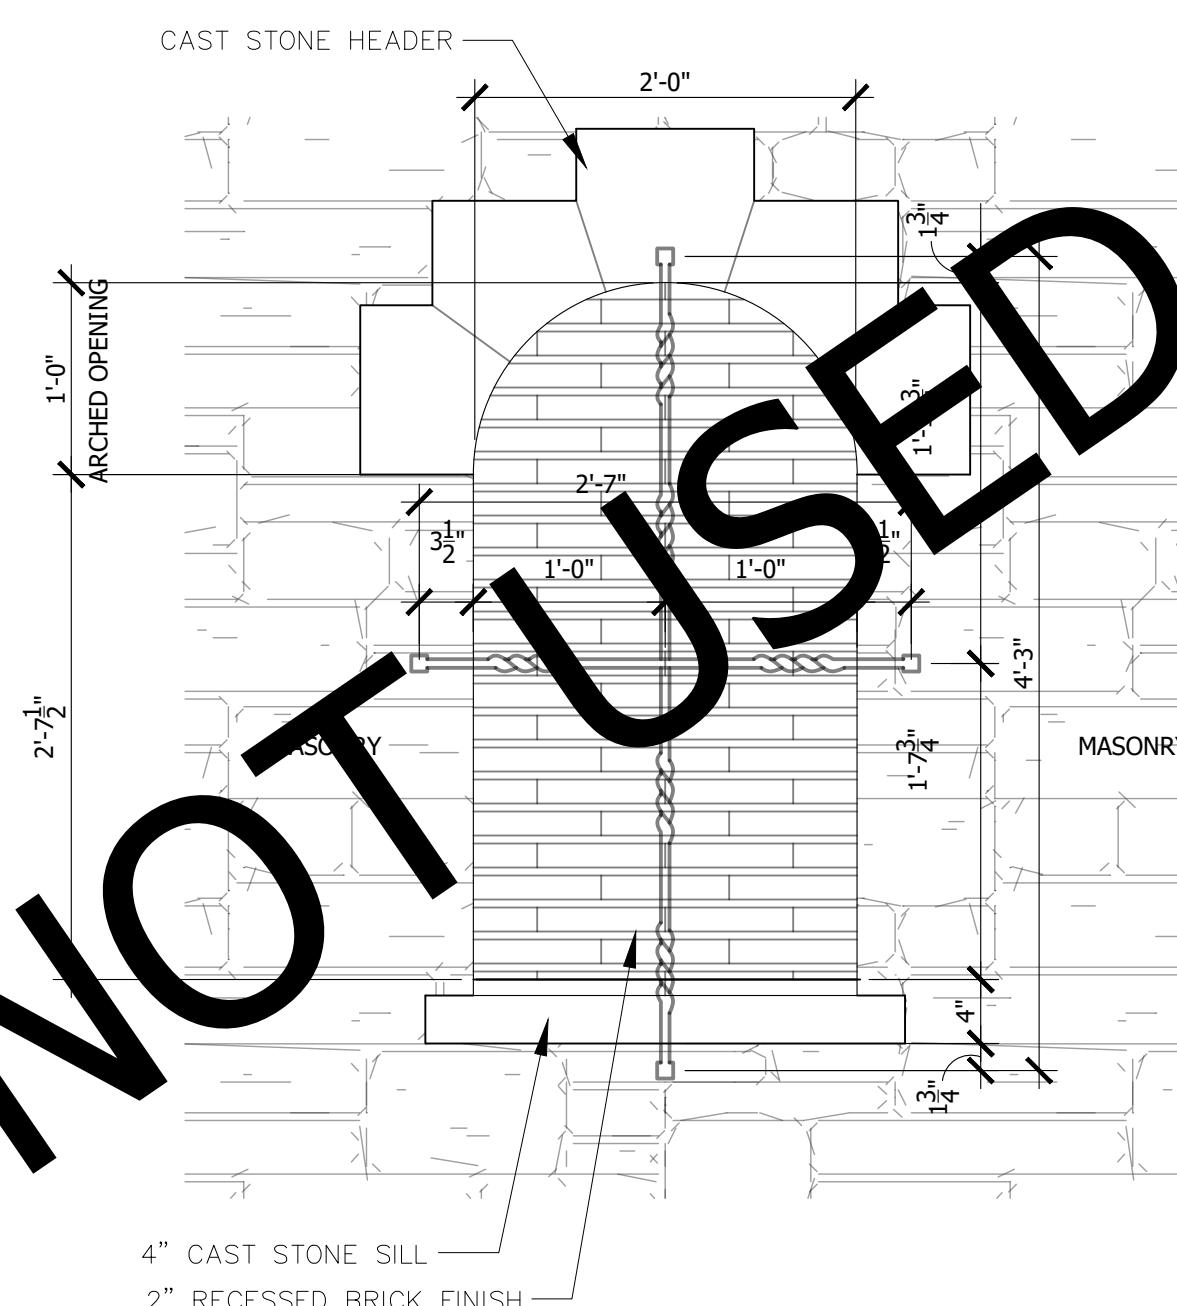


NOTE:
ALL IRON WORK MUST COMPLY WITH
ENTRADA DESIGN GUIDELINES


07 INSET BRICK DETAIL
W/ DECORATIVE WROUGHT IRON
SCALE: 1" = 1'-0"

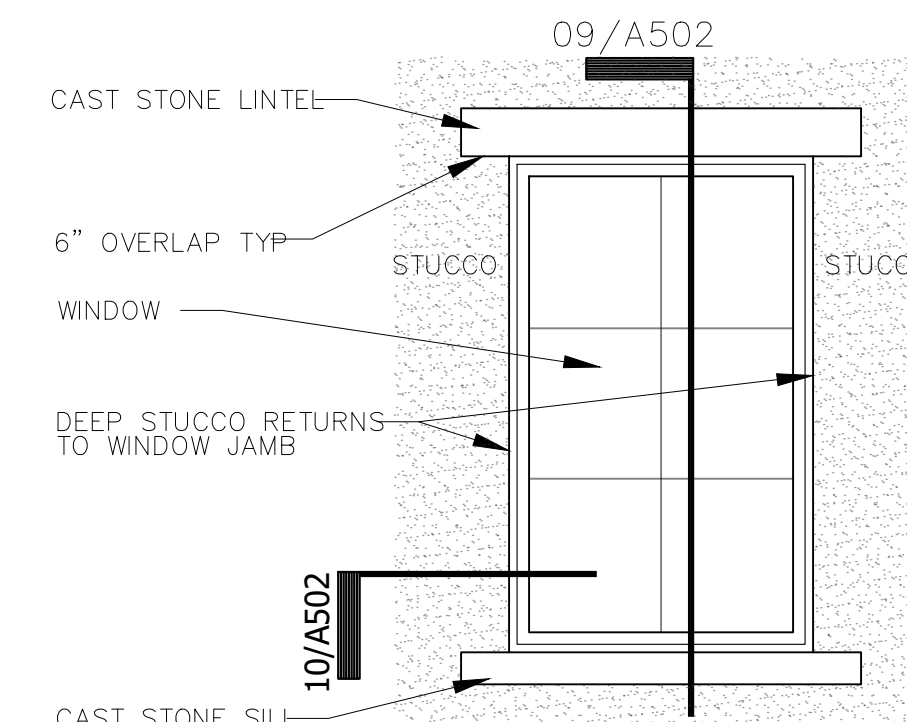


06 CAST STONE LINTEL SILL

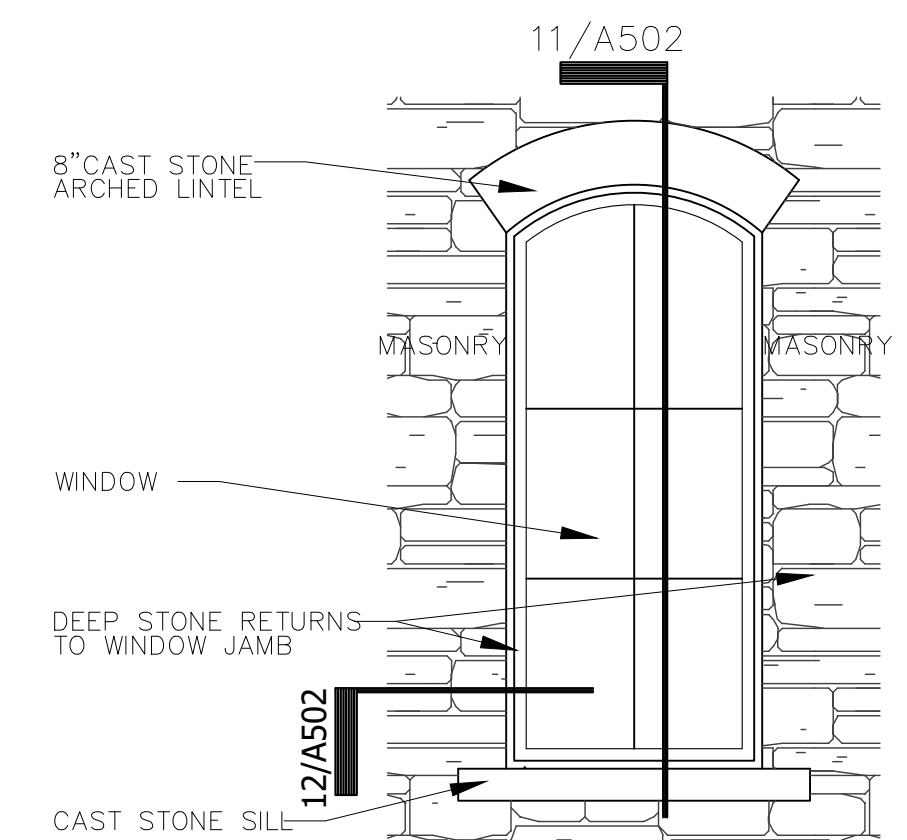

05 CAST STONE LINTEL/SILL

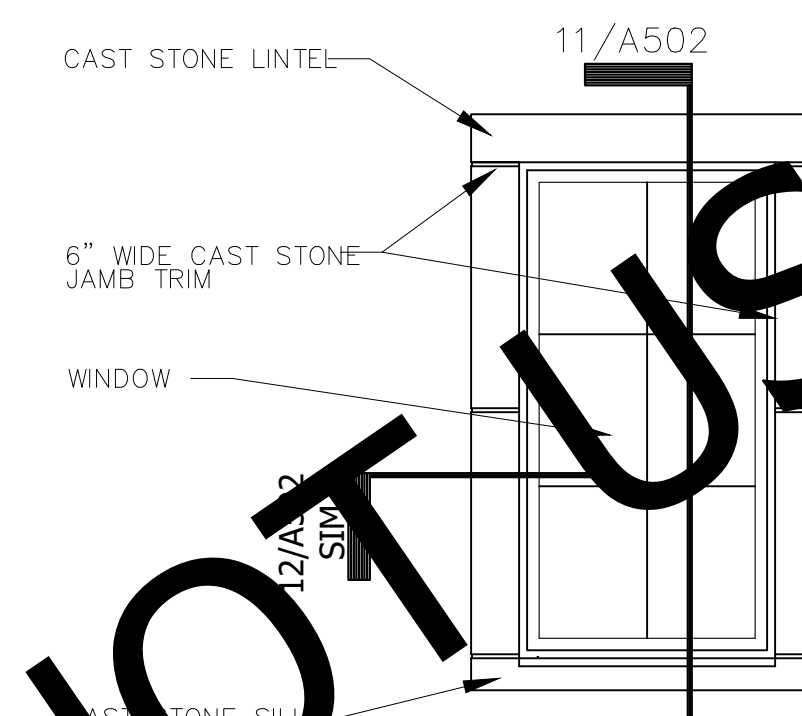


CAST STONE SURROUND DETAIL

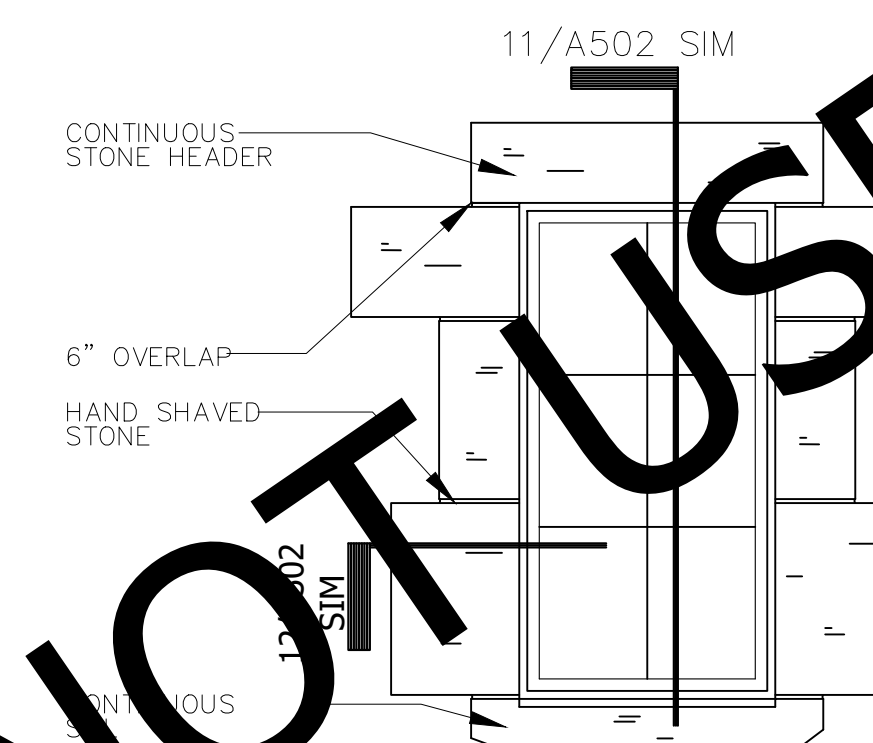


05 NATURAL STONE SURROUND DETAIL

SCALE: 1/2" = 1'-0"

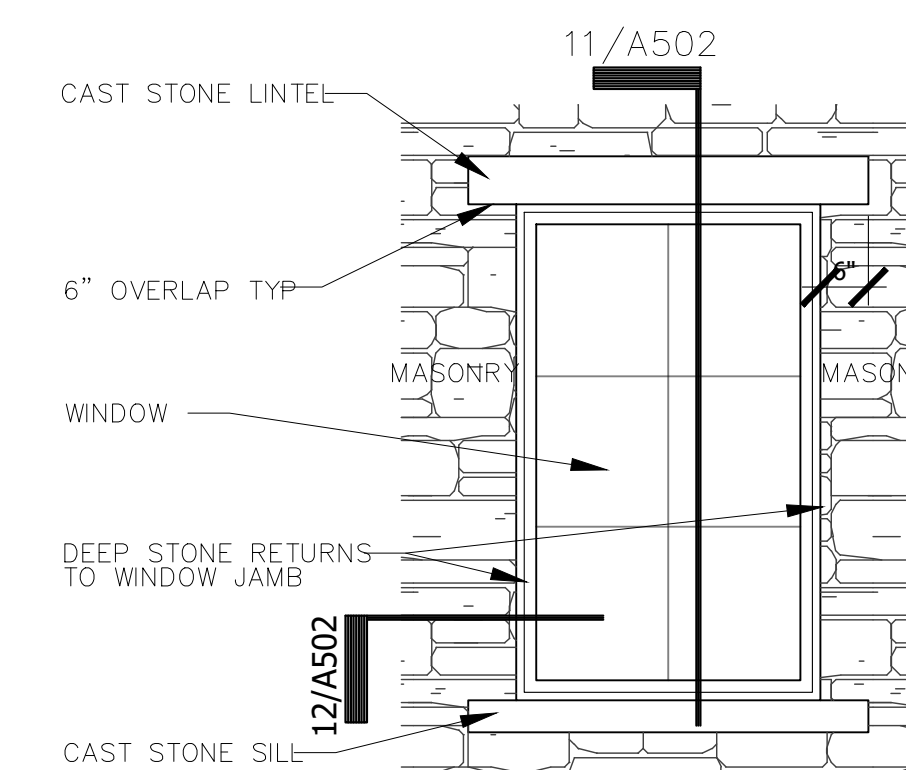

02 CAST STONE LINTEL/SILL














SCALE: 1/2" = 1'-0"

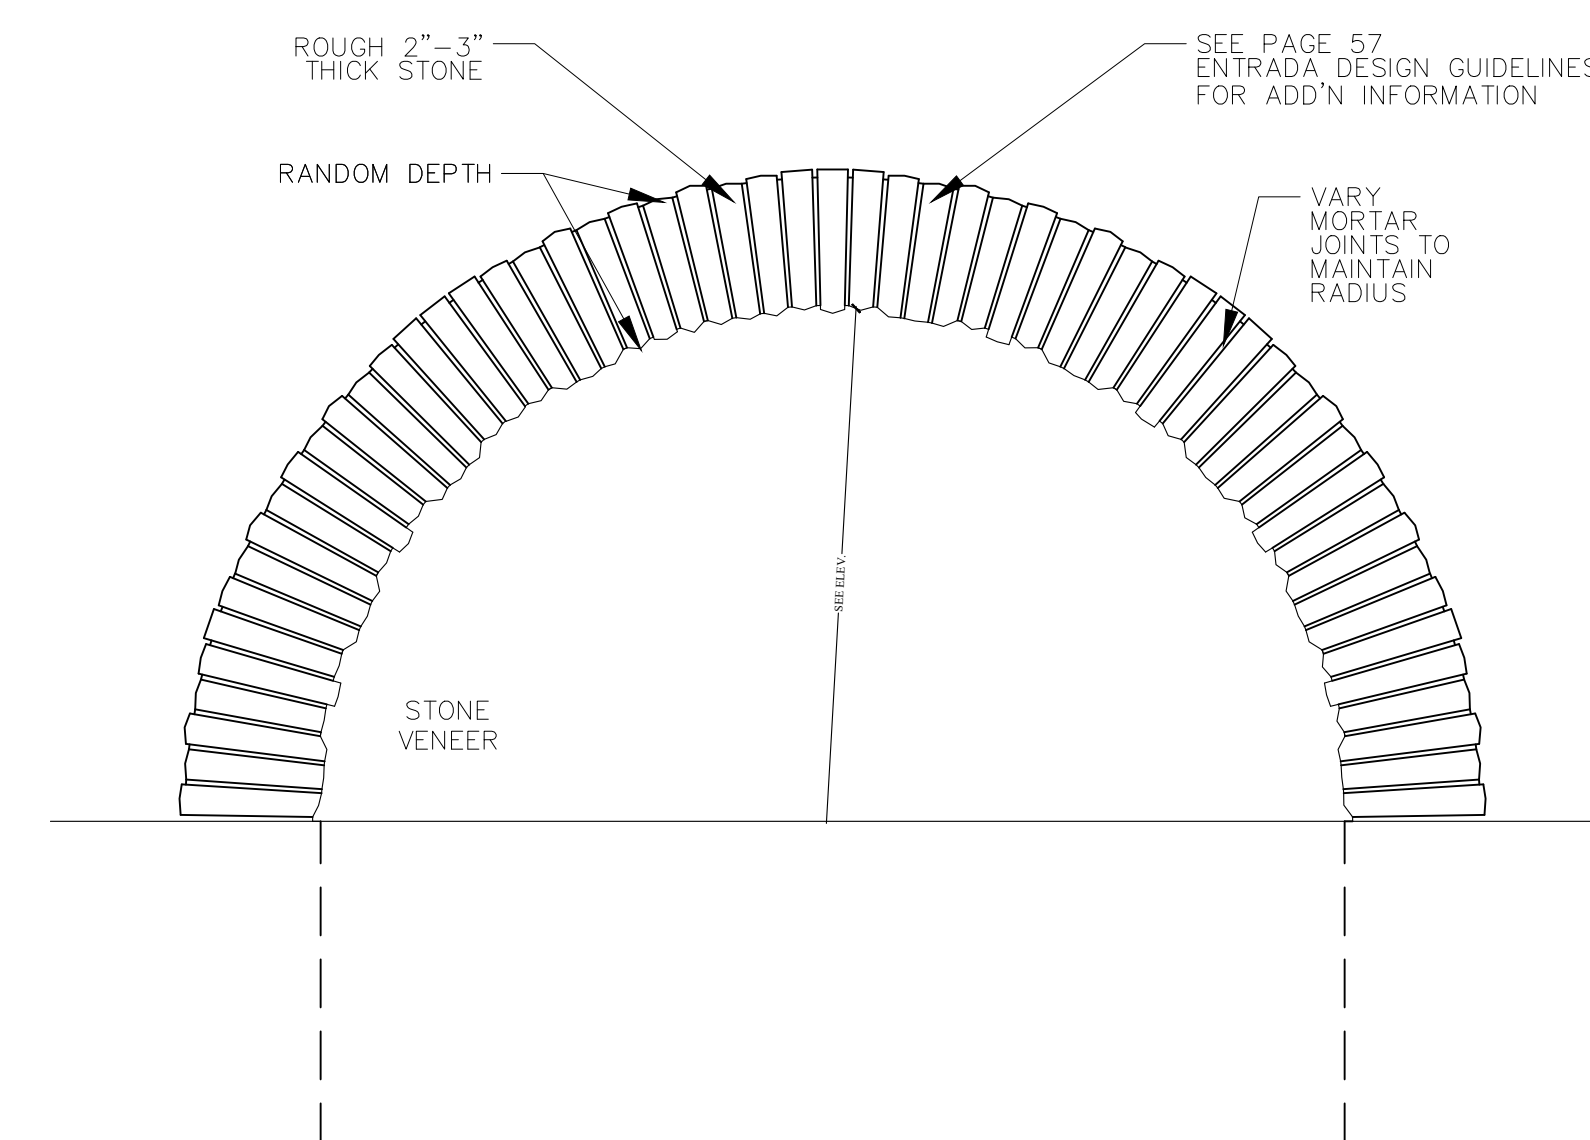

01 ROUGH ARCH DETAIL

SCALE: 1/2" = 1'-0"

REFER TO **ENTRADA DESIGN GUIDELINES** FOR FUTURE DETAILED INFORMATION REGARDING THESE PLANS

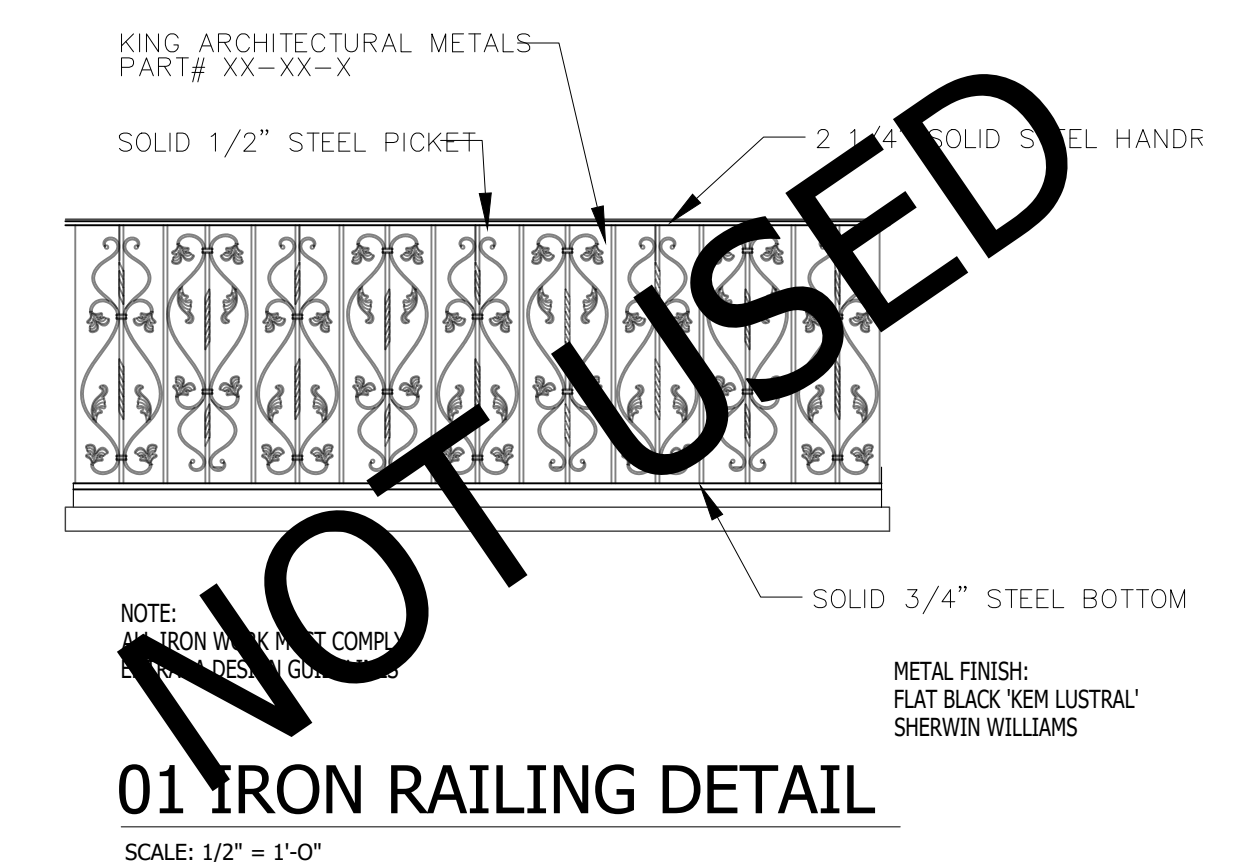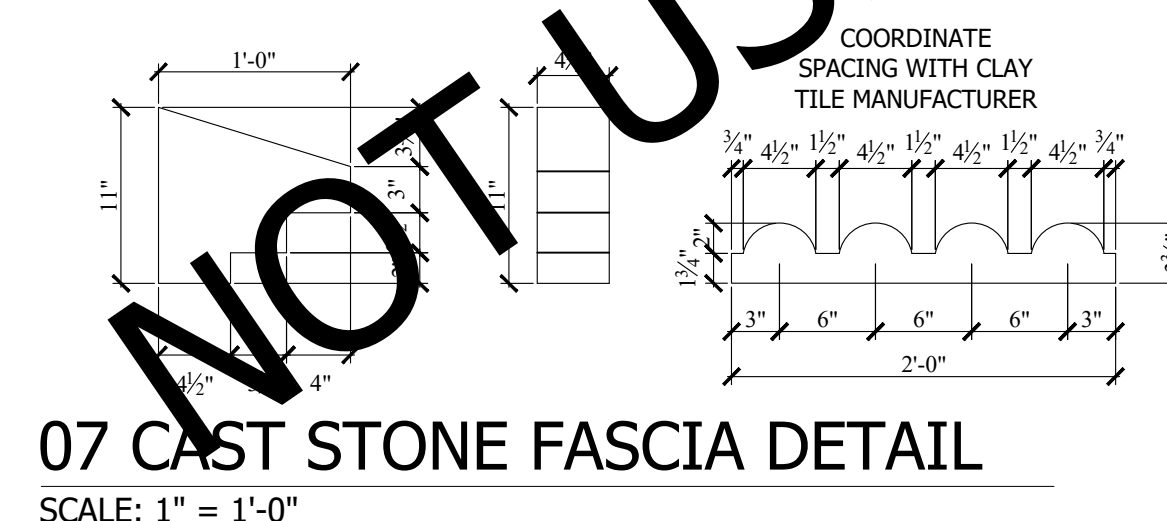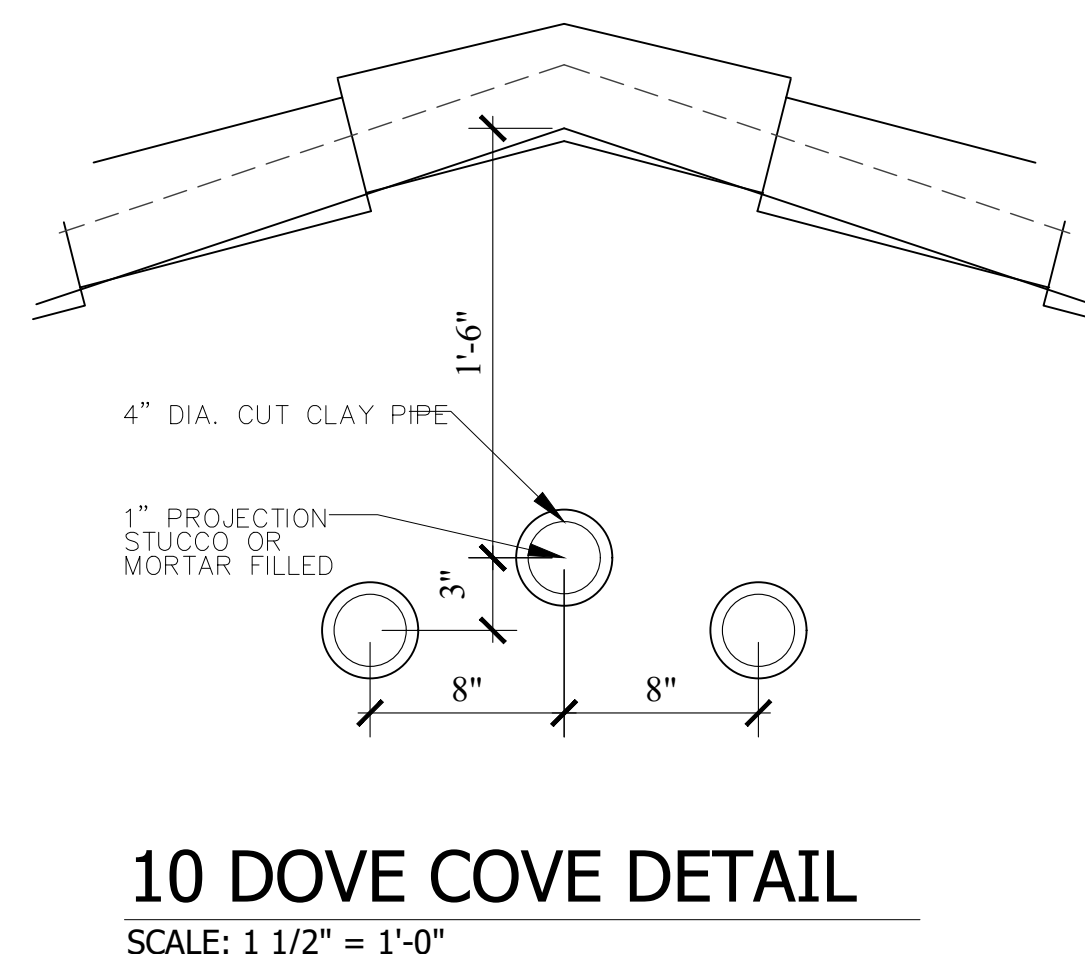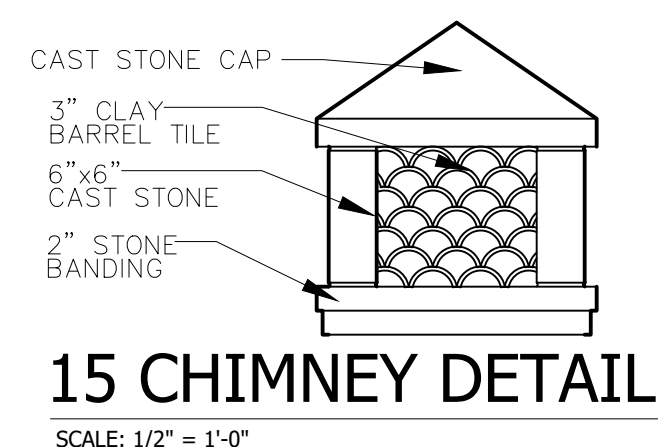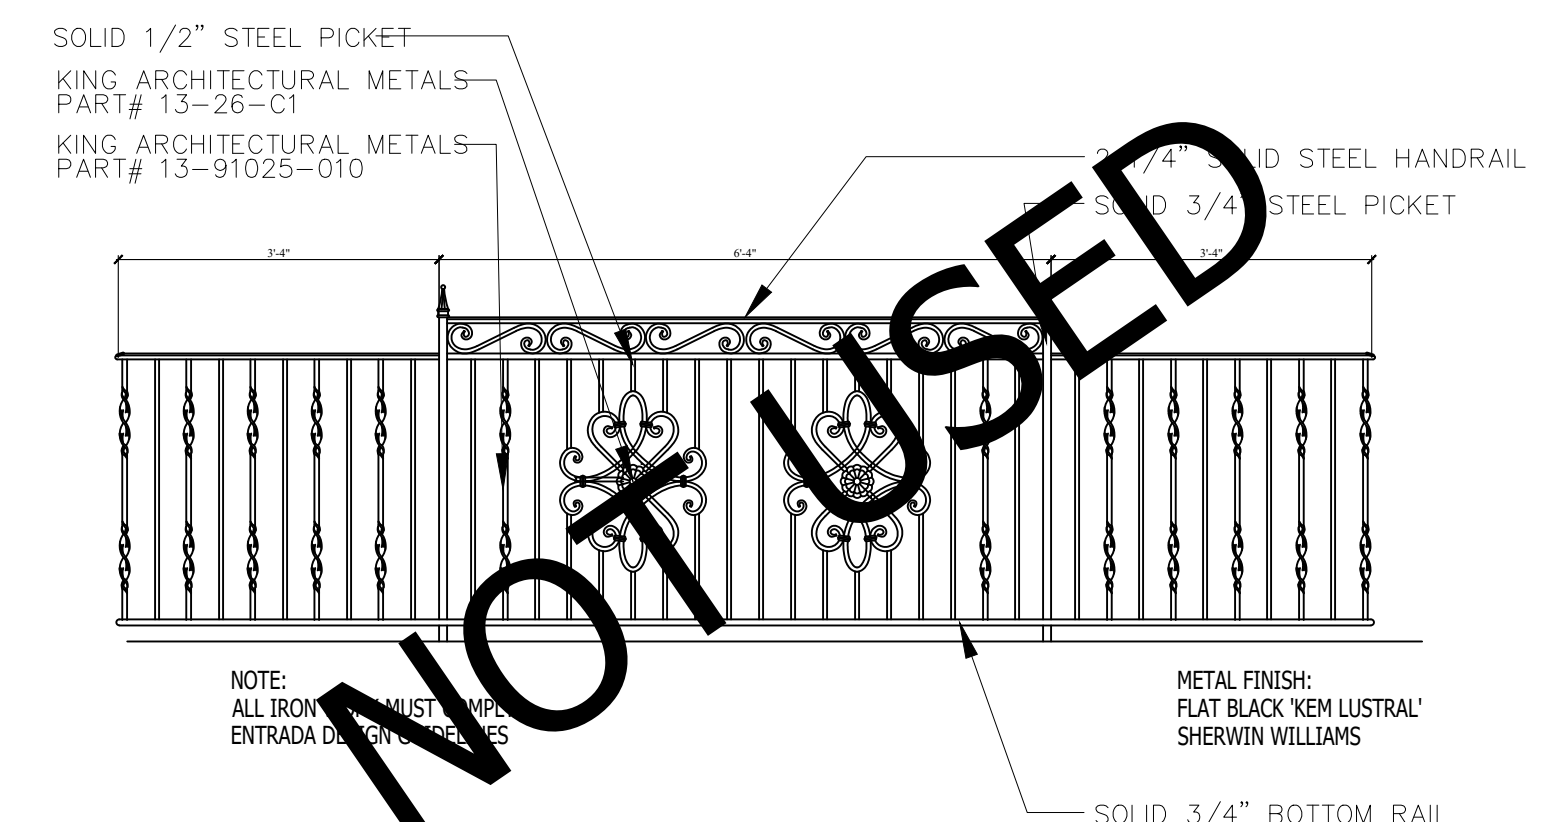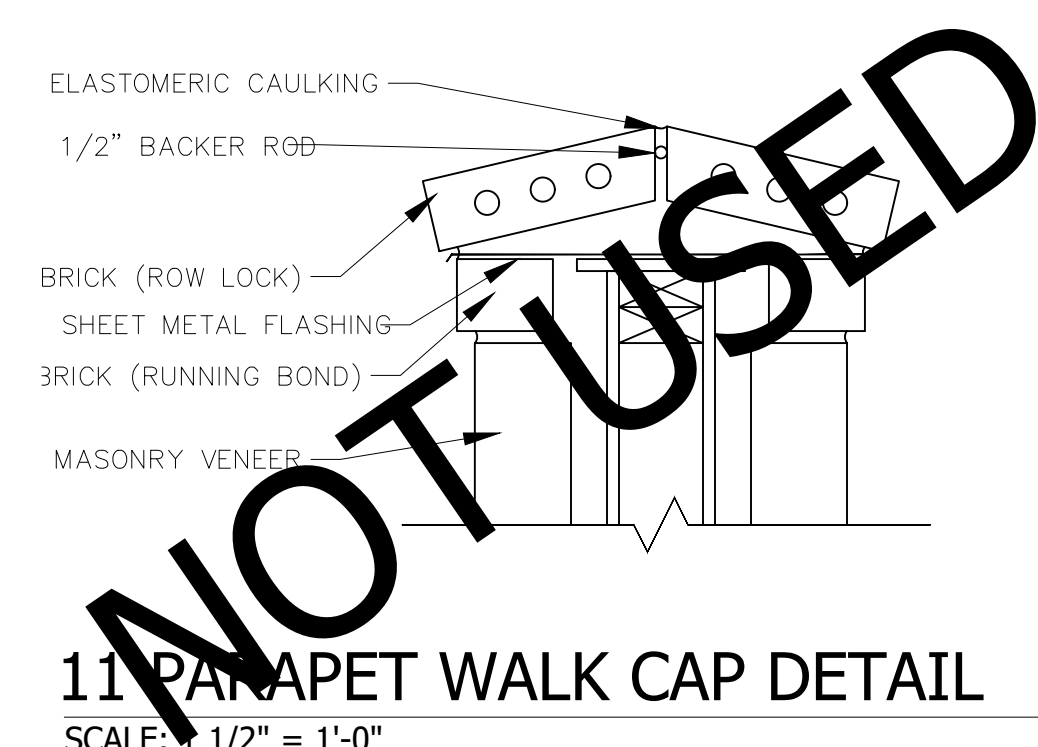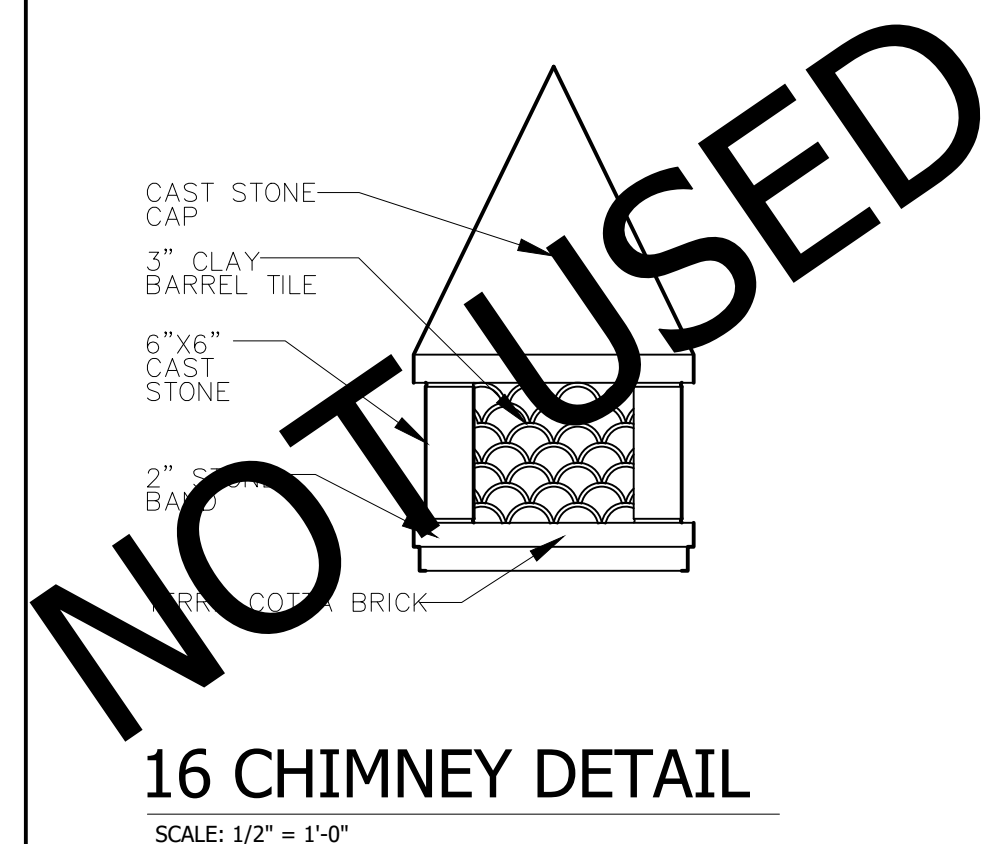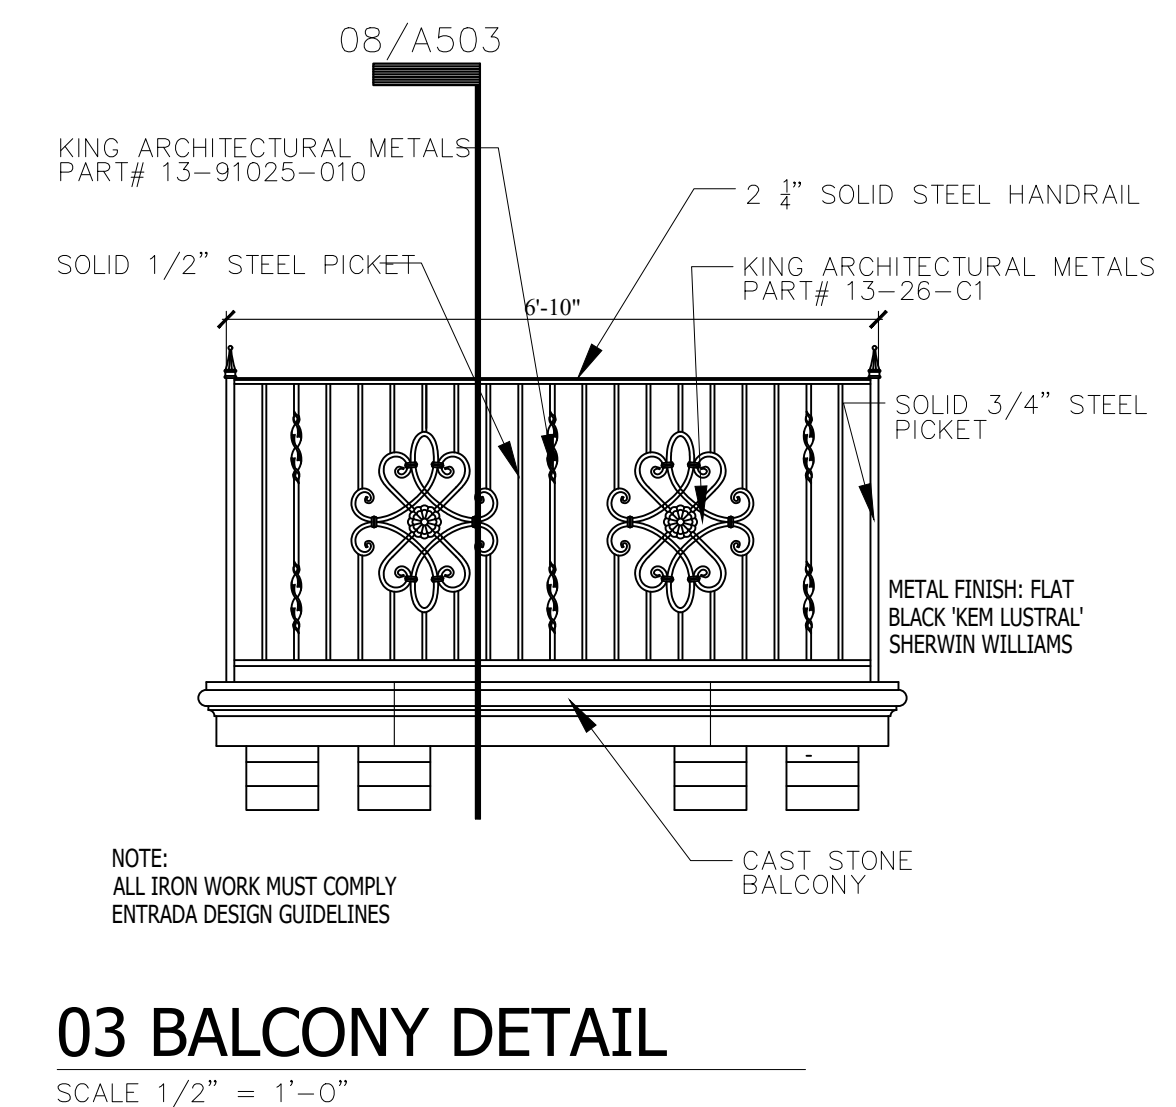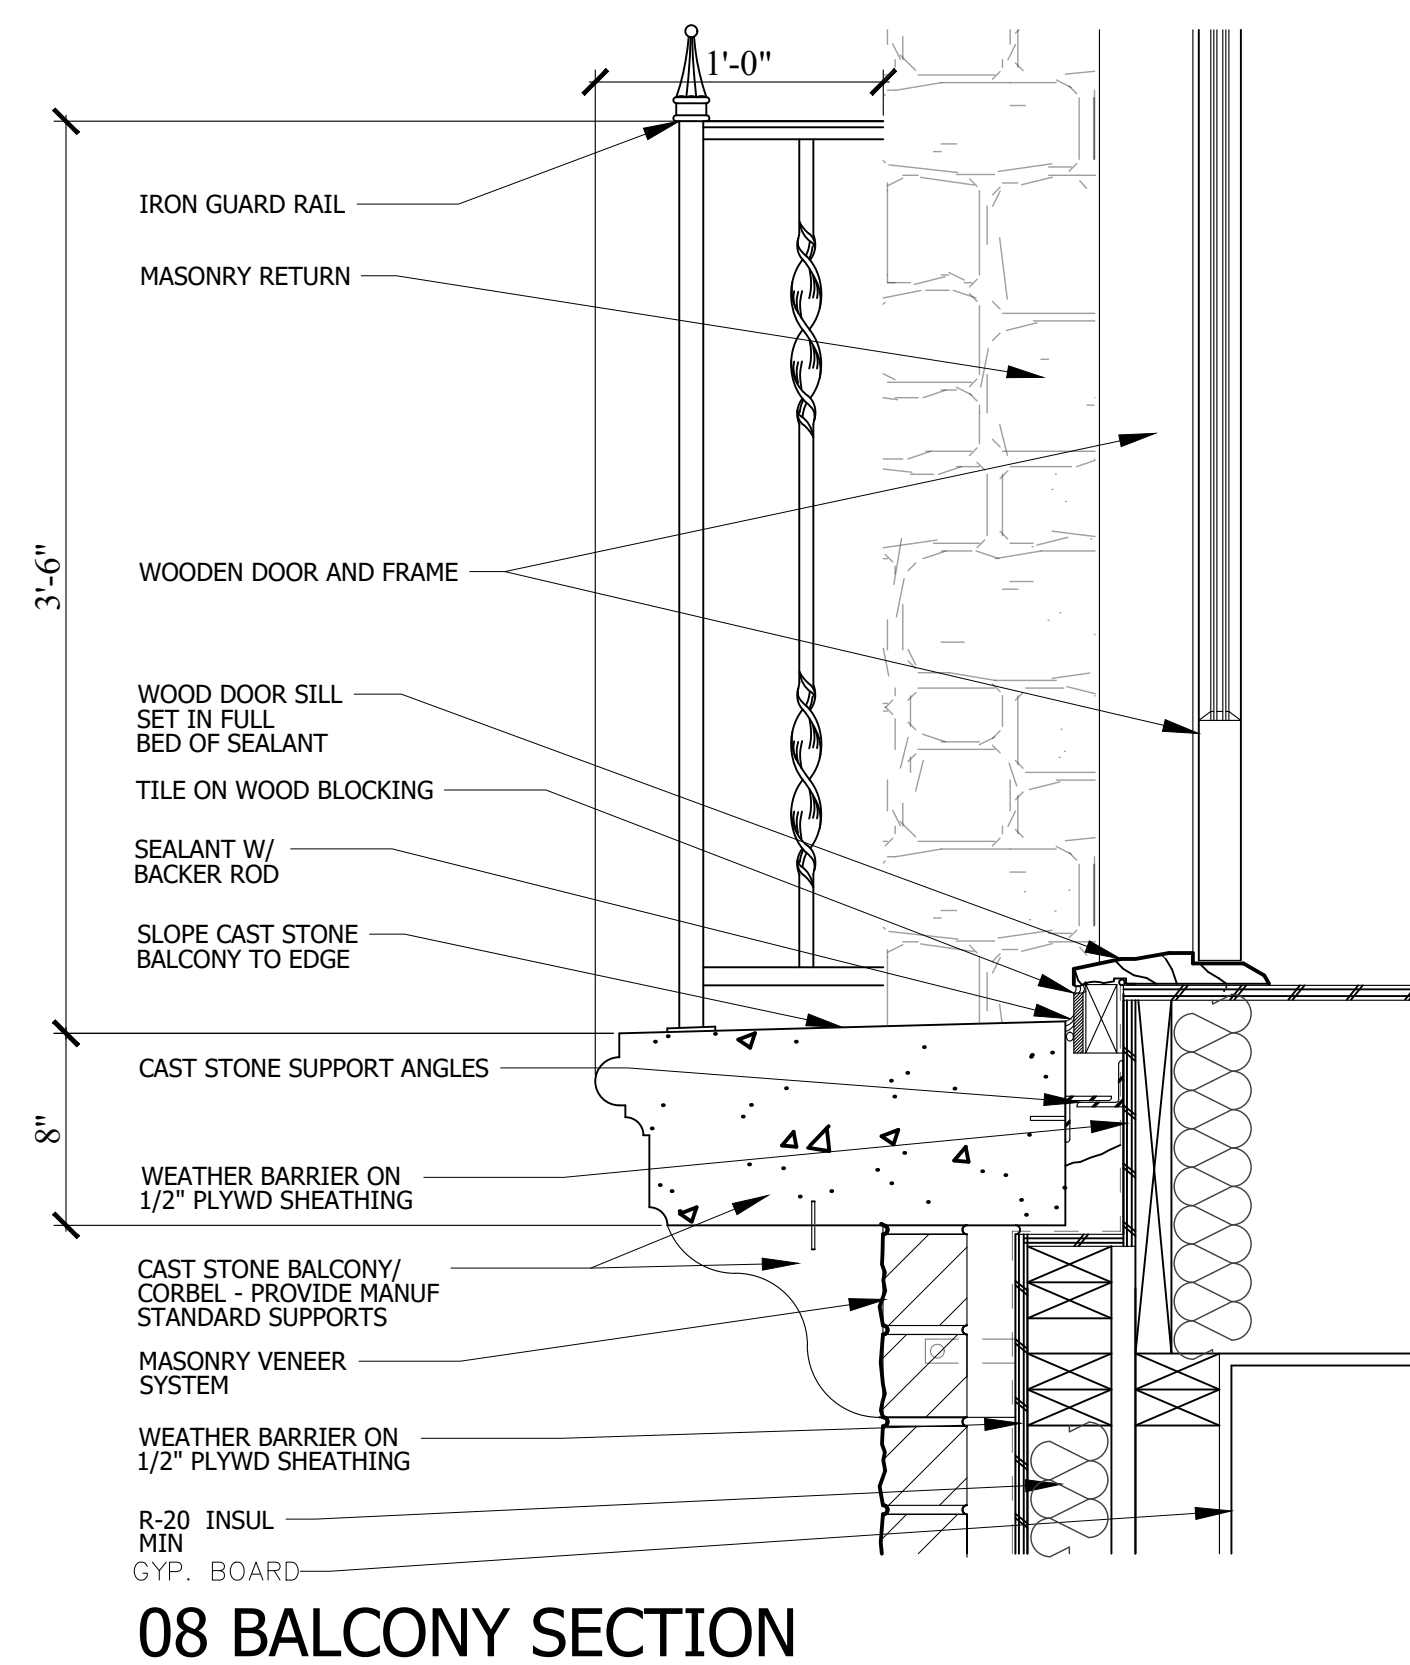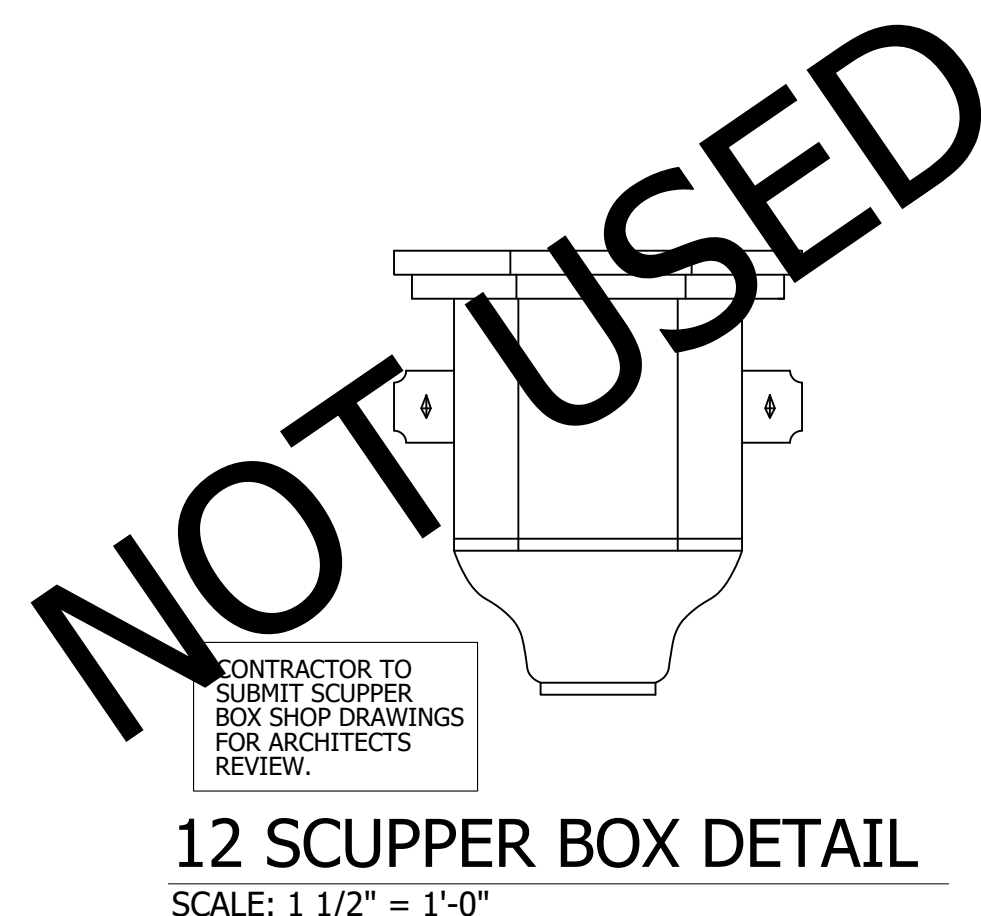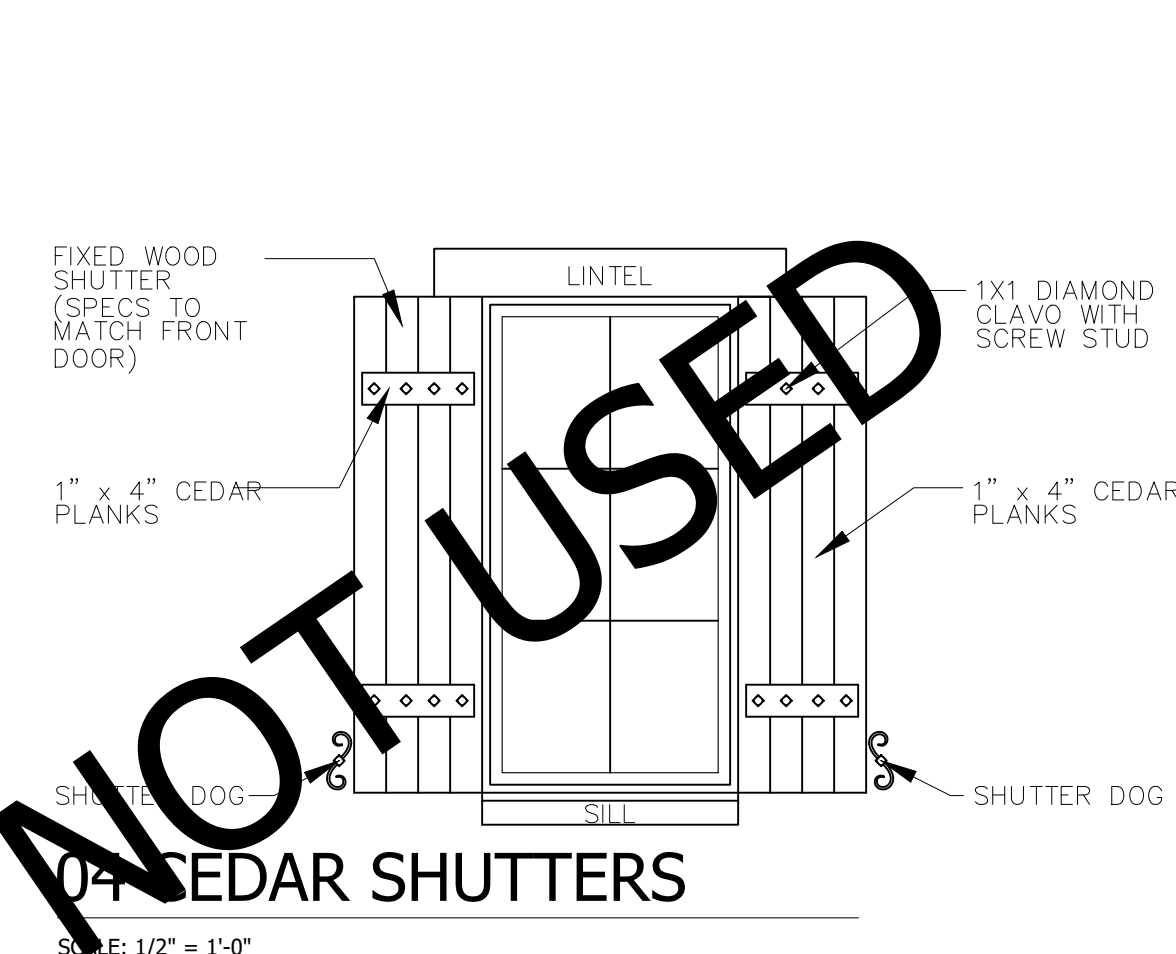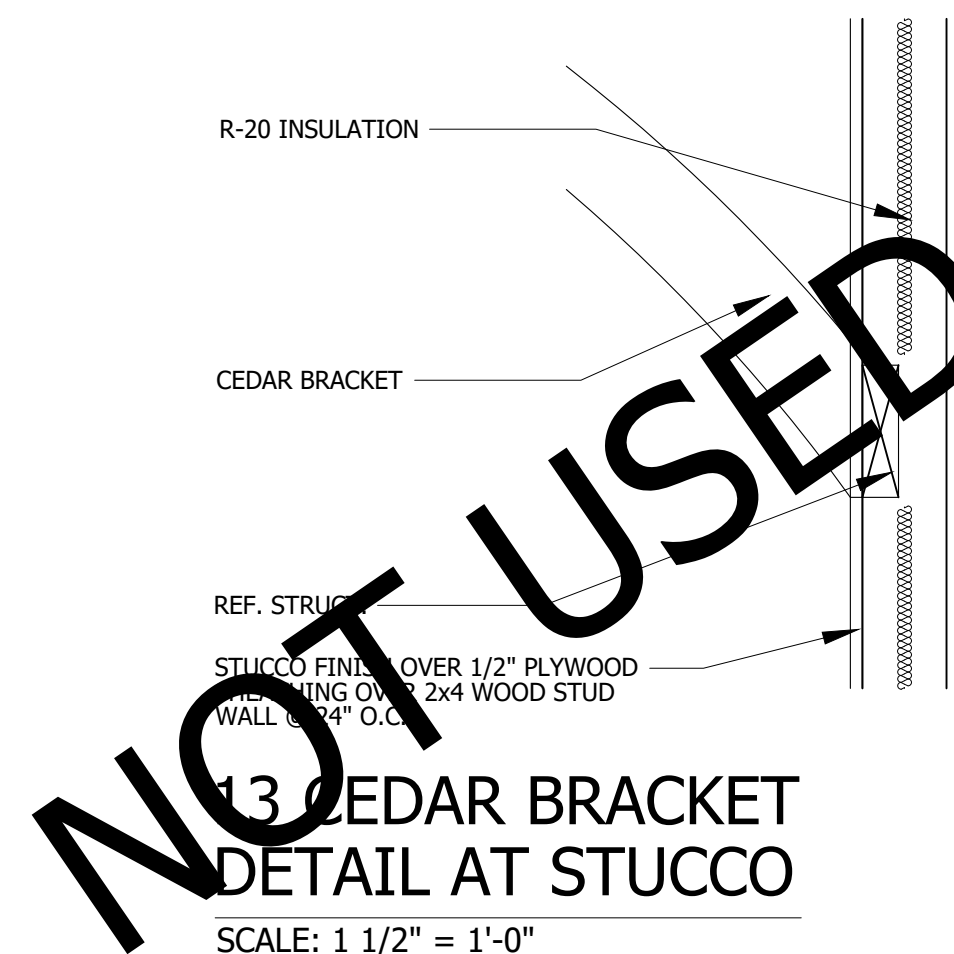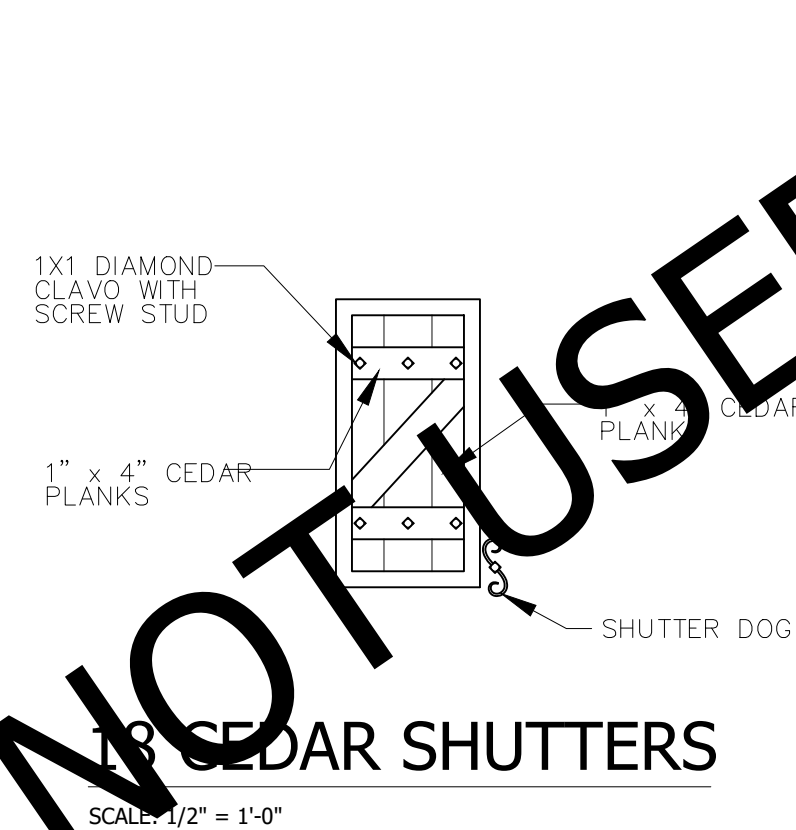[illegible]

PROJECT NO:	21-131
ISSUED FOR:	OTP
DRAWN BY:	Checker
DATE:	06/24/21

MISC DETAILS

A503

REFER TO **ENTRADA DESIGN GUIDELINES** FOR FUTHER DETAILED INFORMATION REGARDING THESE PLANS














ISSUE LOG

NO.	DESCRIPTION	DATE

PROJECT NO:	21-131
ISSUED FOR:	OTP
DRAWN BY:	Checker
DATE:	06/24/21

DOOR ELEVATIONS

A504

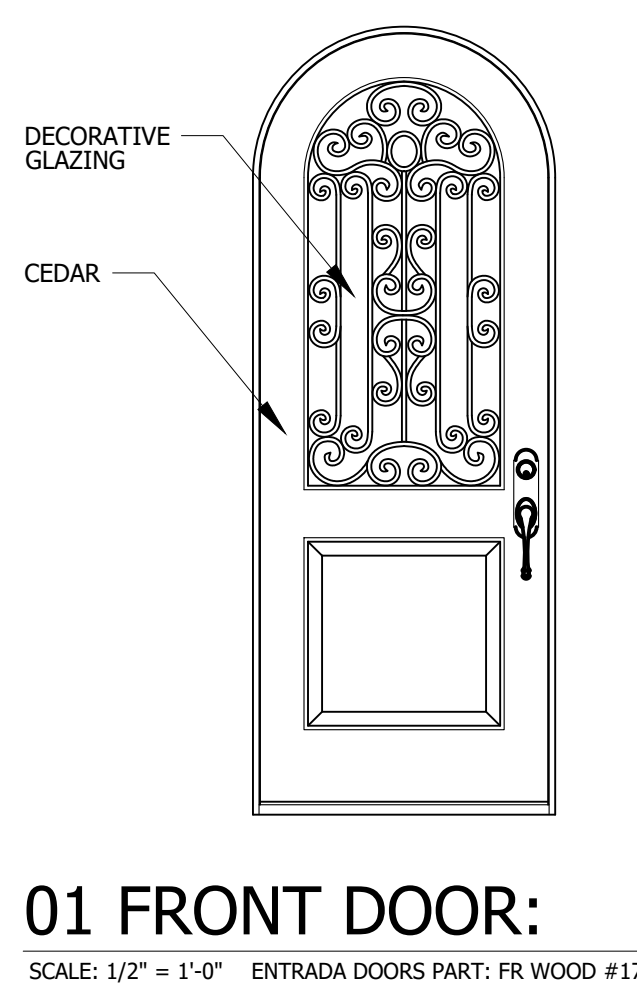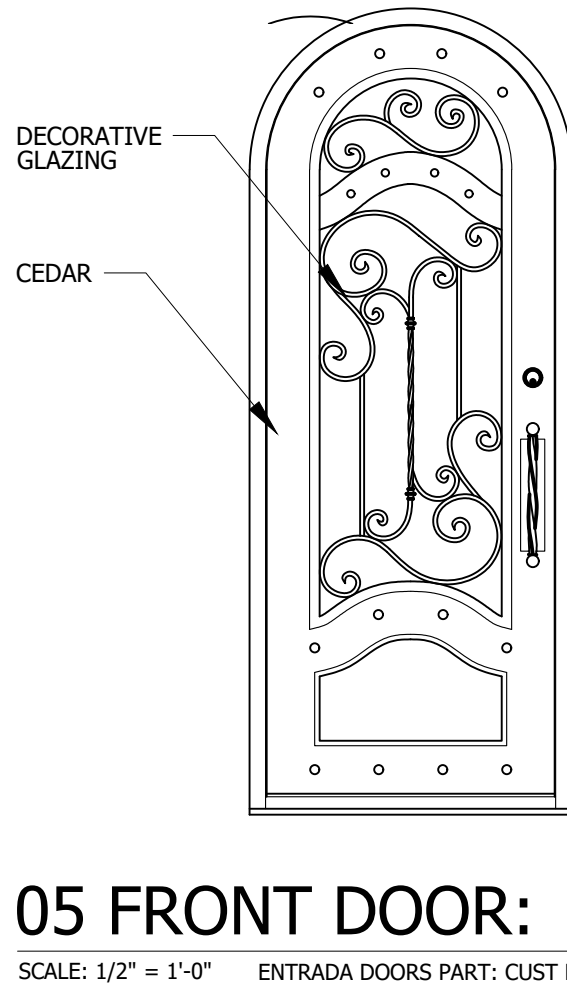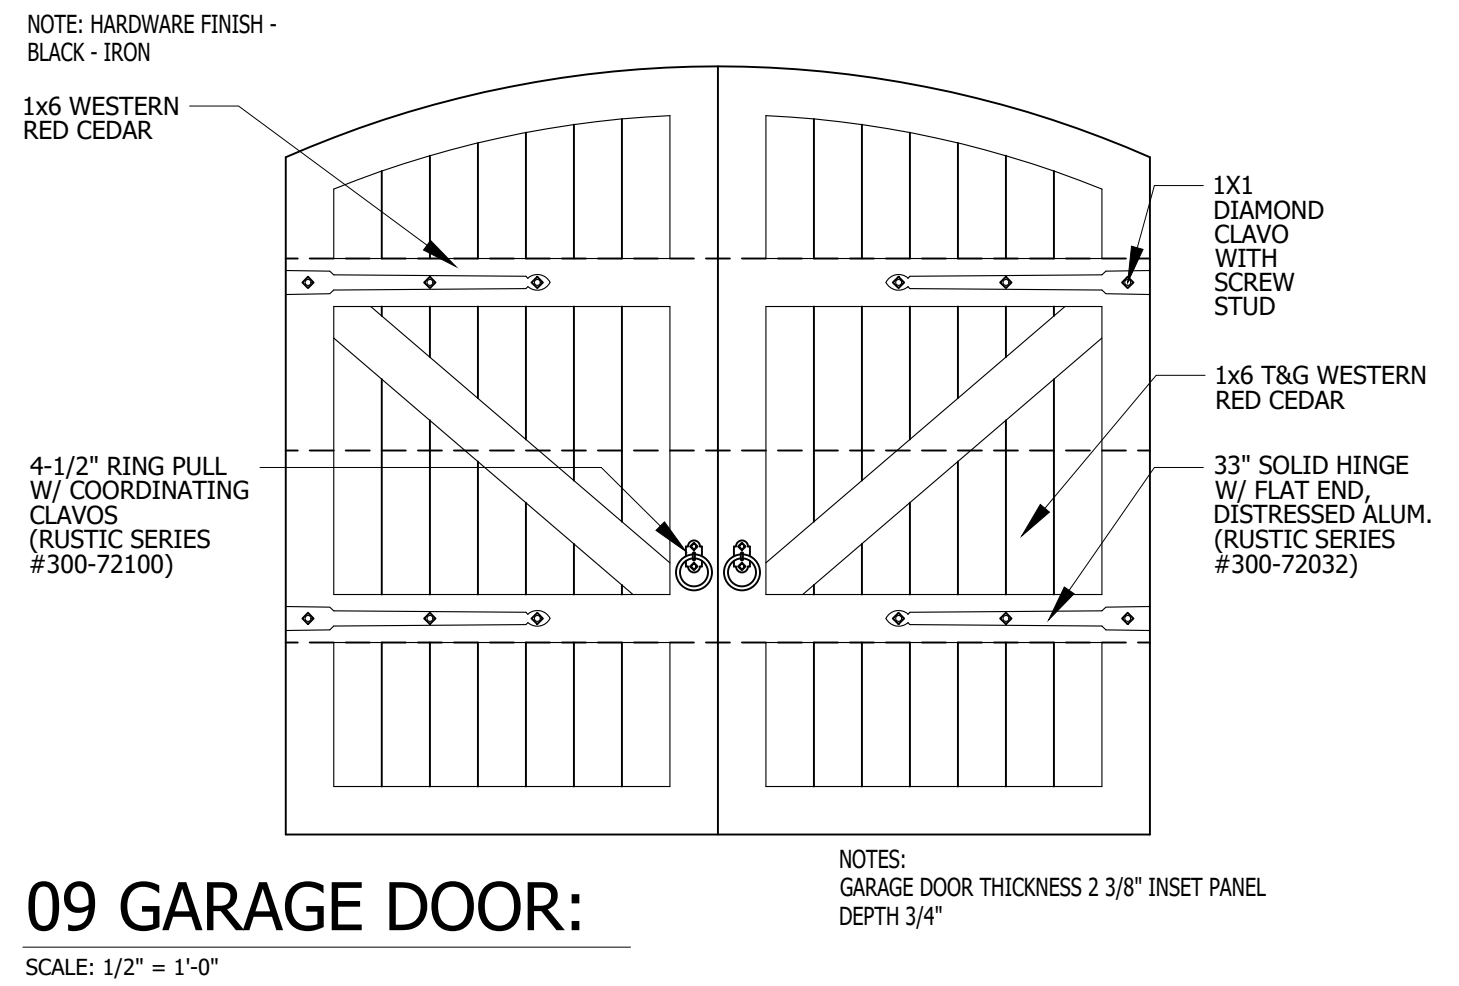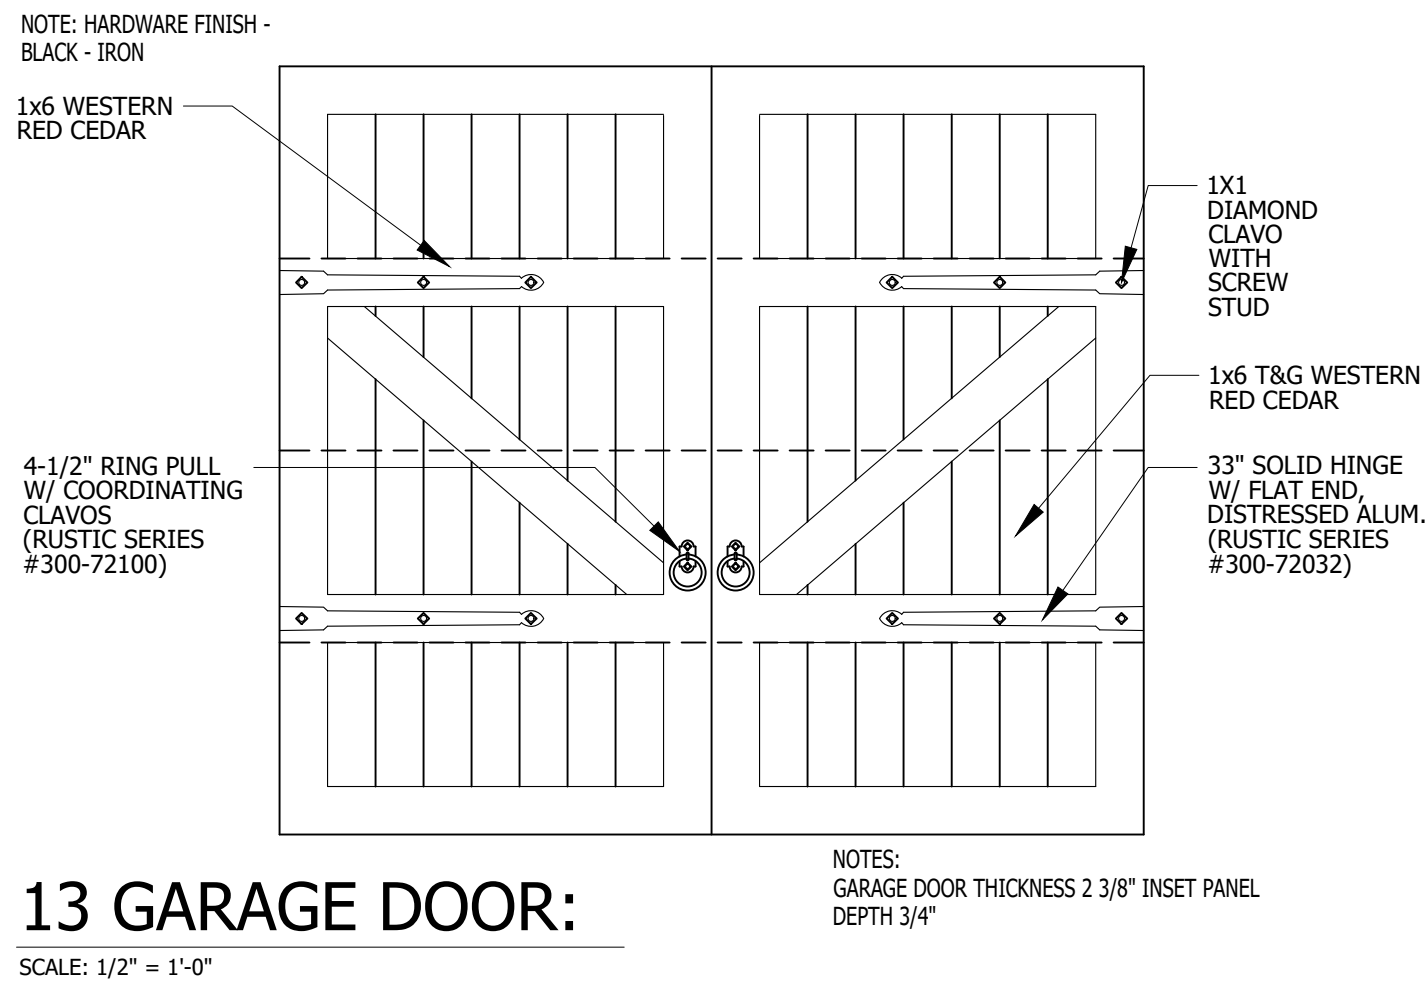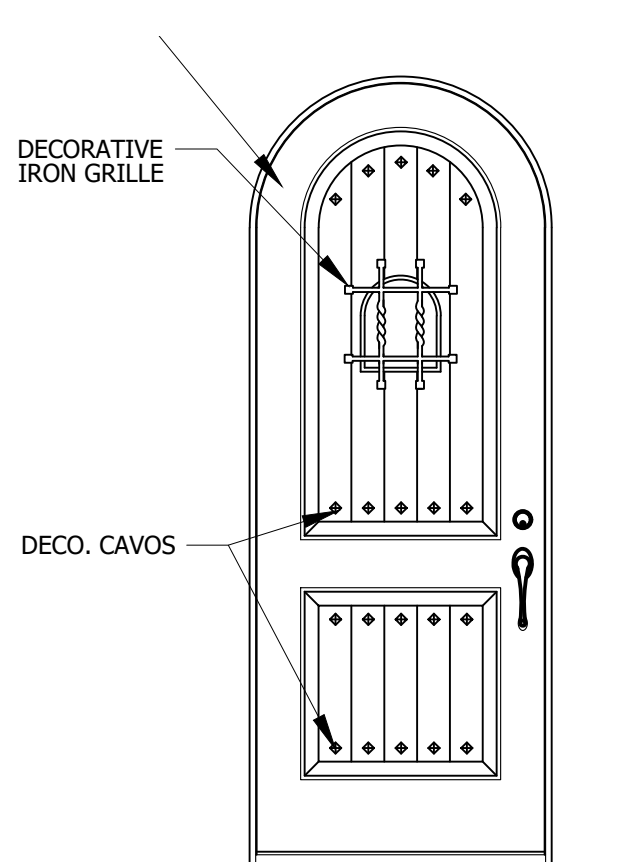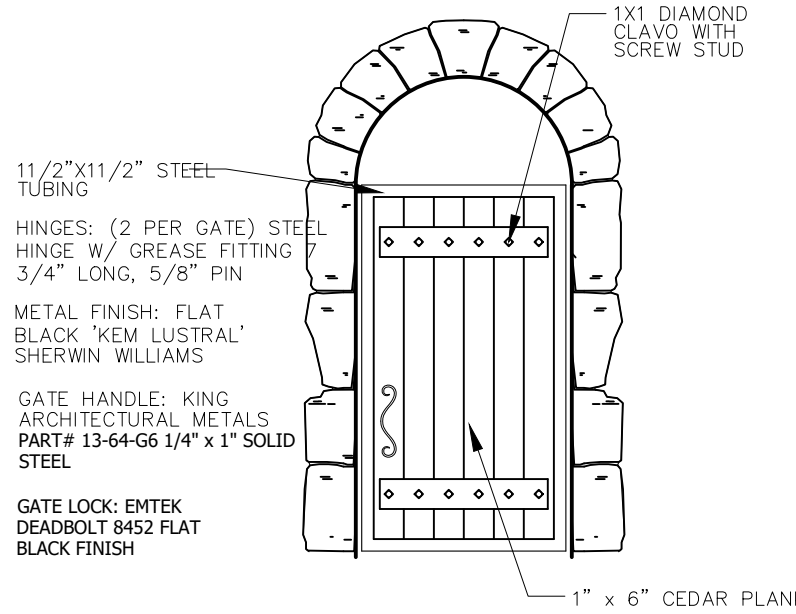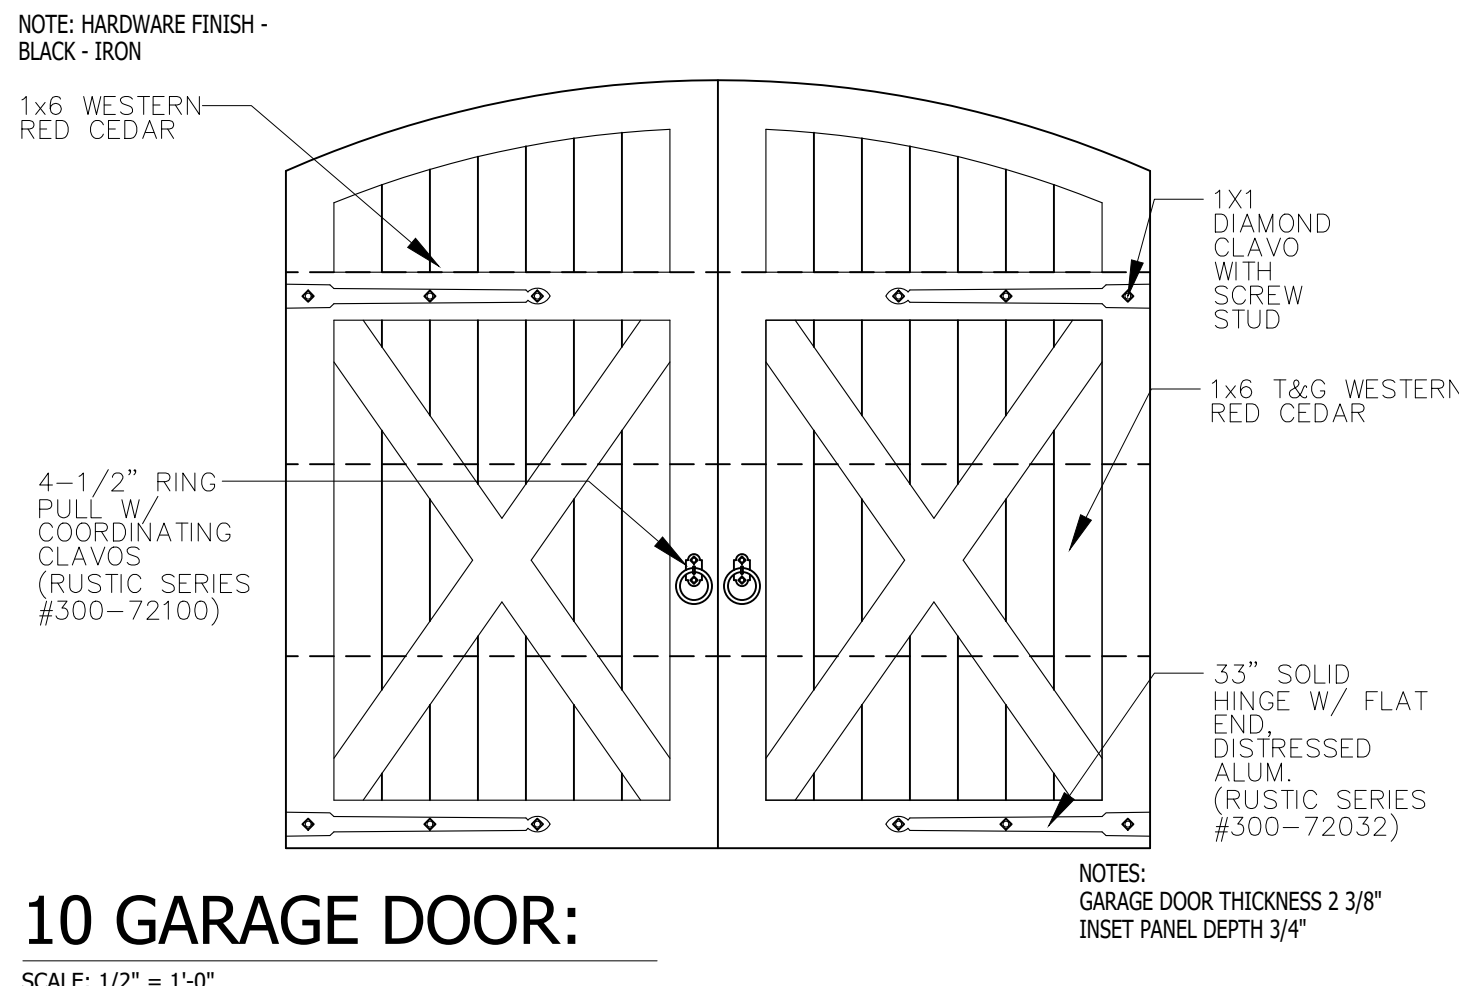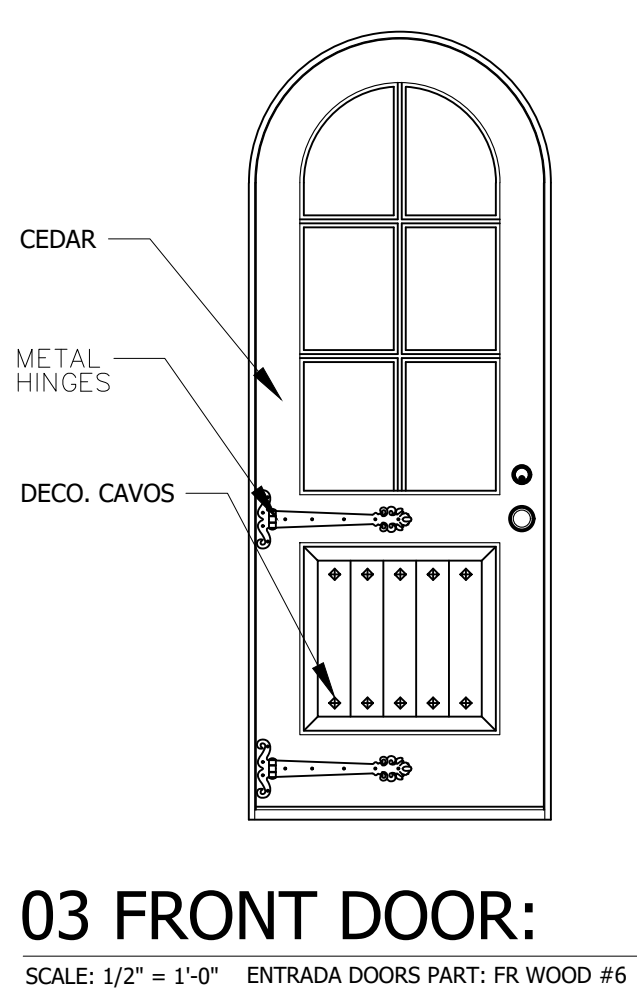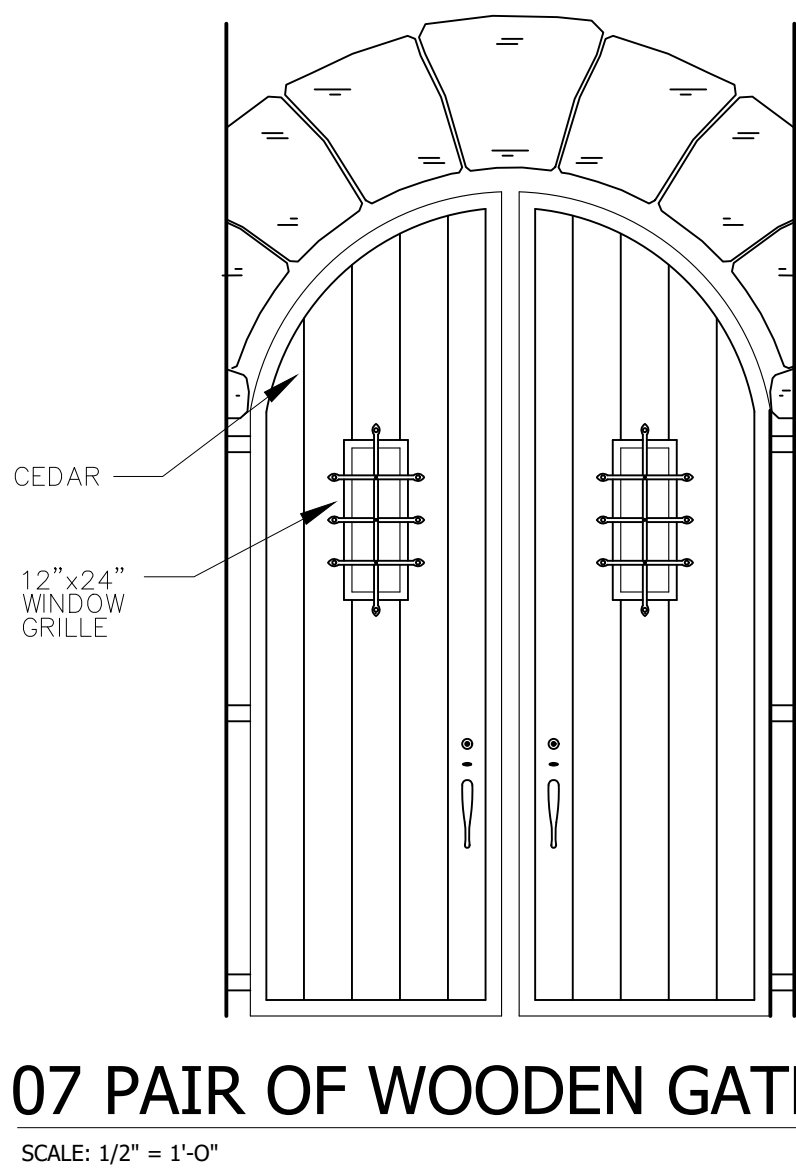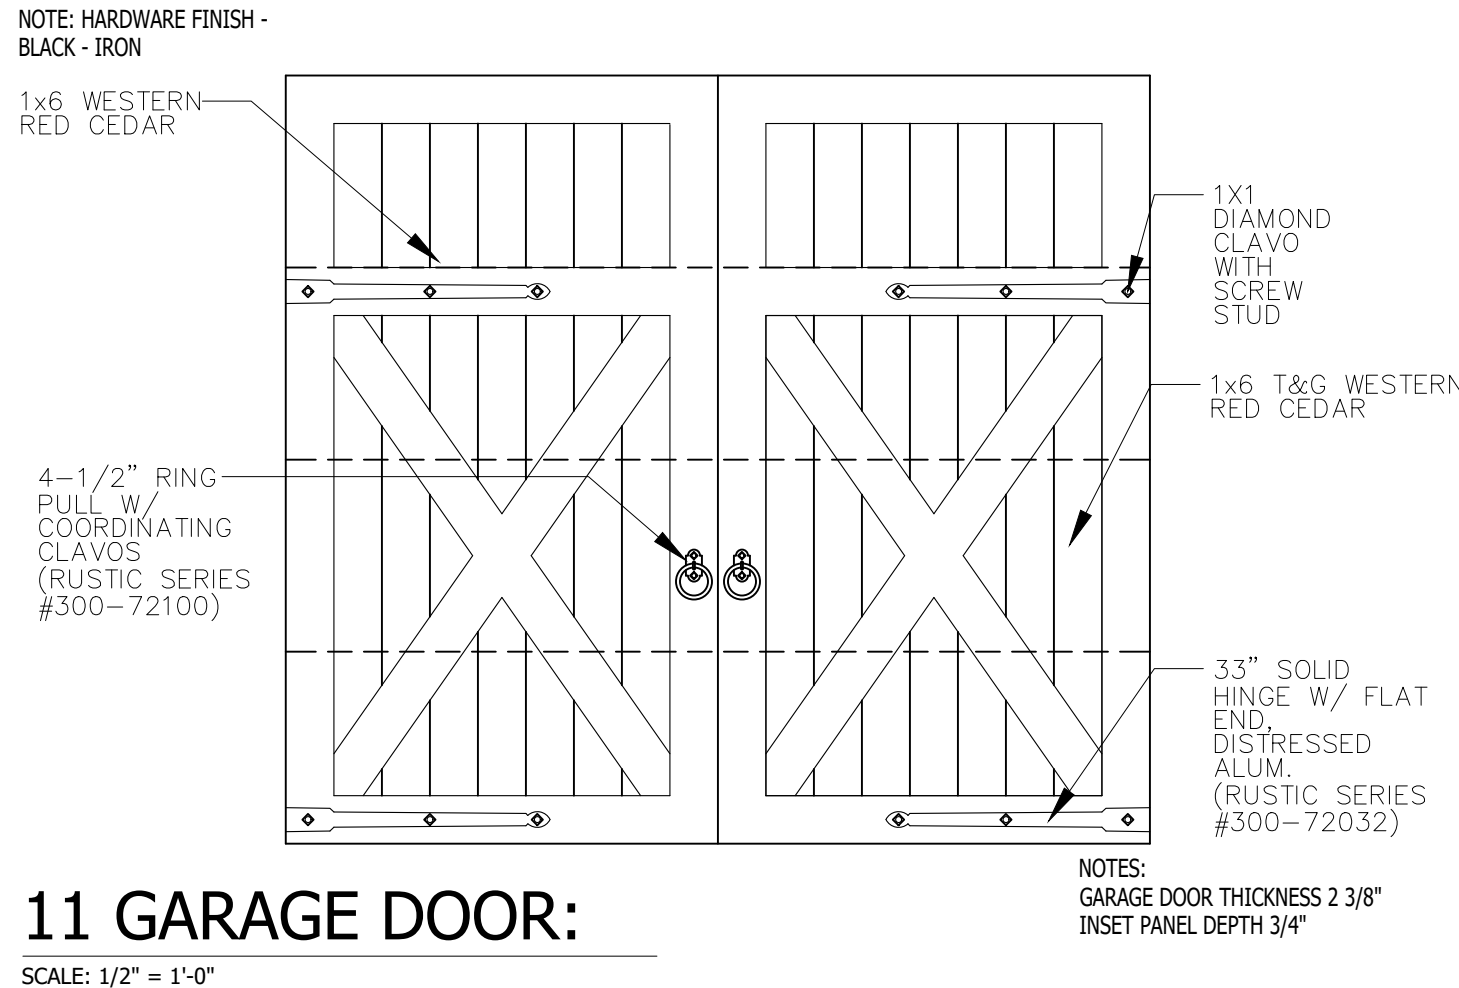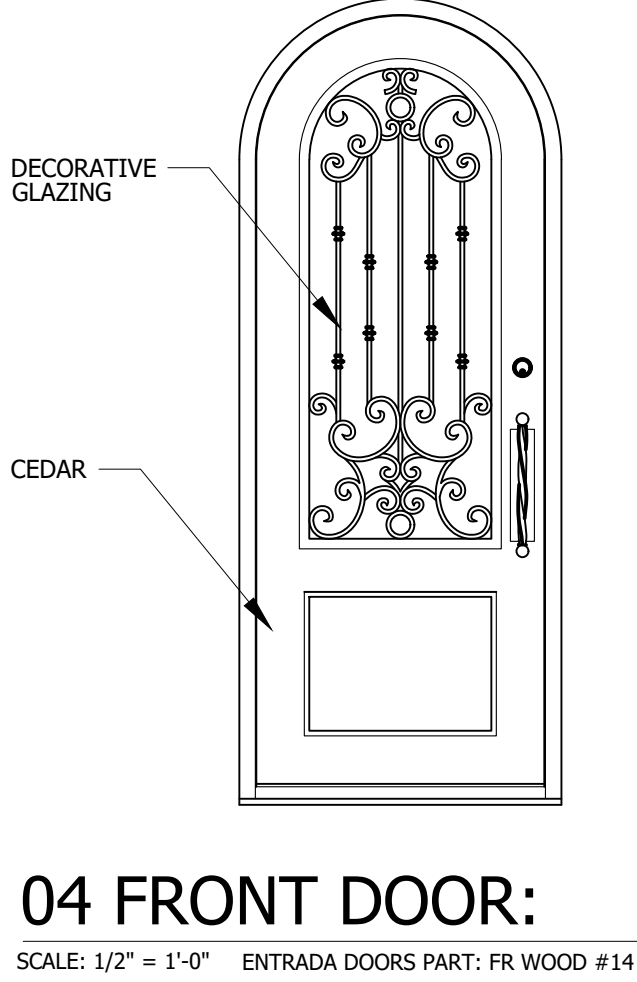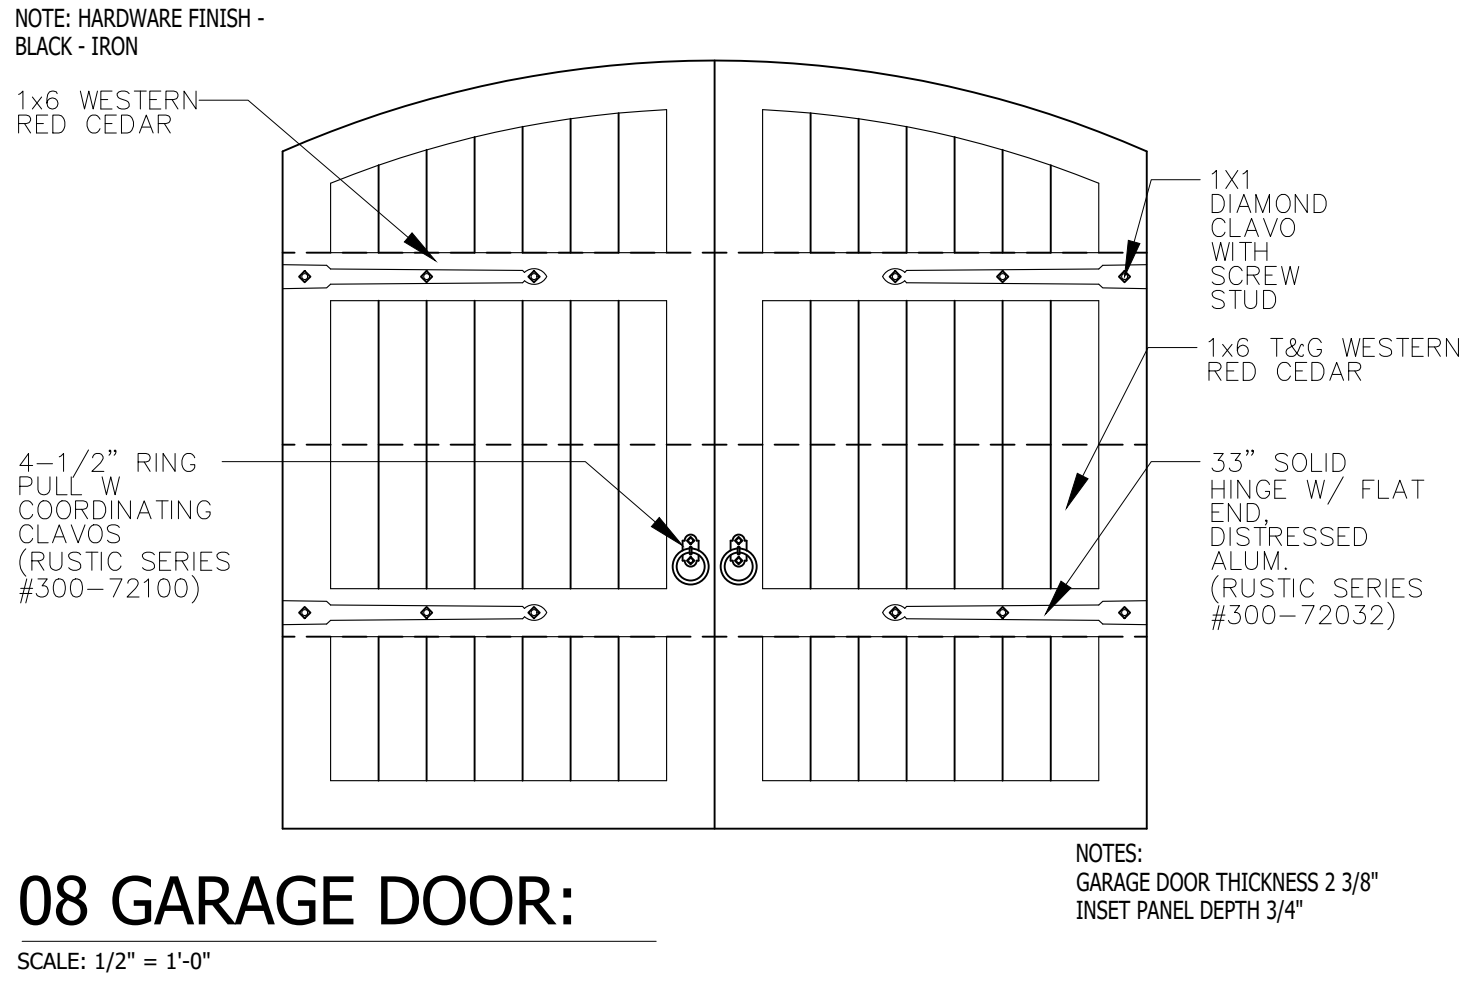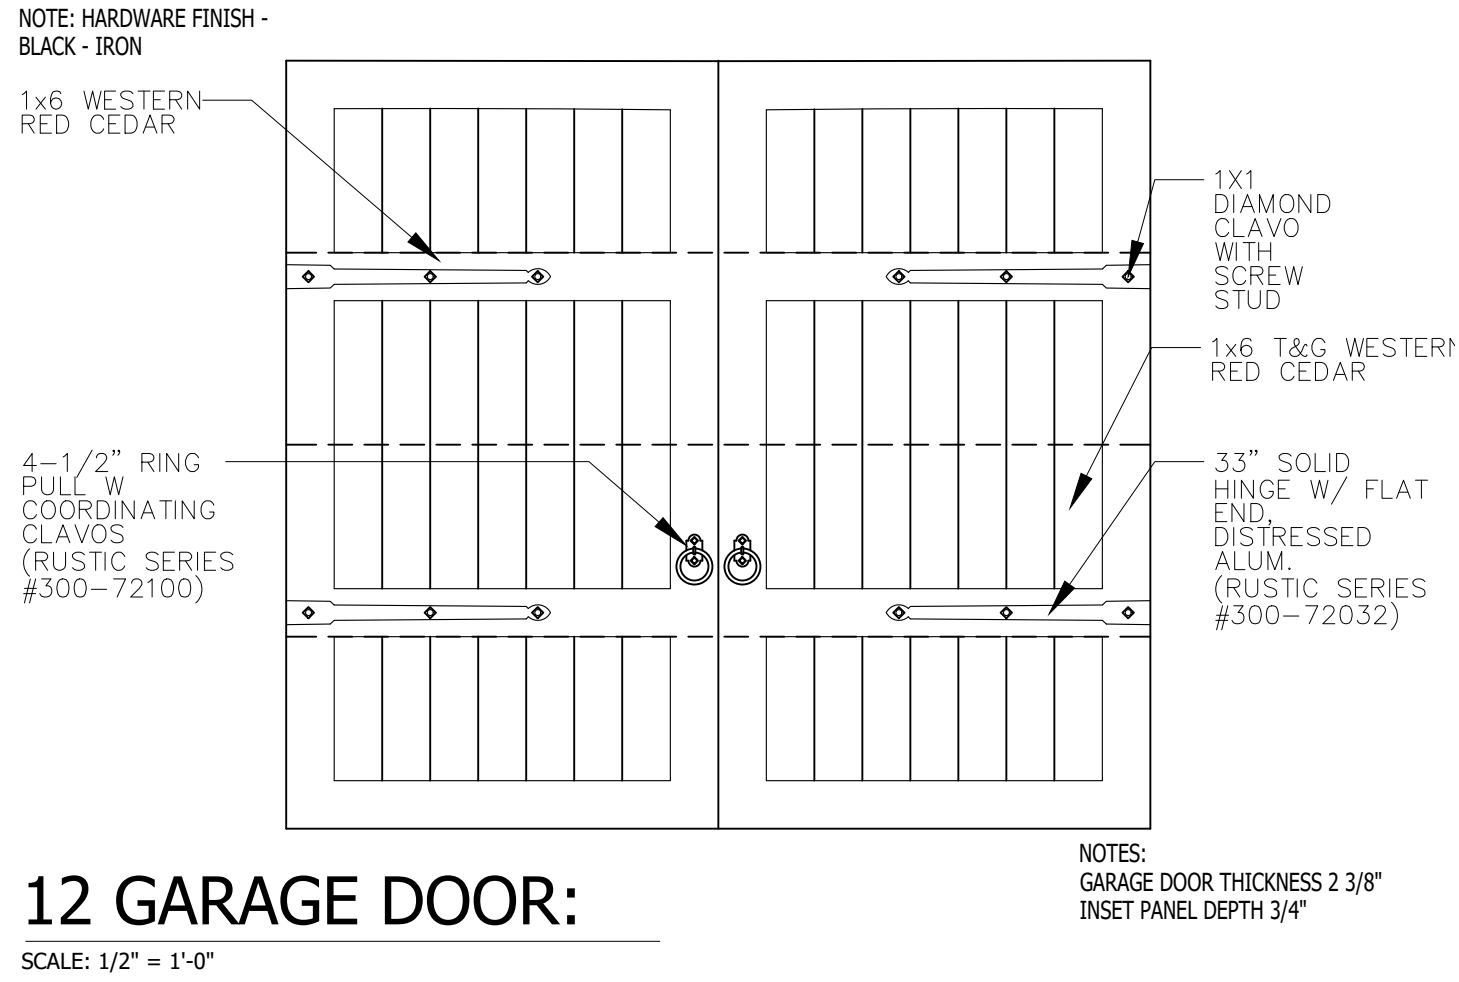

REFER TO **ENTRADA DESIGN GUIDELINES** FOR FUTHER DETAILED INFORMATION REGARDING THESE PLANS